



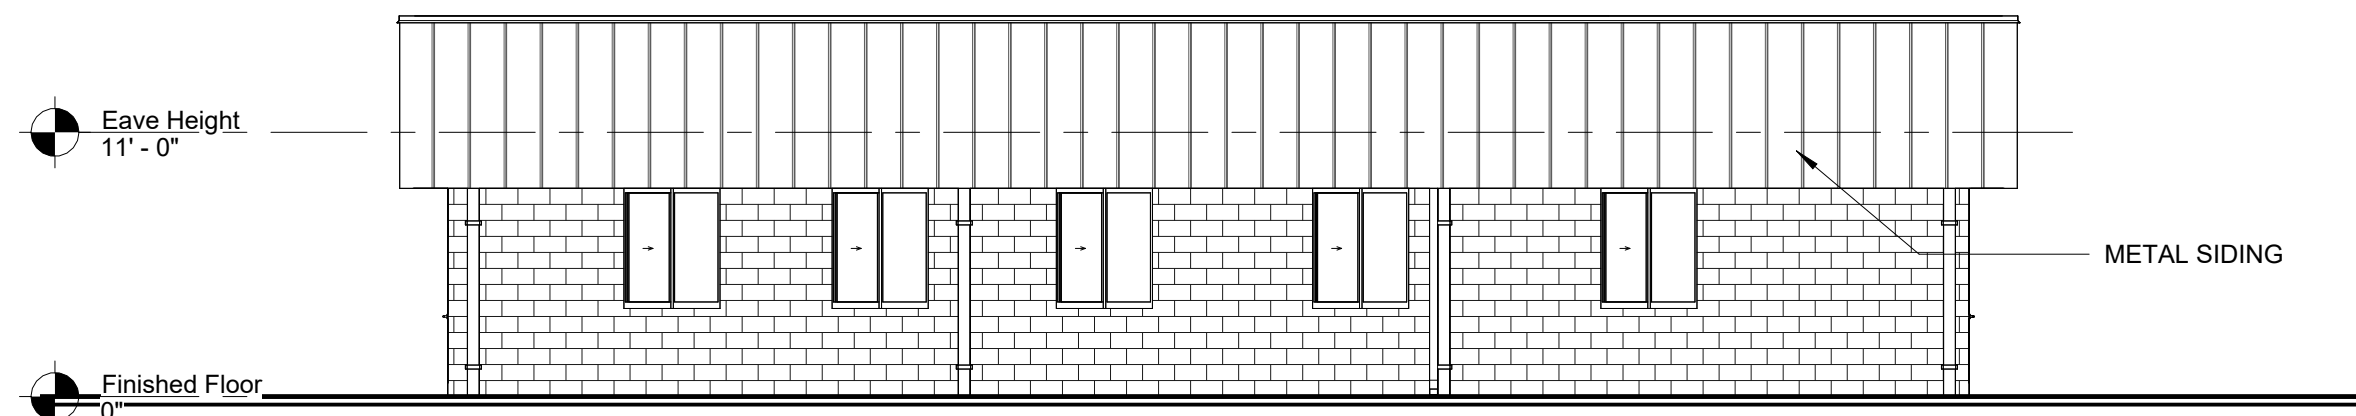


2 Front Elevation-Existing
A0.1 Scale: 1/8" = 1'-0"

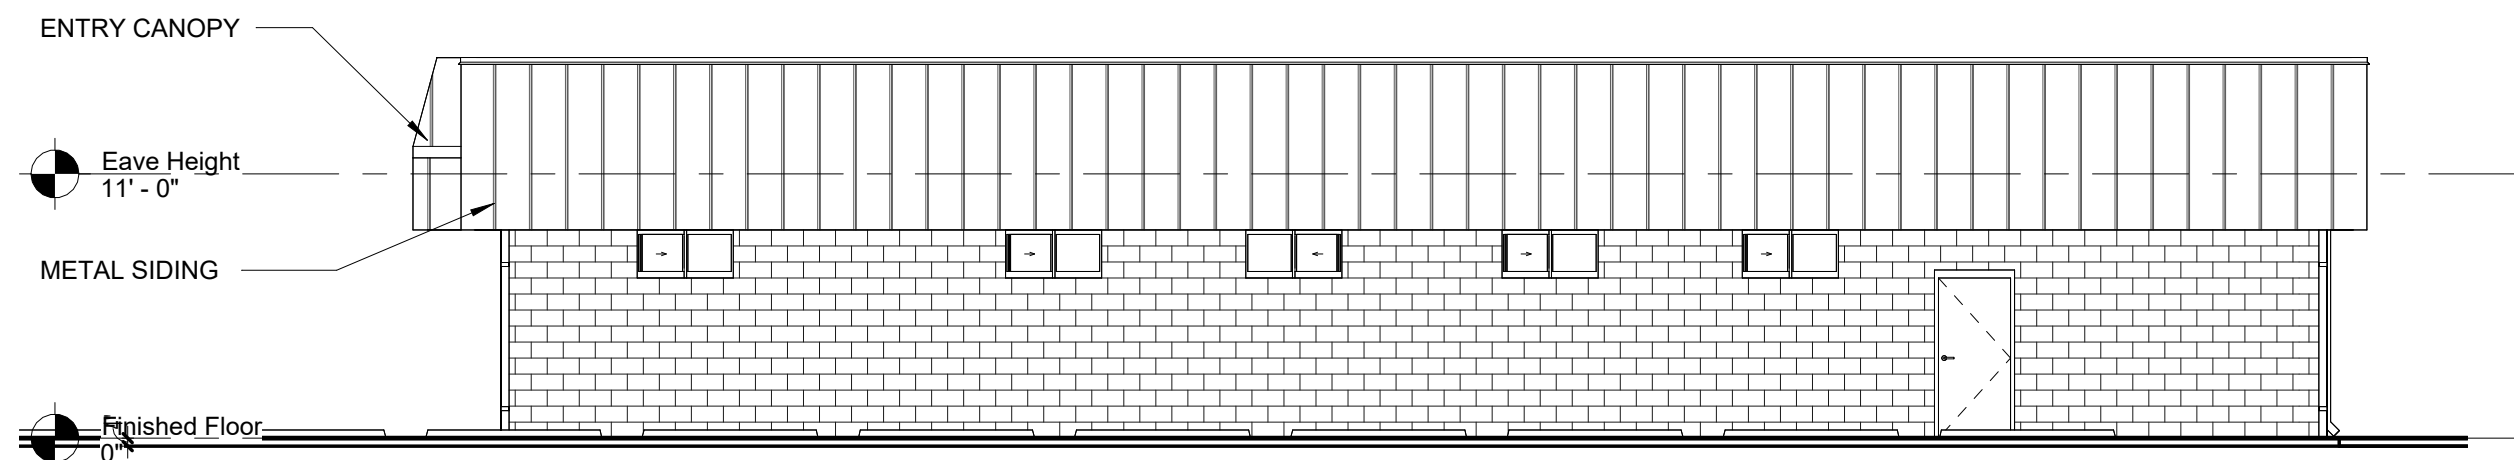


3 Rear Elevation-Existing
A0.1 Scale: 1/8" = 1'-0"



4 Side Elevation A-Existing
A0.1 Scale: 1/8" = 1'-0"

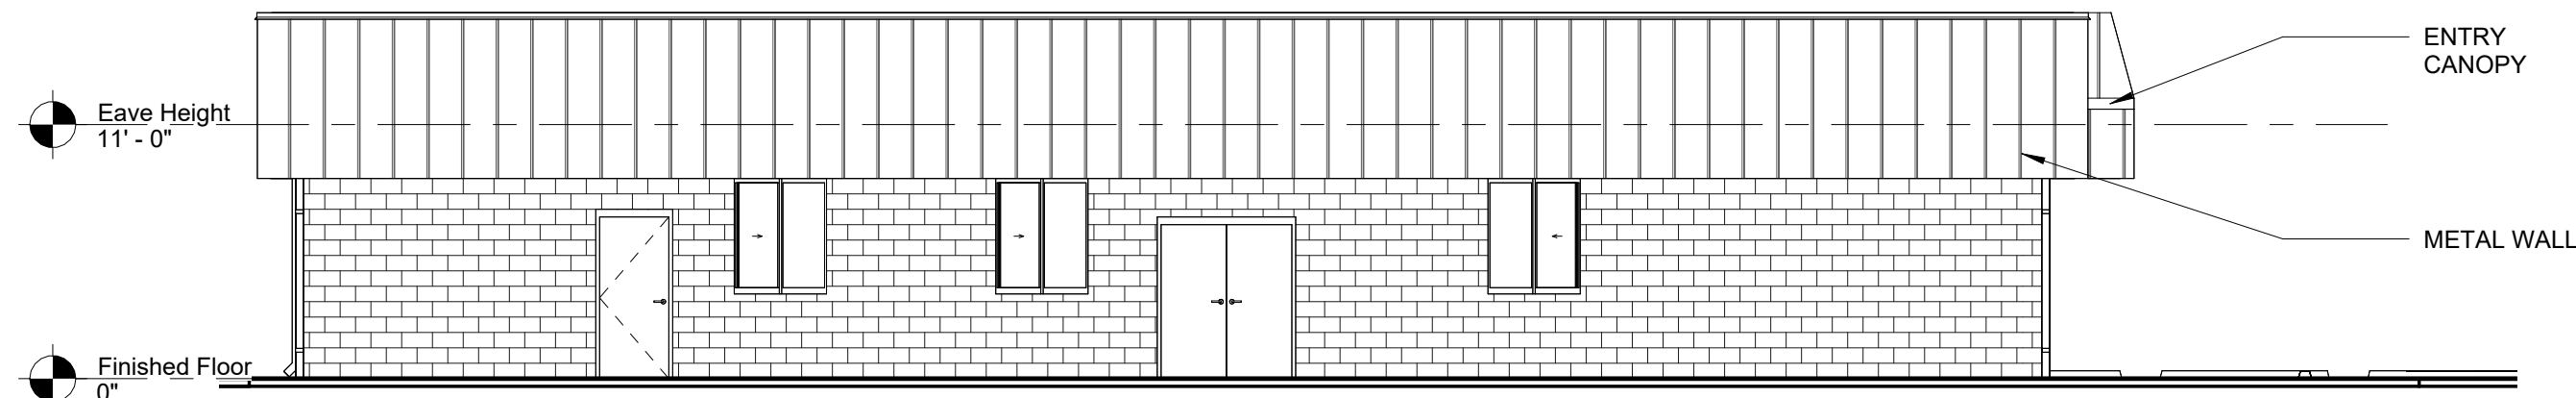

5 Side Elevation B-Existing
A0.1 Scale: 1/8" = 1'-0"

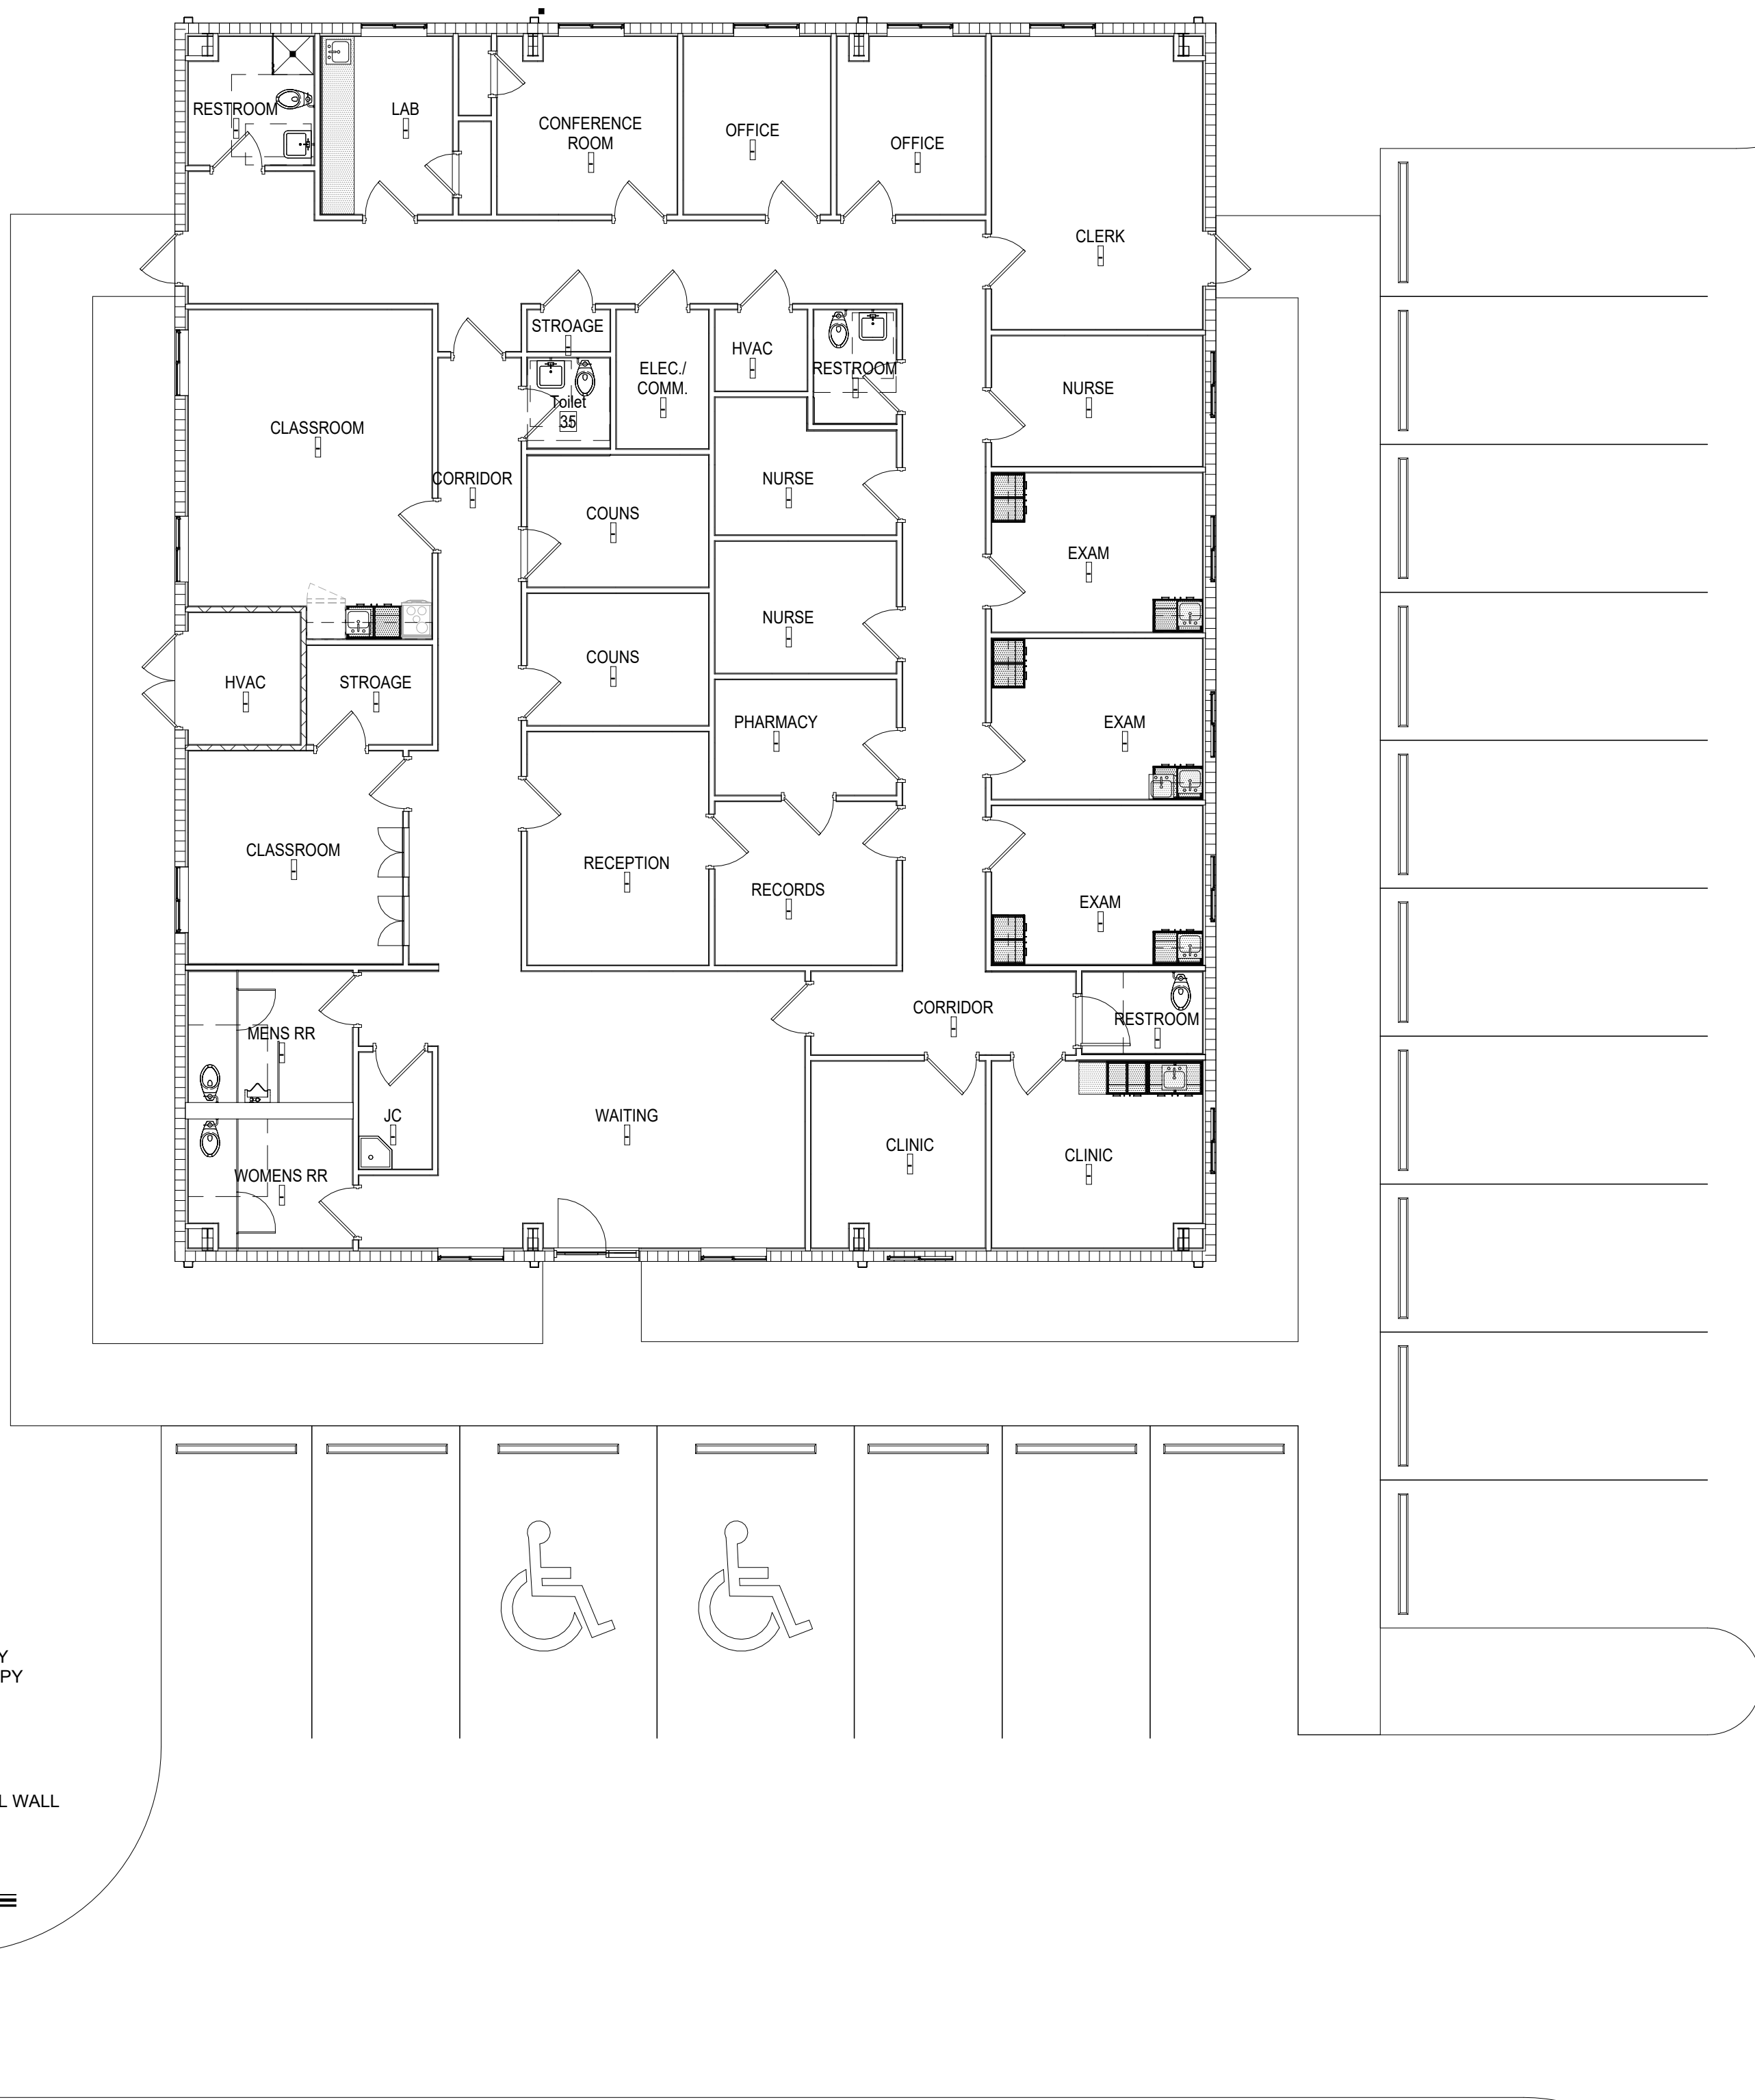

1 Floor Plan
A0.1 Scale: 1/8" = 1'-0"

GADSDEN CO. BOCC

**Havana
Medical Center
Remodel**

Havana, FL



**Clemons, Rutherford,
& Associates, Inc.**

Architects
Planners
Interior Designers
Construction Managers

2027 Thomasville Road
Tallahassee, Florida 32308

phone 850-385-6153

fax 850-386-8420

cra@craarchitects.com

The Drawings, Specifications and other documents prepared by Clemons, Rutherford & Associates, Inc. (CRA) for this Project are instruments of CRA for use solely with respect to this Project and, unless otherwise provided, CRA shall be deemed the author of these documents and shall retain all common law, statutory and other reserved rights, including the copyright. The Owner shall be permitted to retain copies, including reproducible copies, of CRA's Drawings, Specifications and other documents for information and reference in connection with the Owner's use and occupancy of the Project. CRA's Drawings, Specifications or other documents shall not be used by the Owner or others on other projects, for documents shall not be used by the Owner or others on other projects, for additions to this Project or for completion of this Project by others, unless the Architect is adjudged to be in default under this Agreement, except by agreement in writing and with appropriate compensation to CRA.

Gregory Westmoreland Kelley
RA00000006

Submittal

Phase	Date	Drw	Chk
100% Construction Doc.	5/26/25	Author	Checker
100% Review Documents	12/16/24		
-	-		
-	-		
-	-		
-	-		

Revision


#	Description	Date

CRA Project # **25027**


Phase: **100% Construction
Doc.**

SHEET TITLE
EXISTING FLOOR PLAN


A0.1

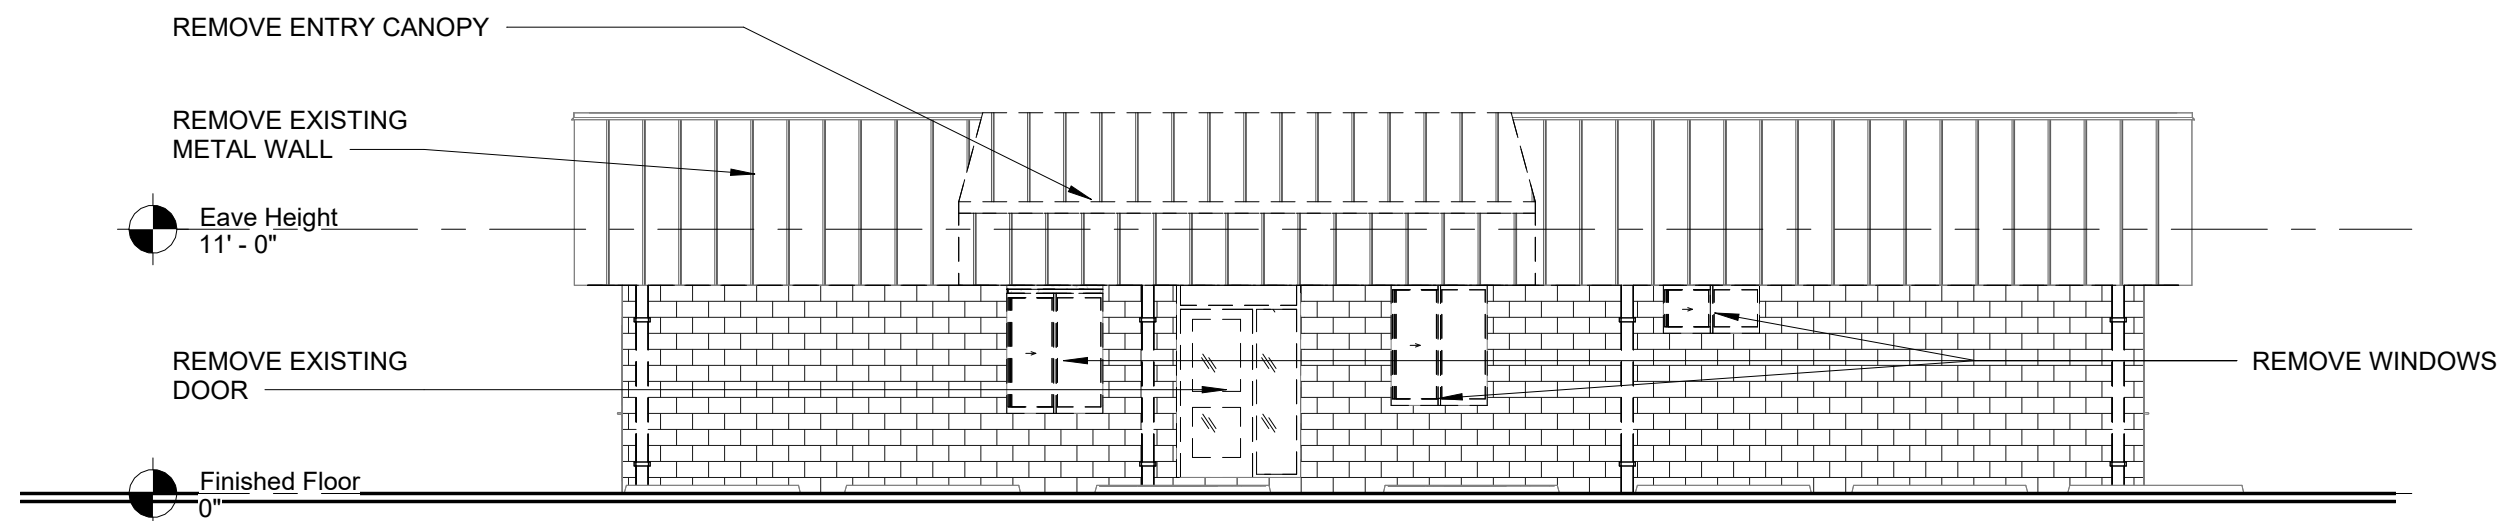


2 Front Elevation-Demo
D1.1 Scale: 1/8" = 1'-0"

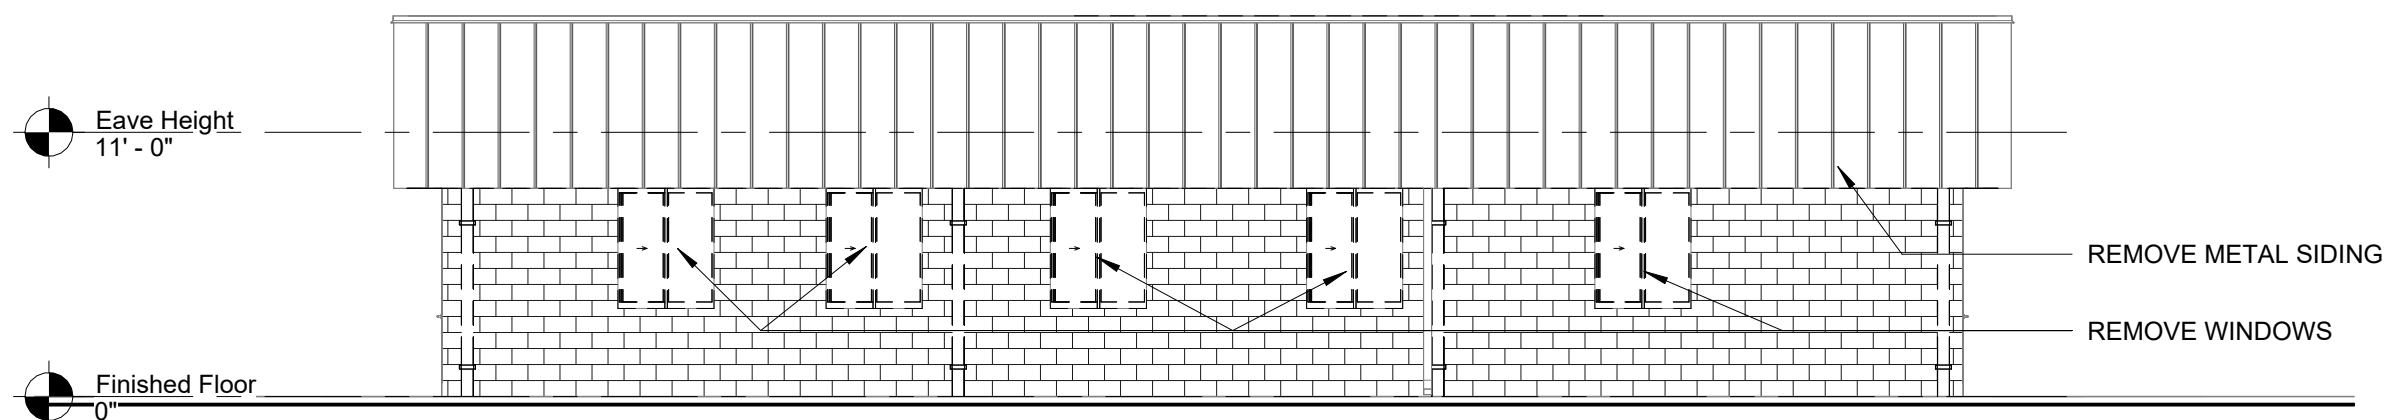


3 Rear Elevation-Demo
D1.1 Scale: 1/8" = 1'-0"

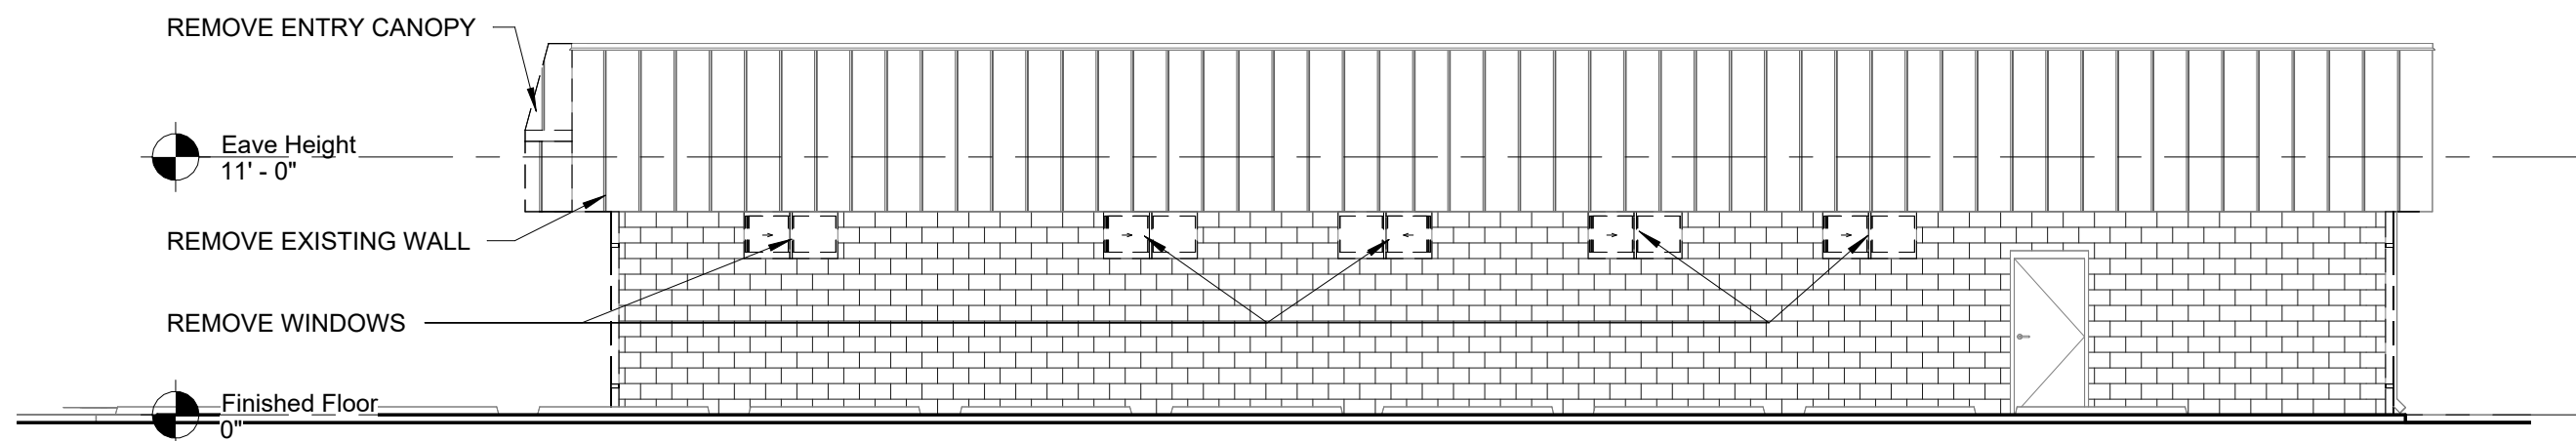

4 Side Elevation A-Demo
D1.1 Scale: 1/8" = 1'-0"

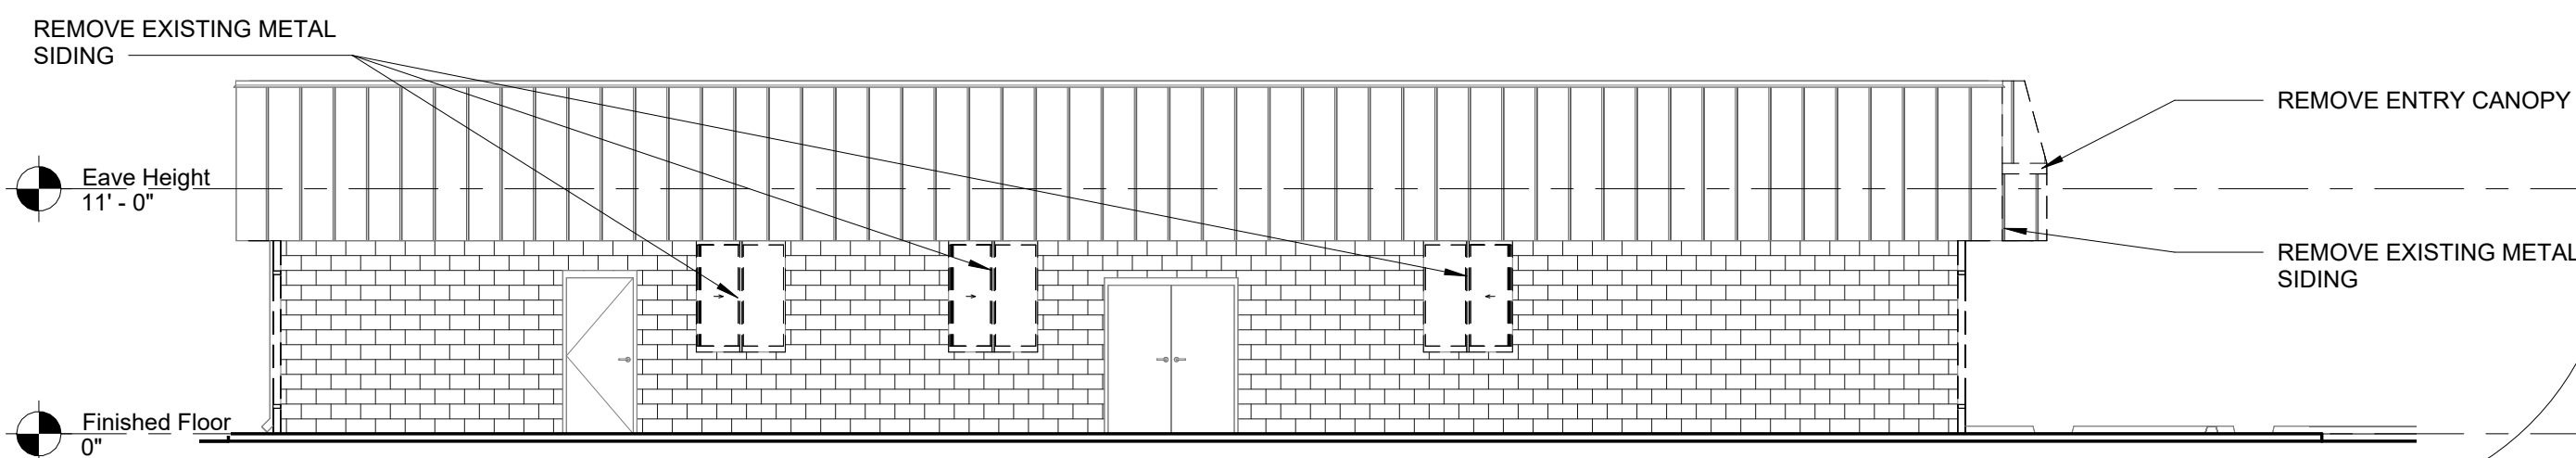

5 Side Elevation B-Demo
D1.1 Scale: 1/8" = 1'-0"

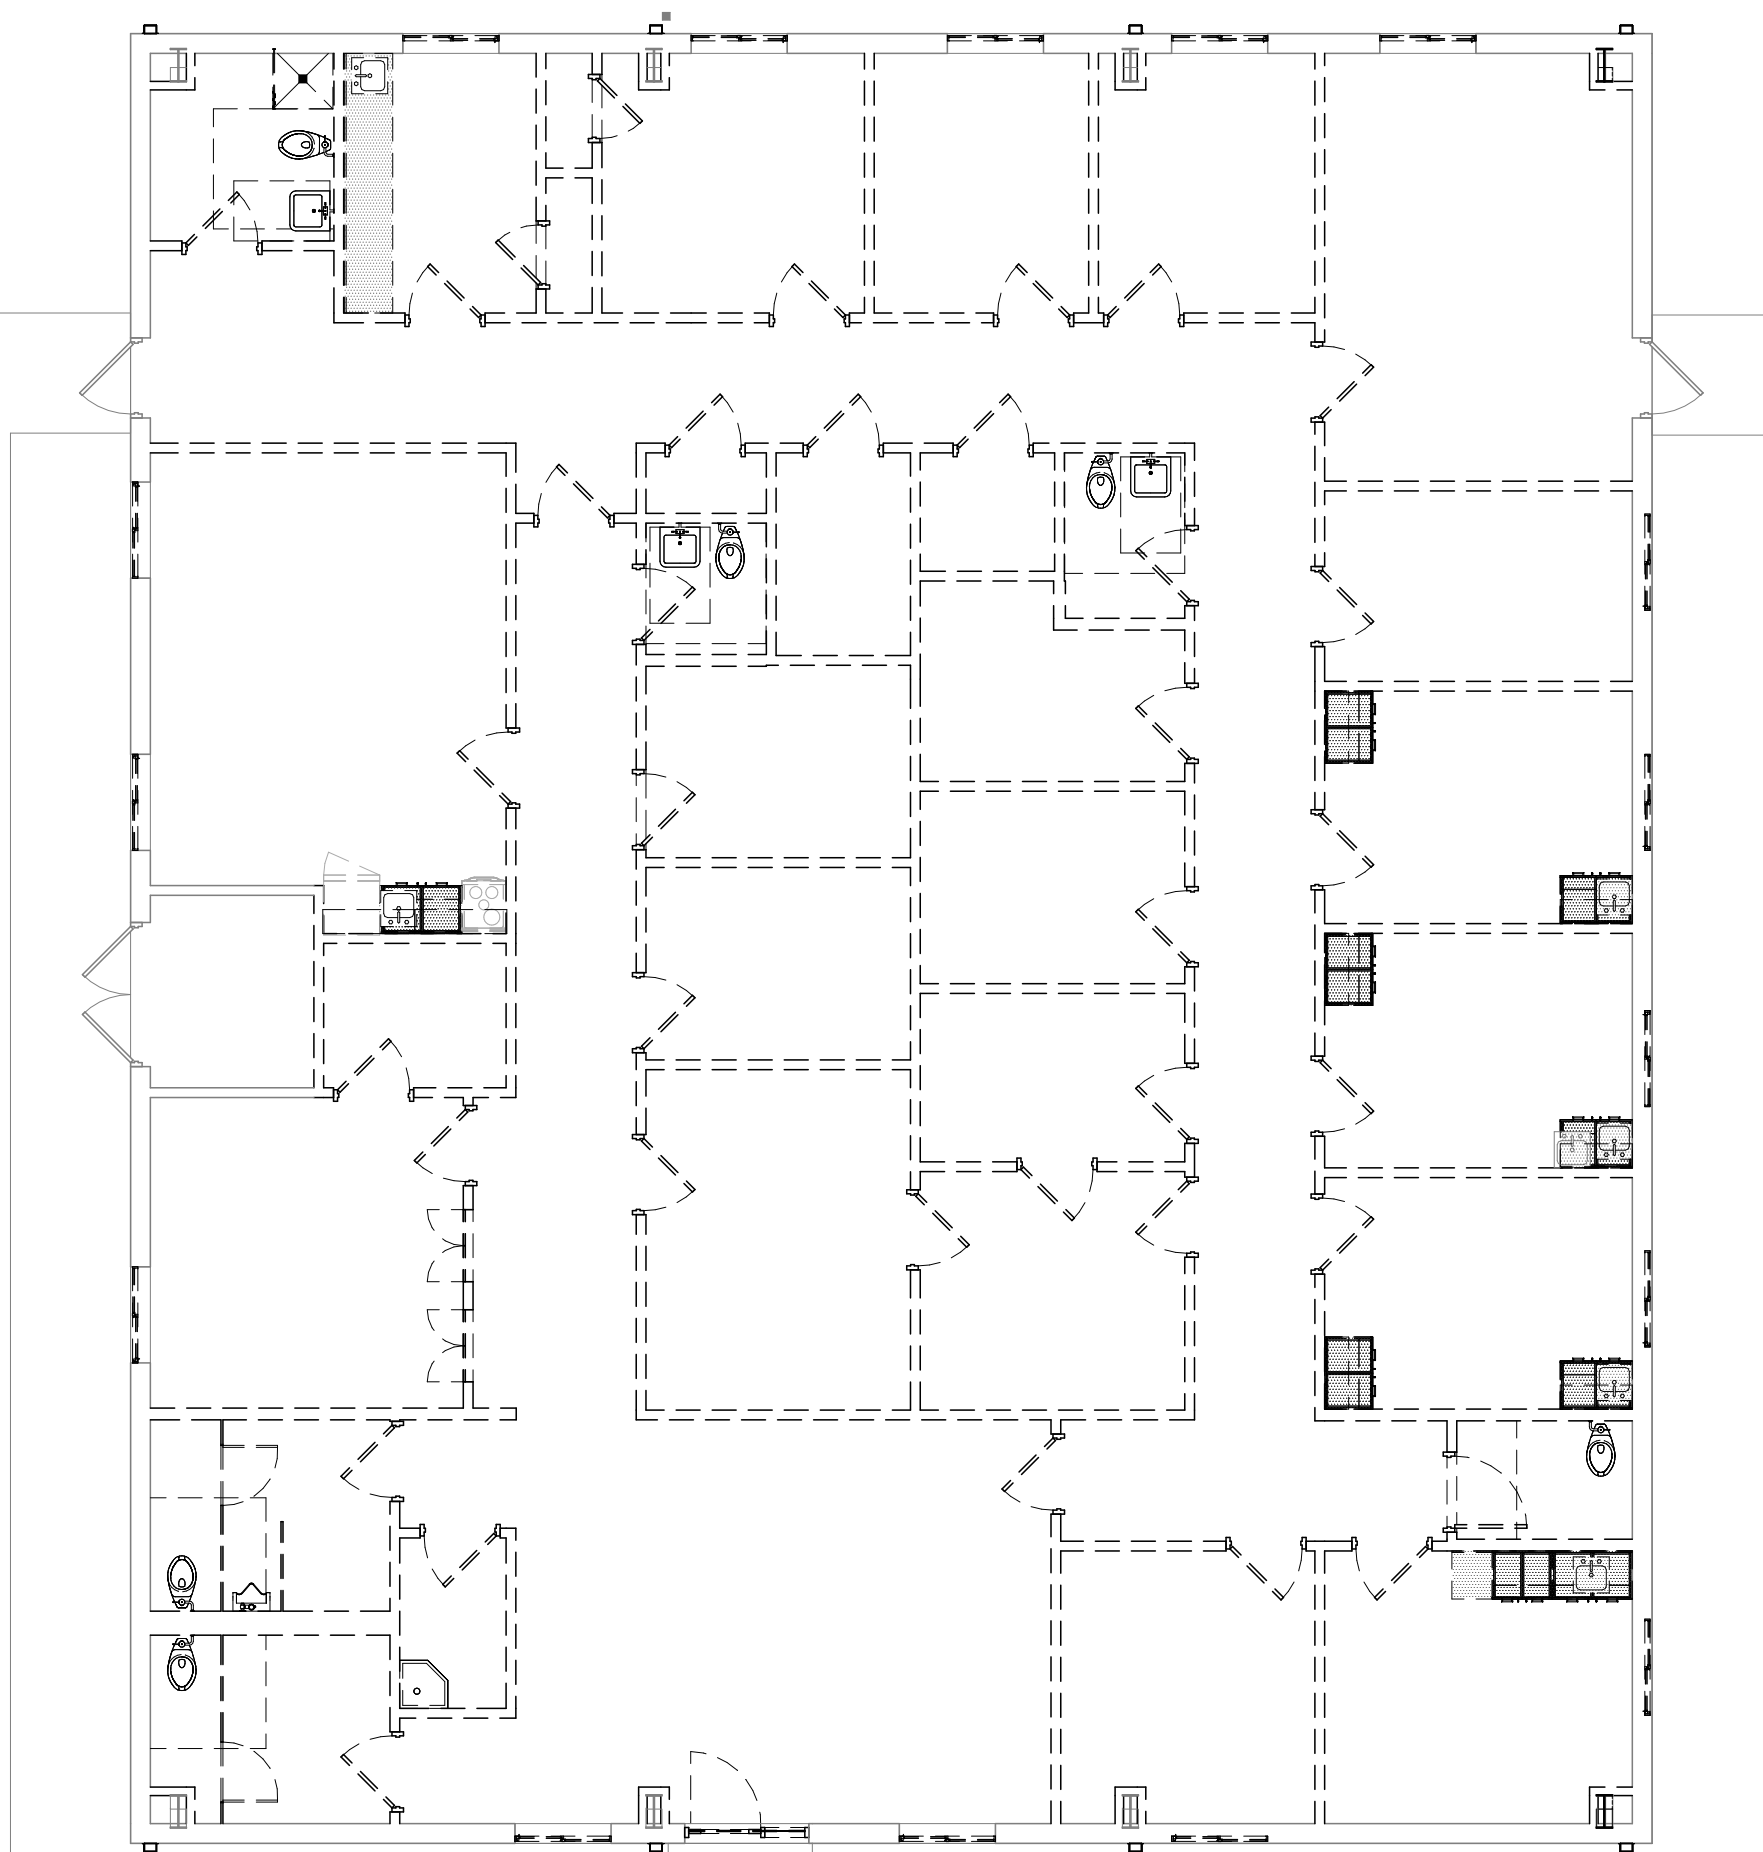

1 Floor Plan-Demo
D1.1 Scale: 1/8" = 1'-0"

GADSDEN CO. BOCC

**Havana
Medical Center
Remodel**

Havana, FL



Clemons, Rutherford,
& Associates, Inc.

Architects
Planners
Interior Designers
Construction Managers
2027 Thomasville Road
Tallahassee, Florida 32308

phone 850-385-6153
fax 850-386-8420
cra@craarchitects.com

The Drawings, Specifications and other documents prepared by Clemons, Rutherford & Associates, Inc. (CRA) for this Project are instruments of CRA for use solely with respect to this Project and, unless otherwise provided, CRA shall be deemed the author of these documents and shall retain all common law, statutory and other reserved rights, including the copyright. The Owner shall be permitted to retain copies, including reproducible copies, of CRA's Drawings, Specifications and other documents for information and reference in connection with the Owner's use and occupancy of the Project. CRA's Drawings, Specifications or other documents shall not be used by the Owner or others on other projects, for documents shall not be used by the Owner or others on other projects, for additions to this Project or for completion of this Project by others, unless the Architect is adjudged to be in default under this Agreement, except by agreement in writing and with appropriate compensation to CRA.

Gregory Westmoreland Kelley
RA00008906

Submittal

Phase	Date	Drw	Chk
100% Construction Doc.	5/26/25	Author	Checker
100% Review Documents	12/16/24		
-	-		
-	-		
-	-		
-	-		

Revision


#	Description	Date

CRA Project # 25027

Phase: 100% Construction
Doc.

SHEET TITLE
DEMO PLANS

D1.1

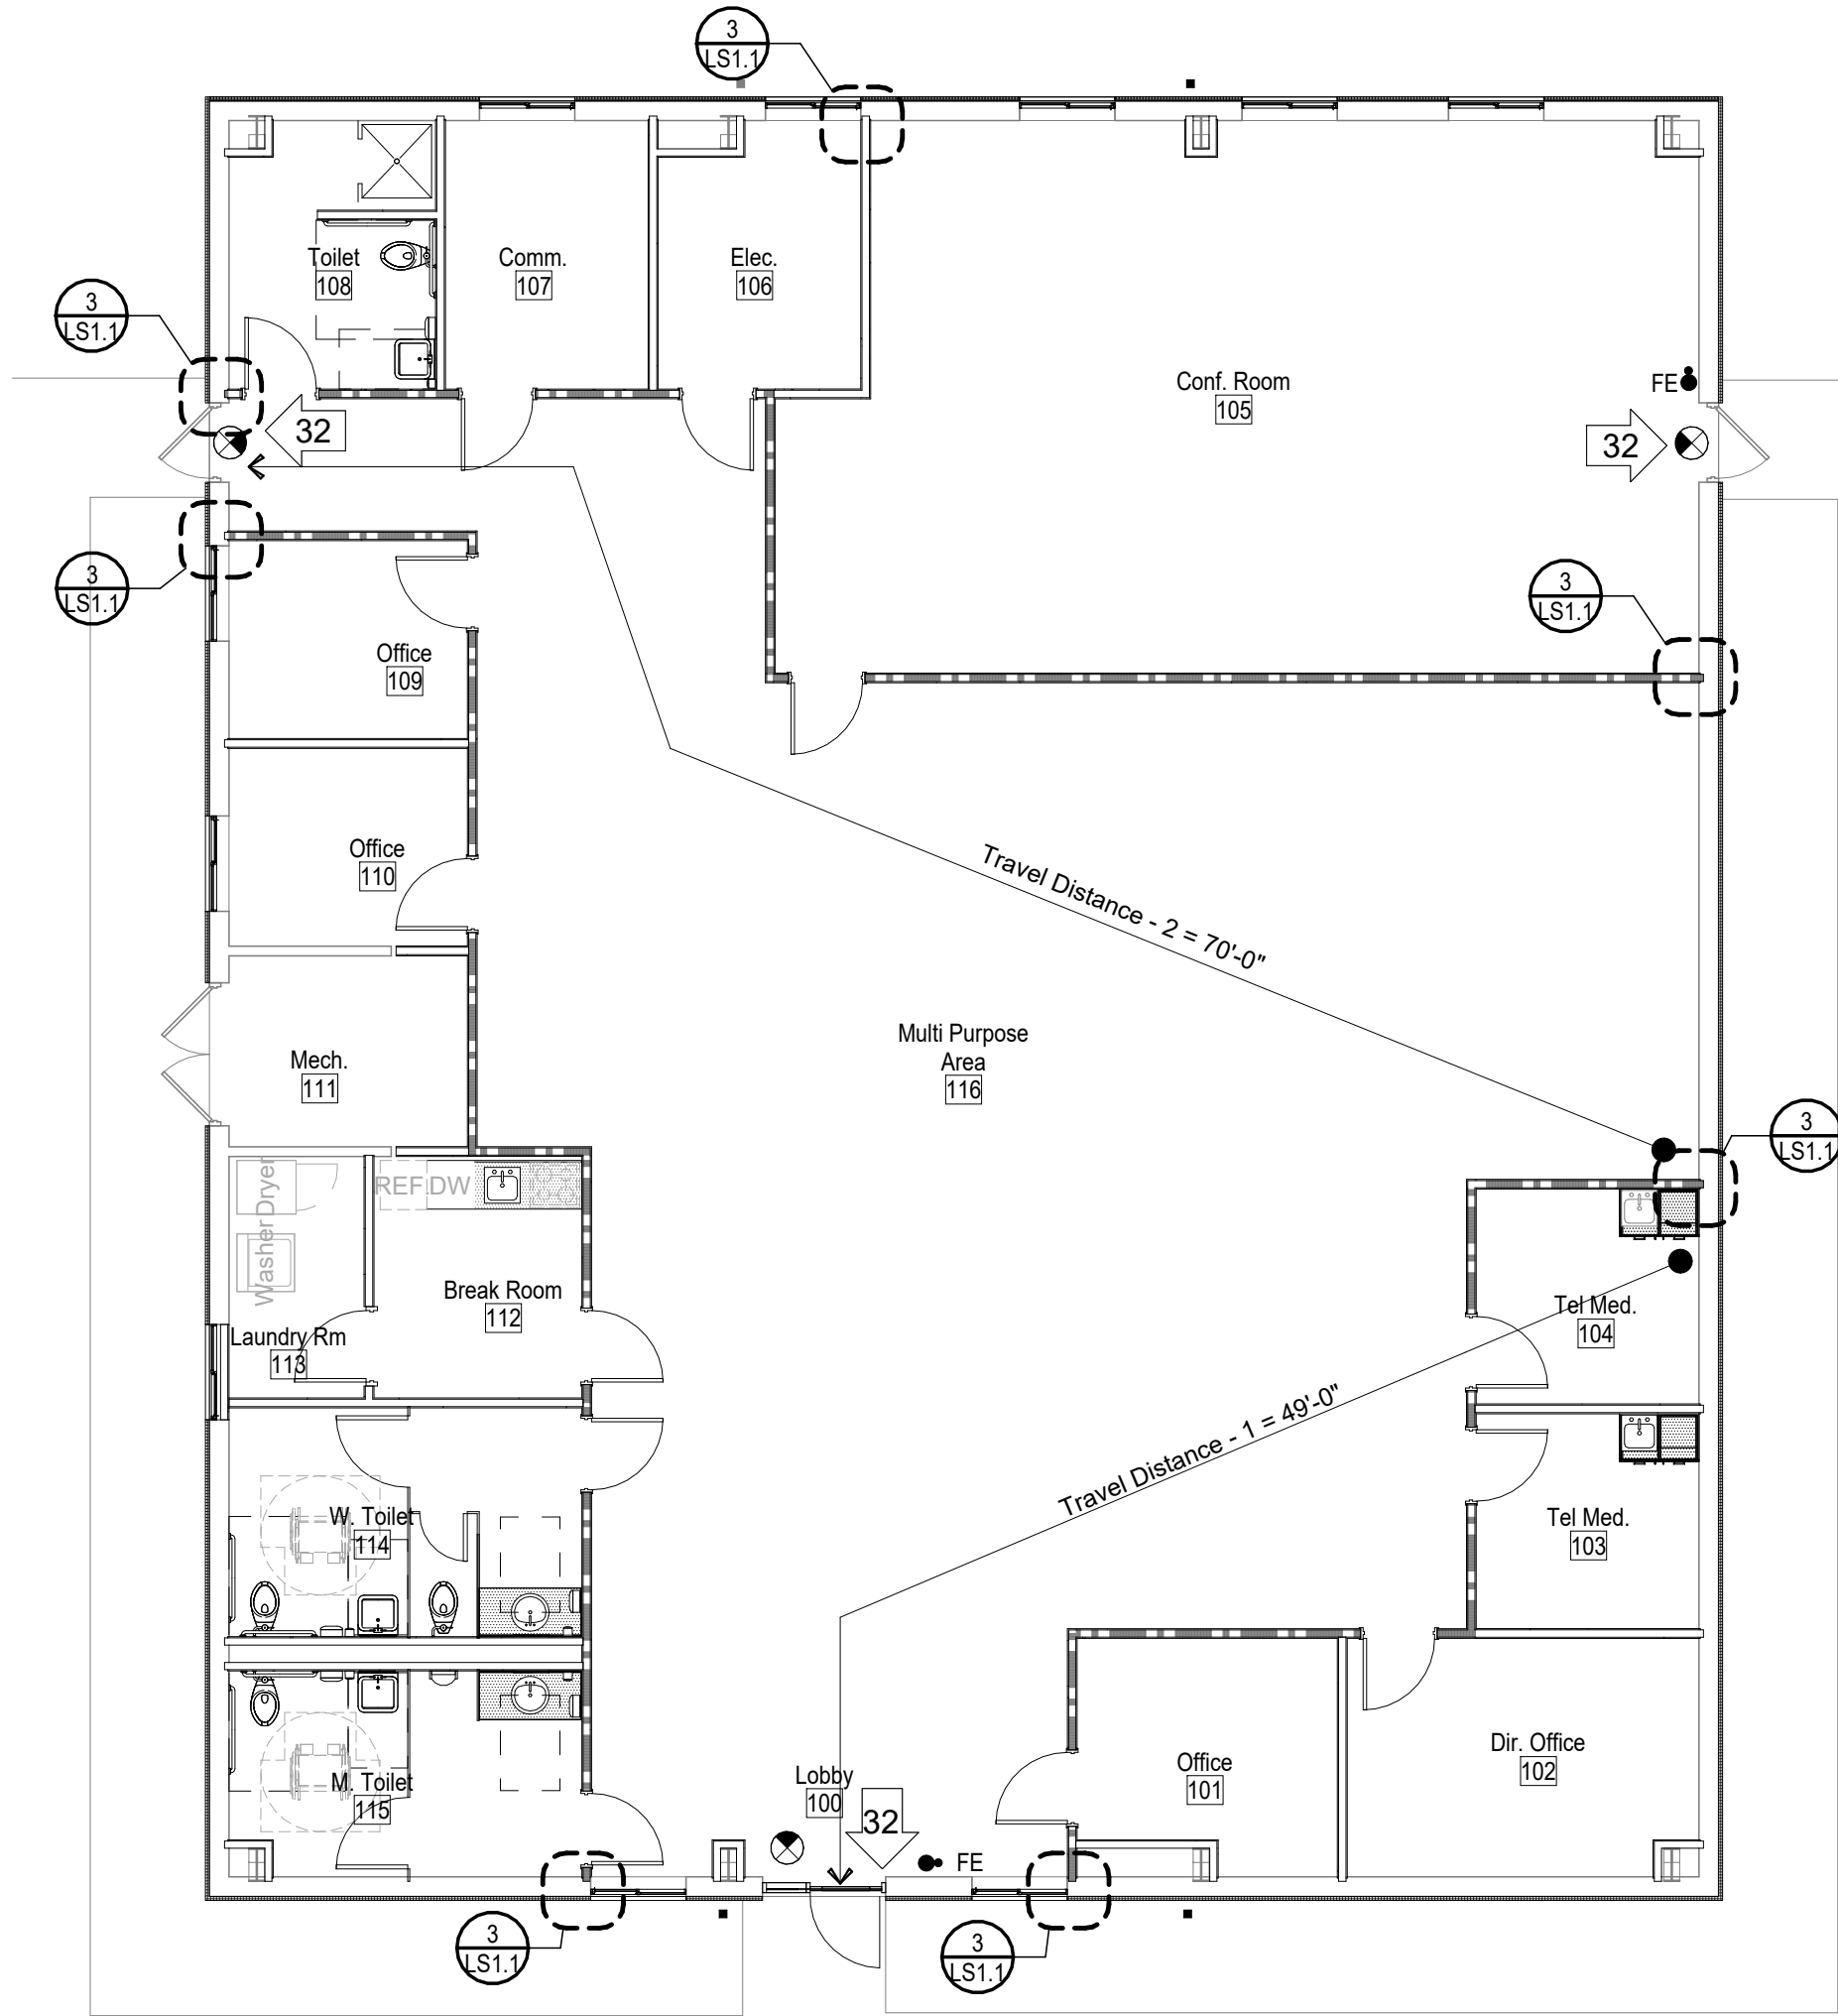


1 Life Safety Plan - First Floor
Scale: 1/8" = 1'-0"

LIFE SAFETY EXIT CALCULATIONS				
Occupant Load		Exit Capacity Required (Minimum Width in Inches)	Exit Capacity Provided (In Inches)	
Occupancy Classification		Level	Level	Total
Business	4,771sf /150 = 32 Occupants	Non-Sprinklered 0.5 (FBC 1005.3.2)	Non-Sprinklered	
			96	96
Total Occupant Load 32		Exit Capacity Required: 16 Inches	Total Exit Width Provided: 96 Inches	
<u>OCCUPANT LOAD CALCULATIONS:</u> Business (B) 4,771 SF of Business Space 1 Person per 150 SF (Per FBC Table 1004.5) 4,771/150 =				

FIRE PROTECTION NOTES

1. All fire AND/OR smoke partitions shall be effectively and permanently identified with stenciling above and decorative ceiling AND/OR in concealed spaces with letters a minimum of two (2) inches high on a contrasting background spaced a maximum of twelve (12) feet on center with a minimum of one (1) wall or barrier. The hourly fire rating shall be included on all rated barrier or walls. Required wording () hour fire and smoke partition-protect all openings.

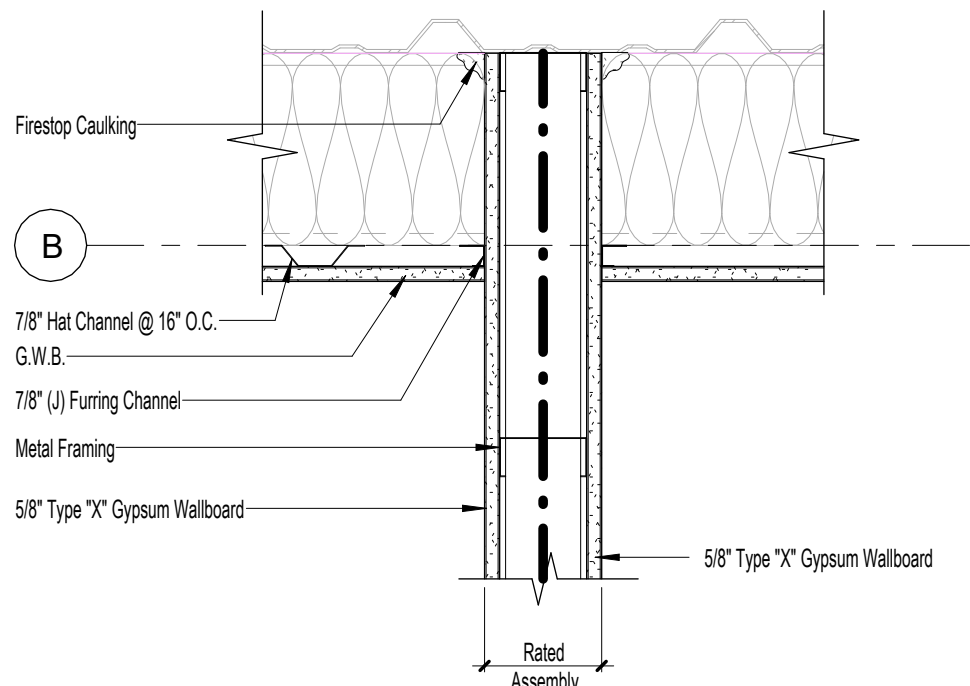

3 Rated Wall Detail - B
Scale: 1 1/2" = 1'-0"

- Life Safety Legend**
- 1 Hour Rated Partition
 - 1 Hour Rated Smoke Partition
 - Smoke Partition
 - 36 Egress Width and Direction
 - Exit Light & Direction
 - Fire Alarm Horn
 - FACP Fire Alarm Control Panel
 - Fire Extinguisher Cabinet (F.E.C.)
 - Fire Extinguisher-Wall Mounted (F.E.C.)
 - Travel Path End
 - Travel Path Begin
 - 125'-6" 125' Travel Distance
 - Smoke Detector
 - F Visual Signaling Device
 - F Visual Signaling Device
 - Fire Alarm Door opening Device
 - Emergency Lighting
 - Rated Tunnel

GADSDEN CO. BOCC

Havana Medical Center Remodel

Havana, FL



Clemons, Rutherford, & Associates, Inc.

Architects
Planners
Interior Designers
Construction Managers

2027 Thomasville Road
Tallahassee, Florida 32308

phone 850-385-6153

fax 850-386-8420

cra@craarchitects.com

The Drawings, Specifications and other documents prepared by Clemons, Rutherford & Associates, Inc. (CRA) for this Project are instruments of CRA for use solely with respect to this Project and, unless otherwise provided, CRA shall be deemed the author of these documents and shall retain all common law, statutory and other reserved rights, including the copyright. The Owner shall be permitted to retain copies, including reproducible copies, of CRA's Drawings, Specifications and other documents for information and reference in connection with the Owner's use and occupancy of the Project. CRA's Drawings, Specifications or other documents shall not be used by the Owner or others on other projects, for documents shall not be used by the Owner or for completion of this Project by others, unless the Architect is adjudged to be in default under this Agreement, except by agreement in writing and with appropriate compensation to CRA.

Gregory Westmoreland Kelley
AR0016706

Submittal

Phase	Date	Drw	Chk
100% Construction Doc.	5/26/25	BY	GK
100% Review Documents	12/16/24		
-	-		
-	-		
-	-		
-	-		

Revision

#	Description	Date


CRA Project # 25027

Phase: 100% Construction Doc.


SHEET TITLE

First & Second Floor
Life Safety Plan


LS1.1

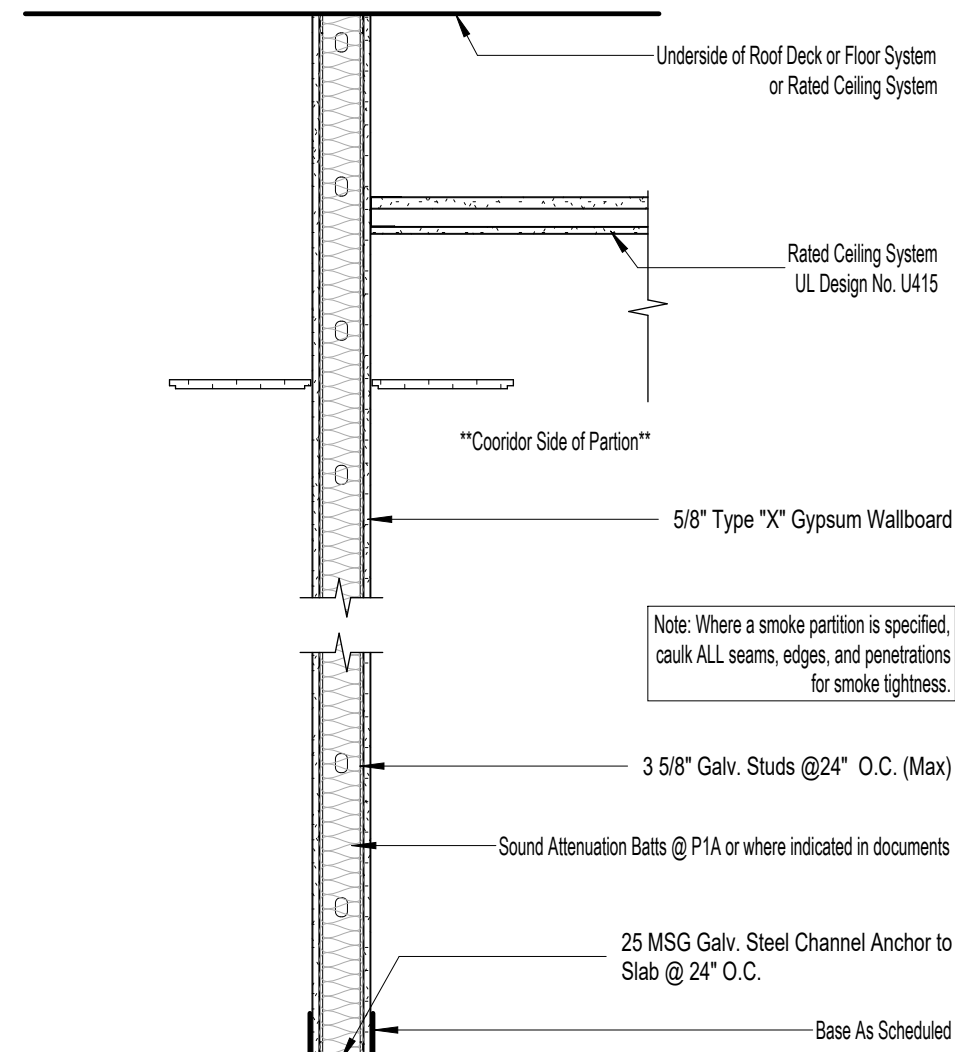


P1 - One Hour Fire Rated = UL# 465
P1A - One Hour Fire Rated = UL# 465 (with 6" Stud)

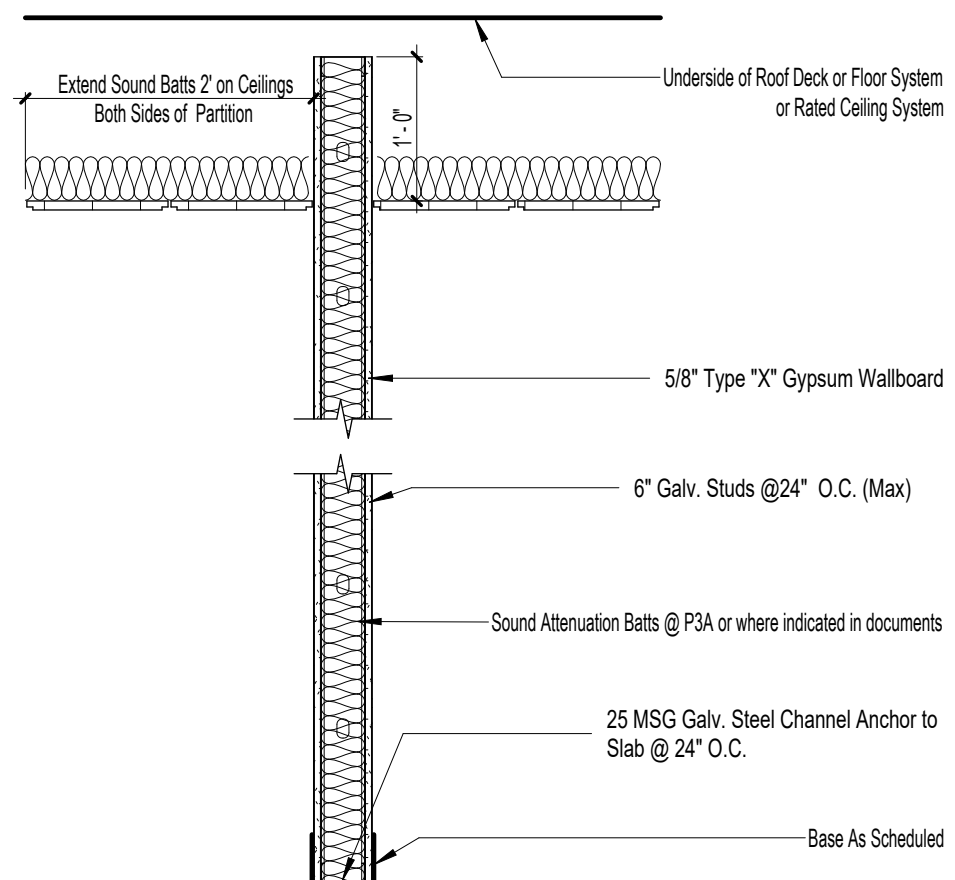


P3 - Typical GWB Partition
P3A - Typical GWB Partition w/Sound Attenuation Batts

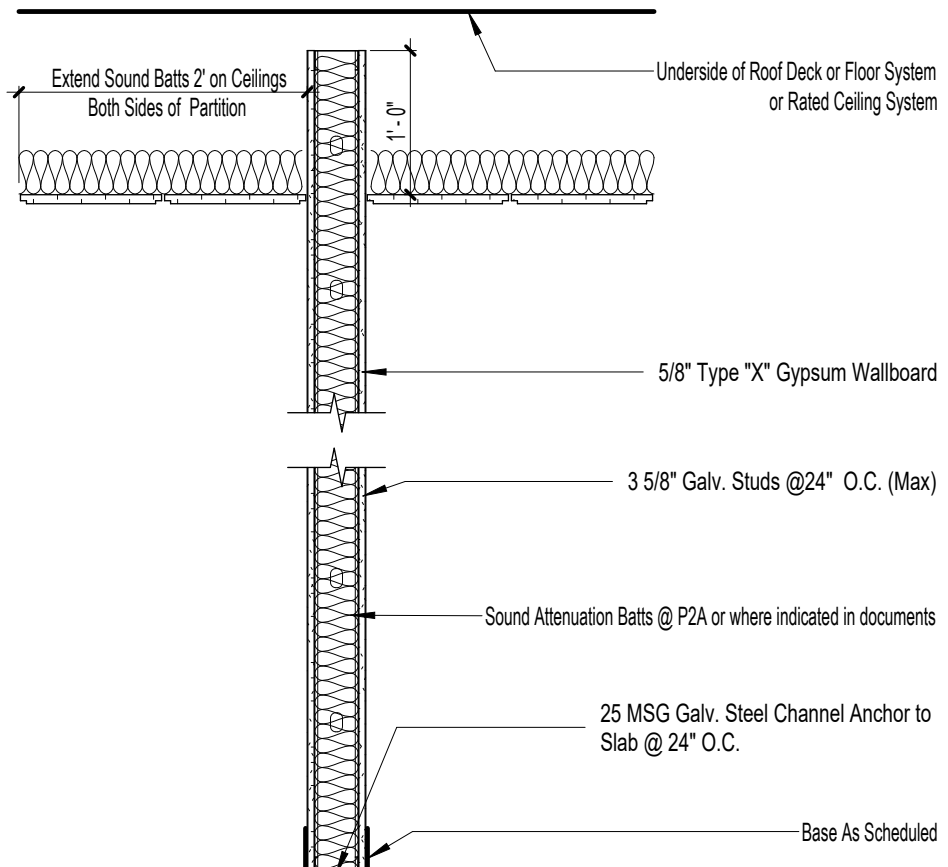

P2 - Typical GWB Partition
P2A - Typical GWB Partition w/Sound Attenuation Batts

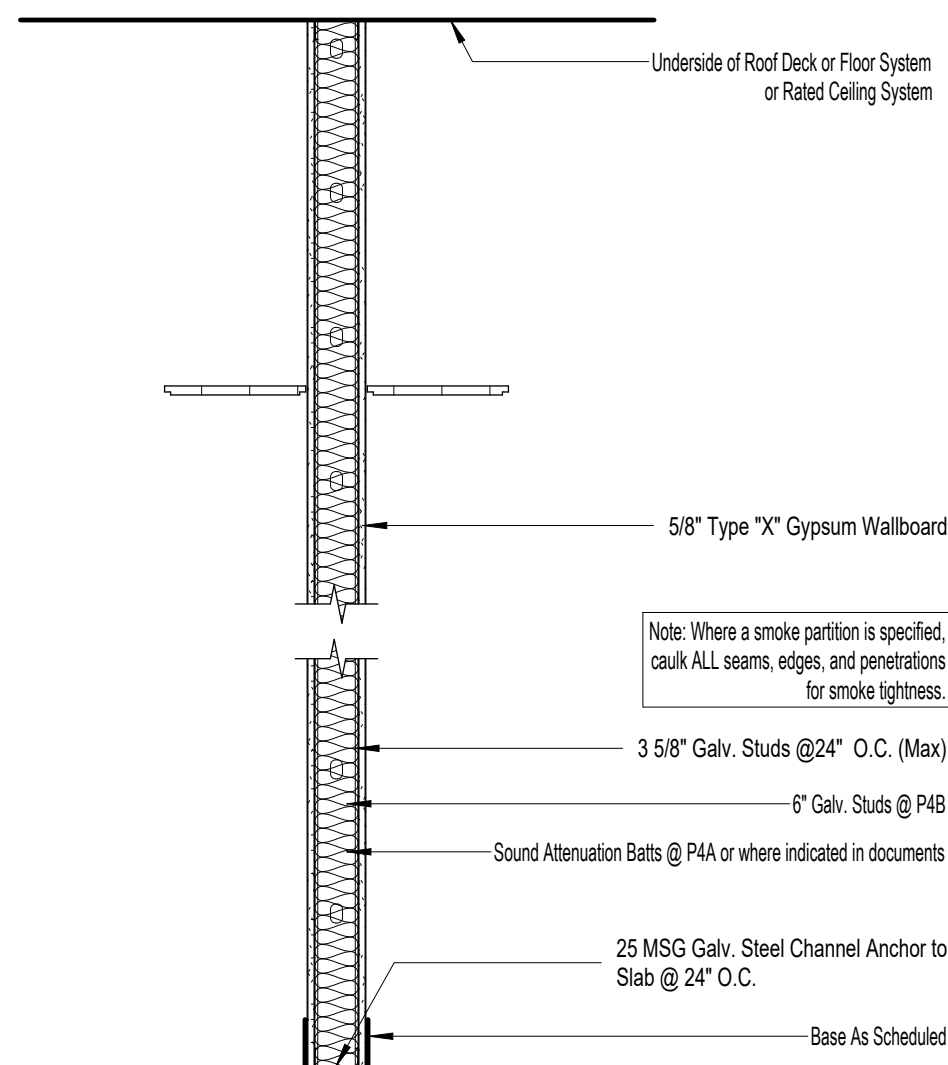

P4 - Full Height GWB Partition
P4A - Full Height GWB Partition with Sound Attenuation Batts
P4B - Full Height GWB Partition with Sound Attenuation Batts 6" Stud

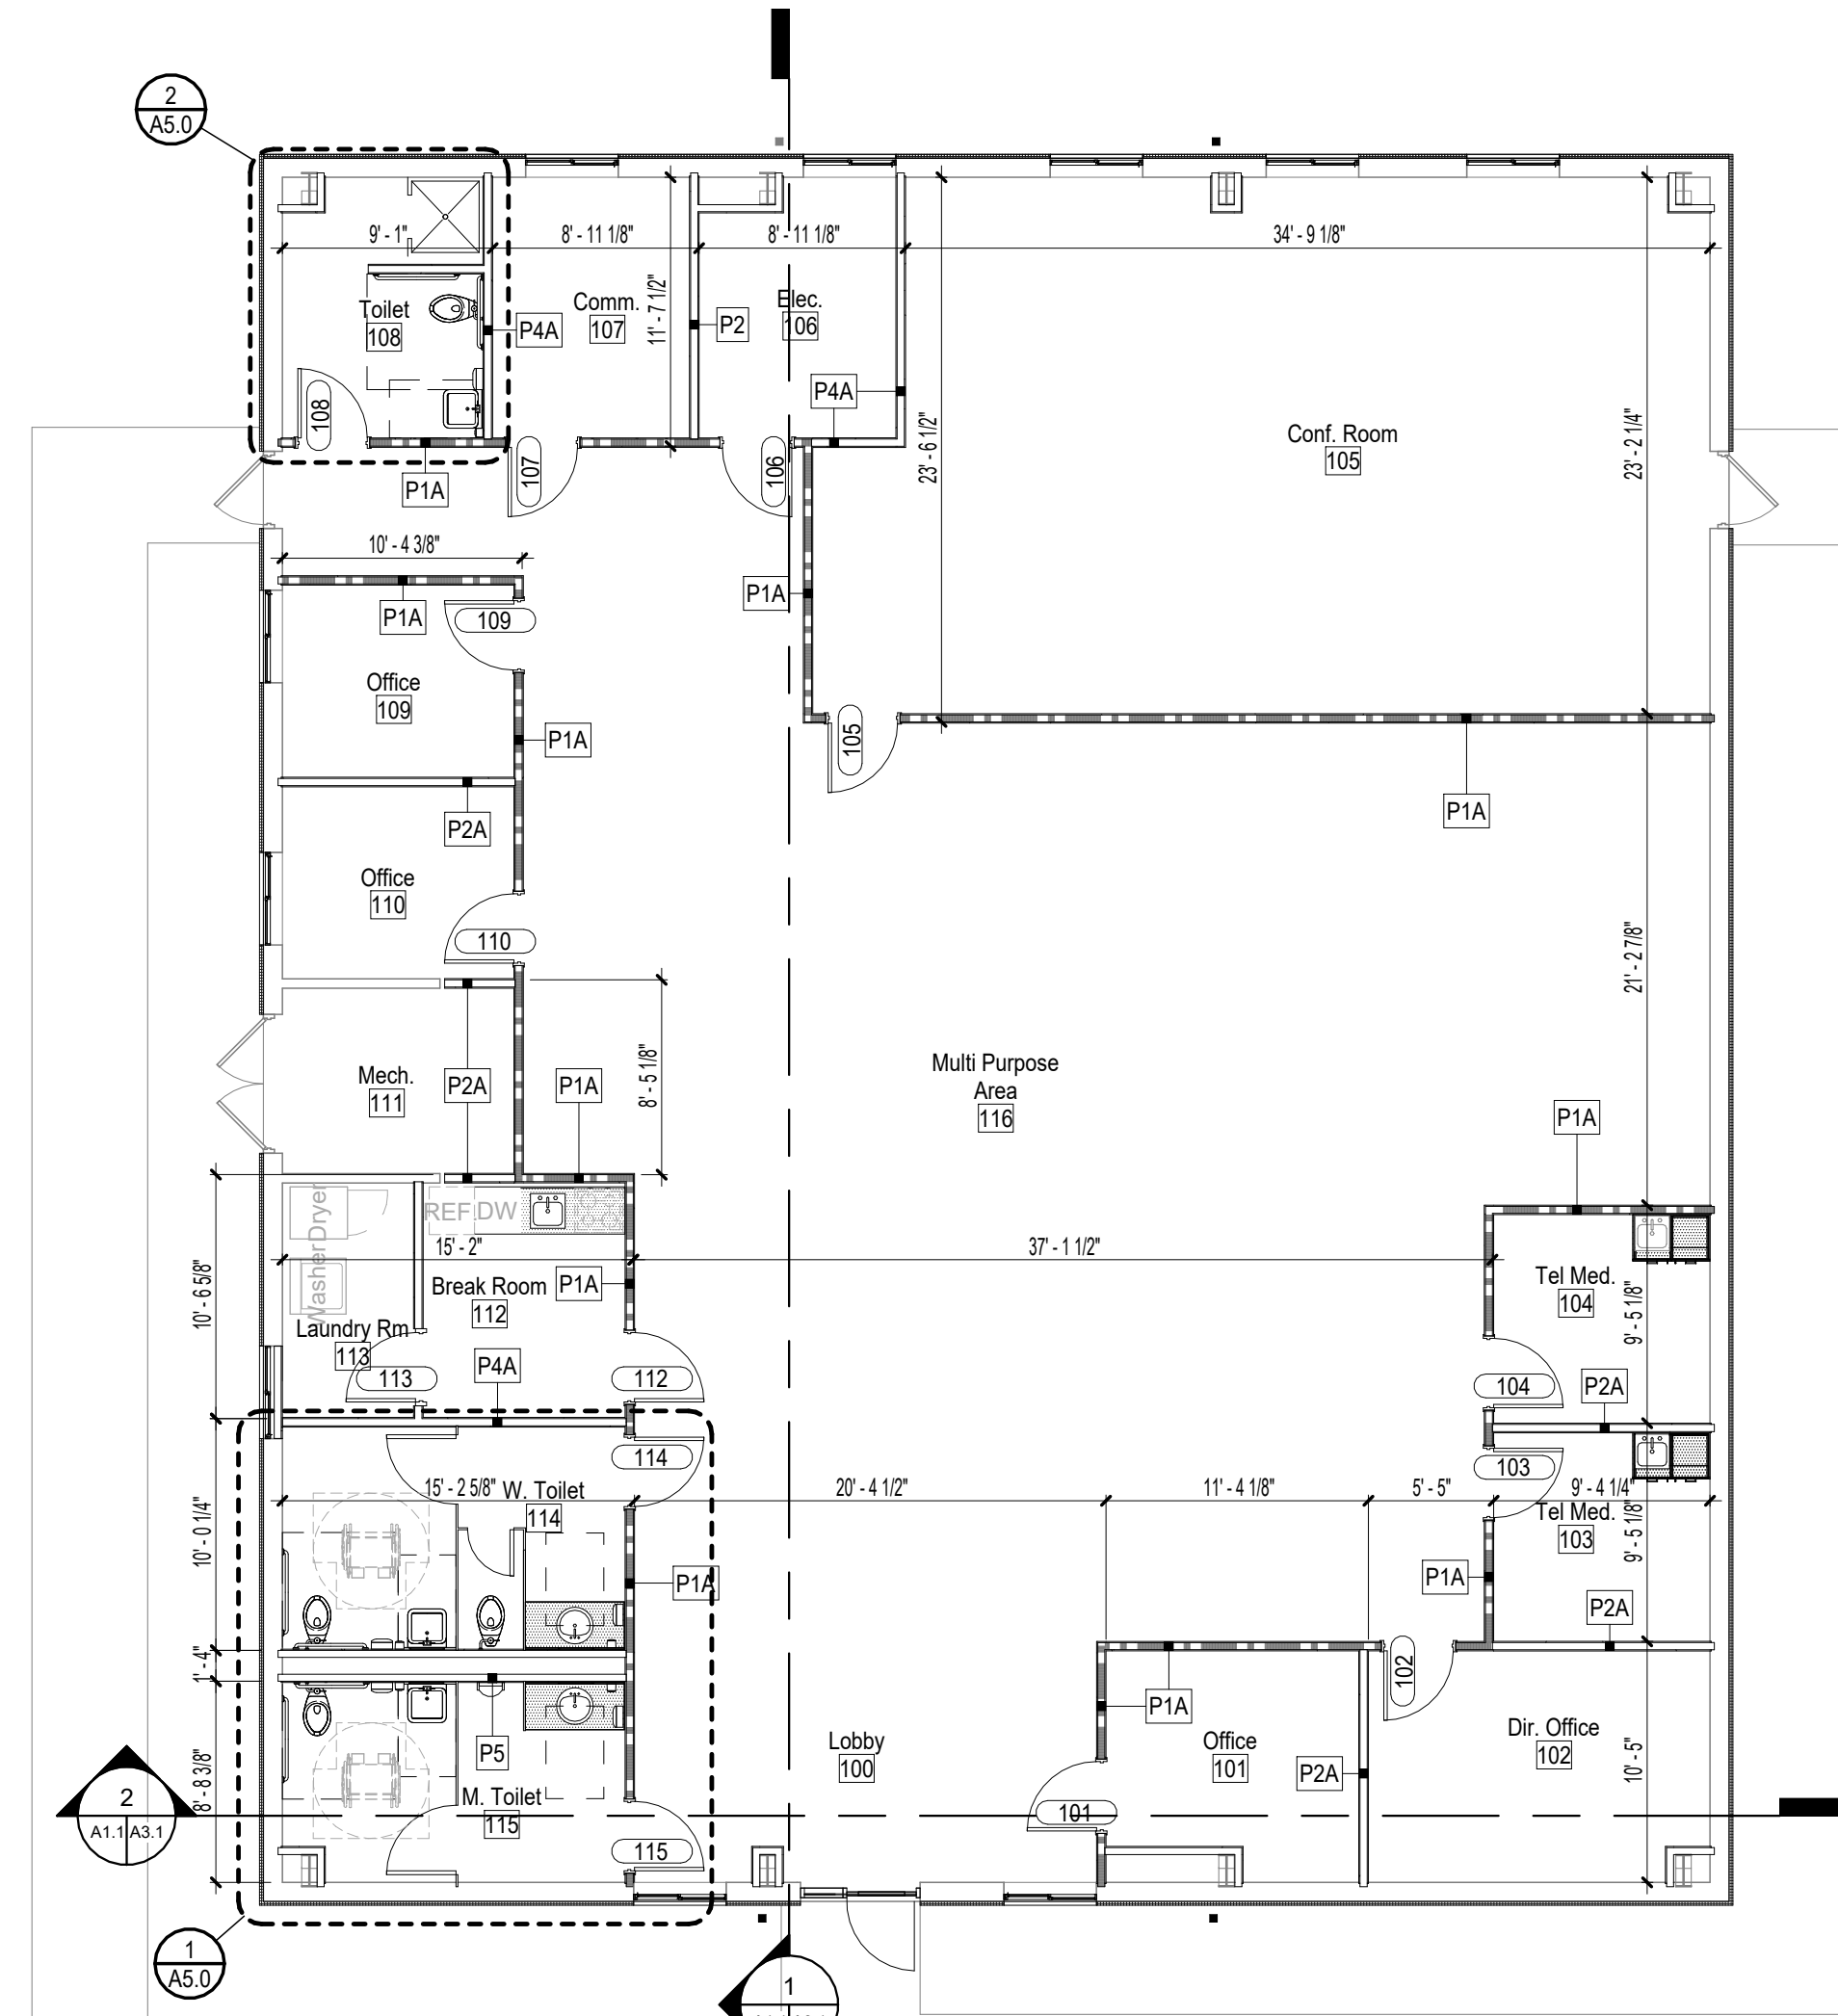

1 Floor Plan-New
Scale: 1/8" = 1'-0"

Legend

- 1 Hour Rated Partition
- 2 Hour Rated Partition
- 1 Hour/Smoke Rated Partition
- 2 Hour/Smoke Rated Partition
- Smoke Partition
- Partition Type Tag
- New Door
- Room name
- Room Tag
- Room Name
- Room Number
- Finish Tag
- Ceiling Type
- Wall Finish
- Base Type
- Floor Covering
- Section Number
- Sheet Shown
- Sheet Taken From
- Door Symbol
- Storefront Symbol
- Window Symbol
- Casework
- Furnishings by Owner (Reference Only)
- Revision Symbol
- Equipment Flag
- Direction
- Sheet Shown
- Elevation Number- on Sheet
- Elevation Letter- Found in the Name of Detail
- Structural Grid & Column
- Toilet Accessory

GADSDEN CO. BOCC

Havana Medical Center Remodel

Havana, FL



Clemons, Rutherford, & Associates, Inc.

Architects
Planners
Interior Designers
Construction Managers
2027 Thomasville Road
Tallahassee, Florida 32308

phone 850-385-6153
fax 850-386-8420
cra@craarchitects.com

The Drawings, Specifications and other documents prepared by Clemons, Rutherford & Associates, Inc. (CRA) for this Project are instruments of CRA for use solely with respect to this Project and, unless otherwise provided, CRA shall be deemed the author of these documents and shall retain all common law, statutory and other reserved rights, including the copyright. The Owner shall be permitted to retain copies, including reproducible copies, of CRA's Drawings, Specifications and other documents for information and reference in connection with the Owner's use and occupancy of the Project. CRA's Drawings, Specifications and other documents shall not be used by the Owner or others on other projects, for documents shall not be used by the Owner or others on other projects, for additions to this Project or for completion of this Project by others, unless the Architect is adjudged to be in default under this Agreement, except by agreement in writing and with appropriate compensation to CRA.

Gregory Westmoreland Kelley
AR0016706

Submittal

Phase	Date	Drw	Chk
100% Construction Doc.	5/26/25	DBY	DBY
100% Review Documents	12/16/24		
-	-		
-	-		
-	-		
-	-		

Revision


#	Description	Date

CRA Project # **25027**


Phase: **100% Construction Doc.**

SHEET TITLE
First Floor Plan


A1.1

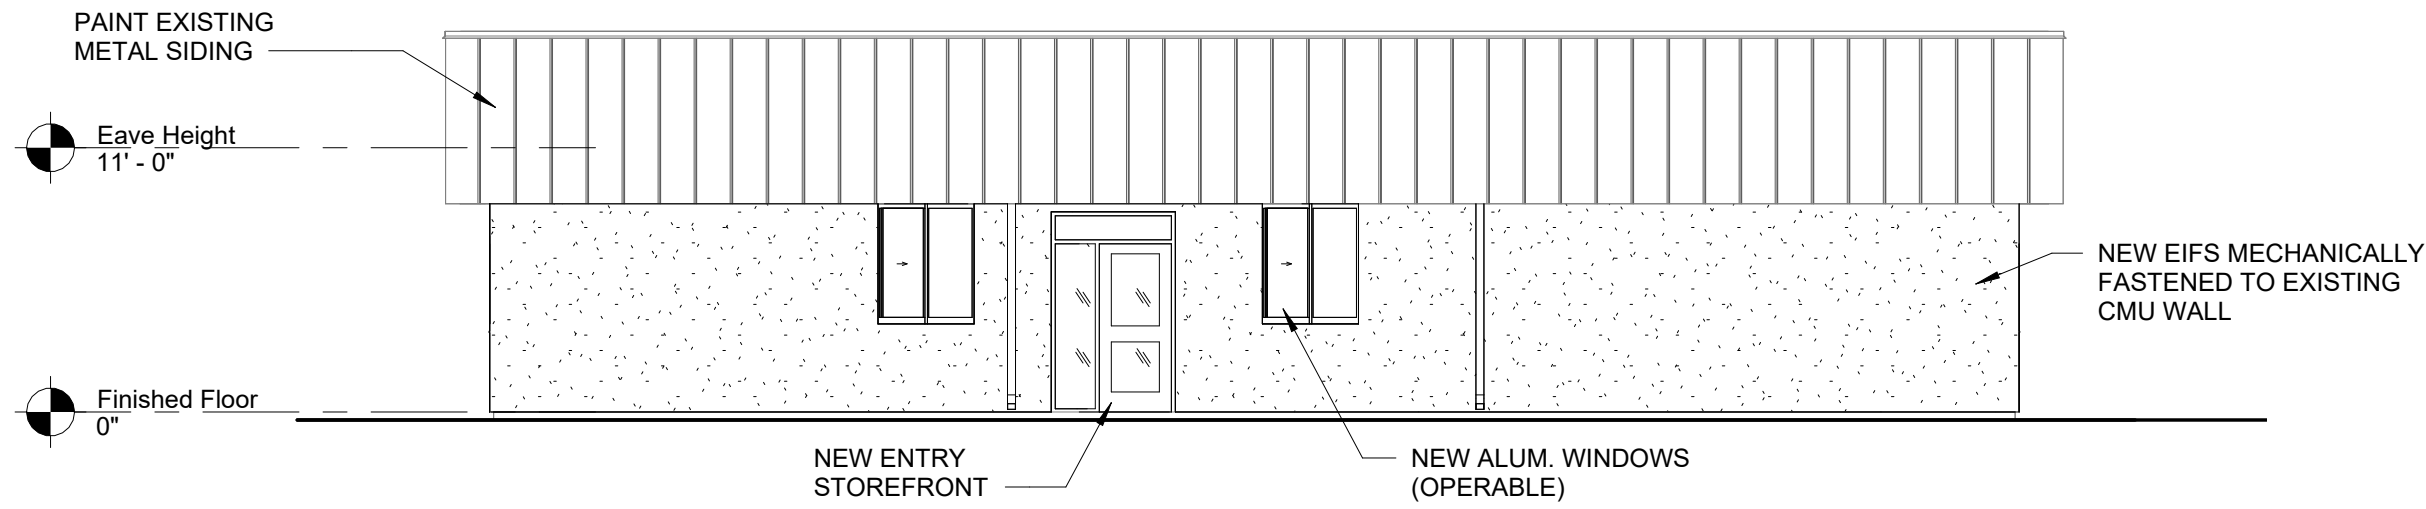


1 Front Elevation-NEW
A2.1 Scale: 1/8" = 1'-0"

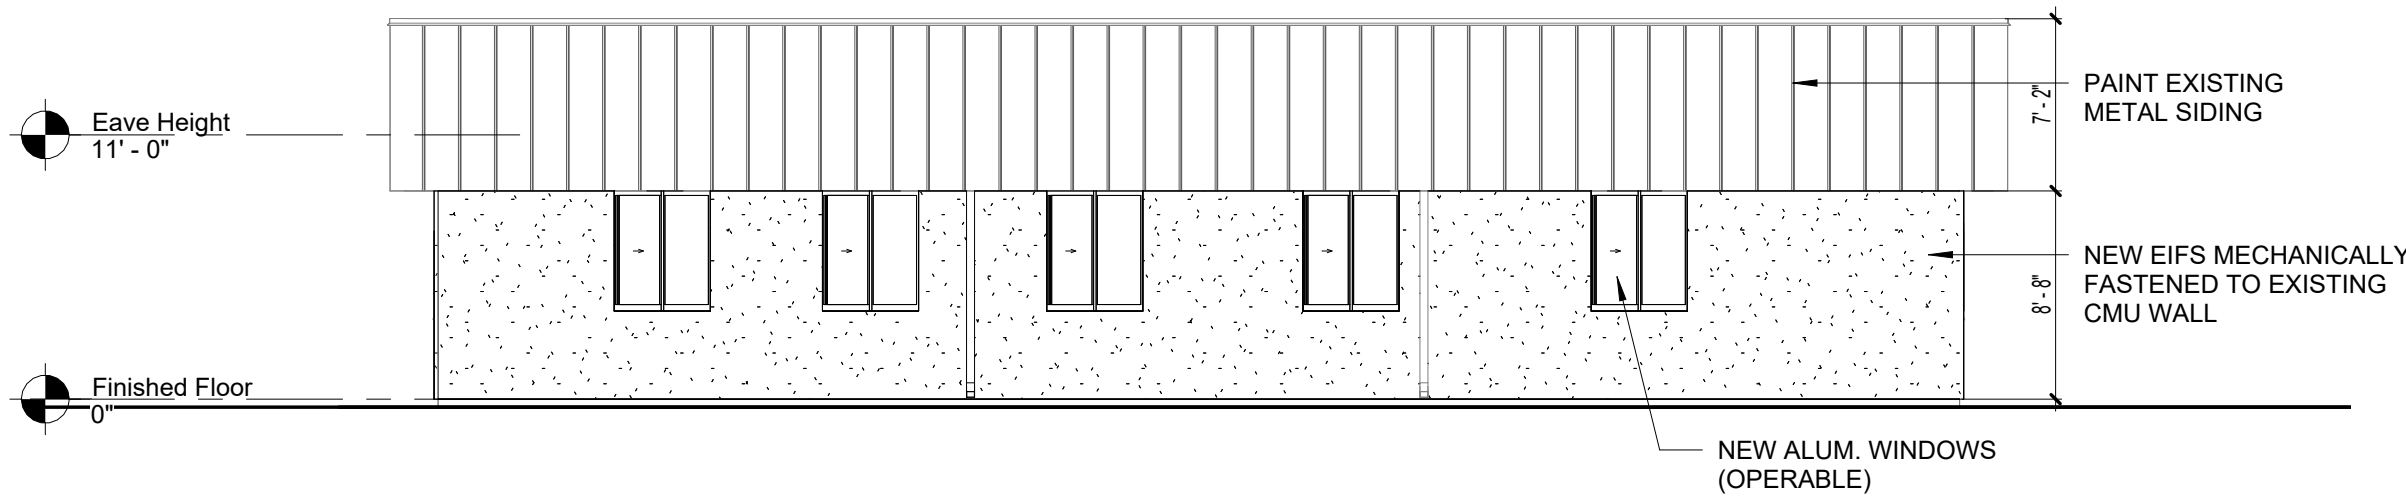

2 Rear Elevation-NEW
A2.1 Scale: 1/8" = 1'-0"

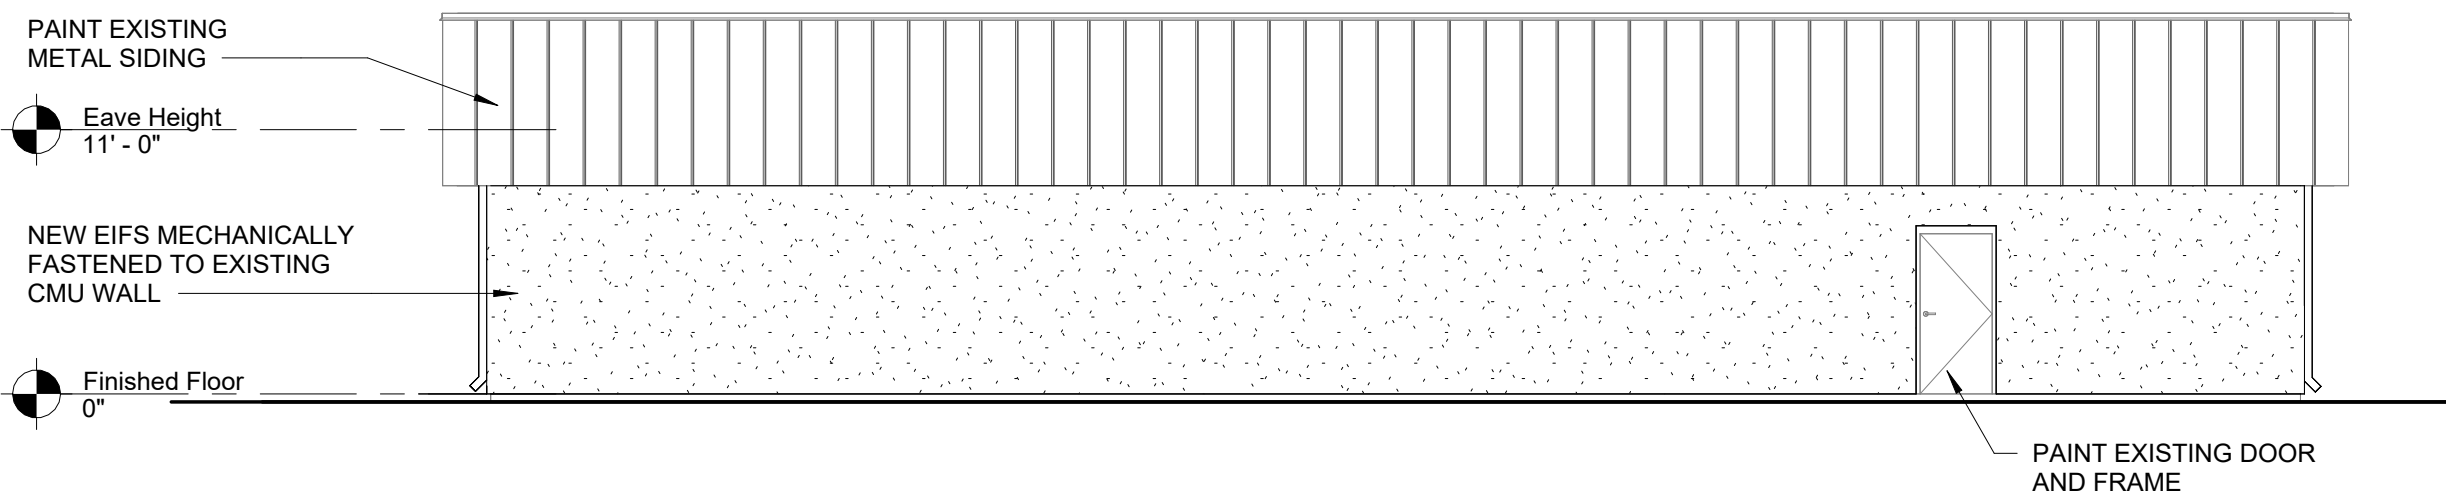

3 Side Elevation A-NEW
A2.1 Scale: 1/8" = 1'-0"

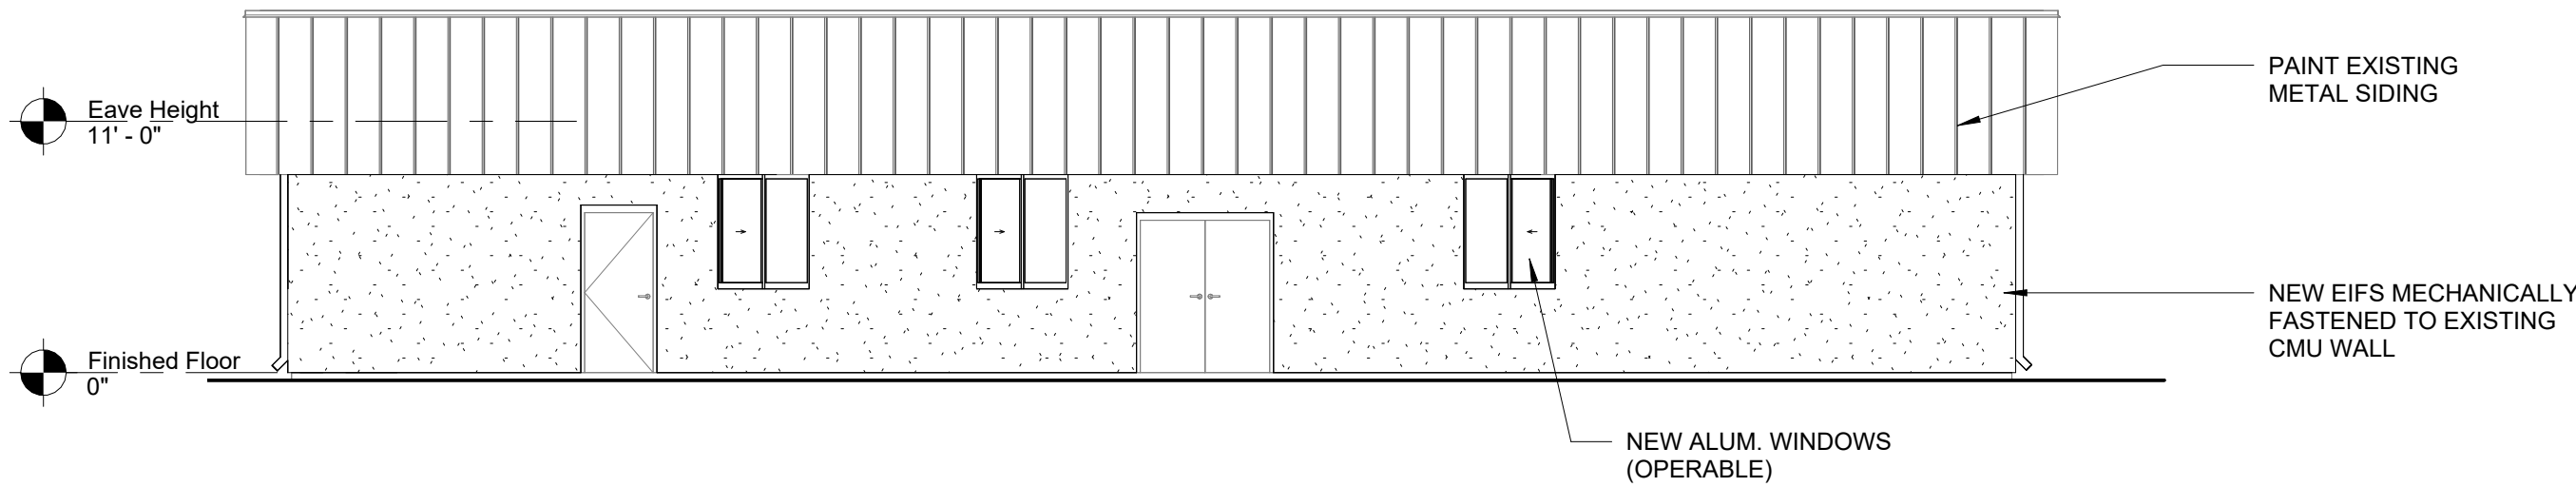

4 Side Elevation B-NEW
A2.1 Scale: 1/8" = 1'-0"

GADSDEN CO. BOCC

Havana
Medical Center
Remodel

Havana, FL



Clemons,Rutherford,
& Associates, Inc.

Architects
Planners
Interior Designers
Construction Managers

2027 Thomasville Road
Tallahassee, Florida 32308

phone 850-385-6153
fax 850-386-8420
cra@craarchitects.com

The Drawings, Specifications and other documents prepared by Clemons, Rutherford & Associates, Inc. (CRA) for this Project are instruments of CRA for use solely with respect to this Project and, unless otherwise provided, CRA shall be deemed the author of these documents and shall retain all common law, statutory and other reserved rights, including the copyright. The Owner shall be permitted to retain copies, including reproducible copies, of CRA's Drawings, Specifications and other documents for information and reference in connection with the Owner's use and occupancy of the Project. CRA's Drawings, Specifications or other documents shall not be used by the Owner or others on other projects, for documents shall not be used by the Owner or others on other projects, for additions to this Project or for completion of this Project by others, unless the Architect is adjudged to be in default under this Agreement, except by agreement in writing and with appropriate compensation to CRA.

Gregory Westmoreland Kelley
AR0016706

Submittal

Phase	Date	Drw	Chk
100% Construction Doc.	5/26/25	DBY	GK
100% Review Documents	12/16/24		
-	-		
-	-		
-	-		
-	-		

Revision

#	Description	Date

CRA Project # 25027

Phase: 100% Construction
Doc.

SHEET TITLE
Building Elevations

A2.1

C:\25027\14.3.DWG

G:\Production\CRA Jobs\2025\25027 - Gadsden Co BOCC - Havana Health Dept Remodel\Drawings\CRA DWG\A2.1 100%25027 CDW.dwg

GADSDEN CO. BOCC

Havana
Medical Center
Remodel

Havana, FL



Clemons, Rutherford,
& Associates, Inc.

Architects
Planners
Interior Designers
Construction Managers

2027 Thomasville Road
Tallahassee, Florida 32308

phone 850-385-6153
fax 850-386-8420
cra@craarchitects.com

The Drawings, Specifications and other documents prepared by Clemons, Rutherford & Associates, Inc. (CRA) for this Project are instruments of CRA for use solely with respect to this Project and, unless otherwise provided, CRA shall be deemed the author of these documents and shall retain all common law, statutory and other reserved rights, including the copyright. The Owner shall be permitted to retain copies, including reproducible copies, of CRA's Drawings, Specifications and other documents for information and reference in connection with the Owner's use and occupancy of the Project. CRA's Drawings, Specifications or other documents shall not be used by the Owner or others on other projects, for documents shall not be used by the Owner or others on other projects, for additions to this Project or for completion of this Project by others, unless the Architect is adjudged to be in default under this Agreement, except by agreement in writing and with appropriate compensation to CRA.

Gregory Westmoreland Kelley
AR0016706

Submittal

Phase	Date	Drw	Chk
100% Construction Doc.	5/26/25	BY	GK
100% Review Documents	12/16/24		
-	-		
-	-		
-	-		
-	-		

Revision

#	Description	Date


CRA Project # 25027

Phase: 100% Construction
Doc.

SHEET TITLE


Building Sections

A3.1

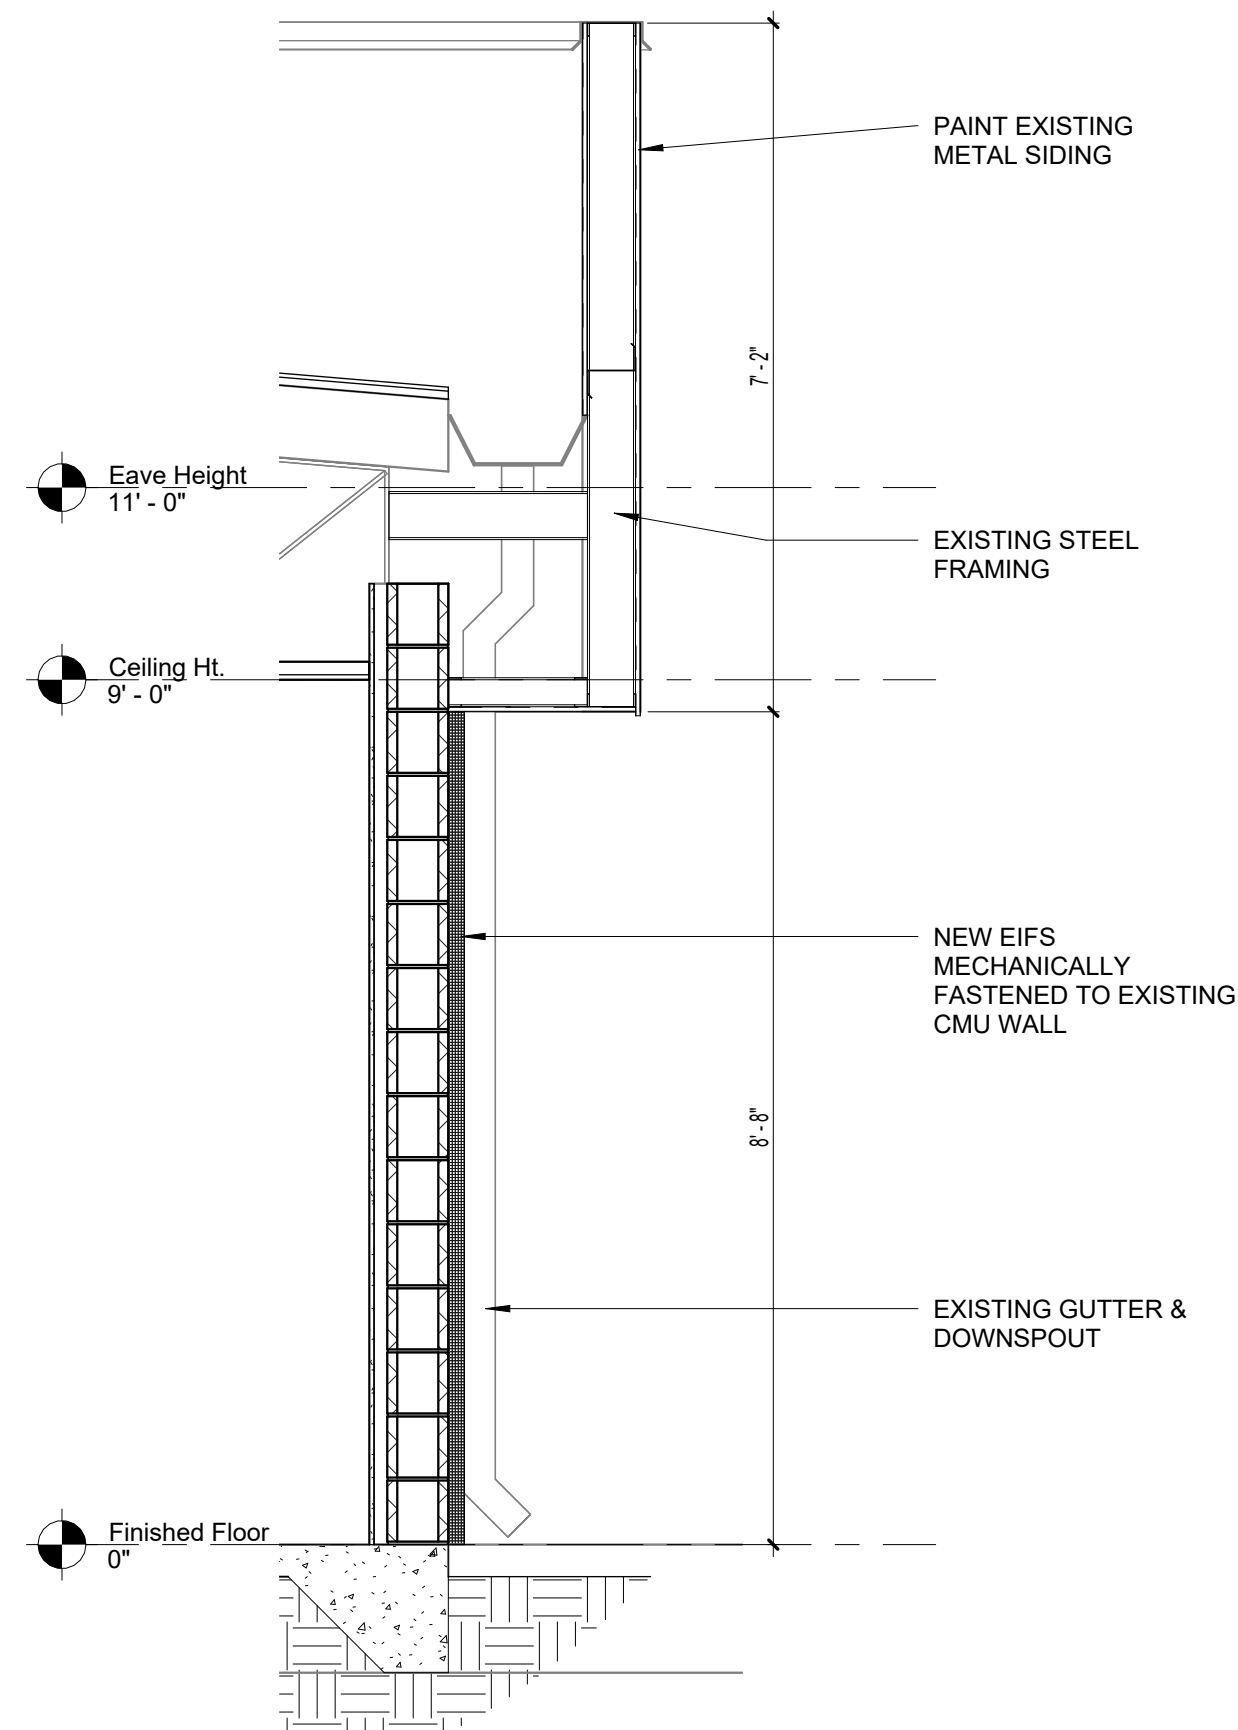


3 Exterior Wall Section, Typ.

A3.1 Scale: 1/2" = 1'-0"

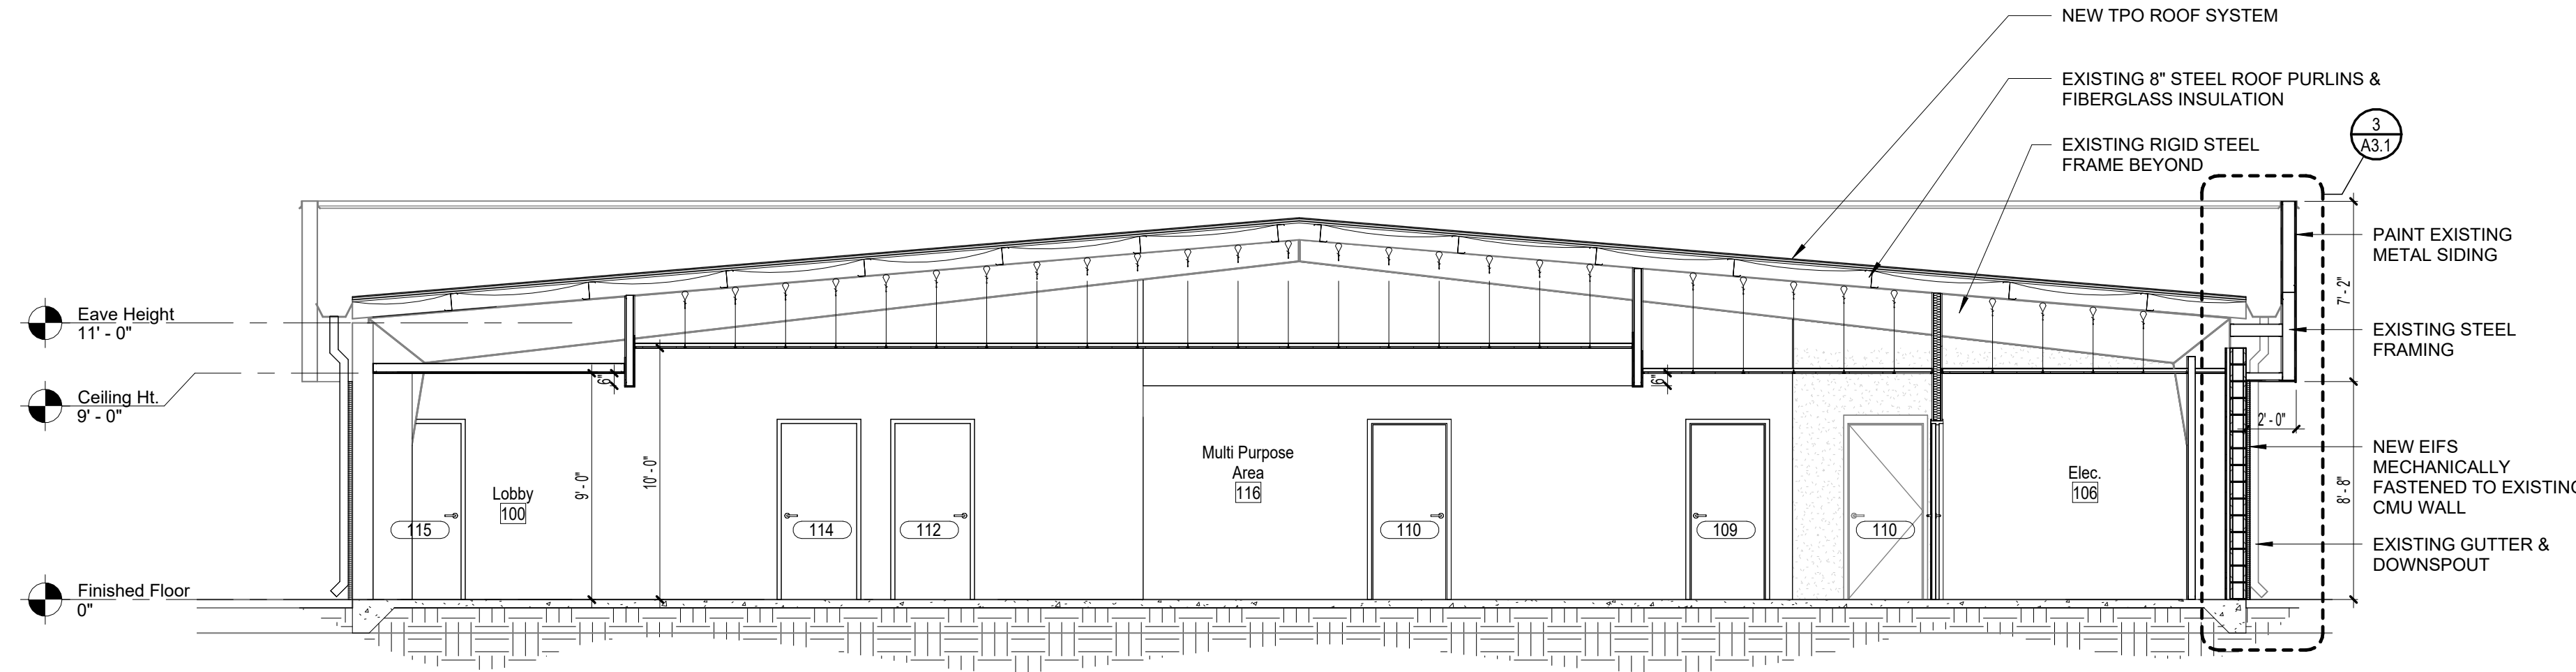


1 BUILDING SECTION


A3.1 Scale: 3/16" = 1'-0"

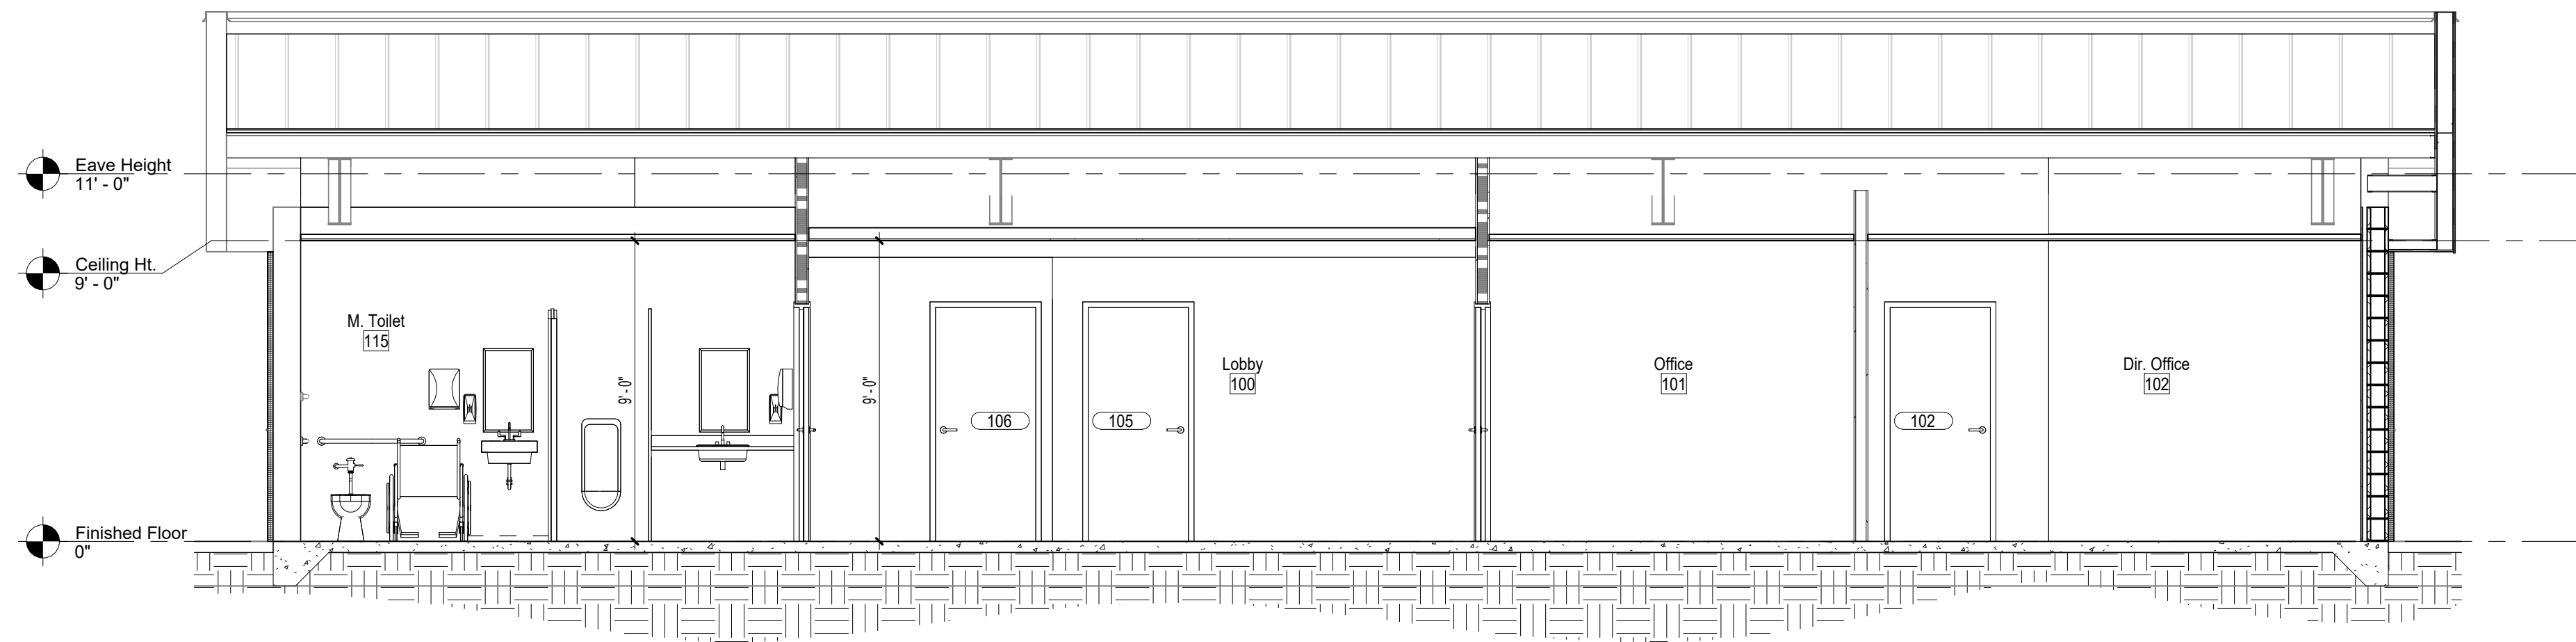

2 BUILDING SECTION

A3.1 Scale: 1/4" = 1'-0"

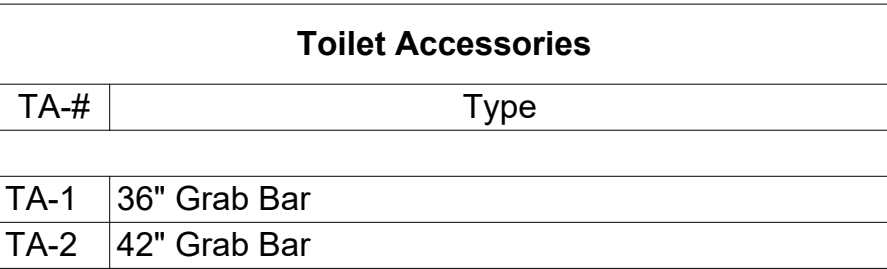

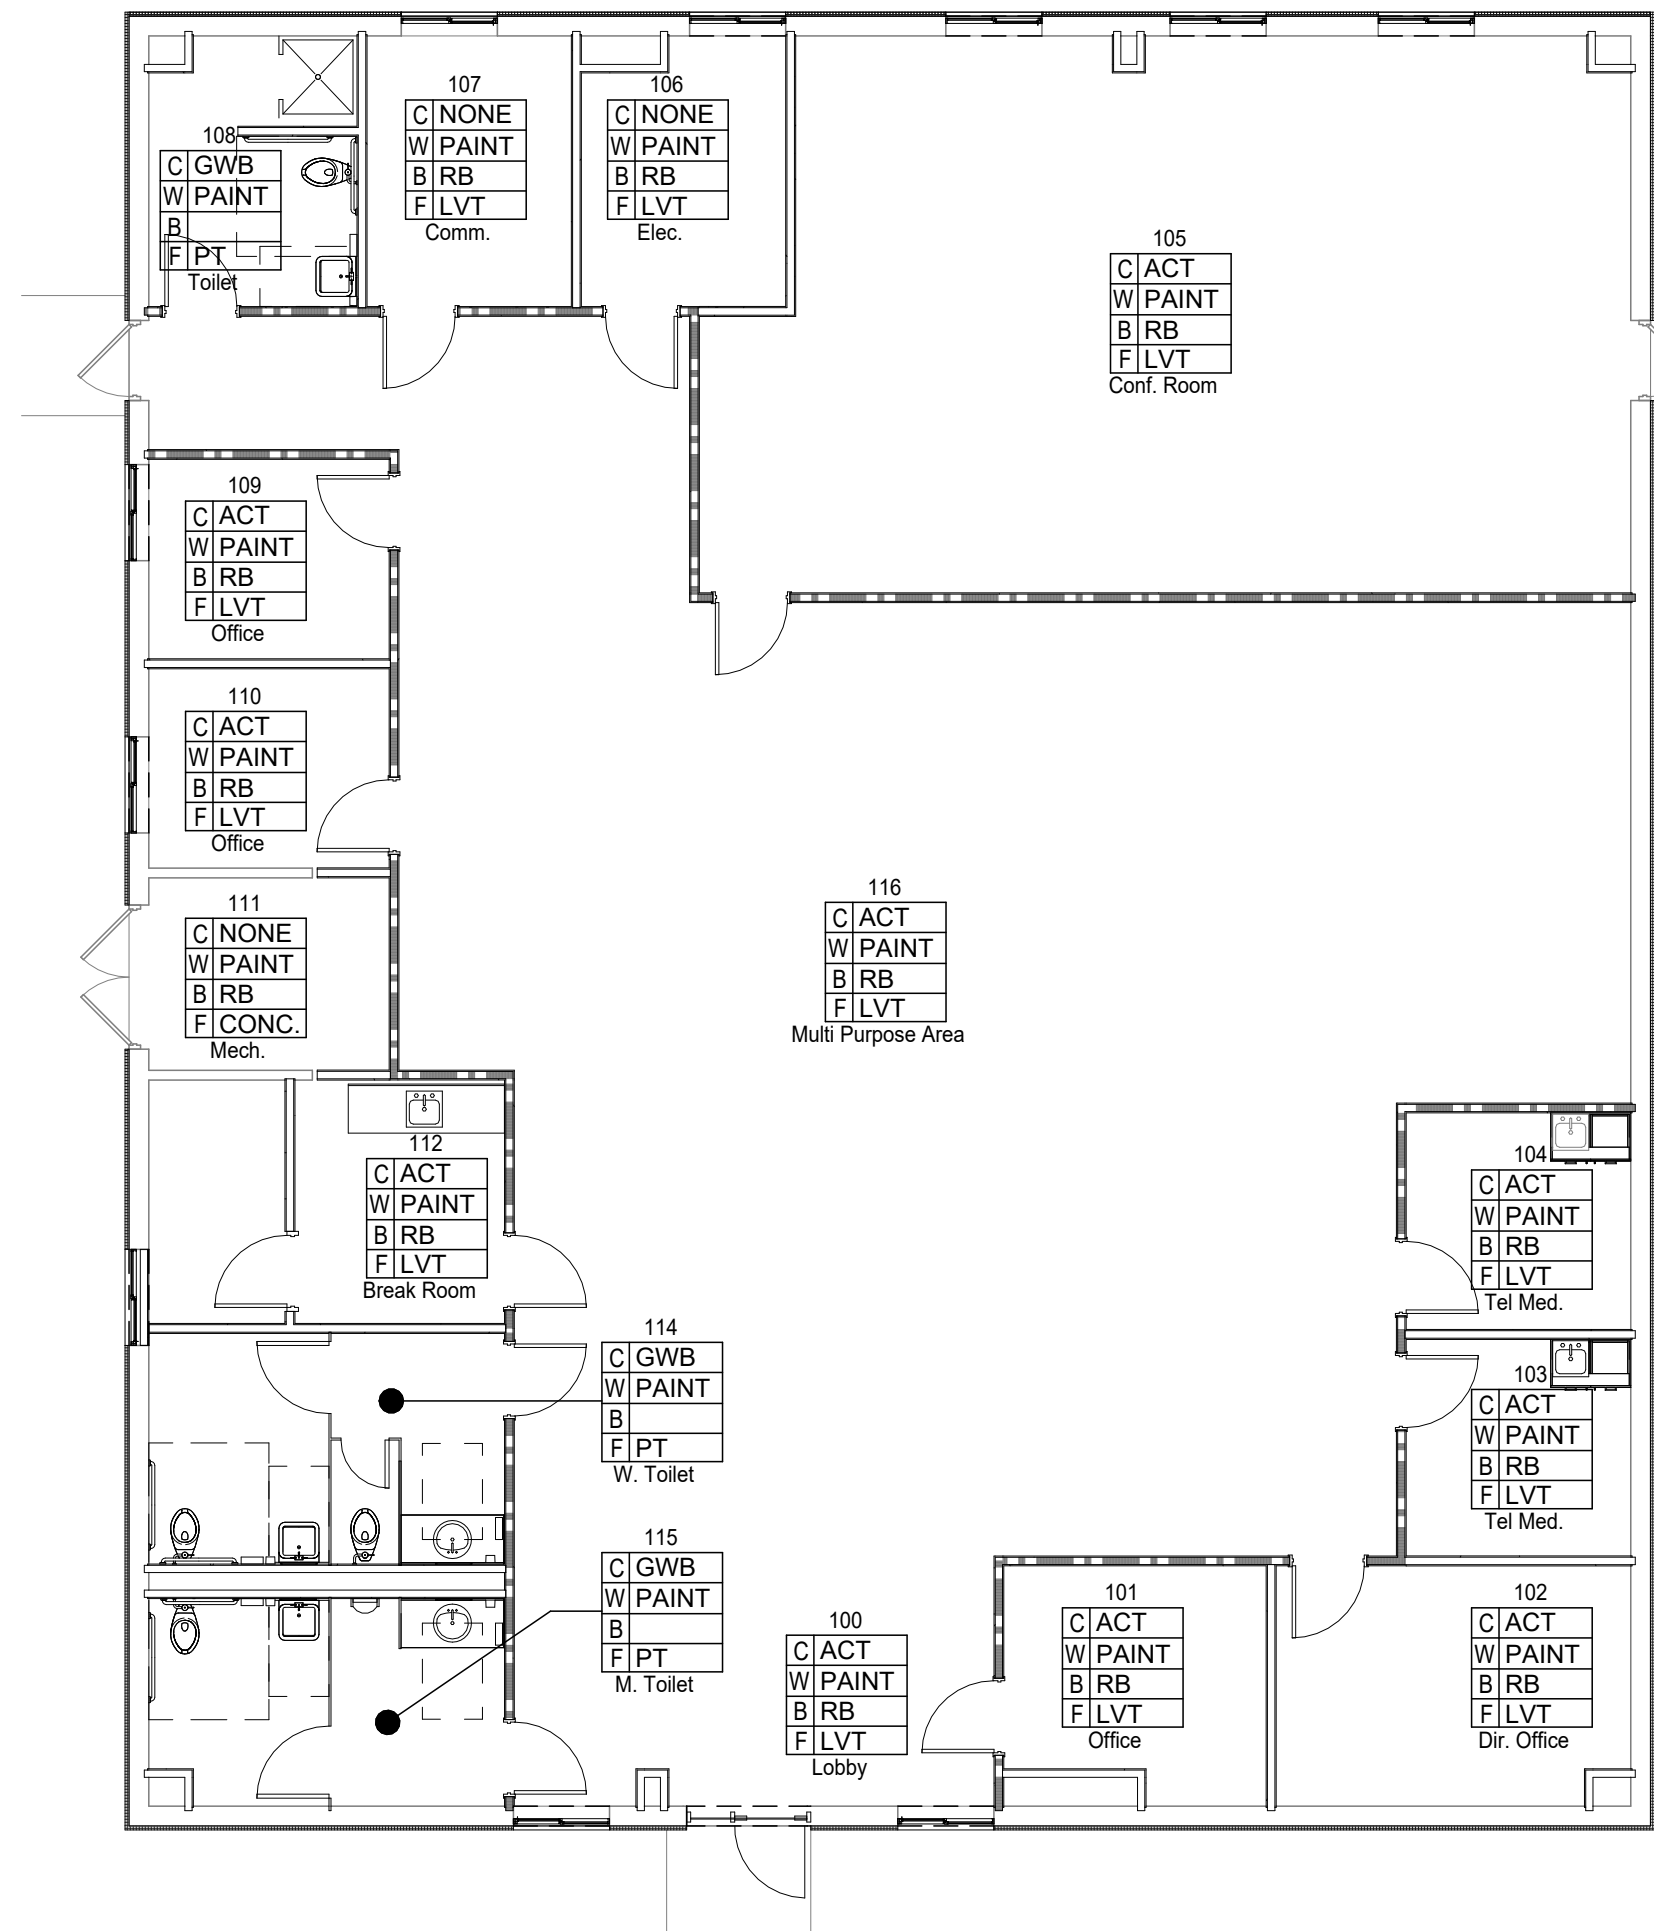


1
A6.0

Finish Floor Plan
Scale: 1/8" = 1'-0"


COLOR LEGEND		
PAINT - P MFR: SHERWIN WILLIAMS	PLASTIC LAMINATE MFR: WILSONANT	SOLID SURFACE MFR: LG HIMACS COLOR: COSMOS (COUNTERTOPS & WINDOW SILLS)
COLOR-1: DORIAN GRAY, 7017 (WALLS - TYPICAL)	COLOR: SHAKER CHERRY, 7935-38 (CABINETS)	TRANSITION STRIPS MFR: FLEXCO COLOR: UMBER, 078
COLOR-2: REPOSE GRAY, 7015 (WALLS - RESTROOMS, ELEC. & MECHANICAL ROOMS)	PVC EDGE BANDING: CHARTER INDUSTRIES - SHAKER CHERRY	
COLOR-3: GRIZZLE GRAY, 7068 (HOLLOW METAL WINDOW & DOOR FRAMES)	PORCELAIN TILE - PT MFR: TRINITY TILE STYLE: ARGONITE	LUXURY VINYL TILE - LVT MFR: CENTIVA STYLE: EVENT SERIES: WOOD COLOR: HARVEST OAK, EHP 3352
COLOR-4: RUSTIC RED, 7593 (ACCENT PAINT)	COLOR 1: BLUE, MATTE (FLOOR TILE IN RESTROOMS - 12" X 12")	
COLOR-5: SANTORINI BLUE, 7607 (ACCENT PAINT)	COLOR 2: GREY, MATTE (WALL TILE - 12" X 12")	WOOD DOORS MFR: MARSHFIELD SPECIES: NATURAL ROTARY BIRCH COLOR: ESPRESSO, 42-95
COLOR-6: MEDITERRANEAN, 7617 (ACCENT PAINT)	COLOR 3: GREEN, MATTE (ACCENT WALL TILE - 12" X 24")	
COLOR-7: ELDER WHITE, 7014 (GWB CEILINGS)	GROUT: MAPEI TBD (WALLS) CHARCOAL,47 (FLOORS)	
	RESILIENT BASE -RB MFR: FLEXCO COLOR: UMBER, 078	

Finish Notes	
1)	All floor finishes shall be Class 1.
2)	All ceiling and wall finishes shall be Class A.
3)	See reflected ceiling plan for ceiling finishes and heights.
4)	Provide a metal transition strip between Porcelain Tile and Resilient Tile or Vinyl Wood Flooring equal to Flexco #167.
5)	Provide a metal transition strip between Porcelain Tile and Resilient Tile or Vinyl Wood Flooring equal to Schluter RENO-U in adnodized aluminum.
6)	Provide a metal transition strip between Porcelain Tile and Carpet equal to Schluter RENO-TK in adnodized aluminum.
7)	Provide a 72" high wainscot of Porcelain Tile on all restroom walls. See wall tile pattern.

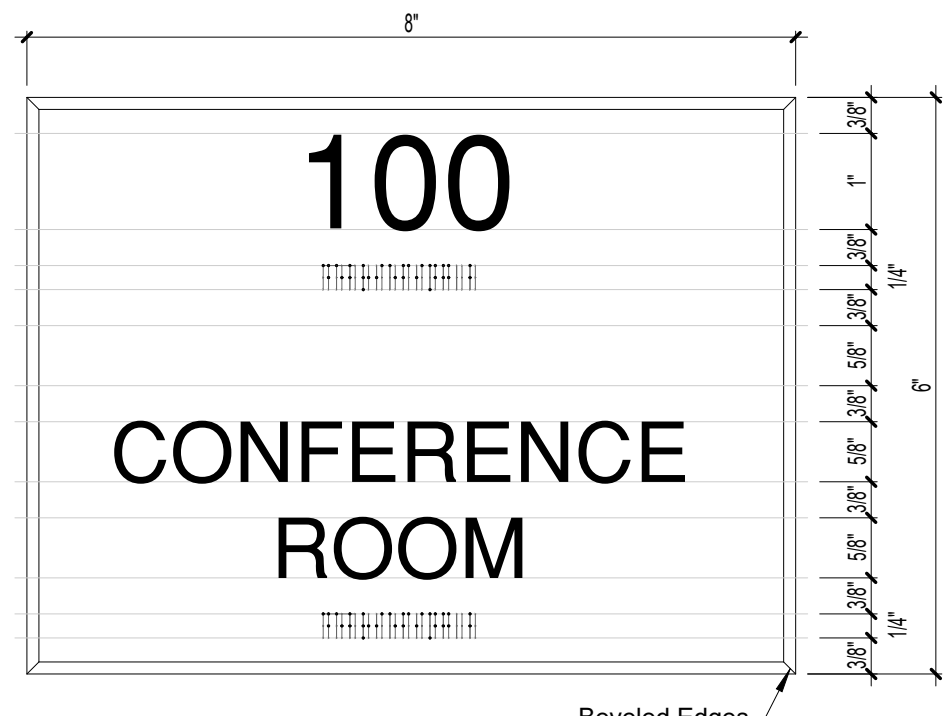

3
A6.0

Room Signage
Scale: 6" = 1'-0"

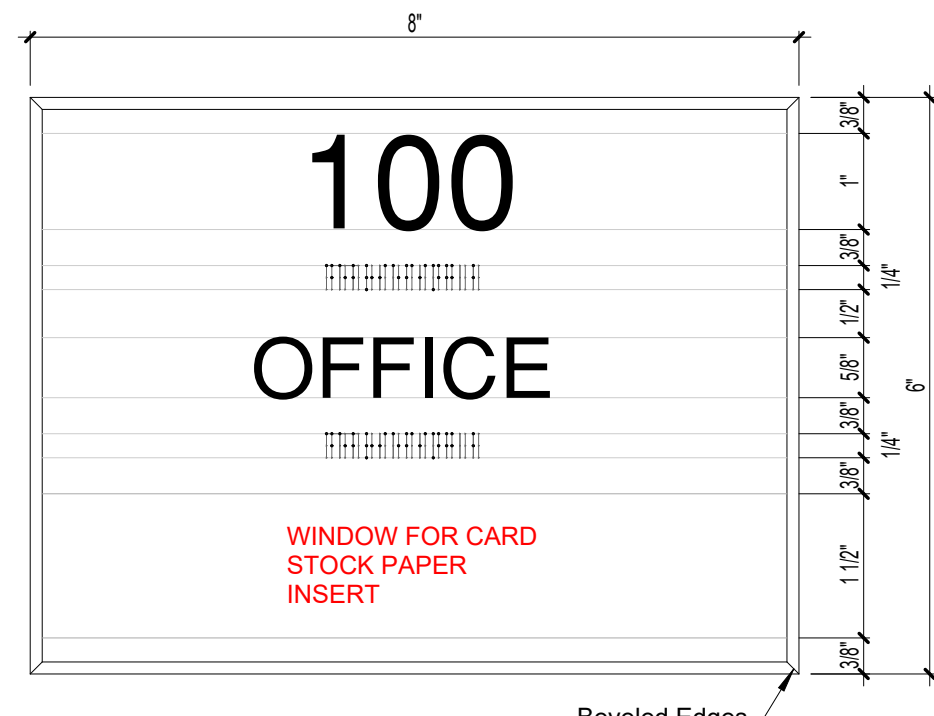

Finish Legend	
CONC	Concrete
CPT	Carpet
EP	Epoxy Paint
FRWS	Fiberglass Reinforced Wall System
GWB	Gypsum Wall Board
LVT	Luxury Vinyl Tile
P	Paint
PT	Porcelain Tile
RAF	Resilient Athletic Flooring
RB	Resilient Base
RFL	Resinous Flooring
RT	Resilient Tile
RUB	Rubber Flooring
SC	Sealed Concrete
SPC	Special Coatings for Concrete

GADSDEN CO. BOCC

Havana Medical Center Remodel

Havana, FL



Clemons,Rutherford,
& Associates, Inc.

Architects
Planners
Interior Designers
Construction Managers

2027 Thomasville Road
Tallahassee, Florida 32308

phone 850-385-6153
fax 850-386-8420
cra@craarchitects.com

The Drawings, Specifications and other documents prepared by Clemons, Rutherford & Associates, Inc. (CRA) for this Project are instruments of CRA for use solely with respect to this Project and, unless otherwise provided, CRA shall be deemed the author of these documents and shall retain all common law, statutory and other reserved rights, including the copyright. The Owner shall be permitted to retain copies, including reproducible copies, of CRA's Drawings, Specifications and other documents for information and reference in connection with the Owner's use and occupancy of the Project. CRA's Drawings, Specifications or other documents shall not be used by the Owner or others on other projects, for documents shall not be used by the Owner or others on other projects, for additions to this Project or for completion of this Project by others, unless the Architect is adjudged to be in default under this Agreement, except by agreement in writing and with appropriate compensation to CRA.

Gregory Westmoreland Kelley
AR0016706

Submittal

Phase	Date	Drw	Chk
100% Construction Doc.	5/26/25	BY	TB
100% Review Documents	12/16/24		
-	-		
-	-		
-	-		
-	-		
-	-		

Revision

#	Description	Date


CRA Project # 25027

Phase: 100% Construction Doc.


SHEET TITLE
Finish Plan, Interior Elevations, and Details

A6.0


G:\Production\CRA Jobs\2025\B02 - Gadsden Co. BOCC - Havana Health Dept Remodel Drawings\CRA FWW\A6.1 10625027 CDD-47

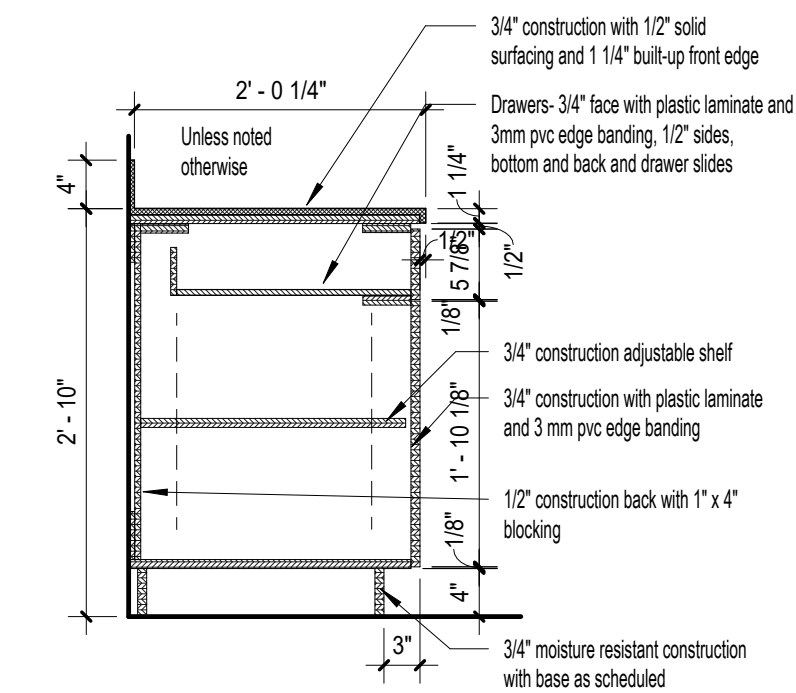


6 B1 Base Cabinet Detail
A6.1 Scale: 3/4" = 1'-0"

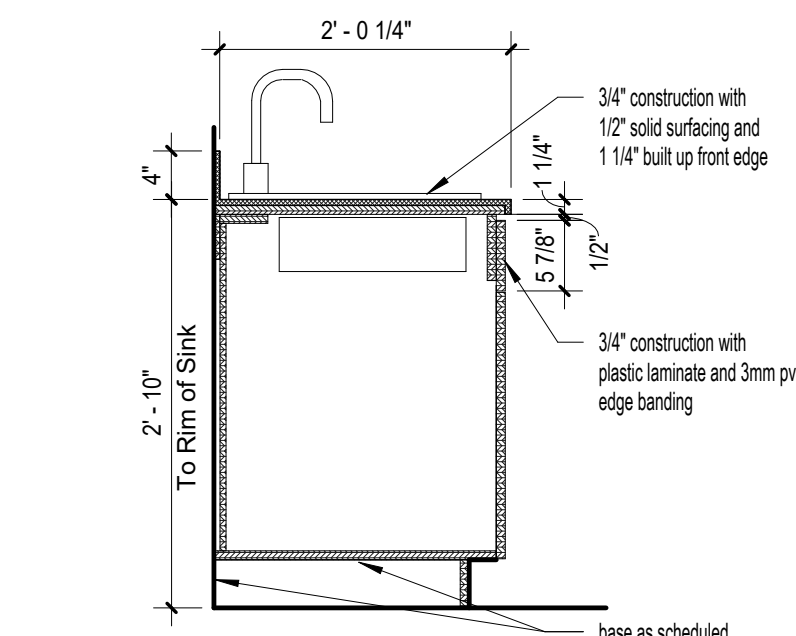

7 B2 Base Cabinet w/ Sink
A6.1 Scale: 3/4" = 1'-0"

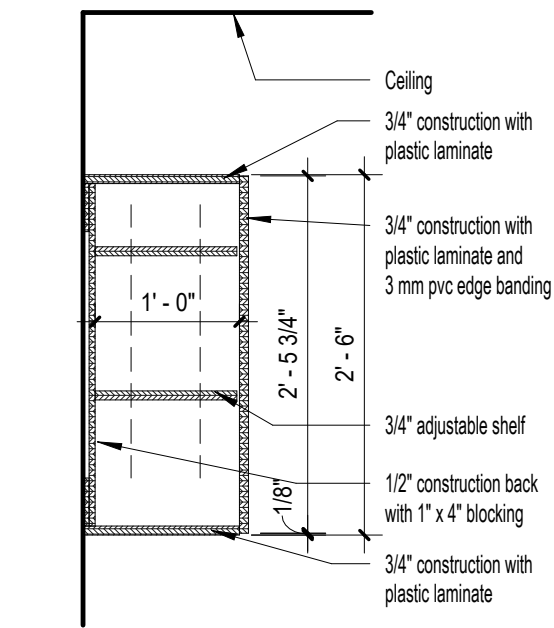

8 W1 Wall Cabinet Detail
A6.1 Scale: 3/4" = 1'-0"

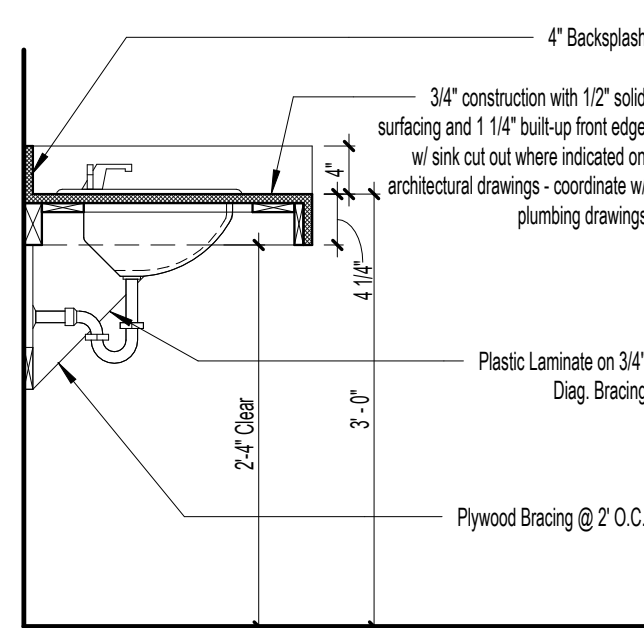

9 Vanity Section
A6.1 Scale: 3/4" = 1'-0"

Model #

B11

243521

Model Number (see specification section 124000)

Casework Type (see typical casework elevations)

Casework Size (Width x Height x Depth)

W - Wall Cabinet, No Valance

WV - Wall Cabinet, with Task Light Valance

B - Base Cabinet

S - Shelving

T - Tall Cabinet

F - Filler Panel

Casework Legend

Scale: 3/4" = 1'-0"

Millwork Notes

1) Contractor shall field verify all dimensions prior to millwork fabrication.

2) Shop drawings shall include fully dimensioned and detailed elevations for architect / owner's review.

3) Provide plastic laminate on all exposed and semi-exposed surfaces.

4) Refer to interior elevation key for designations.

5) Contractor to coordinate all appliance and equipment sizes with owner prior to fabrication of millwork.

Interior Elevation Key Plan

1A

1B

1C

1D

1E

GADSDEN CO. BOCC

Havana
Medical Center
Remodel

Havana, FL

Clemons,Rutherford,
& Associates, Inc.

Architects
Planners
Interior Designers
Construction Managers

2027 Thomasville Road
Tallahassee, Florida 32308

phone 850-385-6153

fax 850-386-8420

cra@craarchitects.com

The Drawings, Specifications and other documents prepared by Clemons, Rutherford & Associates, Inc. (CRA) for this Project are instruments of CRA for use solely with respect to this Project and, unless otherwise provided, CRA shall be deemed the author of these documents and shall retain all common law, statutory and other reserved rights, including the copyright. The Owner shall be permitted to retain copies, including reproducible copies, of CRA's Drawings, Specifications and other documents for information and reference in connection with the Owner's use and occupancy of the Project. CRA's Drawings, Specifications or other documents shall not be used by the Owner or others on other projects, for documents shall not be used by the Owner or others on other projects, for additions to this Project or for completion of this Project by others, unless the Architect is adjudged to be in default under this Agreement, except by agreement in writing and with appropriate compensation to CRA.

Gregory Westmoreland Kelley
AR0016706

Submittal

Phase	Date	Drw	Chk
100% Construction Doc.	5/26/25	Author	Checker
100% Review Documents	12/16/24		
-	-		
-	-		
-	-		
-	-		

Revision

#	Description	Date

CRA Project # 25027

Phase: 100% Construction
Doc.

SHEET TITLE
Millwork Plan & Details



A6.1

Door Schedule Notes


1. See HVAC Floor Plans for Undercut Doors. Maximum Undercut to be 3/4"
2. All Doors are to be 1-3/4" Thick Unless Noted Otherwise.
3. All Stair Doors Shall be Temperature-Rise Label Doors.
4. All Door Thresholds Shall Meet ADA Height Requirement 1/2" Maximum

Alum.	Aluminum
Anod.	Anodized
AP	Access Panel
CO	Cased Opening
HM	Hollow Metal
PT	Paint
PR	Pair of Doors
SC	Solid Core
ST	Stain
WD	Wood
20 C	20 Min Certified Door & Frame Assembly
20 M	20 Min Fire Rated Door and Frame Assembly
B Label	1-1/2" Hour Fire Rated Door & Frame Assembly
C-Label	45 Min. Fire Rated Door & Frame Assembly

Door Schedule Legend

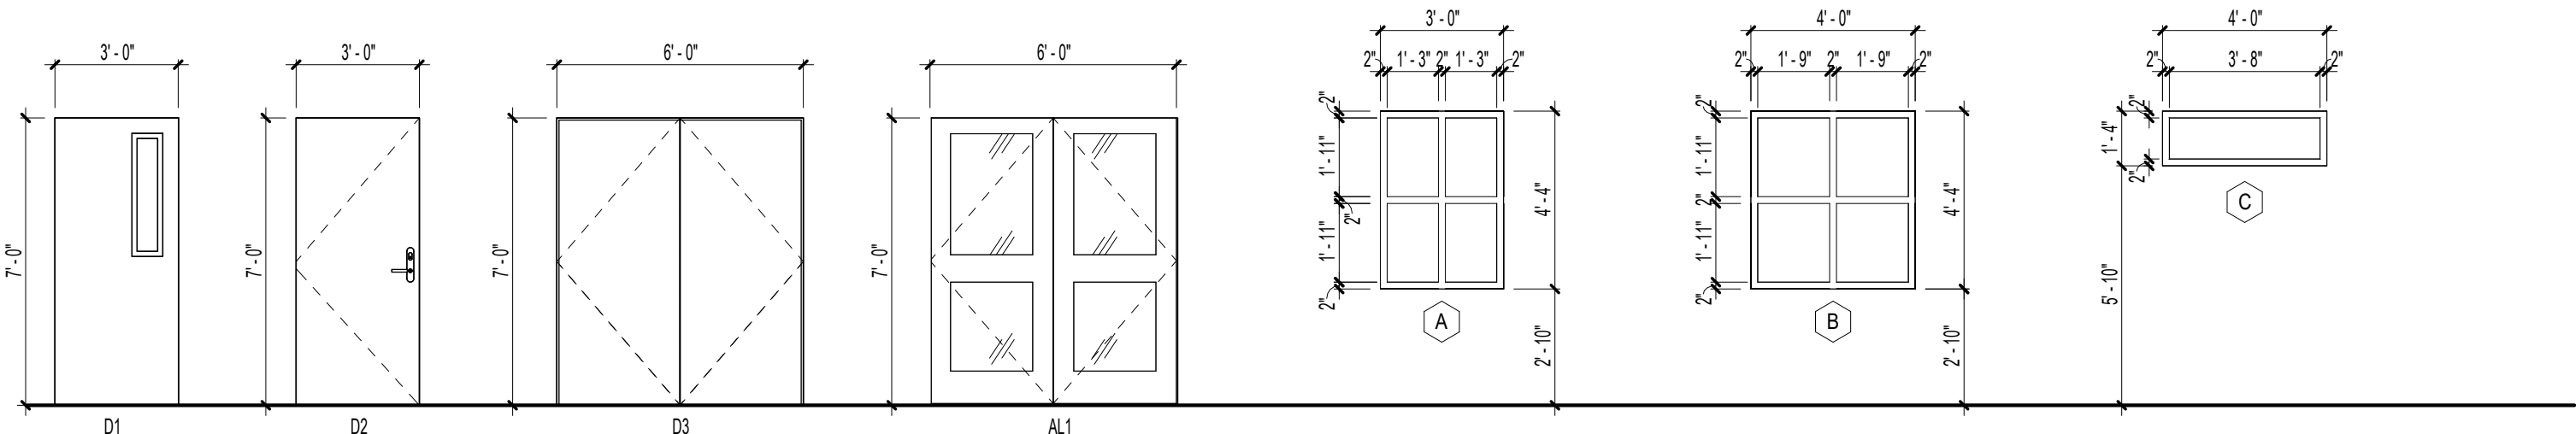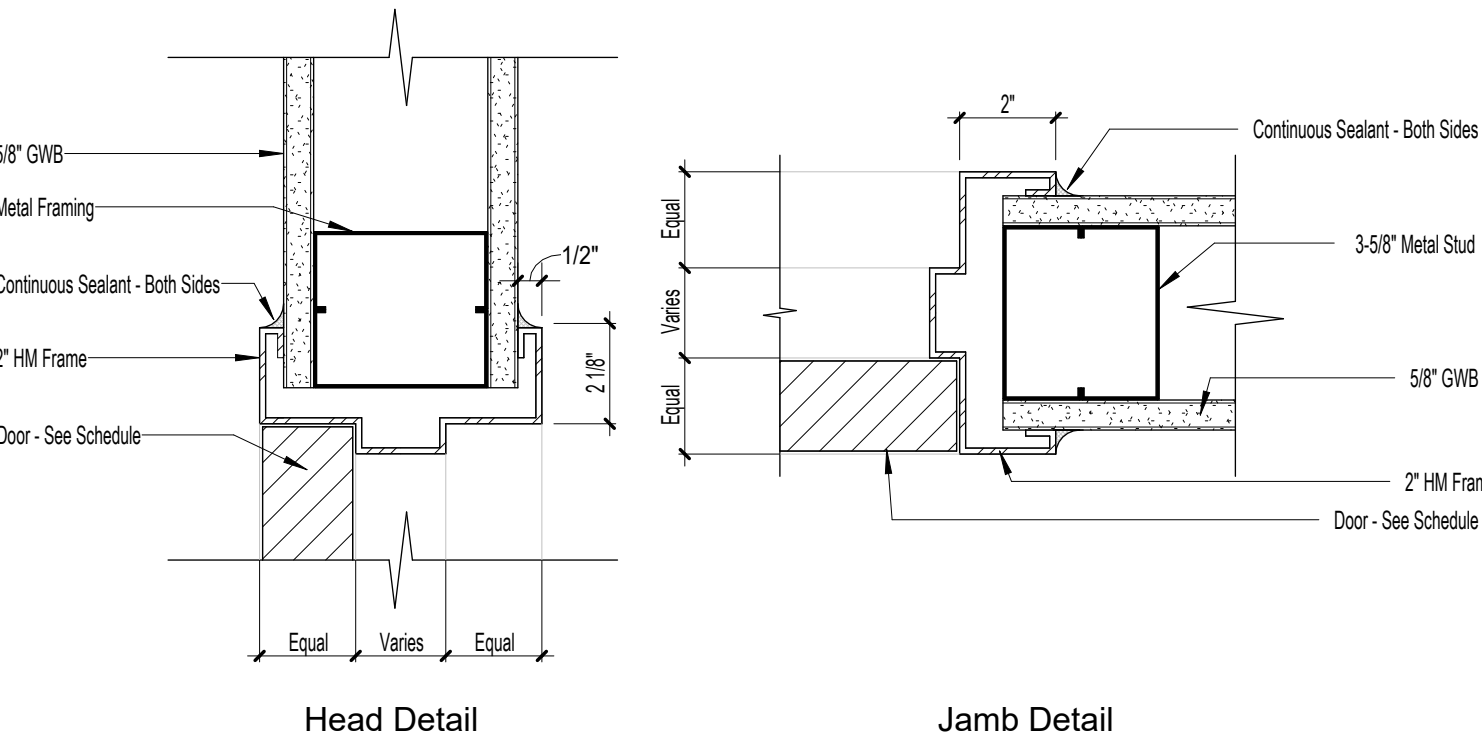


Door & Window Types

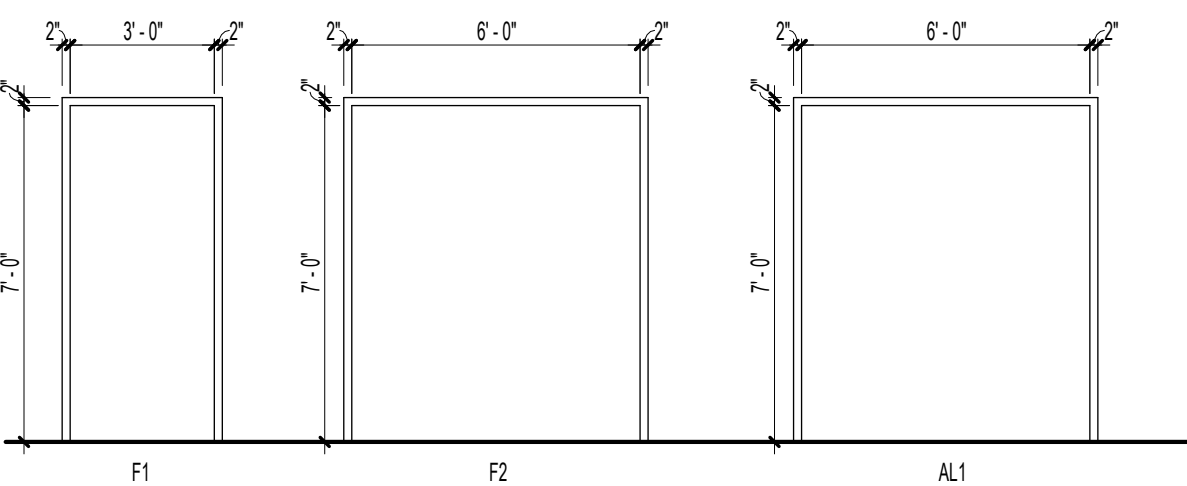

Frame Type


1 Interior Door Detail

Scale: 3" = 1'-0"

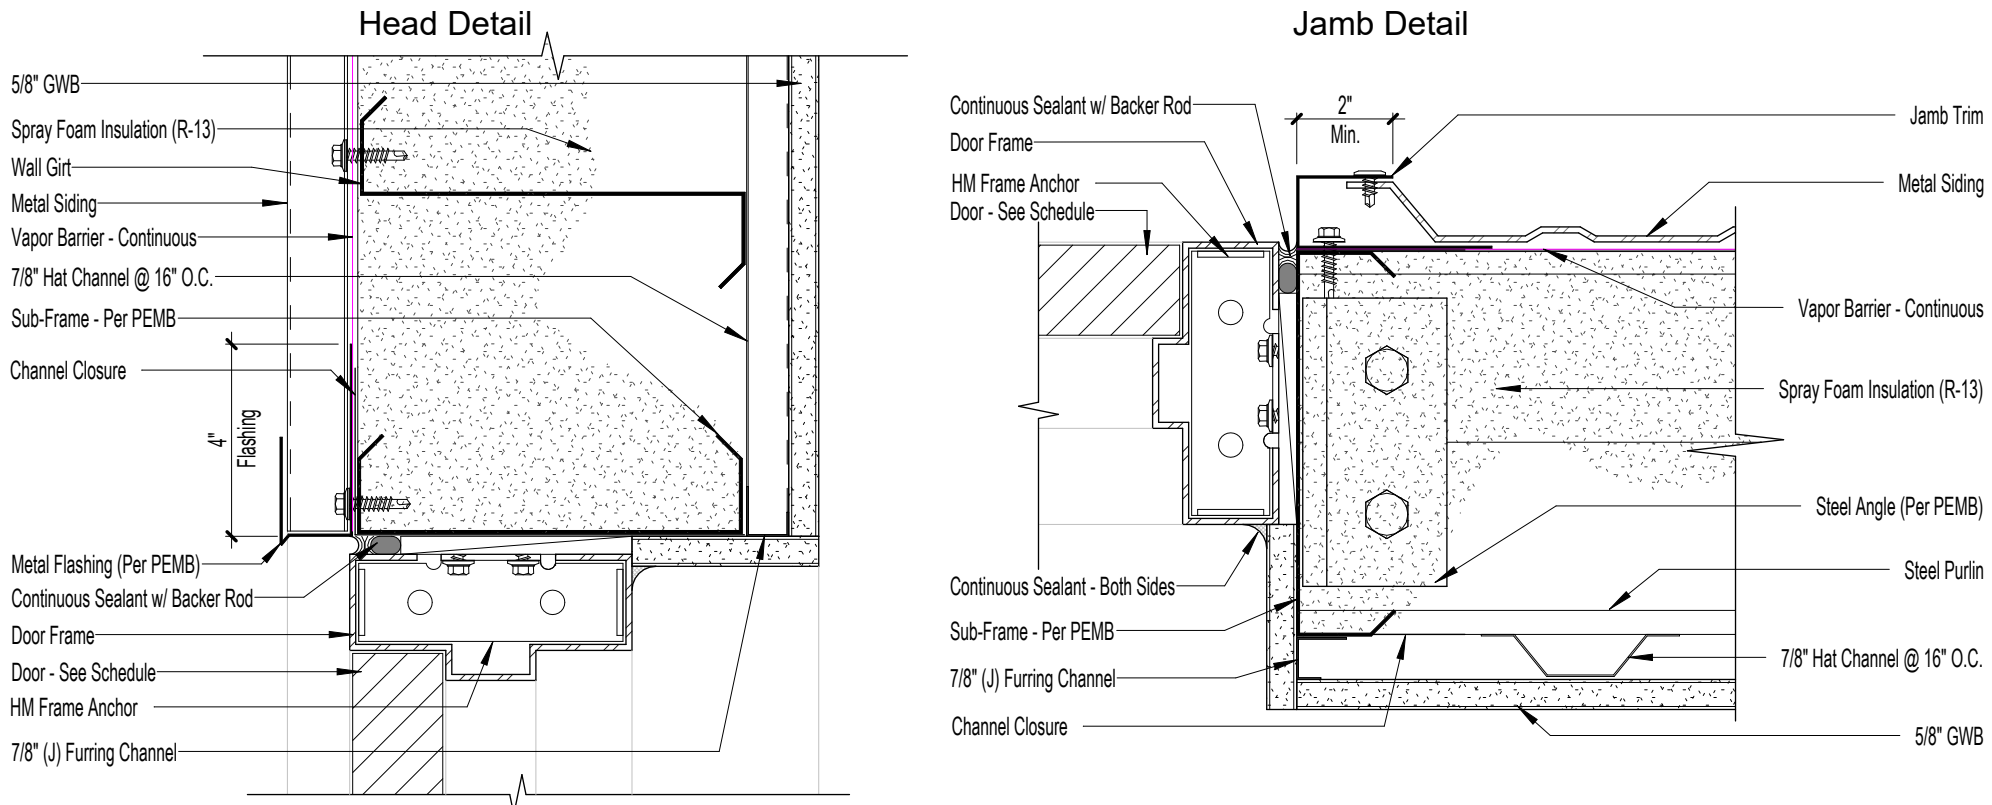

2 Exterior HM Door Details

Scale: 3" = 1'-0"

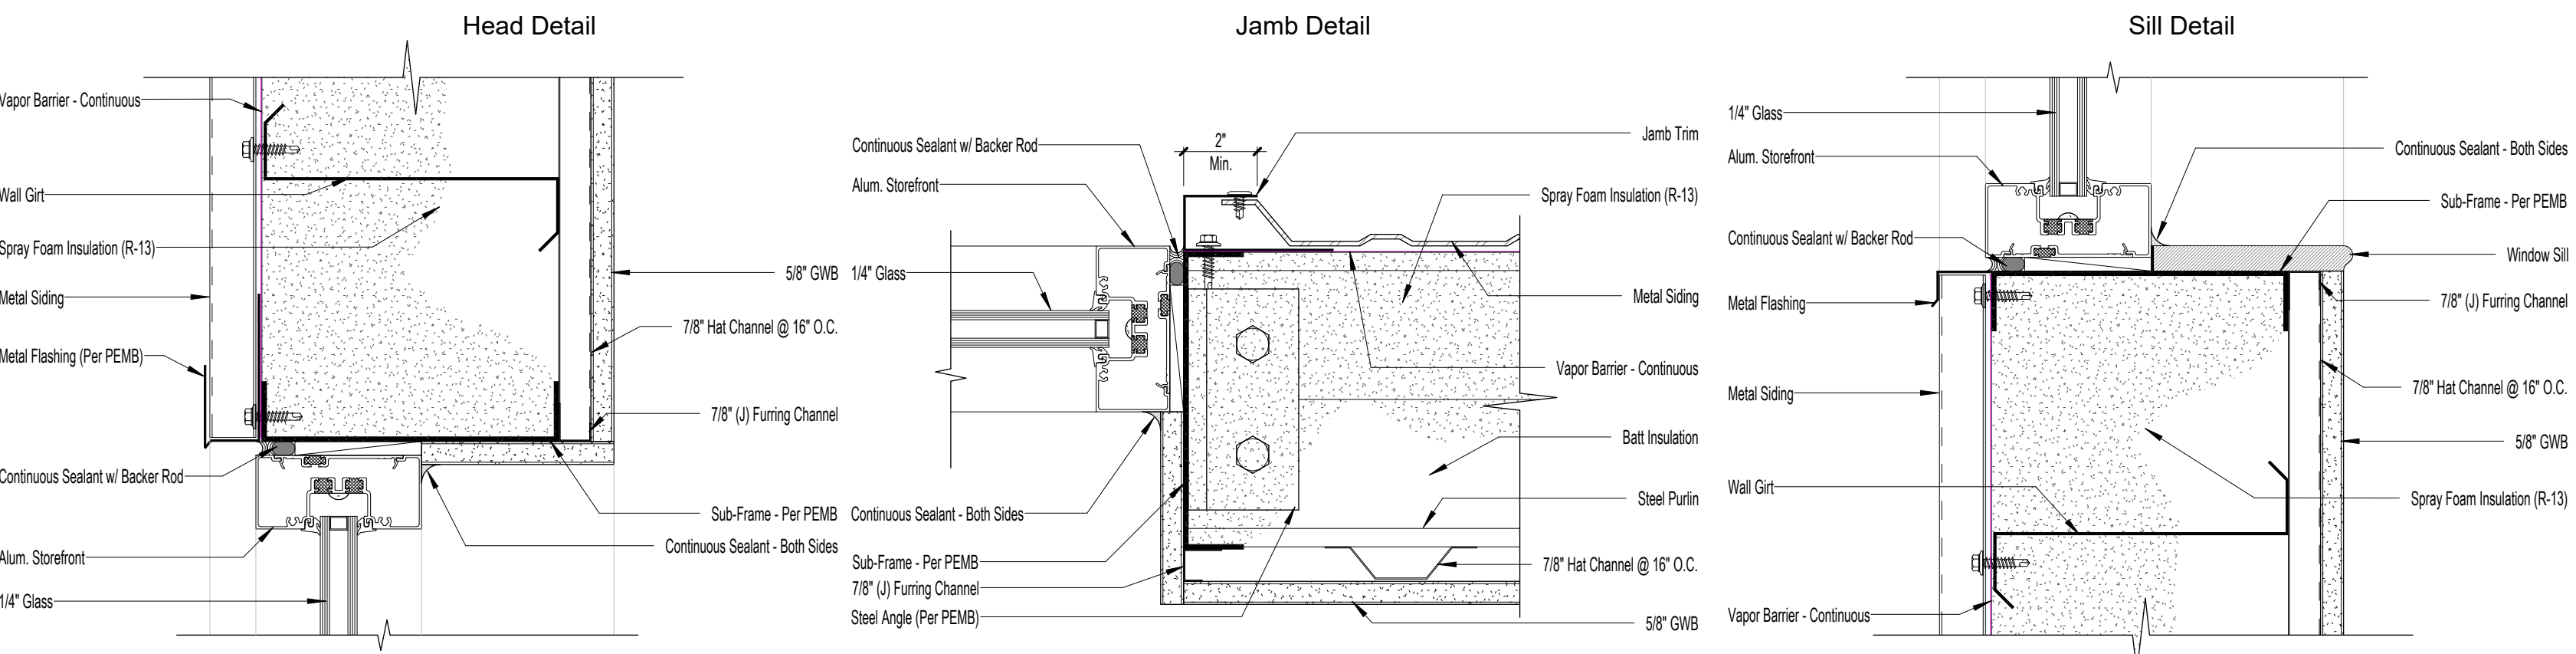


3 Exterior Window Detail

Scale: 3" = 1'-0"

4 Storefront Door Detail

Scale: 3" = 1'-0"

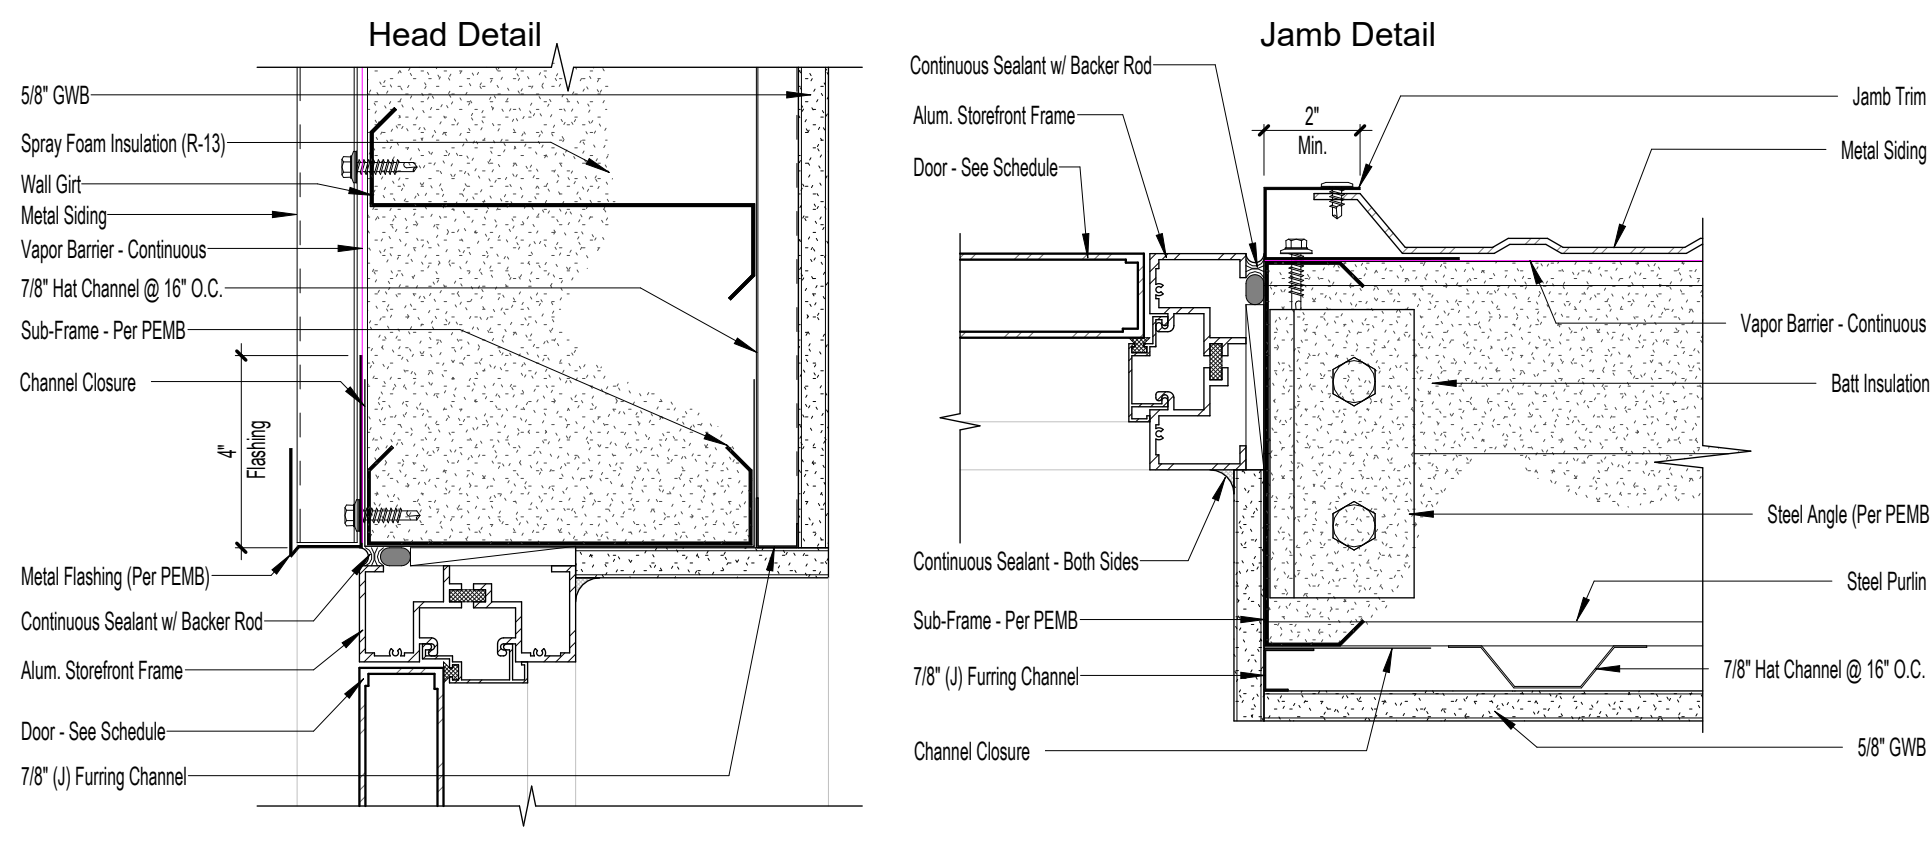

GADSDEN CO. BOCC

Havana Medical Center Remodel

Havana, FL



Clemons, Rutherford, & Associates, Inc.

Architects
Planners
Interior Designers
Construction Managers

2027 Thomasville Road
Tallahassee, Florida 32308

phone 850-385-6153

fax 850-386-8420

cra@craarchitects.com

The Drawings, Specifications and other documents prepared by Clemons, Rutherford & Associates, Inc. (CRA) for this Project are instruments of CRA for use solely with respect to this Project and, unless otherwise provided, CRA shall be deemed the author of these documents and shall retain all common law, statutory and other reserved rights, including the copyright. The Owner shall be permitted to retain copies, including reproducible copies, of CRA's Drawings, Specifications and other documents for information and reference in connection with the Owner's use and occupancy of the Project. CRA's Drawings, Specifications or other documents shall not be used by the Owner or others on other projects, for documents shall not be used by the Owner or others on other projects, for additions to this Project or for completion of this Project by others, unless the Architect is adjudged to be in default under this Agreement, except by agreement in writing and with appropriate compensation to CRA.

Gregory Westmoreland Kelley
AR0016706

Submittal

Phase	Date	Drw	Chk
100% Construction Doc.	5/26/25	BY	GK
100% Review Documents	12/16/24		
-	-		
-	-		
-	-		


Revision

#	Description	Date



CRA Project # 25027

Phase: 100% Construction Doc.

SHEET TITLE
Door & Window Elev. /
SCHEDULE
A 7.0

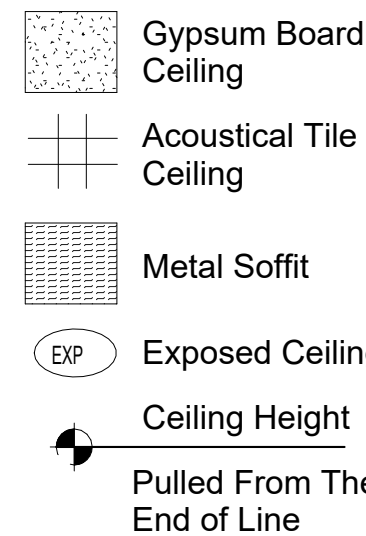

Ceiling Plan Legend

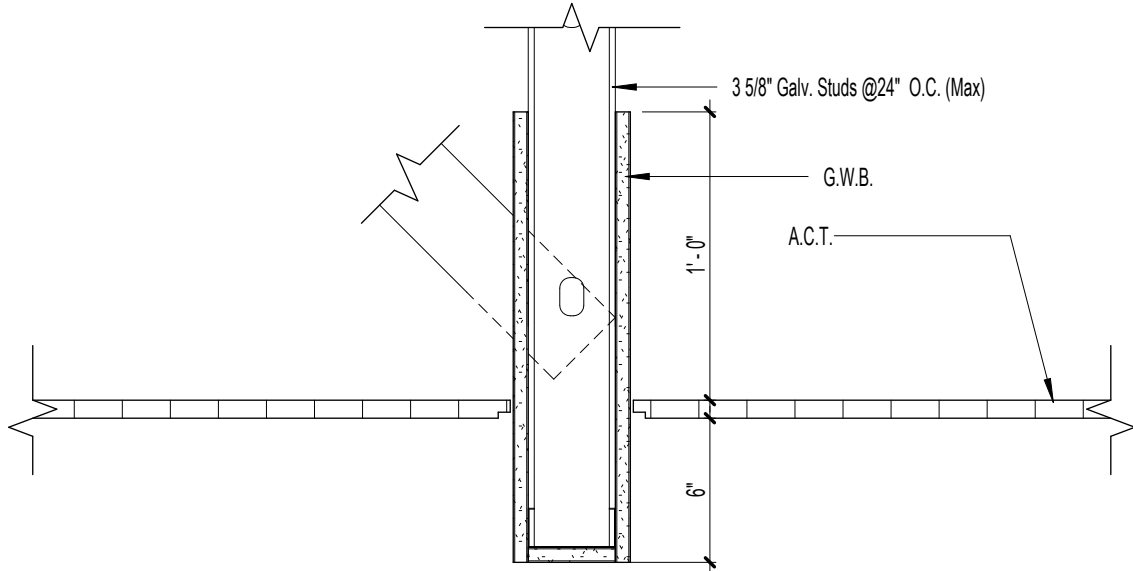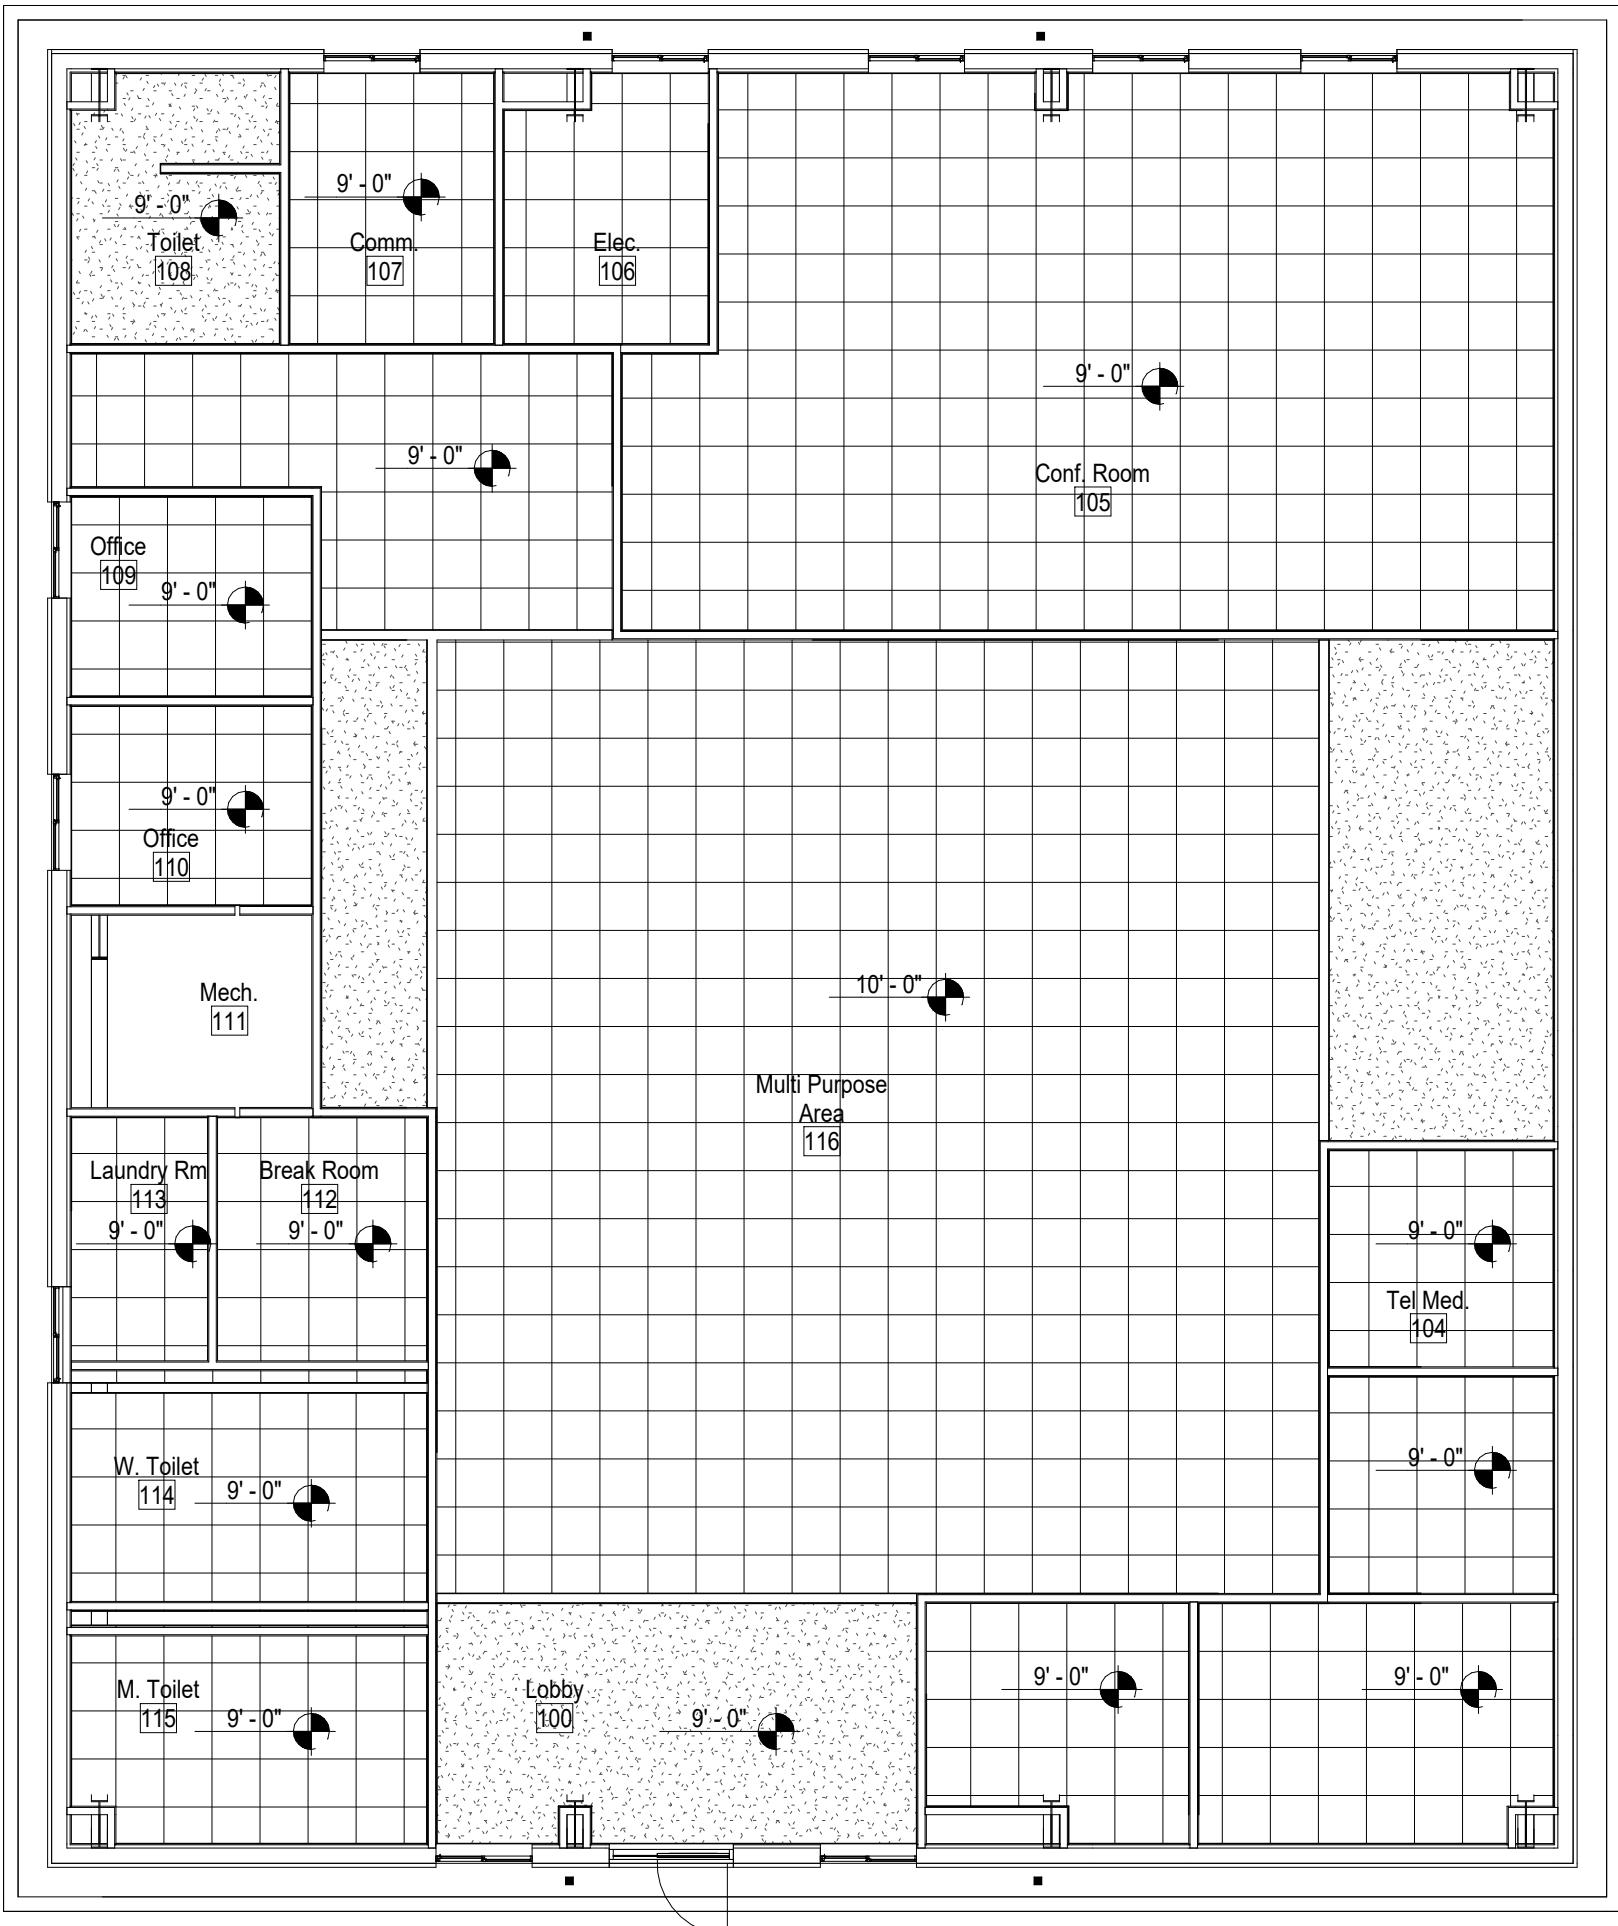

2 Ceiling Transition

Scale: 1 1/2" = 1'-0"

1 Finished Floor

A8.0 Scale: 1/8" = 1'-0"

GADSDEN CO. BOCC

Havana Medical Center Remodel

Havana, FL



Clemons, Rutherford,
& Associates, Inc.

Architects
Planners
Interior Designers
Construction Managers

2027 Thomasville Road
Tallahassee, Florida 32308

phone 850-385-6153

fax 850-386-8420

cra@craarchitects.com

The Drawings, Specifications and other documents prepared by Clemons, Rutherford & Associates, Inc. (CRA) for this Project are instruments of CRA for use solely with respect to this Project and, unless otherwise provided, CRA shall be deemed the author of these documents and shall retain all common law, statutory and equitable rights in and to these documents. CRA shall be permitted to retain copies, including reproducible copies of CRA's Drawings, Specifications and other documents for information and reference in connection with the Owner's use and occupancy of the Project. CRA's Drawings, Specifications and other documents shall not be used by the Owner or others on other projects, for projects shall not be used by the Owner or others for any other purpose, for or in connection with this Project, for completion of this Project or any other, unless the Architect is adjudged to be in default under this Agreement, except by agreement in writing and with appropriate compensation to CRA.

Gregory Westmoreland Kelley
AR0016706

Submittal

Phase	Date	Drw	Chk
100% Construction Doc.	5/26/25	BY	GK
100% Review Documents	12/16/24		
-	-		
-	-		
-	-		
-	-		

Revision

[illegible]


CRA Project # 25027

Phase: **100% Construction**
Doc.


SHEET TITLE

Reflected Ceiling Plan


A8.0

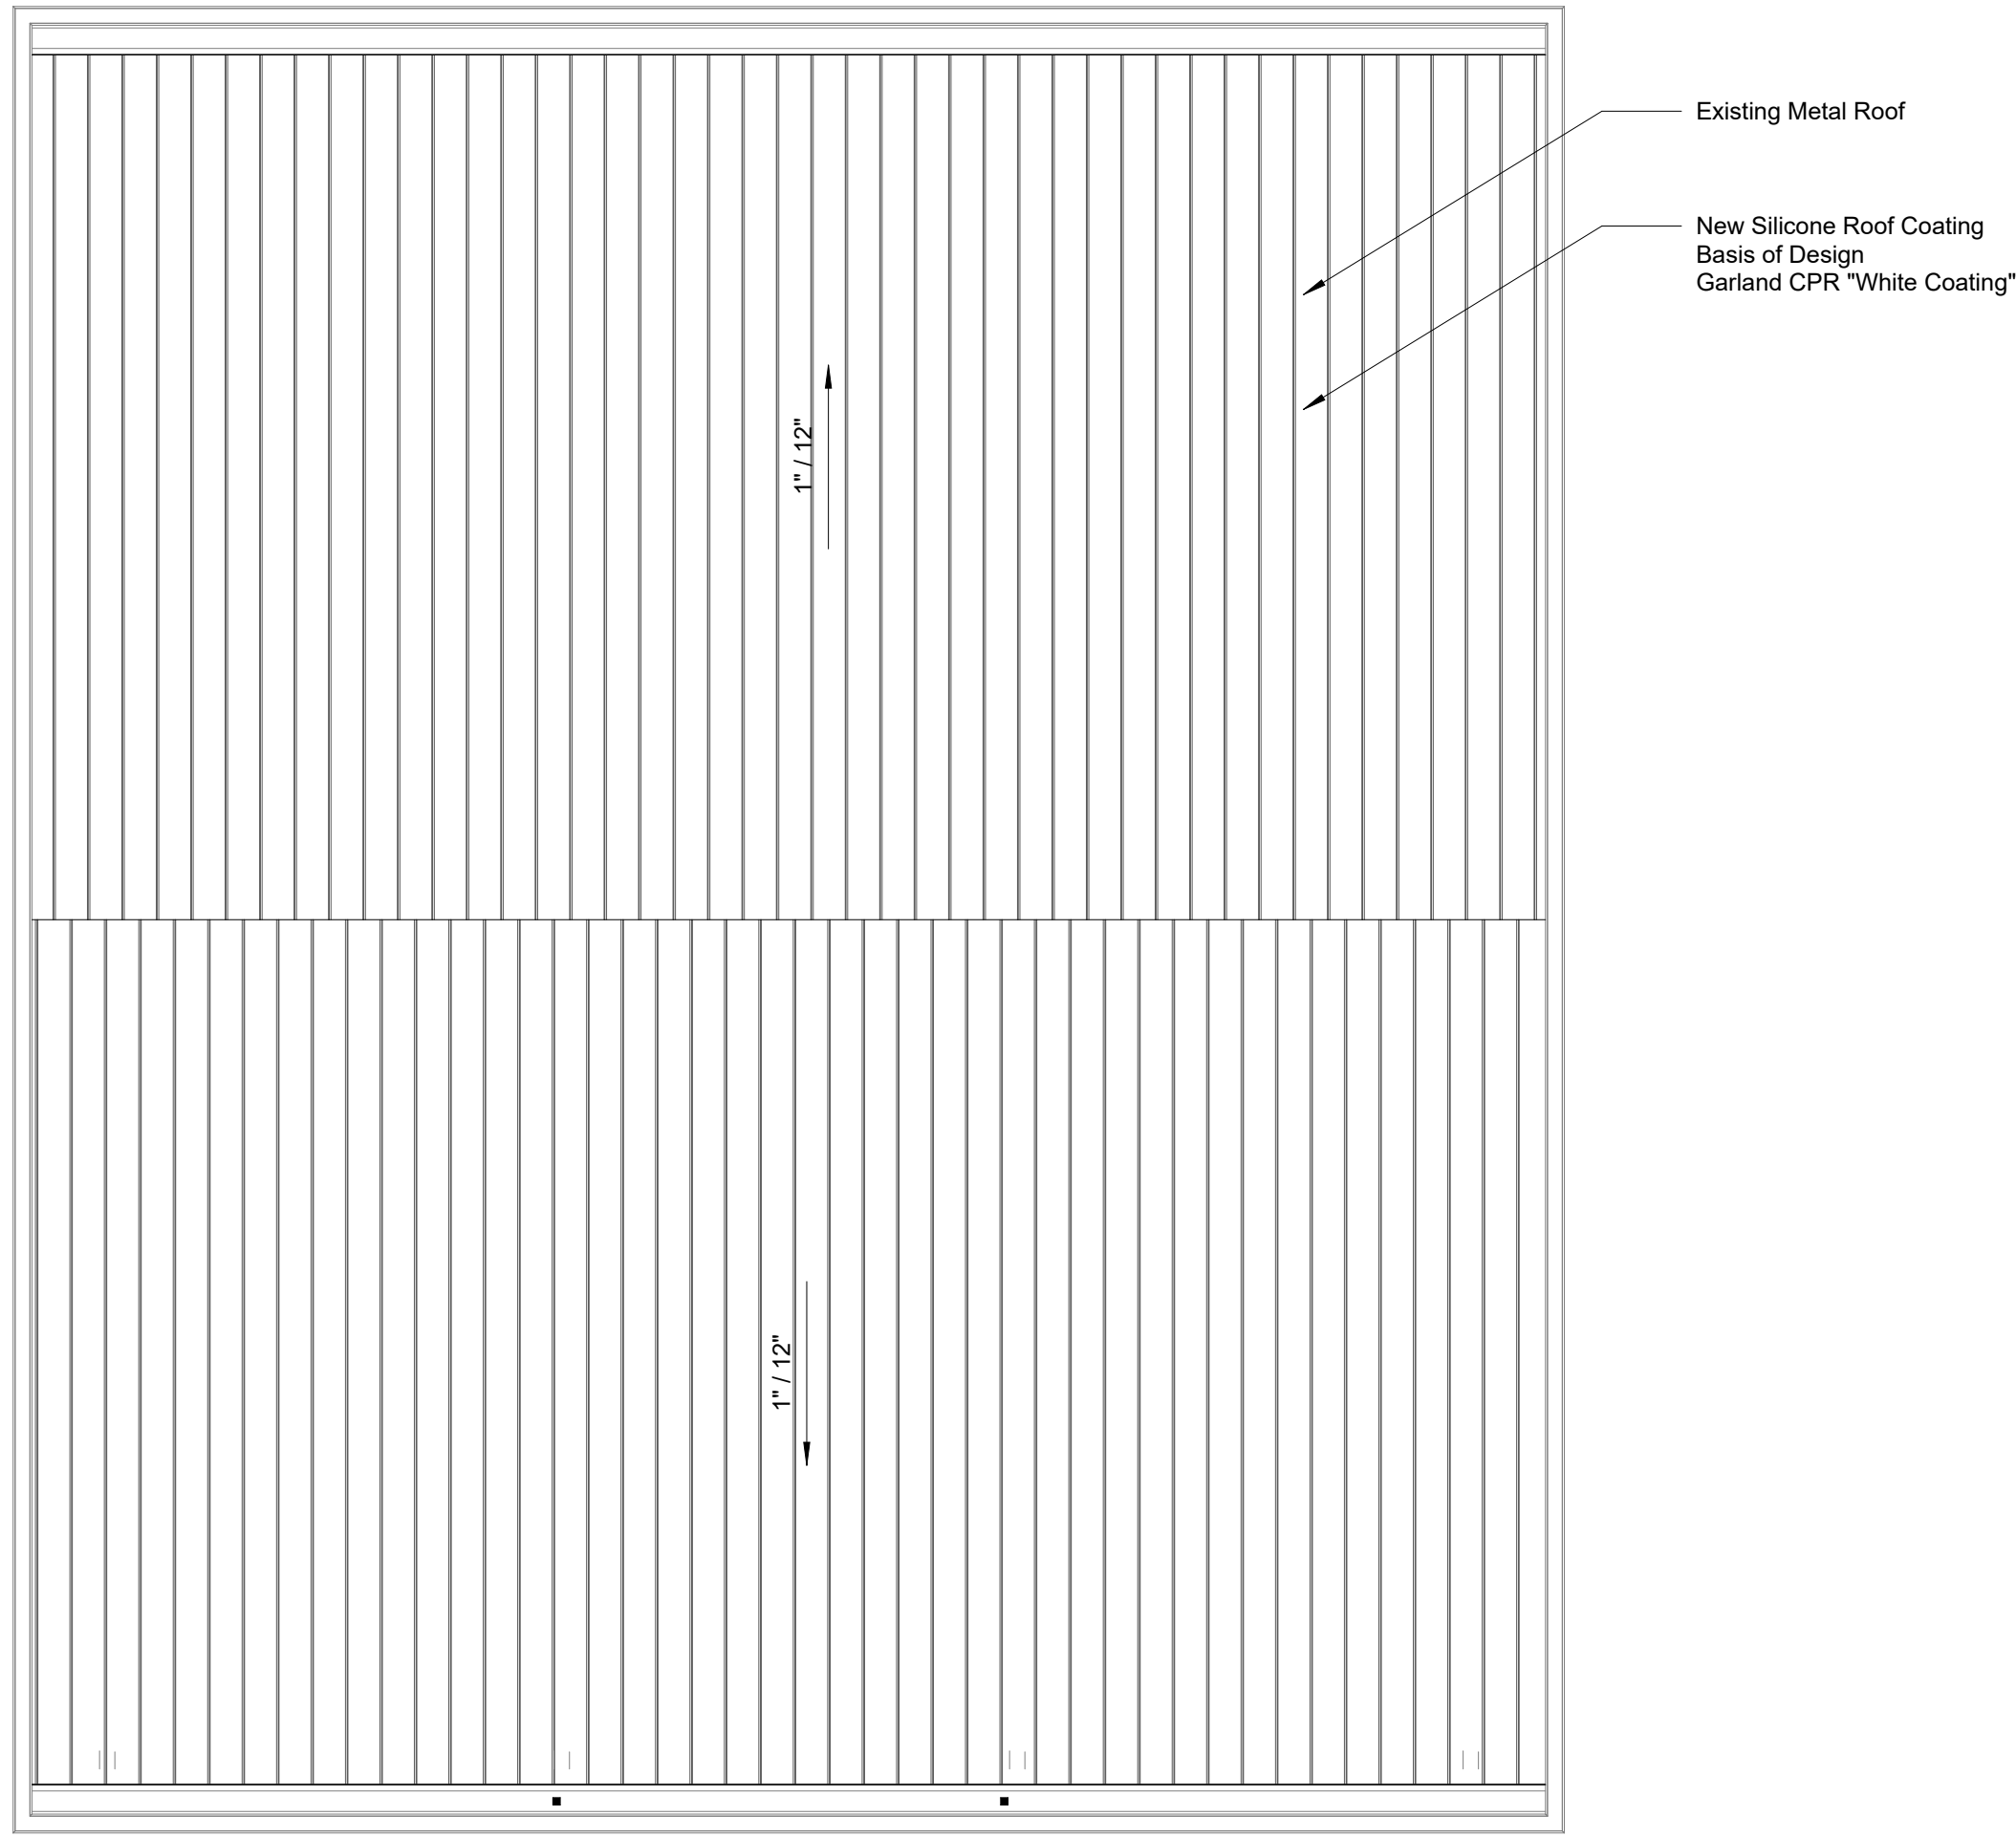


1 Roof Plan
A9.0 Scale: 1/8" = 1'-0"

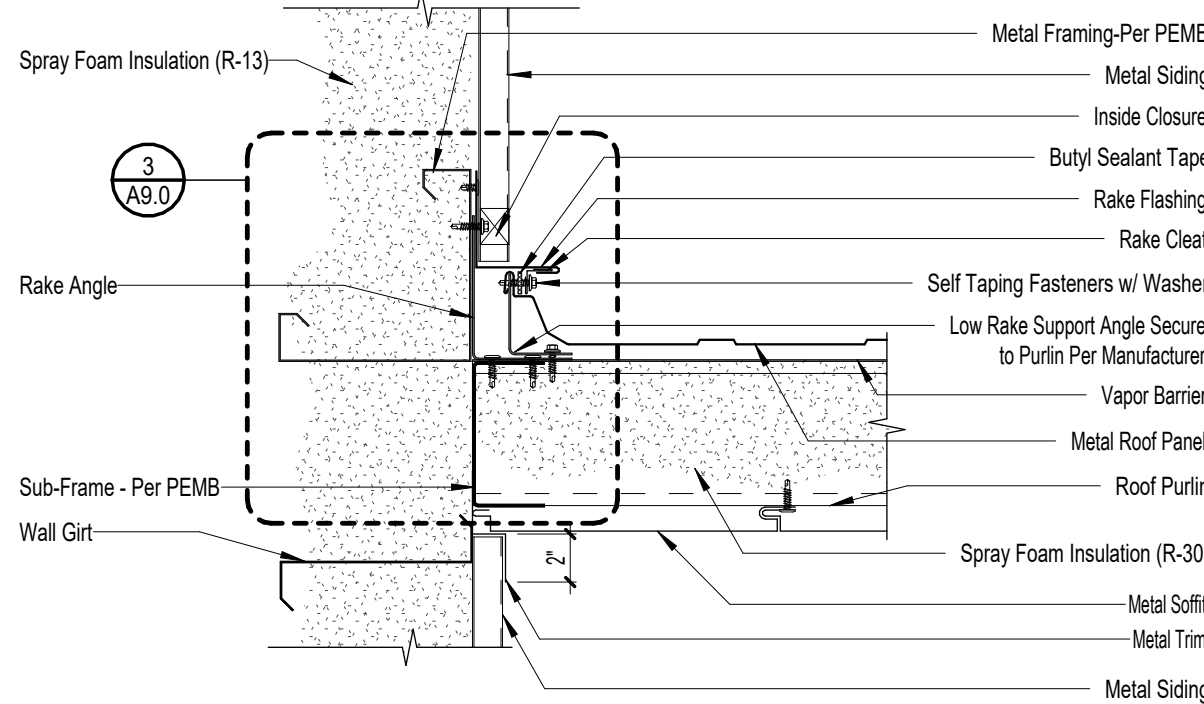


2 Canopy Detail
A9.0 Scale: 1 1/2" = 1'-0"

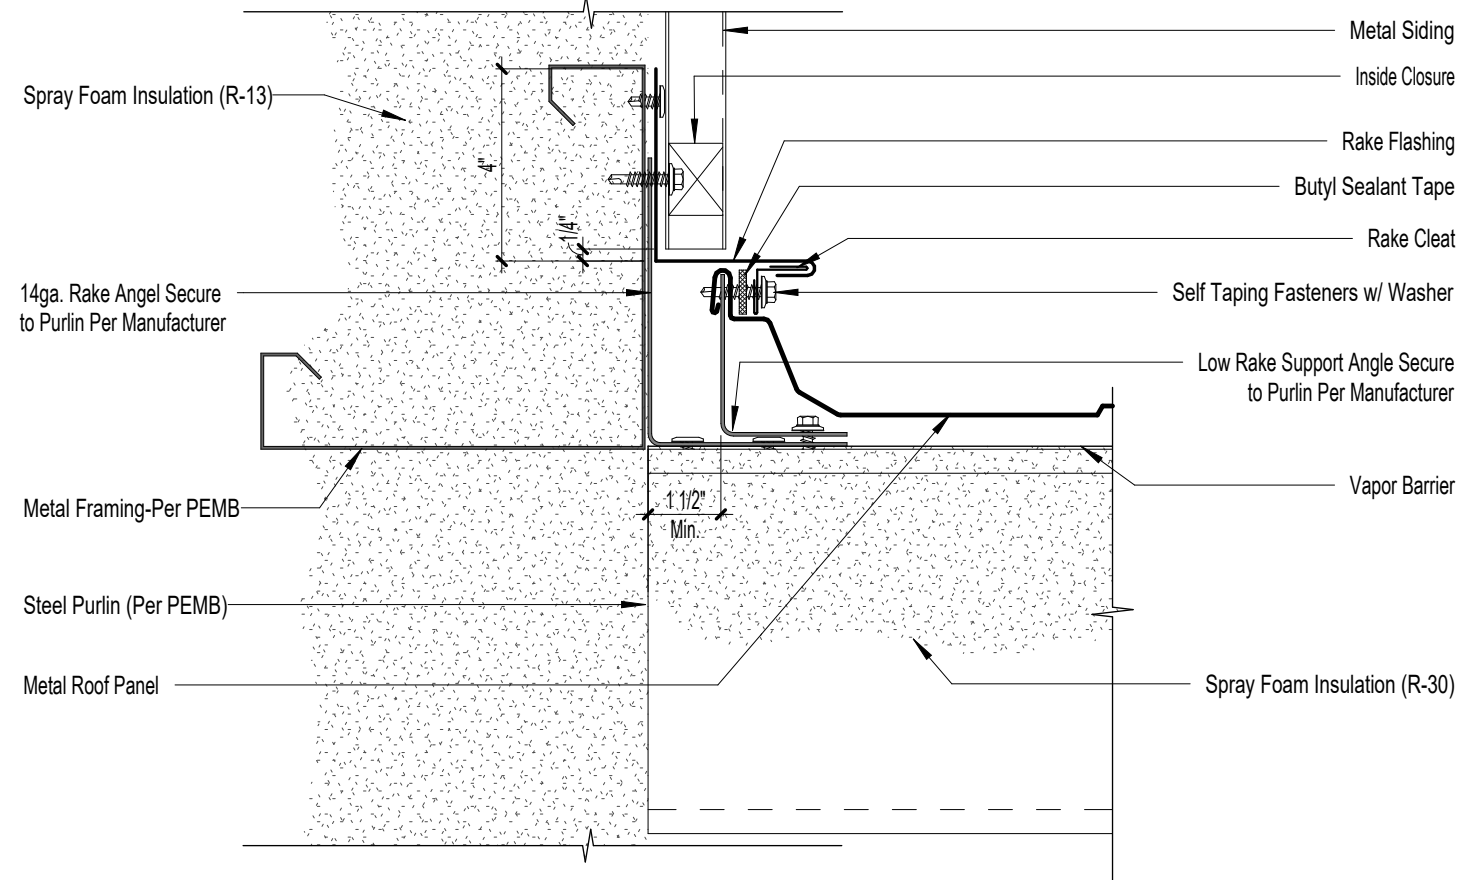


3 Enlarged Canopy Detail
A9.0 Scale: 3" = 1'-0"

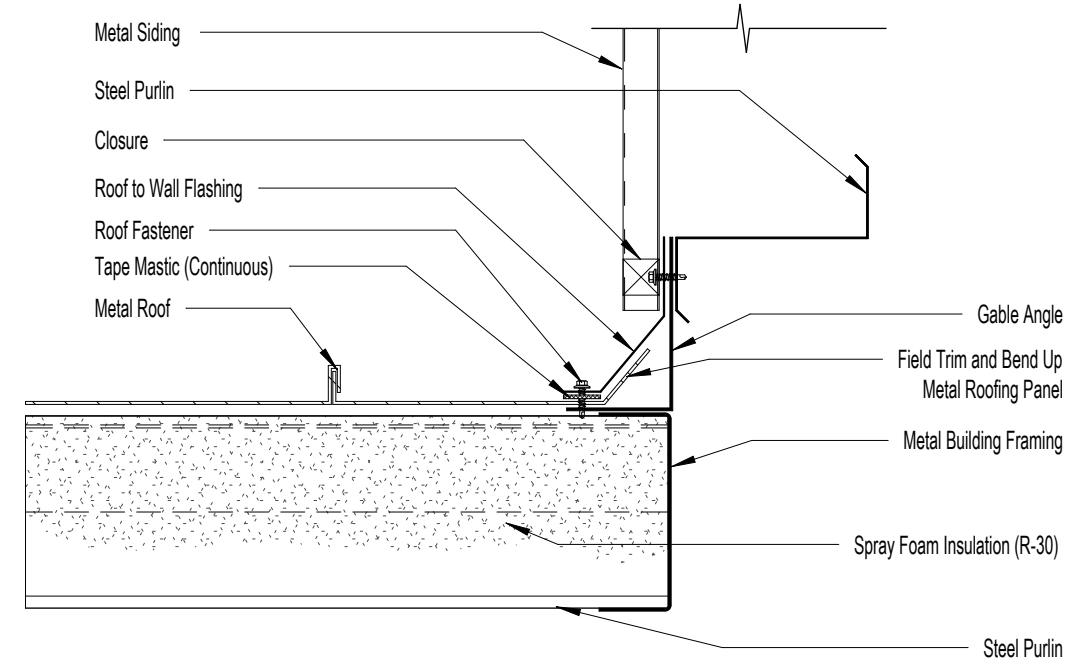


4 Roof to Wall Detail
A9.0 Scale: 1 1/2" = 1'-0"

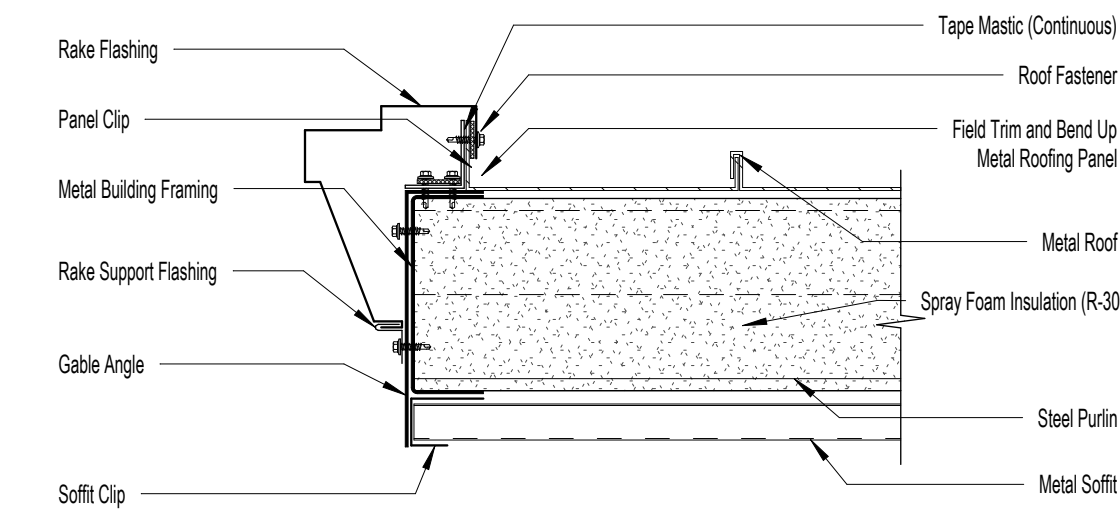


5 Roof Rake Detail
A9.0 Scale: 1 1/2" = 1'-0"

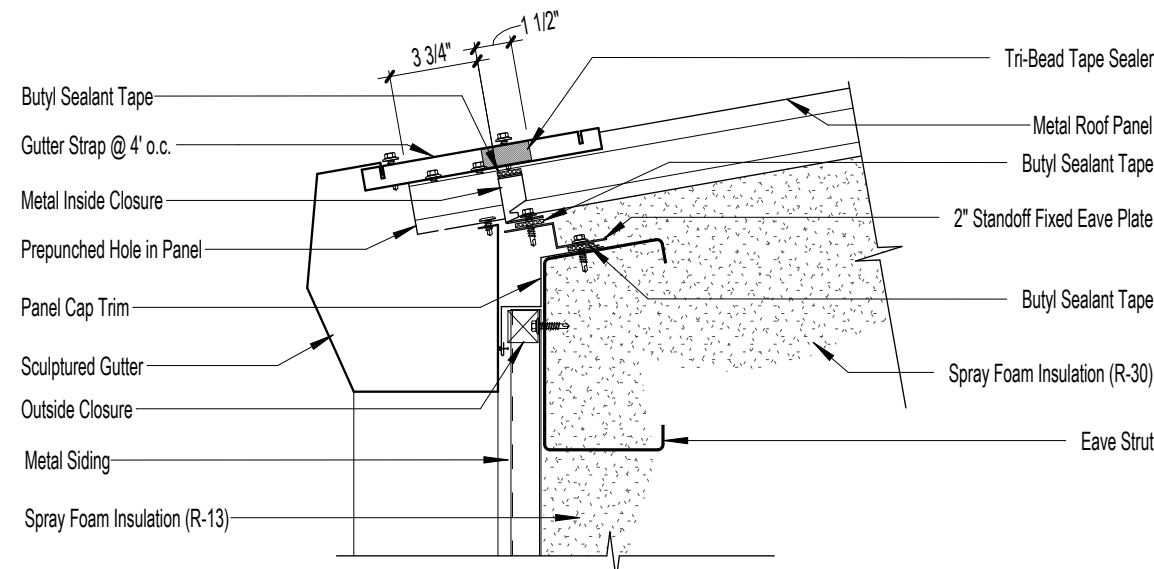

7 Eave Detail w/ Gutter
A9.0 Scale: 1 1/2" = 1'-0"

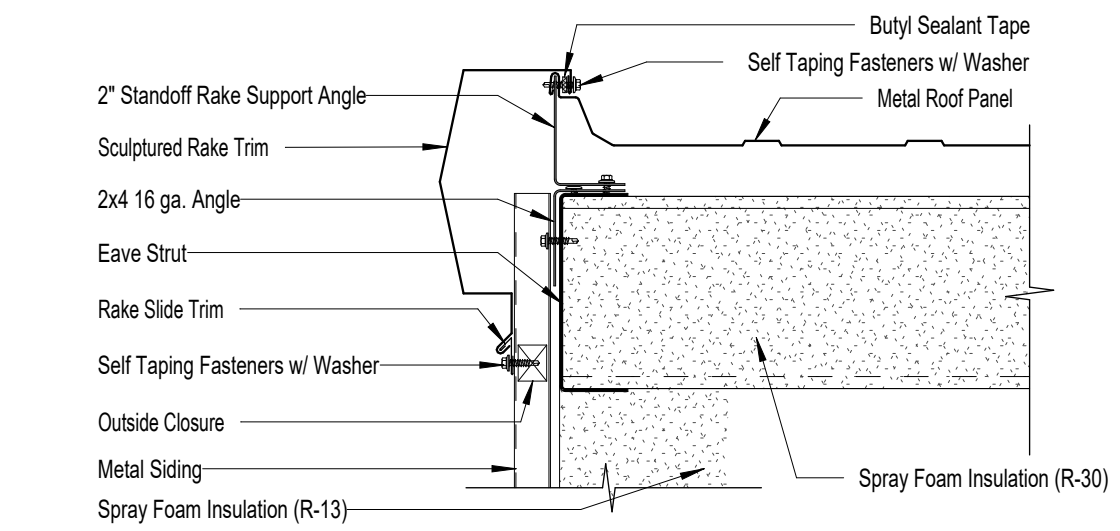

6 Rake Detail
A9.0 Scale: 1 1/2" = 1'-0"

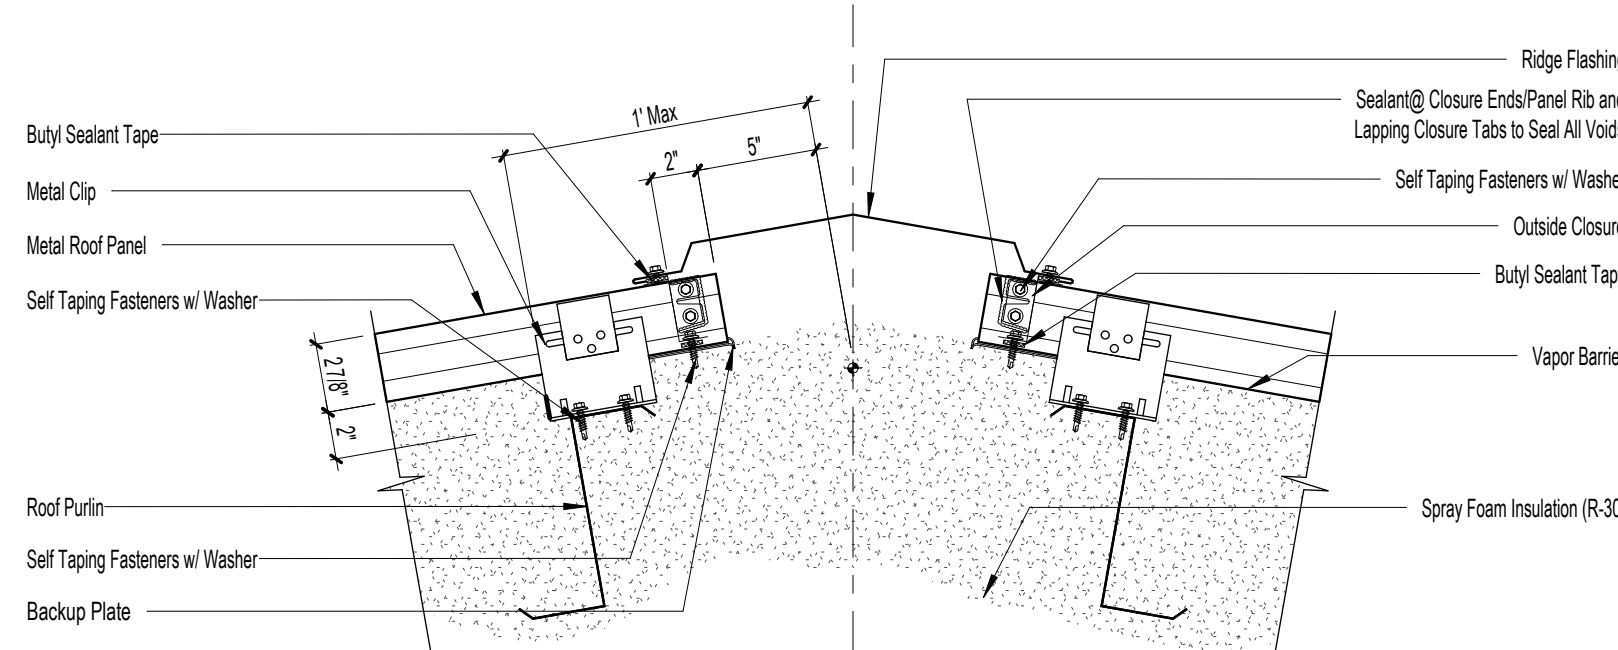

9 Ridge Detail
A9.0 Scale: 1 1/2" = 1'-0"

GADSDEN CO. BOCC

Havana Medical Center Remodel

Havana, FL



Clemons, Rutherford,
& Associates, Inc.

Architects
Planners
Interior Designers
Construction Managers

2027 Thomasville Road
Tallahassee, Florida 32308

phone 850-385-6153
fax 850-386-8420
cra@craarchitects.com

The Drawings, Specifications and other documents prepared by Clemons, Rutherford & Associates, Inc. (CRA) for this Project are instruments of CRA for use solely with respect to this Project and, unless otherwise provided, CRA shall be deemed the author of these documents and shall retain all common law, statutory and other reserved rights, including the copyright. The Owner shall be permitted to retain copies, including reproducible copies, of CRA's Drawings, Specifications and other documents for information and reference in connection with the Owner's use and occupancy of the Project. CRA's Drawings, Specifications or other documents shall not be used by the Owner or others on other projects, for documents shall not be used by the Owner or others on other projects, for additions to this Project or for completion of this Project by others, unless the Architect is adjudged to be in default under this Agreement, except by agreement in writing and with appropriate compensation to CRA.

Gregory Westmoreland Kelley
AR0016706

Submittal

Phase	Date	Drw	Chk
100% Construction Doc.	5/26/25	BY	GK
100% Review Documents	12/16/24		
-	-		
-	-		
-	-		
-	-		

Revision

#	Description	Date

CRA Project # 25027

Phase: 100% Construction Doc.

SHEET TITLE

Roof Plan

A9.0