

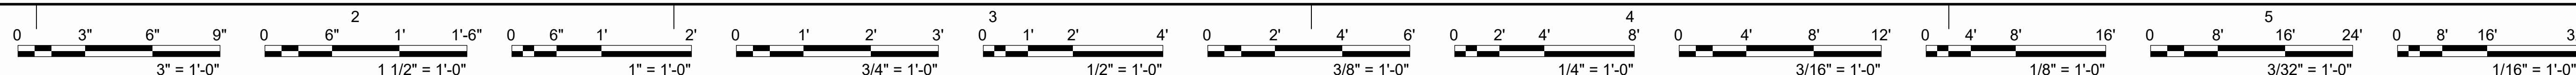
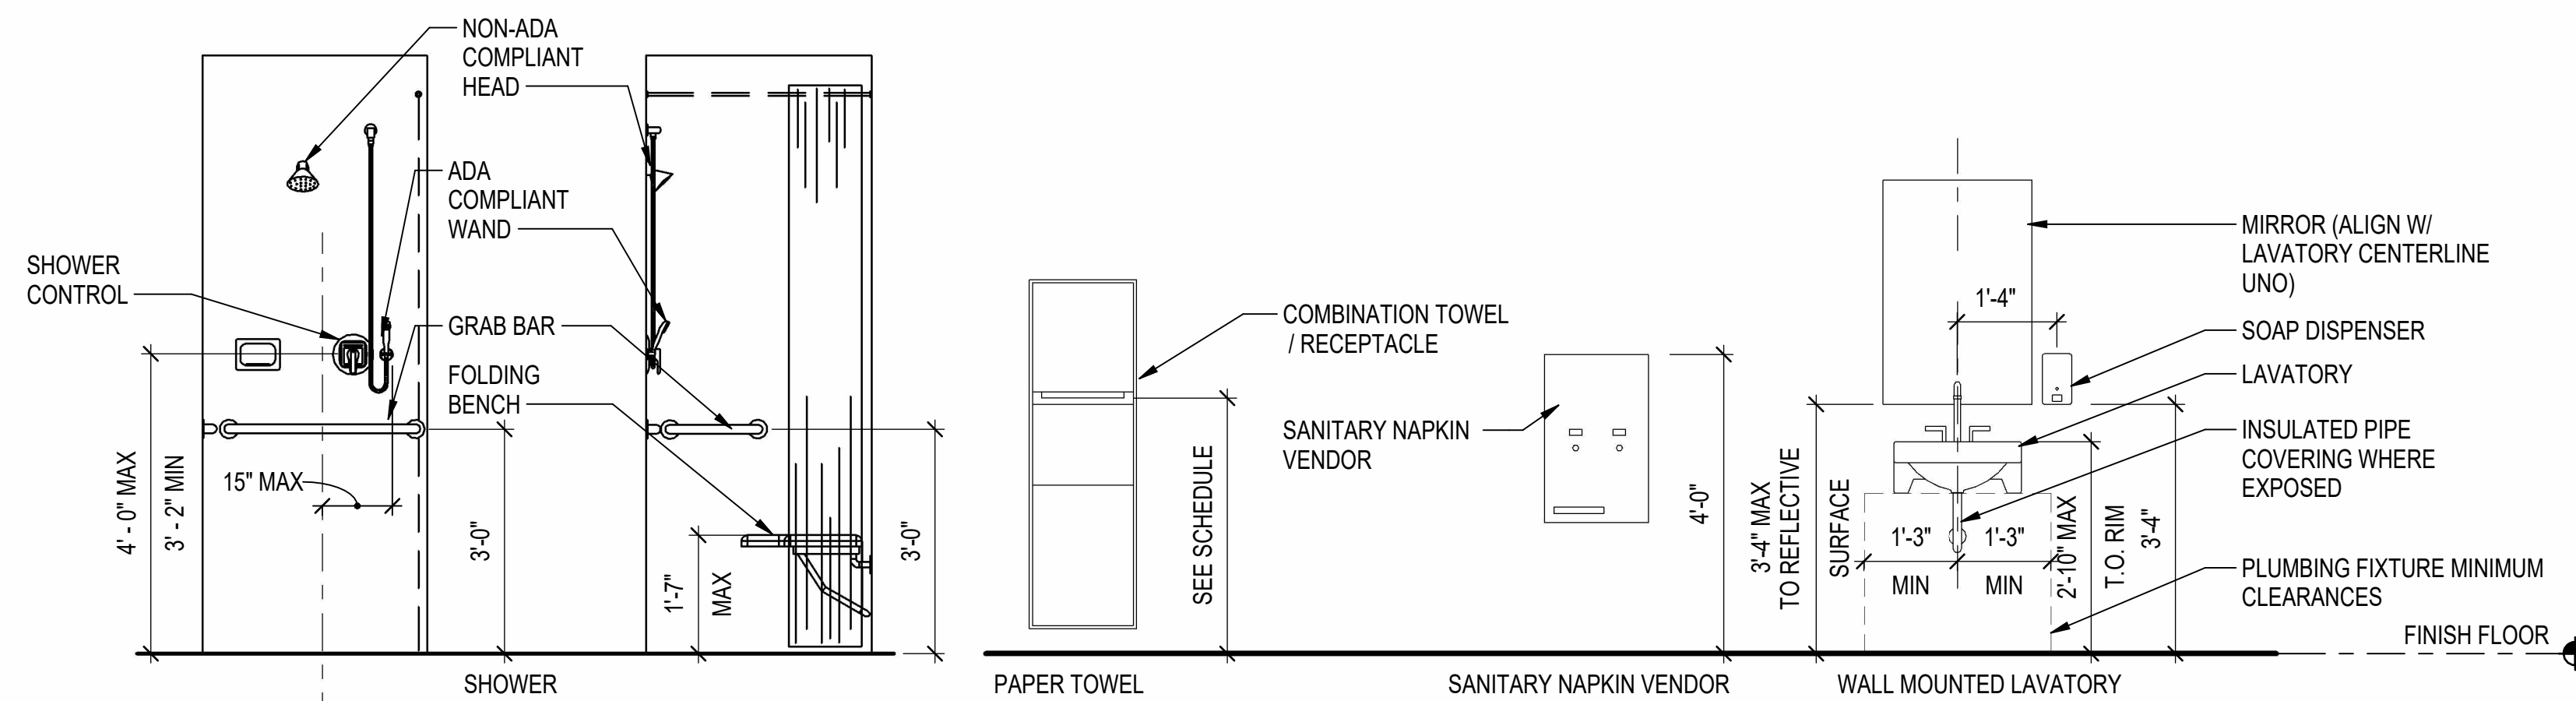


GA	GAUGE
GALV	GALVANIZED
GB	GRAB BAR
GC	GENERAL CONTRACTOR
GDR	GUARD RAIL
GEN	GENERAL
GFRG	GLASS FIBER REINFORCED GYPSUM
GL	GLASS
GRD	GRADE
GYM	GYMNASIUM
GYP BD	GYPSUM BOARD
HM	HOLLOW METAL
HORIZ	HORIZONTAL
HR	HOUR
HT	HEIGHT
HVAC	"HEATING, VENTILATING, & AIR CONDITIONING"
IBC	INTERNATIONAL BUILDING CODE
ID	INSIDE DIAMETER
IN	INCH(ES)
INSUL	INSULATE (OR) INSULATION
INT	INTERIOR
JAN	JANITOR
JT	JOINT
KIT	KITCHEN
LAM	LAMINATE
LAV	LAVATORY
LBS	POUND(S)
LED	LIGHT EMITTING DIODE
LF	LINEAR FEET (FOOT)
LH	LEFT HAND
LIB	LIBRARY
LIN	LINEAR
LOC	LOCATION
LTG	LIGHTING
LVR	LOUVER
MAINT	MAINTENANCE
MATL	MATERIAL
MAX	MAXIMUM
MECH	MECHANICAL
MEP	"MECHANICAL, ELECTRICAL, PLUMBING"
MEZZ	MEZZANINE
MFR	MANUFACTURER
MIN	MINIMUM
MIRR	MIRROR
MISC	MISCELLANEOUS
MJ	MASONRY EXPANSION JOINT
MO	MASONRY OPENING
MTD	MOUNTED
MTL	METAL
N	NORTH
NA	NOT APPLICABLE
NC	NOISE CRITERIA
NPFA	NATIONAL FIRE PROTECTION ASSOCIATION
NIC	NOT IN CONTRACT
N	NUMBER
NOM	NOMINAL
NRC	NOISE REDUCTION COEFFICIENT
NTS	NOT TO SCALE
OA	OVERALL
OC	ON CENTER
OCEW	ON CENTER EACH WAY
OD	OUTSIDE DIAMETER
OFCI	OWNER FURNISHED CONTRACTOR INSTALLED
OFOI	OWNER FURNISHED OWNER INSTALLED
OSFS	OUTSIDE FACE OF STUDS
OH	OPPOSITE HAND
OPNG	OPENING
OPP	OPPOSITE
OPT	OPTIONAL
ORD	OVER/LOW ROOF DRAIN
OVHD	OVERHEAD
OZ	OUNCE(S)
PCI	PRECAST / PRESTRESSED CONCRETE INSTITUTE
PEMB	PRE-ENGINEERED METAL BUILDING
PH	PHASE
PLAM	PLASTIC LAMINATE
PLBG	PLUMBING
PLF	POUNDS PER LINEAR FOOT
PLYWD	PLYWOOD
PR	PAIR

TYPICAL ACCESSIBILITY, PLUMBING FIXTURE AND TOILET ACCESSORY CLEARANCES, MOUNTING HEIGHTS AND DIMENSIONS

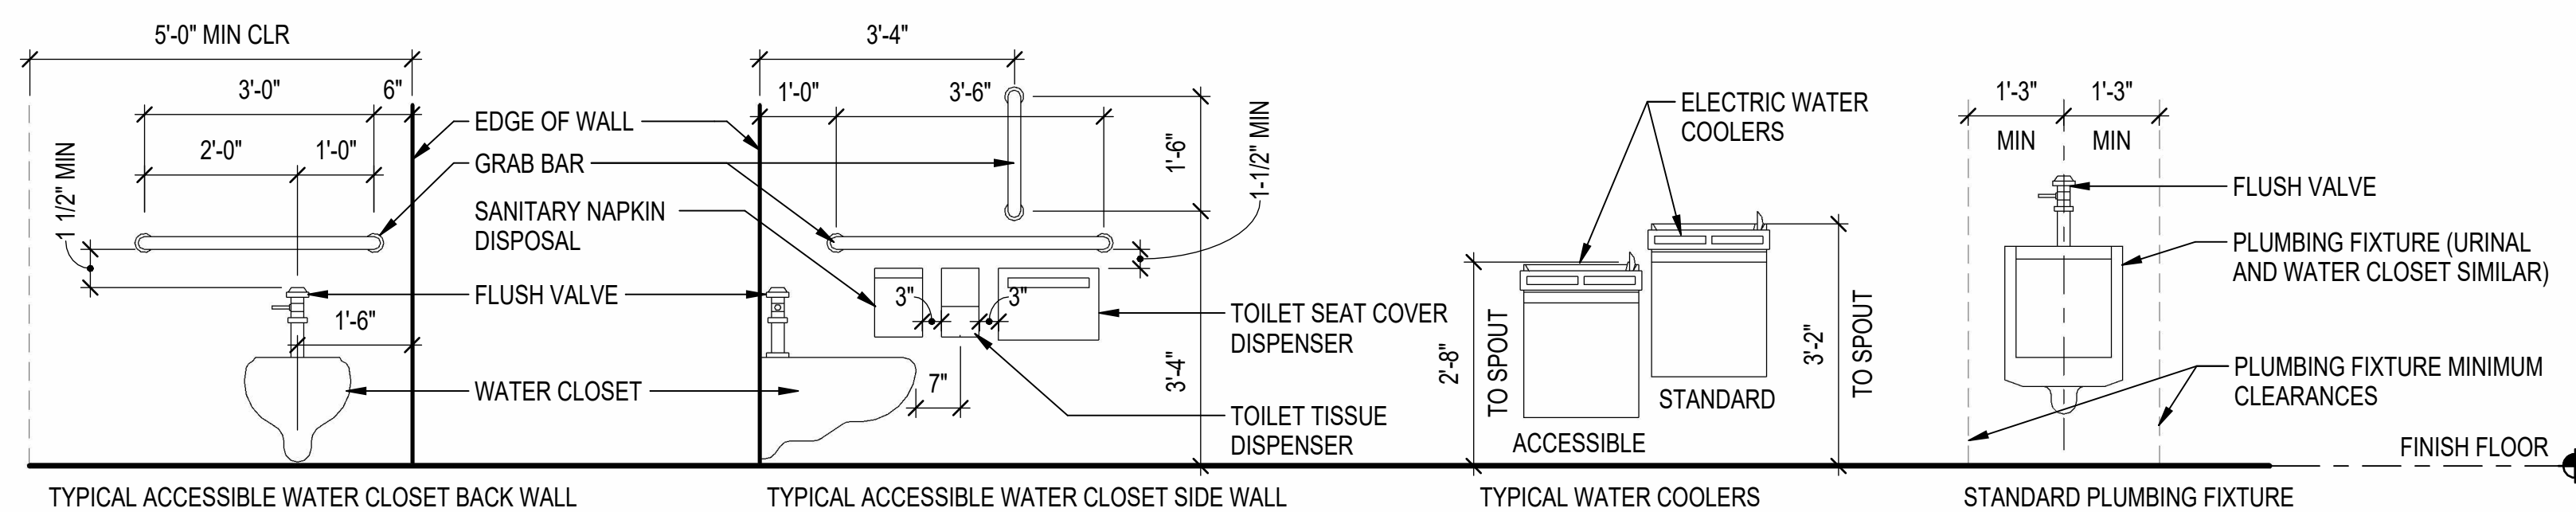

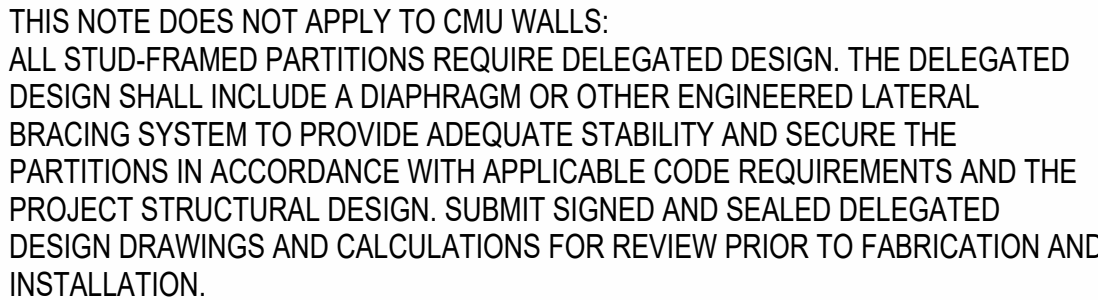

- | | | | |
|----|---|----|---|
| A1 | NON-RATED PARTITION | C1 | NON-RATED PARTITION |
| A2 | NON-RATED PARTITION WITHOUT SOUND ATTENUATION BATTS | C2 | NON-RATED PARTITION WITHOUT SOUND ATTENUATION BATTS |
| A3 | NON-RATED PARTITION WITH 6" STUDS IN LIEU OF 3 5/8" STUDS | | |
| A4 | NON-RATED PARTITION WITH 6" STUDS IN LIEU OF 3 5/8" STUDS AND WITHOUT SOUND ATTENUATION BATTS | | |

TYPICAL PARTITION NOTES

- A. ALL GYPSUM BOARD SHALL BE 5/8" TYPE-X.
- B. ALL INTERIOR NON-LOAD BEARING STUDS SHALL BE 20 GAUGE AT 16" ON CENTER - UNLESS NOTED OTHERWISE.
- C. PROVIDE CONTINUOUS 20 GAUGE DEFLECTION TRACK (2 1/2" DEEP) TRACK AND 20 GAUGE UPPER HORIZONTAL SPACING BARS AT ALL INTERIOR PARTITIONS EXTENDED TO DECK.
- D. SUBSTITUTE 5/8" TYPE-X TYPE I BACKER BOARD AT ALL LOCATIONS SCHEDULED TO RECEIVE WALL TILE.
- E. ALL GYPSUM BOARD SHALL BE CUT TIGHT TO FIT AND SEALED COMPLETELY WITH REQUIRED SEALANT FOR EITHER FIRE RATING OR SOUND ATTENUATION AT ALL PENETRATIONS THROUGH INTERIOR PARTITIONS. ALL FULL HEIGHT GYPSUM WALL BOARD ON ONE OR BOTH SIDES.
- F. FILL ALL PERIMETER VOIDS AND HEAD OF WALL METAL DECK FLUTES WITH FIRESEALING INSULATION AT ALL FIRE RATED WALLS TO ACHIEVE COMPLETE CLOSURE AND SEAL BOTH SIDES WITH ELASTIC FIRESTOPPING SPRAY MASTIC.
- G. ALL PENETRATIONS THROUGH PARTITIONS WHERE INDICATED SHALL FILL THE STUD CAVITY AND SHALL BE UNFRAISED, 25 Pcf - INSTALLED CONTINUOUS VERTICALLY, CUT TIGHT TO FIT.
- H. PROVIDE MOISTURE RESISTANT GYPSUM BOARD AT THE FOLLOWING LOCATIONS:
 - a. XXXX
 - b. XXXX
- I. PROVIDE IMPACT RESISTANT GYPSUM BOARD AT THE FOLLOWING LOCATIONS:
 - a. XXXX
 - b. XXXX

PRELIMINARY

THIS DOCUMENT IS
PRELIMINARY IN
NATURE AND IS NOT A
FINAL, SIGNED AND
SEALED DOCUMENT

FLORIDA STATE UNIVERSITY
FSU INSPIRE

PANAMA CITY, FLORIDA

REVISION HISTORY		
△	DESCRIPTION	DATE

PROJECT INFORMATION	
DESIGNED BY: SM	REVIEWED BY: AM
DRAWN BY: SM	PROJECT MANAGER: LL

PROJECT NUMBER
FSB2026-176-00
SHEET TITLE:


PARTITION TYPES

ISSUE DATE



AUGUST 6, 2026

SHEET NUMBER

50% CONSTRUCTION DOCUMENTS

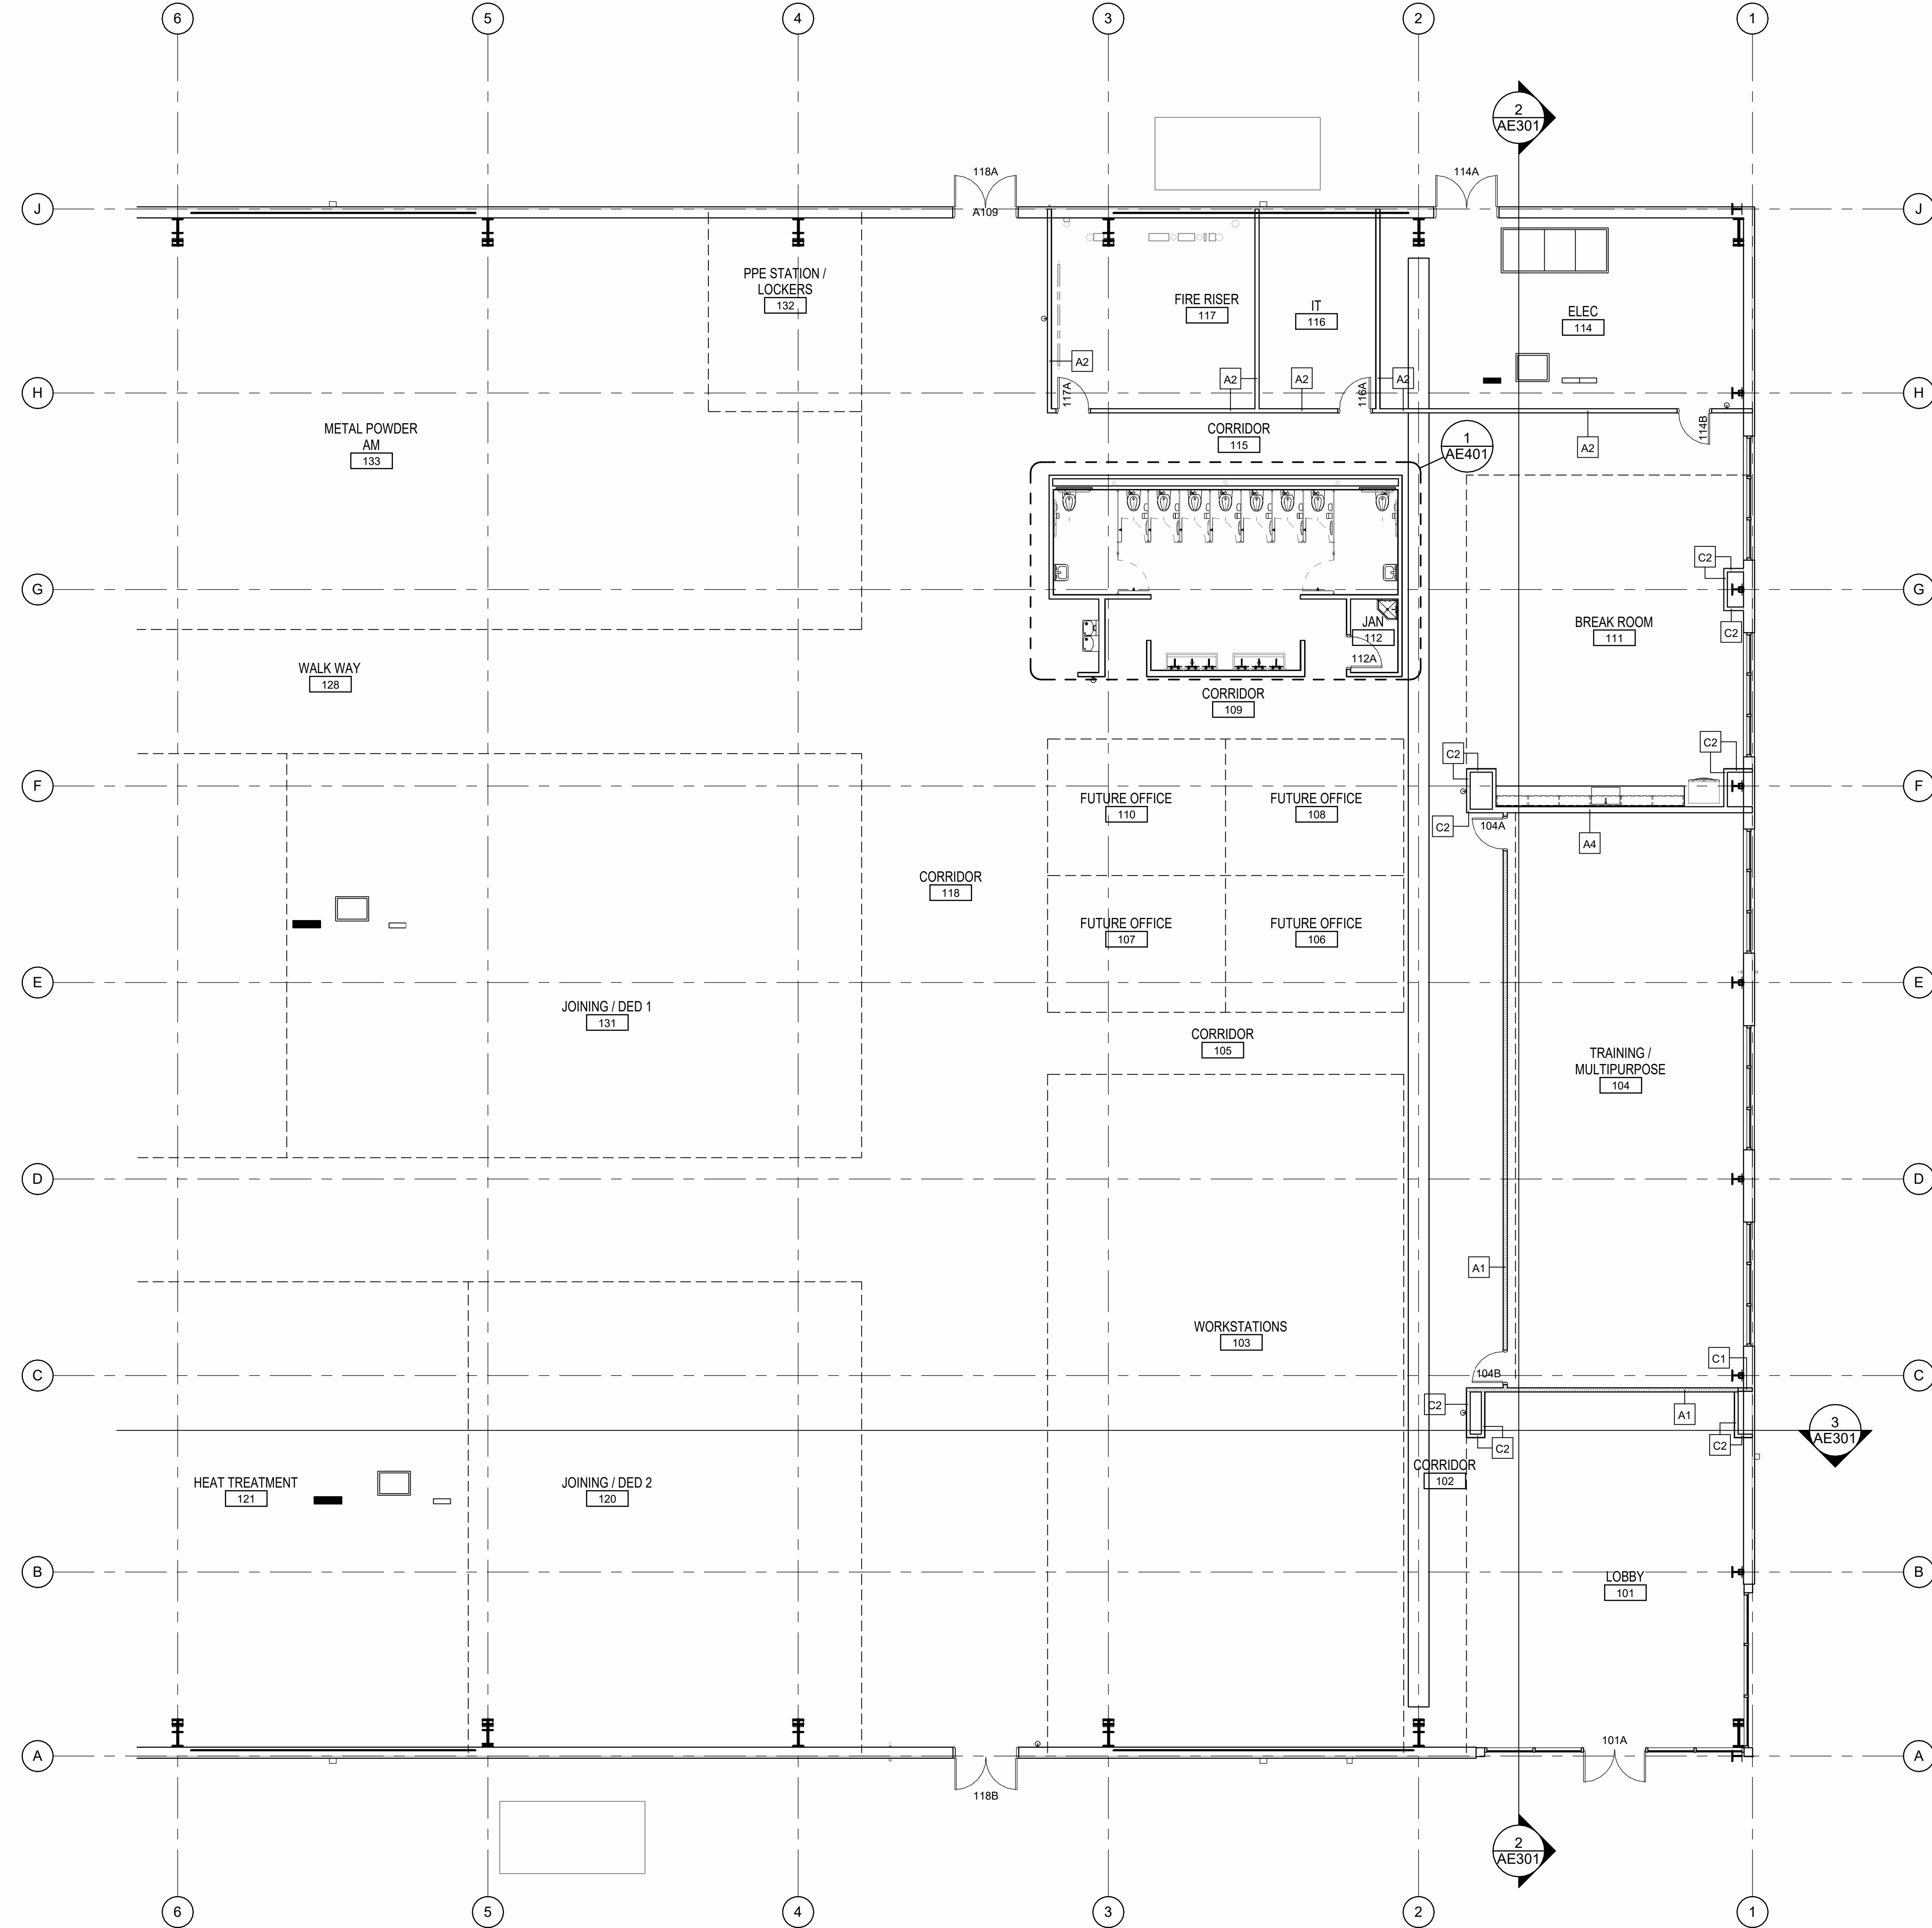

1 SECTOR A - FLOOR PLAN
SCALE: 1/8" = 1'-0"

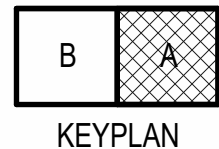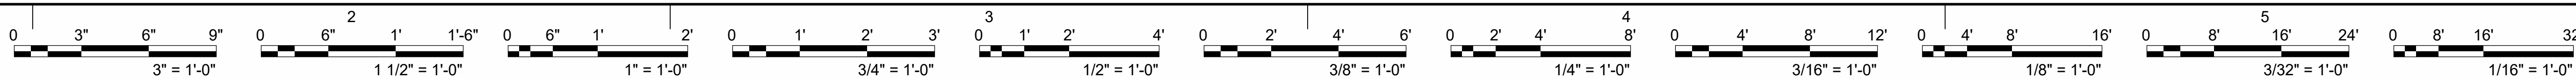

GENERAL NOTES

- ALL EXTERIOR BUILDING PERIMETER DIMENSIONS ARE TO FINISH FACE OF EXTERIOR BUILDING. EXTERIOR STRUCTURAL LINE (GIRT LINE) AND COLUMN ROW DIMENSIONS TO BE COORDINATED WITH THE PRE-ENGINEERED METAL BUILDING MANUFACTURER.
- ALL INTERIOR DIMENSIONS ARE TO FACE OF STUD, UNLESS NOTED OTHERWISE.
- ALL DOOR FRAMES TO BE LOCATED 4" FROM ADJACENT WALL, UNLESS NOTED OTHERWISE.
- COORDINATE REQUIRED BLOCKING, BACKING, PENETRATIONS AND SUPPORTS FOR OPENINGS AND WALL MOUNTED CONSTRUCTION OR EQUIPMENT. PROVIDE ALL INTERNAL WALL SUPPORTS FOR ANY WALL MOUNTED FIXTURES, EQUIPMENT, MILLWORK OR OTHER CONSTRUCTION WHETHER OR NOT THE ITEMS ARE PROVIDED BY THE CONTRACTOR. WHERE OWNER FURNISHED ITEMS REQUIRE WALL BLOCKING OR OTHER SUPPORT COORDINATE WITH OWNER FOR REQUIREMENTS.
- REFERENCE SHEET xxx FOR DOOR AND GLAZING TYPES.



Frankfurt-Short-Bruza Associates, P.C.
1999 Bryan St., Suite 900
Dallas, TX 75201-3136
405.840.2931 | fsb-ae.com
Engineering CoA - 36003 Exp. 12/31/2030
Architectural CoA - 36003 Exp. 2/28/2030

PRELIMINARY

THIS DOCUMENT IS
PRELIMINARY IN
NATURE AND IS NOT A
FINAL, SIGNED AND
SEALED DOCUMENT

FLORIDA STATE UNIVERSITY FSU INSPIRE PANAMA CITY, FLORIDA

REVISION HISTORY

NO.	DESCRIPTION	DATE

PROJECT INFORMATION

DESIGNED BY:	SM	REVIEWED BY:	AM
DRAWN BY:	SM	PROJECT MANAGER:	LL

PROJECT NUMBER

FSB2026-176-00

SHEET TITLE:


SECTOR A - FLOOR PLAN

ISSUE DATE



AUGUST 6, 2026

SHEET NUMBER

AE101A

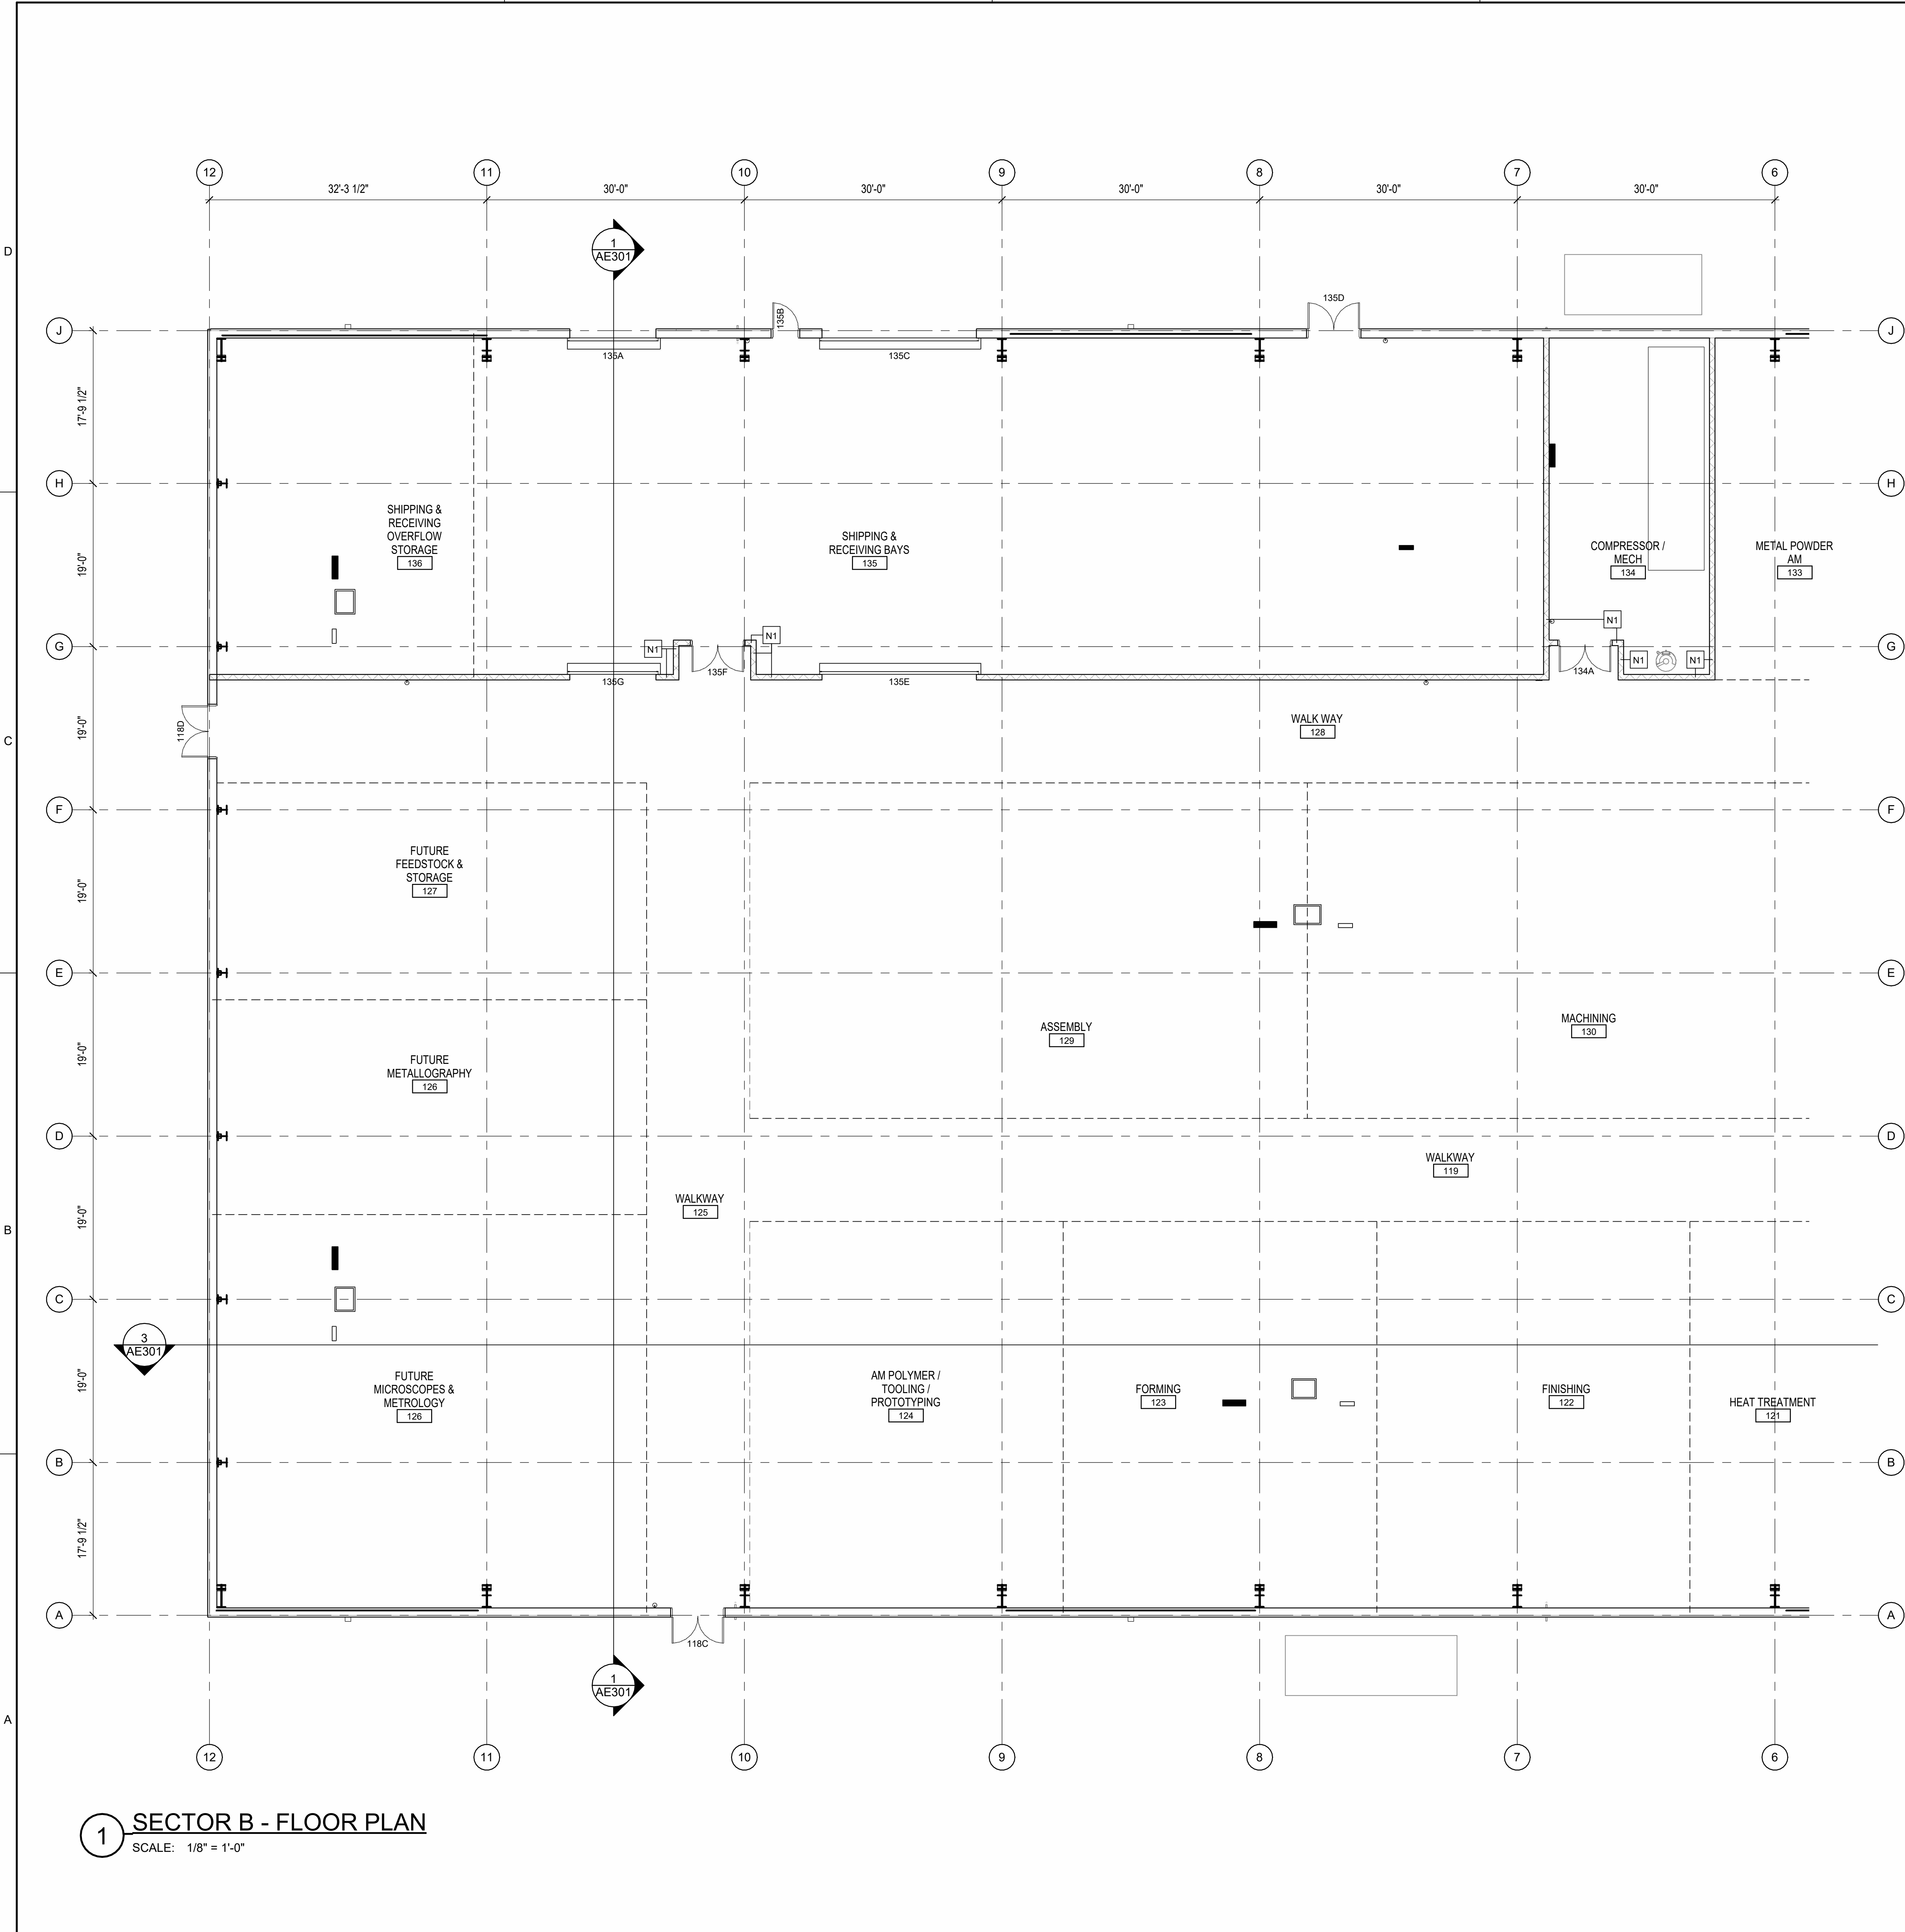

1 SECTOR B - FLOOR PLAN
SCALE: 1/8" = 1'-0"

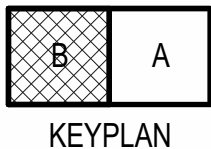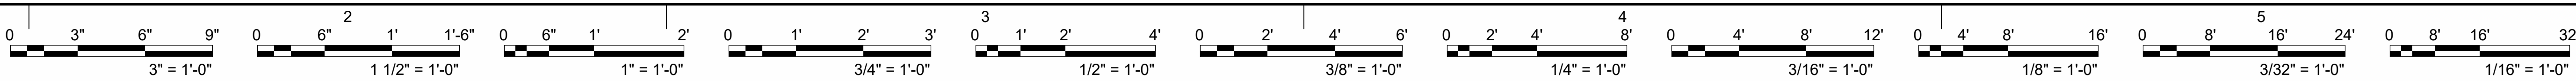

GENERAL NOTES

- A. ALL EXTERIOR BUILDING PERIMETER DIMENSIONS ARE TO FINISH FACE OF EXTERIOR BUILDING. EXTERIOR STRUCTURAL LINE (GIRT LINE) AND COLUMN ROW DIMENSIONS TO BE COORDINATED WITH THE PRE-ENGINEERED METAL BUILDING MANUFACTURER.
- B. ALL INTERIOR DIMENSIONS ARE TO FACE OF STUD, UNLESS NOTED OTHERWISE.
- C. ALL DOOR FRAMES TO BE LOCATED 4" FROM ADJACENT WALL, UNLESS NOTED OTHERWISE.
- D. COORDINATE REQUIRED BLOCKING, BACKING, PENETRATIONS AND SUPPORTS FOR OPENINGS AND WALL MOUNTED CONSTRUCTION OR EQUIPMENT. PROVIDE ALL INTERNAL WALL SUPPORTS FOR ANY WALL MOUNTED FIXTURES, EQUIPMENT, MILLWORK OR OTHER CONSTRUCTION WHETHER OR NOT THE ITEMS ARE PROVIDED BY THE CONTRACTOR. WHERE OWNER FURNISHED ITEMS REQUIRE WALL BLOCKING OR OTHER SUPPORT COORDINATE WITH OWNER FOR REQUIREMENTS.
- E. REFERENCE SHEET xxx FOR DOOR AND GLAZING TYPES.



Frankfurt-Short-Bruza Associates, P.C.
1999 Bryan St., Suite 900
Dallas, TX 75201-3136
405.840.2931 | fsb-ae.com
Engineering CoA - 36003 Exp. 12/31/2030
Architectural CoA - 36003 Exp. 2/28/2030

PRELIMINARY
THIS DOCUMENT IS
PRELIMINARY IN
NATURE AND IS NOT A
FINAL, SIGNED AND
SEALED DOCUMENT

FLORIDA STATE UNIVERSITY
FSU INSPIRE
PANAMA CITY, FLORIDA

REVISION HISTORY		
NO.	DESCRIPTION	DATE


PROJECT INFORMATION	
DESIGNED BY:	REVIEWED BY:
DRAWN BY:	PROJECT MANAGER:
SM	AM
SM	LL

PROJECT NUMBER
FSB2026-176-00

SHEET TITLE:
SECTOR B - FLOOR PLAN

ISSUE DATE
AUGUST 6, 2026

SHEET NUMBER
AE101B

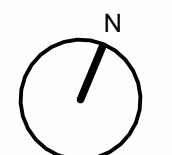

SCALE: 3/32" = 1'-0"

A. ALL EXTERIOR BUILDING PERIMETER DIMENSIONS ARE TO FINISH FACE OF EXTERIOR BUILDING. EXTERIOR STRUCTURAL LINE (GIRT LINE) AND COLUMN ROW DIMENSIONS TO BE COORDINATED WITH THE PRE-ENGINEERED METAL BUILDING MANUFACTURER.

B. ALL INTERIOR DIMENSIONS ARE TO FACE OF STUD, UNLESS NOTED OTHERWISE.

C. ALL DOOR THRESHLES TO BE LOCATED 4" FROM ADJACENT WALL, UNLESS NOTED OTHERWISE.

D. COORDINATE REQUIRED BLOCKING, BACKING, PENETRATIONS AND SUPPORTS FOR OPENINGS AND WALL MOUNTED CONSTRUCTION OR EQUIPMENT. PROVIDE ALL INTERNAL WALL SUPPORTS FOR ANY WALL MOUNTED FIXTURES, EQUIPMENT, MILLWORK OR OTHER CONSTRUCTION WHETHER OR NOT THE ITEMS ARE PROVIDED BY THE CONTRACTOR. THE OWNER FURNISHES ITEMS REQUIRED FOR BLOCKING OR OTHER SUPPORT COORDINATE WITH OWNER FOR REQUIREMENTS.

E. REFERENCE SHEET xxx FOR DOOR AND GLAZING TYPES.



Frankfurt-Short-Bruza Associates, P.C.
1999 Bryan St., Suite 900
Dallas, TX 75201-3136
405.840.2931 | fsb-ae.com

Engineering CoA - 36003	Exp. 12/31/2030
Architectural CoA - 36003	Exp. 2/28/2030

THIS DOCUMENT IS
PRELIMINARY IN
NATURE AND IS NOT A
FINAL, SIGNED AND
SEALED DOCUMENT

FLORIDA STATE UNIVERSITY
FSU INSPIRE

PANAMA CITY, FLORIDA

REVISION HISTORY		
△	DESCRIPTION	DATE

PROJECT INFORMATION	
DESIGNED BY: SM	REVIEWED BY: AM
DRAWN BY: SM	PROJECT MANAGER: LL

PROJECT NUMBER	FSB2026-176-00
----------------	----------------

SHEET TITLE:

COMPOSITE - FIRST FLOOR


ISSUE DATE

AUGUST 6, 2026

SHEET NUMBER

AE101

50% CONSTRUCTION DOCUMENTS

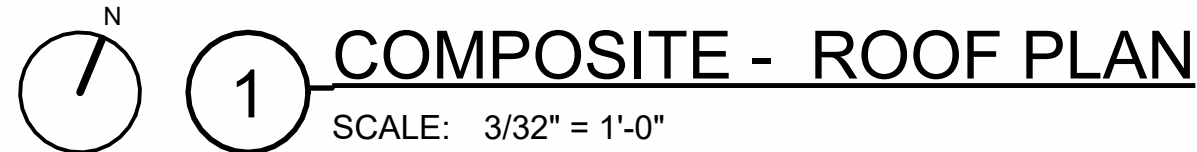

A. ALL ROOFING SHALL BE A TPO ROOF SYSTEM U.N.O .
B. ALL MAIN ROOFS SHALL SLOPE AT 1/4" PER FOOT UNO
C. ALL DRAINAGE CRICKETS SHALL BE 1/2" PER FOOT UNO
D. THE ENTIRE BASE ROOF INSULATION SHALL BE (2) LAYERS OF 2" RIGID INSULATION
E. ALL PARAPET CAPS ARE PRE-FINISHED METAL UNO



Frankfurt-Short-Bruza Associates, P.C.
1999 Bryan St., Suite 900
Dallas, TX 75201-3136
405.840.2931 | fsb-ae.com

Engineering CoA - 36003 Exp. 12/31/2030
Architectural CoA - 36003 Exp. 2/28/2030

THIS DOCUMENT IS
PRELIMINARY IN
NATURE AND IS NOT A
FINAL, SIGNED AND
SEALED DOCUMENT

FLORIDA STATE UNIVERSITY
FSU INSPIRE

PANAMA CITY, FLORIDA

REVISION HISTORY		
△	DESCRIPTION	DATE

PROJECT INFORMATION	
DESIGNED BY: SM	REVIEWED BY: AM
DRAWN BY: SM	PROJECT MANAGER: LL


PROJECT NUMBER	
FSB2026-176-00	
SHEET TITLE:	

COMPOSITE - ROOF PLAN

ISSUE DATE	AUGUST 6, 2026
SHEET NUMBER	

AE103

50% CONSTRUCTION DOCUMENTS

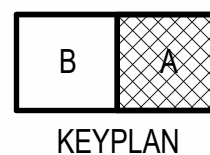


- A. IN ROOMS WITHOUT CEILING, ALL EXPOSED STRUCTURE AND INFRASTRUCTURE TO BE PAINTED UNO
- B. PROVIDE CONTROL JOINTS IN GYPSUM BOARD CEILINGS WHERE INDICATED OR SPECIFIED.
- C. DOWNLIGHTS WHERE PROVIDED TO BE CENTERED IN ACOUSTICAL CEILING TILE, UNO
- D. ALL CEILINGS AT 9'-0" AFF UNO

KEY VALUE	DESCRIPTION
-----------	-------------

TYPICAL CEILING LEGEND

	2' x 2' CEILING GRID
	GYP BD CEILING
	2' x 4' FIXTURE
	2' x 4' FIXTURE - EMERGENCY
	2' x 4' FIXTURE - CLG MTD
	1' x 4' FIXTURE
	1' x 4' FIXTURE - EMERGENCY
	1' x 4' FIXTURE - SUSPENDED
	4' FIXTURE - STRIP
	RECESSED DOWNLIGHT
	RECESSED DOWNLIGHT - EMERGENCY
	EXIT SIGNS
	WALL MTD EXTERIOR LIGHT
	WALL MTD EXTERIOR LIGHT - EMERGENCY
	SUPPLY AIR DIFFUSERS
	RETURN AIR GRILLES
	ACCESS DOORS

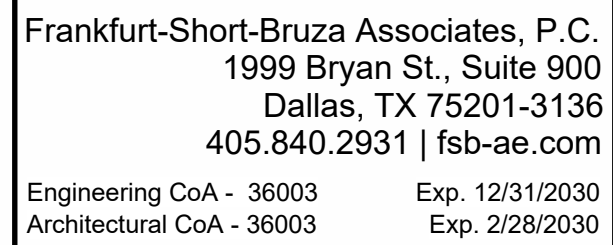

THIS DOCUMENT IS
PRELIMINARY IN
NATURE AND IS NOT A
FINAL, SIGNED AND
SEALED DOCUMENT


FLORIDA STATE UNIVERSITY
FSU INSPIRE

PANAMA CITY, FLORIDA

SHEET NUMBER

AE151

50% CONSTRUCTION DOCUMENTS

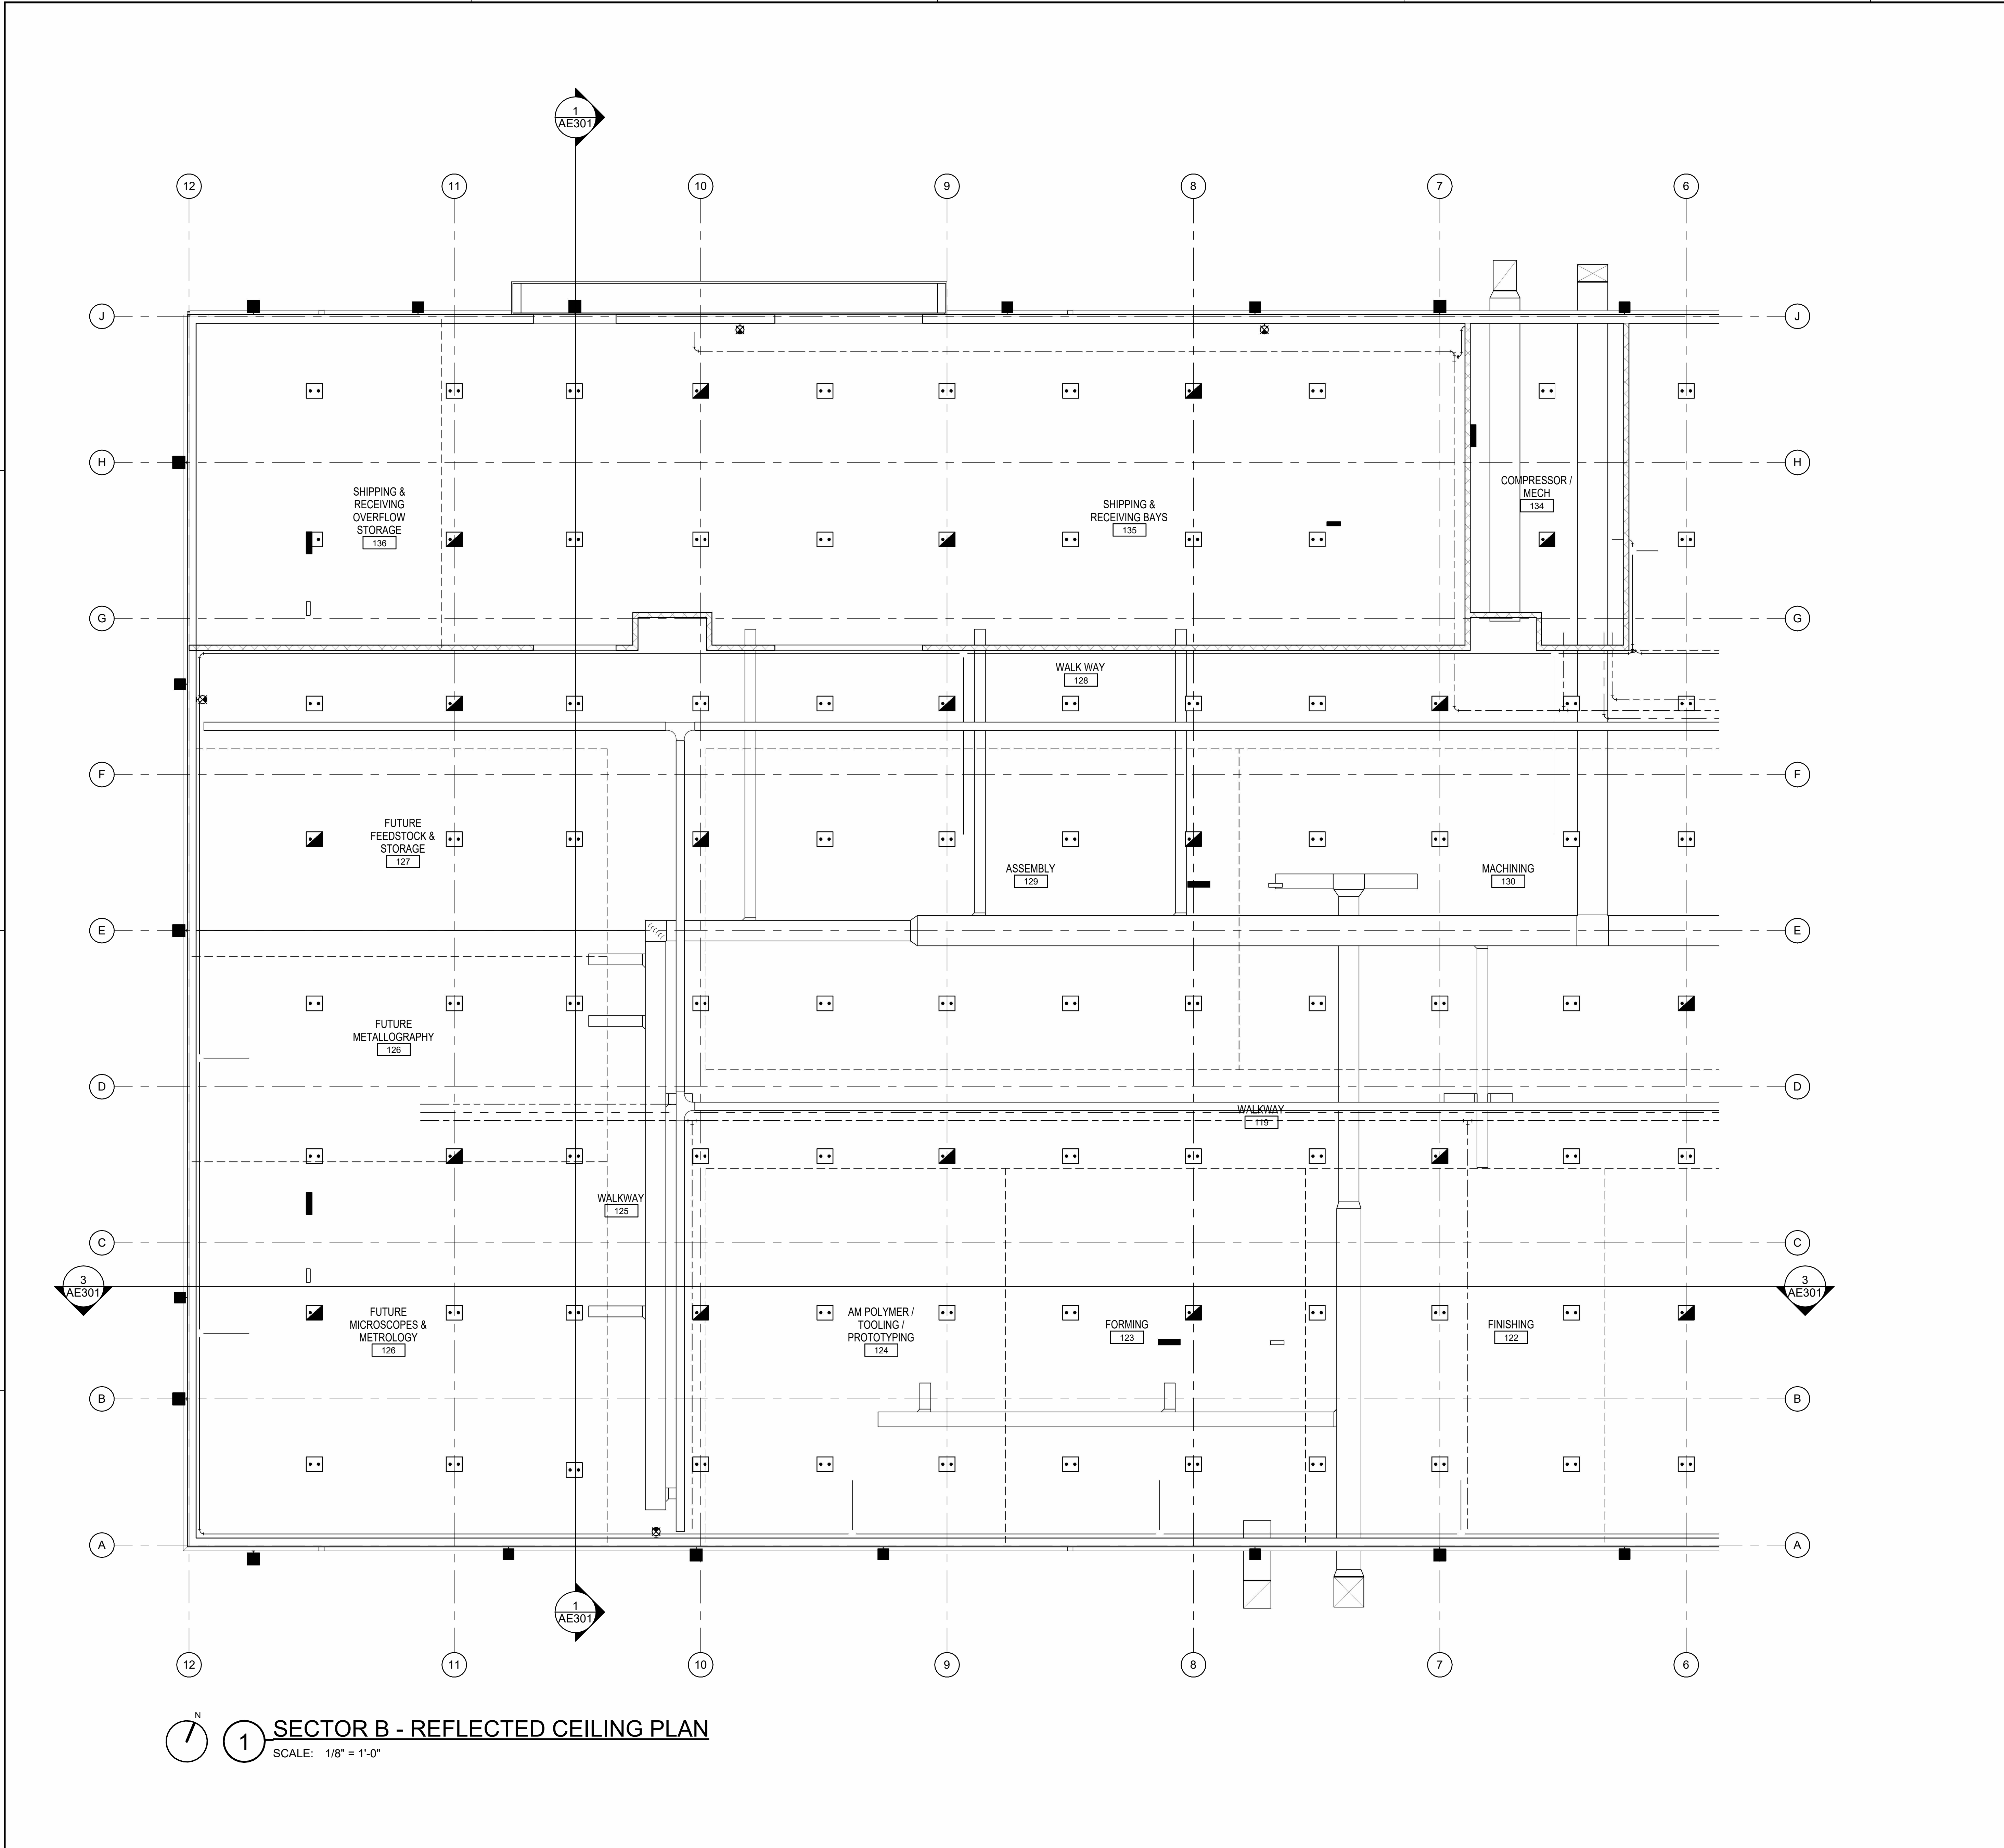

1 SECTOR B - REFLECTED CEILING PLAN
SCALE: 1/8" = 1'-0"

GENERAL SHEET NOTES


- A. IN ROOMS WITHOUT CEILING, ALL EXPOSED STRUCTURE AND INFRASTRUCTURE TO BE PAINTED UNO
- B. PROVIDE CONTROL JOINTS IN GYPSUM BOARD CEILINGS WHERE INDICATED OR SPECIFIED
- C. DOWNLIGHTS WHERE PROVIDED TO BE CENTERED IN ACOUSTICAL CEILING TILE, UNO
- D. ALL CEILINGS AT 9'-0" AFF UNO

SHEET KEYNOTES

KEY VALUE DESCRIPTION

TYPICAL CEILING LEGEND

	2' x 2' CEILING GRID
	GYP BD CEILING
	2' x 4' FIXTURE
	2' x 4' FIXTURE - EMERGENCY
	2' x 4' FIXTURE - CLG MTD
	1' x 4' FIXTURE
	1' x 4' FIXTURE - EMERGENCY
	1' x 4' FIXTURE - SUSPENDED
	4' FIXTURE - STRIP
	RECESSED DOWNLIGHT
	RECESSED DOWNLIGHT - EMERGENCY
	EXIT SIGNS
	WALL MTD EXTERIOR LIGHT
	WALL MTD EXTERIOR LIGHT - EMERGENCY
	SUPPLY AIR DIFFUSERS
	RETURN AIR GRILLES
	ACCESS DOORS

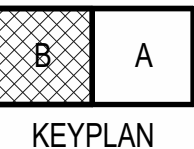

Frankfurt-Short-Bruza Associates, P.C.
1999 Bryan St., Suite 900
Dallas, TX 75201-3136
405.840.2931 | fsb-ae.com
Engineering CoA - 36003 Exp. 12/31/2030
Architectural CoA - 36003 Exp. 2/28/2030

PRELIMINARY
THIS DOCUMENT IS
PRELIMINARY IN
NATURE AND IS NOT A
FINAL, SIGNED AND
SEALED DOCUMENT

FLORIDA STATE UNIVERSITY
FSU INSPIRE
PANAMA CITY, FLORIDA


REVISION HISTORY	
DESCRIPTION	DATE

PROJECT INFORMATION	
DESIGNED BY:	REVIEWED BY:
DRAWN BY:	PROJECT MANAGER:

PROJECT NUMBER
FSB2026-176-00
SHEET TITLE:
SECTOR B - REFLECTED
CEILING PLAN

ISSUE DATE
AUGUST 6, 2026
SHEET NUMBER

AE152

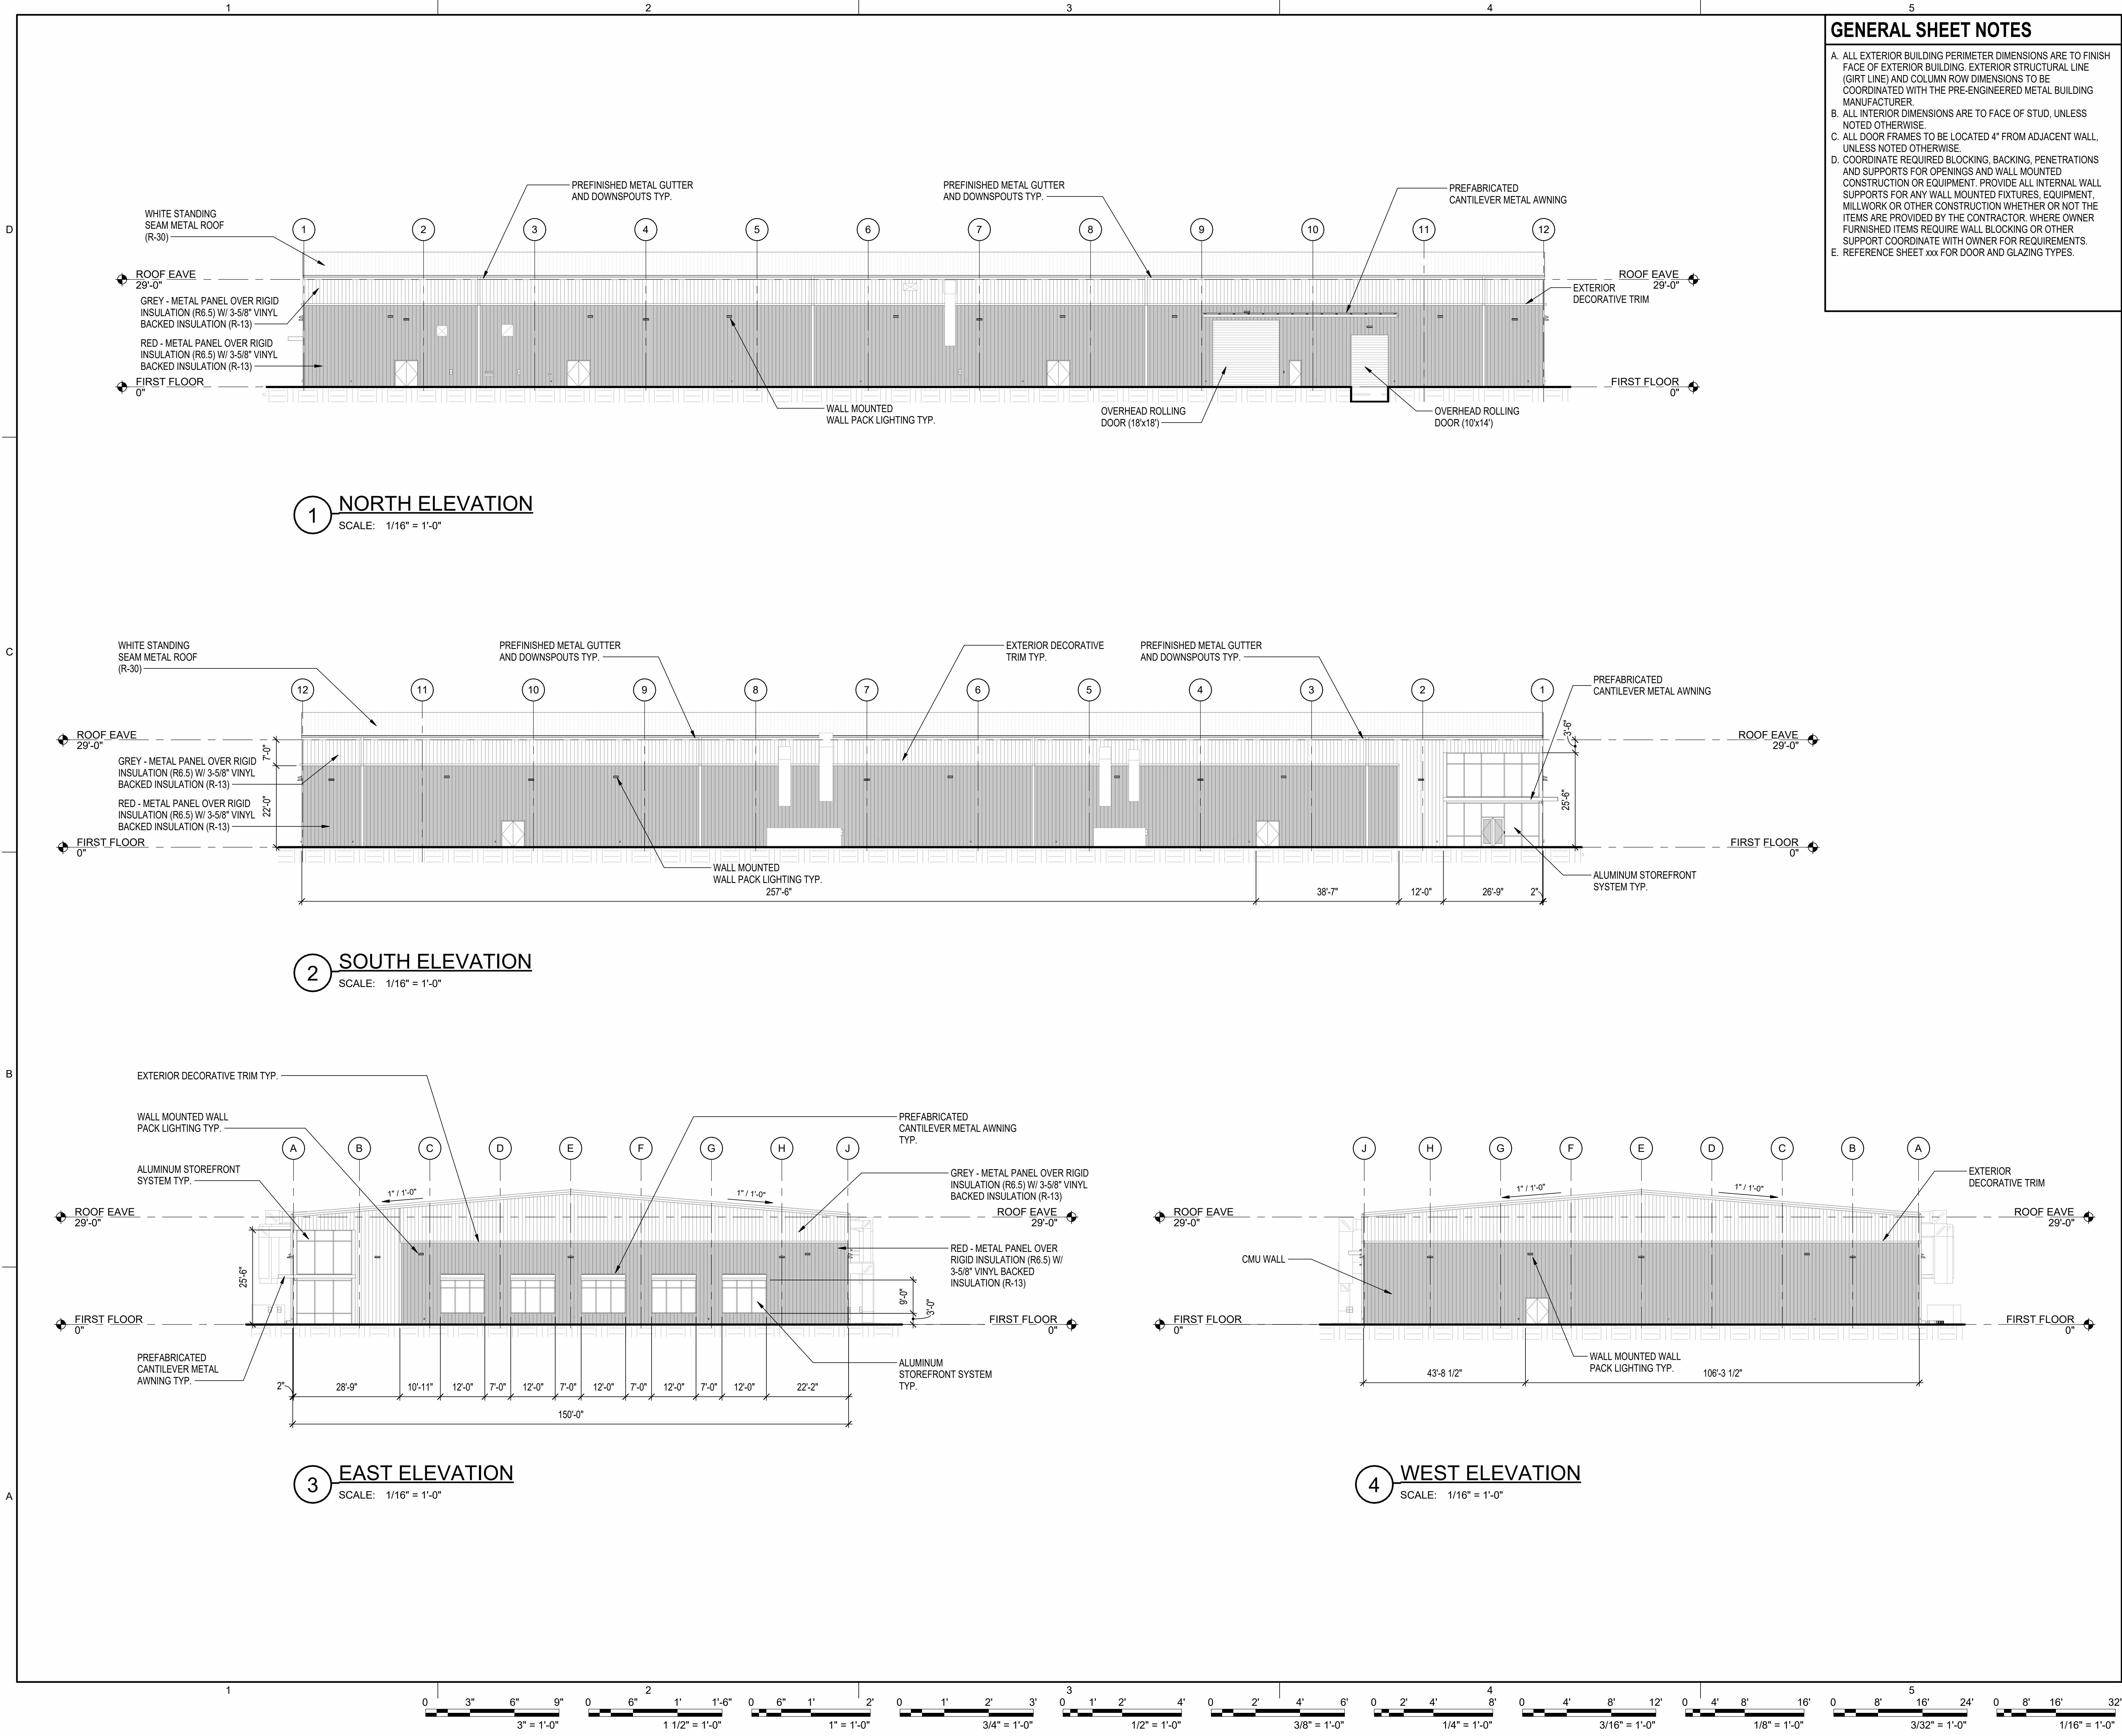

GENERAL SHEET NOTES

- A. ALL EXTERIOR BUILDING PERIMETER DIMENSIONS ARE TO FINISH FACE OF EXTERIOR BUILDING. EXTERIOR STRUCTURAL LINE (GIRT LINE) AND COLUMN ROW DIMENSIONS TO BE COORDINATED WITH THE PRE-ENGINEERED METAL BUILDING MANUFACTURER.
- B. ALL INTERIOR DIMENSIONS ARE TO FACE OF STUD, UNLESS NOTED OTHERWISE.
- C. ALL DOOR FRAMES TO BE LOCATED 4" FROM ADJACENT WALL, UNLESS NOTED OTHERWISE.
- D. COORDINATE REQUIRED BLOCKING, BACKING, PENETRATIONS AND SUPPORTS FOR OPENINGS AND WALL MOUNTED CONSTRUCTION OR EQUIPMENT. PROVIDE ALL INTERNAL WALL SUPPORTS FOR ANY WALL MOUNTED FIXTURES, EQUIPMENT, MILLWORK OR OTHER CONSTRUCTION WHETHER OR NOT THE ITEMS ARE PROVIDED BY THE CONTRACTOR. WHERE OWNER FURNISHED ITEMS REQUIRE WALL BLOCKING OR OTHER SUPPORT COORDINATE WITH OWNER FOR REQUIREMENTS.
- E. REFERENCE SHEET xxx FOR DOOR AND GLAZING TYPES.



Frankfurt-Short-Bruza Associates, P.C.
1999 Bryan St., Suite 900
Dallas, TX 75201-3136
405.840.2931 | fsb-ae.com
Engineering CoA - 36003 Exp. 12/31/2030
Architectural CoA - 36003 Exp. 2/28/2030

PRELIMINARY

THIS DOCUMENT IS
PRELIMINARY IN
NATURE AND IS NOT A
FINAL, SIGNED AND
SEALED DOCUMENT

FLORIDA STATE UNIVERSITY
FSU INSPIRE
PANAMA CITY, FLORIDA

REVISION HISTORY	

PROJECT INFORMATION	
DESIGNED BY:	REVIEWED BY:
DRAWN BY:	PROJECT MANAGER:

PROJECT NUMBER
FSB2026-176-00

BUILDING ELEVATIONS

ISSUE DATE

AUGUST 6, 2026

SHEET NUMBER

AE201



Frankfurt-Short-Bruza Associates, P.C.
1999 Bryan St., Suite 900
Dallas, TX 75201-3136
405.840.2931 | fsb-ae.com
Engineering CoA - 36003 Exp. 12/31/2030
Architectural CoA - 36003 Exp. 2/28/2030

PRELIMINARY

THIS DOCUMENT IS
PRELIMINARY IN
NATURE AND IS NOT A
FINAL, SIGNED AND
SEALED DOCUMENT

FLORIDA STATE UNIVERSITY
FSU INSPIRE
PANAMA CITY, FLORIDA

REVISION HISTORY		
Δ	DESCRIPTION	DATE


PROJECT INFORMATION	
DESIGNED BY:	SM
REVIEWED BY:	AM
DRAWN BY:	SM
PROJECT MANAGER:	LL

PROJECT NUMBER
FSB2026-176-00


SHEET TITLE:
BUILDING SECTIONS

ISSUE DATE
AUGUST 6, 2026
SHEET NUMBER


AE301

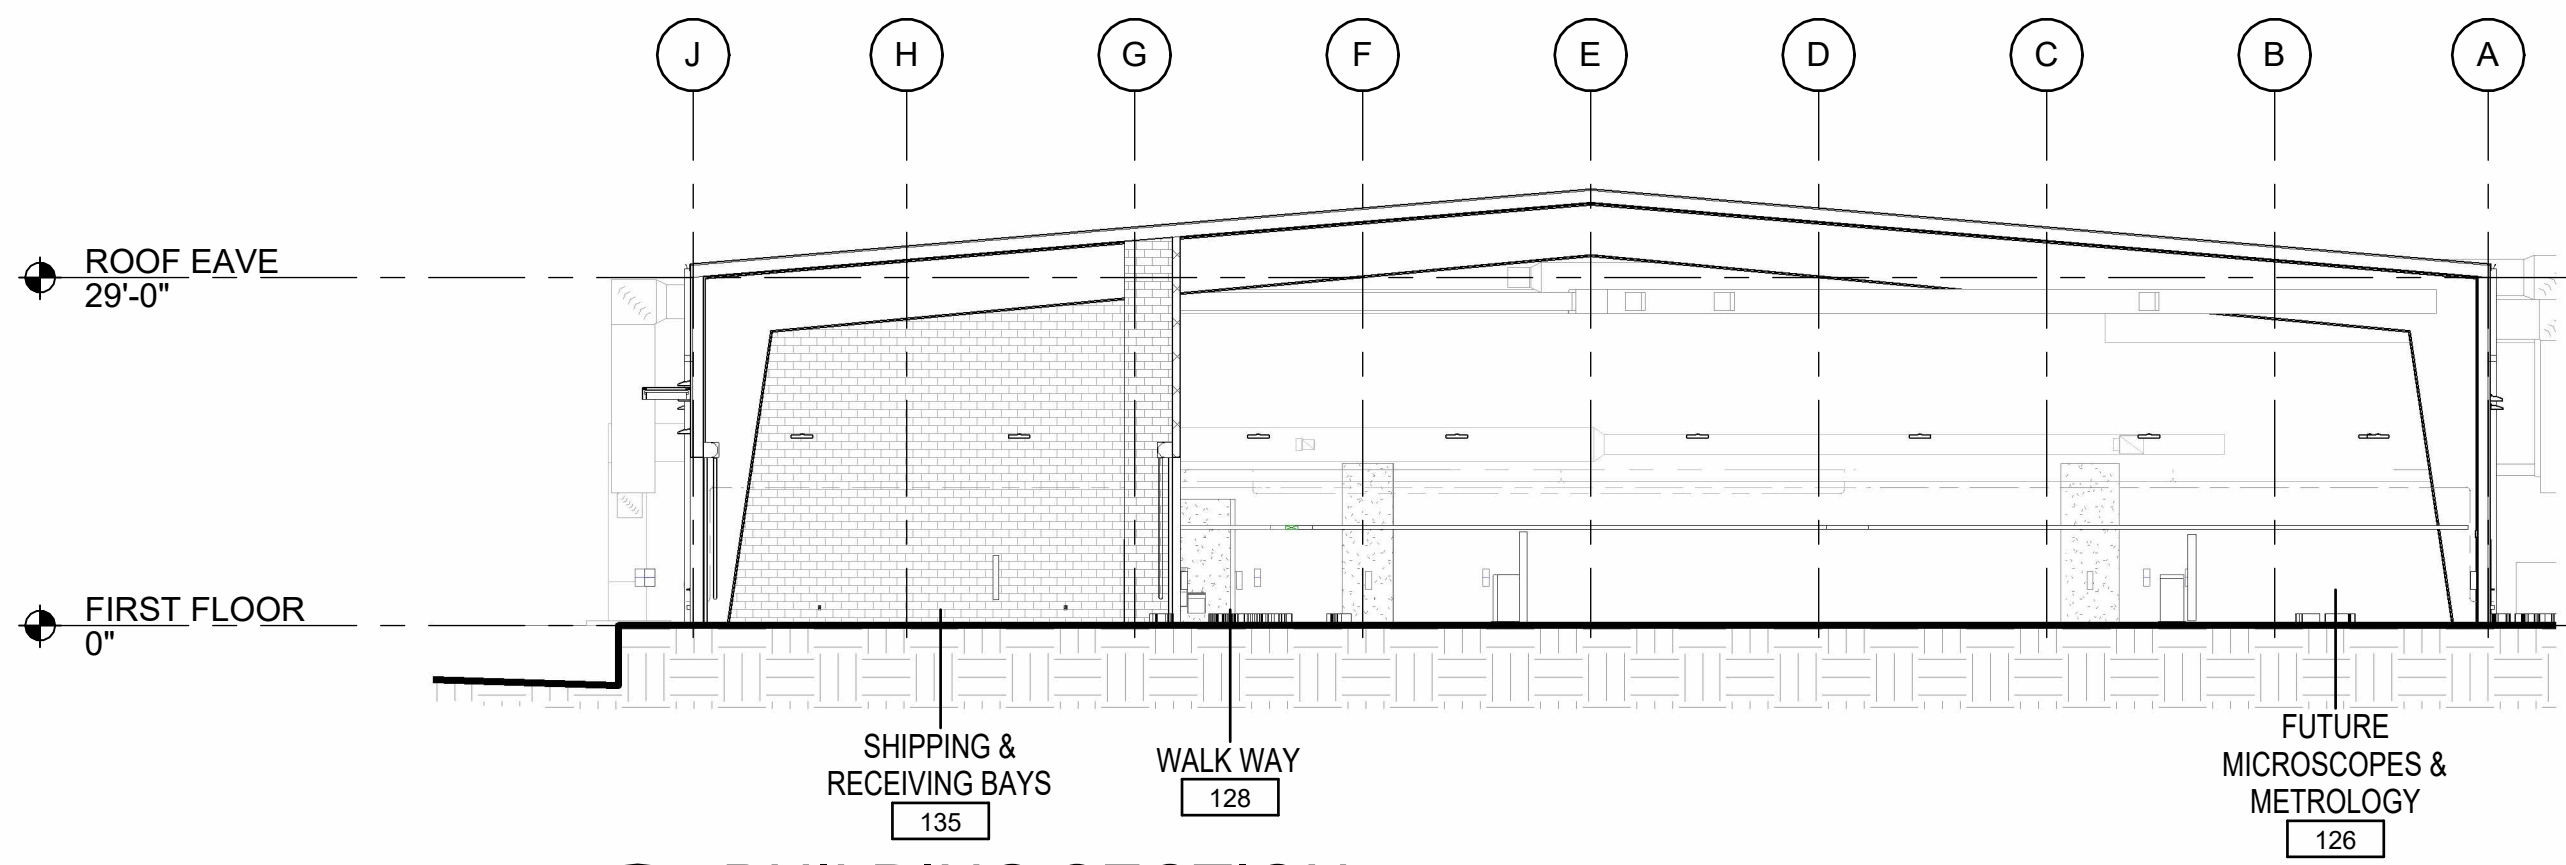


1 BUILDING SECTION
SCALE: 1/16" = 1'-0"

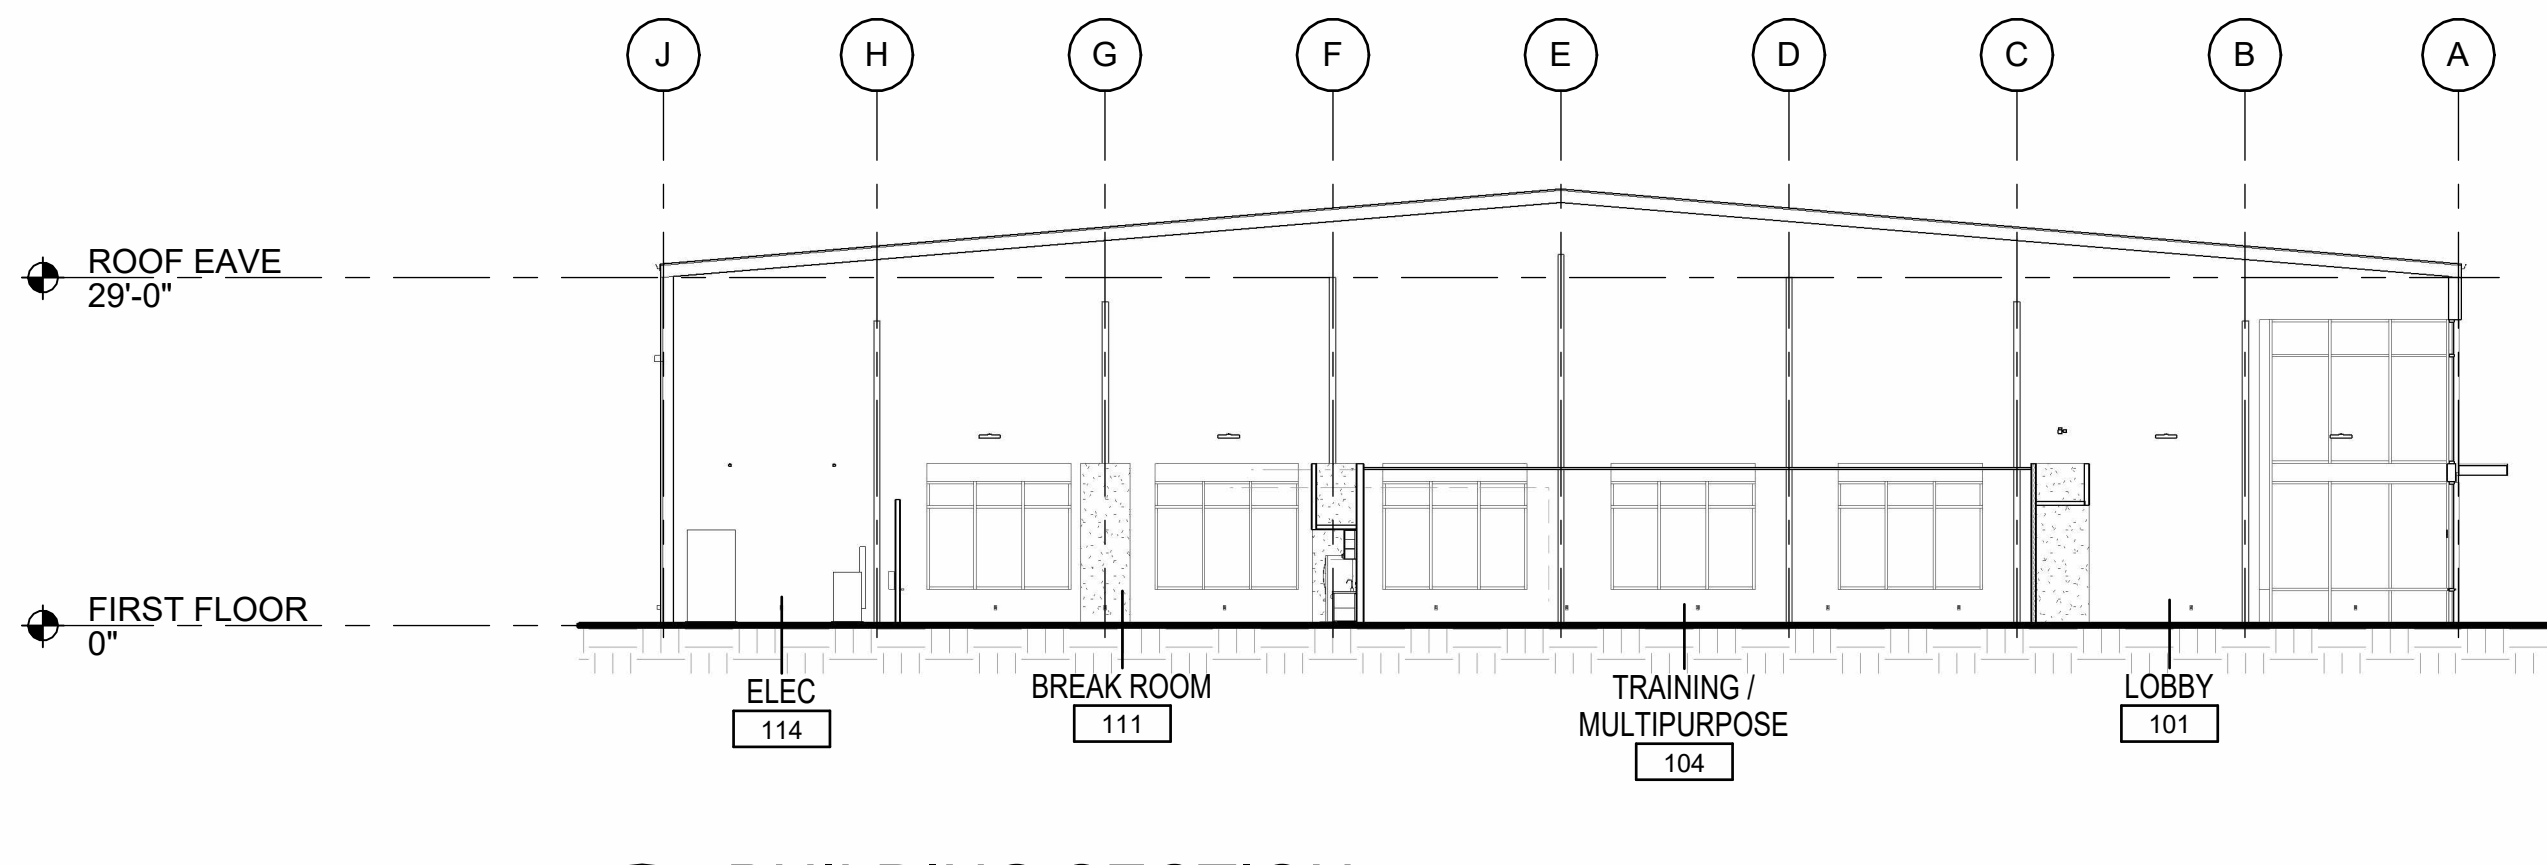


2 BUILDING SECTION
SCALE: 1/16" = 1'-0"

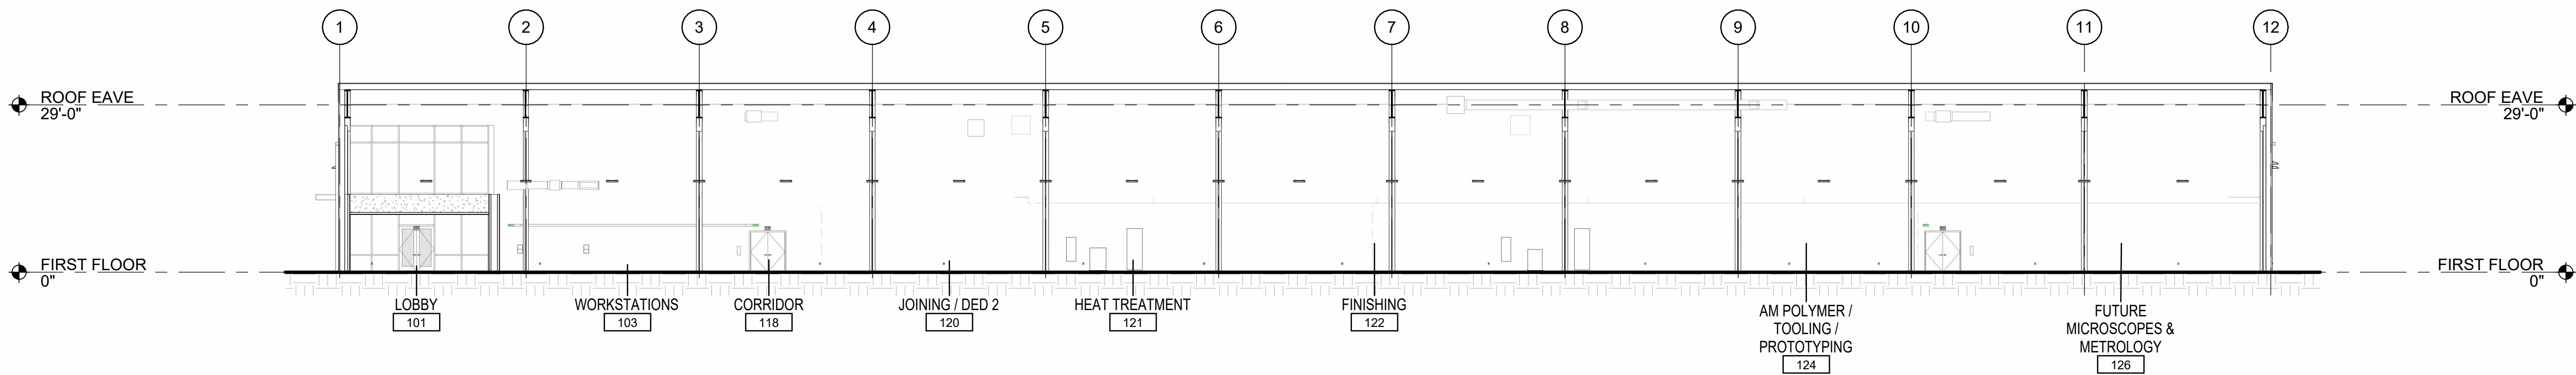

3 BUILDING SECTION
SCALE: 1/16" = 1'-0"

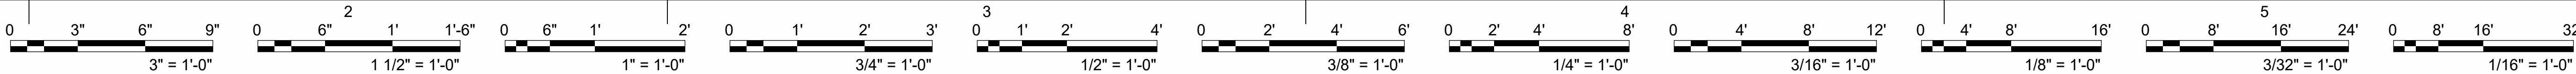

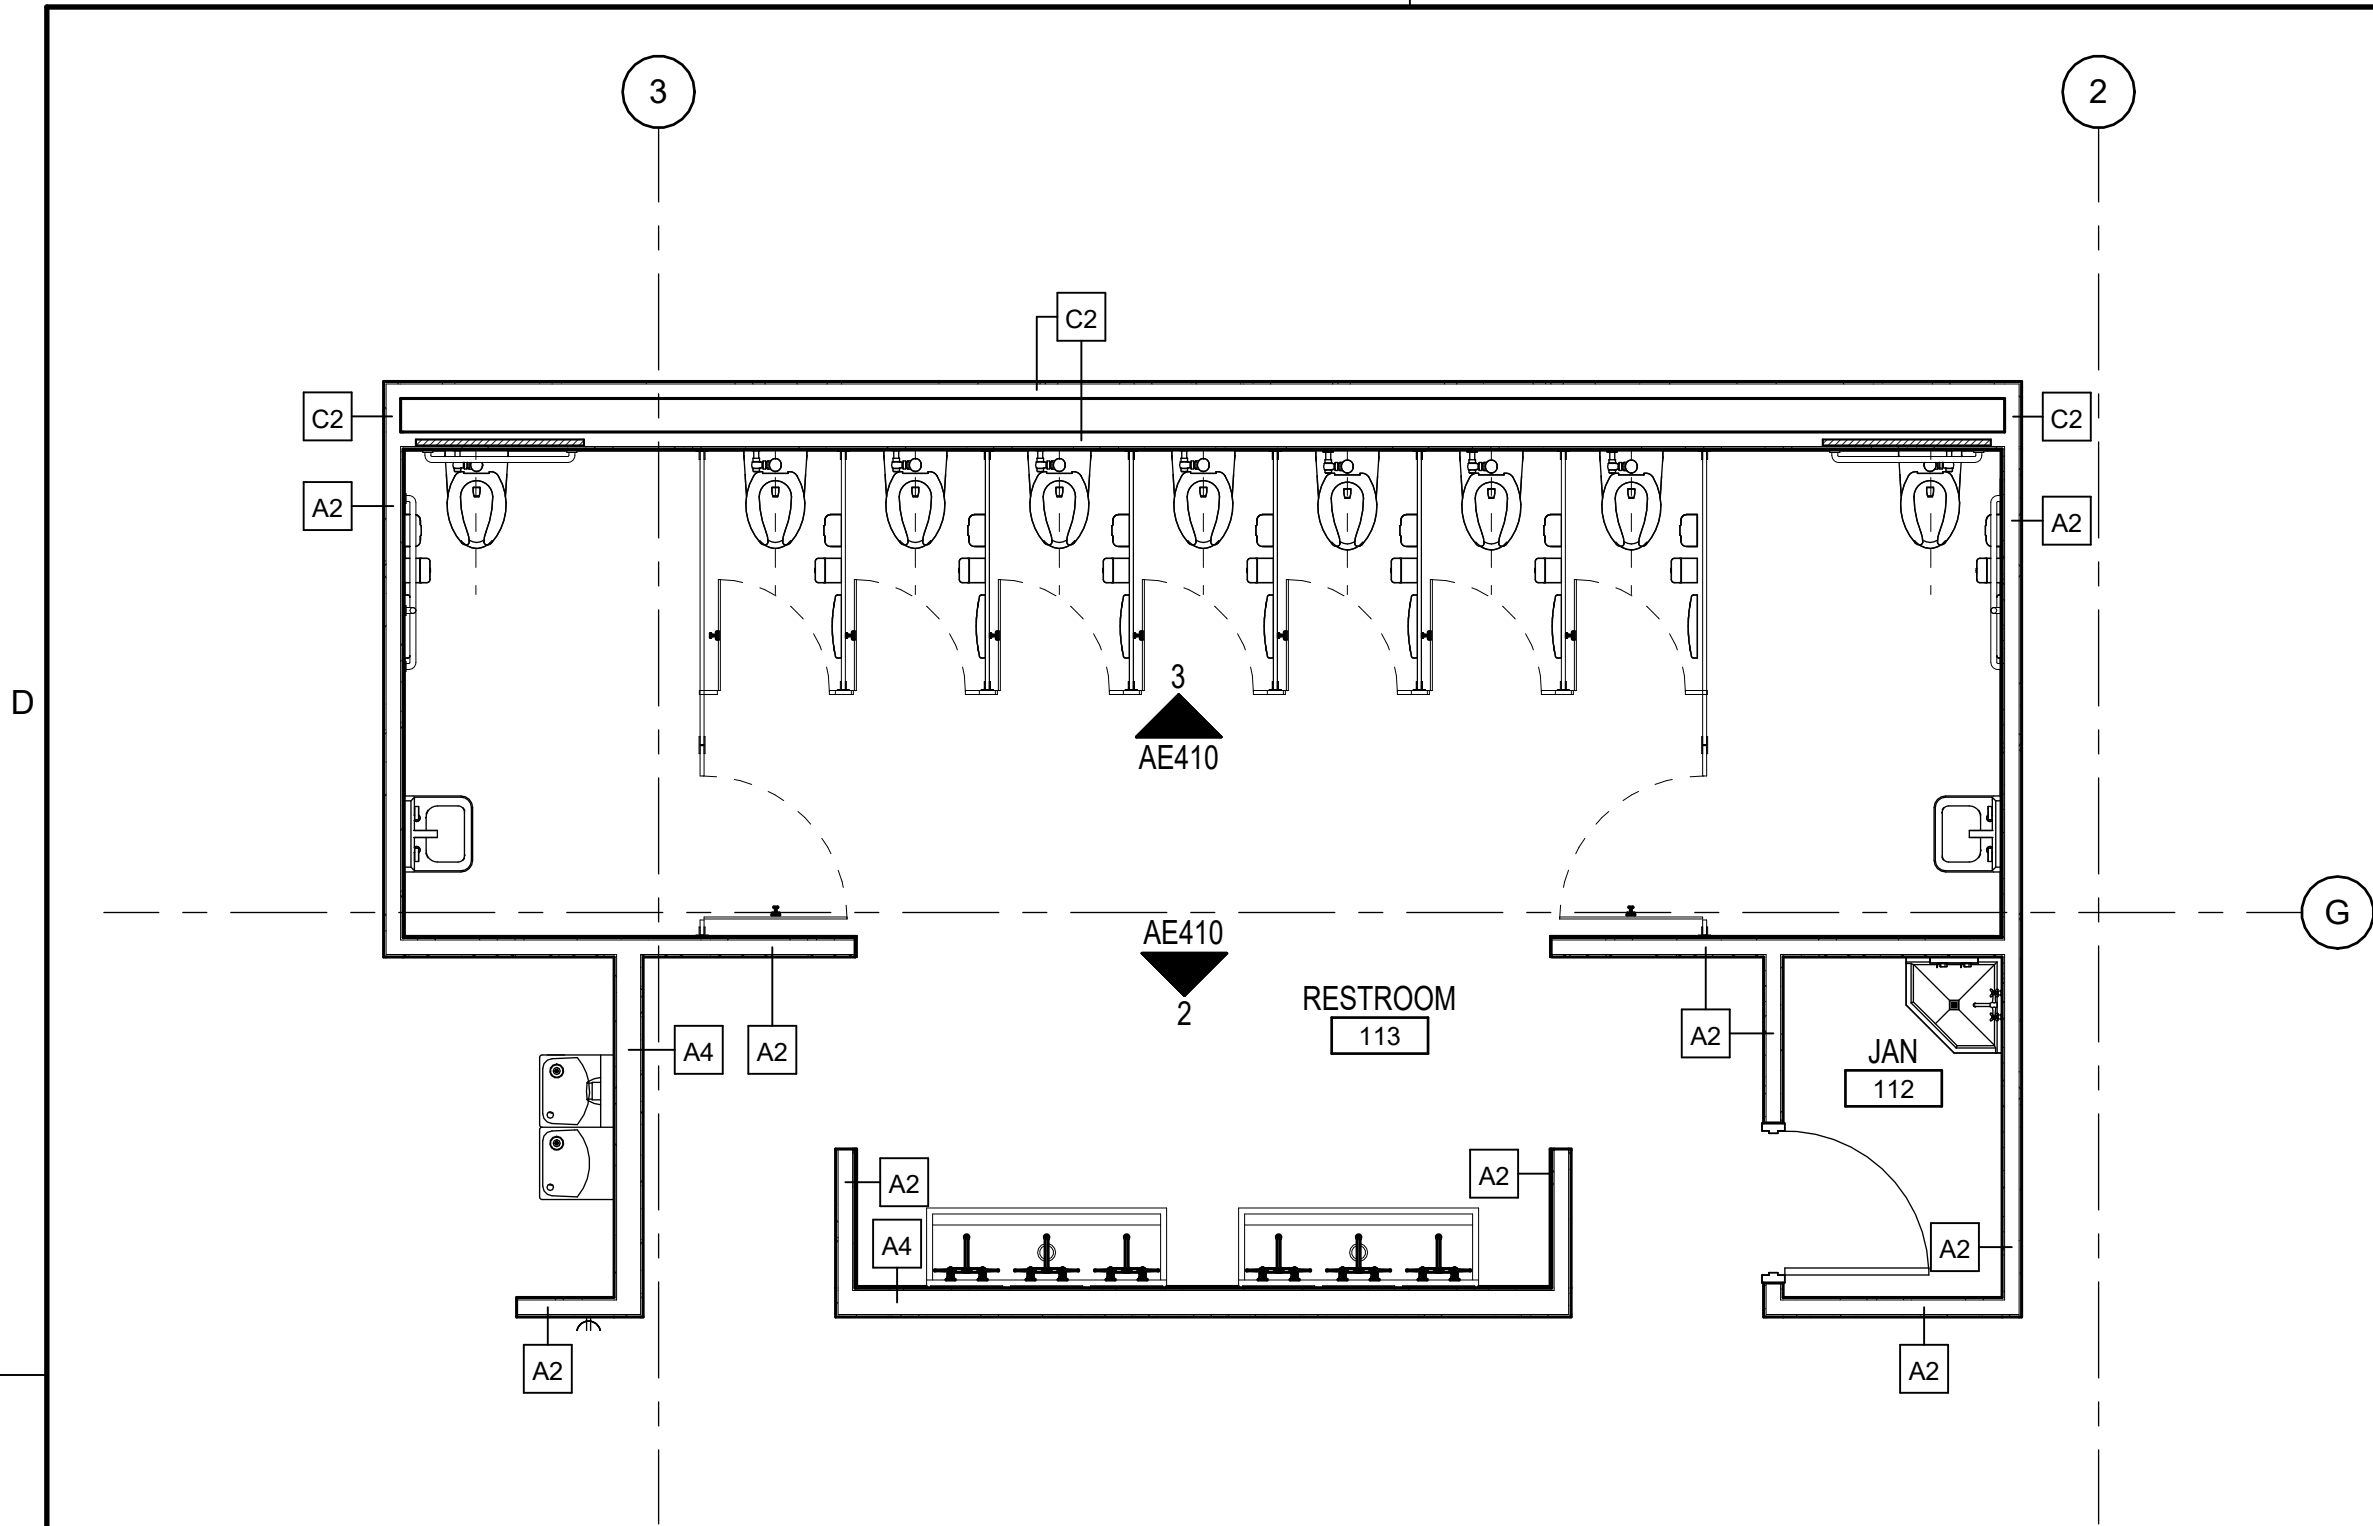

1 ENLARGED RESTROOM PLAN
SCALE: 1/4" = 1'-0"

GENERAL NOTES

ACCESSORIES SCHEDULE

MARK	DESCRIPTION
GB1	GRAB BAR - HORIZONTAL - 42"
GB2	GRAB BAR - VERTICAL - 18"
GB3	GRAB BAR - HORIZONTAL - 36"
HK1	HOOK
MH2	MOP AND BROOM HOLDER - 2 HOOK
MI4	MIRROR - 18"W X 36"H - FRAMELESS
SCD1	SEAT COVER DISPENSER
SND1	SANITARY NAPKIN DISPOSAL - SURFACE MOUNT
TPD1	TOILET PAPER DISPENSER - SURFACE MOUNT
TS13W	TOILET STALL- WOMENS
TS24W	TOILET STALL- WOMENS

Frankfurt-Short-Bruza Associates, P.C.
1999 Bryan St., Suite 900
Dallas, TX 75201-3136
405.840.2931 | fsb-ae.com
Engineering CoA - 36003 Exp. 12/31/2030
Architectural CoA - 36003 Exp. 2/28/2030

PRELIMINARY
THIS DOCUMENT IS
PRELIMINARY IN
NATURE AND IS NOT A
FINAL, SIGNED AND
SEALED DOCUMENT

FLORIDA STATE UNIVERSITY
FSU INSPIRE
PANAMA CITY, FLORIDA

MOUNTING HEIGHT SCHEDULE	
DESCRIPTION	MOUNTING HEIGHT
WATER CLOSET	15" AFF TO RIM
WATER CLOSET - ACCESSIBLE	17" AFF TO RIM
URINAL	24" AFF TO RIM
URINAL - ACCESSIBLE	17" AFF TO RIM
LAVATORY	34" AFF TO TOP
PAPER TOWEL DISPENSER	46" AFF TO BOTTOM/DISPENSER
SANITARY NAPKIN DISPOSAL	28" AFF TO TOP
TOILET PAPER DISPENSER	28" AFF TO TOP
TOILET SEAT COVER DISPENSER	28" AFF TO TOP
GRAB BAR	34.5" AFF TO CENTER
ROBE HOOK/TOWEL BAR	60" AFF TO TOP
ROBE HOOK/TOWEL BAR - ACCESSIBLE	48" AFF TO TOP
HAND DRYER	15" AFF TO BOTTOM
BABY CHANGING STATION	48" AFF TO TOP
COAT HOOK - ACCESSIBLE	48" AFF TO TOP
COAT HOOK	60" AFF TO TOP
**NOTE: ALL TOILET ACCESSORIES LISTED ABOVE MAY NOT BE IN CONTRACT	

REVISION HISTORY

NO.	DESCRIPTION	DATE

PROJECT INFORMATION

DESIGNED BY:	KLS	REVIEWED BY:	AM
DRAWN BY:	KLS	PROJECT MANAGER:	LL

PROJECT NUMBER

FSB2026-176-00

SHEET TITLE:


ENLARGED PLANS

ISSUE DATE

AUGUST 6, 2026

SHEET NUMBER

AE401

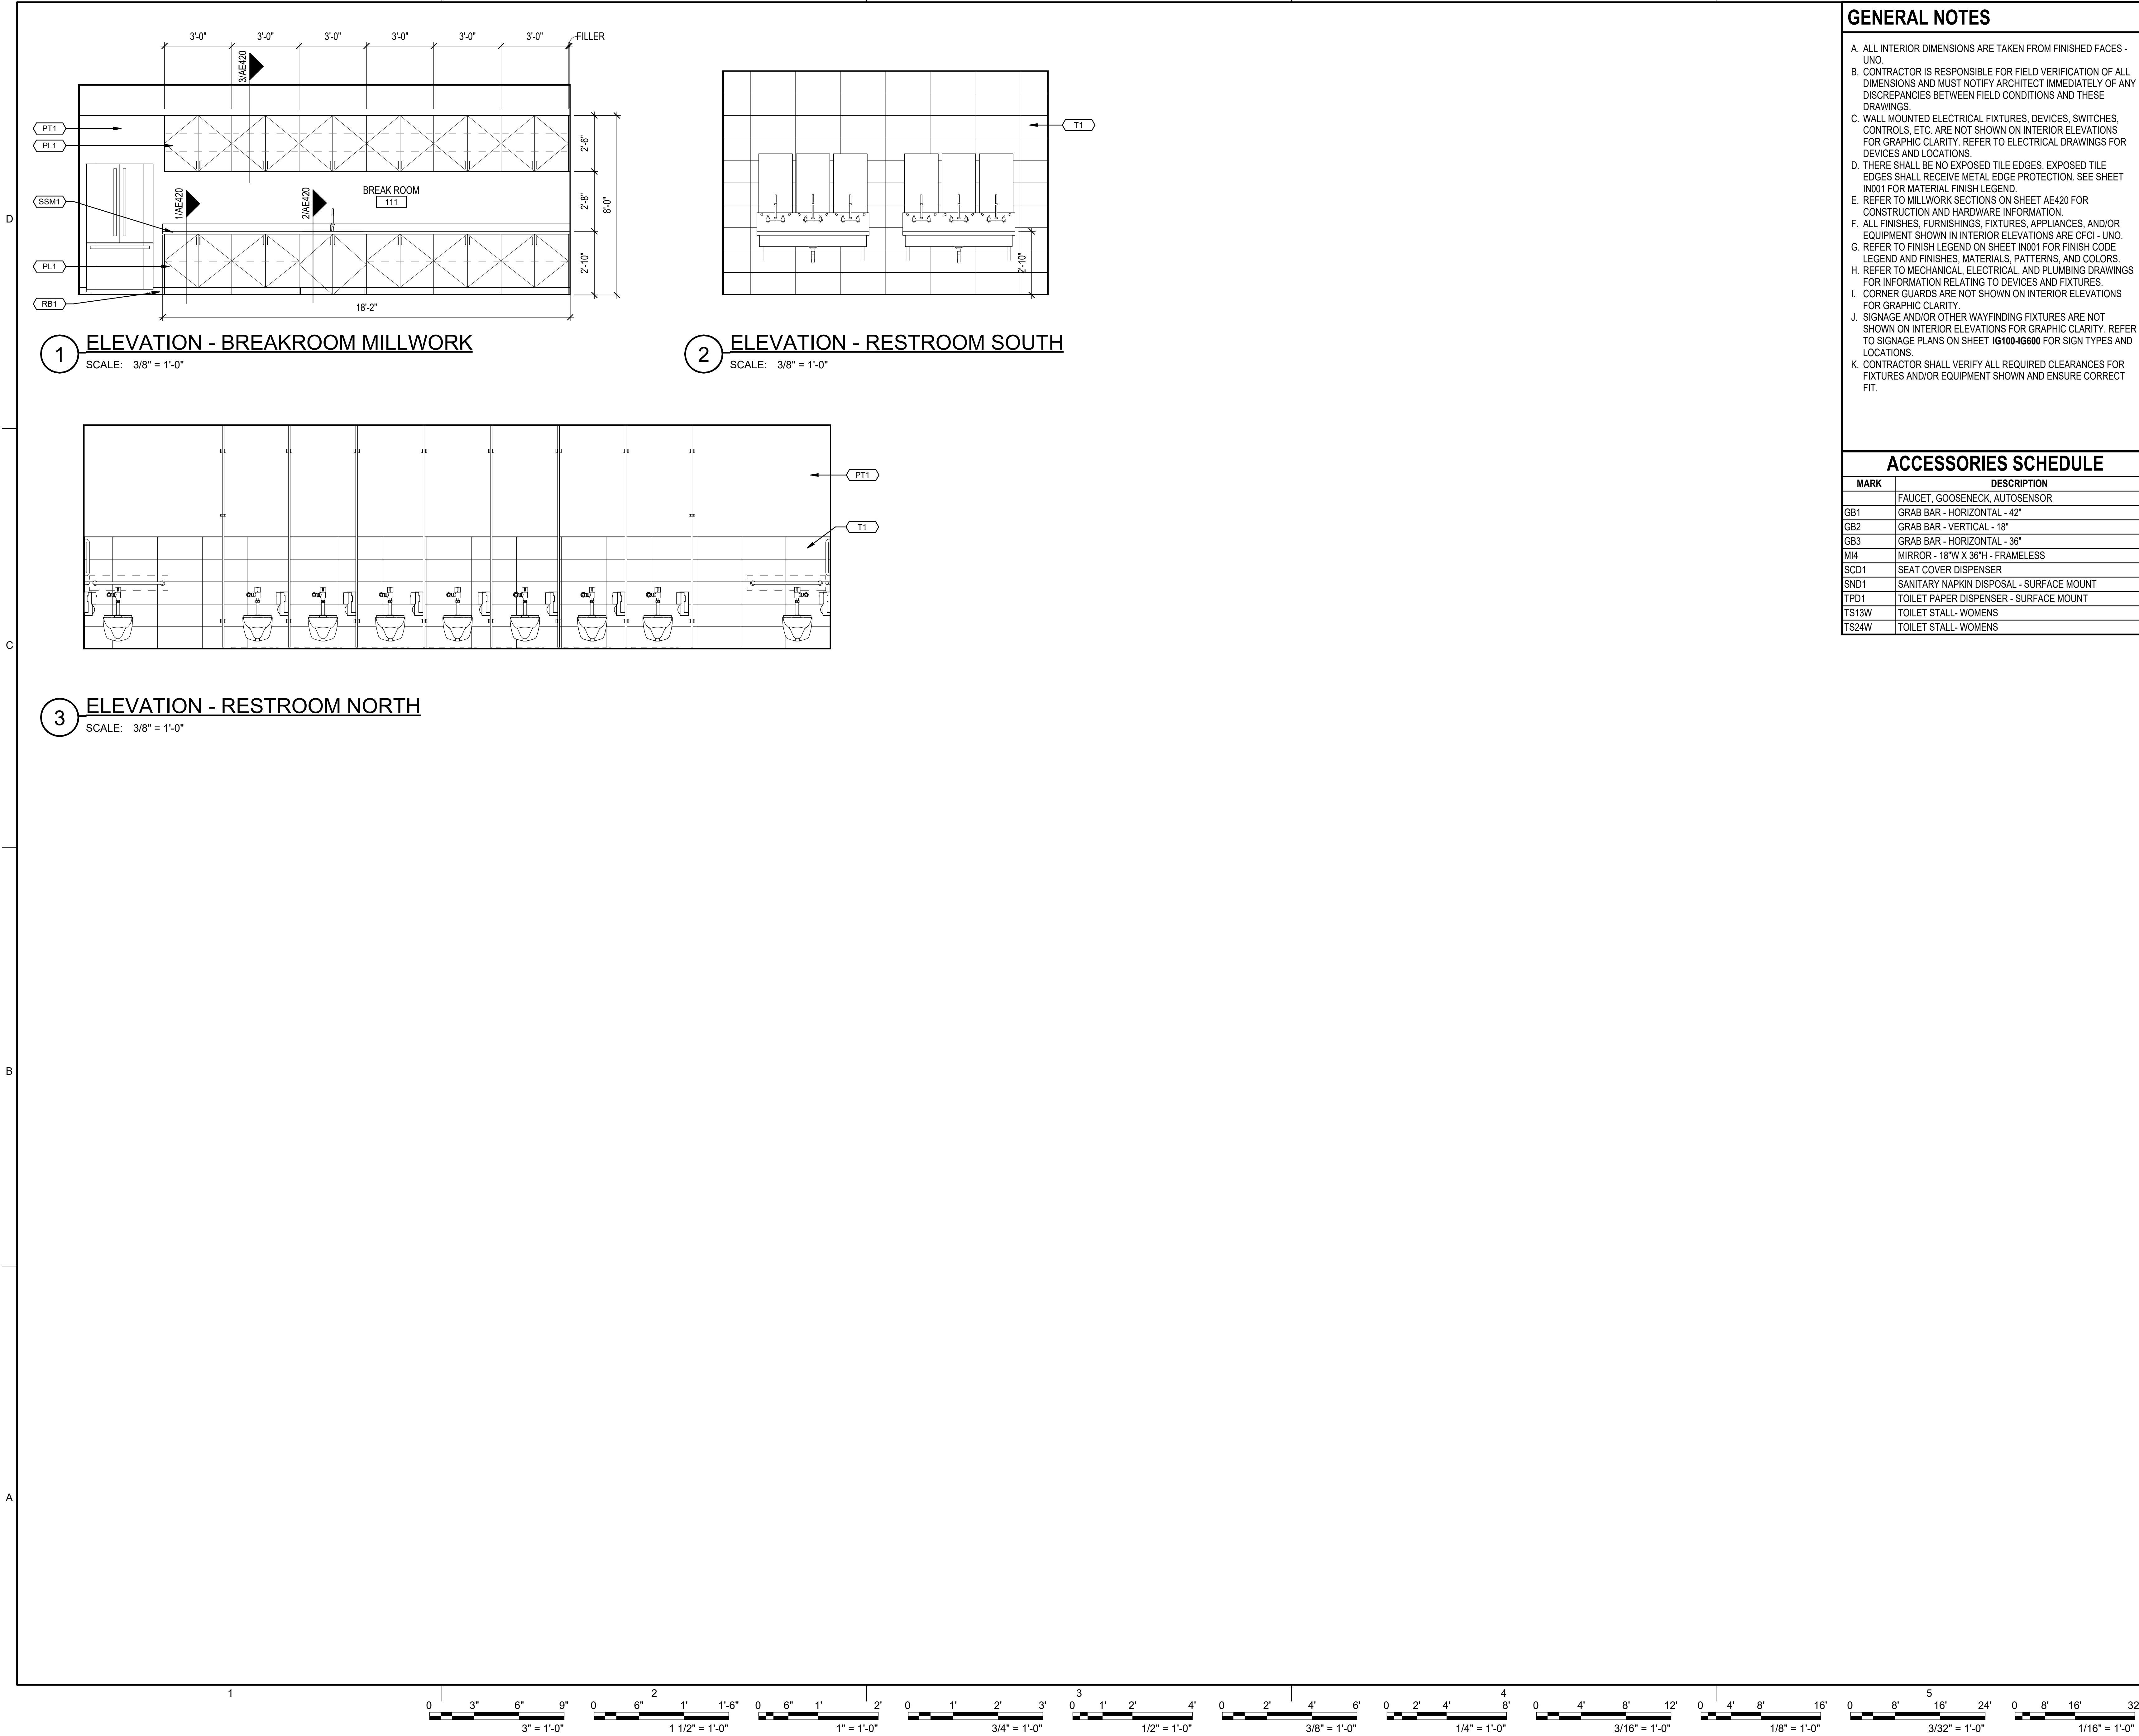

GENERAL NOTES

A. ALL INTERIOR DIMENSIONS ARE TAKEN FROM FINISHED FACES - UNO.

B. CONTRACTOR IS RESPONSIBLE FOR FIELD VERIFICATION OF ALL DIMENSIONS AND MUST NOTIFY ARCHITECT IMMEDIATELY OF ANY DISCREPANCIES BETWEEN FIELD CONDITIONS AND THESE DRAWINGS.

C. WALL MOUNTED ELECTRICAL FIXTURES, DEVICES, SWITCHES, CONTROLS, ETC. ARE NOT SHOWN ON INTERIOR ELEVATIONS FOR GRAPHIC CLARITY. REFER TO ELECTRICAL DRAWINGS FOR DEVICES AND LOCATIONS.

D. THERE SHALL BE NO EXPOSED TILE EDGES. EXPOSED TILE EDGES SHALL RECEIVE METAL EDGE PROTECTION. SEE SHEET IN001 FOR MATERIAL FINISH LEGEND.

E. REFER TO MILLWORK SECTIONS ON SHEET AE420 FOR CONSTRUCTION AND HARDWARE INFORMATION.

F. ALL FINISHES, FURNISHINGS, FIXTURES, APPLIANCES, AND/OR EQUIPMENT SHOWN IN INTERIOR ELEVATIONS ARE CFCI - UNO.

G. REFER TO FINISH LEGEND ON SHEET IN001 FOR FINISH CODE LEGEND AND FINISHES, MATERIALS, PATTERNS, AND COLORS.

H. REFER TO MECHANICAL, ELECTRICAL, AND PLUMBING DRAWINGS FOR INFORMATION RELATING TO DEVICES AND FIXTURES.

I. CORNER GUARDS ARE NOT SHOWN ON INTERIOR ELEVATIONS FOR GRAPHIC CLARITY.

J. SIGNAGE AND/OR OTHER WAYFINDING FIXTURES ARE NOT SHOWN ON INTERIOR ELEVATIONS FOR GRAPHIC CLARITY. REFER TO SIGNAGE PLANS ON SHEET **IG100-IG600** FOR SIGN TYPES AND LOCATIONS.

K. CONTRACTOR SHALL VERIFY ALL REQUIRED CLEARANCES FOR FIXTURES AND/OR EQUIPMENT SHOWN AND ENSURE CORRECT FIT.

ACCESSORIES SCHEDULE

MARK	DESCRIPTION
	FAUCET, GOOSENECK, AUTOSENSOR
GB1	GRAB BAR - HORIZONTAL - 42"
GB2	GRAB BAR - VERTICAL - 18"
GB3	GRAB BAR - HORIZONTAL - 36"
MI4	MIRROR - 18"W X 36"H - FRAMELESS
SCD1	SEAT COVER DISPENSER
SND1	SANITARY NAPKIN DISPOSAL - SURFACE MOUNT
TPD1	TOILET PAPER DISPENSER - SURFACE MOUNT
TS13W	TOILET STALL- WOMENS
TS24W	TOILET STALL- WOMENS



Frankfurt-Short-Bruza Associates, P.C.
1999 Bryan St., Suite 900
Dallas, TX 75201-3136
405.840.2931 | fsb-ae.com

Engineering CoA - 36003 Exp. 12/31/2030
Architectural CoA - 36003 Exp. 2/28/2030

PRELIMINARY

THIS DOCUMENT IS
PRELIMINARY IN
NATURE AND IS NOT A
FINAL, SIGNED AND
SEALED DOCUMENT

FLORIDA STATE UNIVERSITY

FSU INSPIRE

PANAMA CITY, FLORIDA

REVISION HISTORY

NO.	DESCRIPTION	DATE

PROJECT INFORMATION

DESIGNED BY:	KLS	REVIEWED BY:	AM
DRAWN BY:	KLS	PROJECT MANAGER:	LL

PROJECT NUMBER

FSB2026-176-00

SHEET TITLE:


INTERIOR ELEVATIONS

ISSUE DATE

AUGUST 6, 2026

SHEET NUMBER

AE410

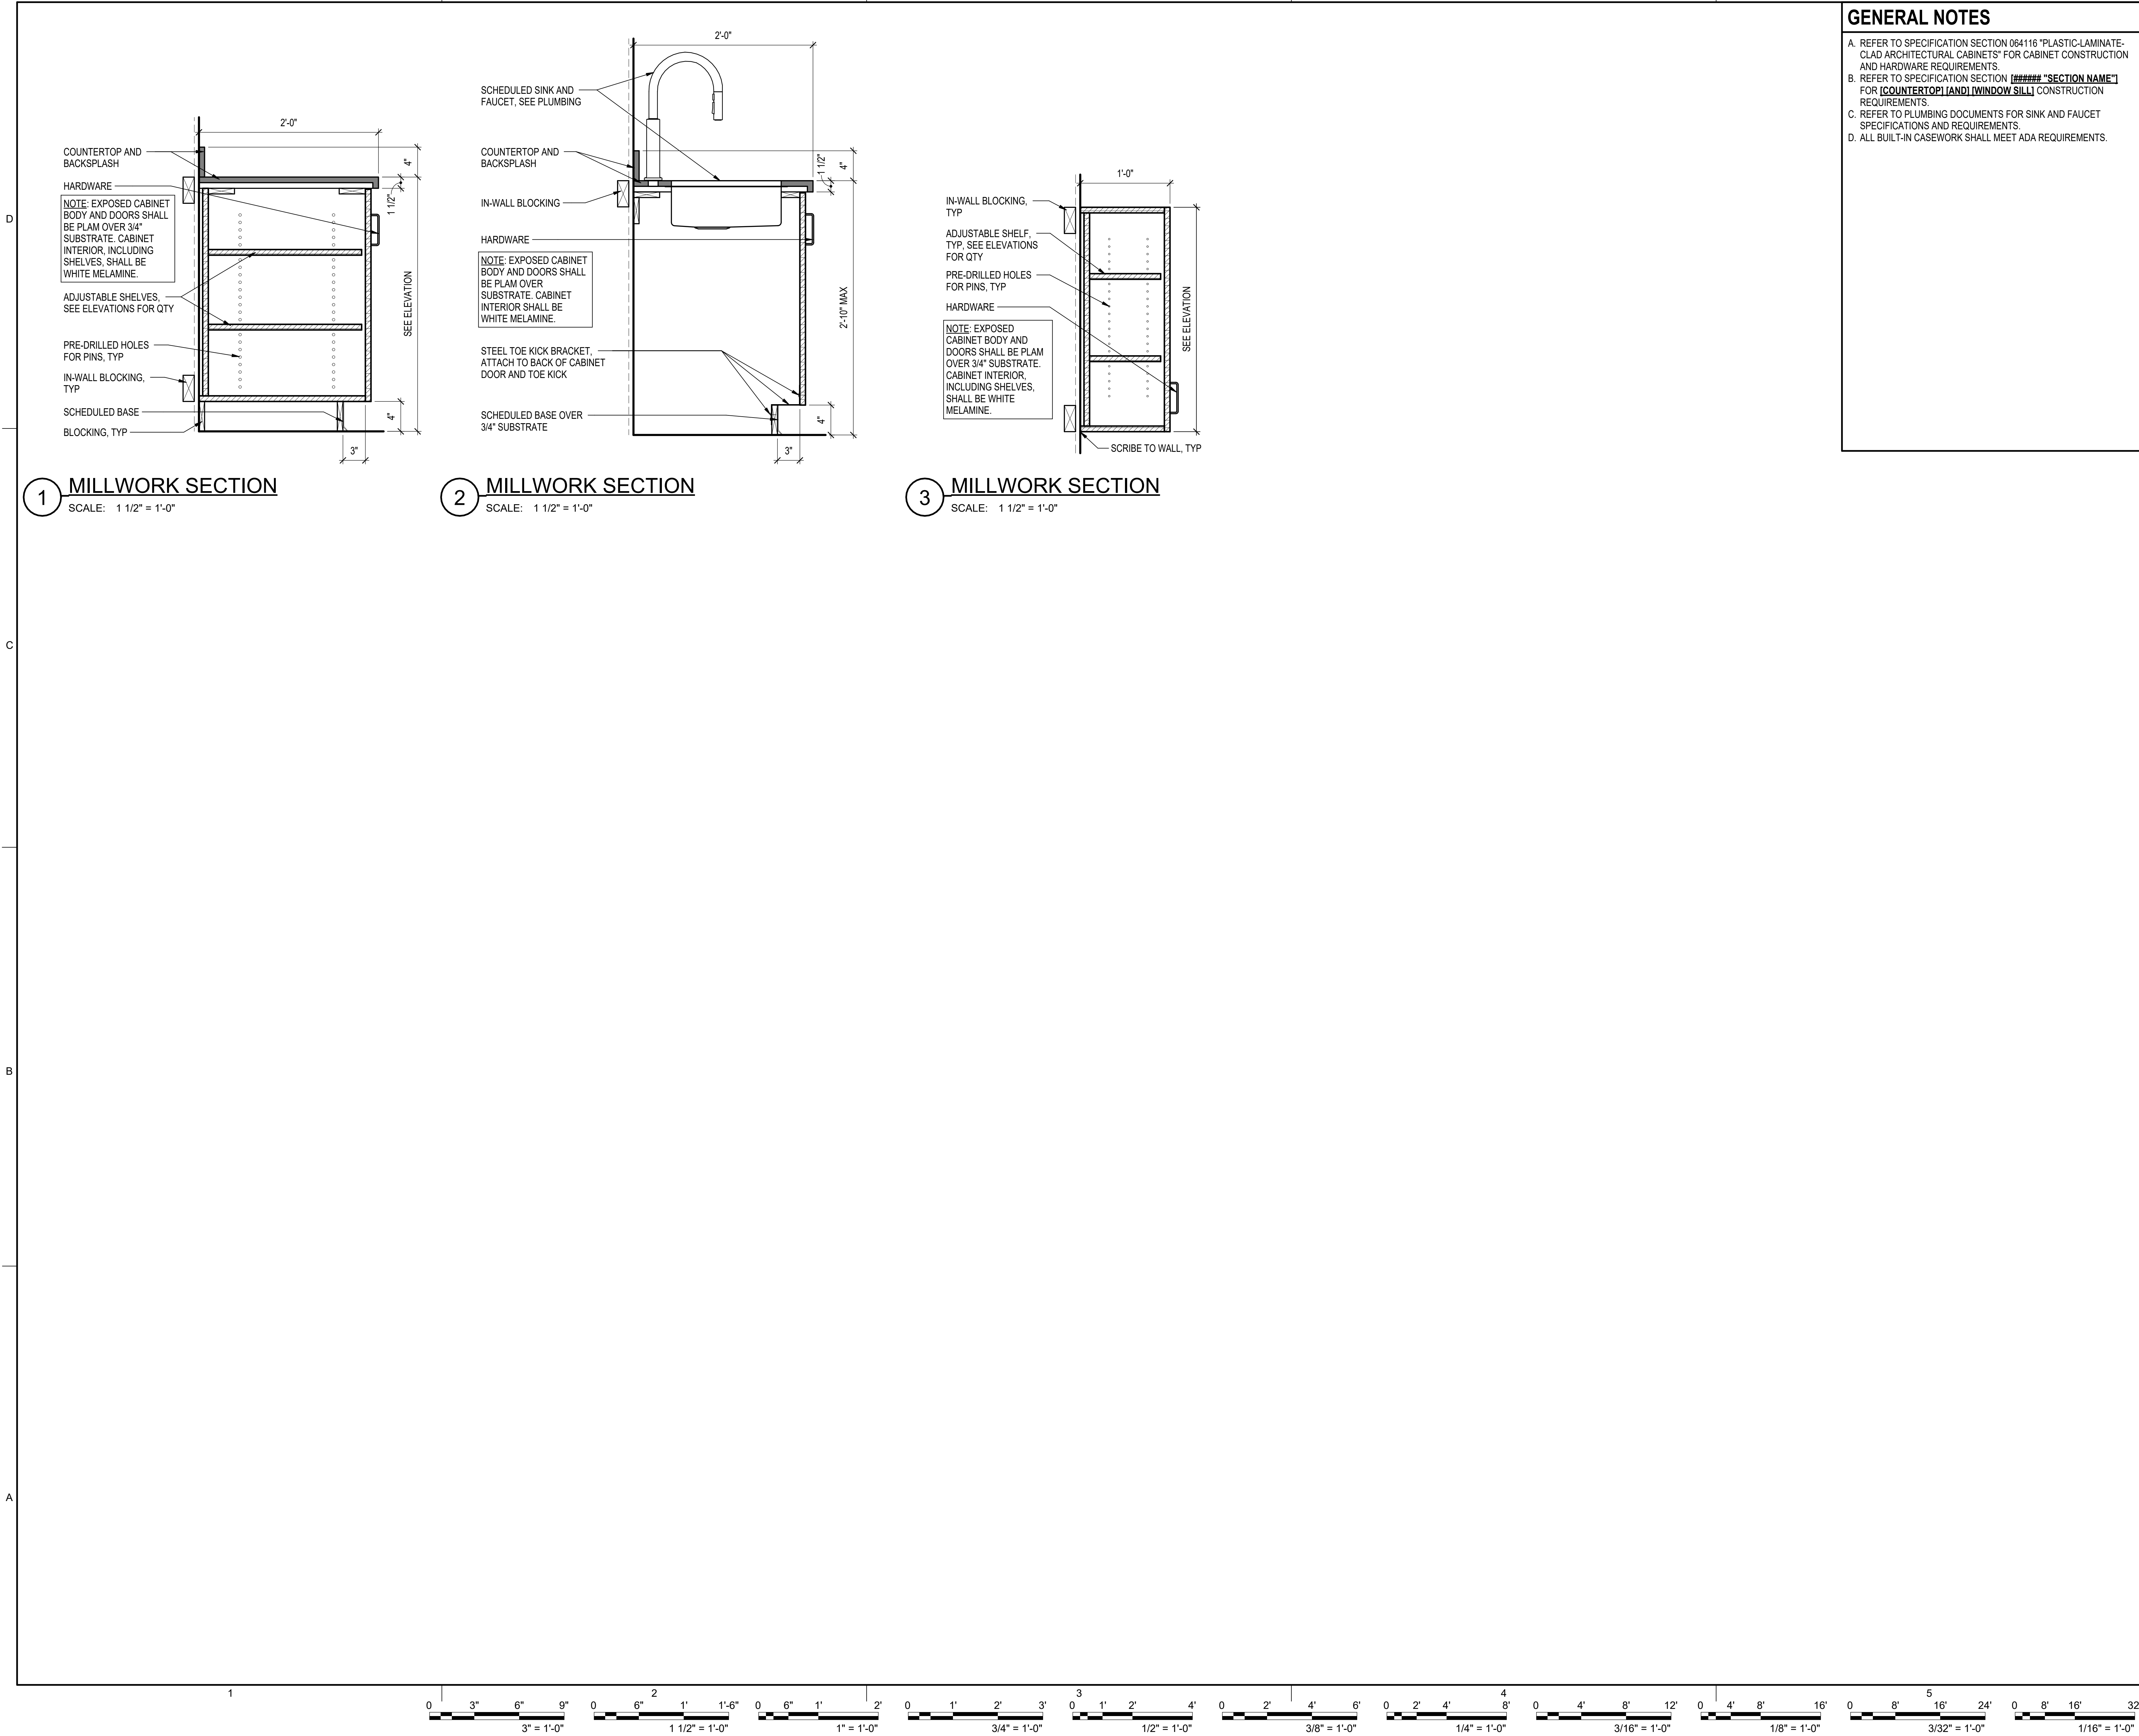



Frankfurt-Short-Bruza Associates, P.C.
1999 Bryan St., Suite 900
Dallas, TX 75201-3136
405.840.2931 | fsb-ae.com
Engineering CoA - 36003 Exp. 12/31/2030
Architectural CoA - 36003 Exp. 2/28/2030

PRELIMINARY


THIS DOCUMENT IS
PRELIMINARY IN
NATURE AND IS NOT A
FINAL, SIGNED AND
SEALED DOCUMENT

FLORIDA STATE UNIVERSITY
FSU INSPIRE
PANAMA CITY, FLORIDA

REVISION HISTORY	
Δ	DESCRIPTION

PROJECT INFORMATION	
DESIGNED BY:	REVIEWED BY:
KLS	AM
DRAWN BY:	PROJECT MANAGER:
KLS	LL
PROJECT NUMBER	
FSB2026-176-00	
SHEET TITLE:	
MILLWORK SECTIONS	
ISSUE DATE	
AUGUST 6, 2026	
SHEET NUMBER	
AE420	

50% CONSTRUCTION DOCUMENTS

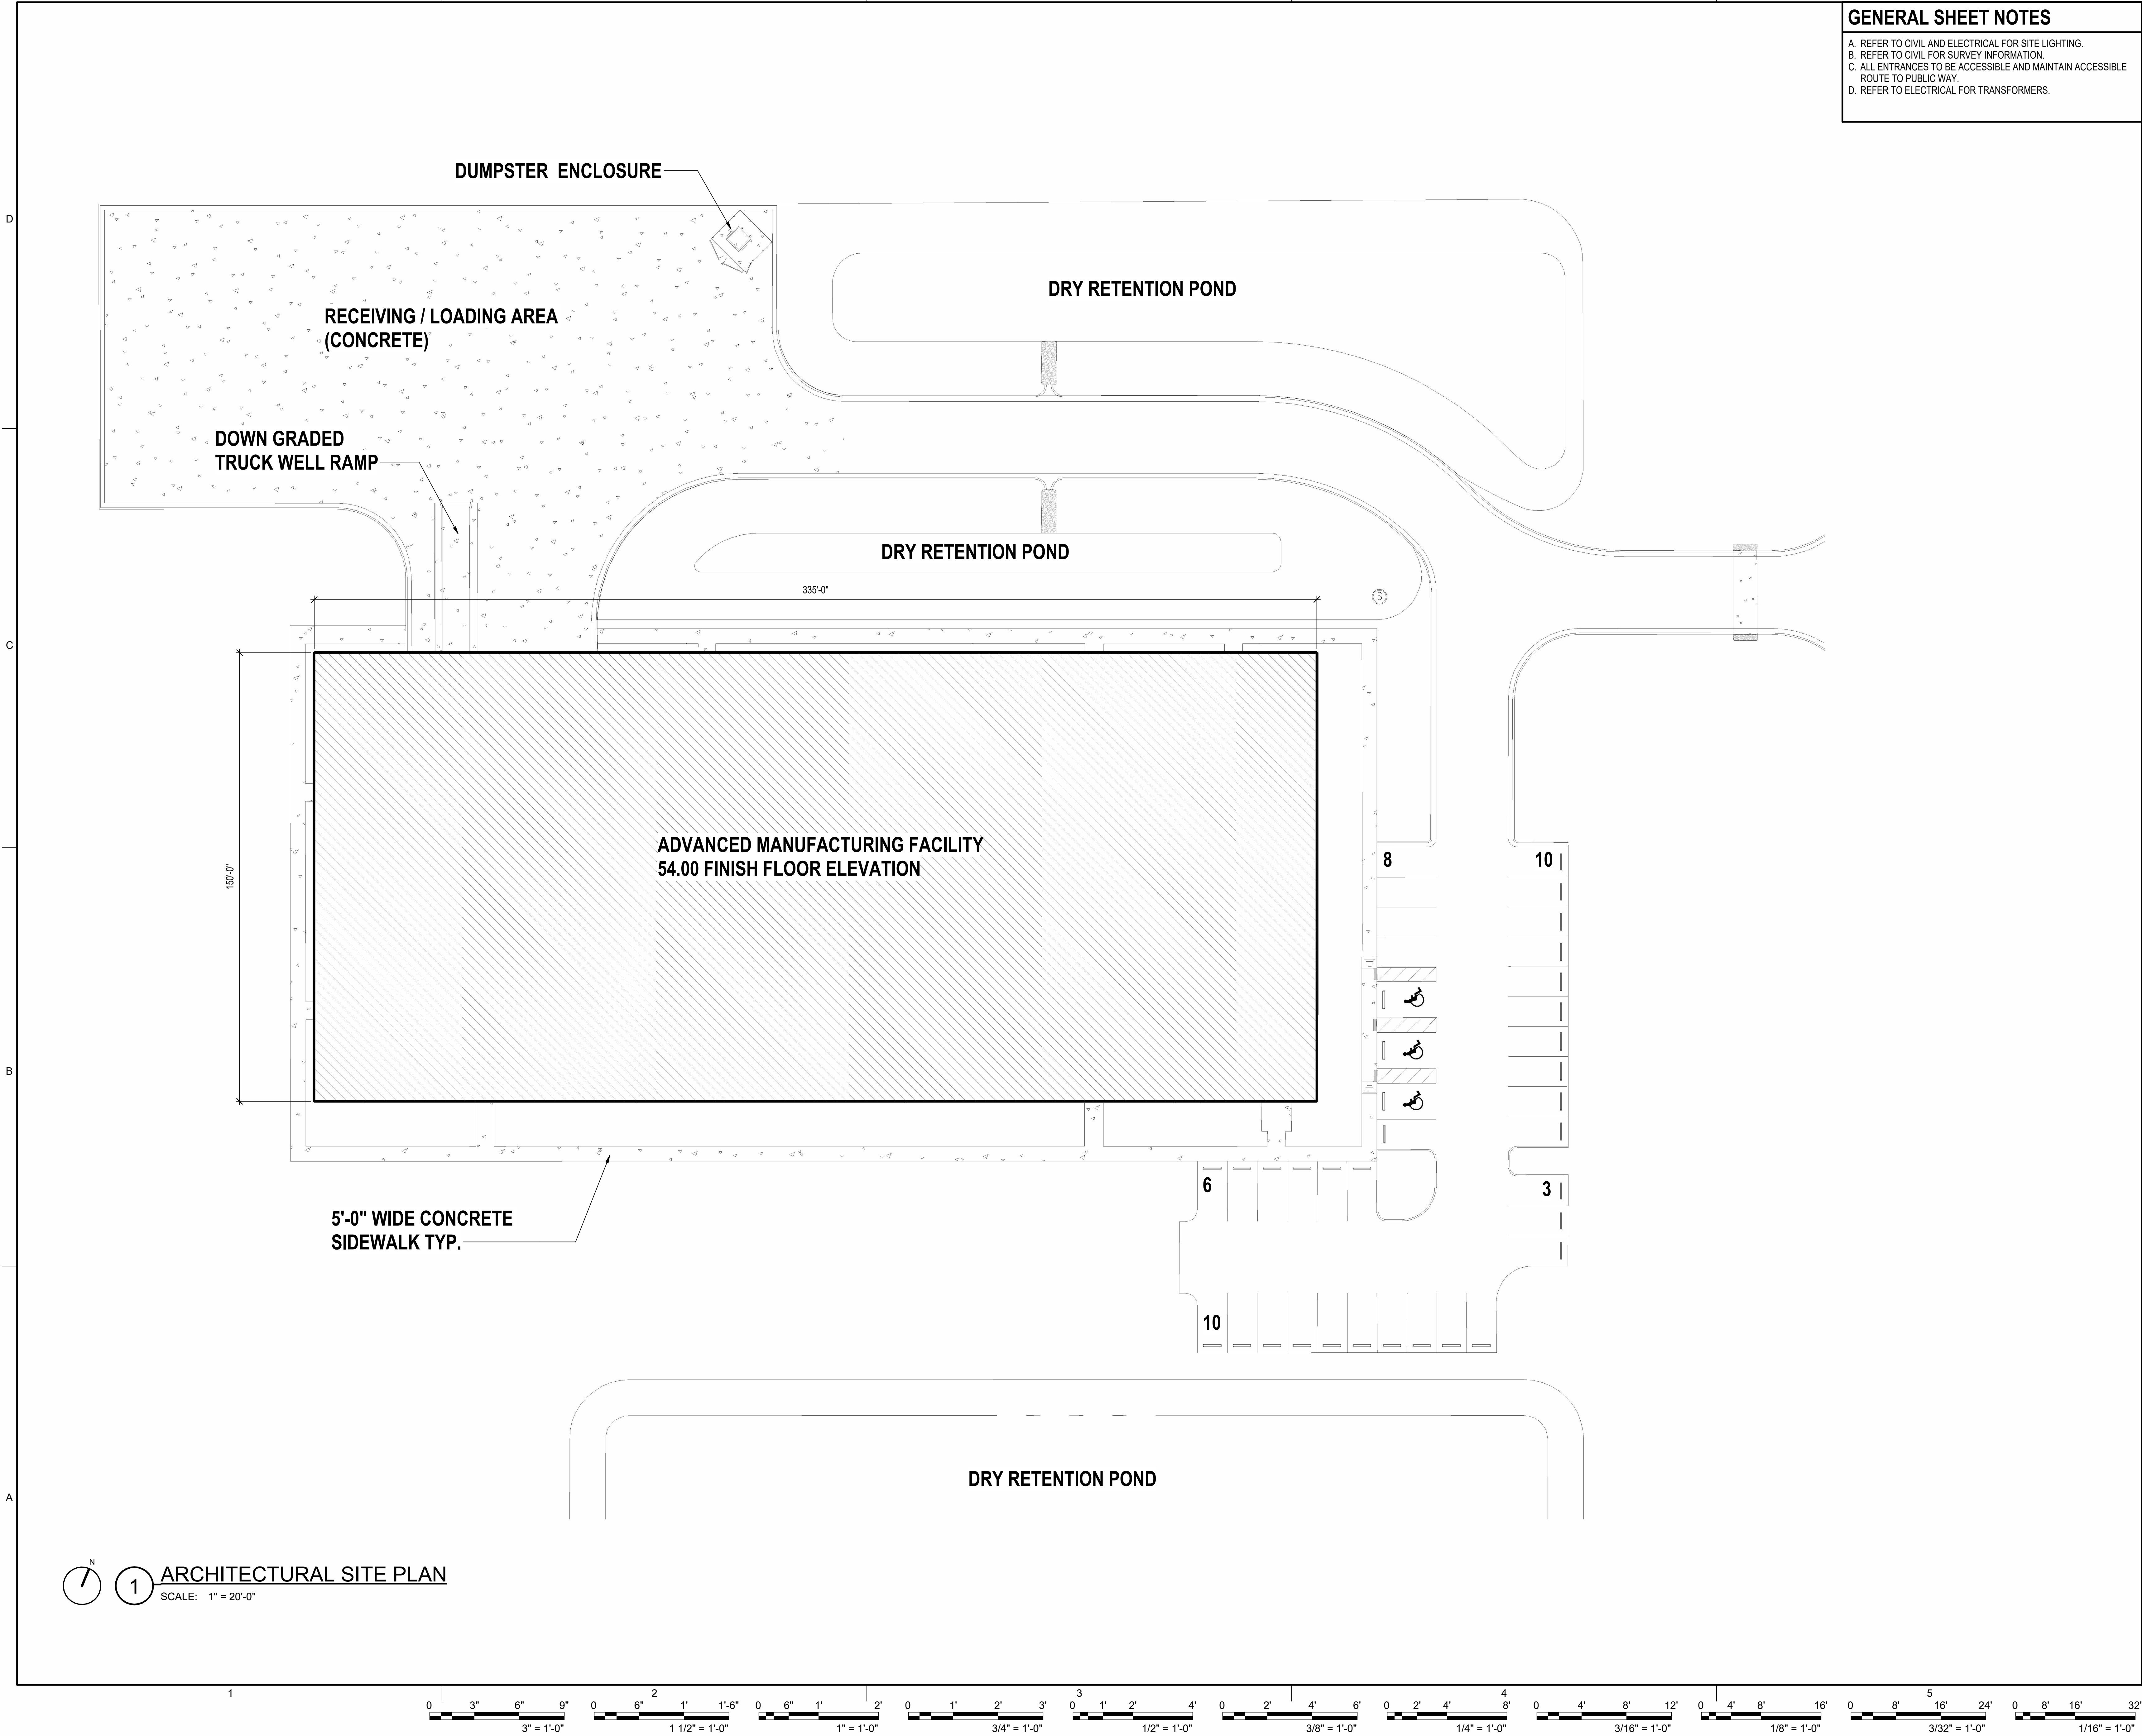

GENERAL SHEET NOTES

- A. REFER TO CIVIL AND ELECTRICAL FOR SITE LIGHTING.
- B. REFER TO CIVIL FOR SURVEY INFORMATION.
- C. ALL ENTRANCES TO BE ACCESSIBLE AND MAINTAIN ACCESSIBLE ROUTE TO PUBLIC WAY.
- D. REFER TO ELECTRICAL FOR TRANSFORMERS.



Frankfurt-Short-Bruza Associates, P.C.
1999 Bryan St., Suite 900
Dallas, TX 75201-3136
405.840.2931 | fsb-ae.com
Engineering CoA - 36003 Exp. 12/31/2030
Architectural CoA - 36003 Exp. 2/28/2030

PRELIMINARY

THIS DOCUMENT IS
PRELIMINARY IN
NATURE AND IS NOT A
FINAL, SIGNED AND
SEALED DOCUMENT

FLORIDA STATE UNIVERSITY
FSU INSPIRE
PANAMA CITY, FLORIDA

REVISION HISTORY

Δ	DESCRIPTION	DATE

PROJECT INFORMATION

DESIGNED BY:	SM	REVIEWED BY:	AM
DRAWN BY:	SM	PROJECT MANAGER:	LL

PROJECT NUMBER

FSB2026-176-00

SHEET TITLE:

ARCHITECTURAL SITE PLAN

ISSUE DATE

AUGUST 6, 2026

SHEET NUMBER

AS100