

PLUMBING LEGEND

SYSTEM ABBREVIATIONS	
—CA—	COMPRESSED AIR
-----	DOMESTIC COLD WATER
-----	DOMESTIC HOT WATER
-----	DOMESTIC HOT WATER RETURN
—D—	DRAIN
—G—	NATURAL GAS
—NPW—	NON-POTABLE WATER
—PG—	PROPANE GAS
—LPG—	PROPANE LIQUID
—SS—	SANITARY
—GW—	SANITARY - GREASE (ABOVE FLOOR)
—GW---	SANITARY - GREASE (BELOW FLOOR OR GRADE)
— V -	SANITARY - VENT
—SD—	STORM DRAIN
—OD—	STORM DRAIN OVERTFLOW

	EXISTING TO REMAIN
	DEMOLISHED IN CURRENT PHASE
	NEW IN CURRENT PHASE
	CONNECT TO EXISTING
	EXTENT OF DEMOLITION (DEMOLISH BETWEEN / BEYOND)

∠	ANGLE
°	DEGREE
∅	DIAMETER
φ	PHASE
Ø	ROUND
%	PERCENT


	ELBOW, 90°
	ELBOW DWV
	ELBOW, RISER DOWN
	ELBOW, RISER UP
	ELBOW, RISE OR DROP
	ELBOW, 45° RISER OR DROP
	TEE UP
	TEE DOWN
	TEE TOP CONNECTION
	TEE BOTTOM CONNECTION
	TEE SIDE CONNECTION
	CROSS
	CROSS DWV
	DIRECTION OF FLOW
	CENTRIC REDUCER
	ECCENTRIC REDUCER
	UNION
	BLIND FLANGE
	PIPE CAP
	FLEXIBLE CONNECTOR
	EXPANSION JOINT
	ANCHOR
	PIPE SLEEVE THROUGH WALL
	BALL VALVE
	BUTTERFLY VALVE
	CALIBRATED MANUAL BALANCING VALVE
	CHECK VALVE
	GATE VALVE
	GLOBE VALVE
	PLUG VALVE
	NEEDLE VALVE
	AUTOMATIC FLOW LIMITING VALVE
	SOLENOID VALVE
	ANGLE PATTERN GATE VALVE
	RELIEF VALVE
	PILOT-OPERATED PRESSURE REGULATOR
	SELF-CONTAINED PRESSURE REGULATOR
	WYE STRAINER
	DOUBLE CHECK BACK FLOW PREVENTER
	REDUCED PRESSURE BACKFLOW PREVENTER W/STRAINER
	AUTOMATIC CONDENSATE DRAIN, COMPRESSED AIR
	PUMP
	PRESSURE GAUGE (WITH GAUGE COCK)
	THERMOMETER
	THERMOWELL
	CLEANOUT - FLOOR
	CLEANOUT - WALL
	CLEANOUT - PIPE
	WATER HAMMER ARRESTOR
	HOSE BIBB
	WALL HYDRANT
	DIRECTION OF SLOPE
	COMPRESSED AIR RELIEF VALVE
	OPEN FUNNEL DRAIN
	FLOOR DRAIN

THIS DOCUMENT IS
PRELIMINARY IN
NATURE AND IS NOT A
FINAL, SIGNED AND
SEALED DOCUMENT

FLORIDA STATE UNIVERSITY
FSU INSPIRE

PANAMA CITY, FLORIDA

REVISION HISTORY		
	DESCRIPTION	DATE
PROJECT INFORMATION		
DESIGNED BY:		REVIEWED BY:
BB	CLF	
DRAWN BY:		PROJECT MANAGER:
BB	LL	
PROJECT NUMBER		
FSB-2026-176-00		
SHEET TITLE:		
LEGEND & ABBREVIATIONS		
ISSUE DATE		
AUGUST 6, 2026		
SHEET NUMBER		
P-001		

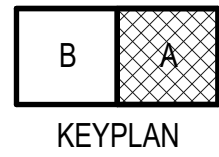


KEY VALUE	DESCRIPTION
-----------	-------------



P-101

50% CONSTRUCTION DOCUMENTS

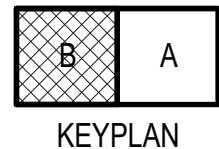


Frankfurt-Short-Bruza Associates, P.C.
1999 Bryan St., Suite 900
Dallas, TX 75201-3136
405.840.2931 | fsb-ae.com

Engineering CoA - 360003	Exp. 12/31/2030
Architectural CoA - 360003	Exp. 2/28/2030

PRELIMINARY

THIS DOCUMENT IS
PRELIMINARY IN
NATURE AND IS NOT A
FINAL, SIGNED AND
SEALED DOCUMENT

FLORIDA STATE UNIVERSITY
FSU INSPIRE

PANAMA CITY, FLORIDA

[illegible]

PROJECT INFORMATION	
DESIGNED BY: BB	REVIEWED BY: CLF
DRAWN BY: BB	PROJECT MANAGER: LL

PROJECT NUMBER
FSB2026-176-00
SHEET TITLE:

**SECTOR B - UNDERFLOOR
PLUMBING PLAN**

ISSUE DATE


AUGUST 6, 2026

SHEET NUMBER

D-100

P-102

50% CONSTRUCTION DOCUMENTS

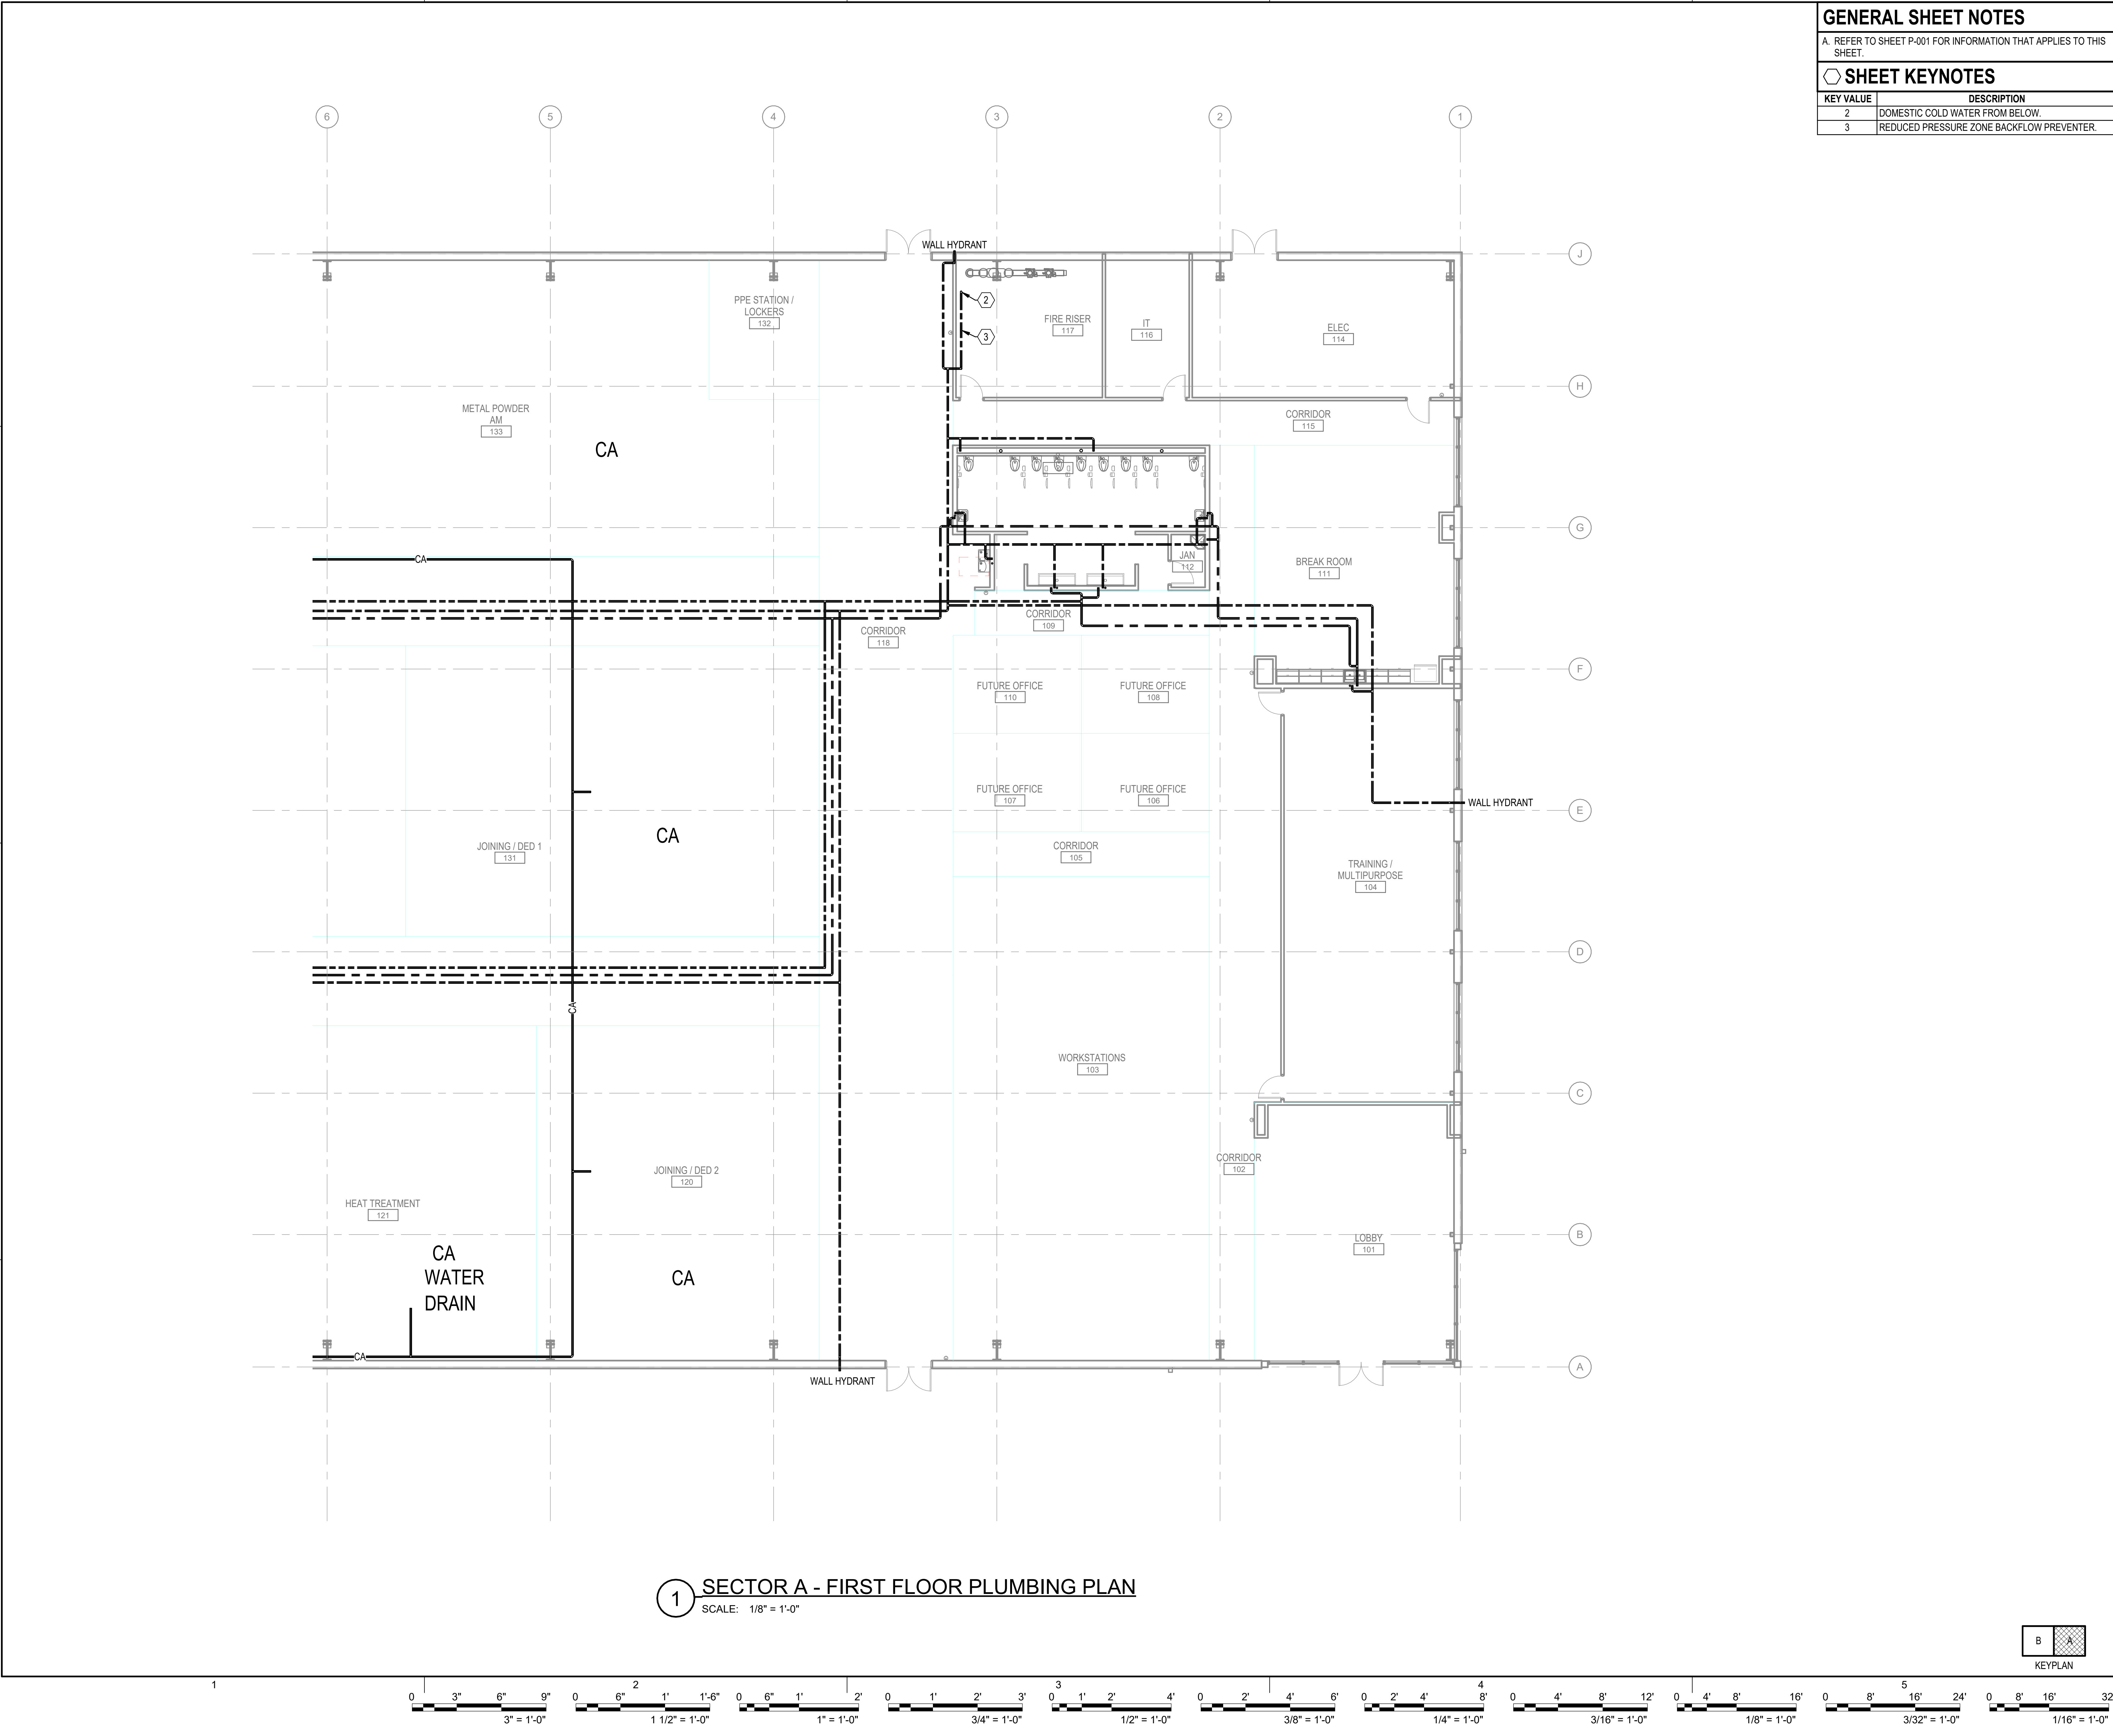

1 SECTOR A - FIRST FLOOR PLUMBING PLAN
SCALE: 1/8" = 1'-0"

GENERAL SHEET NOTES	
A. REFER TO SHEET P-001 FOR INFORMATION THAT APPLIES TO THIS SHEET.	
SHEET KEYNOTES	
KEY VALUE	DESCRIPTION
2	DOMESTIC COLD WATER FROM BELOW.
3	REDUCED PRESSURE ZONE BACKFLOW PREVENTER.





Frankfurt-Short-Bruza Associates, P.C.
1999 Bryan St., Suite 900
Dallas, TX 75201-3136
405.840.2931 | fsb-ae.com
Engineering CoA - 36003 Exp. 12/31/2030
Architectural CoA - 36003 Exp. 2/28/2030

PRELIMINARY

THIS DOCUMENT IS
PRELIMINARY IN
NATURE AND IS NOT A
FINAL, SIGNED AND
SEALED DOCUMENT

FLORIDA STATE UNIVERSITY

FSU INSPIRE

PANAMA CITY, FLORIDA

REVISION HISTORY

NO.	DESCRIPTION	DATE

PROJECT INFORMATION

DESIGNED BY:	REVIEWED BY:
DRAWN BY:	PROJECT MANAGER:

PROJECT NUMBER
FSB2026-176-00

SHEET TITLE:
SECTOR A - FIRST FLOOR
PLUMBING PLAN

ISSUE DATE
AUGUST 6, 2026

SHEET NUMBER
P-103

