


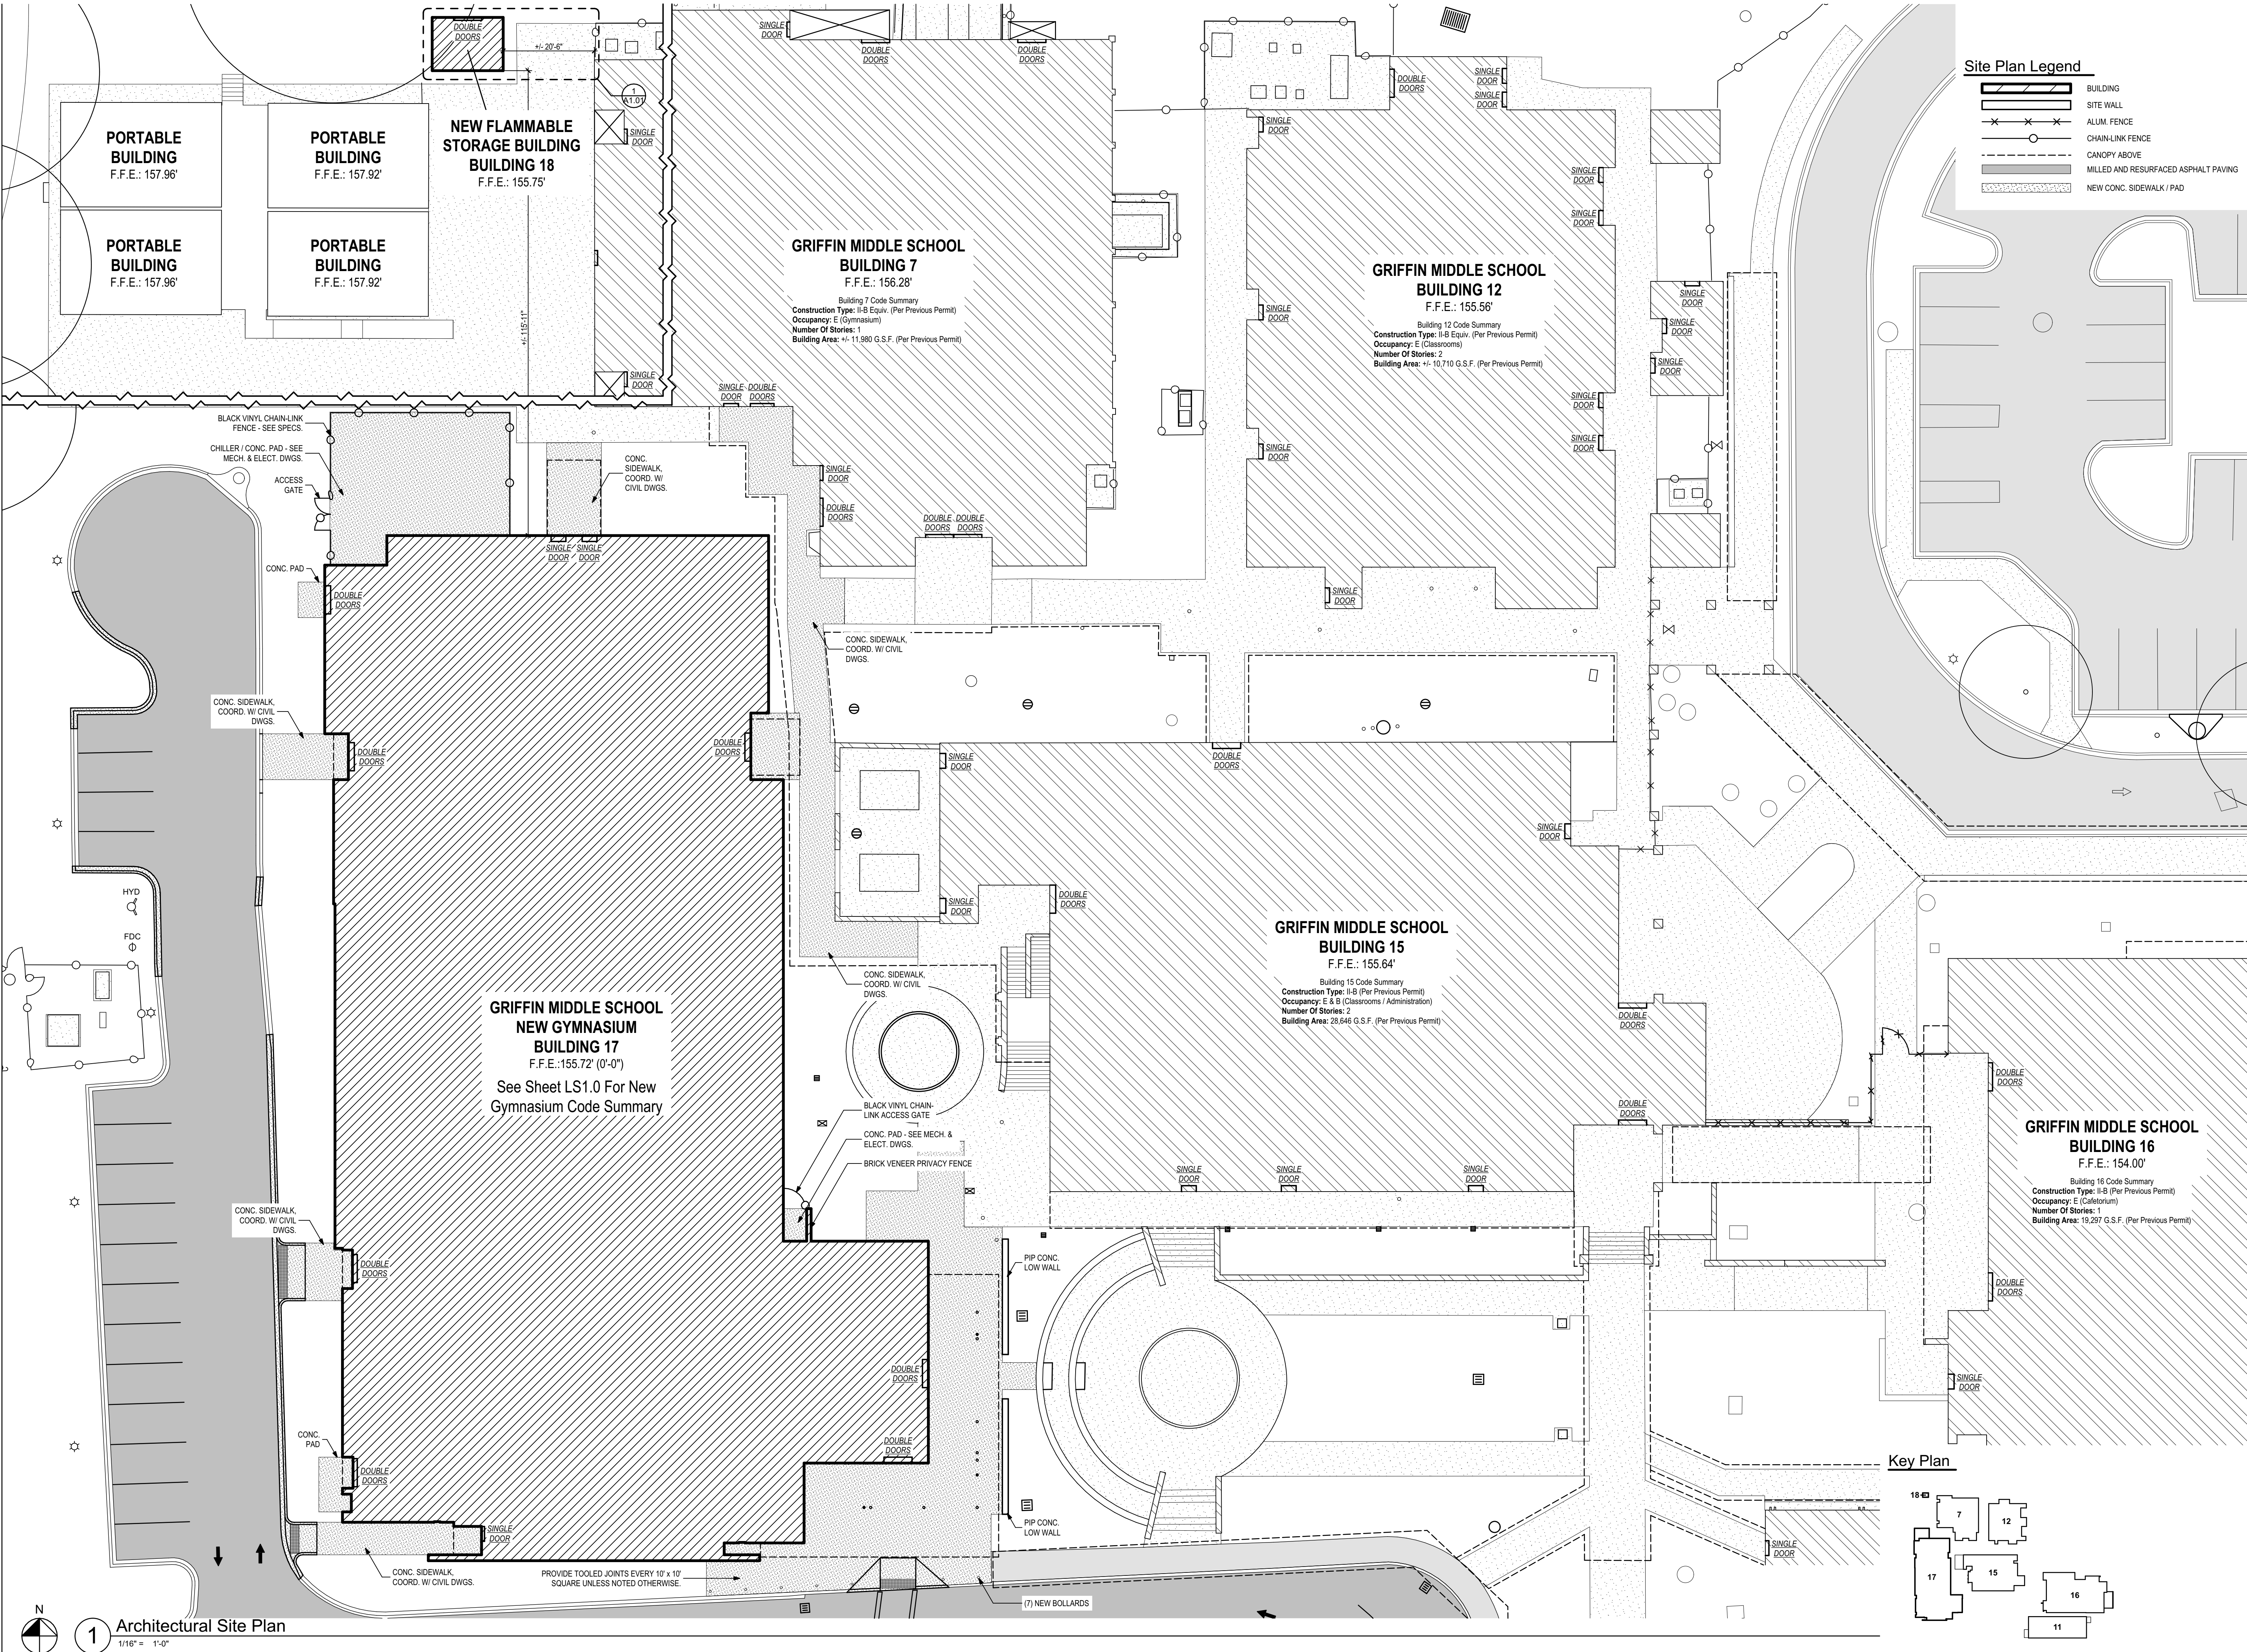

Site Plan Legend			
	BUILDING		SITE WALL
	ALUM. FENCE		CHAIN-LINK FENCE
	CANOPY ABOVE		MILLED AND RESURFACED ASPHALT PAVING
	NEW CONC. SIDEWALK / PAD		

PHASE:	DRAWN:	REVIEWED:	DATE:	ID:	REVISION:	DRAWN:	REVIEWED:	DATE:
CONCEPT SCHEM. DESIGN	BG / RS	C. WHITLOCK	10/8/2024					
DESIGN DEVELOPMENT	BG/RS/SMS	C. WHITLOCK	12/20/2024					
EARLY DEMOLITION PACKAGE	BG/RS/SMS	C. WHITLOCK	12/20/2024					
80% CONSTRUCTION DOCS	BG/RS/SMS	R. LEWIS	03/21/2025					
PERMIT DOCS	BG/RS/SMS	R. LEWIS	03/21/2025					
100% CONSTRUCTION DOCS	BG/RS/SMS	R. LEWIS	05/09/2025					








	Leon County Schools	
	3420 W. Tharpe St., Suite 100 Tallahassee, FL 32303	
Client:	Griffin Middle School - Phase 2	
Job Title:	800 Alabama St. Tallahassee, FL 32304	


Consultant:	Project #:	23483
Seal:	Phase:	100% CDs

ALW


Architects Lewis + Whitlock
206 West Virginia St.
Tallahassee, Florida 32301
850.942.1718
www.think3d.net

Description:	Architectural Site Plan
Sheet No.:	A1.0

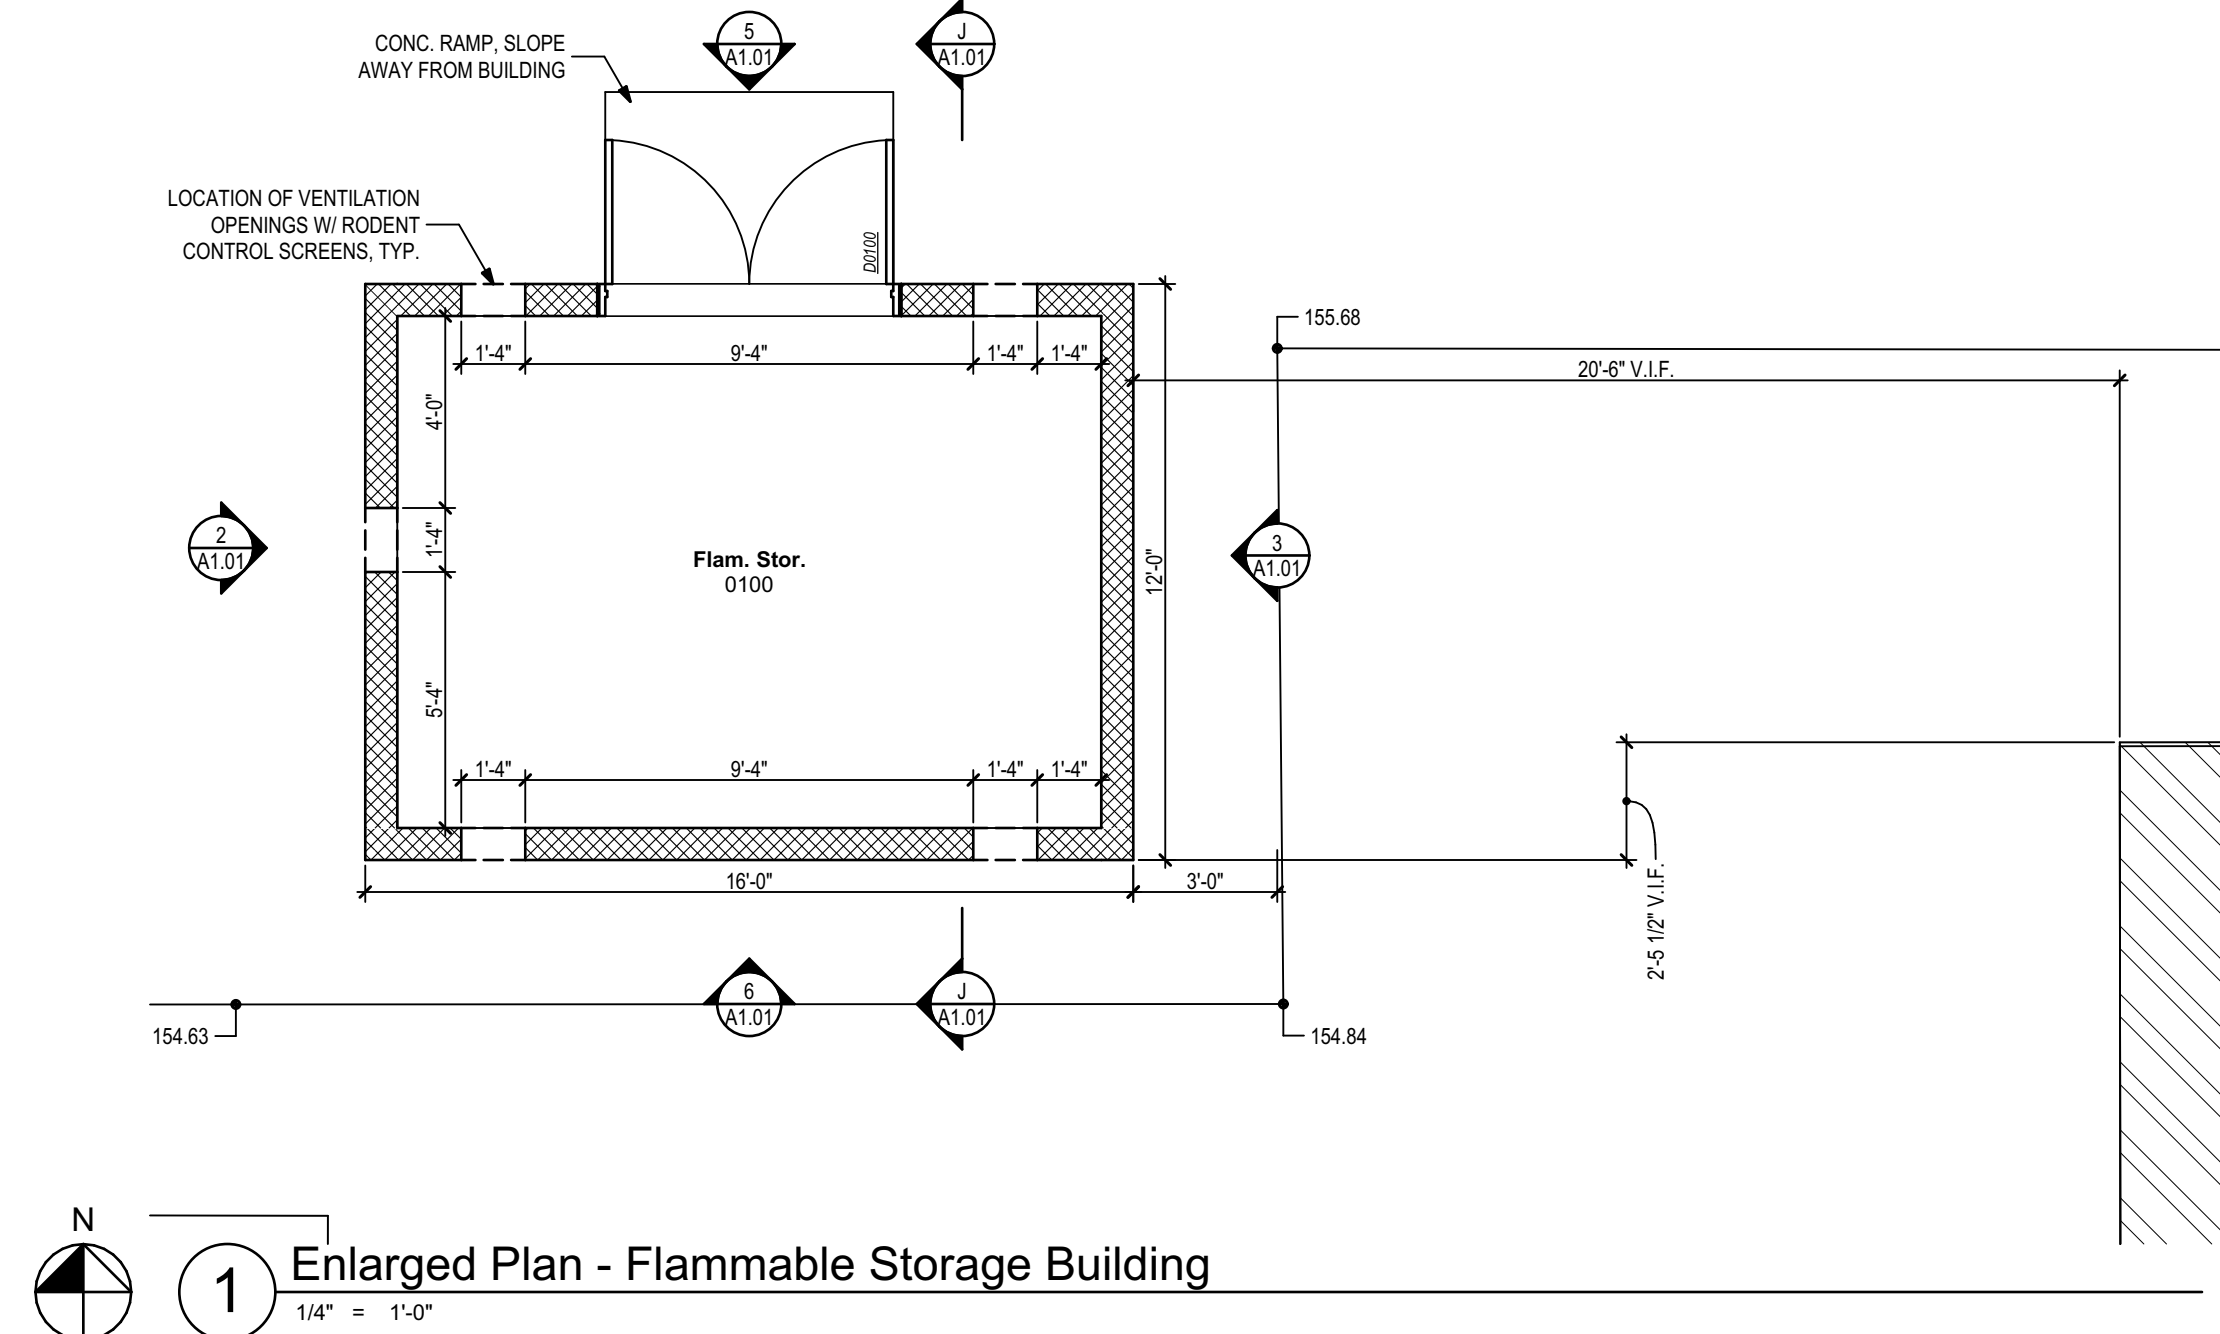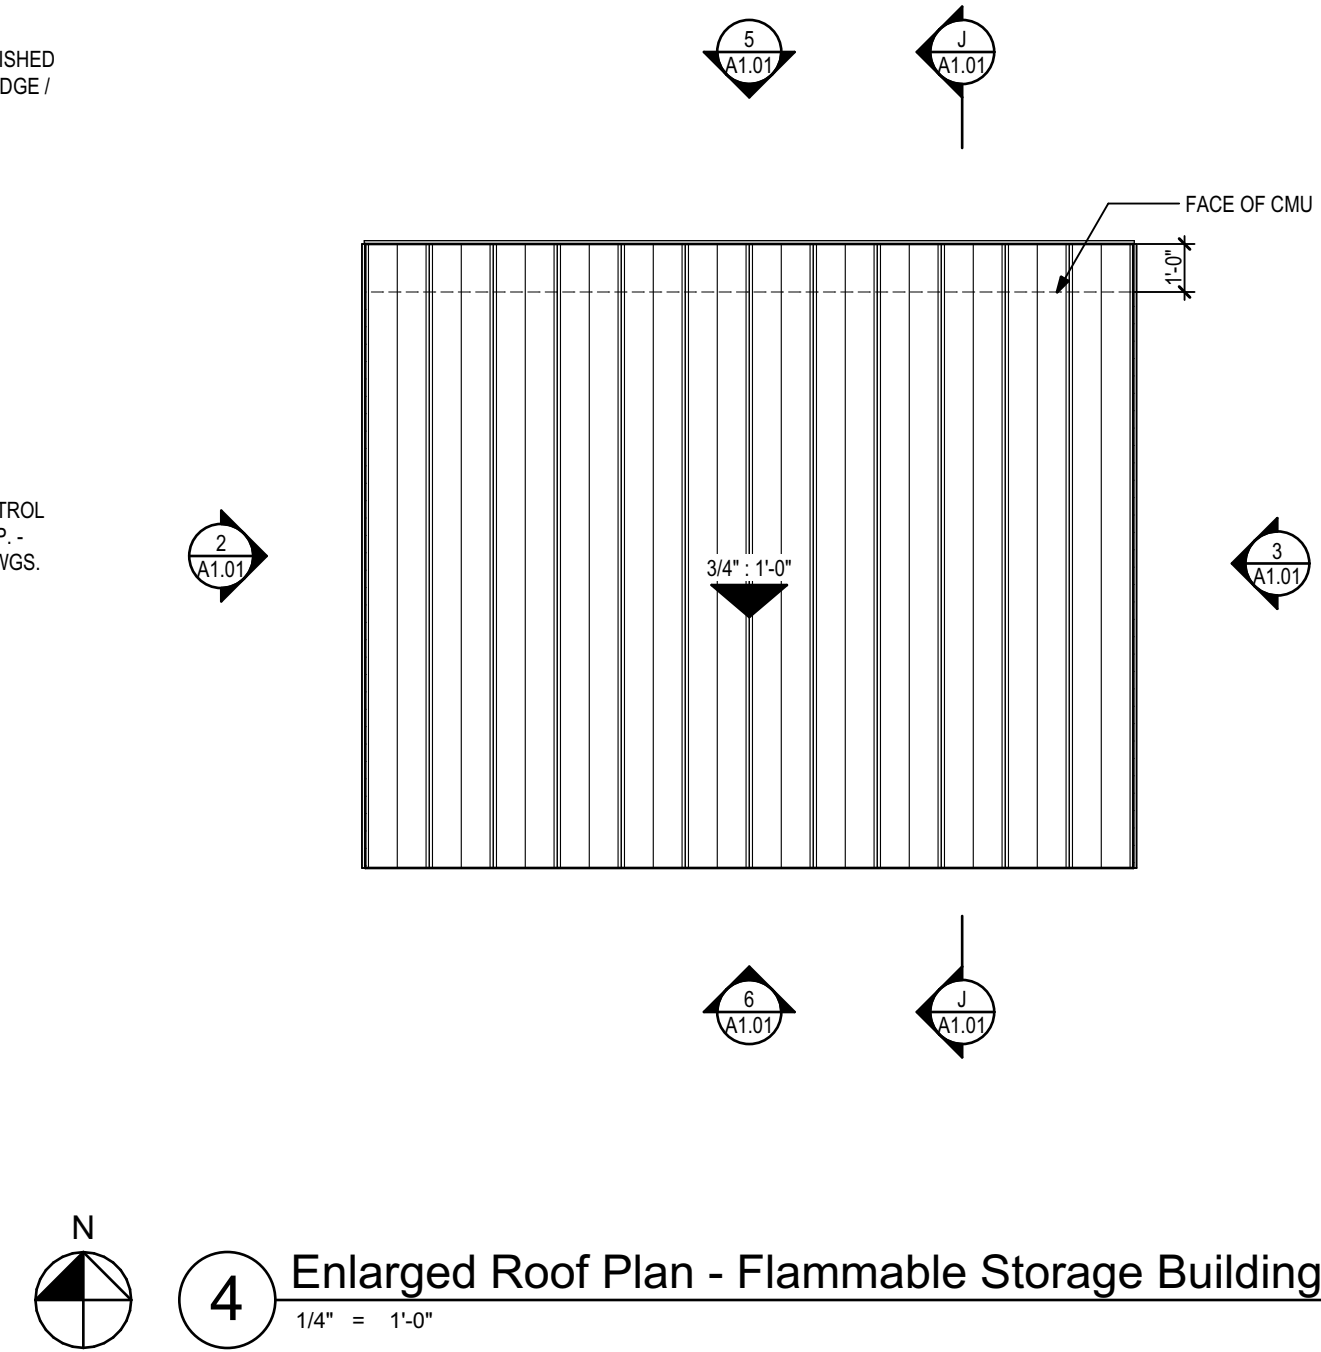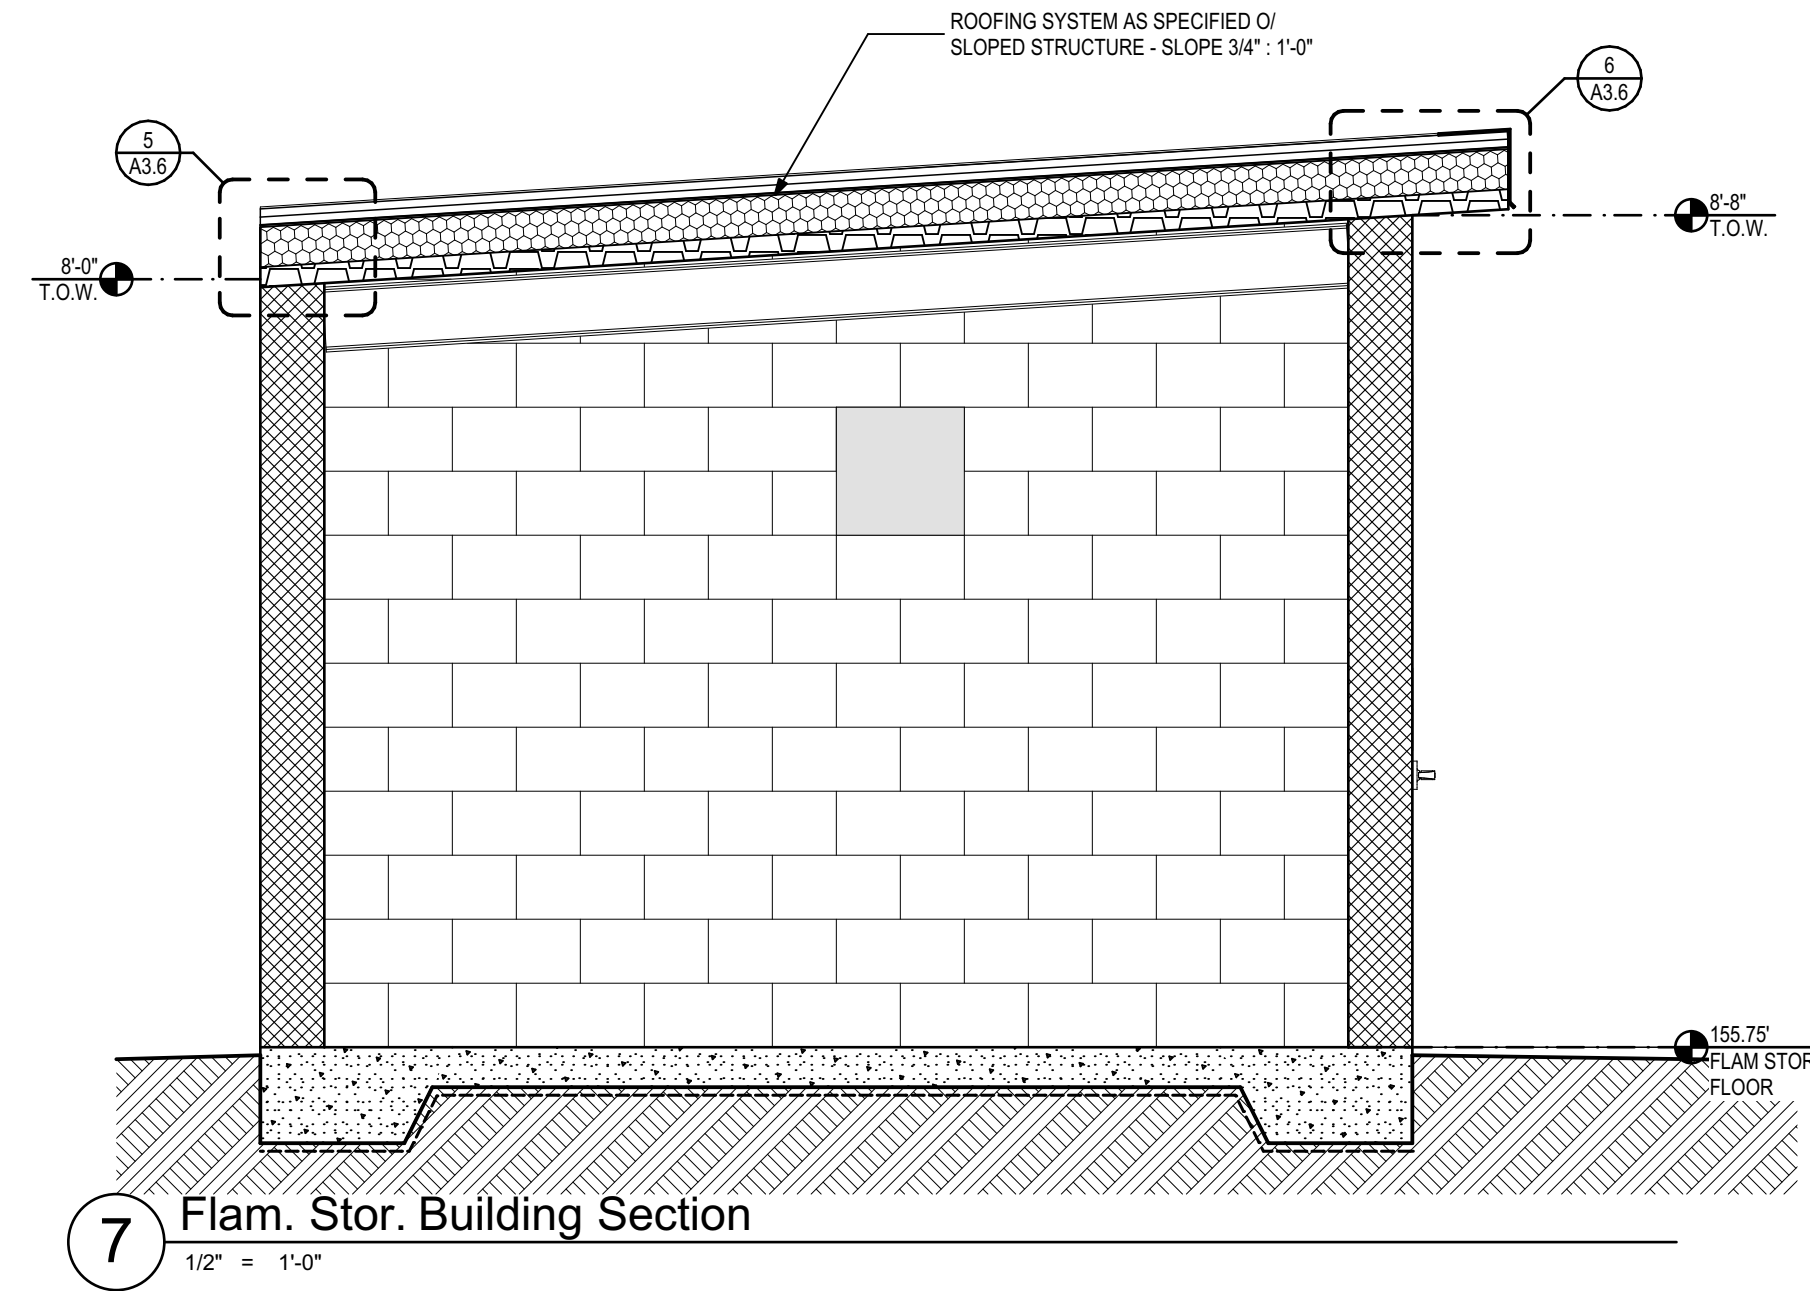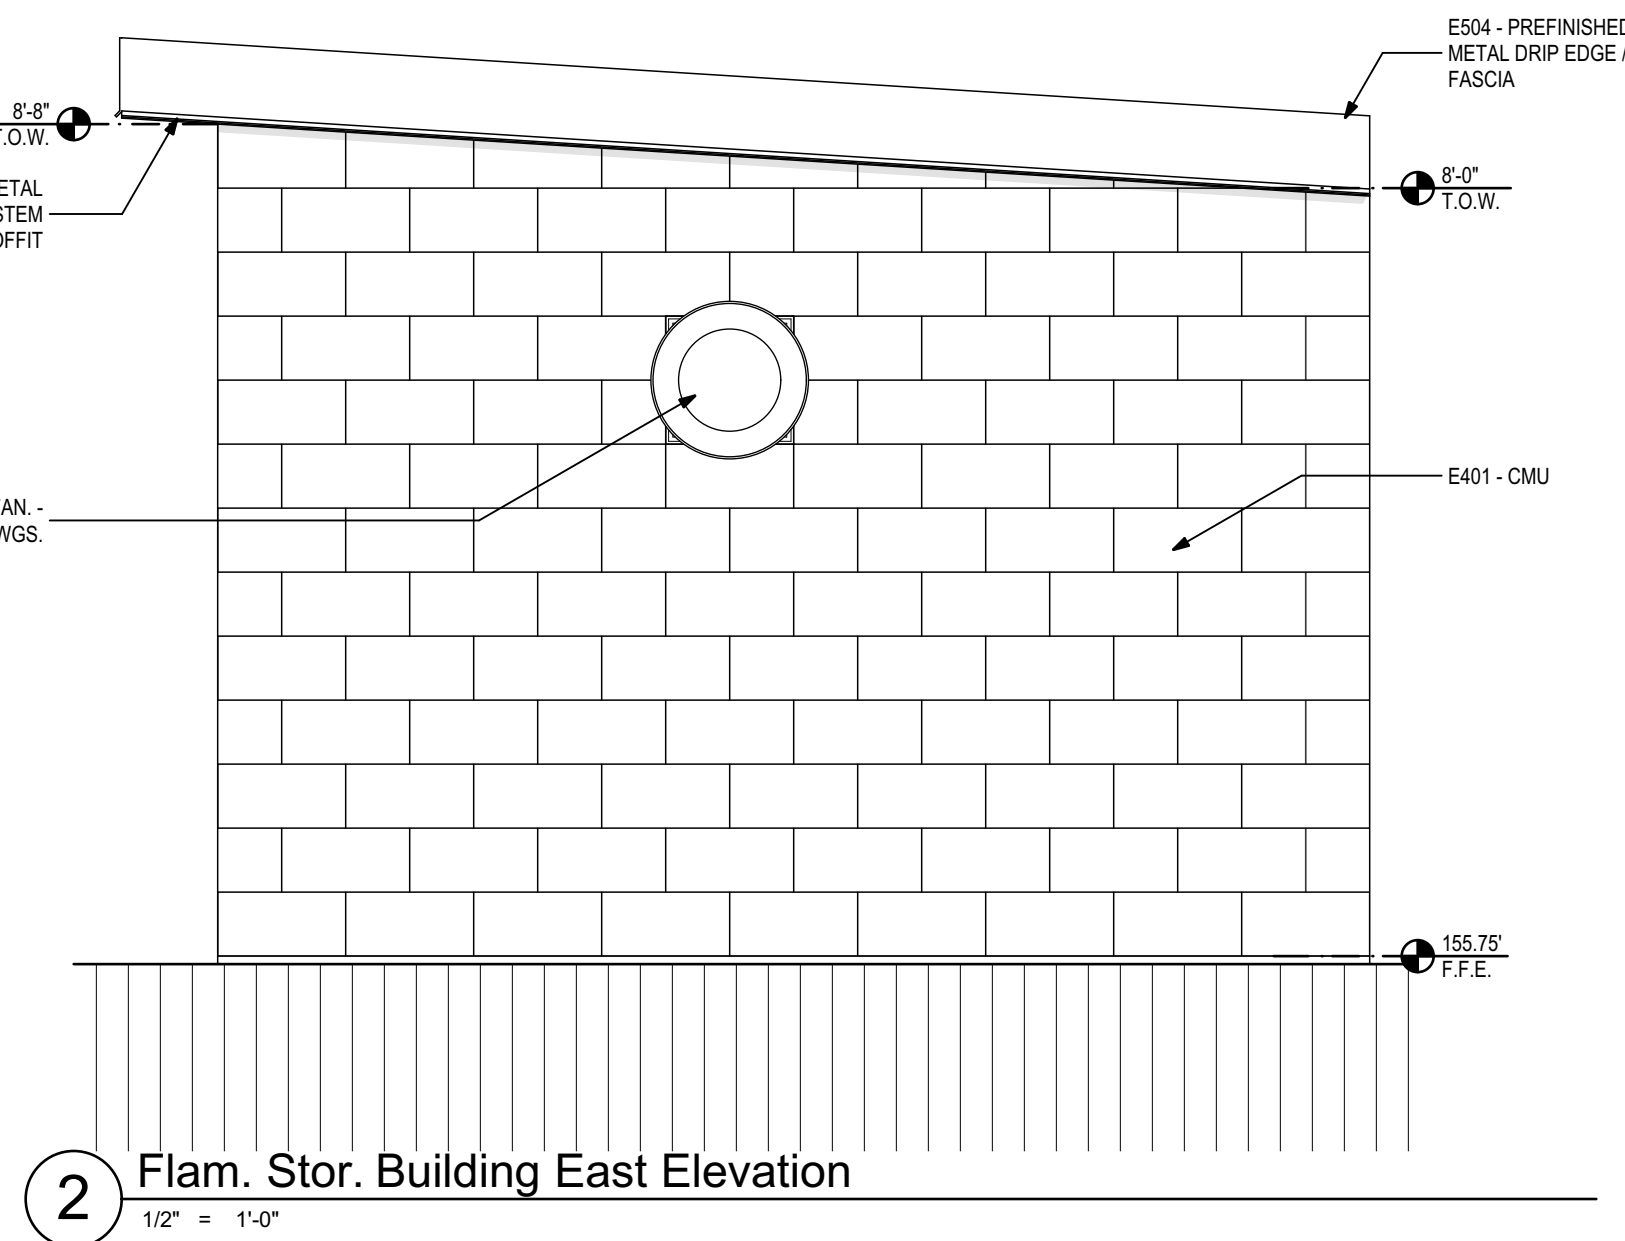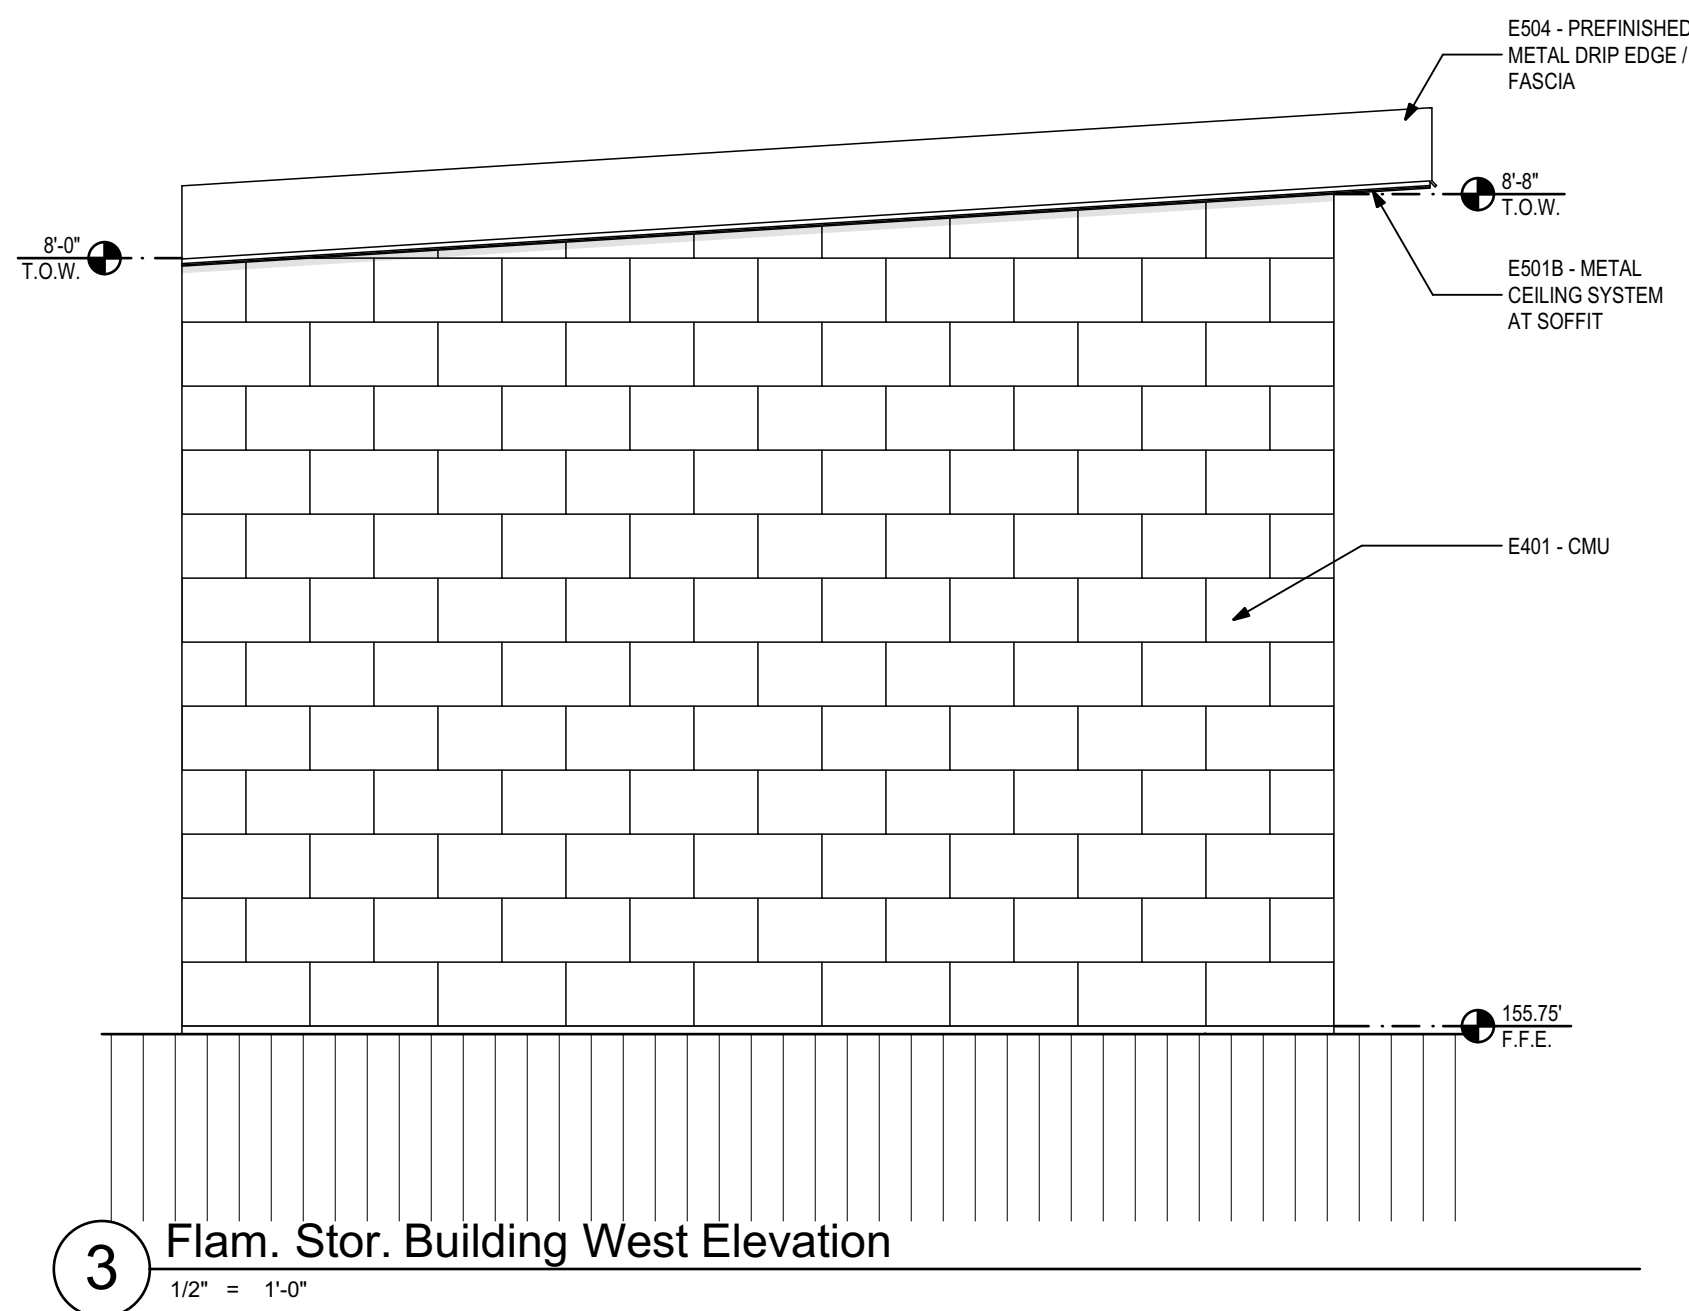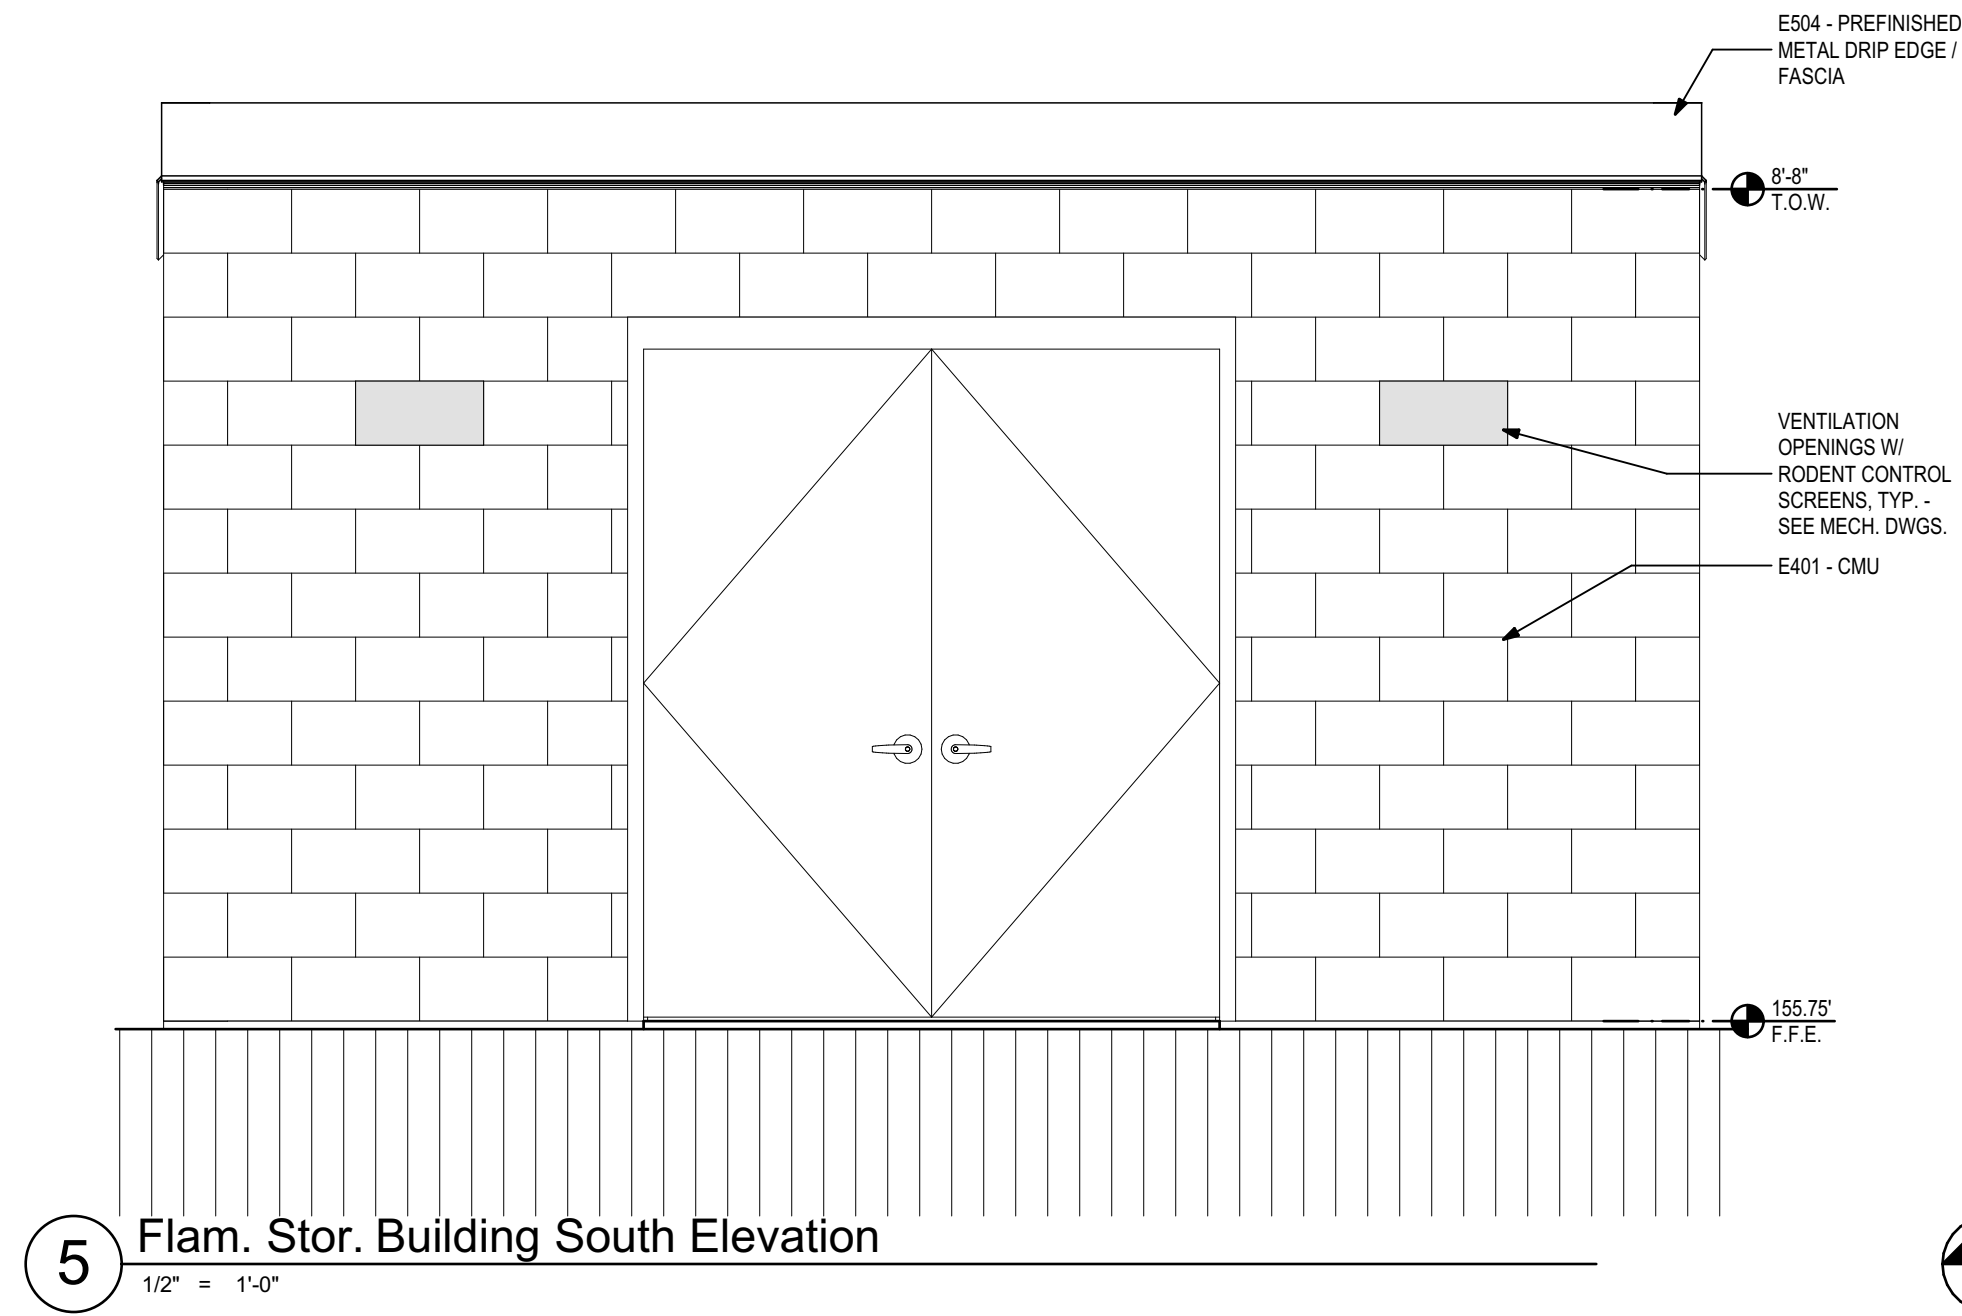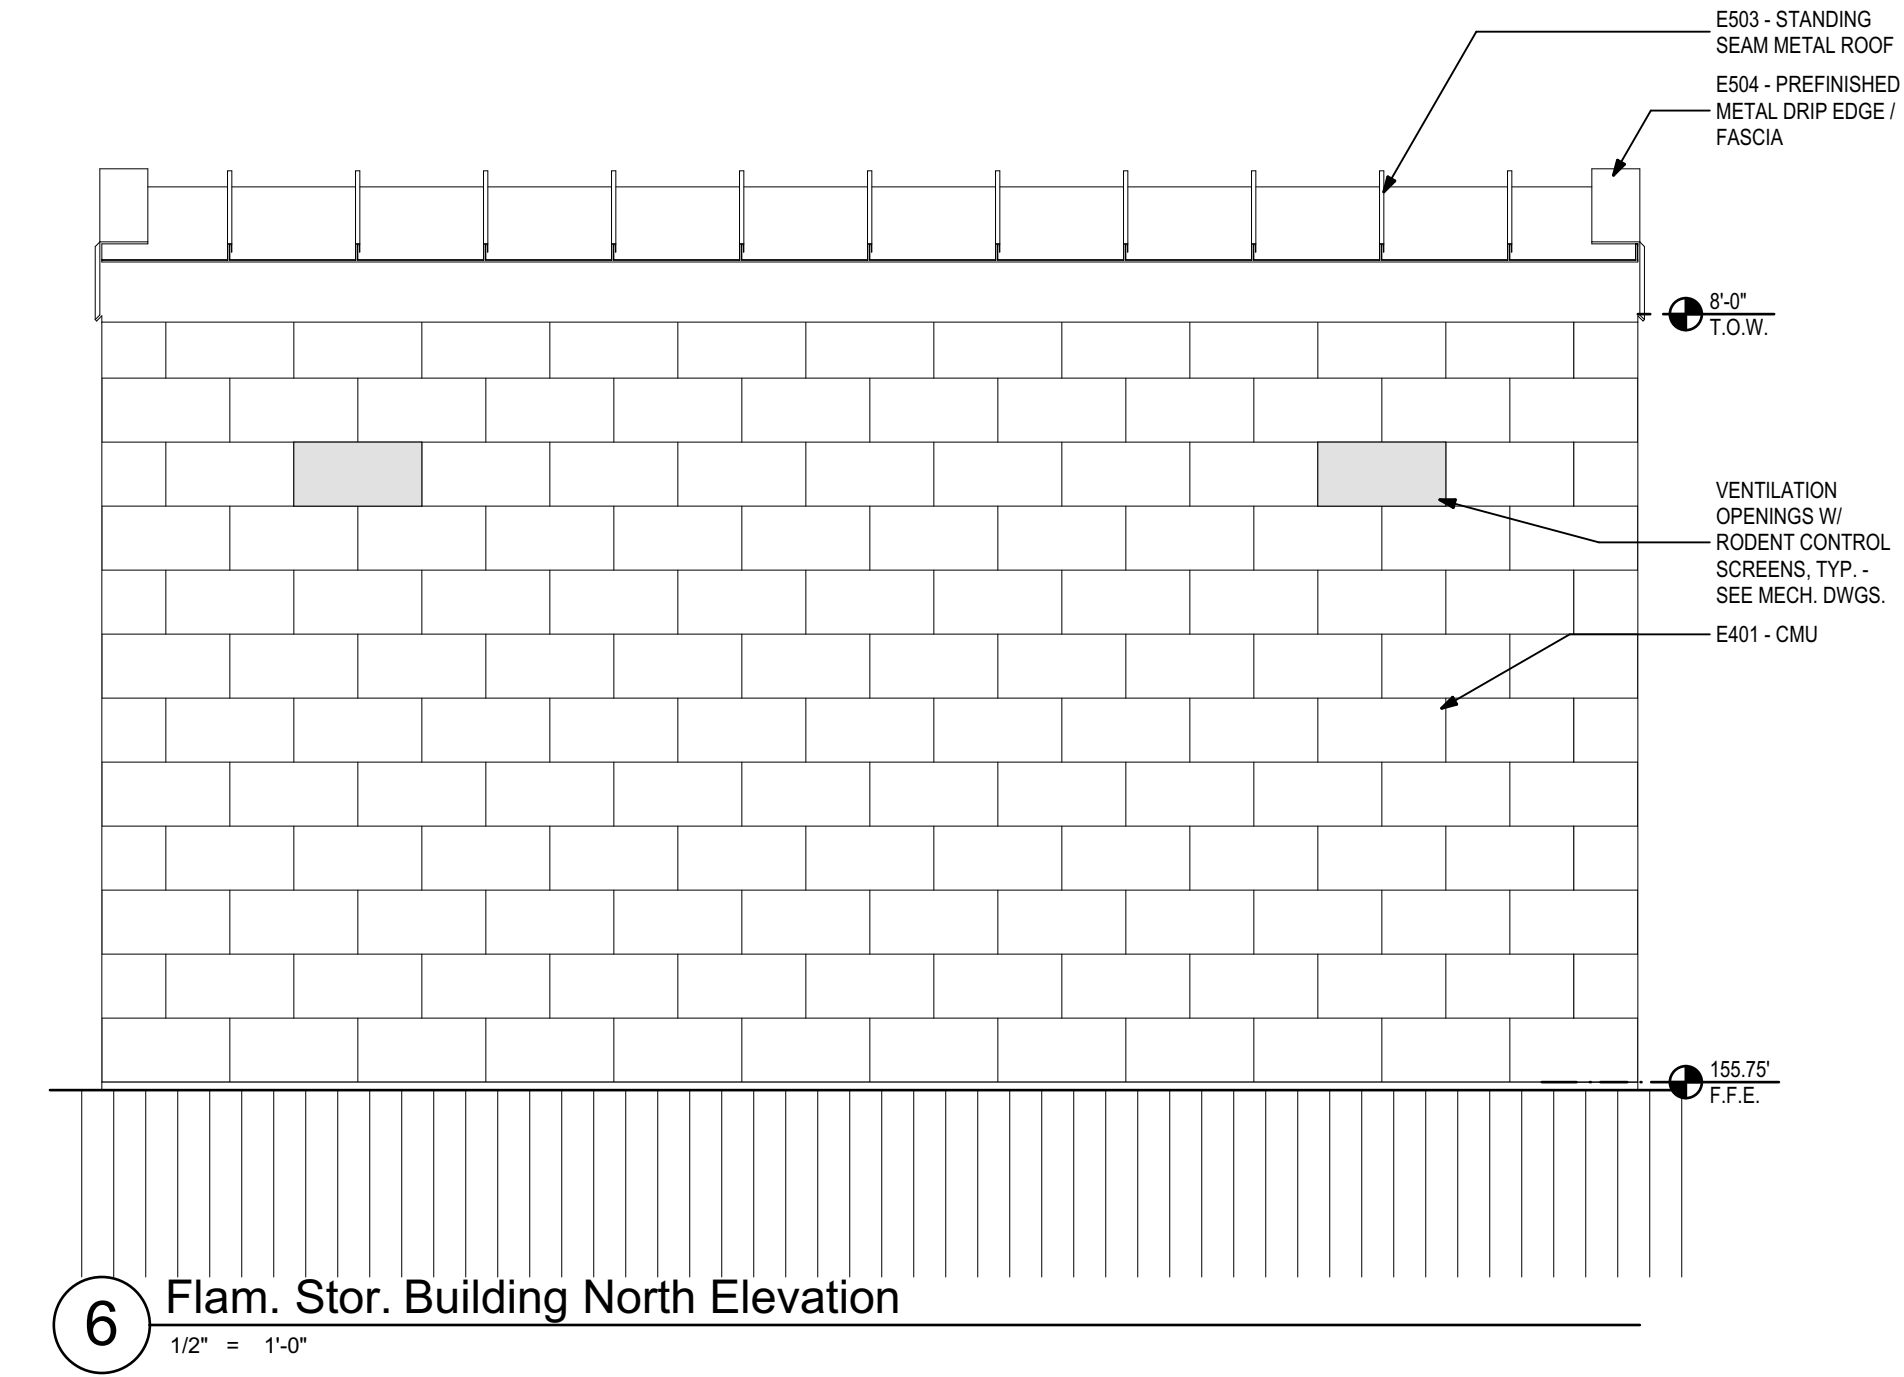


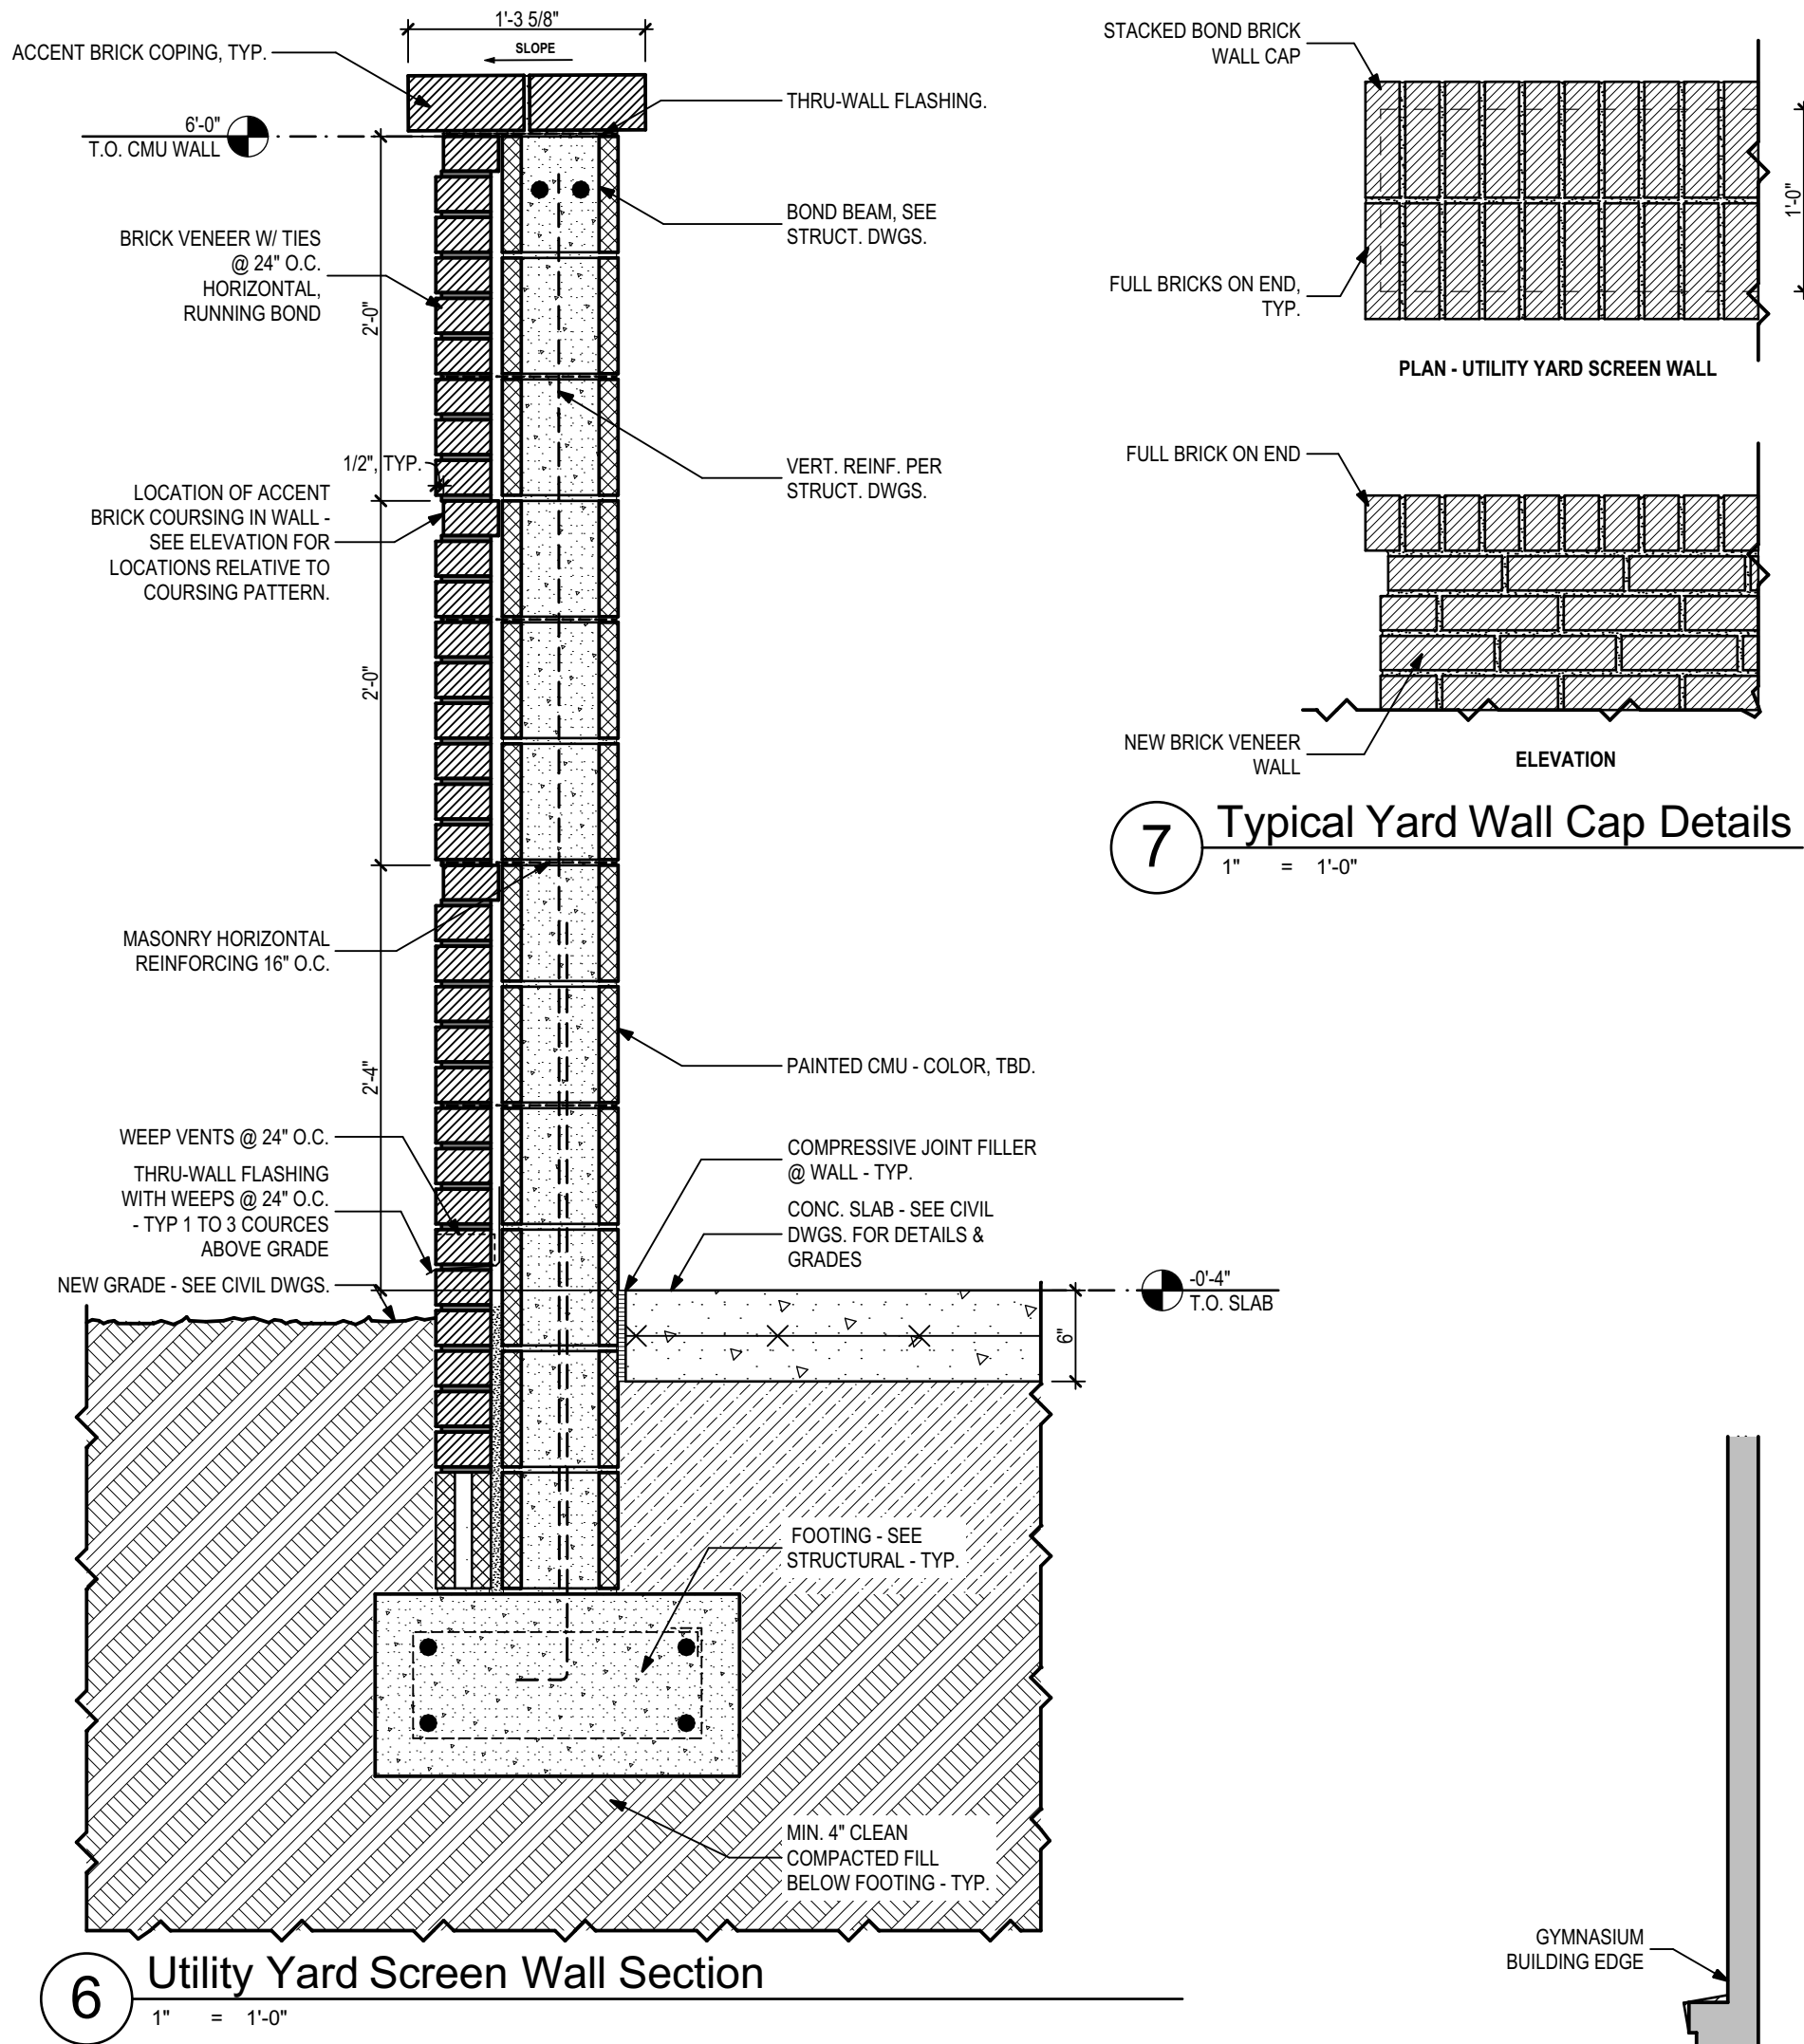


6 Utility Yard Screen Wall Section
1" = 1'-0"

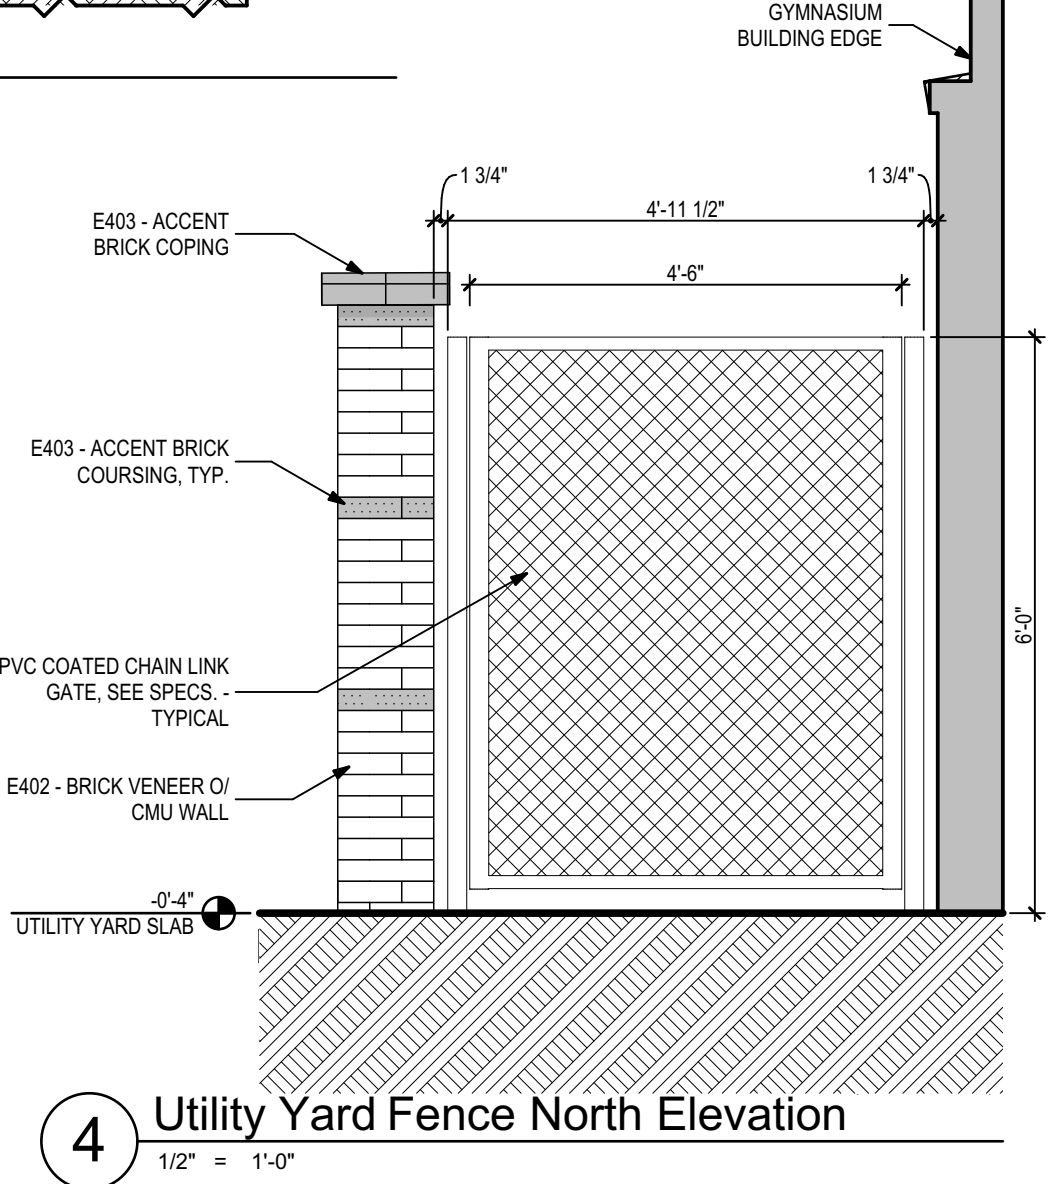


4 Utility Yard Fence North Elevation
1/2" = 1'-0"

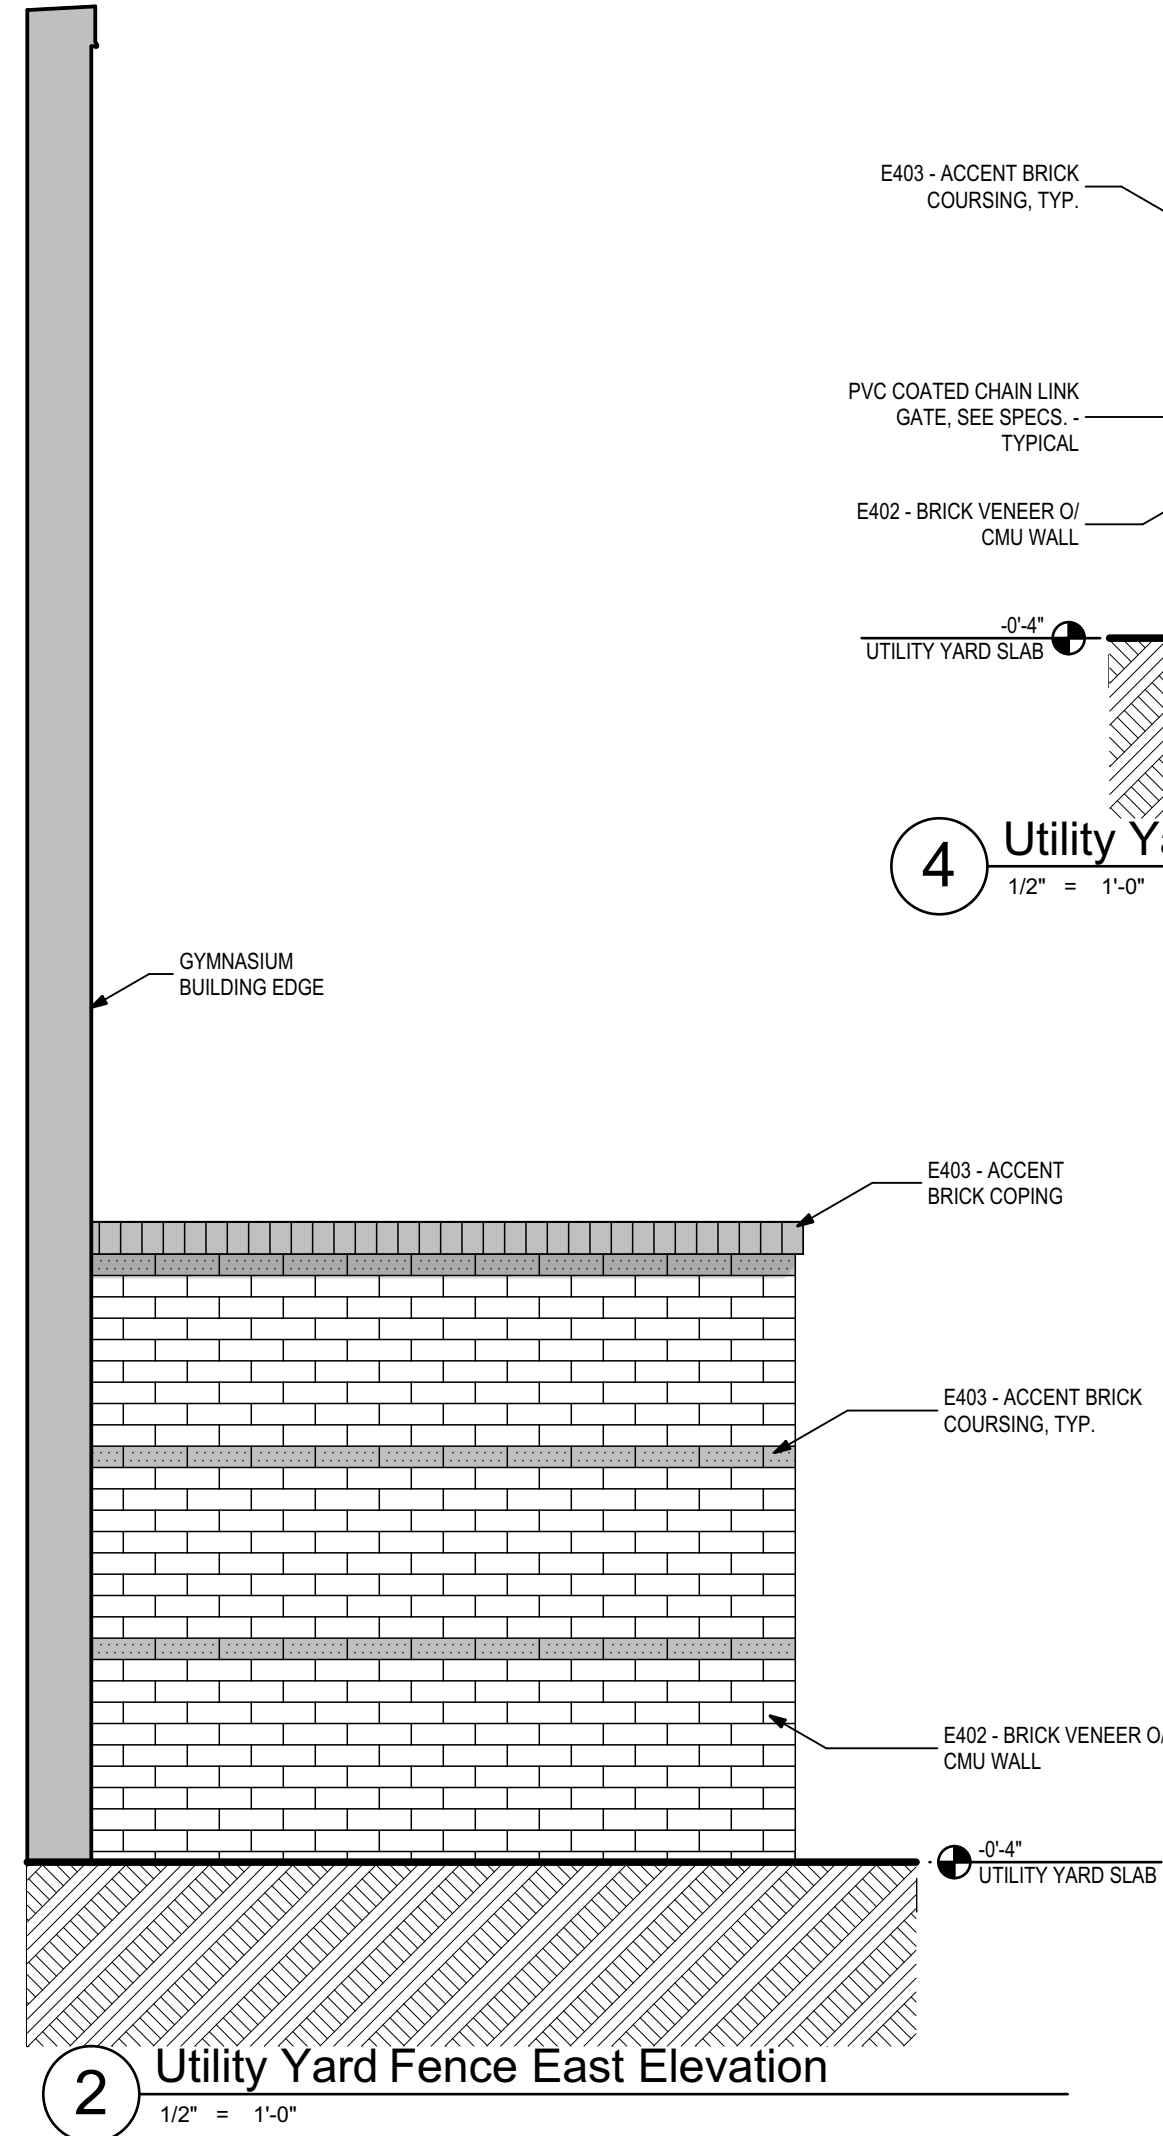


2 Utility Yard Fence East Elevation
1/2" = 1'-0"

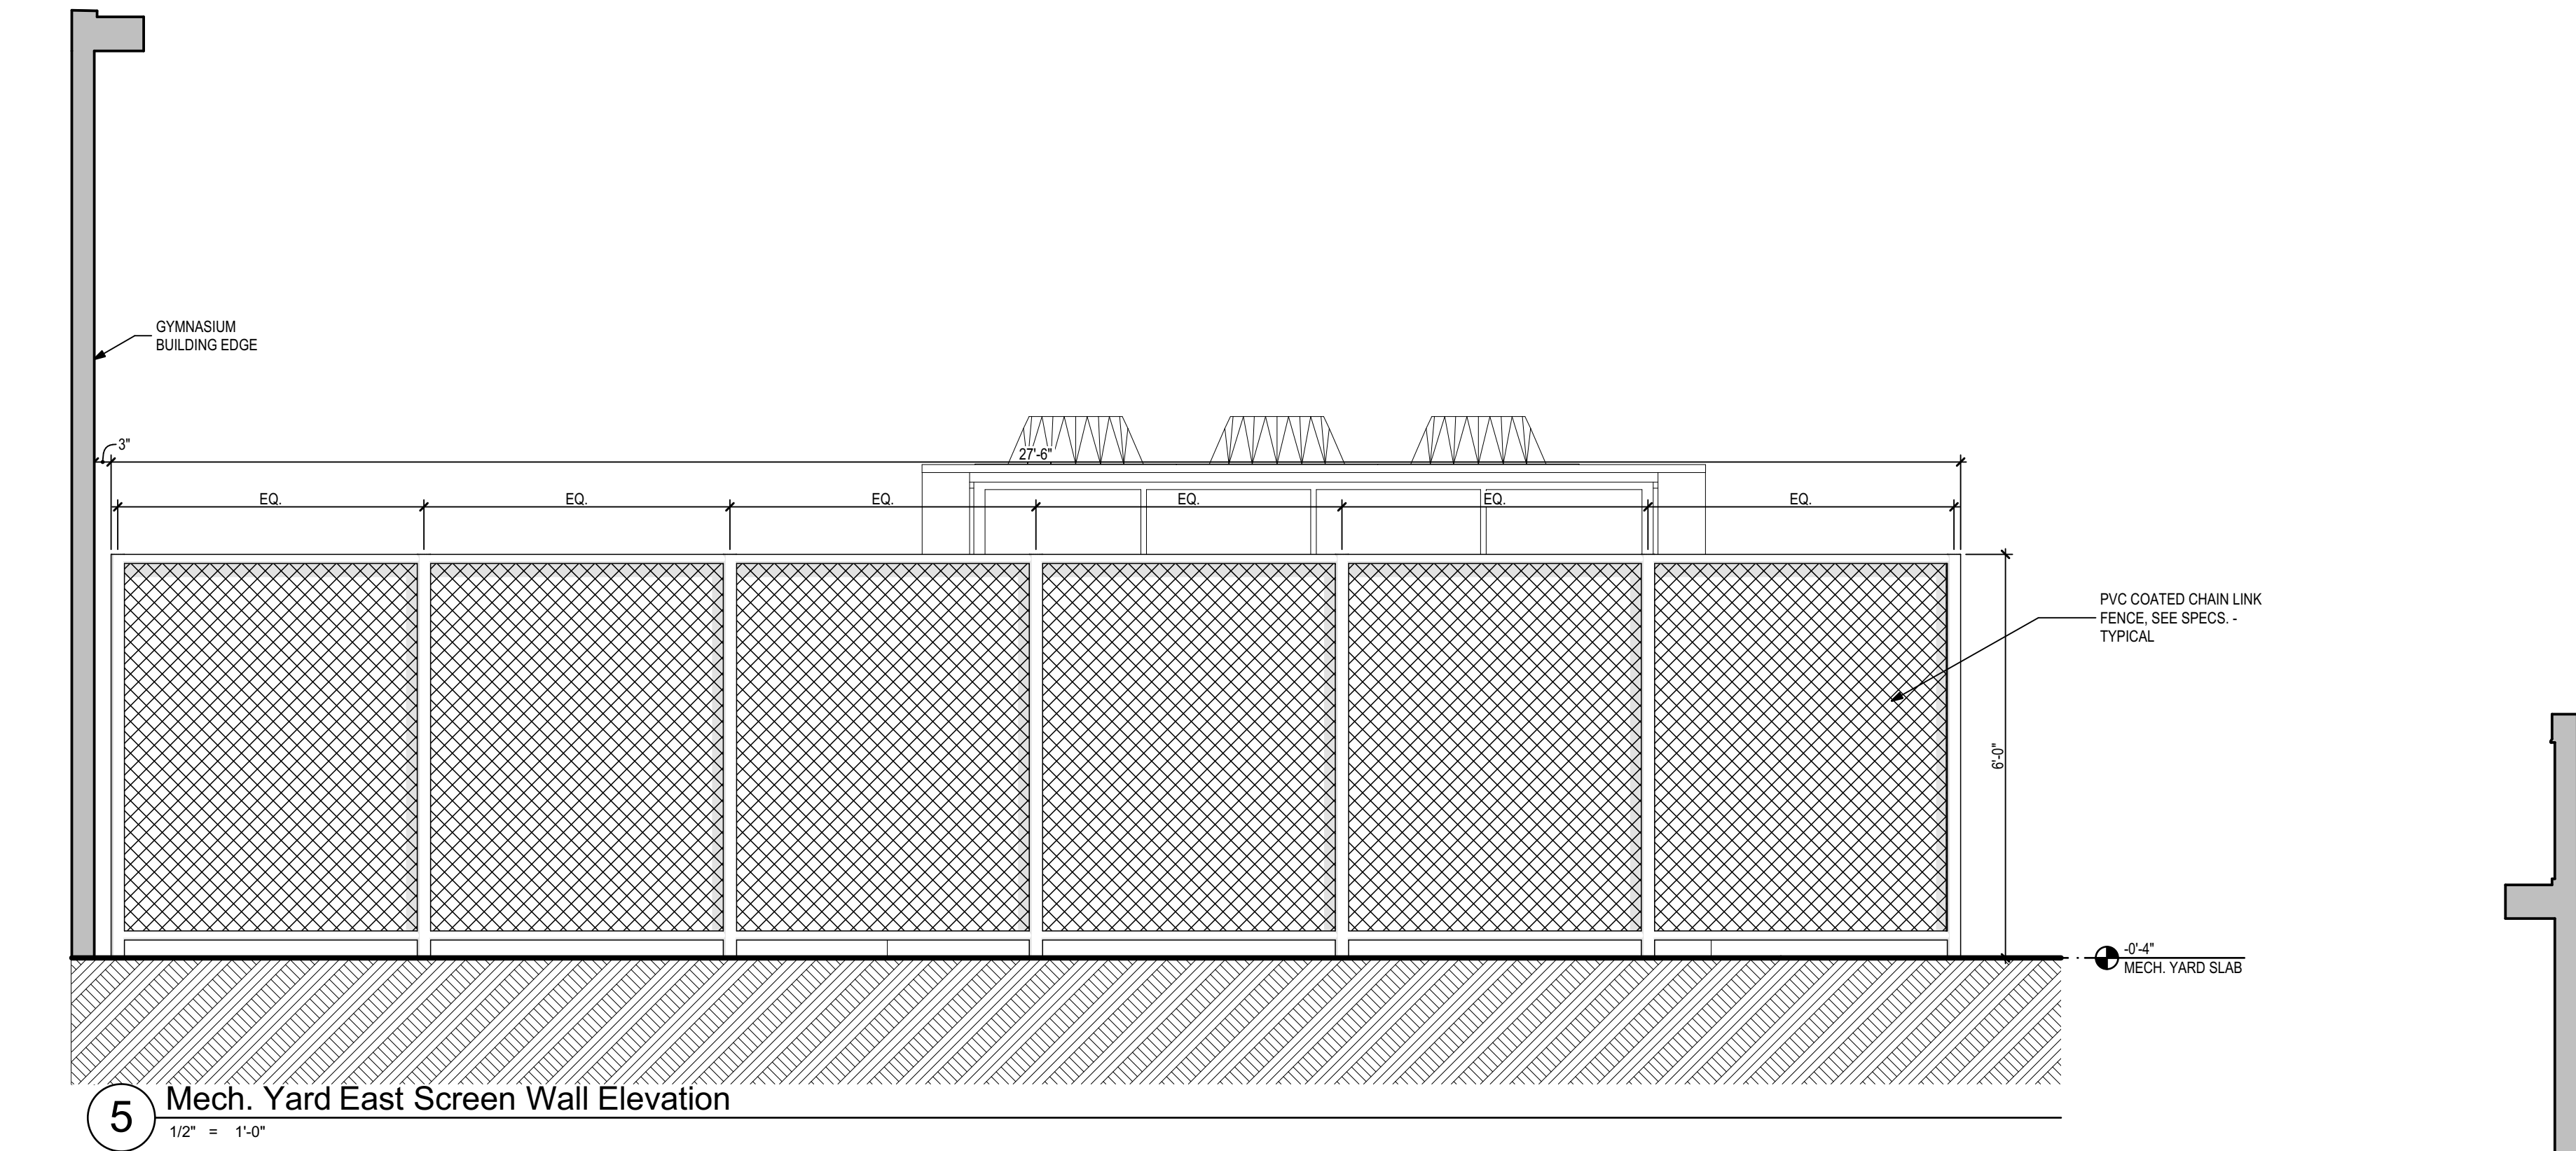

5 Mech. Yard East Screen Wall Elevation
1/2" = 1'-0"

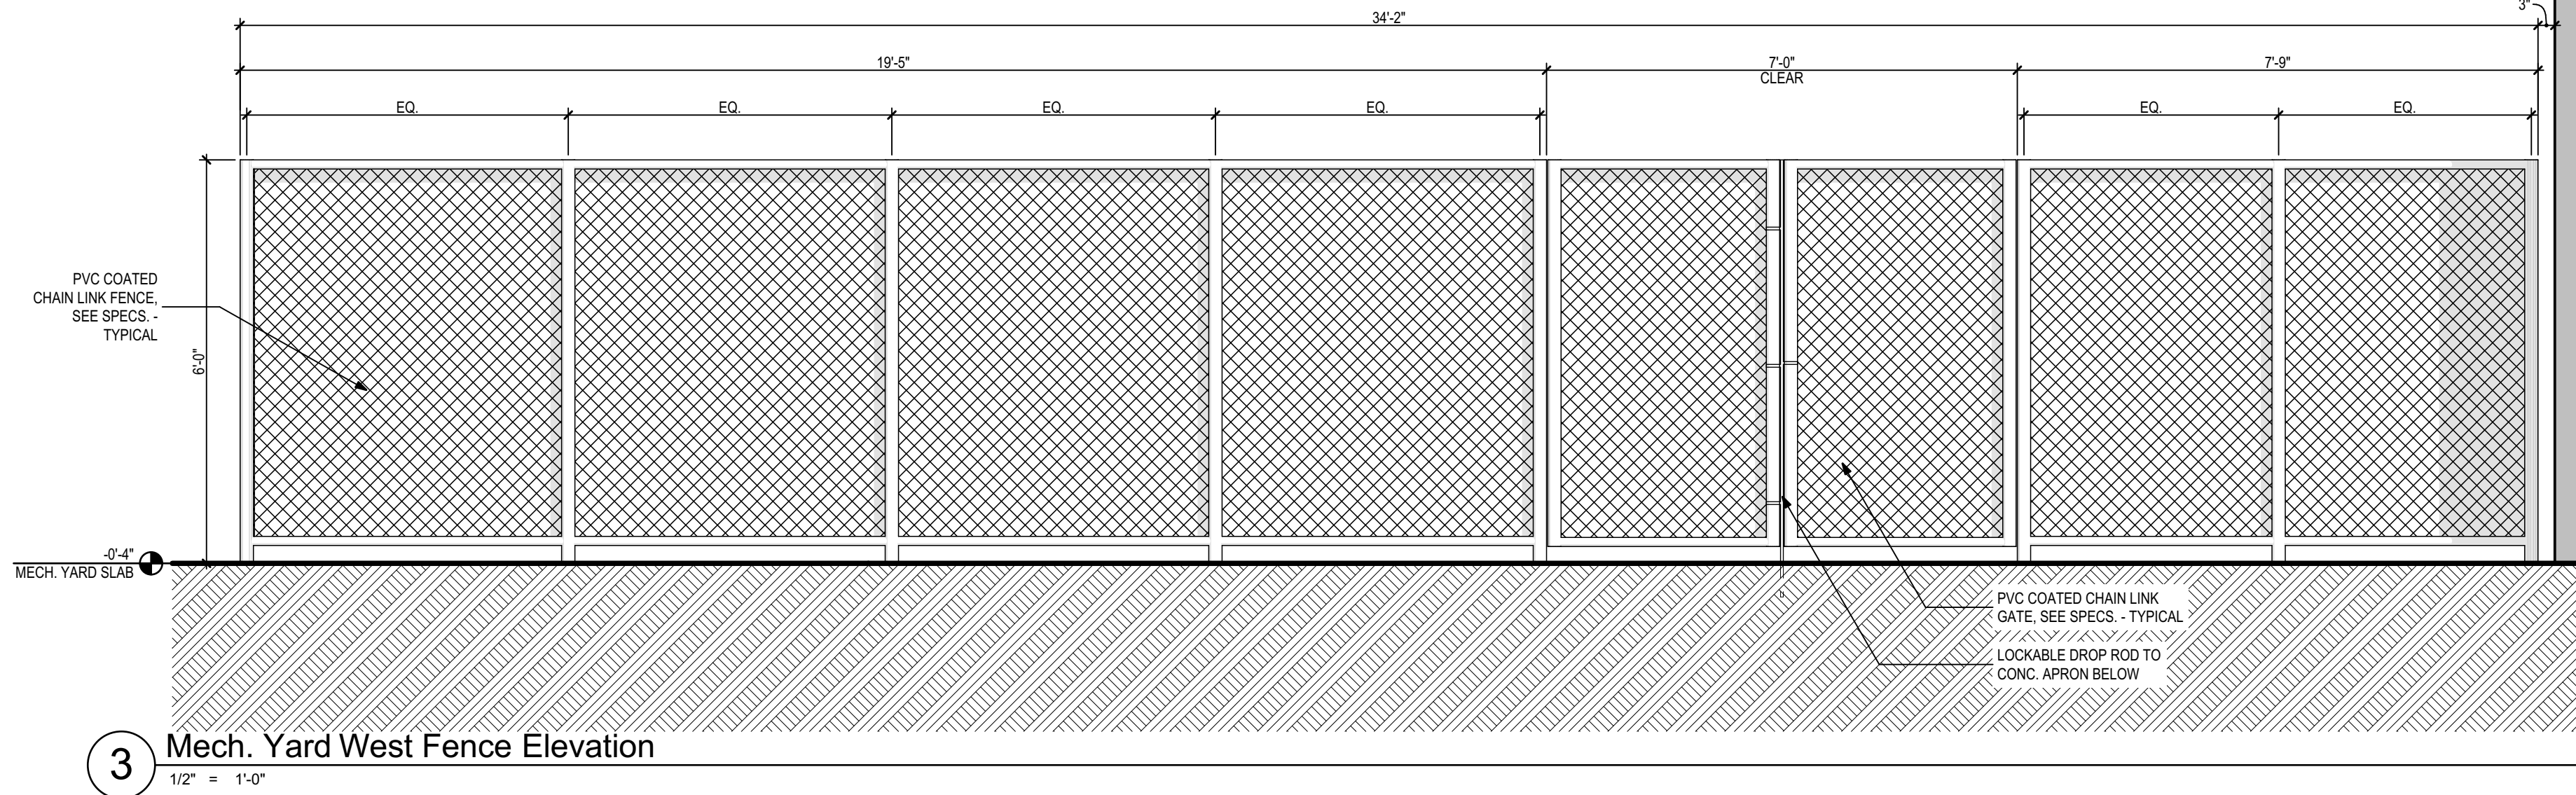


3 Mech. Yard West Fence Elevation
1/2" = 1'-0"

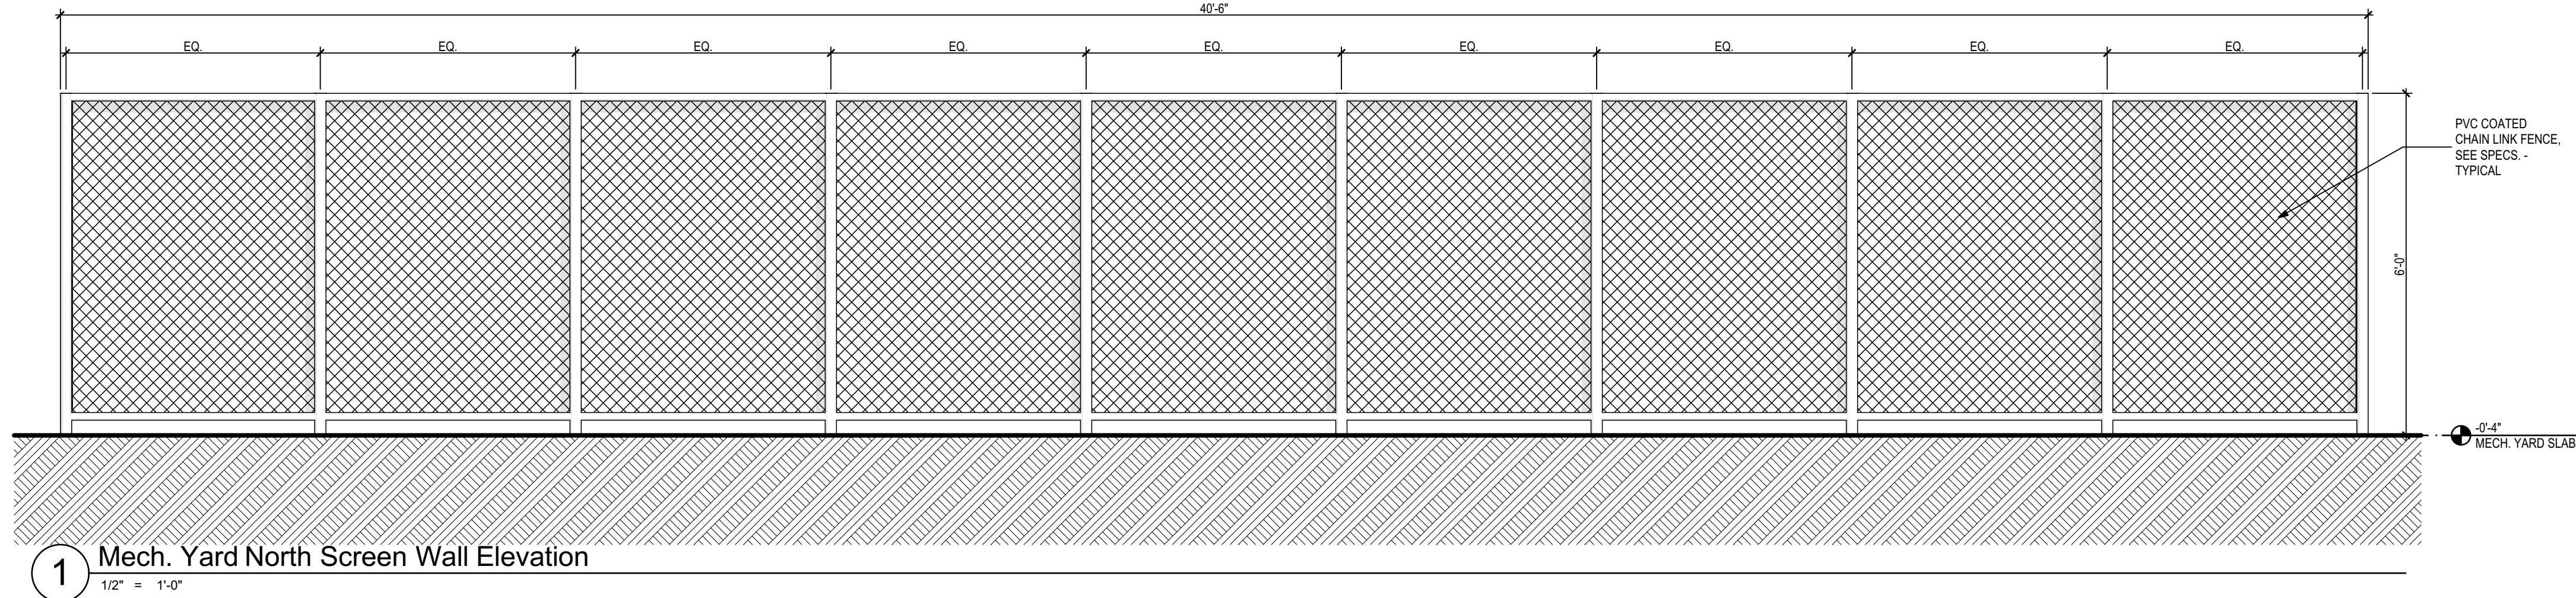


1 Mech. Yard North Screen Wall Elevation
1/2" = 1'-0"


Seal:	Consultant:	Client:	Project #: 23483 Phase: 100% CDs	Job Title: Griffin Middle School - Phase 2 800 Alabama St. Tallahassee, FL 32304	LEON COUNTY SCHOOLS	PHASE:	DRAWN:	REVIEWED:	DATE:	ID:	REVISION:	DRAWN:	REVIEWED:	DATE:
						CONCEPT SCHEM. DESIGN	BG/RS	C. WHITLOCK	10/8/2024					
						DESIGN DEVELOPMENT	BG/RS/MS	C. WHITLOCK	12/20/2024					
						EARLY DEMOLITION PACKAGE	BG/RS/MS	R. LEWIS	03/21/2025					
						80% CONSTRUCTION DOCS	BG/RS/MS	R. LEWIS	05/09/2025					
						PERMIT DOCS	BG/RS/MS	R. LEWIS	05/09/2025					
						100% CONSTRUCTION DOCS	BG/RS/MS	R. LEWIS	05/09/2025					
						THESE DRAWINGS AND RENDERINGS ARE INSTRUMENTS OF SERVICE. THE DRAWINGS AND ASSOCIATED COPIES THEREOF, INCLUDING ELECTRONIC MEDIA AND CAD FILES, ARE THE PROPERTY OF ARCHITECTS LEWIS + WHITLOCK, P.A.A. THEIR USE, REPRESENTATION OR REPRODUCTION FOR ANY PURPOSE EXCEPT BY WRITTEN AGREEMENT WITH THE ARCHITECT IS PROHIBITED. THIS COPYRIGHT NOTIFICATION SHALL BE TRUE AS F DIRECTLY PLACED ON EACH DRAWING EXIST OR FUTURE DURING THE TERM OF THE DOCUMENT AND SHALL NOT BE REMOVED FROM THESE DOCUMENTS								

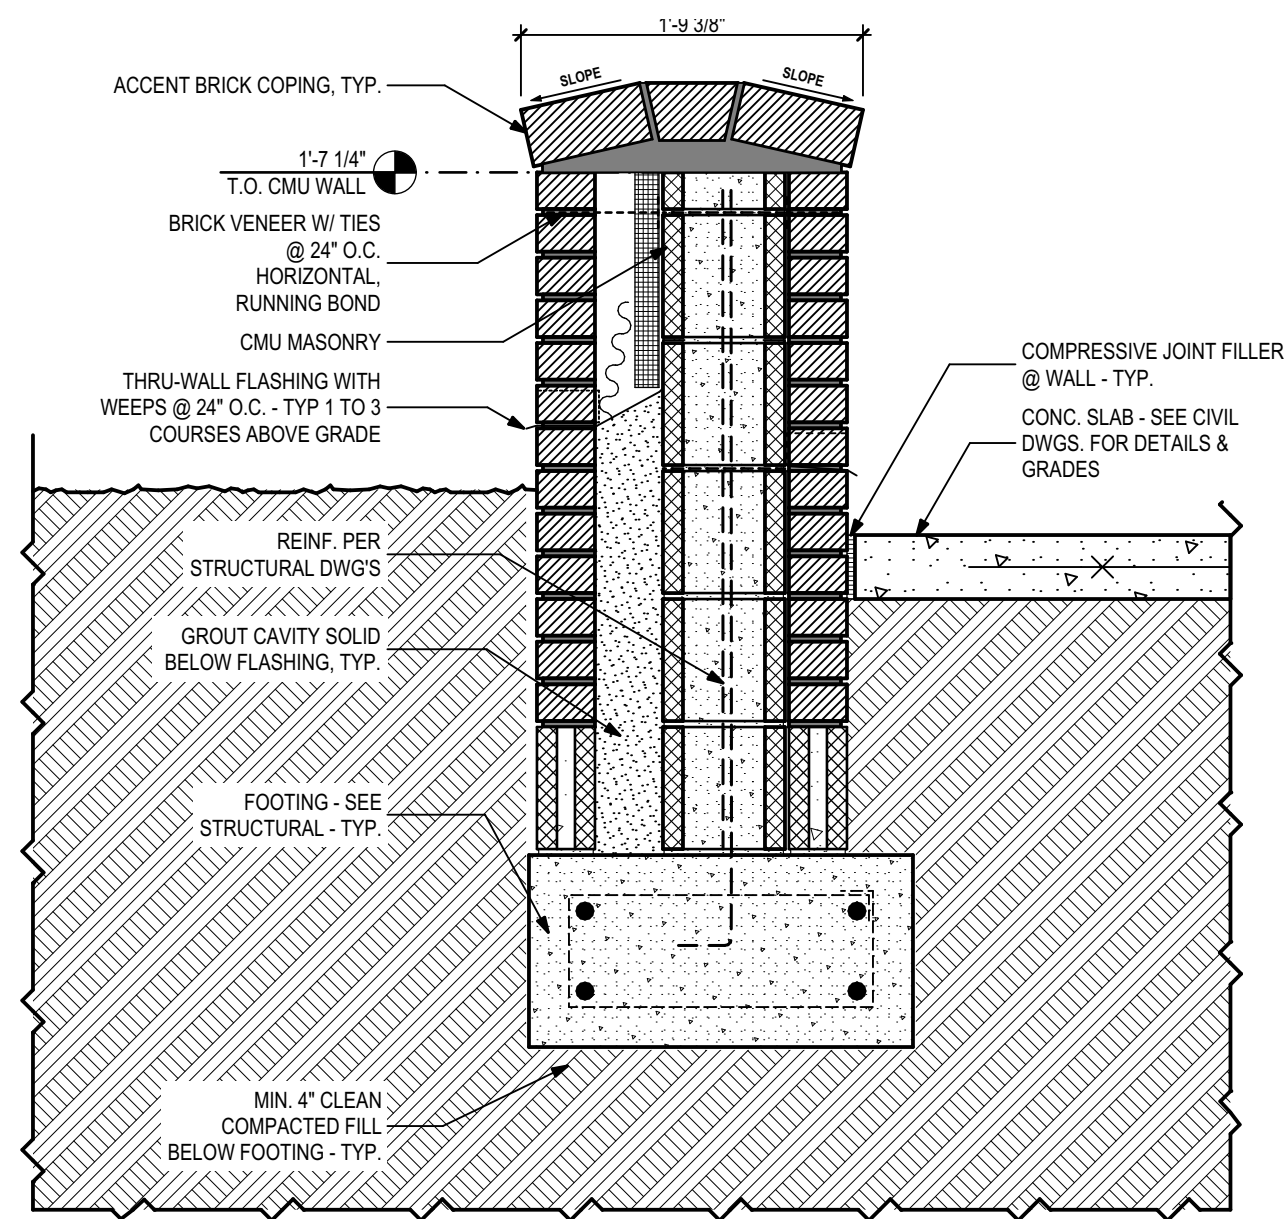


6 Band Room Low Wall Section

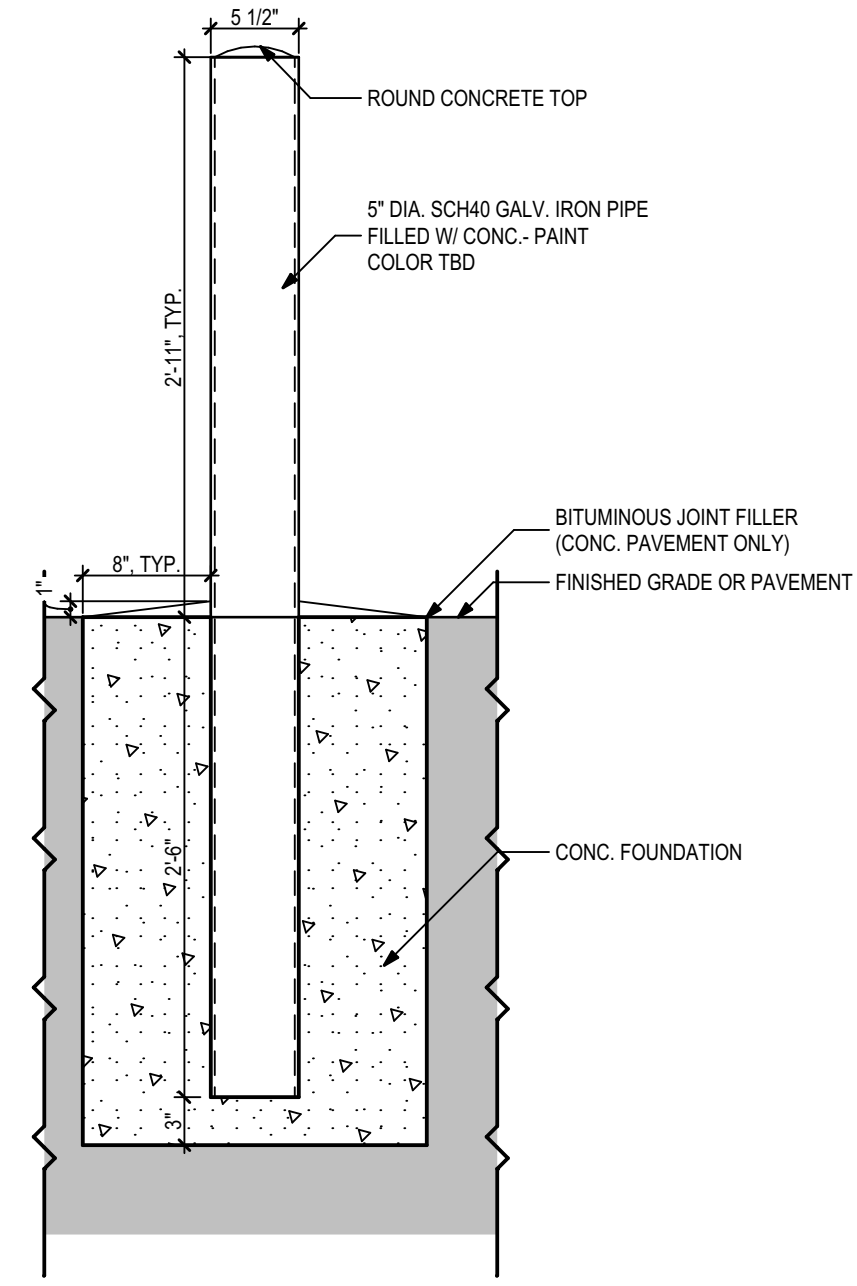


5 Typical Bollard Details

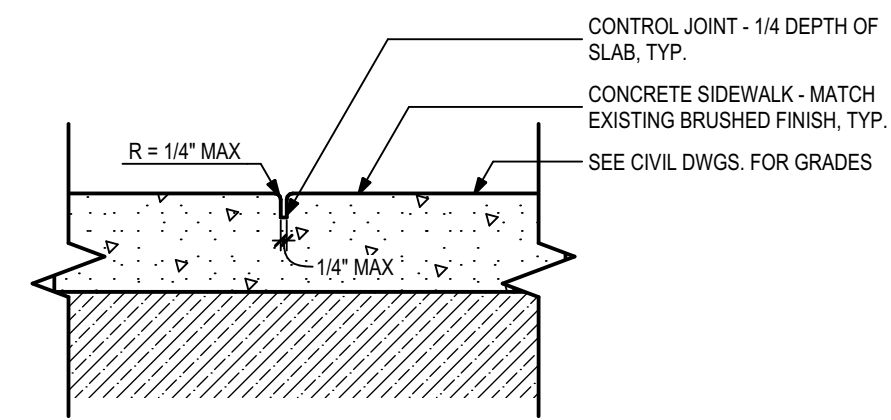


4 Typical Concrete Tooled Joint

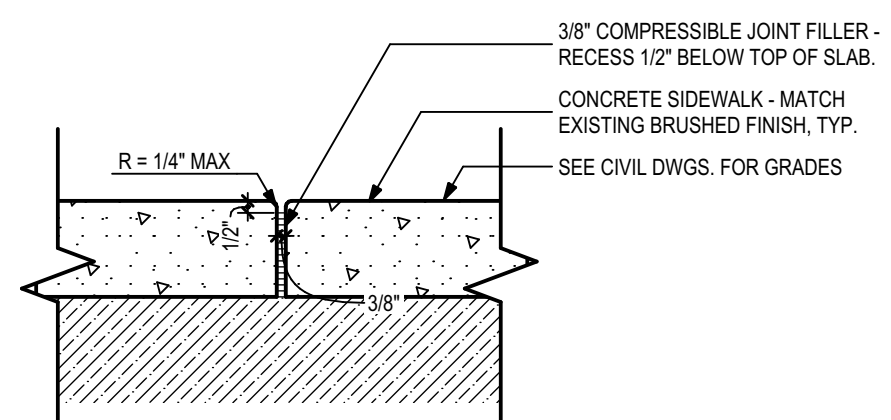


3 Typical Concrete Expansion Joint

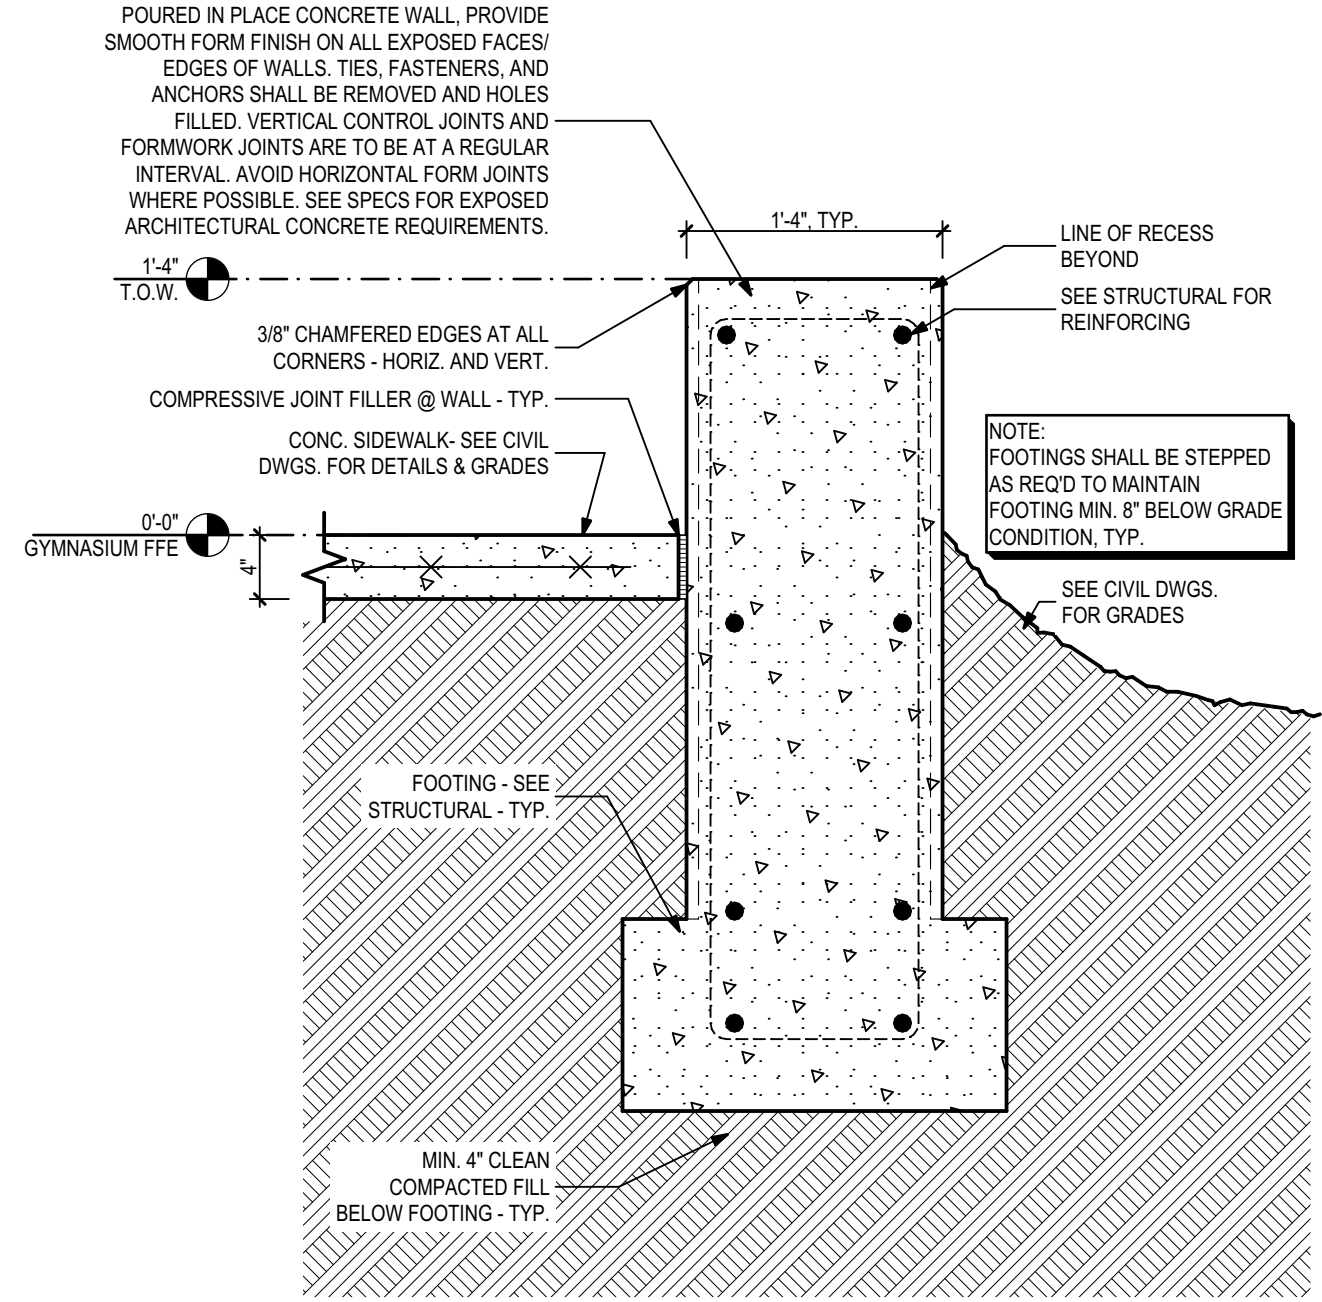

2 Low Seating Wall Section
1" = 1'-0"

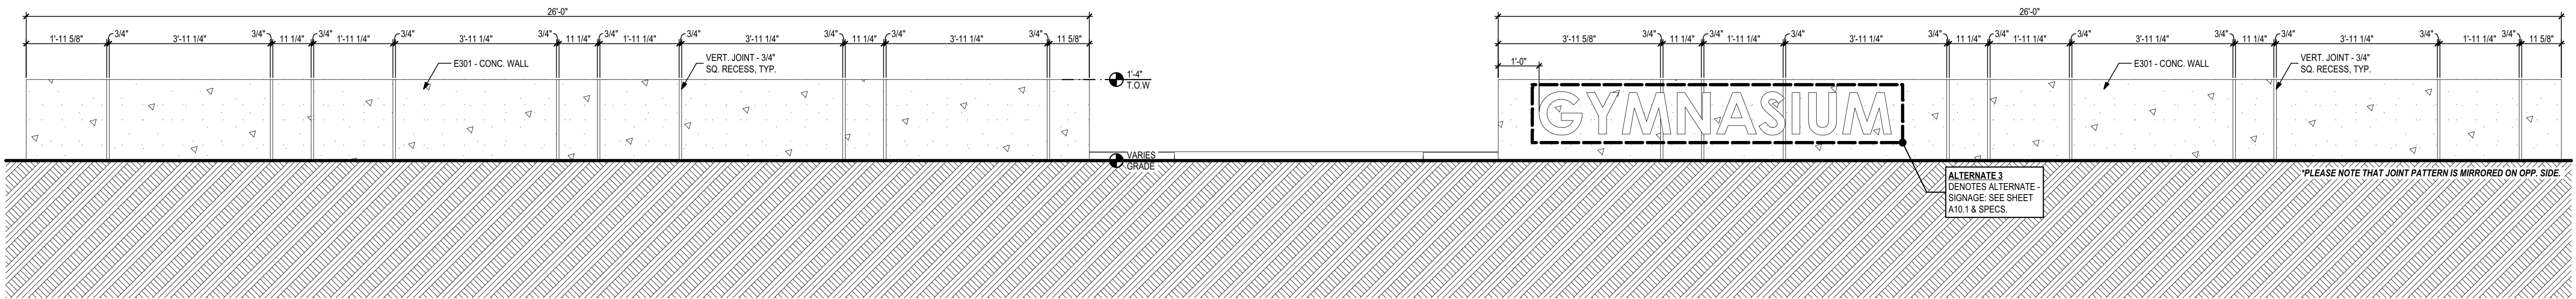


1 Low Entry Wall Elevation
1/2" = 1'-0"

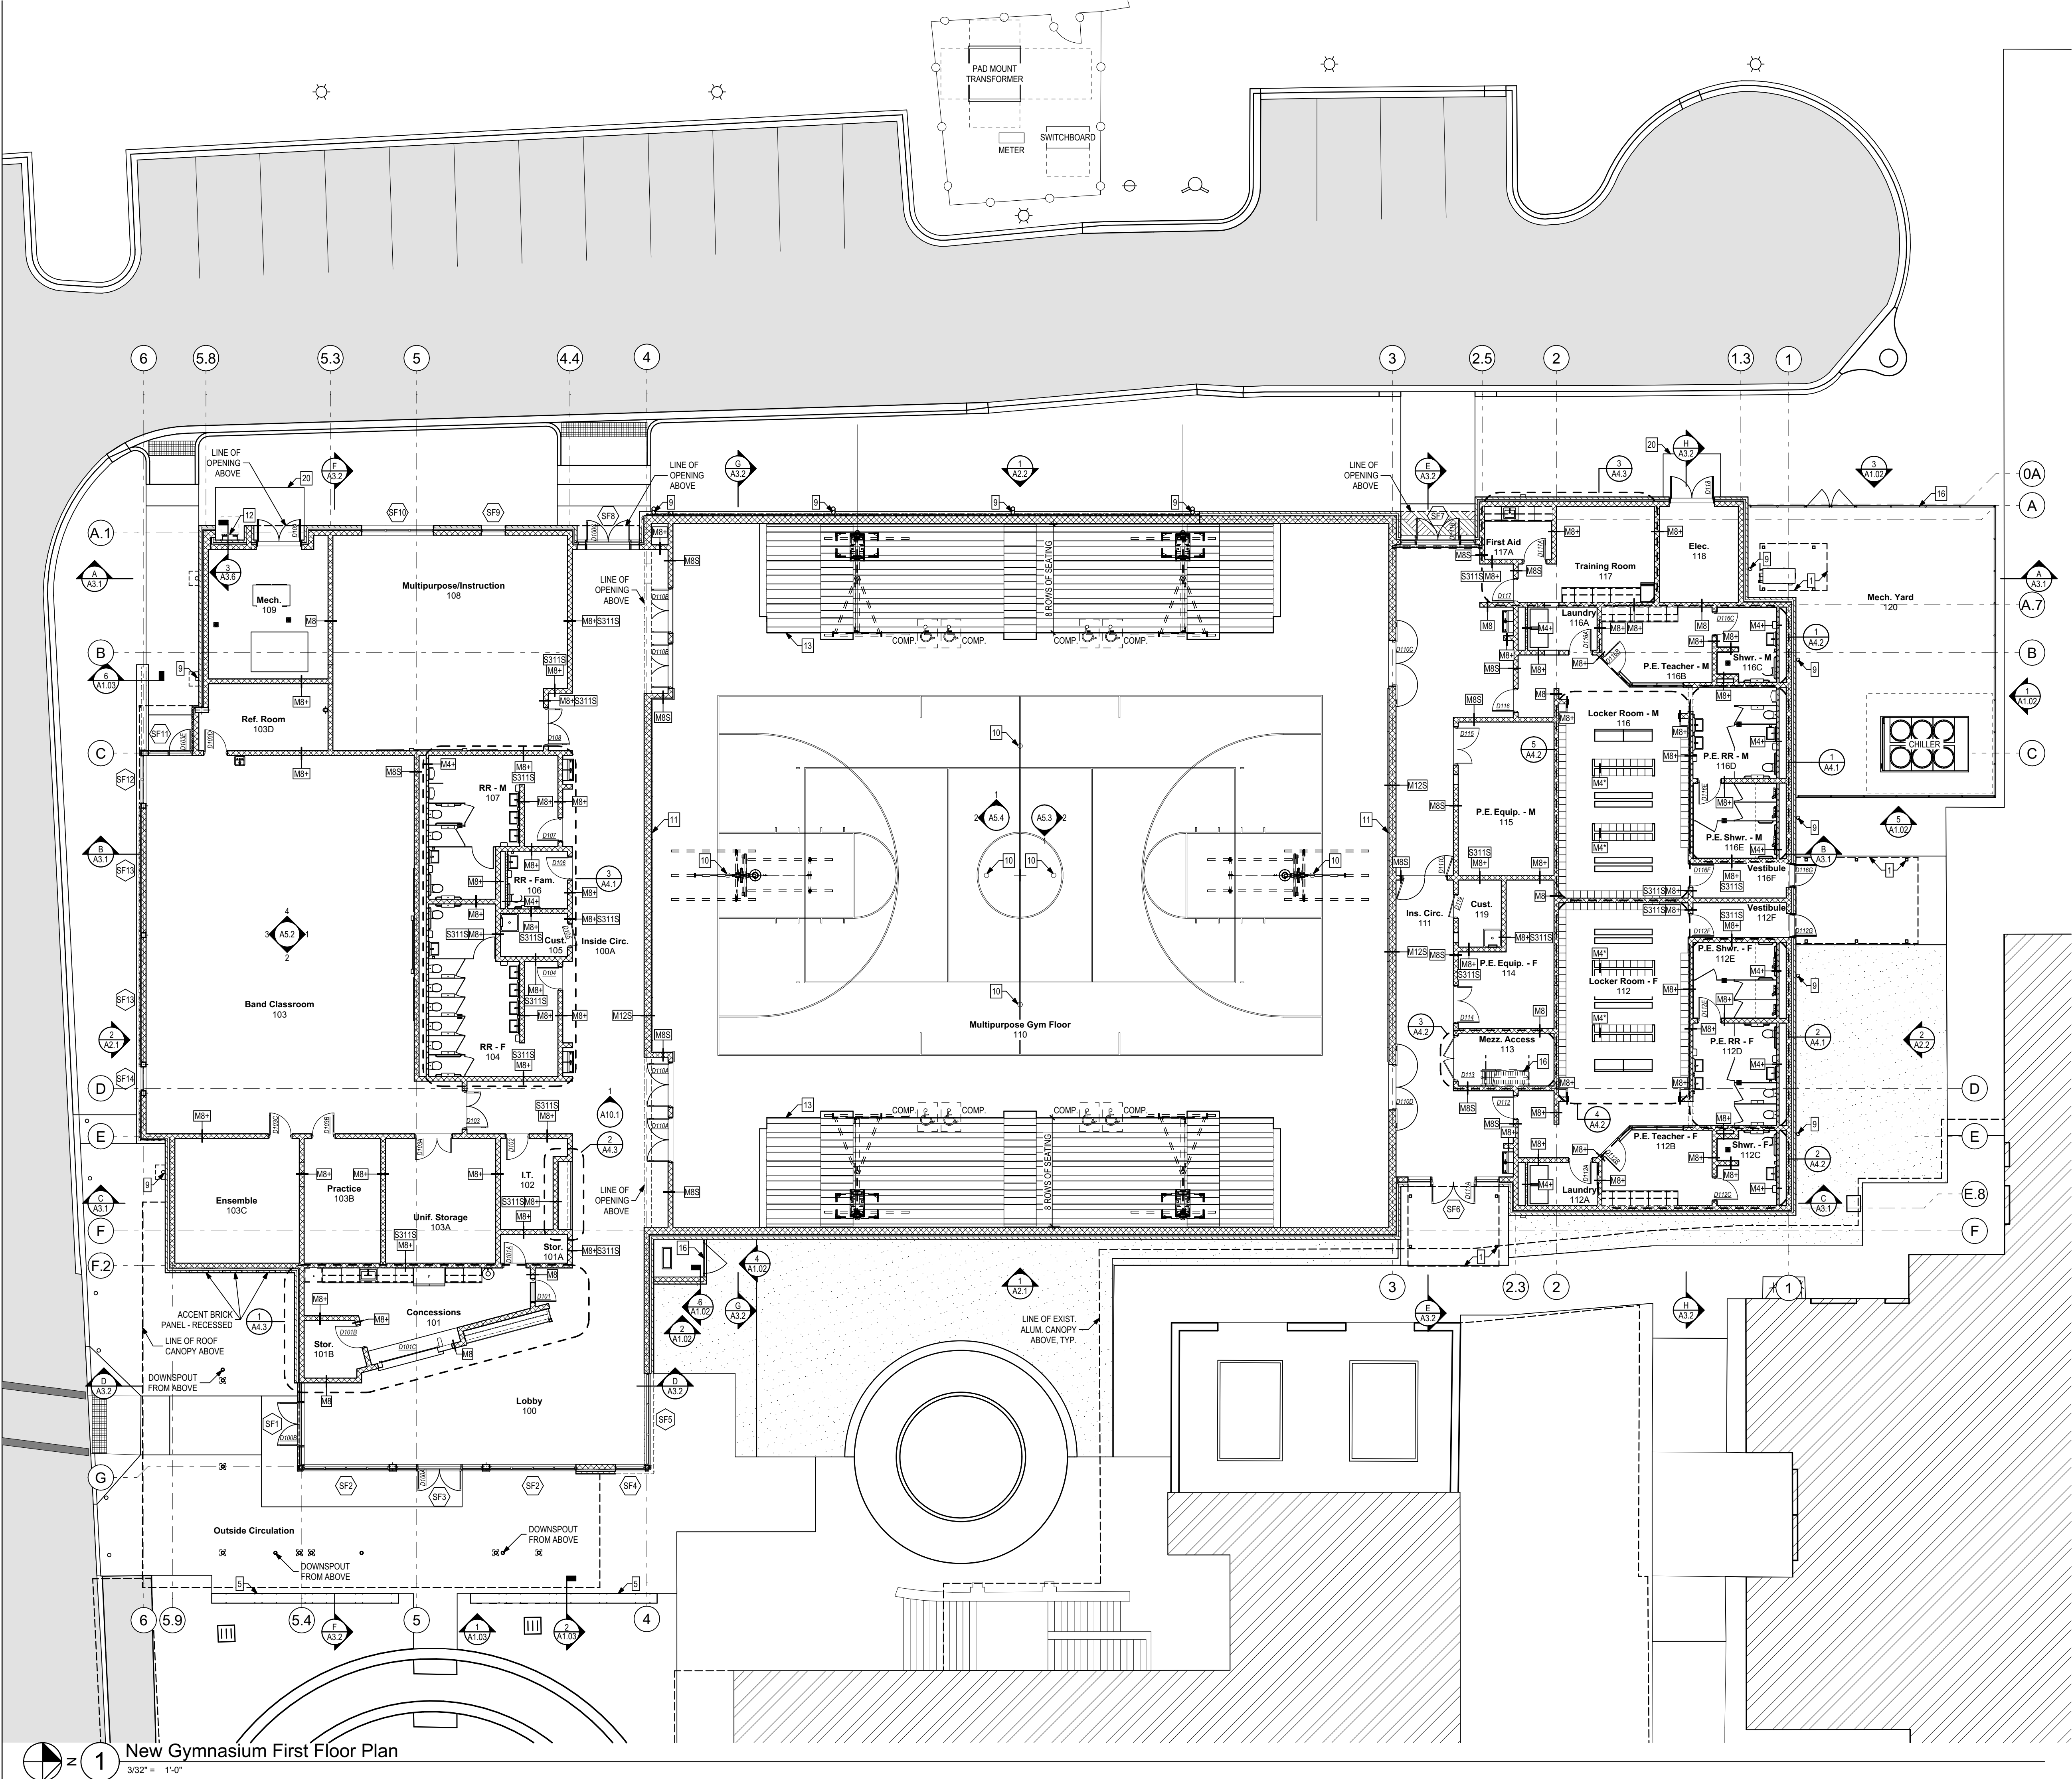

Construction Notes

- [X] REPRESENTS NOTE ON PLANS
- NEW PRE-ENGINEERED ALUMINUM OVERHEAD CANOPY - SEE SPECIFICATIONS.
 - SINGLE POST FRONT-FOLDING CEILING HUNG BASKETBALL BACKSTOP - BASIS OF DESIGN: GARED PSS MODEL 3103 - SEE ELECTRICAL PLANS AND SPECIFICATIONS
 - INDOOR SCOREBOARD - BASIS OF DESIGN: NEVCO MODELS 2700 & 2770 - SEE ELECTRICAL PLANS AND SPECIFICATIONS
 - WALL-MOUNTED INDOOR SOUND SYSTEM, SEE ELECTRICAL PLANS AND SPECIFICATIONS
 - LOW SEATING WALL - SEE SHEET A1.03 FOR DETAILS.
 - COMBINATION ROOF DRAIN & OVERFLOW - BASIS OF DESIGN: ZURN Z163
 - STRUCTURAL COLUMN BELOW
 - CARD READER LOCATION - SEE ELECTRICAL PLANS AND COORDINATE FOR DOOR HARDWARE.
 - 6" METAL DOWNSPOUT ASSEMBLY - SEE CIVIL DRAWINGS FOR CONTINUATION.
 - FLUSH MOUNTED FLOOR SLEEVE FOR VOLLEYBALL POST - BASIS OF DESIGN: GARED PSS 6400 W/ 6432 BRASS COVER TO USE W/ GARED 6000 SERIES VOLLEYBALL EQUIP., SEE SPECIFICATIONS
 - WALL PADDING - SEE SPECIFICATIONS
 - PROVIDE AND INSTALL OSHA COMPLIANT LADDER W/ 7'-0" TALL LOOKING STEEL LADDER SECURITY DOOR/LADDER GUARD TO ROOF - SEE SPECIFICATIONS.
 - ICC 300 COMPLIANT WALL ATTACHED POWERED TELESCOPIC BLEACHERS - BASIS OF DESIGN: MAXAM BY HUSSEY, SEE SPECIFICATIONS
 - PROVIDE AND INSTALL OSHA COMPLIANT ALUMINUM ALTERNATING TREAD STAIR TO MECH. MEZZANINE - BASIS OF DESIGN: GILMORE-KRAMER 68 DEGREE STEEP INCLINE STAIR - SEE SPECIFICATIONS.
 - NEW EXTERIOR GALVANIZED AND PAINTED GUARDRAIL/HANDRAIL - SEE SHEET FOR DETAILS.
 - NEW BLACK VINYL CHAIN-LINK FENCE - SEE SHEET A1.02 FOR DETAILS.
 - SINGLE POST REAR-FOLDING CEILING HUNG BASKETBALL BACKSTOP - BASIS OF DESIGN: GARED PSS MODEL 3105 - SEE ELECTRICAL PLANS AND SPECIFICATIONS
 - NEW PRE-FINISHED ALUM. CONDUCTOR HEAD W/ OVERFLOW.
 - NEW PRE-FINISHED ALUM. SEAMLESS GUTTER.
 - 4" REINFORCED CONCRETE WITH 8" TURN-DOWN EDGE W/ 4XW1.4 WIRE REINFORCING w/BROOMED FINISH - SLOPE AS SHOWN ON DRAWING.
 - PROVIDE AND INSTALL OSHA COMPLIANT REMOVABLE GUARDRAIL.
 - PROVIDE AND INSTALL GALV. STEEL COMMERCIAL ROOF ANCHOR.

Key Plan

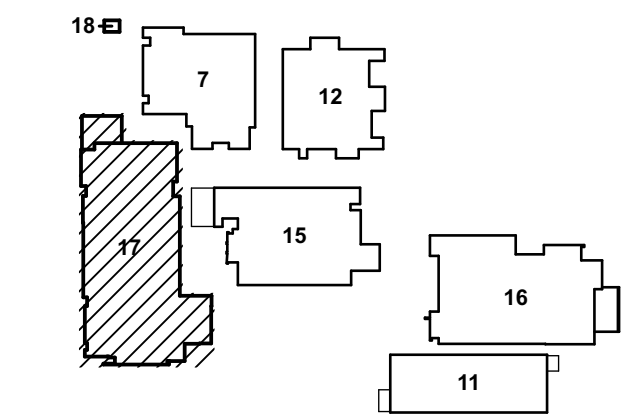

Drawing Legend

- | | |
|--------------------|---------------------------------|
| [Solid line] | NEW PARTITION |
| [Dashed line] | EXISTING CONSTRUCTION TO REMAIN |
| [Thick solid line] | NEW CONSTRUCTION |
| [Dotted line] | CONSTRUCTION ABOVE |
| [Thin solid line] | CONSTRUCTION BELOW |

PHASE:	DRAWN:	REVIEWED:	DATE:	ID:	REVISION:	DRAWN:	REVIEWED:	DATE:
CONCEPT SCHEM. DESIGN	BG/RS	C. WHITLOCK	10/8/2024					
DESIGN DEVELOPMENT	BG/RS/MS	C. WHITLOCK	12/20/2024					
EARLY DEMOLITION PACKAGE	BG/RS/MS	C. WHITLOCK	12/20/2024					
80% CONSTRUCTION DOCS	BG/RS/MS	R. LEWIS	03/21/2025					
PERMIT DOCS	BG/RS/MS	R. LEWIS	05/09/2025					
100% CONSTRUCTION DOCS	BG/RS/MS	R. LEWIS	05/09/2025					

LEON COUNTY SCHOOLS

Client:

Consultant:

Seal:

Leon County Schools

3420 W. Tharpe St., Suite 100

Tallahassee, FL 32303

Griffin Middle School - Phase 2

800 Alabama St. Tallahassee, FL 32304

Project #:

23483

Phase:

100% CDs


ALW

Architects Lewis + Whitlock
206 West Virginia St.
Tallahassee, Florida 32301
850.942.1718
www.think3d.net


Description:
**New Gymnasium
First Floor Plan**

Sheet No.:

A1.1

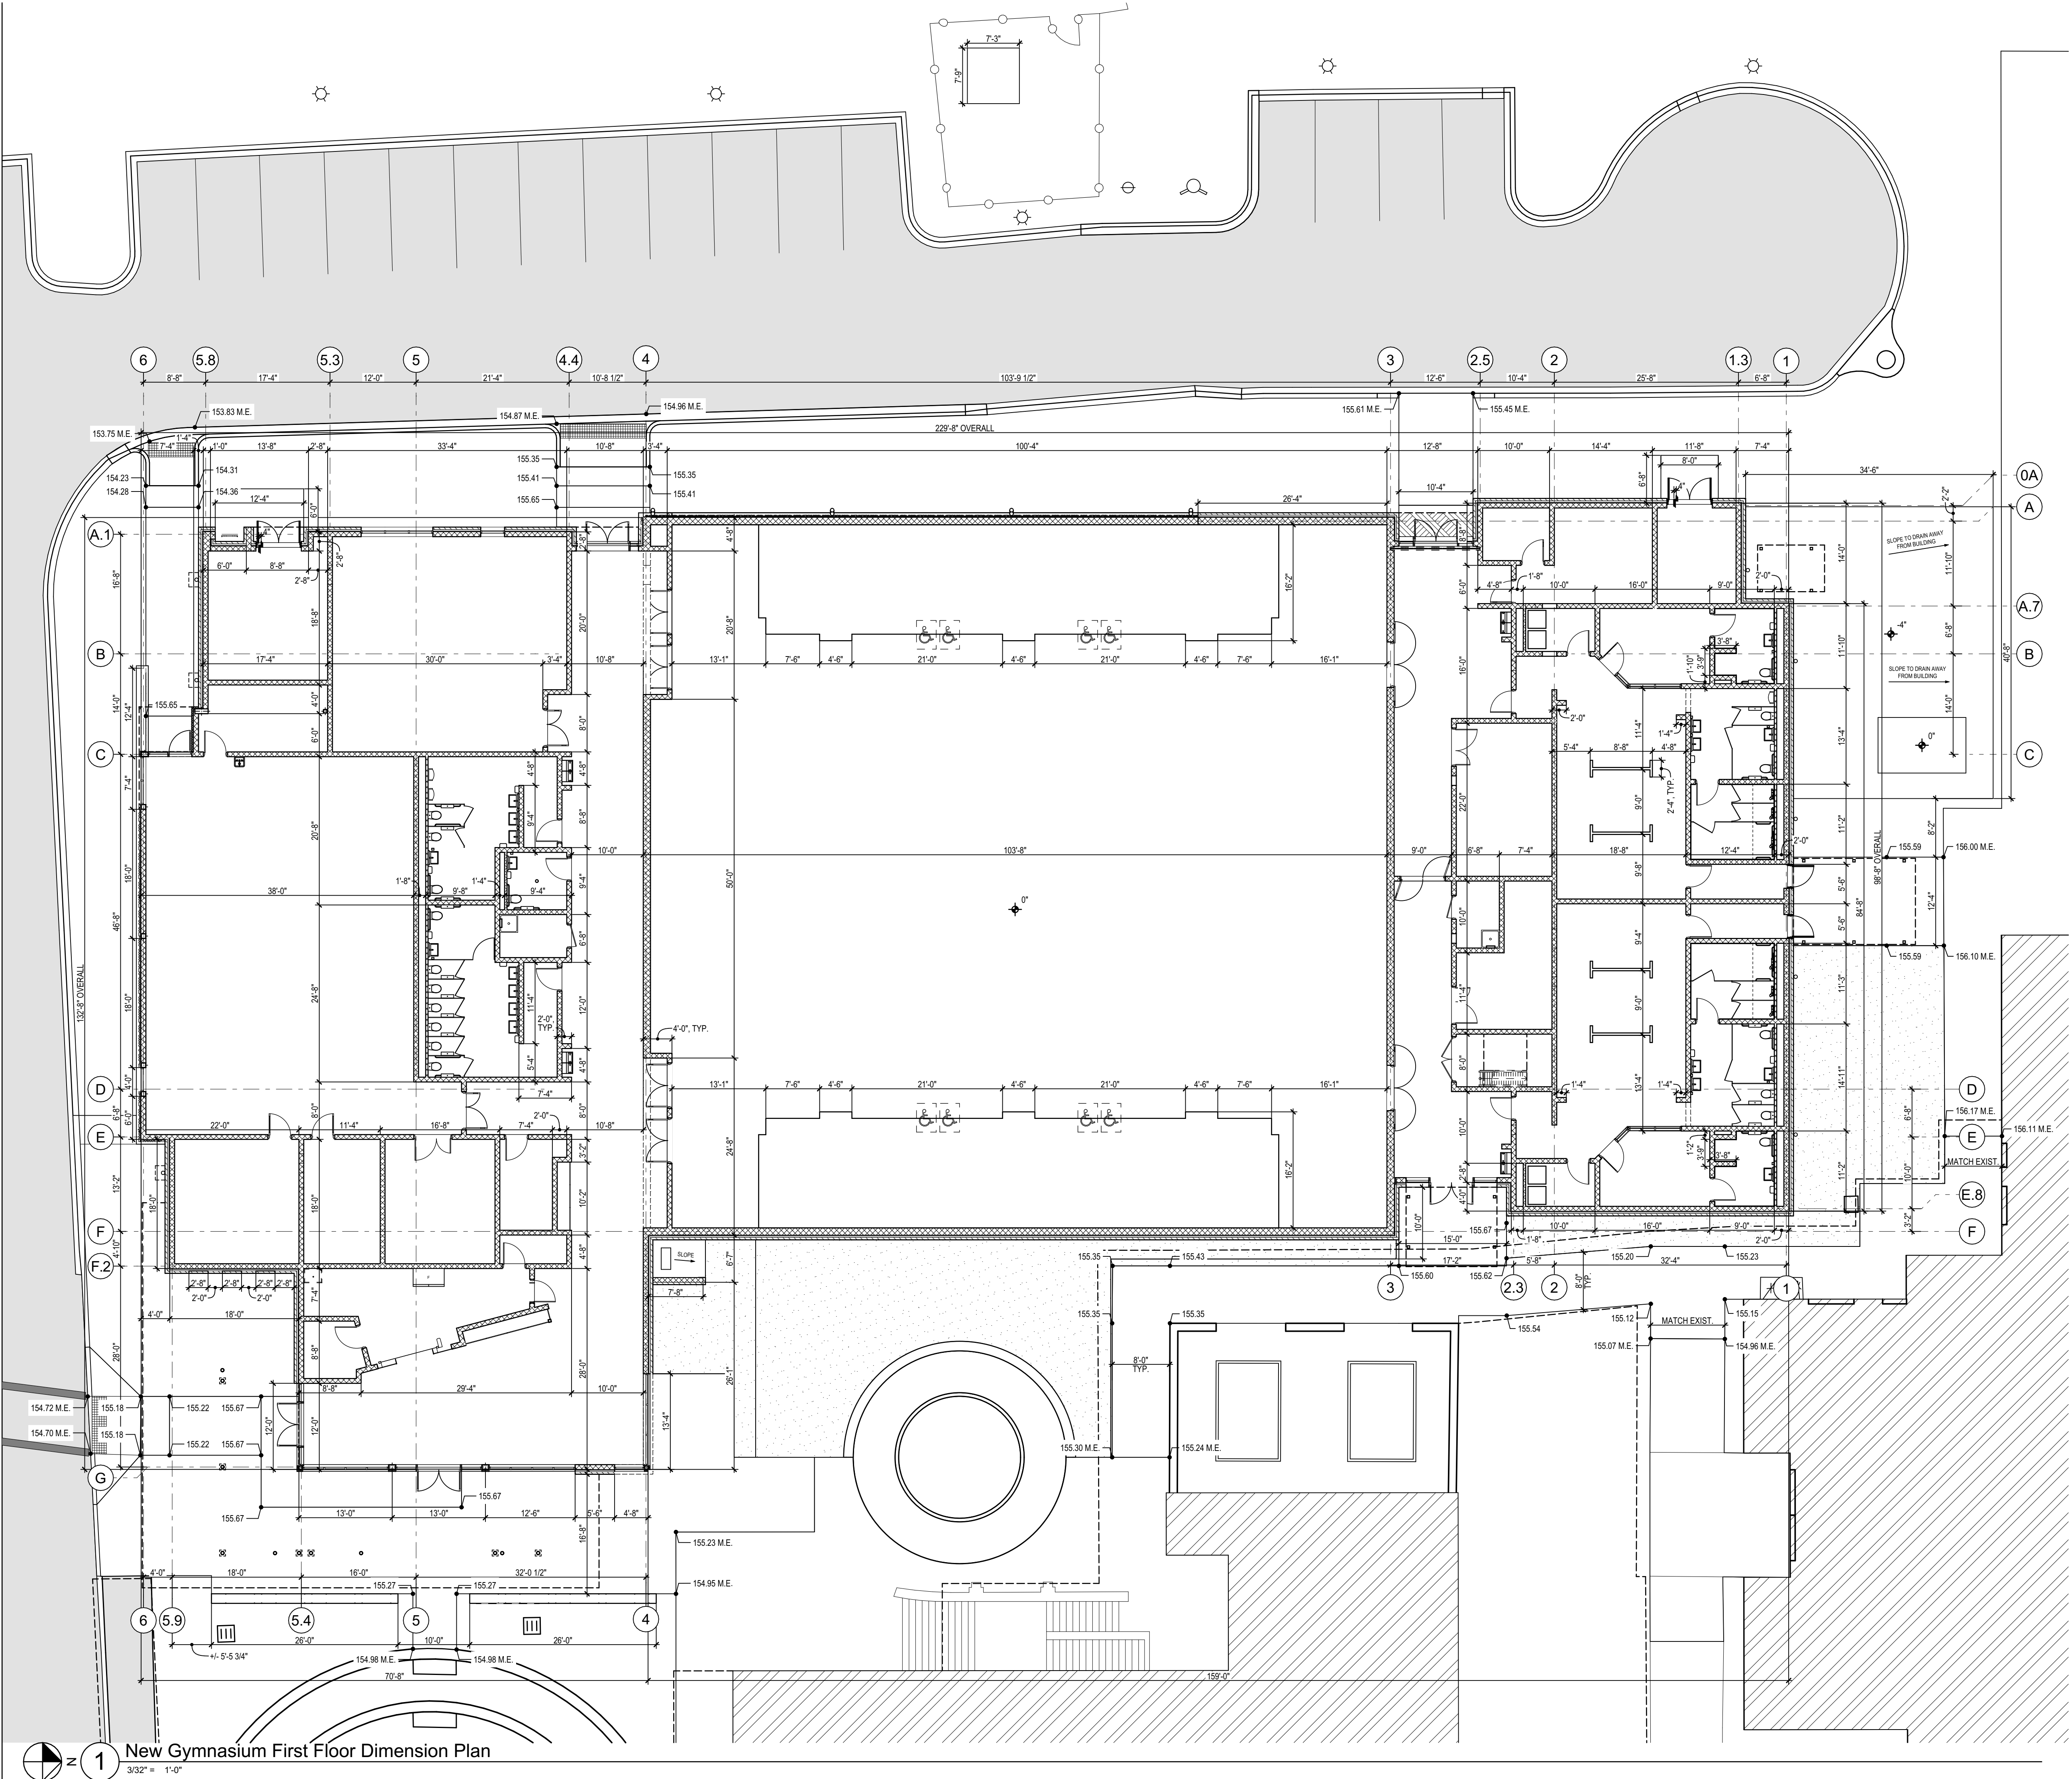

Key Plan

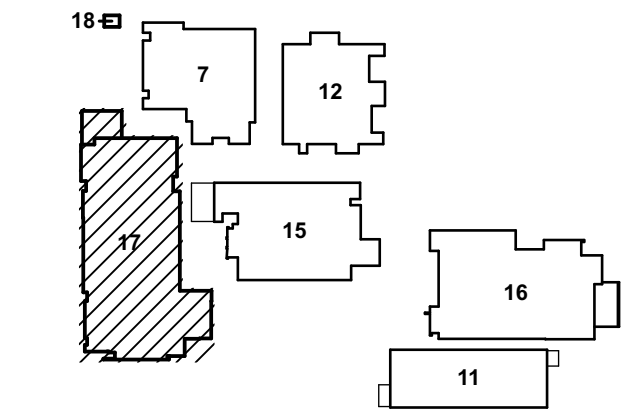

Drawing Legend

	NEW PARTITION
	EXISTING CONSTRUCTION TO REMAIN
	NEW CONSTRUCTION
	CONSTRUCTION ABOVE
	CONSTRUCTION BELOW

PHASE:	DRAWN:	REVIEWED:	DATE:	ID:	REVISION:	DRAWN:	REVIEWED:	DATE:
CONCEPT SCHEM DESIGN	BG/RS	C. WHITLOCK	10/8/2024					
DESIGN DEVELOPMENT	BG/RS/MS	C. WHITLOCK	12/20/2024					
EARLY DEMOLITION PACKAGE	BG/RS/MS	C. WHITLOCK	12/20/2024					
80% CONSTRUCTION DOCS	BG/RS/MS	R. LEWIS	03/21/2025					
PERMIT DOCS	BG/RS/MS	R. LEWIS	03/21/2025					
100% CONSTRUCTION DOCS	BG/RS/MS	R. LEWIS	06/09/2025					

THESE DRAWINGS AND RENDERINGS ARE INSTRUMENTS OF SERVICE. THE DRAWINGS AND ASSOCIATED COPIES THEREOF, INCLUDING ELECTRONIC MEDIA AND CAD FILES, ARE THE PROPERTY OF ARCHITECTS LEWIS + WHITLOCK, P.A. THEIR USE, REPRESENTATION OR REPRODUCTION FOR ANY PURPOSE EXCEPT BY WRITTEN AGREEMENT WITH THE ARCHITECT IS PROHIBITED. THIS COPYRIGHT NOTIFICATION SHALL BE TRUE AS F DIRECTLY PLACED ON EACH DRAWING EXHIBIT, OVERLAPPING ON THIS DOCUMENT AND SHALL NOT BE REMOVED FROM THESE DOCUMENTS.

Client:	Leon County Schools
Consultant:	Griffin Middle School - Phase 2 3420 W. Tharpe St., Suite 100 Tallahassee, FL 32303
Project #:	23483
Phase:	100% CDs
Job Title:	Griffin Middle School - Phase 2 800 Alabama St. Tallahassee, FL 32304

ALW

Architects Lewis + Whitlock
206 West Virginia St.
Tallahassee, Florida 32301
850.942.1718
www.think3d.net

Description:
**New Gymnasium
First Floor
Dimension Plan**

Sheet No.:
A1.1a



1 New Gymnasium Mechanical Mezzanine Floor Plan

3/32" = 1'-0"

VERTICAL LEADER SIZING CALCULATIONS:

AREA 1:

Roof Area = 1,196 sq. ft.
Rainfall Intensity = 8 inches per hour
Total Gallons = 1,196 sq. ft. $\times$ 8 in/hr $\times$ 0.623 = 5,960.64 gallons per hour
GPM = 5,960.64 gallons per hour $\div$ 60 = 99.34 GPM
Downspout Size/Capacity Provided: 6" round @ 600 GPM max.

AREA 2:

Roof Area = 1,196 sq. ft.
Rainfall Intensity = 8 inches per hour
Total Gallons = 1,196 sq. ft. $\times$ 8 in/hr $\times$ 0.623 = 5,960.64 gallons per hour
GPM = 5,960.64 gallons per hour $\div$ 60 = 99.34 GPM
Downspout Size/Capacity Provided: 6" round @ 600 GPM max.

CUMULATIVE AREA 3:

Roof Area = 3,688 sq. ft.
Rainfall Intensity = 8 inches per hour
Total Gallons = 3,688 sq. ft. $\times$ 8 in/hr $\times$ 0.623 = 18,407.30 gallons per hour
GPM = 18,407.30 gallons per hour $\div$ 60 = 306.79 GPM
Downspout Size/Capacity Provided: 6" round @ 600 GPM max.

CUMULATIVE AREA 4:

Roof Area = 3,300 sq. ft.
Rainfall Intensity = 8 inches per hour
Total Gallons = 3,300 sq. ft. $\times$ 8 in/hr $\times$ 0.623 = 16,451.04 gallons per hour
GPM = 16,451.04 gallons per hour $\div$ 60 = 274.18 GPM
Downspout Size/Capacity Provided: 6" round @ 600 GPM max.

CUMULATIVE AREA 5:

Roof Area = 2,089 sq. ft.
Rainfall Intensity = 8 inches per hour
Total Gallons = 2,089 sq. ft. $\times$ 8 in/hr $\times$ 0.623 = 10,421.10 gallons per hour
GPM = 10,421.10 gallons per hour $\div$ 60 = 173.68 GPM
Downspout Size/Capacity Provided: 4" round PVC @ 92 GPM max.

AREA 6:

Roof Area = 544 sq. ft.
Rainfall Intensity = 8 inches per hour
Total Gallons = 544 sq. ft. $\times$ 8 in/hr $\times$ 0.623 = 2,717.76 gallons per hour
GPM = 2,717.76 gallons per hour $\div$ 60 = 45.30 GPM
Downspout Size/Capacity Provided: 3" round PVC @ 92 GPM max.

VERTICAL LEADER SIZING CALCULATIONS (CONT.):

AREA 8:

Roof Area = 640 sq. ft.
Rainfall Intensity = 8 inches per hour
Total Gallons = 640 sq. ft. $\times$ 8 in/hr $\times$ 0.623 = 3,185.28 gallons per hour
GPM = 3,185.28 gallons per hour $\div$ 60 = 53.08 GPM
Downspout Size/Capacity Provided: 3" round PVC @ 92 GPM max.

AREA 10:

Roof Area = 726 sq. ft.
Rainfall Intensity = 8 inches per hour
Total Gallons = 726 sq. ft. $\times$ 8 in/hr $\times$ 0.623 = 3,620.90 gallons per hour
GPM = 3,620.90 gallons per hour $\div$ 60 = 60.35 GPM
Downspout Size/Capacity Provided: 6" round @ 600 GPM max.

AREA 11:

Roof Area = 726 sq. ft.
Rainfall Intensity = 8 inches per hour
Total Gallons = 726 sq. ft. $\times$ 8 in/hr $\times$ 0.623 = 3,620.90 gallons per hour
GPM = 3,620.90 gallons per hour $\div$ 60 = 60.35 GPM
Downspout Size/Capacity Provided: 6" round @ 600 GPM max.

AREA 12:


Roof Area = 1,071 sq. ft.
Rainfall Intensity = 8 inches per hour
Total Gallons = 1,071 sq. ft. $\times$ 8 in/hr $\times$ 0.623 = 5,334.34 gallons per hour
GPM = 5,334.34 gallons per hour $\div$ 60 = 88.91 GPM
Downspout Size/Capacity Provided: 6" round @ 600 GPM max.

AREA 7:

Roof Area = 464 sq. ft.
Rainfall Intensity = 8 inches per hour
Total Gallons = 464 sq. ft. $\times$ 8 in/hr $\times$ 0.623 = 2,314.62 gallons per hour
GPM = 2,314.62 gallons per hour $\div$ 60 = 38.58 GPM
Downspout Size/Capacity Provided: 6" round @ 600 GPM max.

AREA 8:


Roof Area = 688 sq. ft.
Rainfall Intensity = 8 inches per hour
Total Gallons = 688 sq. ft. $\times$ 8 in/hr $\times$ 0.623 = 3,425.44 gallons per hour
GPM = 3,425.44 gallons per hour $\div$ 60 = 57.09 GPM
Downspout Size/Capacity Provided: 6" round @ 600 GPM max.

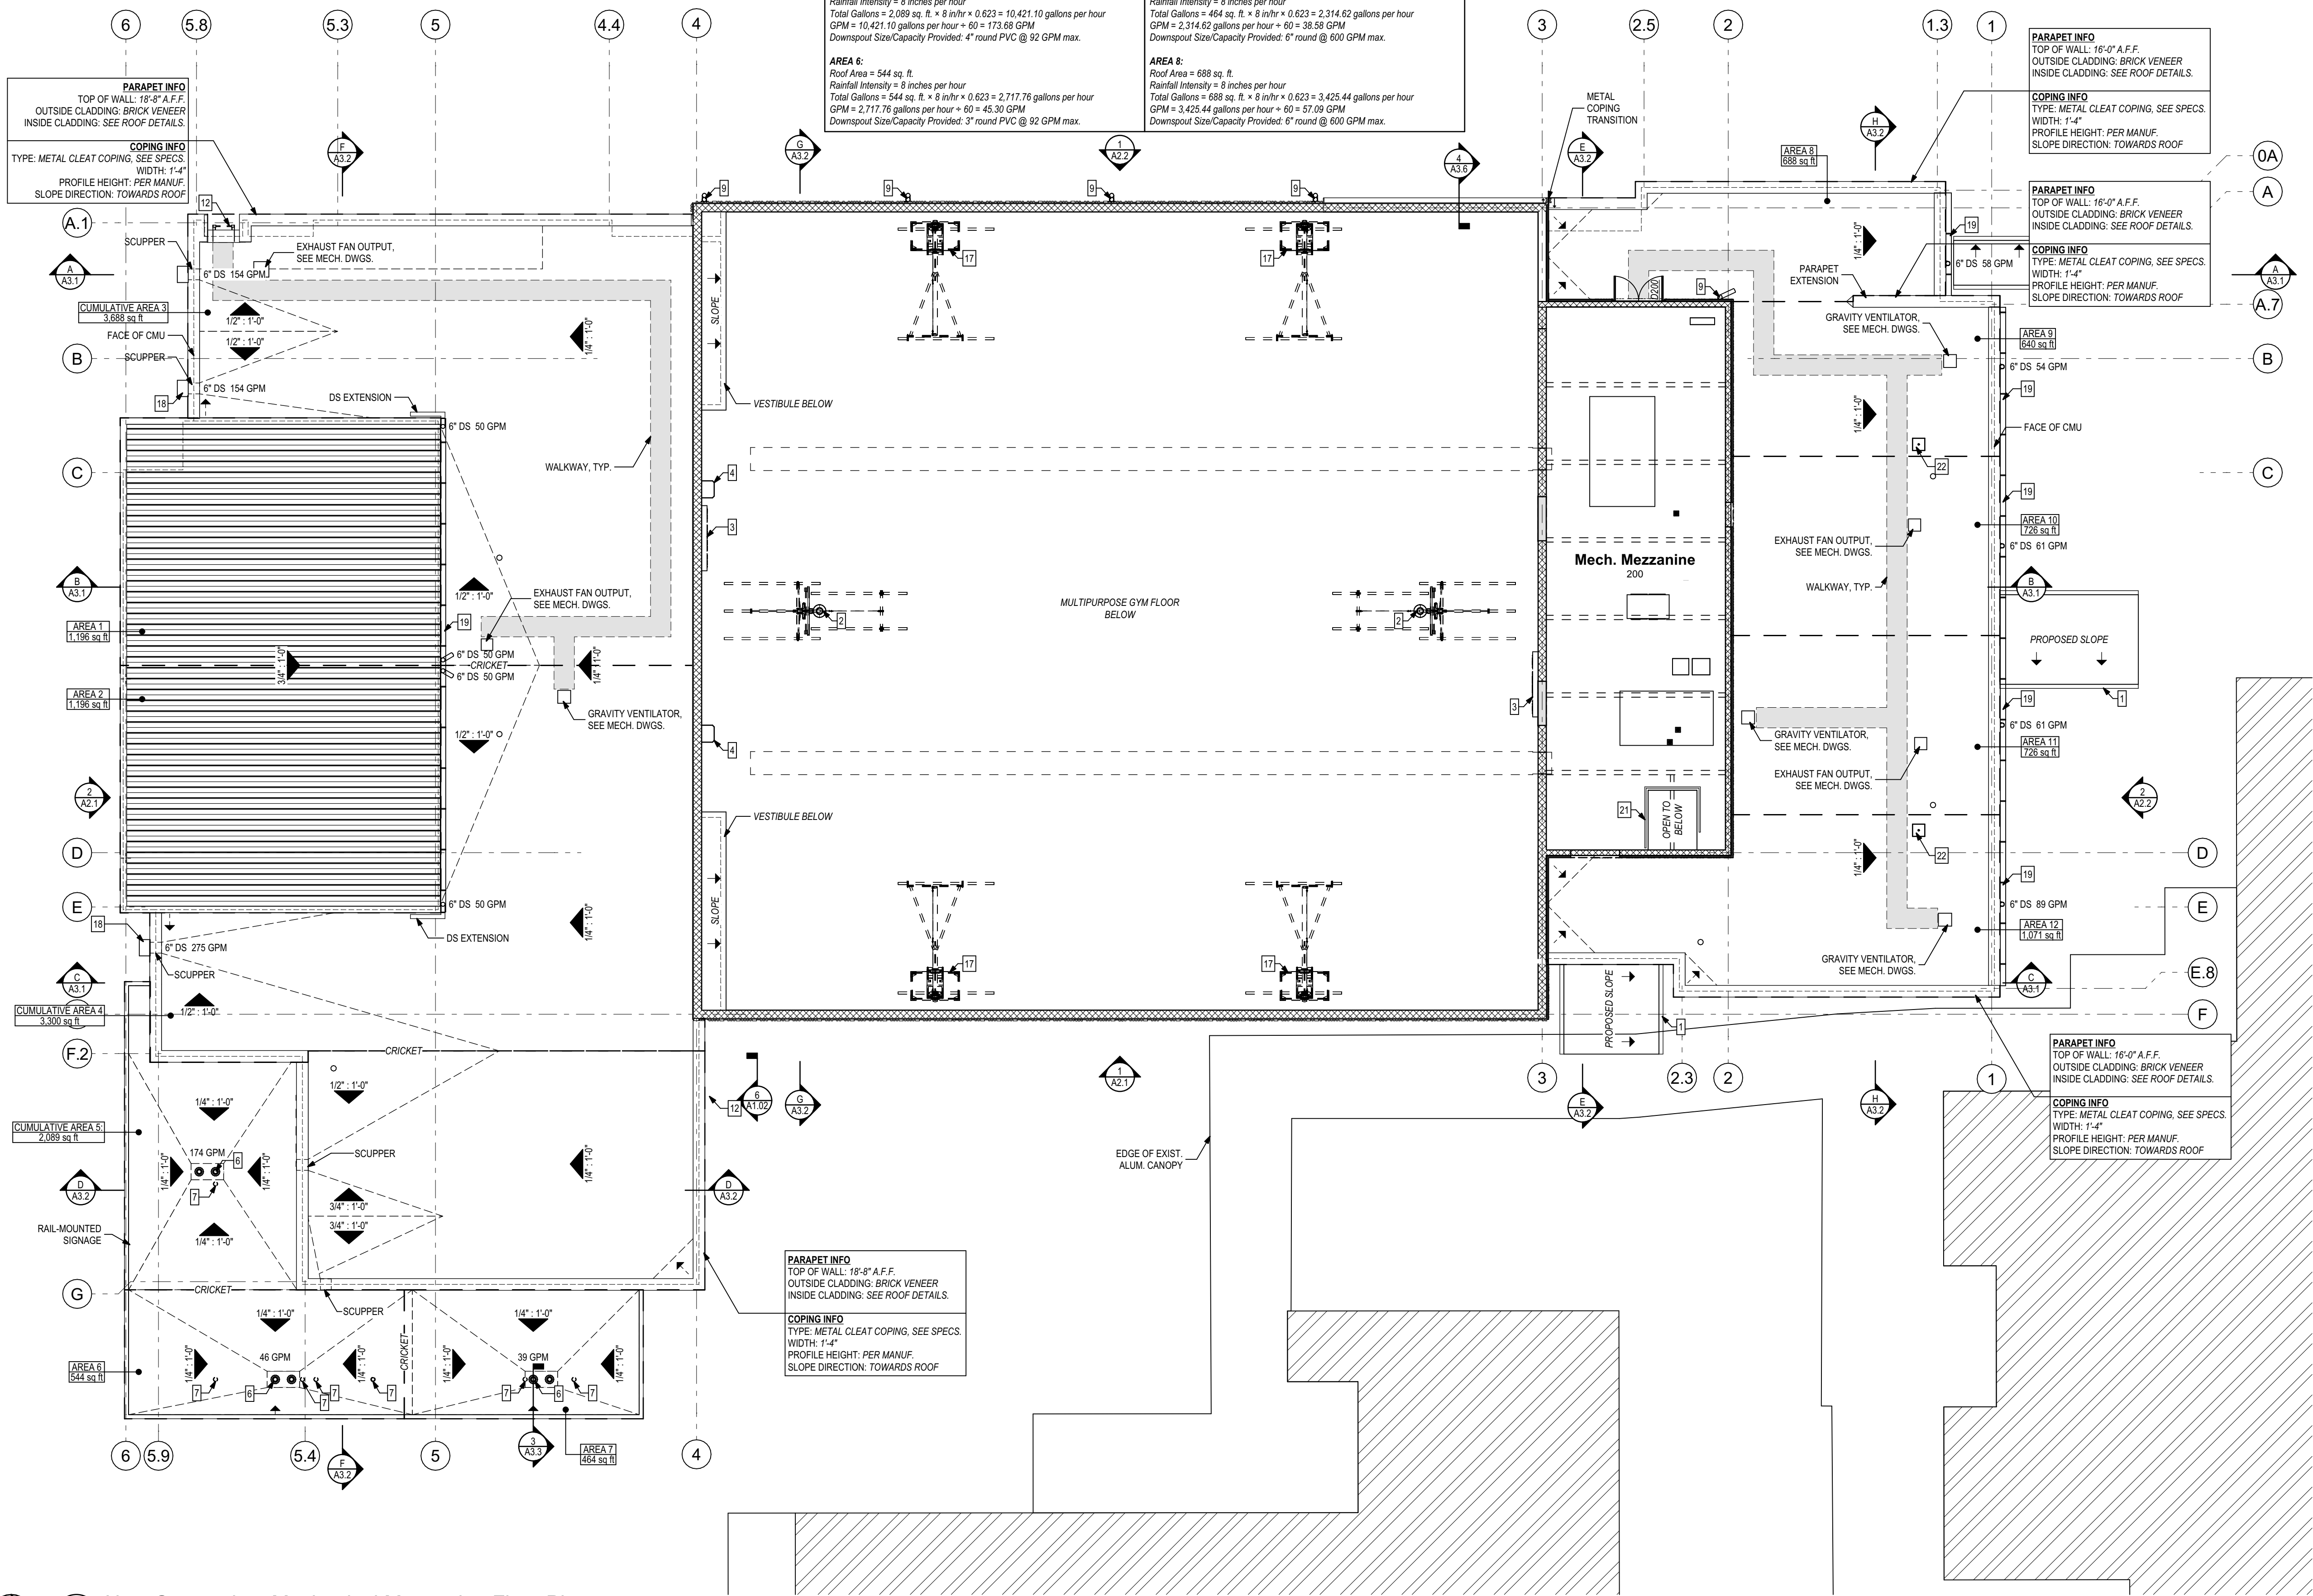

Construction Notes

SEE SHEET A1.1 FOR CONSTRUCTION NOTES.

Key Plan

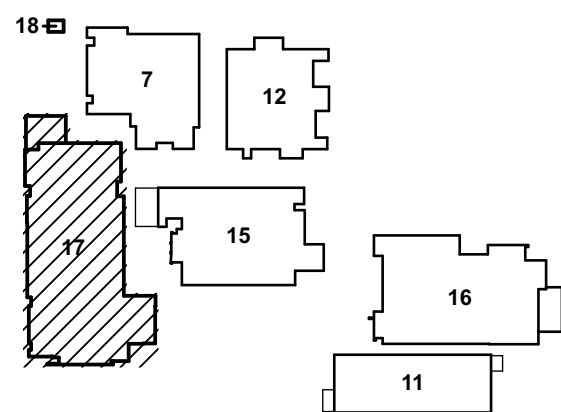

Drawing Legend

- NEW PARTITION
- EXISTING CONSTRUCTION TO REMAIN
- NEW CONSTRUCTION
- CONSTRUCTION ABOVE
- CONSTRUCTION BELOW

PHASE:	DRAWN:	REVIEWED:	DATE:	ID:	REVISION:	DRAWN:	REVIEWED:	DATE:
CONCEPT SCHEM. DESIGN	BG/RS	C. WHITLOCK	10/8/2024					
DESIGN DEVELOPMENT	BG/RS/MS	C. WHITLOCK	12/20/2024					
EARLY DEMOLITION PACKAGE	BG/RS/MS	C. WHITLOCK	12/20/2024					
80% CONSTRUCTION DOCS	BG/RS/MS	R. LEWIS	03/21/2025					
PERMIT DOCS	BG/RS/MS	R. LEWIS	05/09/2025					
100% CONSTRUCTION DOCS	BG/RS/MS	R. LEWIS	05/09/2025					

Client: Leon County Schools
3420 W. Tharpe St., Suite 100
Tallahassee, FL 32303

Job Title: Griffin Middle School - Phase 2
800 Alabama St. Tallahassee, FL 32304

Consultant: 23483
Project #: 100% CDs


Seal:

ALW
Architects Lewis + Whitlock
206 West Virginia St.
Tallahassee, Florida 32301
850.942.1718
www.think3d.net

Description:
**New Gymnasium
Mech. Mezzanine
Floor Plan**

Sheet No.:

A1.2

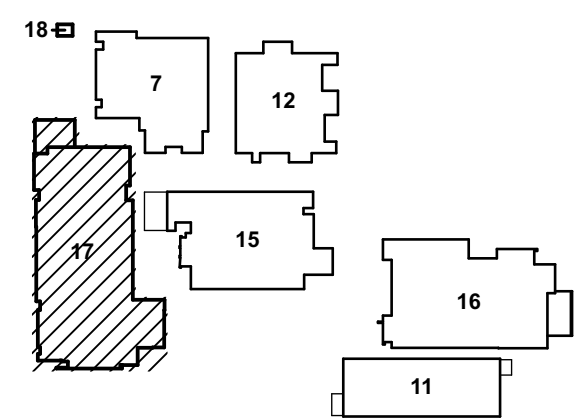

Drawing Legend

	NEW PARTITION
	EXISTING CONSTRUCTION TO REMAIN
	NEW CONSTRUCTION
	CONSTRUCTION ABOVE
	CONSTRUCTION BELOW

deal:

Client:

Leon County Schools
3420 W. Tharpe St., Suite 100
Tallahassee, FL 32303

Job Title: **Griffin Middle School - Phase 2**
800 Alabama St. Tallahassee, FL 32304

Consultant:

Project #: **23483**
Phase: **100% CDs**

Description:

New Gymnasium Mech. Mezzanine Dimension Plan


Sheet No.:

A1.2a

PHASE:	DRAWN:	REVIEWED:	DATE:	ID:	DRAWN:	REVIEWED:	DATE:
CONCEPT SCHEM DESIGN	BOJ/RS	C. WHITLOCK	10/18/2024				
SCHEM DEVELOPMENT	BOJ/RS/MS	C. WHITLOCK	12/20/2024				
EARLY REMEDIATION PACKAGE							
80% CONSTRUCTION DOCS	BOJ/RS/MS	R. LEWIS	03/21/2025				
PERMIT DOCS							
100% CONSTRUCTION DOCS	BOJ/RS/MS	R. LEWIS	05/09/2025				

THESE DRAWINGS AND REMENDERS ARE INSTRUMENTS OF SERVICE. THE DRAWINGS AND ASSOCIATED COPIES THEREOF, INCLUDING ELECTRONIC MEDIA AND CAD FILES ARE THE PROPERTY OF ARCHITECTS LEWIS + WHITLOCK. HAS THEIR USE, REPRESENTATION OR REPRODUCTION FOR ANY PURPOSE, WITHOUT THE WRITTEN PERMISSION OF ARCHITECTS LEWIS + WHITLOCK, SHALL BE PROHIBITED. ANY SUCH USE OR REPRODUCTION WITHOUT WRITTEN PERMISSION SHALL BE AT THE USER'S SOLE RISK AND WITHOUT LIABILITY TO ARCHITECTS LEWIS + WHITLOCK. ANY SUCH USE OR REPRODUCTION WITHOUT WRITTEN PERMISSION SHALL BE REMOVED FROM THESE DOCUMENTS.

THESE DRAWINGS AND RENDERINGS ARE INSTRUMENTS OF SERVICE. THE DRAWINGS AND ASSOCIATED COPIES THEREOF, INCLUDING ELECTRONIC, MEDIA AND CAD FILES, ARE THE PROPERTY OF ARCHITECT'S LEWIS + WHITLOCK P.L.L.C. THEIR USE, REPRESENTATION OR REPRODUCTION FOR ANY PURPOSE EXCEPT BY WRITTEN AGREEMENT WITH THE ARCHITECT IS PROHIBITED. THIS COPYRIGHT NOTIFICATION SHALL BE TRUE & DIRECTLY PLACED ON EACH DRAWING EXHIBIT OR RENDERING ON THIS DOCUMENT AND SHALL NOT BE REMOVED FROM THESE DOCUMENTS.

 


1

New Gymnasium Roof Plan

3/32" = 1'-0"


VERTICAL LEADER SIZING CALCULATIONS:	
AREA 13:	
Roof Area = 1,420 sq. ft.	
Rainfall Intensity = 8 inches per hour	
Total Gallons = 1,420 sq. ft. x 8 in/hr x 0.623 = 7,079.36 gallons per hour	
GPM = 7,079.36 gallons per hour ÷ 60 = 117.99 GPM	
Downspout Size/Capacity Provided: 6" round @ 600 GPM max.	
AREA 14:	
Roof Area = 2,510 sq. ft.	
Rainfall Intensity = 8 inches per hour	
Total Gallons = 2,510 sq. ft. x 8 in/hr x 0.623 = 12,496.48 gallons per hour	
GPM = 12,496.48 gallons per hour ÷ 60 = 208.28 GPM	
Downspout Size/Capacity Provided: 6" round @ 600 GPM max.	
AREA 15:	
Roof Area = 2,514 sq. ft.	
Rainfall Intensity = 8 inches per hour	
Total Gallons = 2,514 sq. ft. x 8 in/hr x 0.623 = 12,547.90 gallons per hour	
GPM = 12,547.90 gallons per hour ÷ 60 = 209.13 GPM	
Downspout Size/Capacity Provided: 6" round @ 600 GPM max.	
AREA 16:	
Roof Area = 4,145 sq. ft.	
Rainfall Intensity = 8 inches per hour	
Total Gallons = 4,145 sq. ft. x 8 in/hr x 0.623 = 20,673.84 gallons per hour	
GPM = 20,673.84 gallons per hour ÷ 60 = 344.56 GPM	
Downspout Size/Capacity Provided: 6" round @ 600 GPM max.	
AREA 17:	
Roof Area = 1,555 sq. ft.	
Rainfall Intensity = 8 inches per hour	
Total Gallons = 1,555 sq. ft. x 8 in/hr x 0.623 = 7,734.24 gallons per hour	
GPM = 7,734.24 gallons per hour ÷ 60 = 128.90 GPM	
Downspout Size/Capacity Provided: 6" round @ 600 GPM max.	

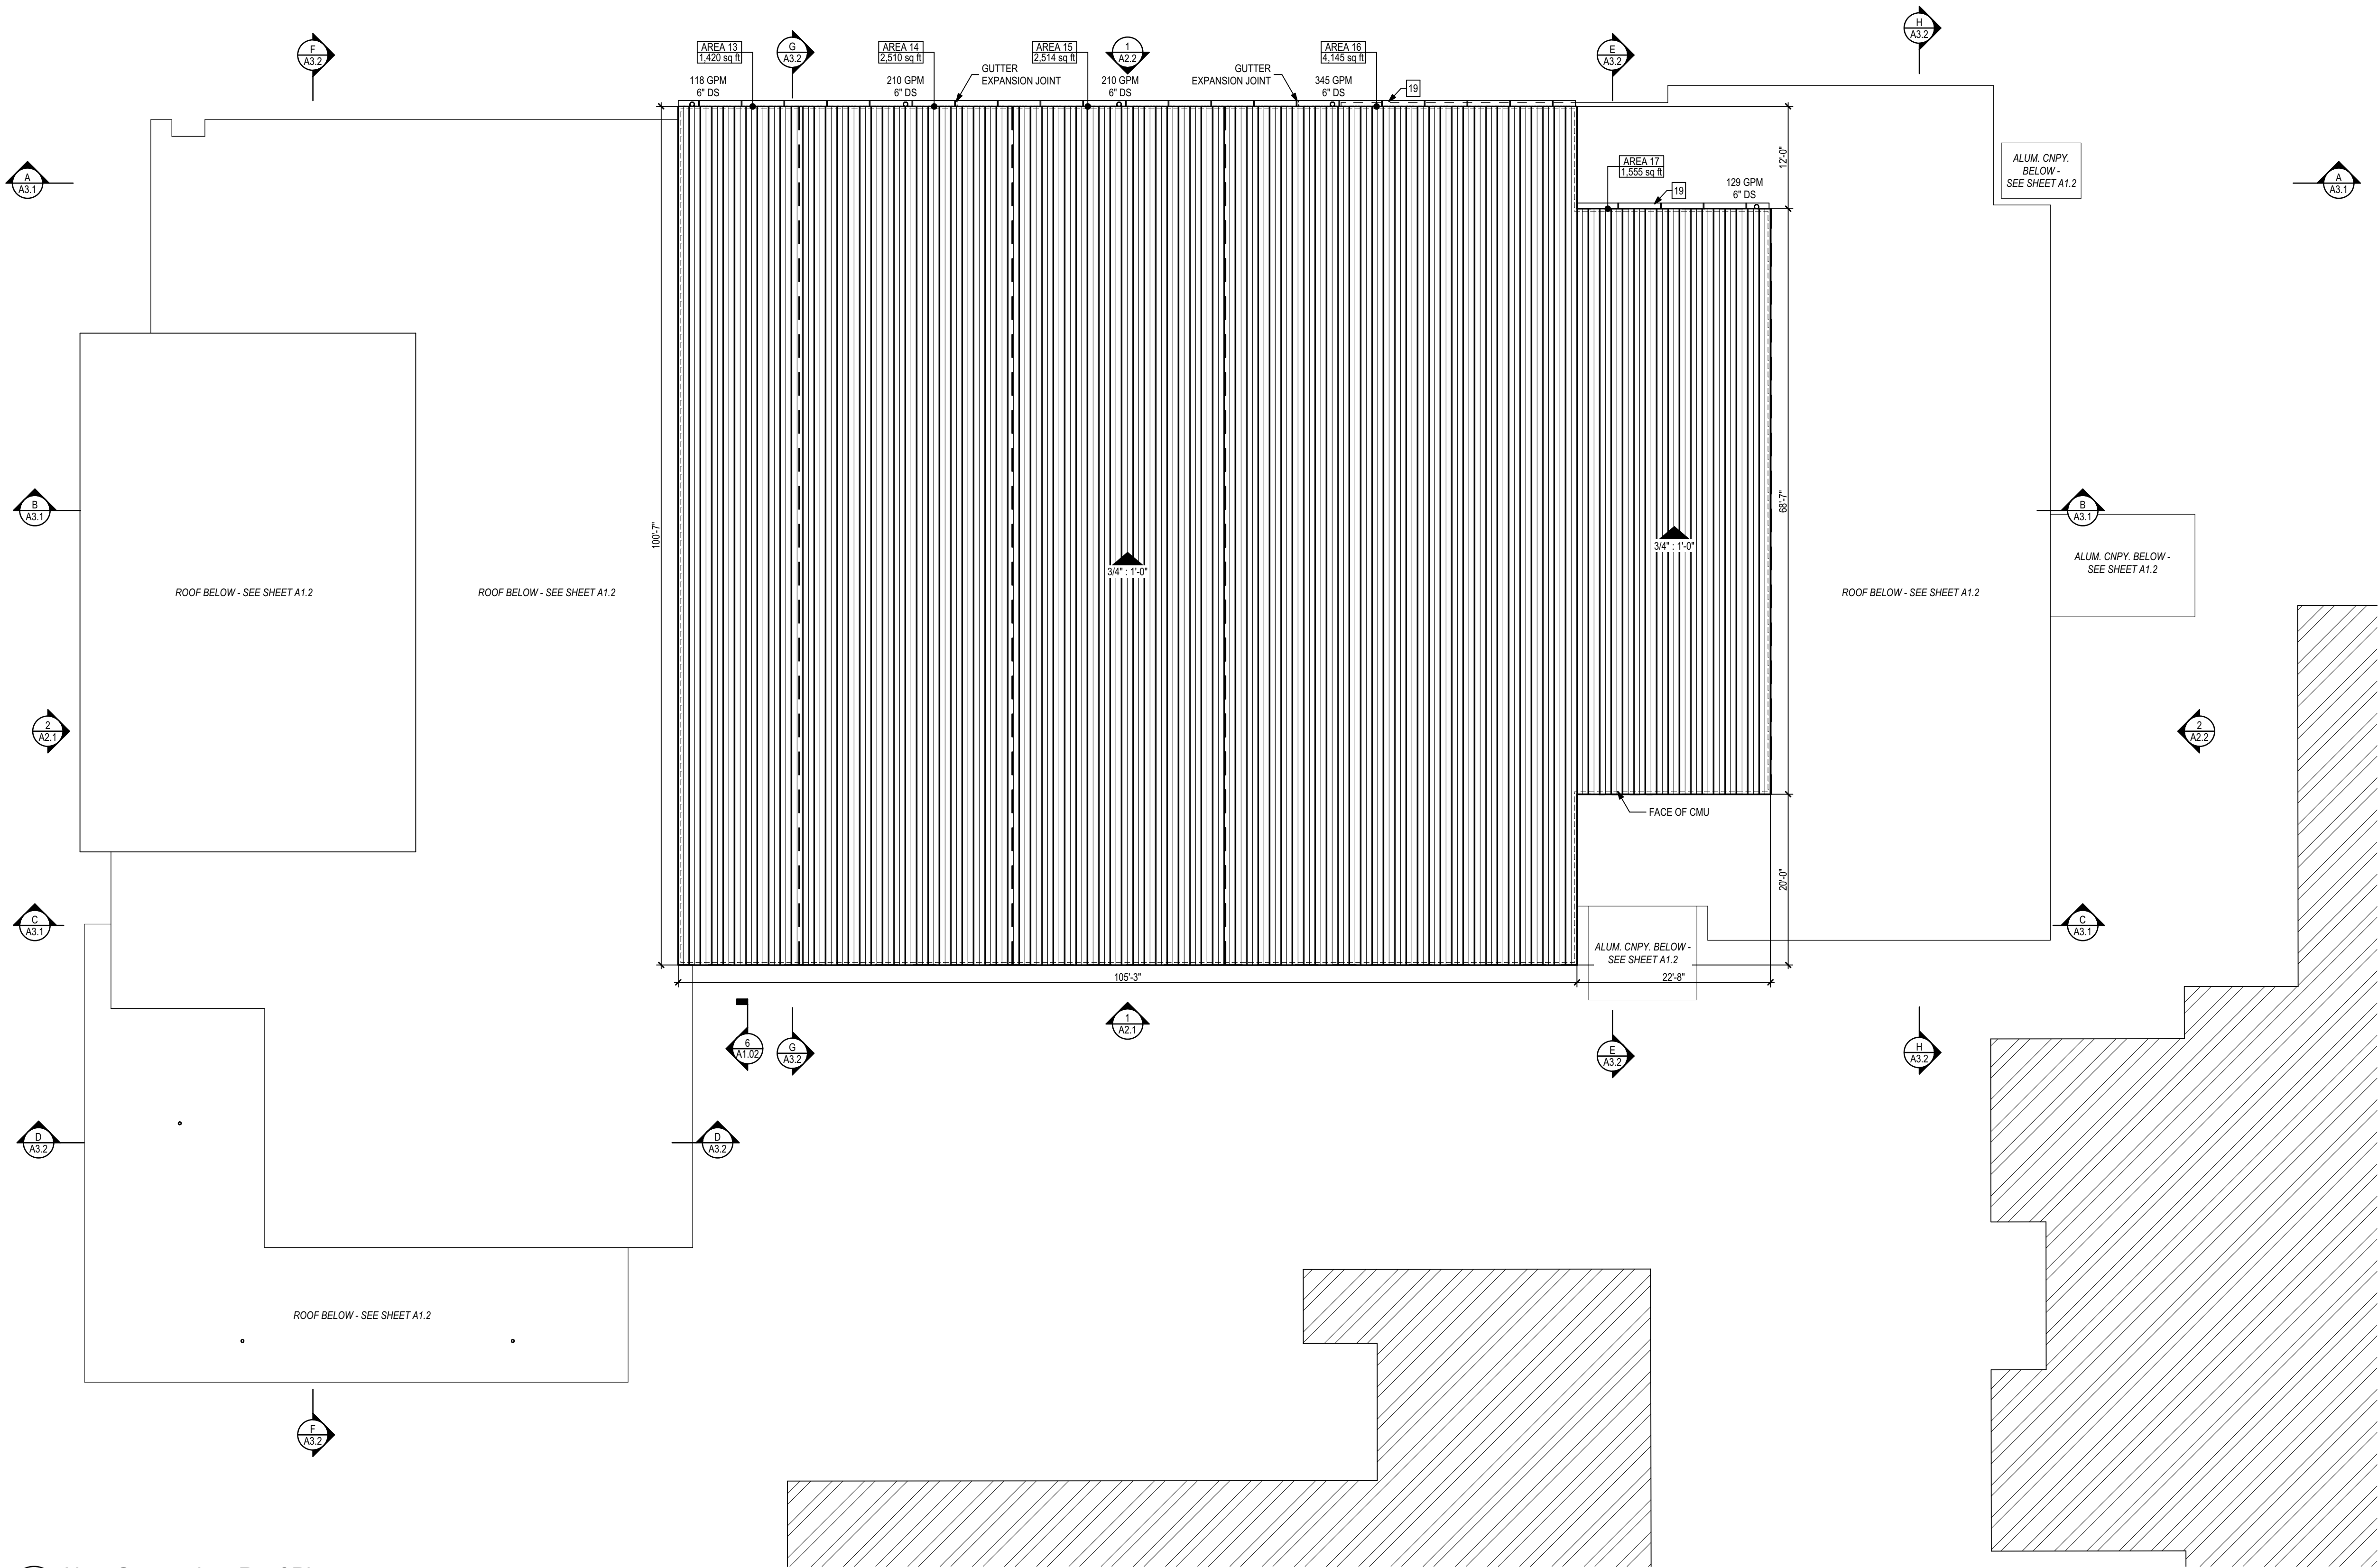

Construction Notes

SEE SHEET A1.1 FOR CONSTRUCTION NOTES.

Key Plan

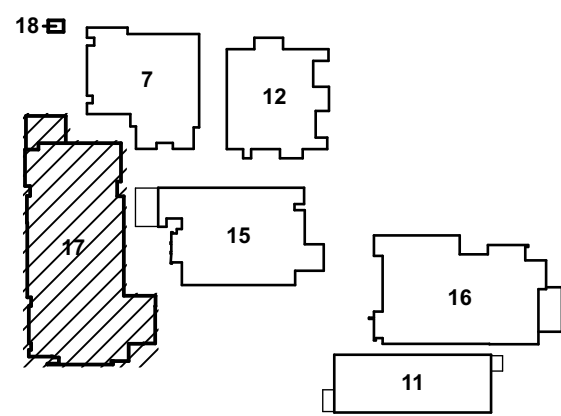

Drawing Legend

	NEW PARTITION
	EXISTING CONSTRUCTION TO REMAIN
	NEW CONSTRUCTION
	CONSTRUCTION ABOVE
	CONSTRUCTION BELOW

PHASE:	DRAWN:	REVIEWED:	DATE:	ID:	REVISION:	DRAWN:	REVIEWED:	DATE:
CONCEPT SCHEM. DESIGN	BG/RS	C. WHITLOCK	10/8/2024					
DESIGN DEVELOPMENT	BG/RS/SIMS	C. WHITLOCK	12/20/2024					
EARLY DEMOLITION PACKAGE	BG/RS/SIMS	R. LEWIS	03/21/2025					
80% CONSTRUCTION DOCS	BG/RS/SIMS	R. LEWIS	03/21/2025					
PERMIT DOCS	BG/RS/SIMS	R. LEWIS	05/09/2025					
100% CONSTRUCTION DOCS	BG/RS/SIMS	R. LEWIS	05/09/2025					

LEON COUNTY SCHOOLS

Client: Leon County Schools
3420 W. Tharpe St., Suite 100
Tallahassee, FL 32303

Consultant: 23483
Project #: 23483
Phase: 100% CDs

Job Title: Griffin Middle School - Phase 2
800 Alabama St. Tallahassee, FL 32304


Seal:

ALW


Architects Lewis + Whitlock
206 West Virginia St.
Tallahassee, Florida 32301
850.942.1718
www.think3d.net

Description:
New Gymnasium
Roof Plan


Sheet No.:
A1.3

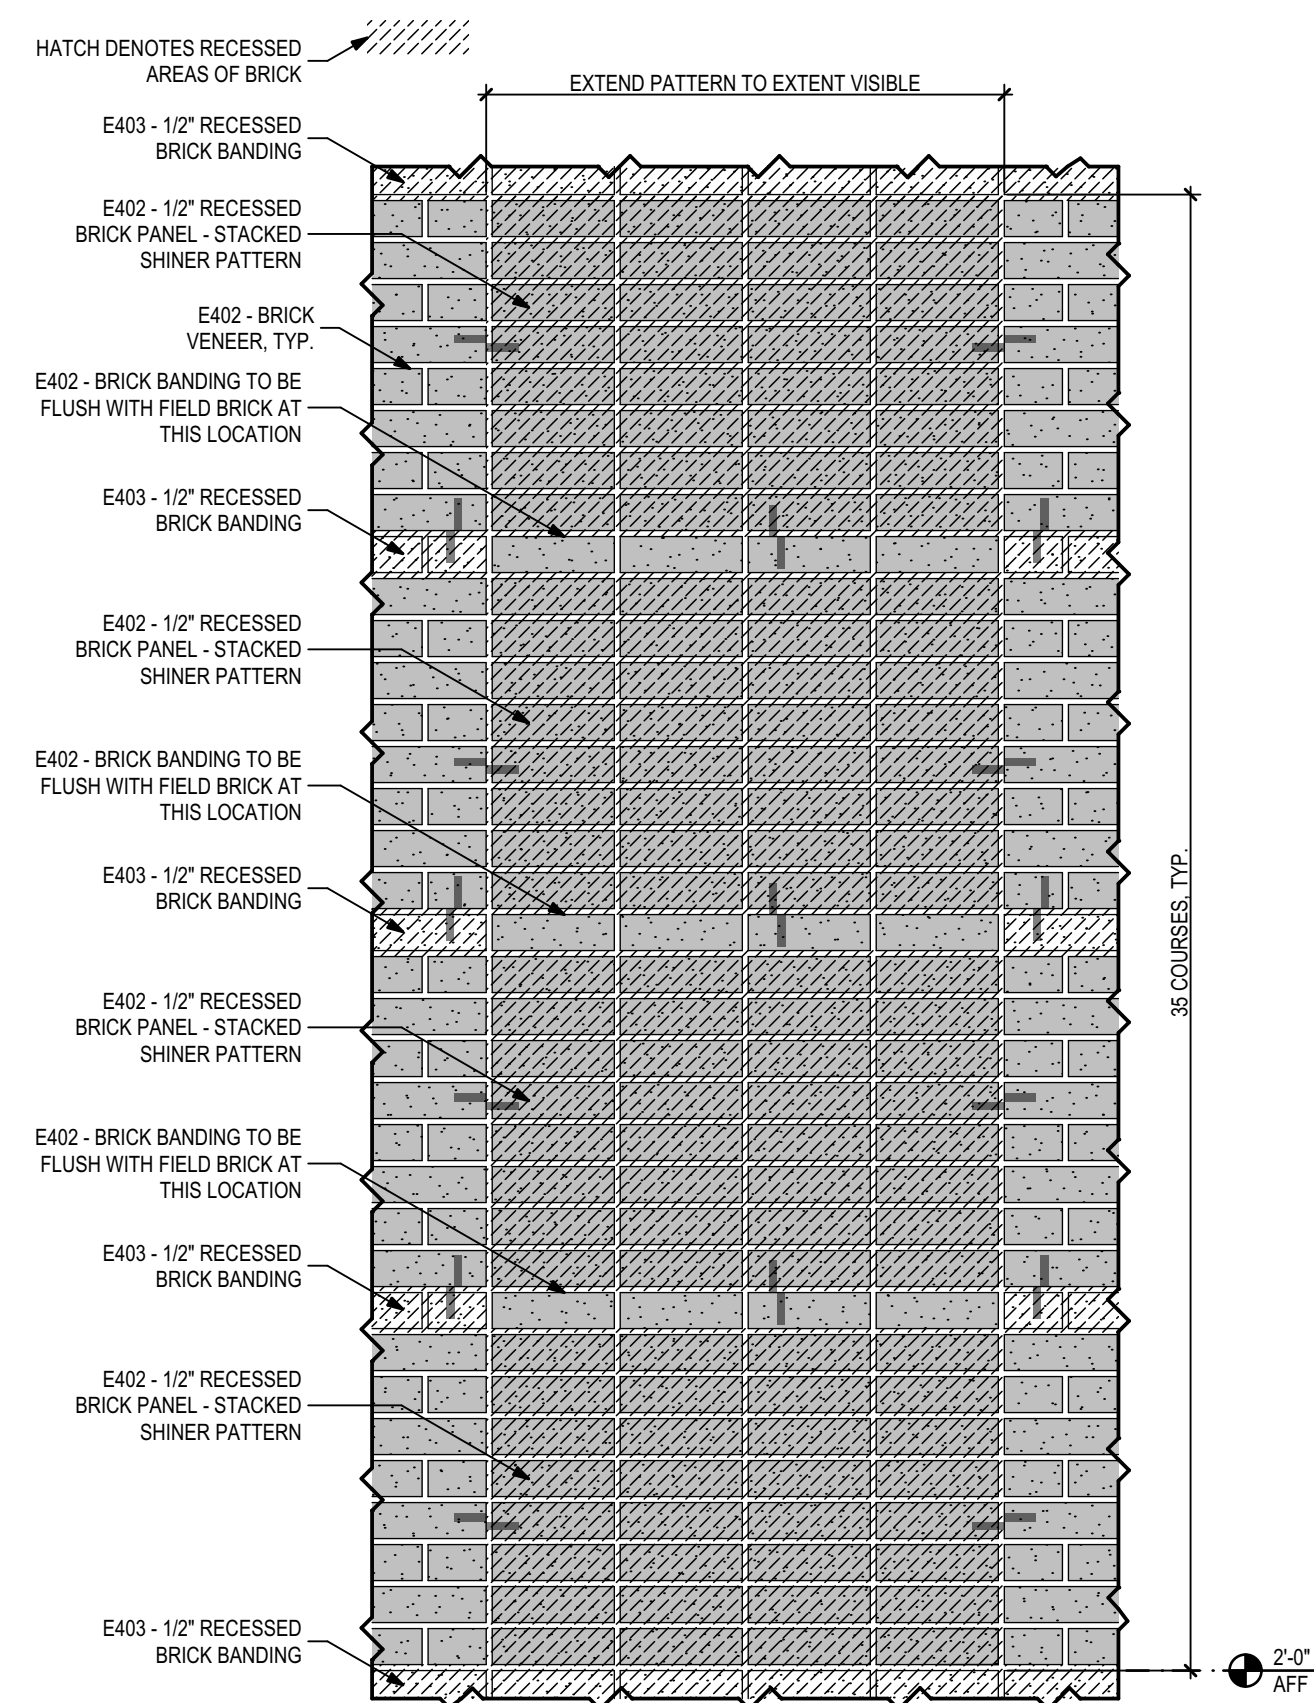






5 Typical Recessed Accent Brick Panel

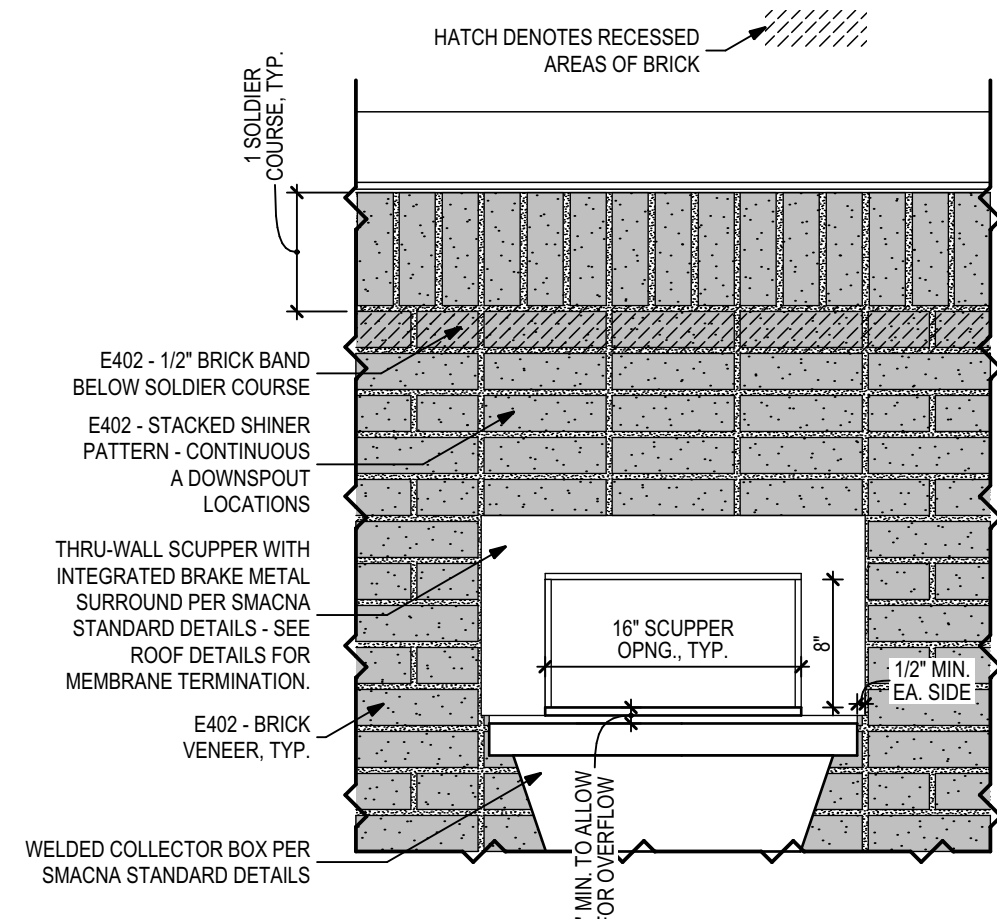


4 Typical Brick Detail at Scupper

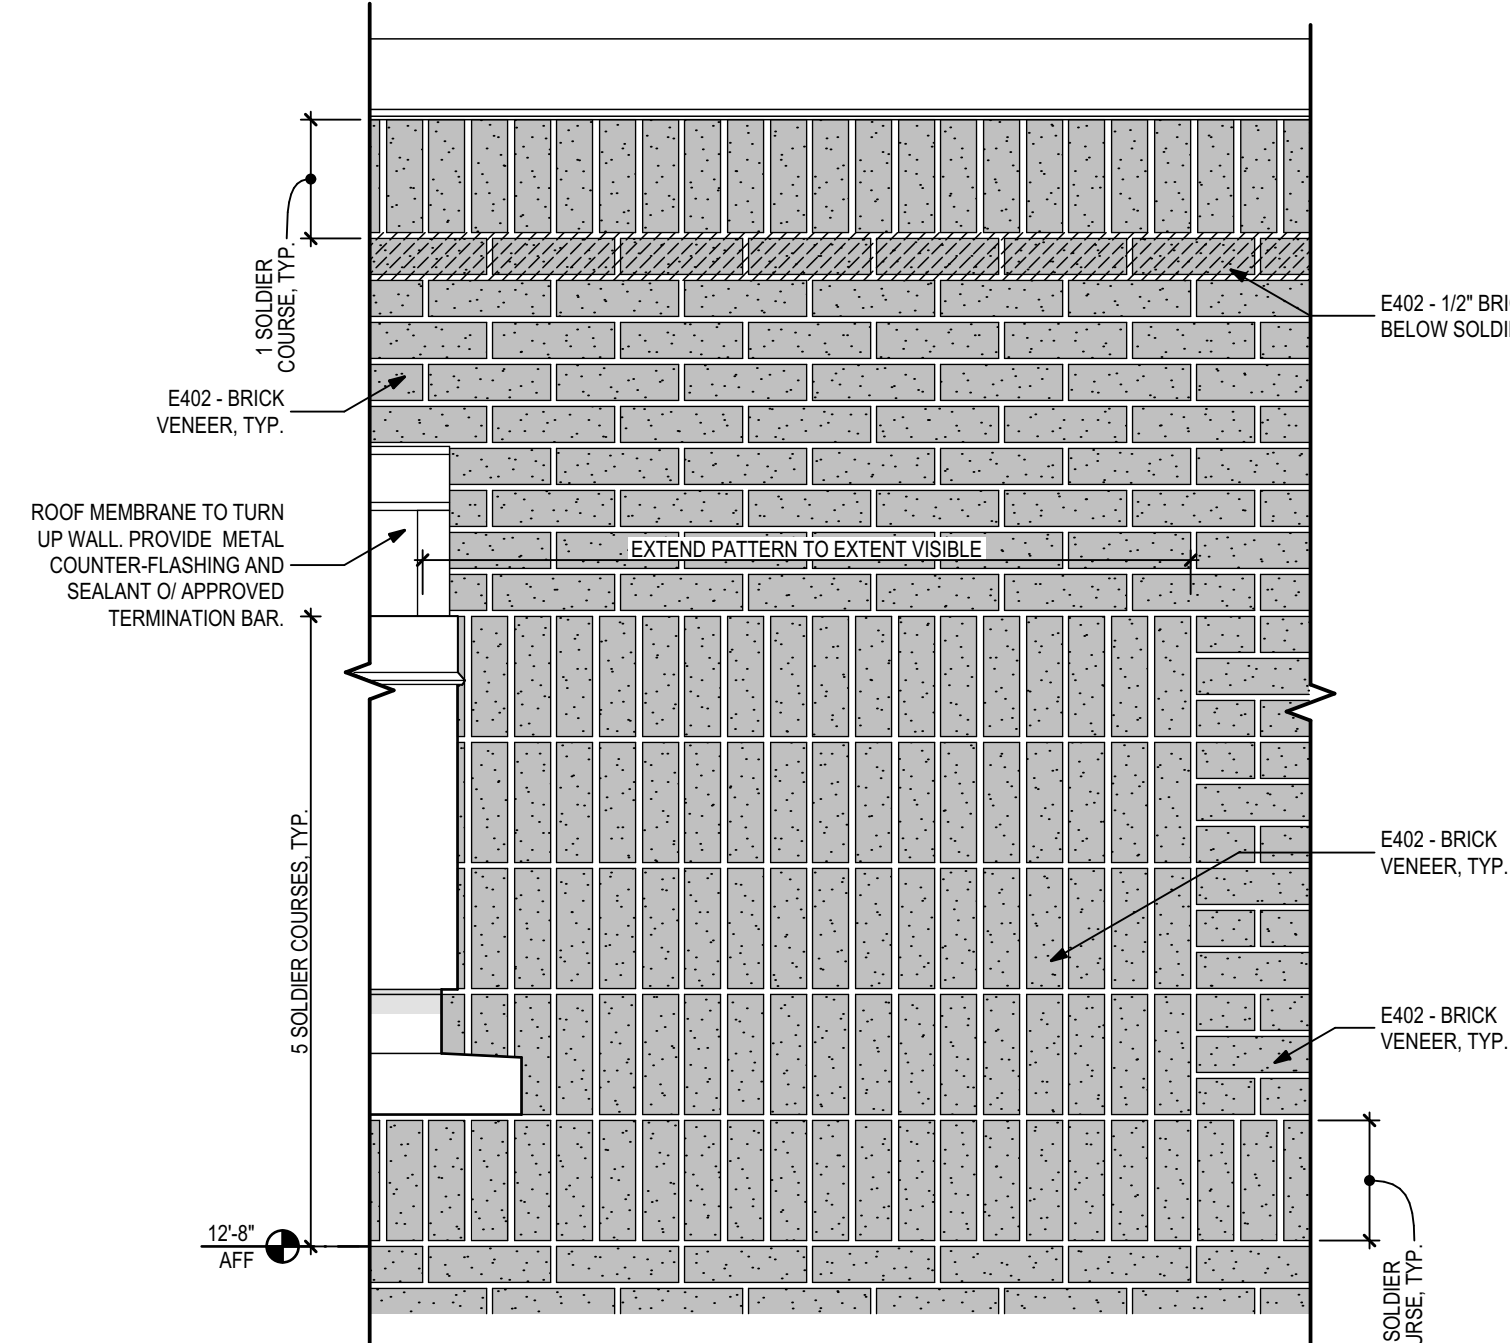


3 Typical Soldier Bond Detail At Canopy

  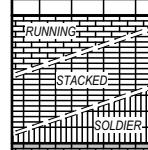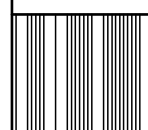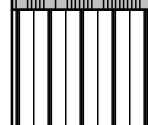LEGEND		NAME	DESCRIPTION
		E301	EXPOSED ARCHITECTURAL CONCRETE PROVIDE UNIFORM, SMOOTH CONCRETE SURFACE. MINIMUM FORM JOINT SPACING 4'-0" EAWAY. PROVIDE UNIFORM SNAP-TIE PATTERN. SNAP-TIE HOLES ARE TO REMAIN EXPOSED AFTER FORM REMOVAL. NOTE: WALLS GREATER THAN 3' IN TOTAL HEIGHT AND LEFT EXPOSED SHALL RECEIVE "WR MEADOWS INTRAGUARD SEALER".
		E401	CMU COLOR: TBD. SEE SPECS FOR PAINT AND PRIMER TYPE / APPLICATION INFO COURSING: VARYING. SEE ELEVATIONS
		E402	BRICK MASONRY VENEER - COLOR A COLOR: CHEROKEE FLASH FINISH: SMOOTH COURSING: VARYING. SEE ELEVATIONS
		E403	BRICK MASONRY VENEER - COLOR B COLOR: CHEROKEE VEIL OR BUFF FINISH: SMOOTH COURSING: VARYING. SEE ELEVATIONS
		E501A	METAL CEILING SYSTEM PAC-CLAD FLUSH SOFFIT - "7112" COLOR: SILVER
		E501B	METAL WALL/CEILING SYSTEM - ACCENT COLOR PAC-CLAD FLUSH SOFFIT - "7112" COLOR: PACIFIC BLUE
		E502	METAL WALL PANEL - FIELD BASIS OF DESIGN: PAC-CLAD BOX RIB COLOR: SILVER (MATCH COLOR FOR ACCESSORIES UNLESS OTHERWISE NOTED)
		E502A	METAL WALL PANEL - ACCENT BASIS OF DESIGN: PAC-CLAD BOX RIB COLOR: ZINC
		E502B	METAL WALL PANEL - ACCENT BASIS OF DESIGN: PAC-CLAD BOX RIB COLOR: INTERSTATE BLUE
		E503	METAL ROOF BASIS OF DESIGN: PAC-CLAD TITE-LOC PLUS COLOR: SILVER
		E504	METAL COPING / DRIP EDGE / ASSORT BRAKE METAL PRE-FINISHED COLOR: SEE ELEVATION TO MATCH ADJACENT
		E505	HANDRAIL / GUARDRAIL GALVANIZED & PAINTED. COLOR TBD. SEE SPECS FOR APPLICATION INFO.
		E801	STOREFRONT SYSTEM BASIS OF DESIGN: KNIHNER COLOR/FINISH: CLEAR ANODIZED
		E901	ALUMINUM CANOPY SYSTEM COLOR/FINISH: TBD











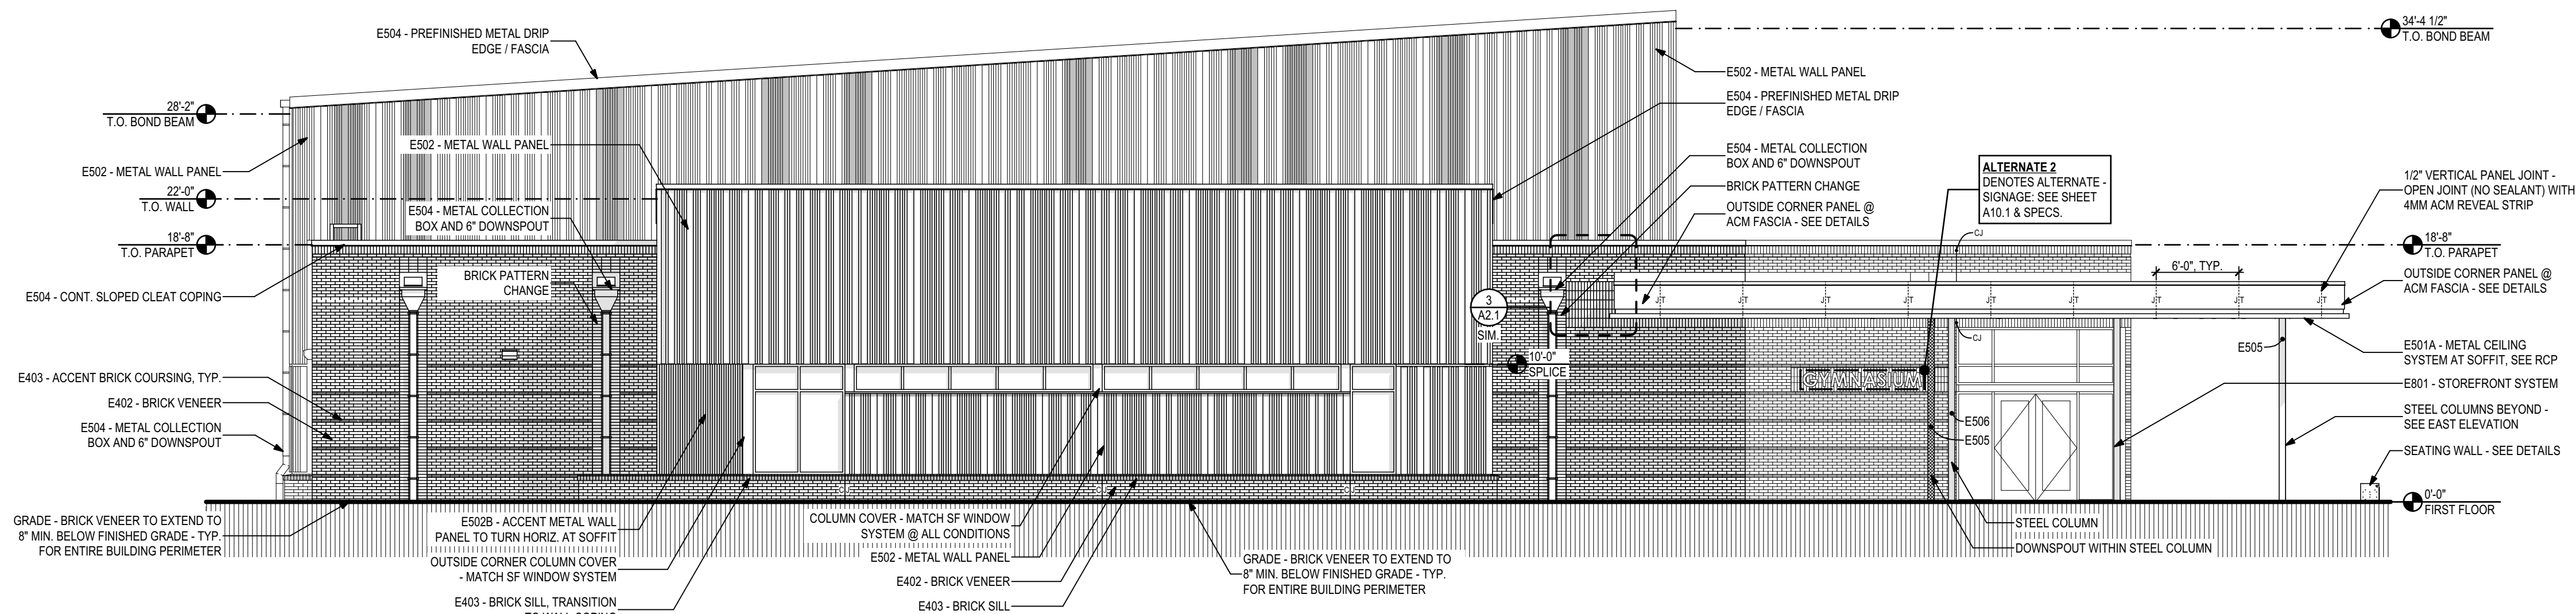





2 South Elevation
1/8" = 1'-0"

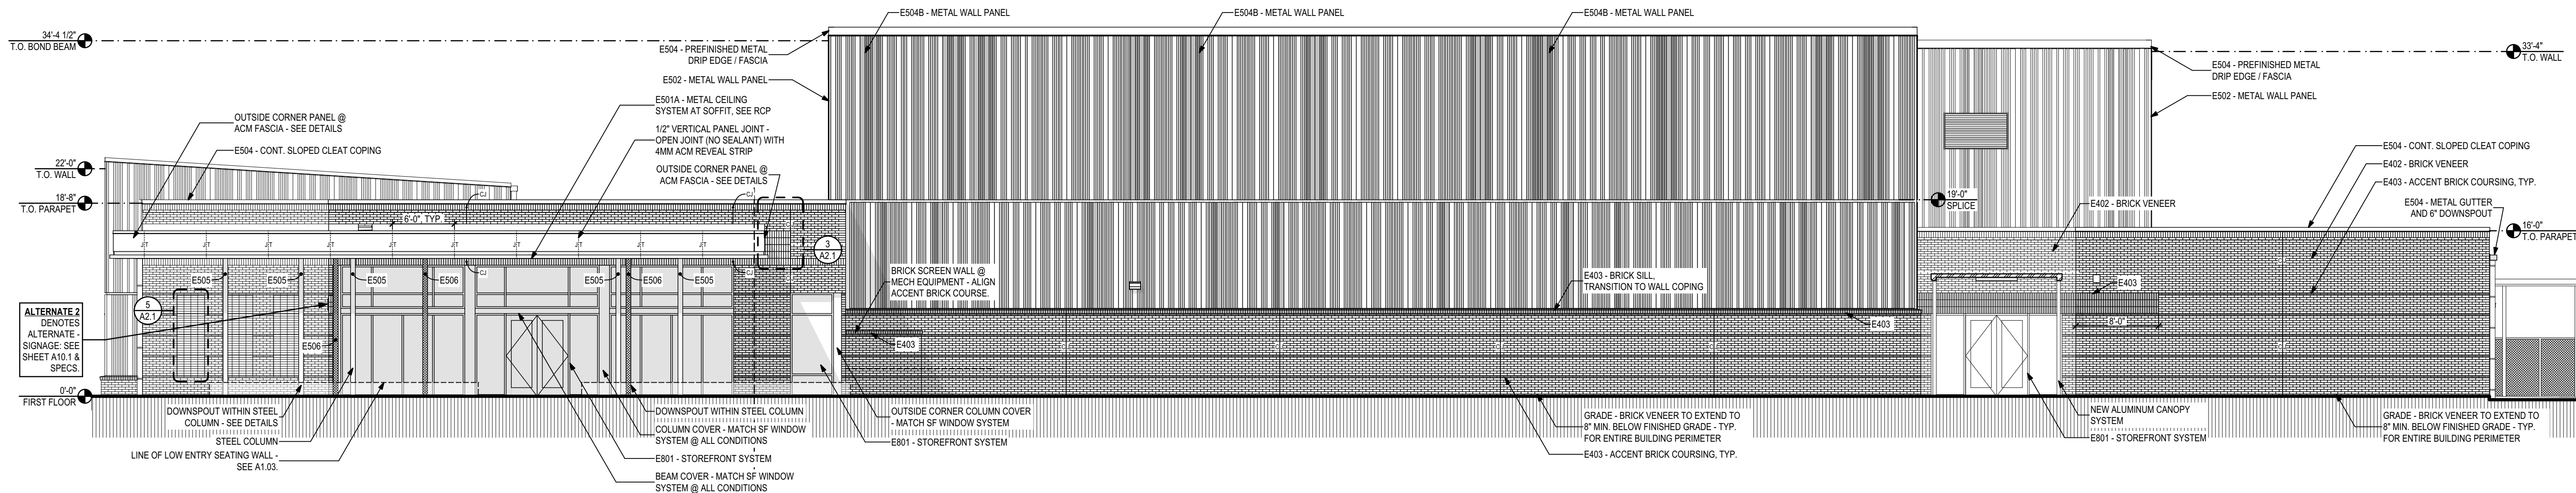


1 East Elevation
1/8" = 1'-0"

      
[illegible]

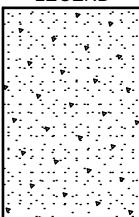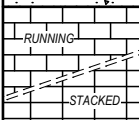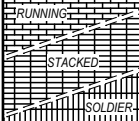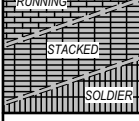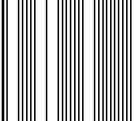LEGEND		NAME	DESCRIPTION
		E301	EXPOSED ARCHITECTURAL CONCRETE PROVIDE UNIFORM, SMOOTH CONCRETE SURFACE. MINIMUM FORM JOINT SPACING 4'-0" EAWAY. PROVIDE UNIFORM SNAP-TIE PATTERN. SNAP-TIE HOLES ARE TO REMAIN EXPOSED AFTER FORM REMOVAL. NOTE: WALLS GREATER THAN 2" IN TOTAL HEIGHT AND LEFT EXPOSED SHALL RECEIVE "WR MEADOWS INTRAGUARD SEALER".
		E401	CMU COLOR: TBD. SEE SPECS FOR PAINT AND PRIMER TYPE / APPLICATION INFO. COURSING: VARYING. SEE ELEVATIONS
		E402	BRICK MASONRY VENEER - COLOR A COLOR: CHEROKEE FLASH FINISH: SMOOTH COURSING: VARYING. SEE ELEVATIONS
		E403	BRICK MASONRY VENEER - COLOR B COLOR: CHEROKEE VELOUR BUFF FINISH: SMOOTH COURSING: VARYING. SEE ELEVATIONS
		E501A	METAL CEILING SYSTEM PAC-CLAD FLUSH SOFFIT - 7712" COLOR: SILVER
		E501B	METAL WALL/CEILING SYSTEM - ACCENT COLOR PAC-CLAD FLUSH SOFFIT - 7712" COLOR: PACIFIC BLUE
		E502	METAL WALL PANEL - FIELD BASIS OF DESIGN: PAC-CLAD BOX RIB COLOR: SILVER (MATCH COLOR FOR ACCESSORIES UNLESS OTHERWISE NOTED)
		E502A	METAL WALL PANEL - ACCENT BASIS OF DESIGN: PAC-CLAD BOX RIB COLOR: ZINC
		E502B	METAL WALL PANEL - ACCENT BASIS OF DESIGN: PAC-CLAD BOX RIB COLOR: INTERSTATE BLUE
		E503	METAL ROOF BASIS OF DESIGN: PAC-CLAD TITE-LOC PLUS COLOR: SILVER
		E504	METAL COPING / DRIP EDGE / ASSORT BRAKE METAL PRE-FINISHED COLOR: SEE ELEVATION TO MATCH ADJACENT
		E505	HANDRAIL / GUARDRAIL GALVANIZED & PAINTED, COLOR TBD. SEE SPECS FOR APPLICATION INFO.
		E801	STOREFRONT SYSTEM BASIS OF DESIGN: KAWNEER COLOR/FINISH: CLEAR ANODIZED
		E901	ALUMINUM CANOPY SYSTEM COLOR/FINISH: TBD

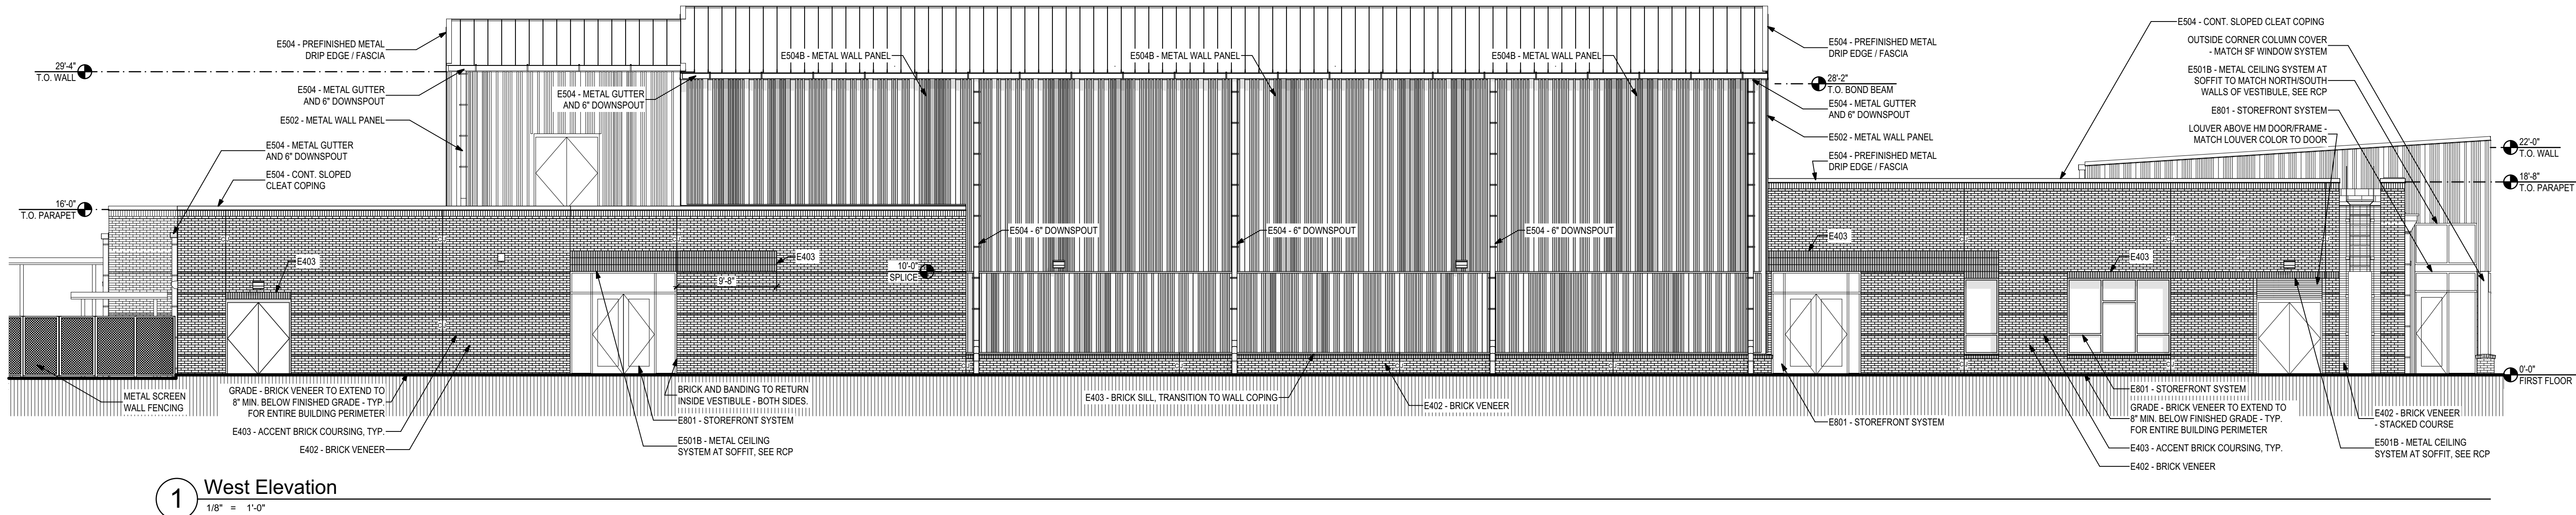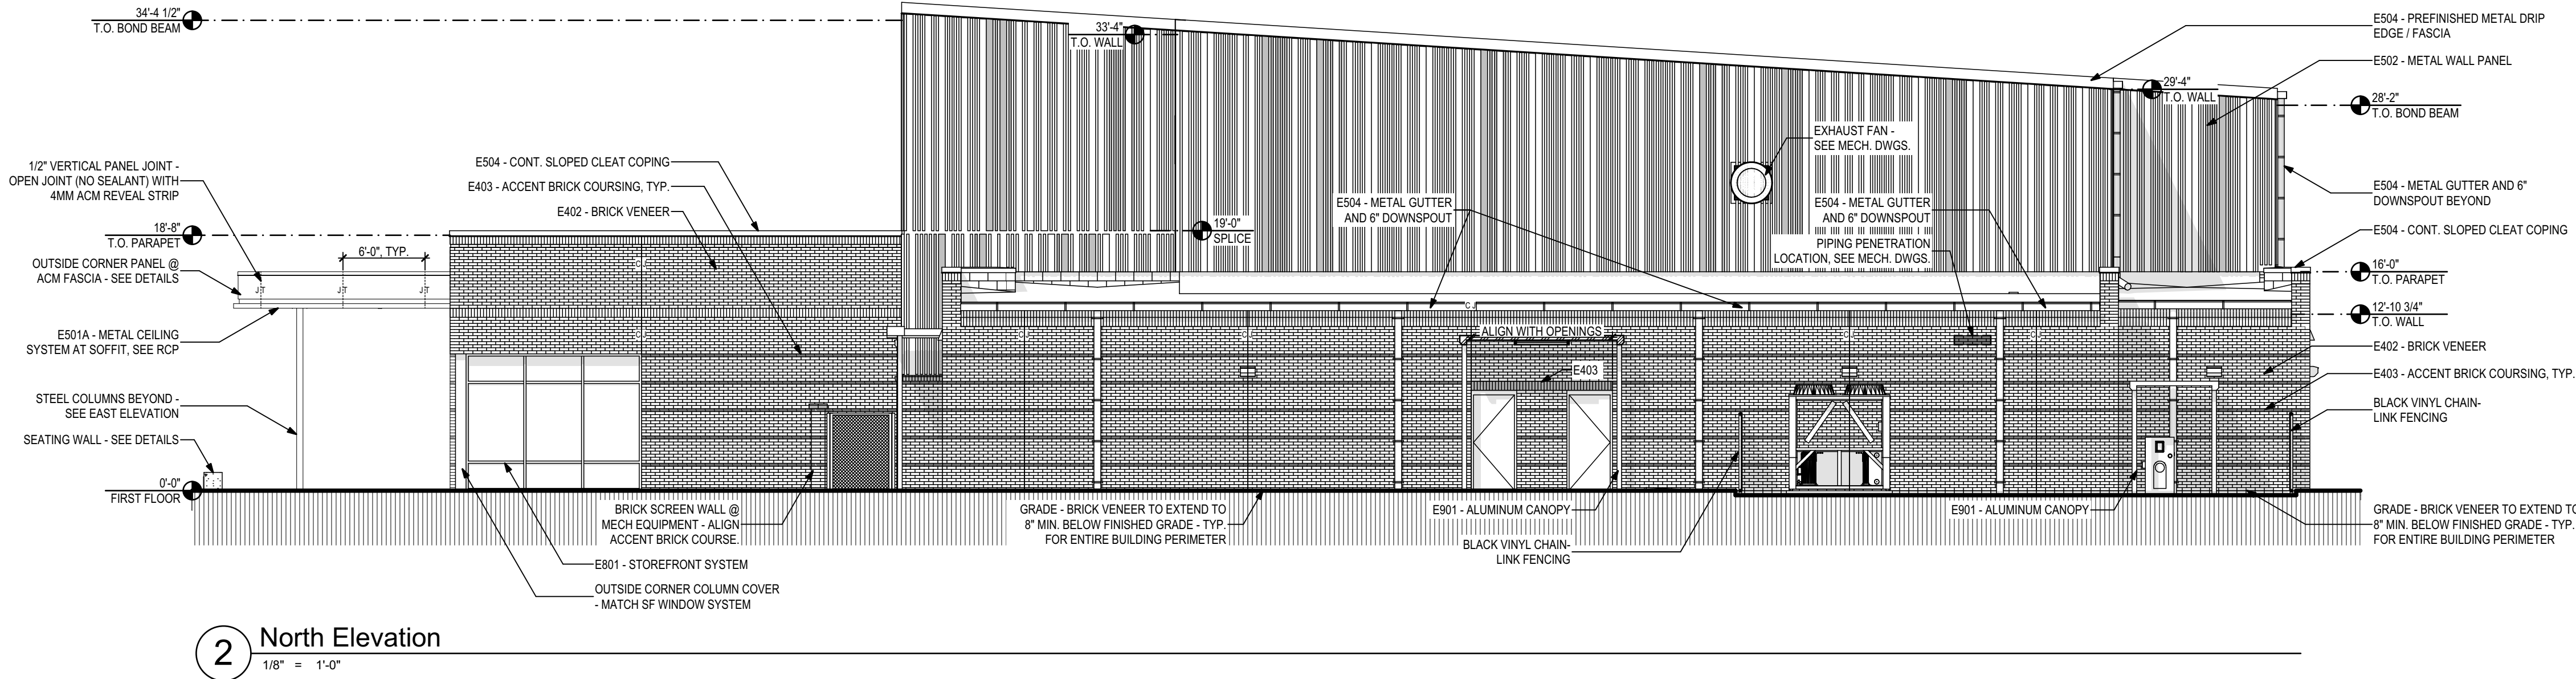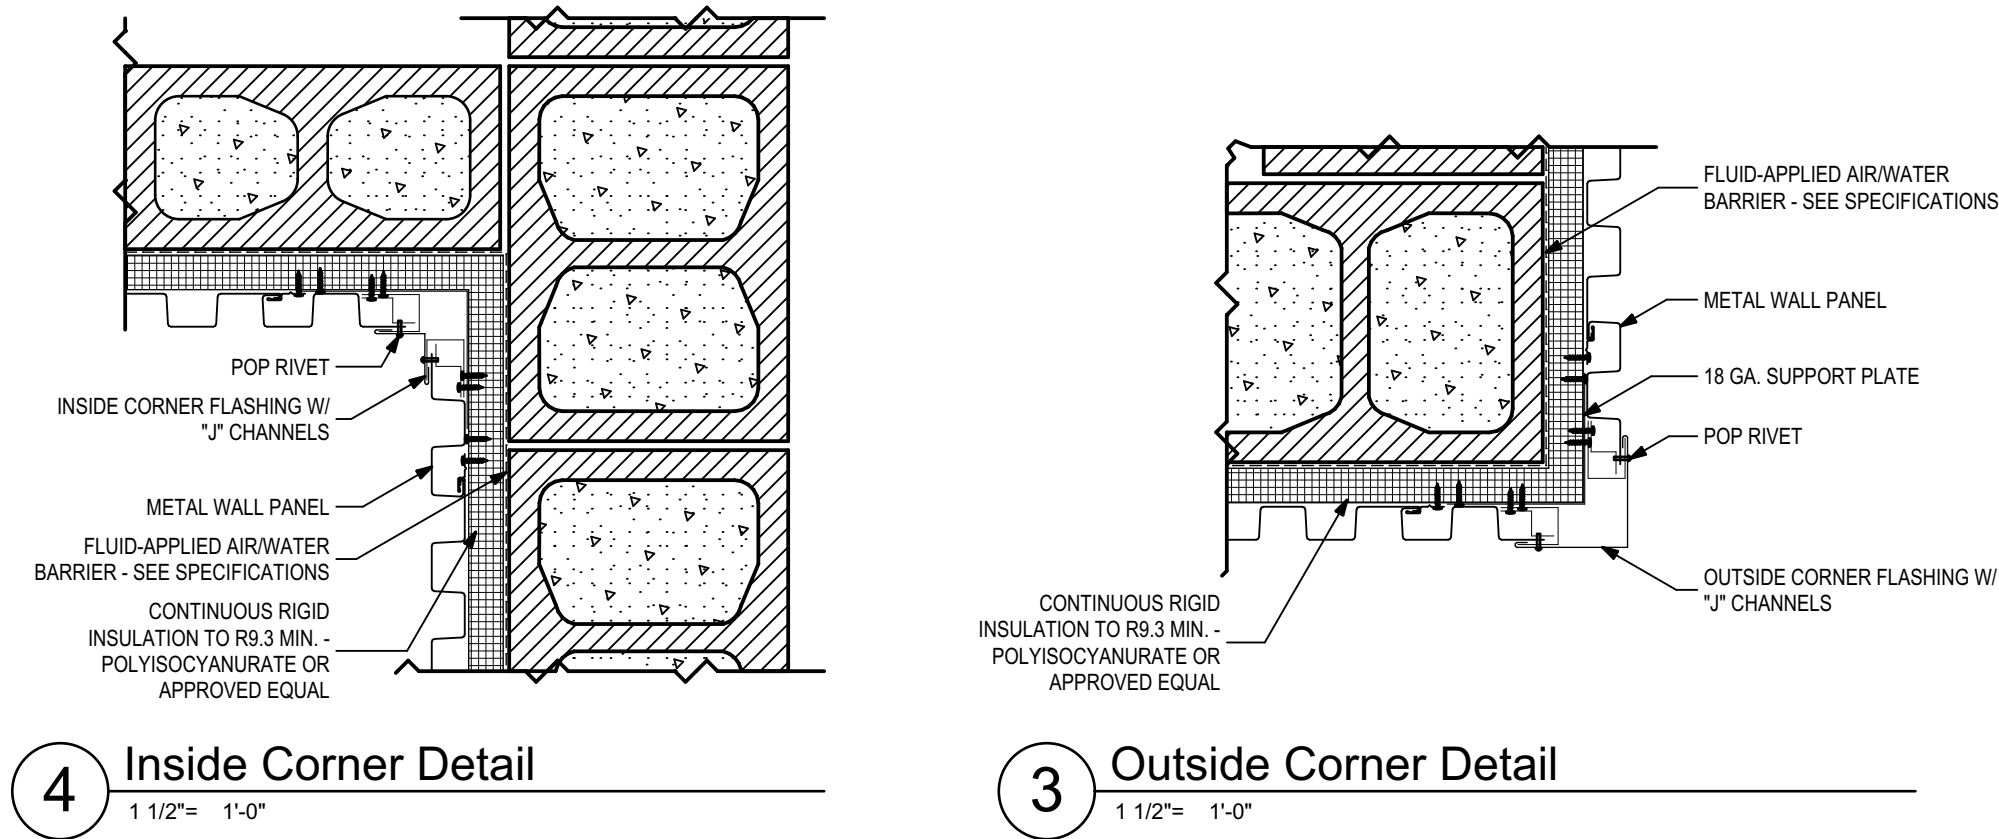


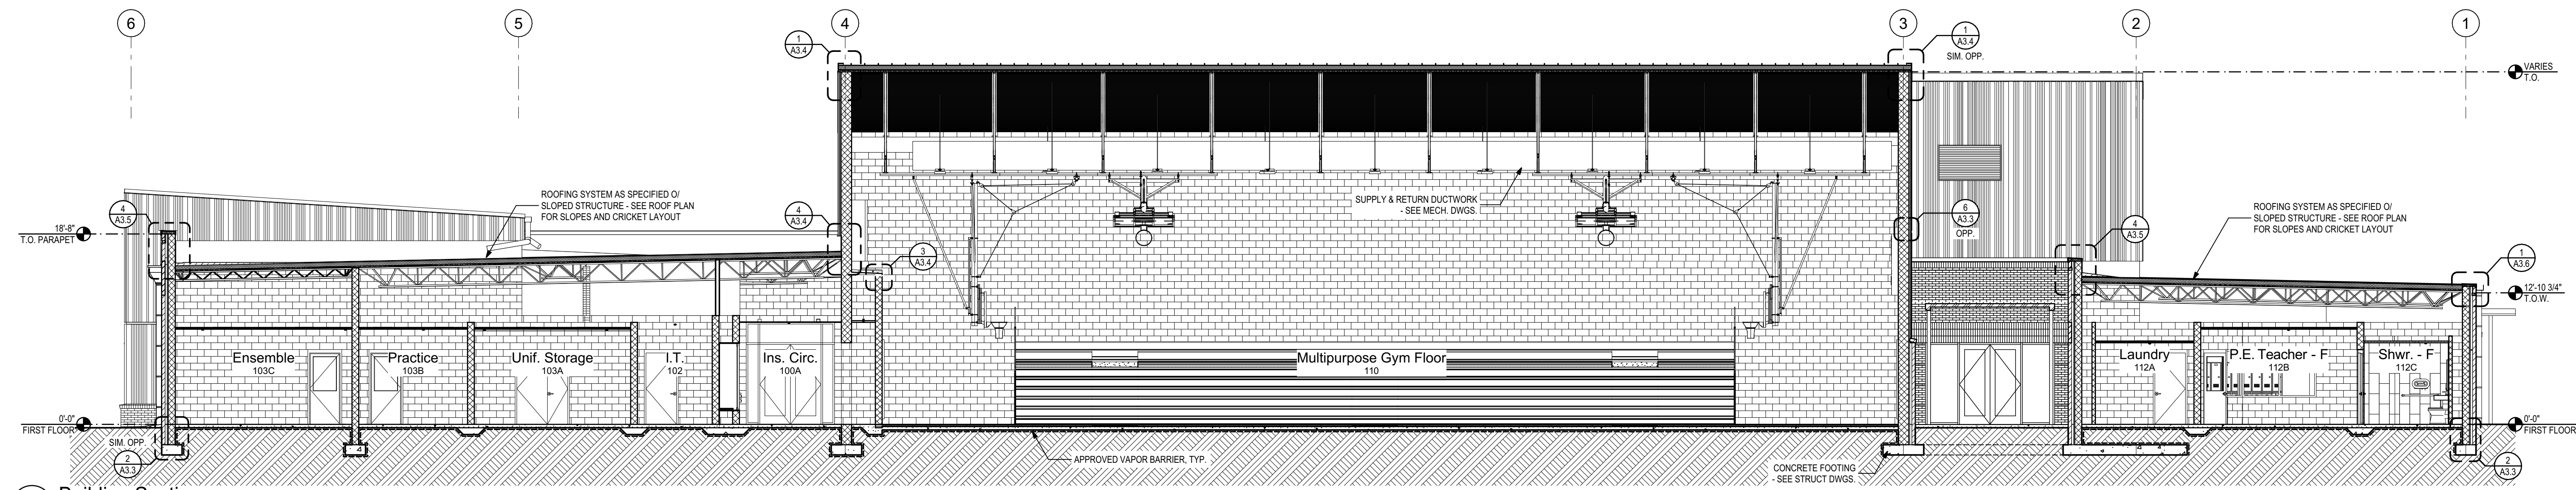

C Building Section
1/8" = 1'-0"

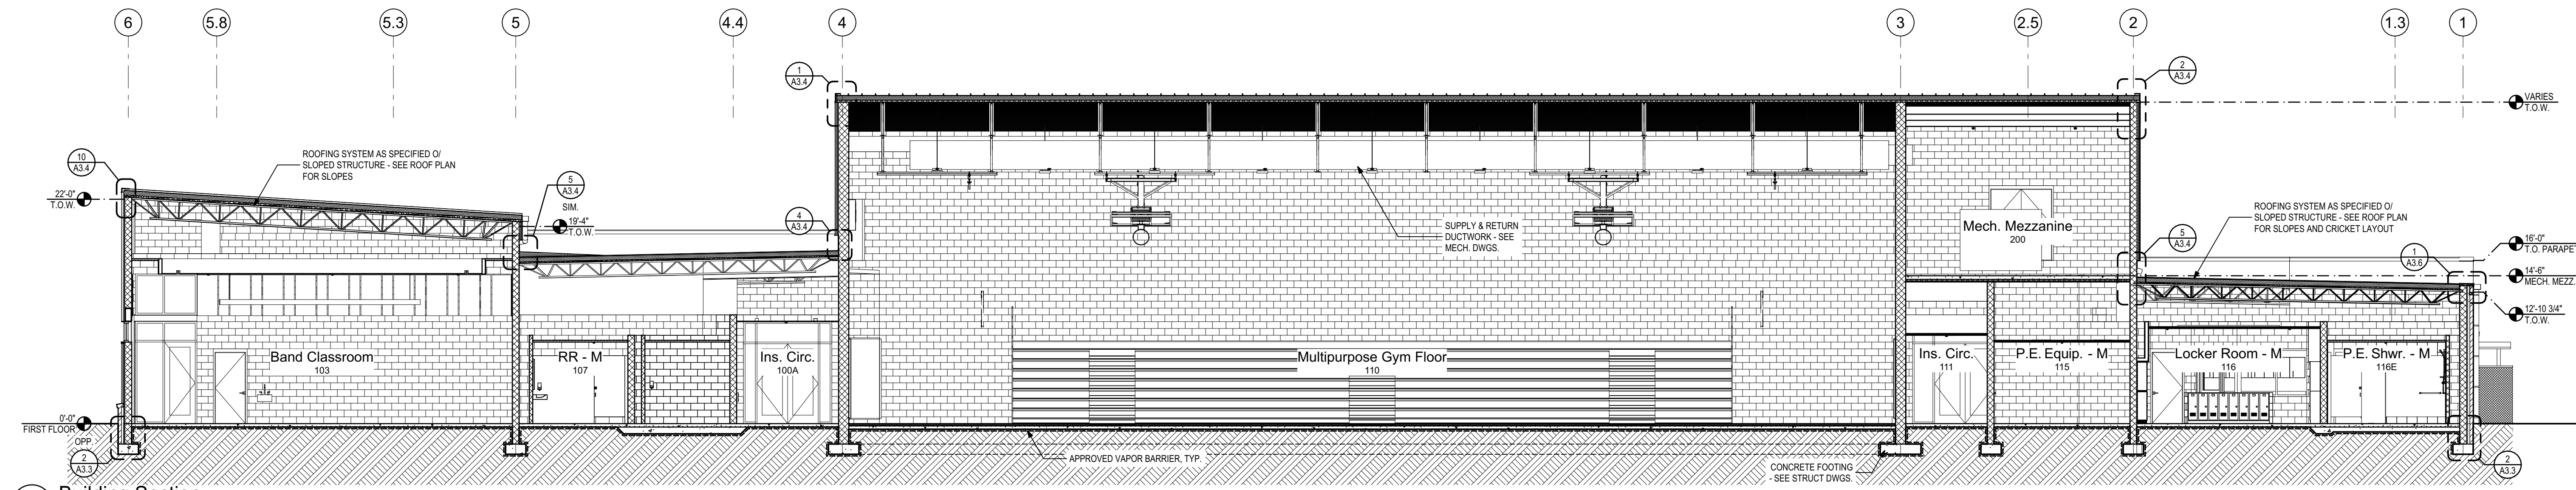

B Building Section
1/8" = 1'-0"

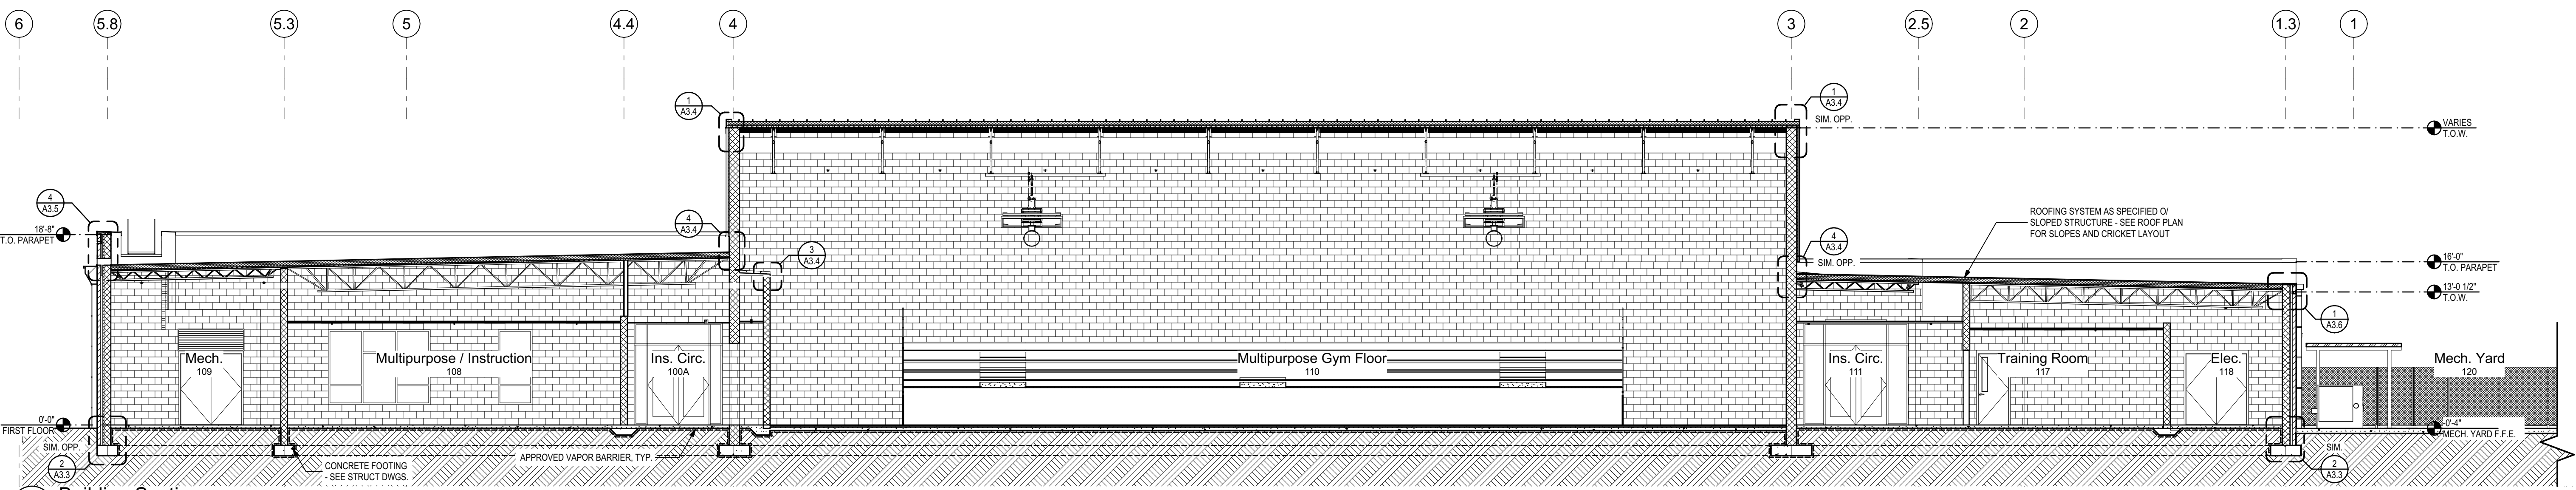

A Building Section
1/8" = 1'-0"

PHASE:	DRAWN:	REVIEWED:	DATE:	ID:	REVISION:	DRAWN:	REVIEWED:	DATE:
CONCEPT SCHEM. DESIGN	BG / RS	C. WHITLOCK	10/8/2024					
DESIGN DEVELOPMENT	BG/RS/MS	C. WHITLOCK	12/20/2024					
EARLY DEMOLITION PACKAGE	BG/RS/MS	R. LEWIS	03/21/2025					
80% CONSTRUCTION DOCS	BG/RS/MS	R. LEWIS	03/21/2025					
PERMIT DOCS	BG/RS/MS	R. LEWIS	05/09/2025					
100% CONSTRUCTION DOCS	BG/RS/MS	R. LEWIS	05/09/2025					

LEON COUNTY SCHOOLS

Client:
Leon County Schools
3420 W. Tharpe St., Suite 100
Tallahassee, FL 32303

Job Title:
Griffin Middle School - Phase 2
800 Alabama St. Tallahassee, FL 32304

Consultant:
23483
100% CDs

Project #:
23483
100% CDs






Seal:

ALW

Architects Lewis + Whitlock
206 West Virginia St.
Tallahassee, Florida 32301
850.942.1718
www.think3d.net

Description:
Building Sections

Sheet No.:
A3.1

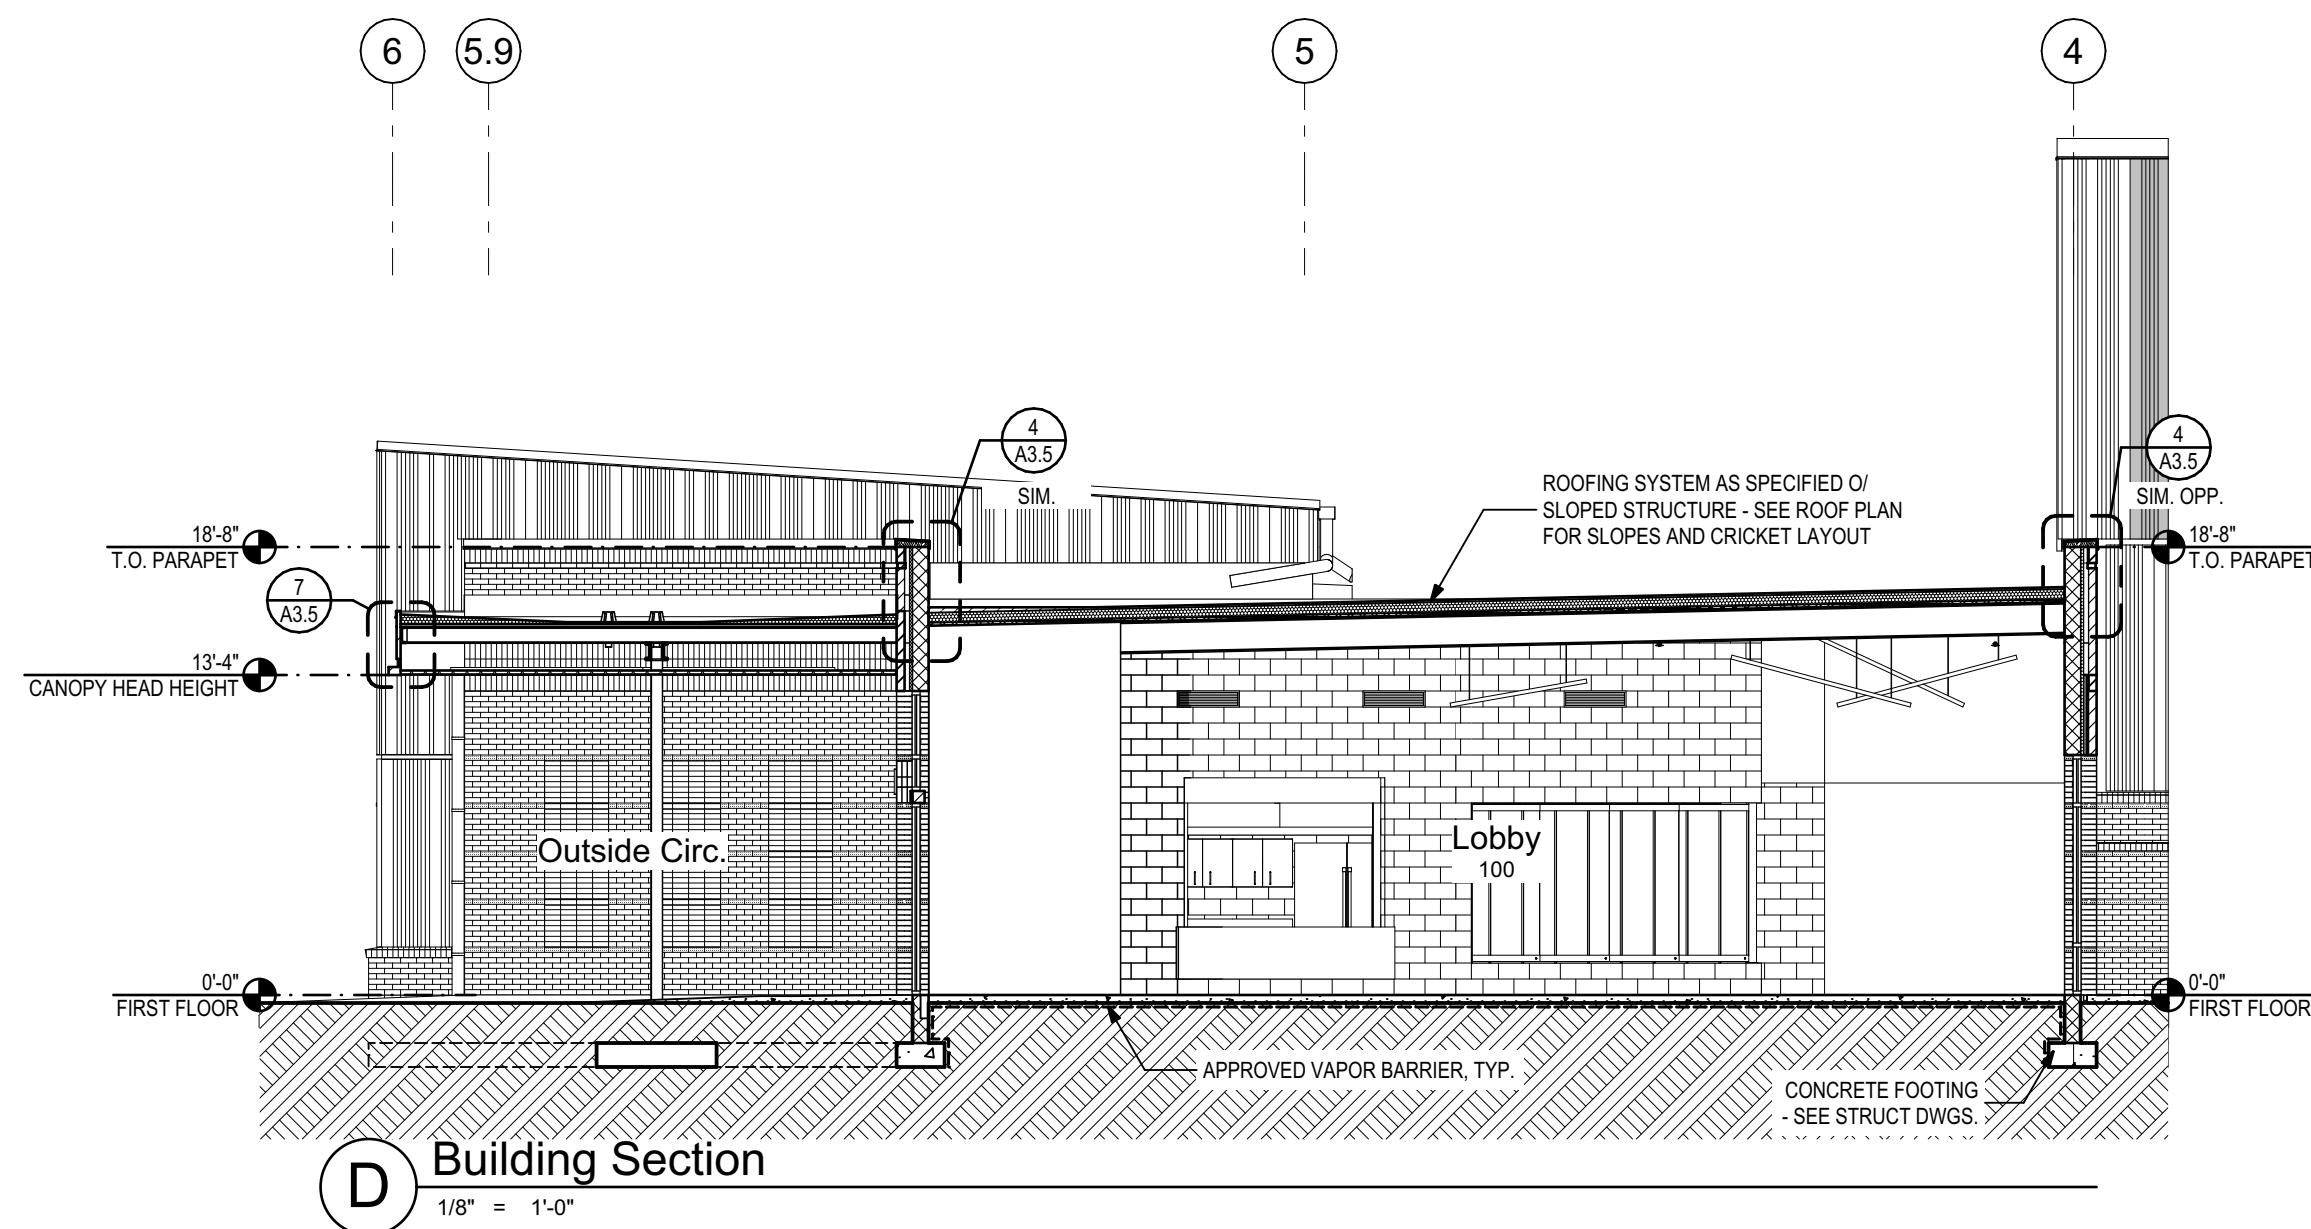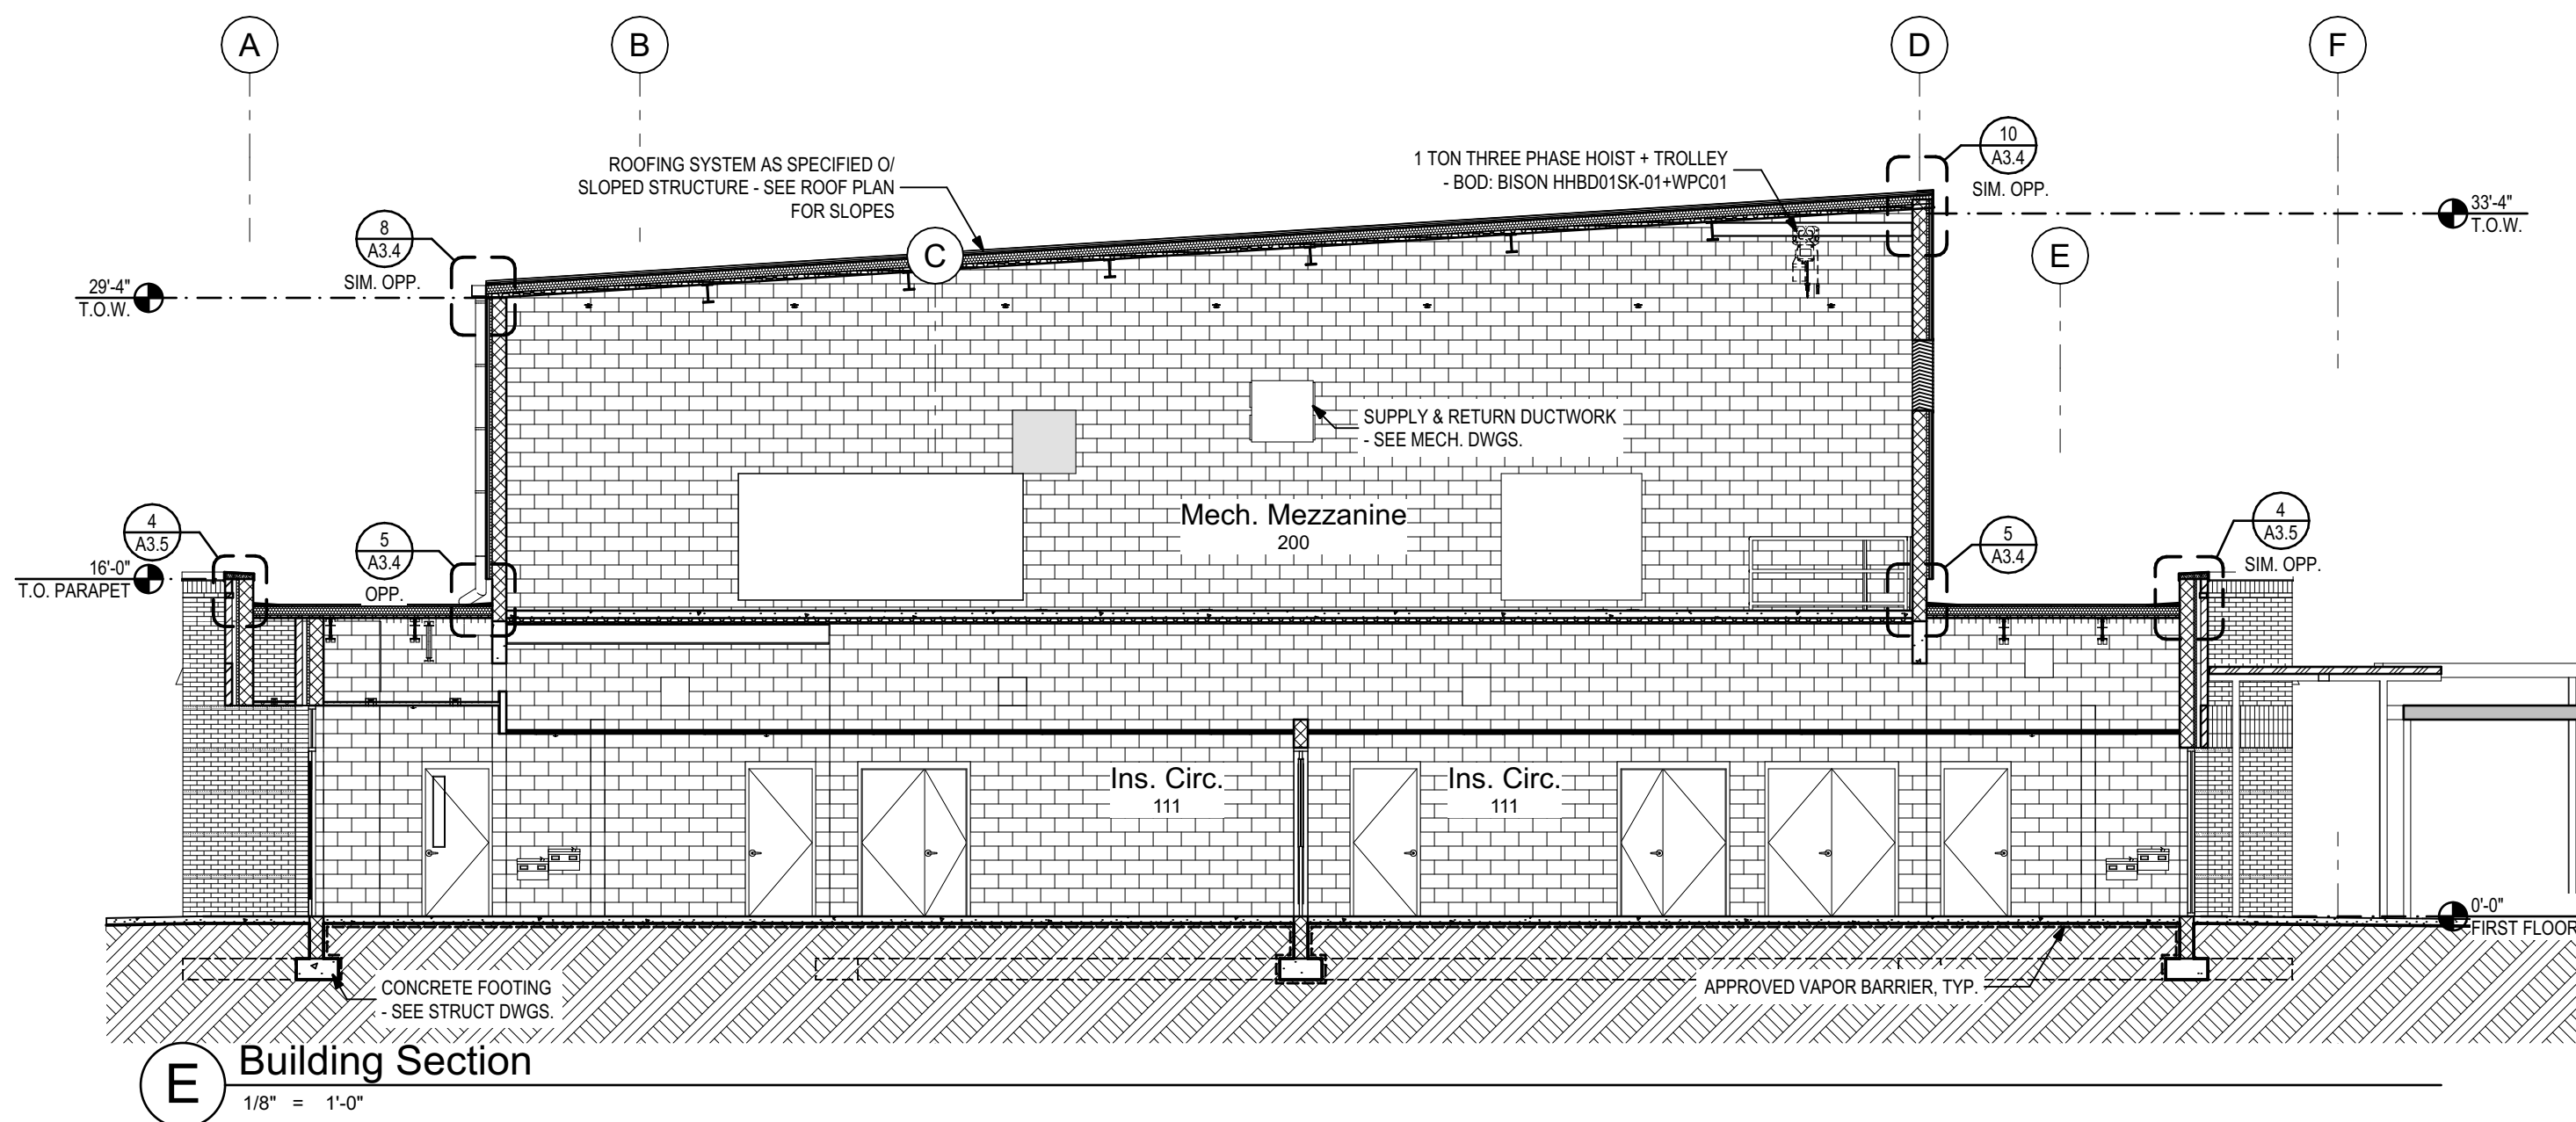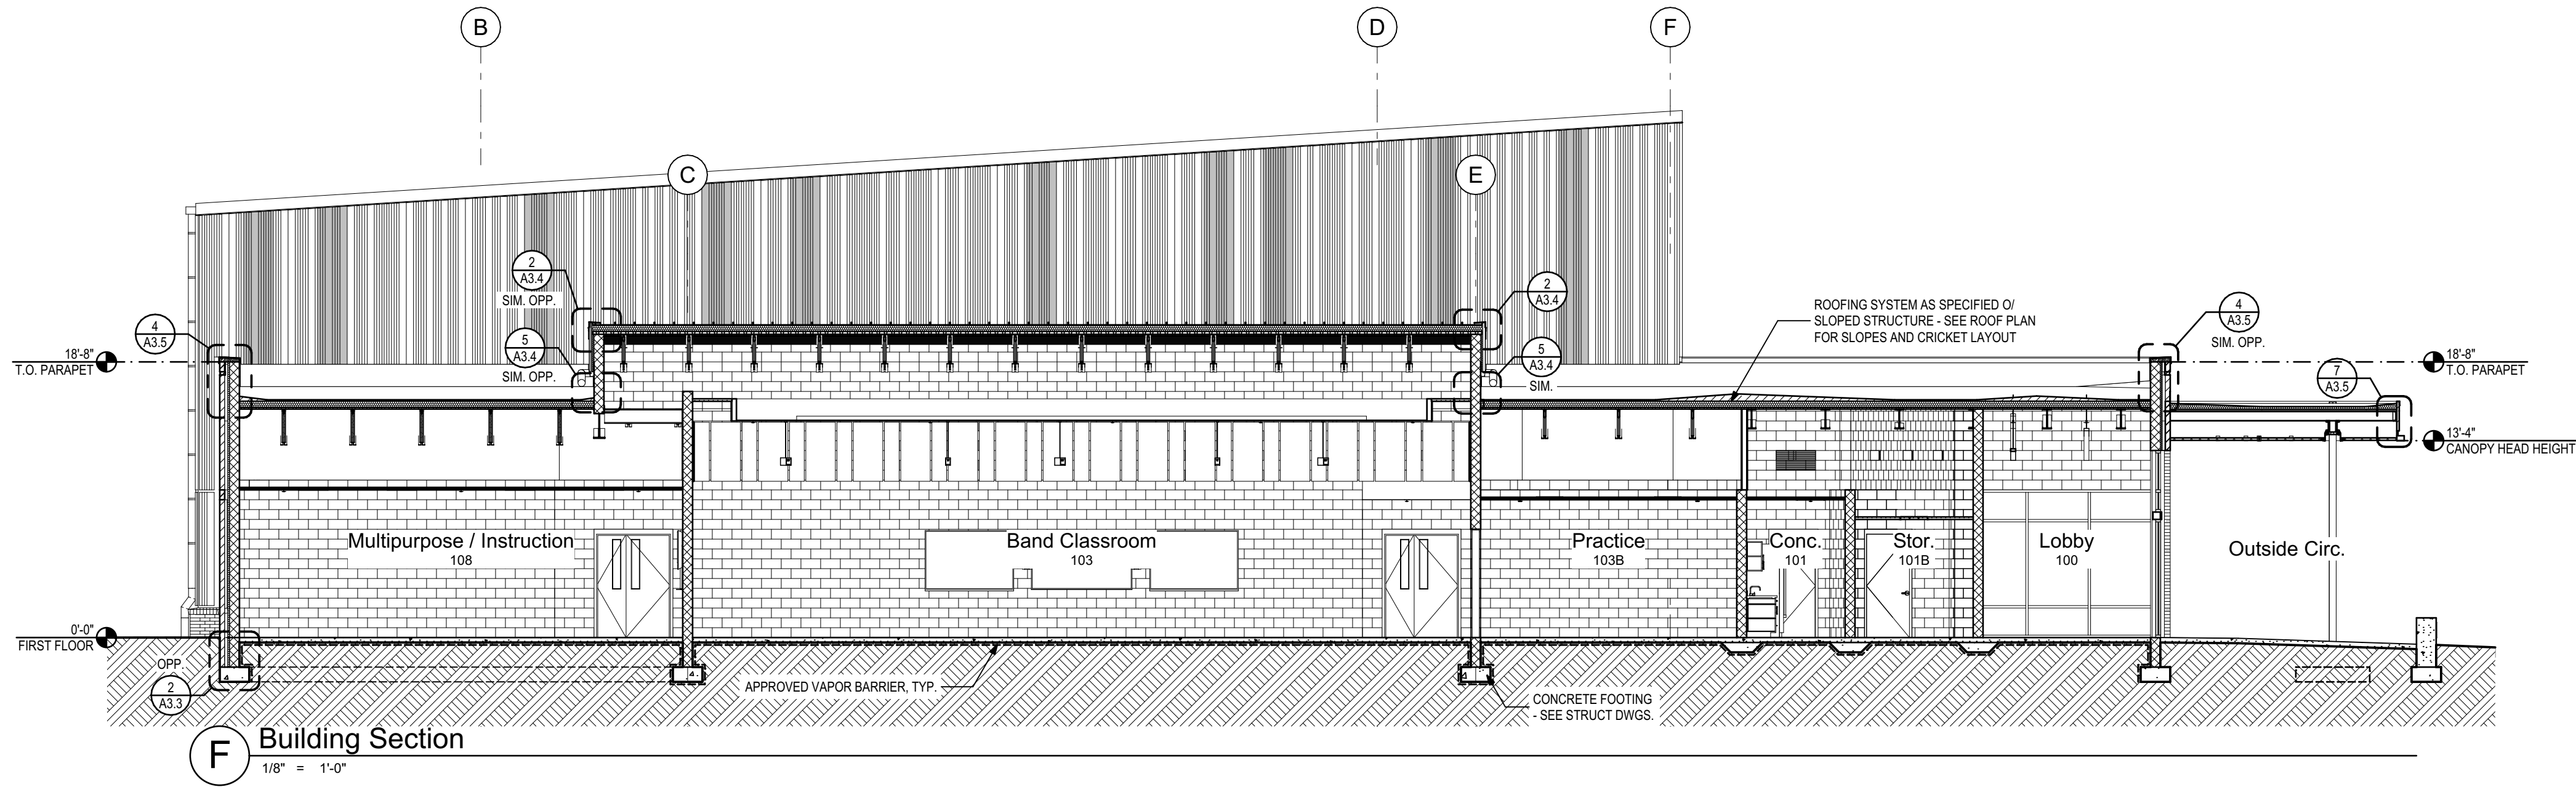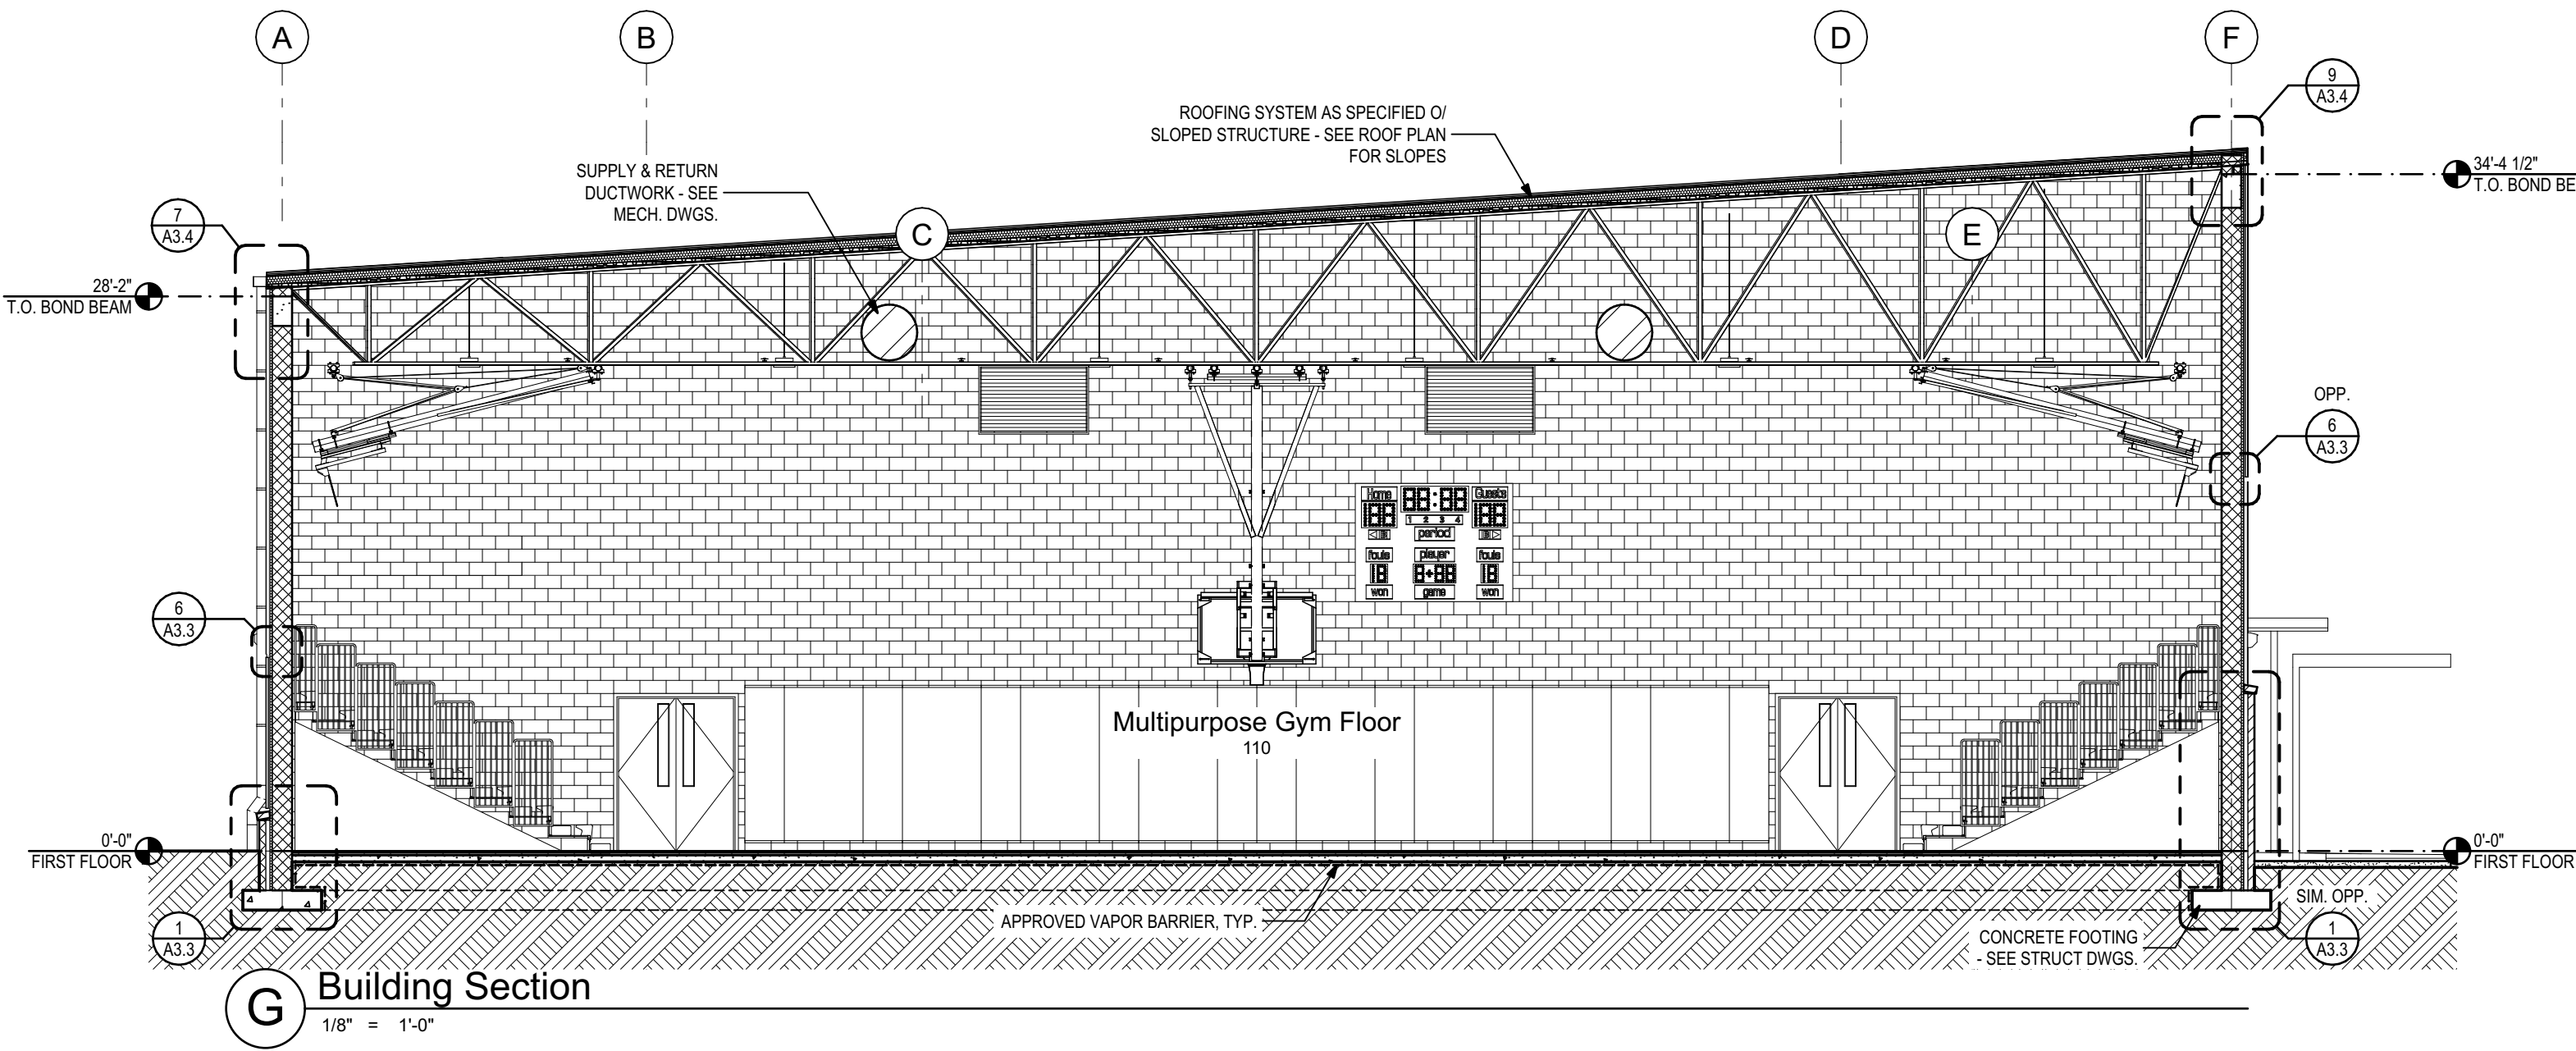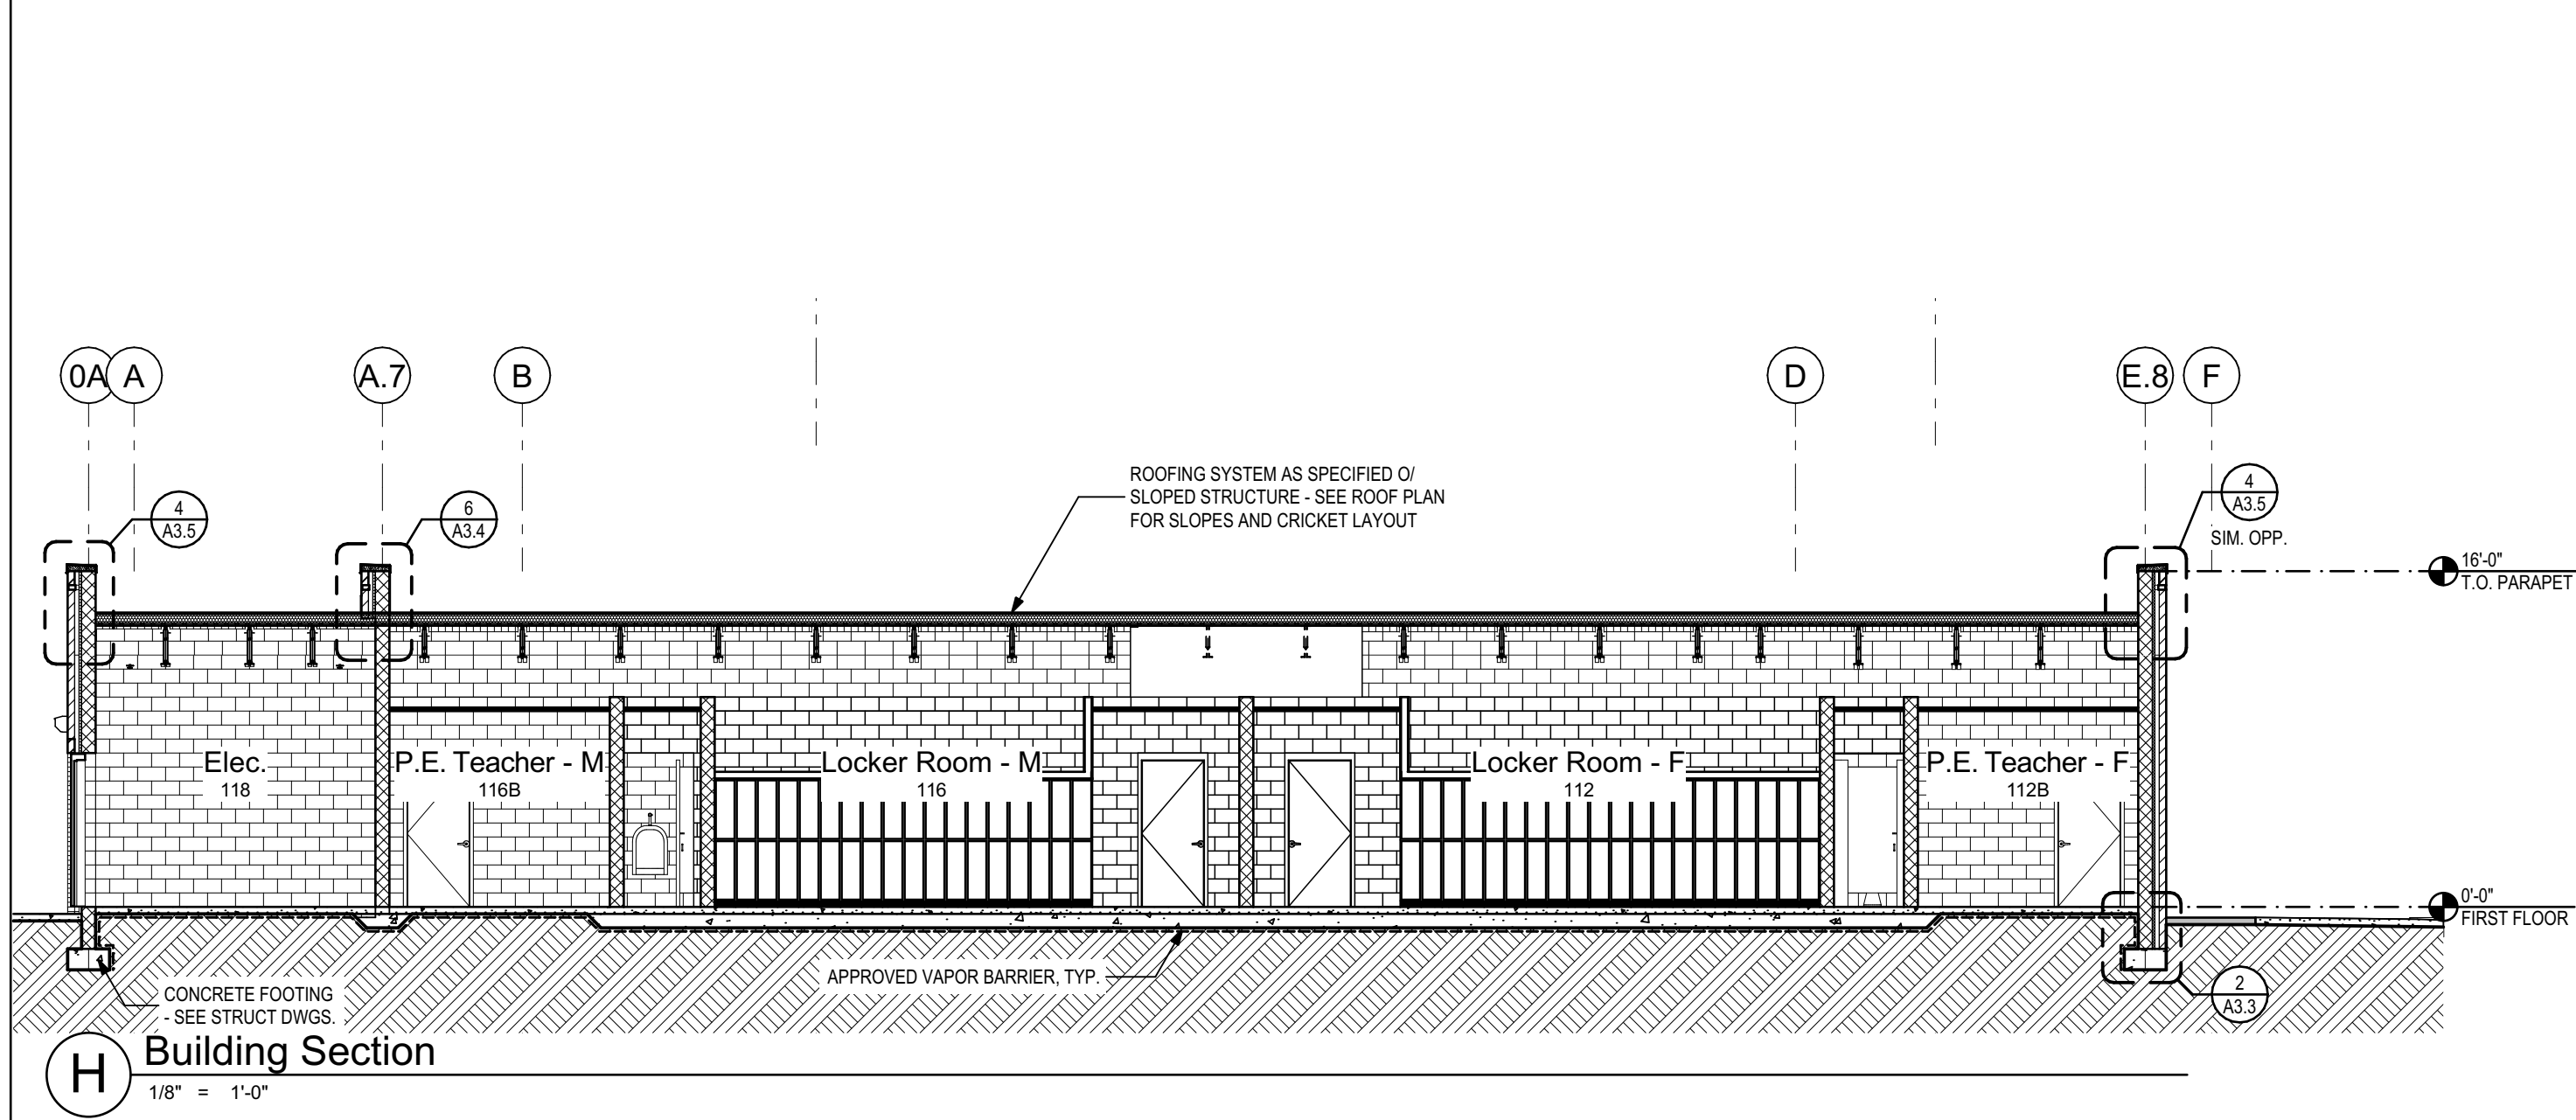

PHASE:	DRAWN:	REVIEWED:	DATE:	ID:	REVISION:	DRAWN:	REVIEWED:	DATE:
CONCEPT SCHEM. DESIGN	BG / RS	C. WHITLOCK	10/8/2024					
DESIGN DEVELOPMENT	BG/RS/SIMS	C. WHITLOCK	12/20/2024					
EARLY DEMOLITION PACKAGE	BG/RS/SIMS	R. LEWIS	03/21/2025					
80% CONSTRUCTION PACKAGE	BG/RS/SIMS	R. LEWIS	03/21/2025					
PERMIT DOCS.	BG/RS/SIMS	R. LEWIS	05/09/2025					
100% CONSTRUCTION DOCS.	BG/RS/SIMS	R. LEWIS	05/09/2025					

LEON COUNTY SCHOOLS

Client:

Consultant:

Seal:

Leon County Schools
3420 W. Tharpe St., Suite 100
Tallahassee, FL 32303

Job Title:
Griffin Middle School - Phase 2
800 Alabama St. Tallahassee, FL 32304

Project #:
23483

Phase:
100% CDs


ALW

Architects Lewis + Whitlock
206 West Virginia St.
Tallahassee, Florida 32301
850.942.1718
www.think3d.net

Description:
Building Sections



Sheet No.:
A3.2

THESE DRAWINGS AND RENDERINGS ARE INSTRUMENTS OF SERVICE. THE DRAWINGS AND ASSOCIATED COPIES THEREOF, INCLUDING ELECTRONIC MEDIA AND CAD FILES, ARE THE PROPERTY OF ARCHITECTS LEWIS + WHITLOCK, P.A. THEIR USE, REPRESENTATION OR REPRODUCTION FOR ANY PURPOSE EXCEPT BY WRITTEN AGREEMENT WITH THE ARCHITECT IS PROHIBITED. THIS COPYRIGHT NOTIFICATION SHALL BE TRUE AS IF DIRECTLY PLACED ON EACH DRAWING EXHIBIT OR RENDERING ON THIS DOCUMENT AND SHALL NOT BE REMOVED FROM THESE DOCUMENTS.

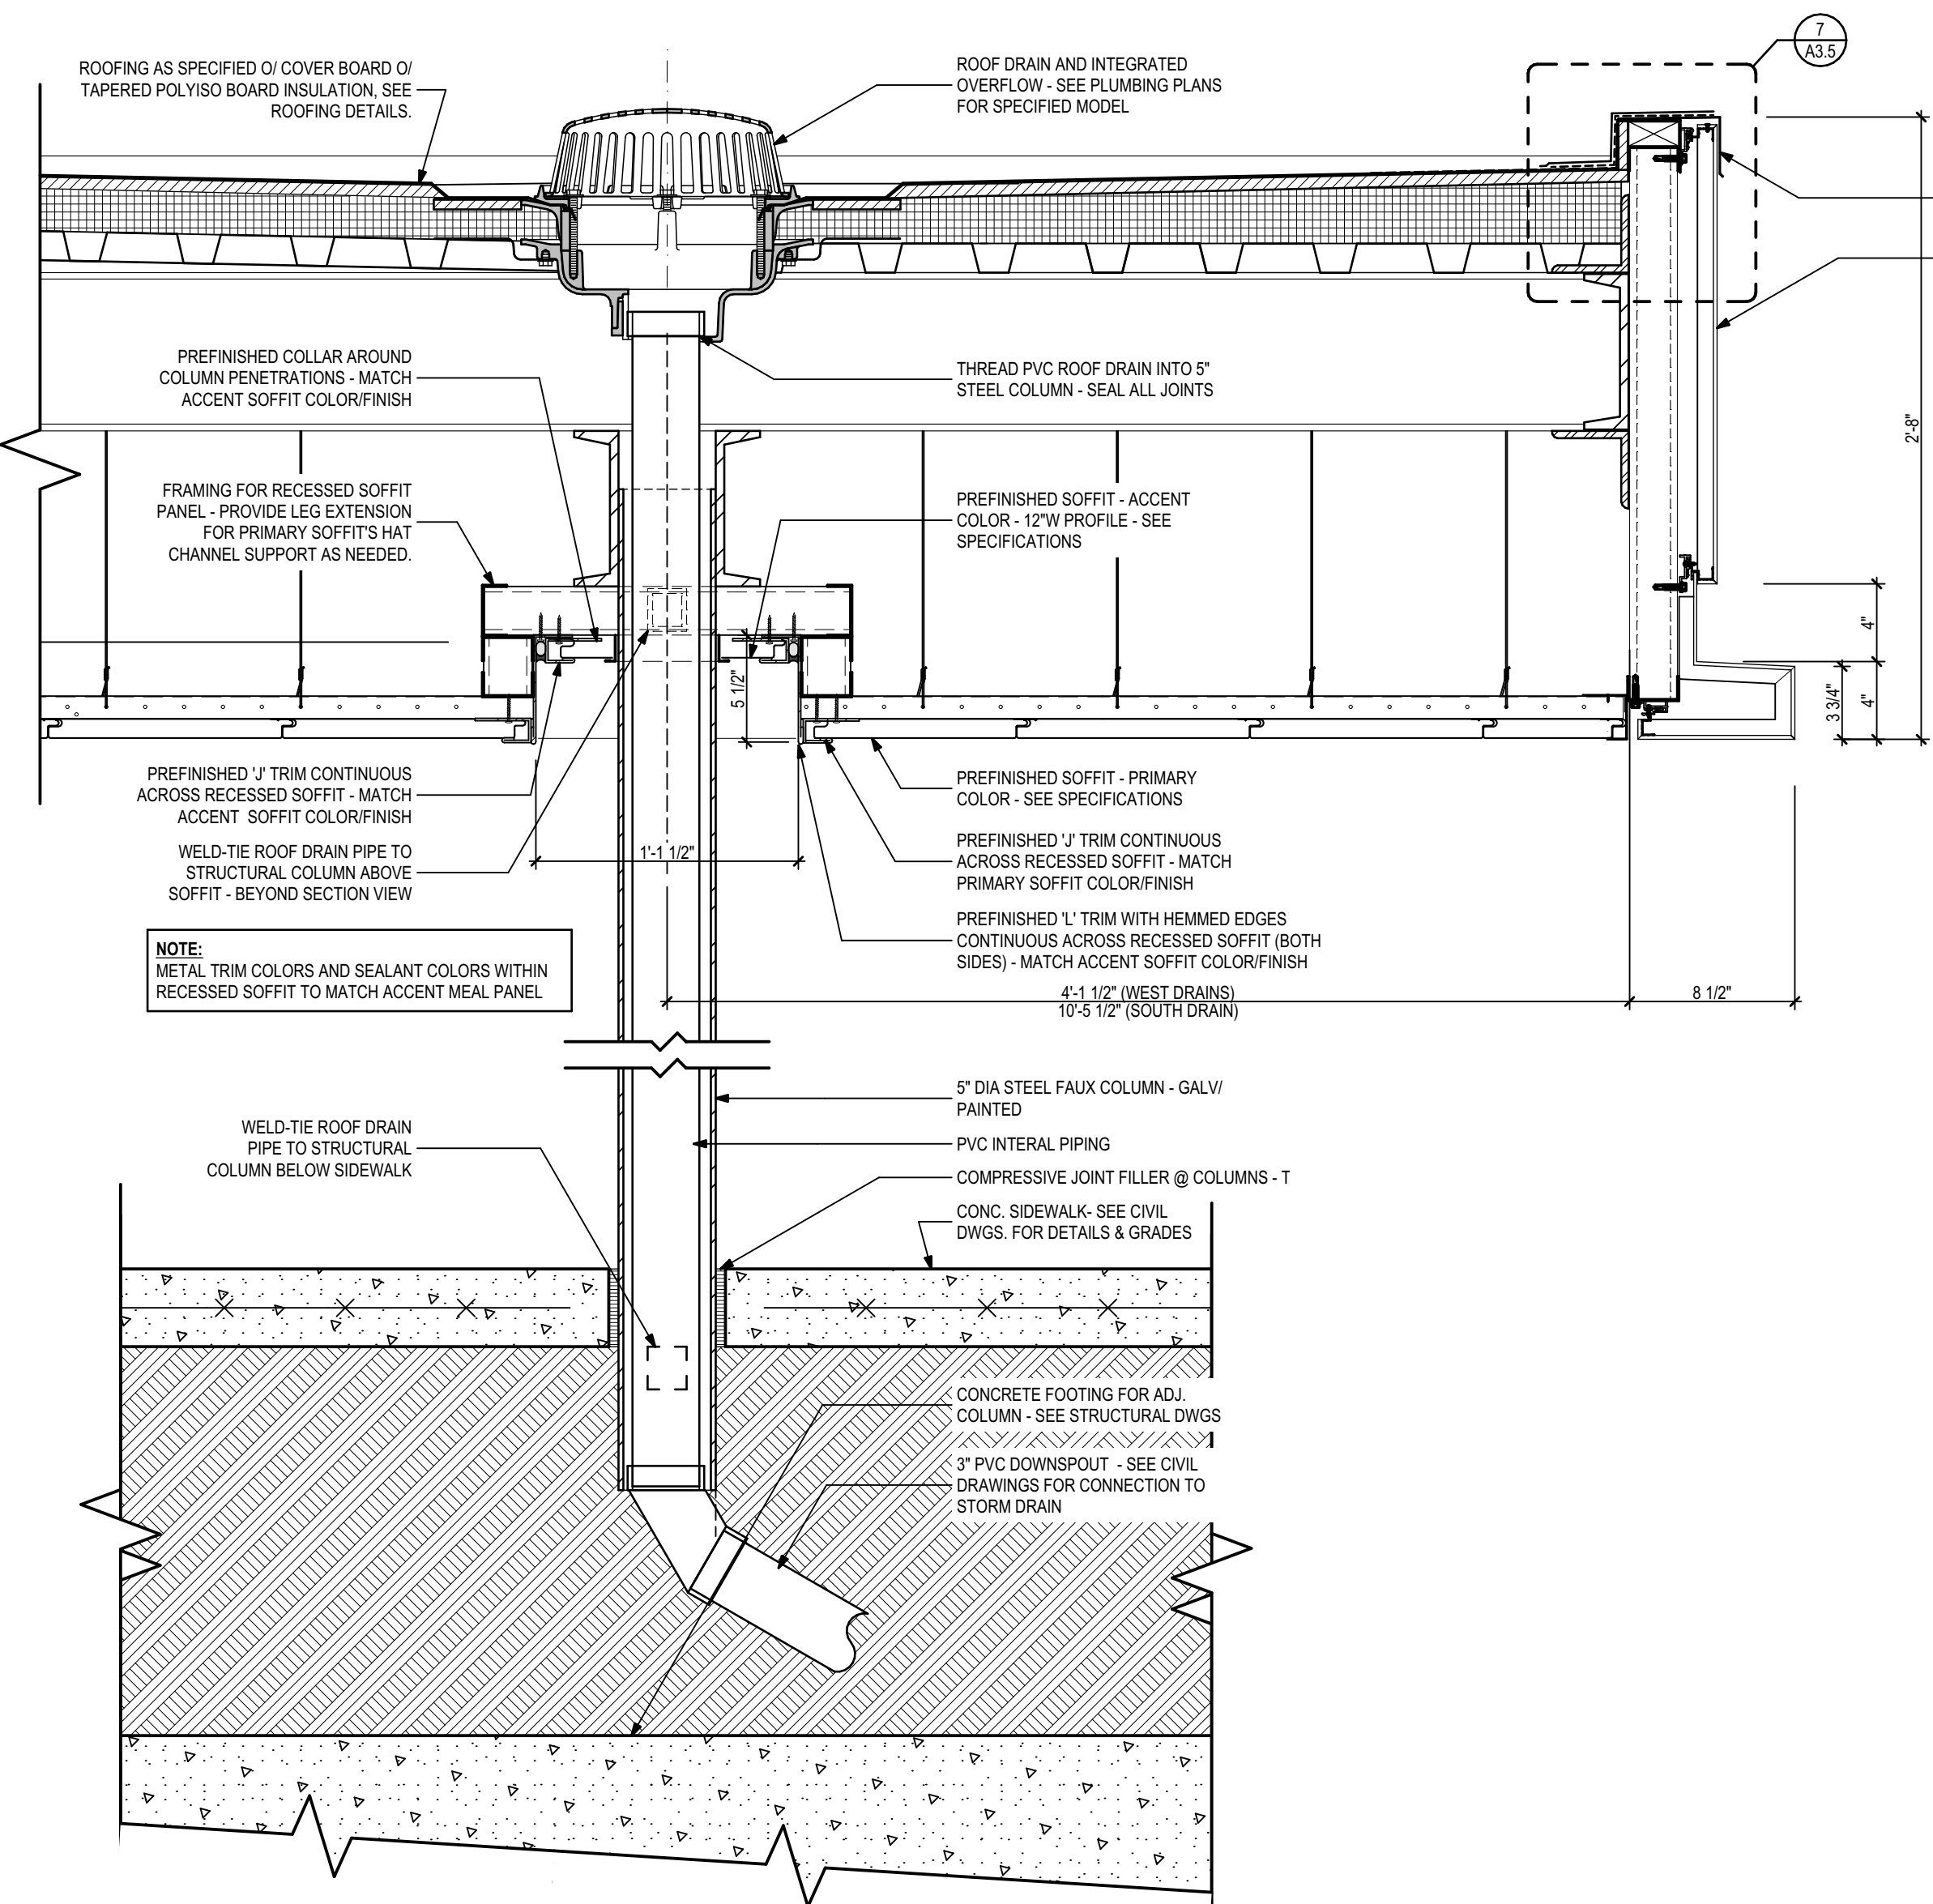


3 Section Detail At Downspout Column / Canopy Roof Drain
1 1/2"= 1'-0"


10 Detail At Downspout Column / Canopy Roof Overflow Drain
1 1/2"= 1'-0"

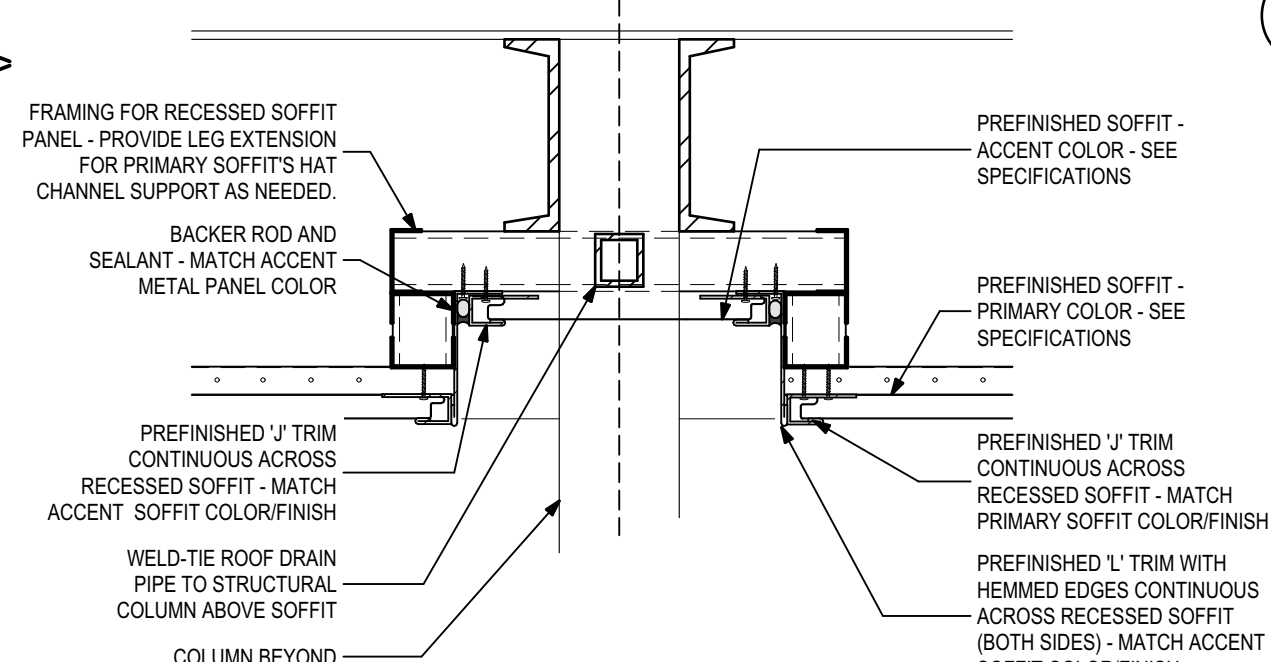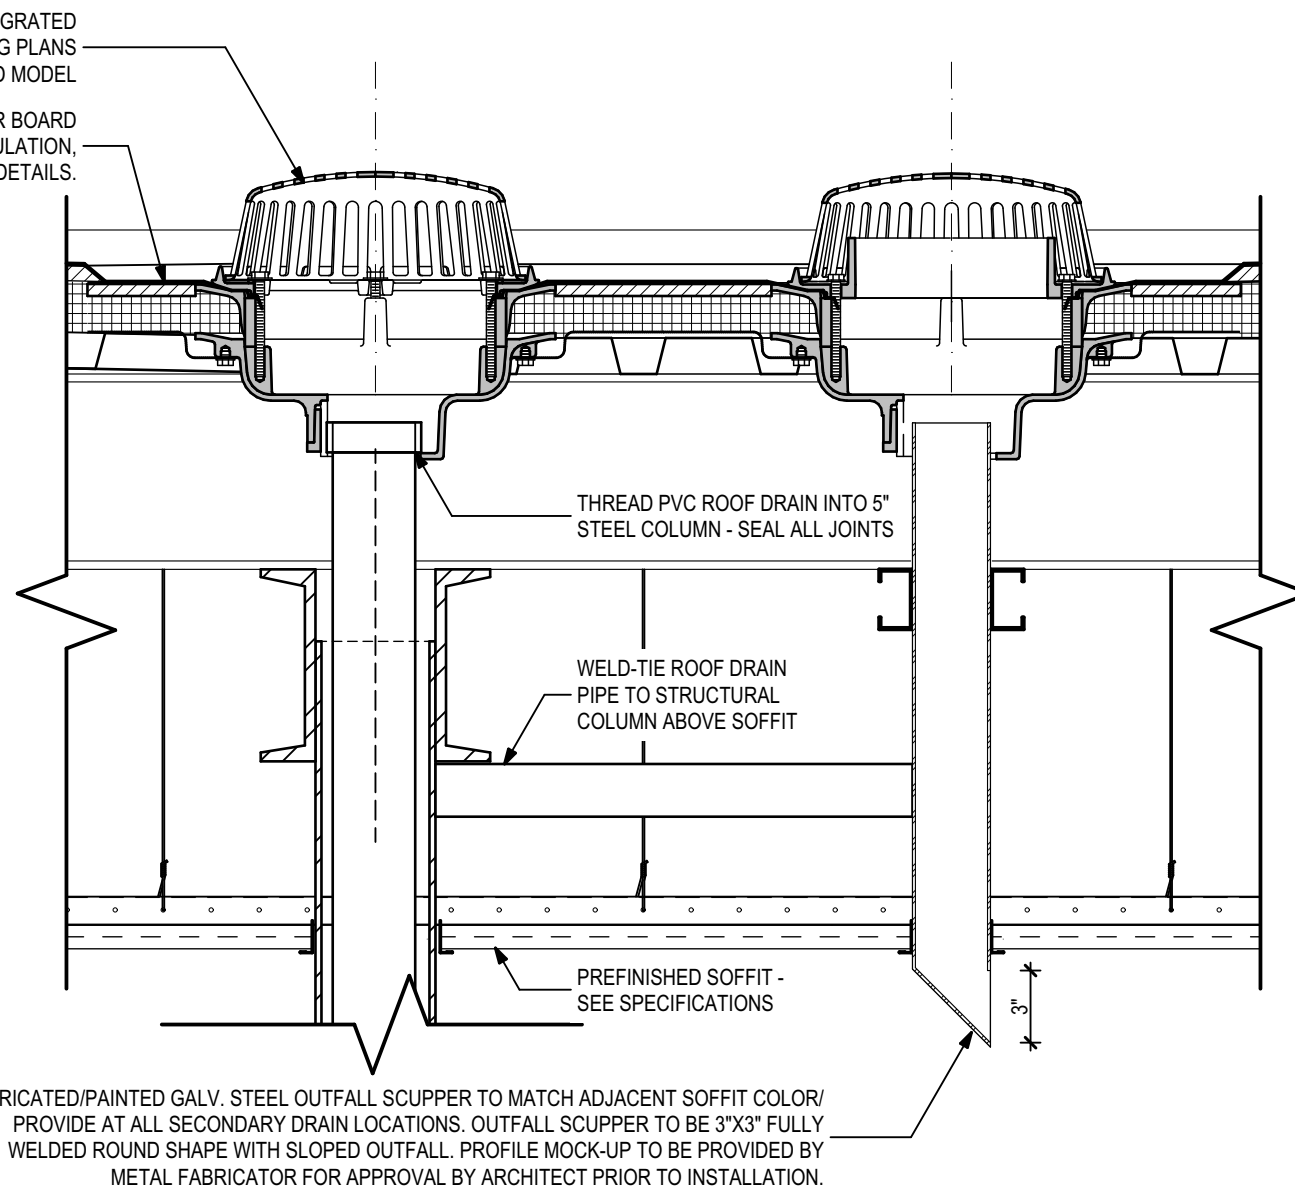


11 Detail At Recessed Soffit
1 1/2"= 1'-0"

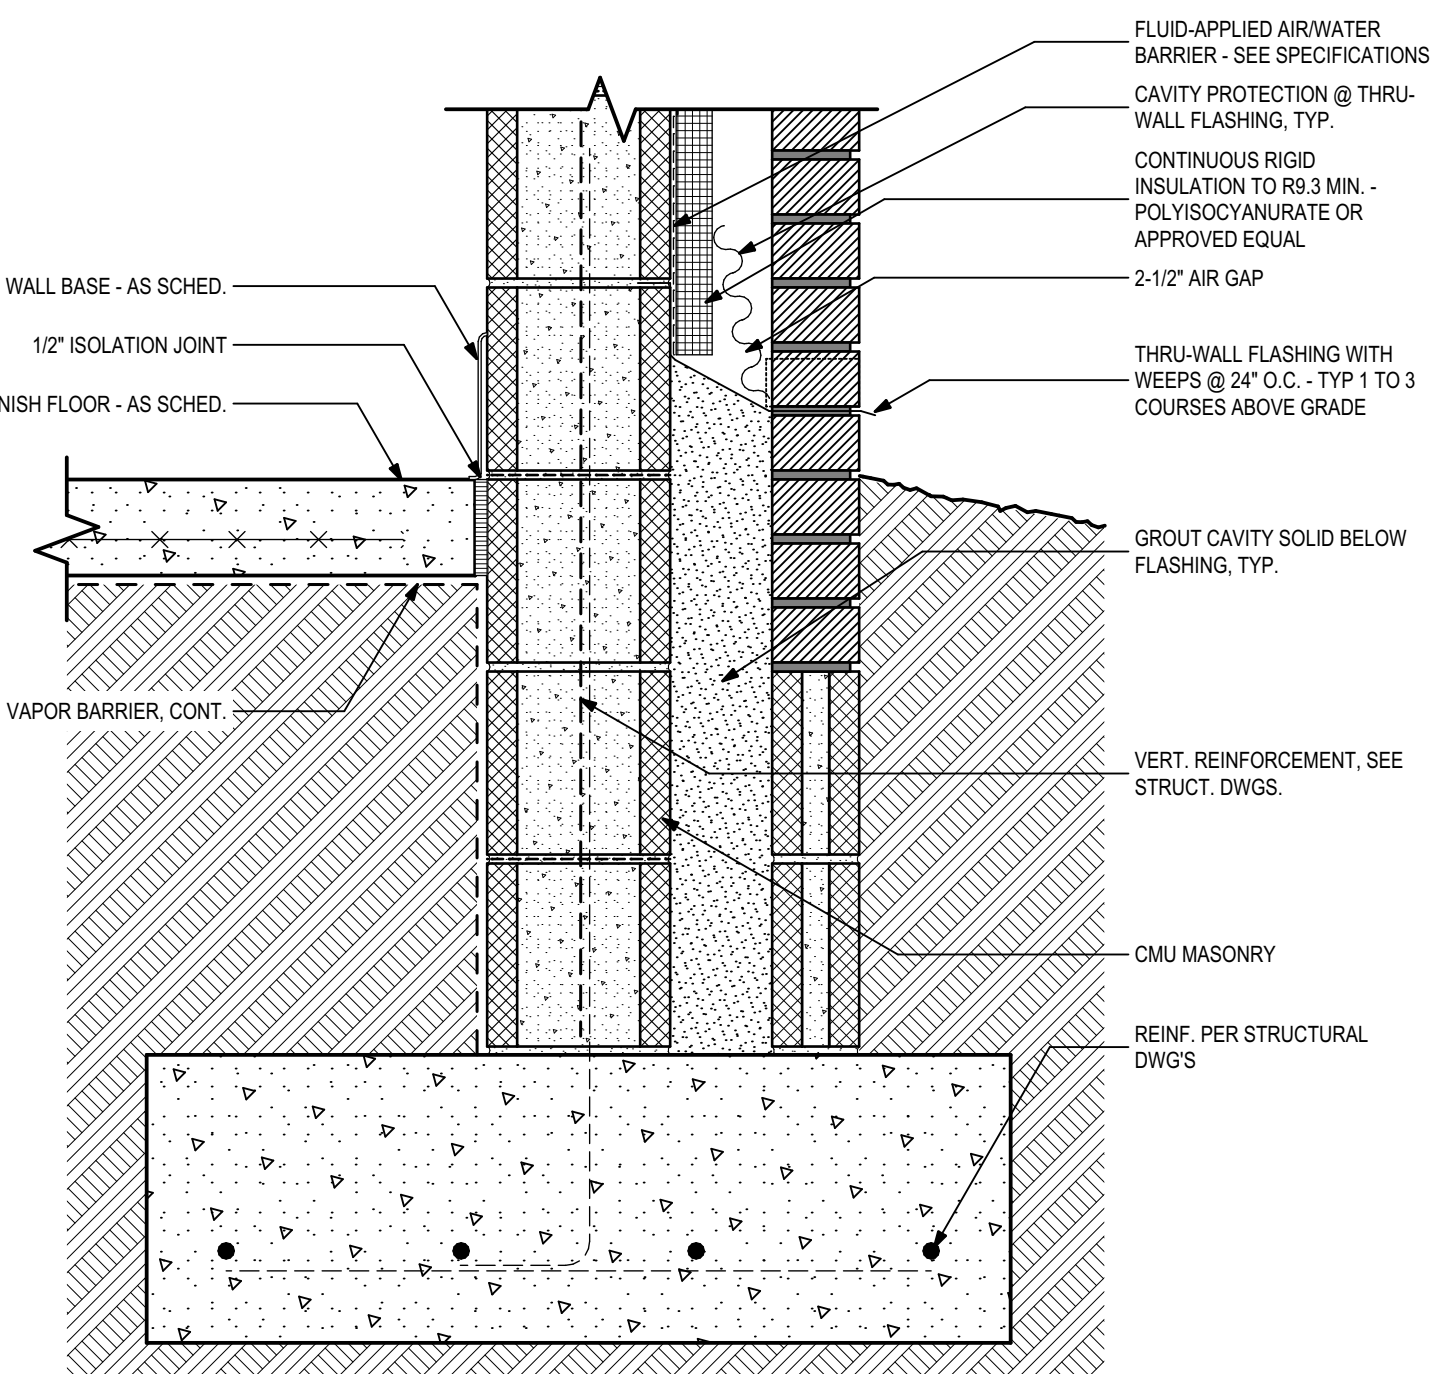

2 Typical Foundation Detail At Grade
1 1/2"= 1'-0"


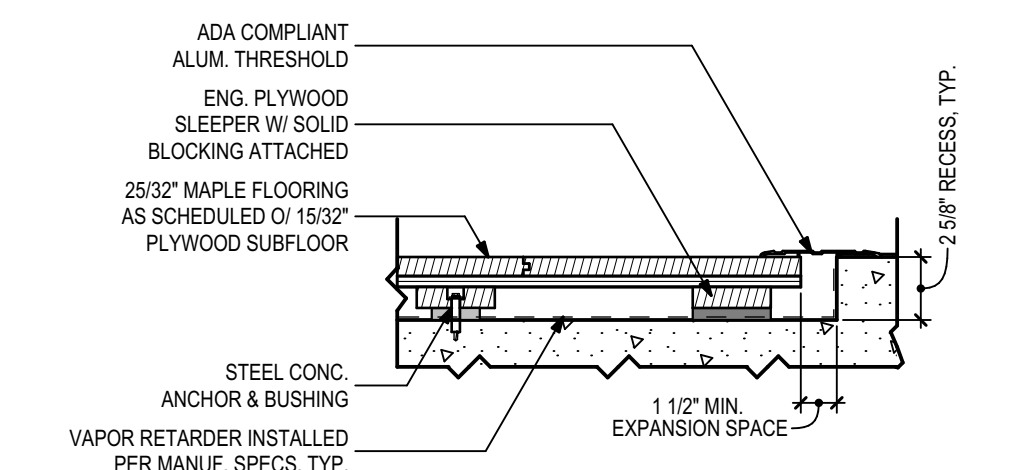


4 Gym Floor Section Detail At LVT Transition
1 1/2"= 1'-0"

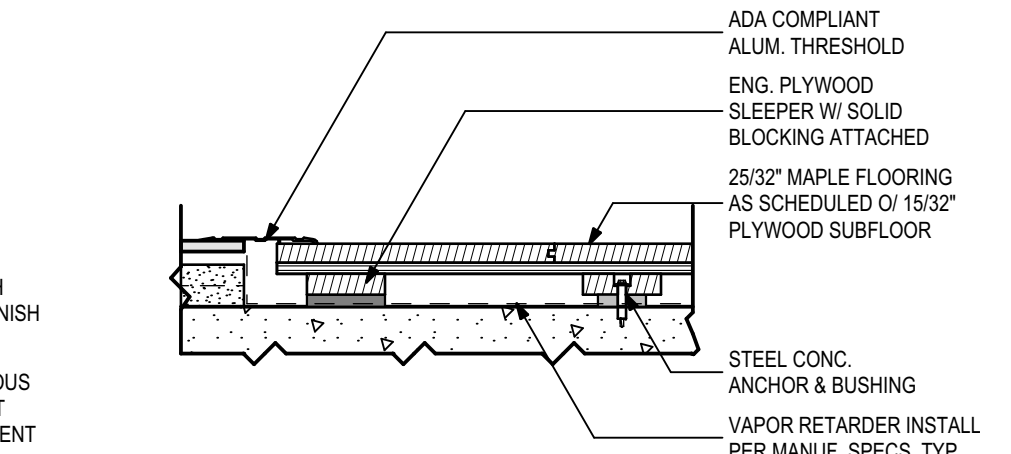


5 Gym Floor Section Detail At Tile Transition
1 1/2"= 1'-0"


7 Gym Floor Section Detail At Inserts
1 1/2"= 1'-0"

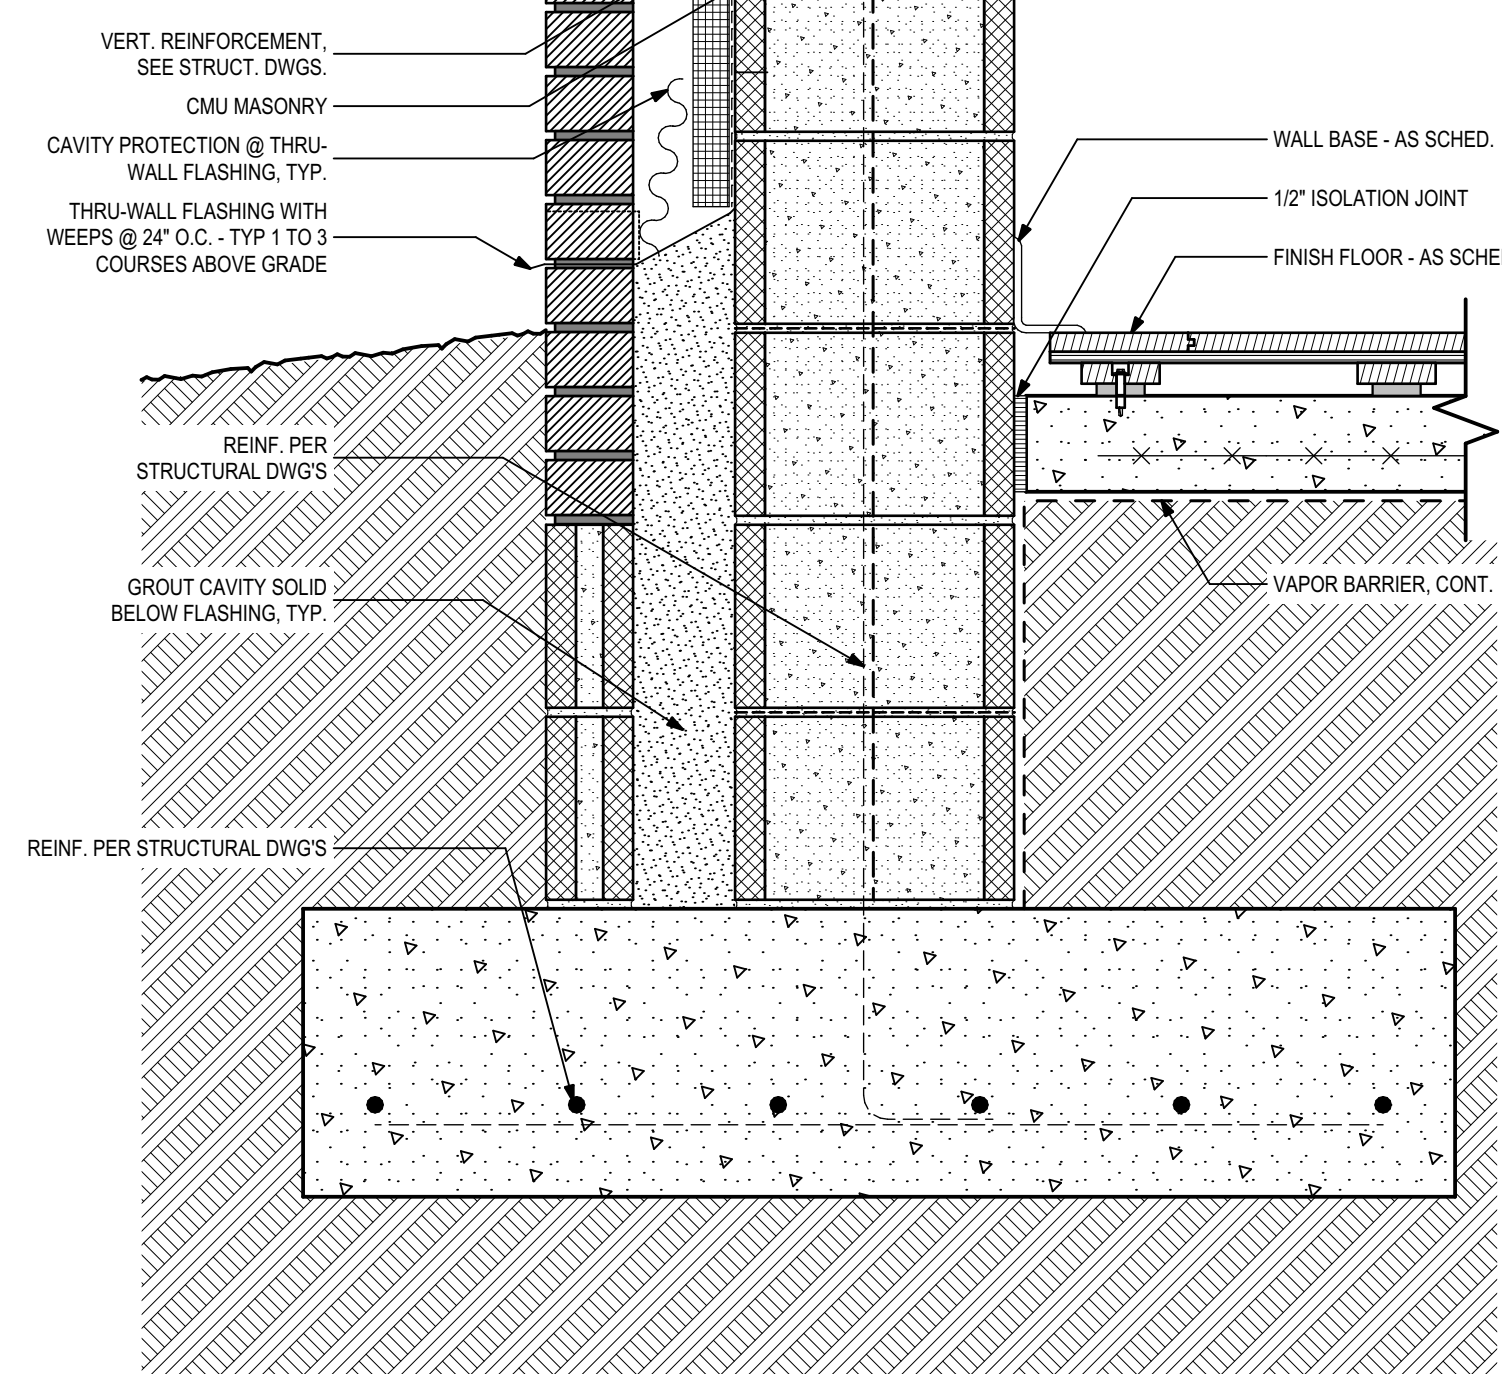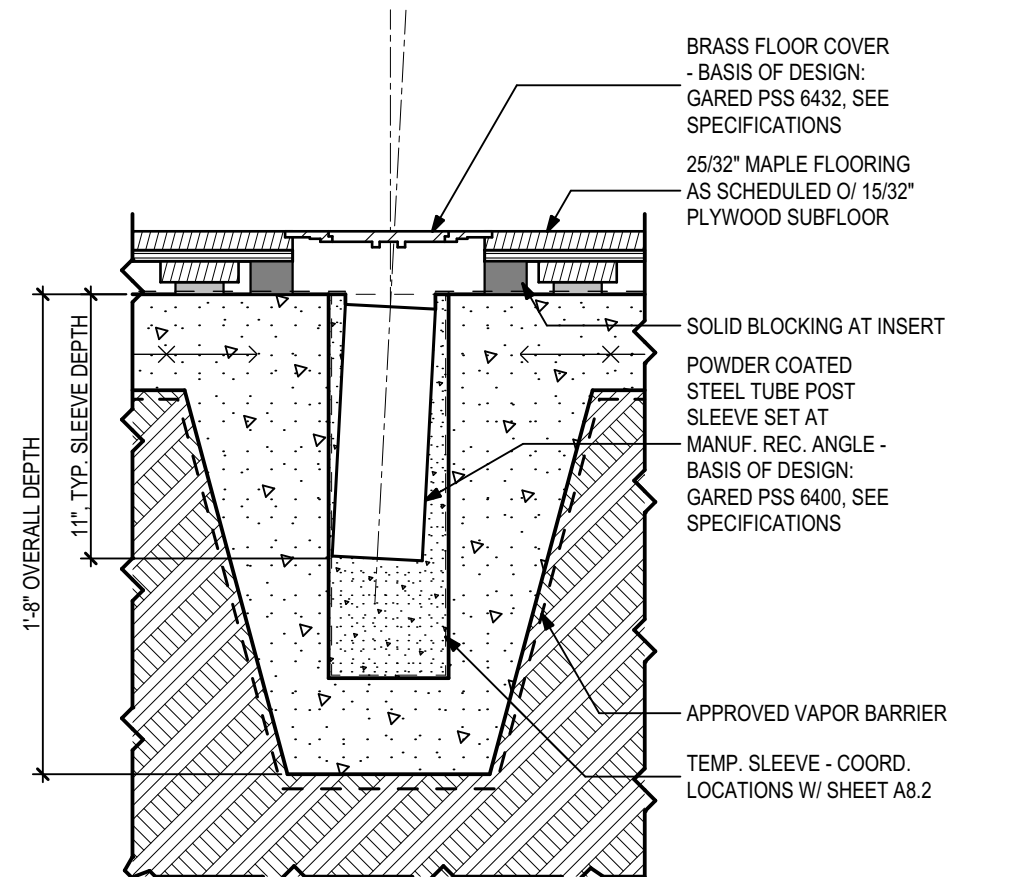


1 Typical Foundation Detail At Metal Wall Panel Transition
1 1/2"= 1'-0"

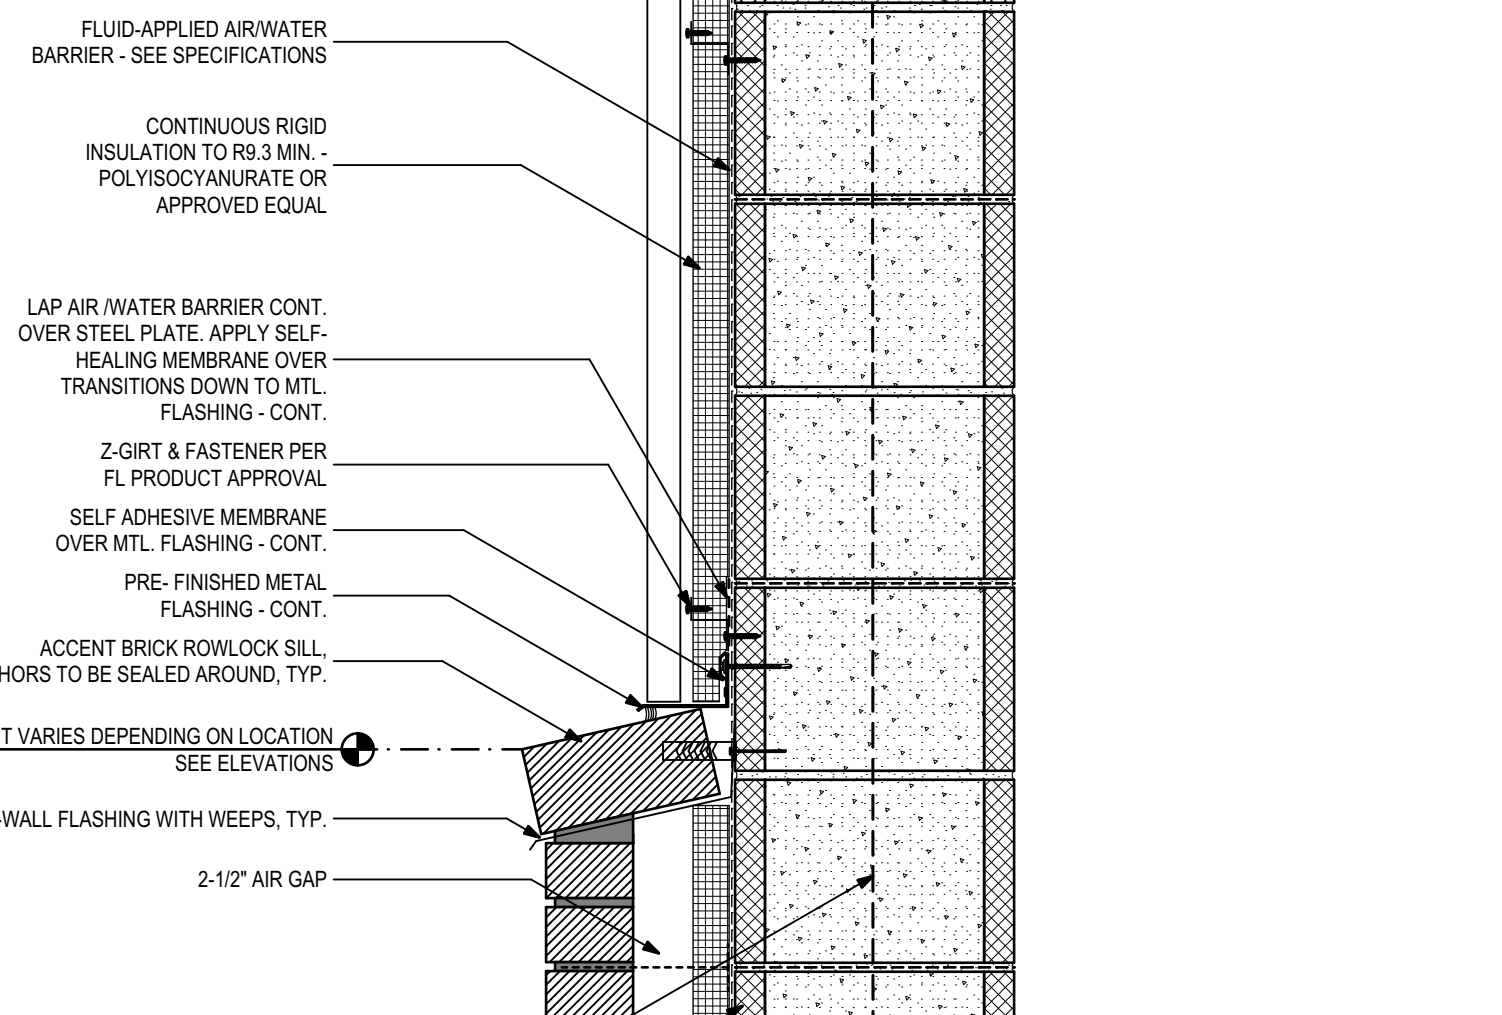

6 Typical Splice Detail
1 1/2"= 1'-0"

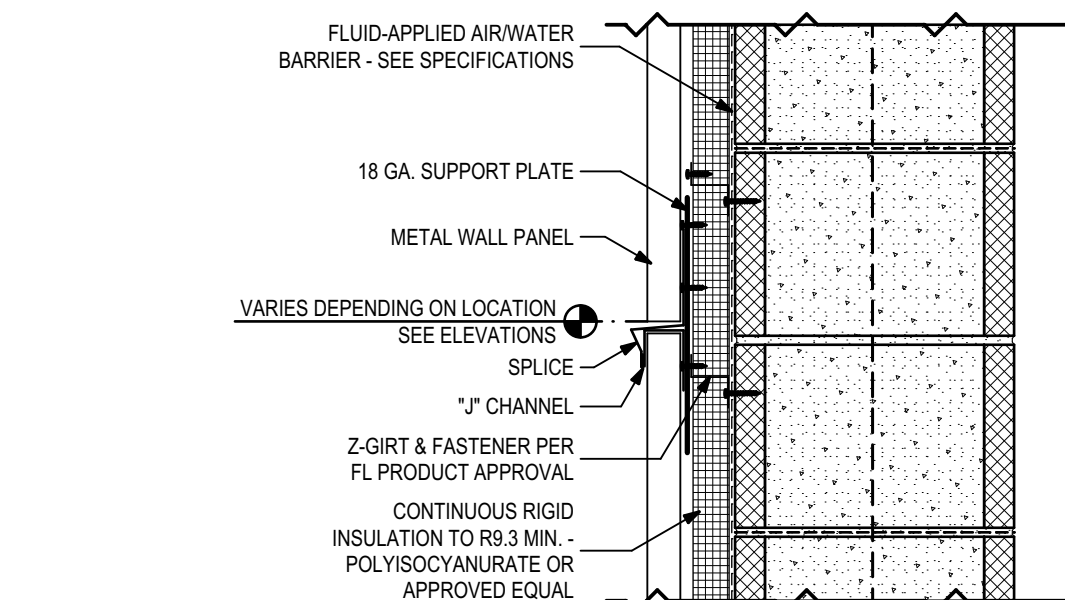

8 Gym Floor Section Detail At Wall Base
1 1/2"= 1'-0"

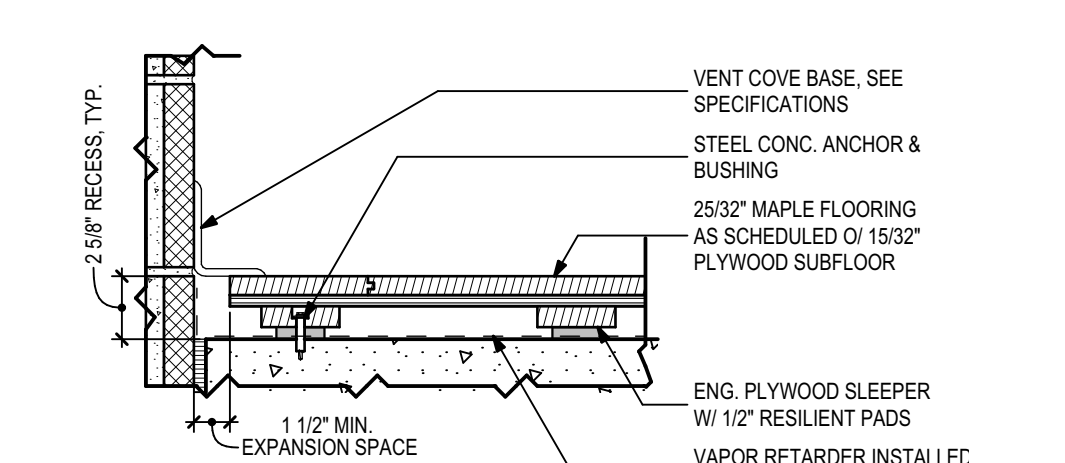

PHASE:	DRAWN:	REVIEWED:	DATE:	ID:	REVISION:	DRAWN:	REVIEWED:	DATE:
CONCEPT SCHEM. DESIGN	BG/RS	C. WHITLOCK	10/8/2024			BG/RS	C. WHITLOCK	12/20/2024
DESIGN DEVELOPMENT	BG/RS	C. WHITLOCK	12/20/2024			BG/RS	C. WHITLOCK	12/20/2024
EARLY DEMOLITION PACKAGE	BG/RS	C. WHITLOCK	12/20/2024			BG/RS	C. WHITLOCK	12/20/2024
80% CONSTRUCTION PACKAGE	BG/RS	C. WHITLOCK	12/20/2024			BG/RS	C. WHITLOCK	12/20/2024
PERMIT DOCS	BG/RS	C. WHITLOCK	12/20/2024			BG/RS	C. WHITLOCK	12/20/2024
100% CONSTRUCTION DOCS	BG/RS	C. WHITLOCK	12/20/2024			BG/RS	C. WHITLOCK	12/20/2024

LEON COUNTY SCHOOLS

Client: Leon County Schools
3420 W. Tharpe St., Suite 100
Tallahassee, FL 32303

Job Title: Griffin Middle School - Phase 2
800 Alabama St. Tallahassee, FL 32304

Consultant: 23483
Project #: 100% CDs

Seal:

Architects Lewis + Whitlock
206 West Virginia St.
Tallahassee, Florida 32301
850.942.1718
www.think3d.net

Description:
Foundation & Section Details

Sheet No.: A3.3

ALW


Architects Lewis + Whitlock
206 West Virginia St.
Tallahassee, Florida 32301
850.942.1718
www.think3d.net

Description:
Foundation & Section Details


Sheet No.:

A3.3


THESE DRAWINGS AND RENDERINGS ARE INSTRUMENTS OF SERVICE. THE DRAWINGS AND ASSOCIATED COPIES THEREOF, INCLUDING ELECTRONIC MEDIA AND CAD FILES, ARE THE PROPERTY OF ARCHITECTS LEWIS + WHITLOCK, P.A. THEIR USE, REPRODUCTION OR REPRODUCTION FOR ANY PURPOSE EXCEPT BY WRITTEN AGREEMENT WITH THE ARCHITECT IS PROHIBITED. THIS COPYRIGHT NOTIFICATION SHALL BE TRUE AS F DIRECTLY PLACED ON EACH DRAWING EXISTING ON THESE DOCUMENTS.

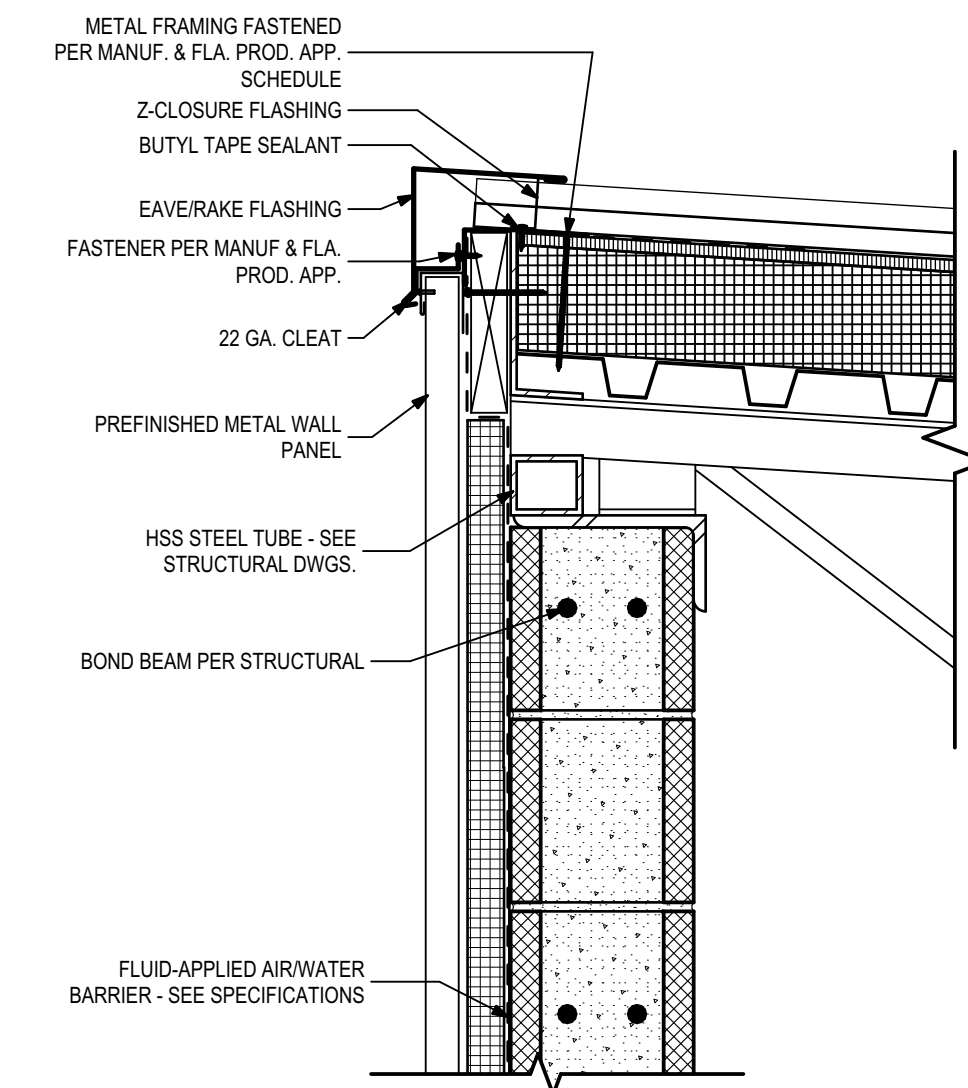


10 High Roof Section Detail 8" CMU Wall
1 1/2"= 1'-0"

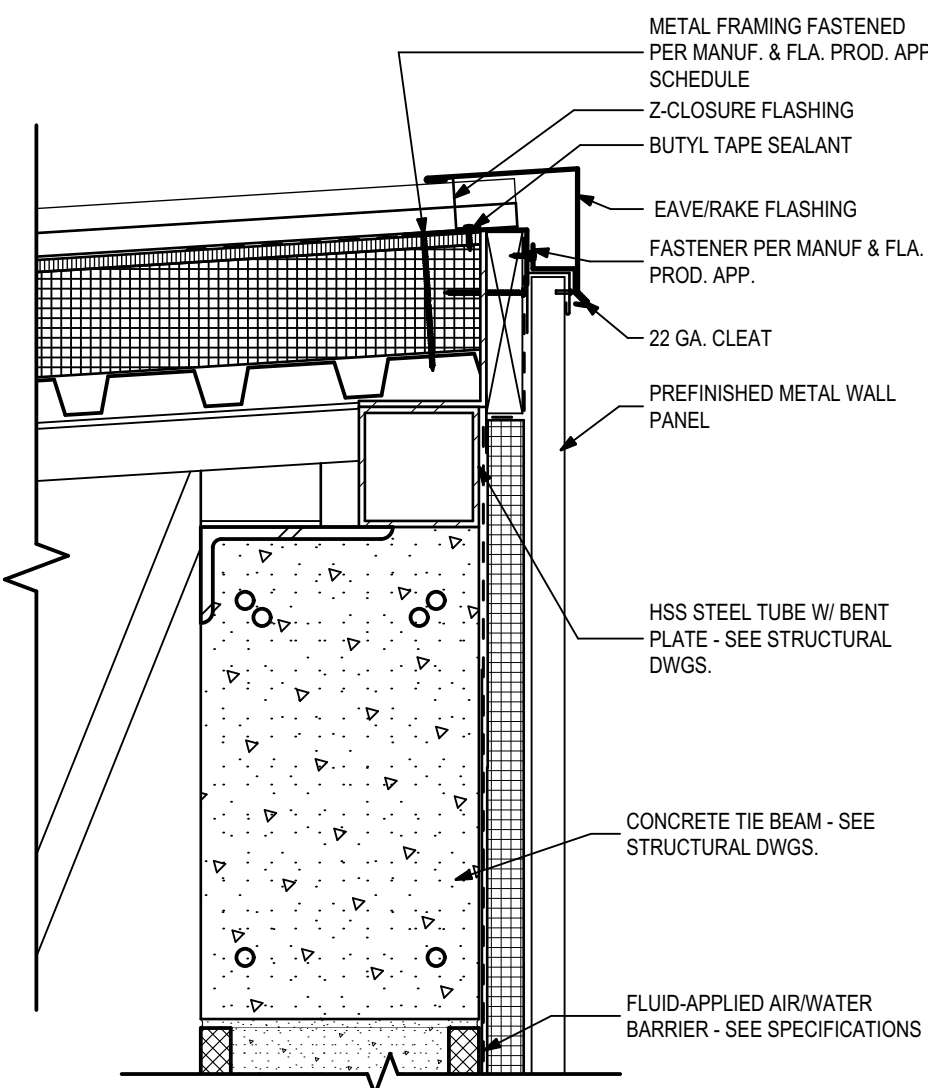


9 High Roof Section Detail 12" CMU Wall
1 1/2"= 1'-0"

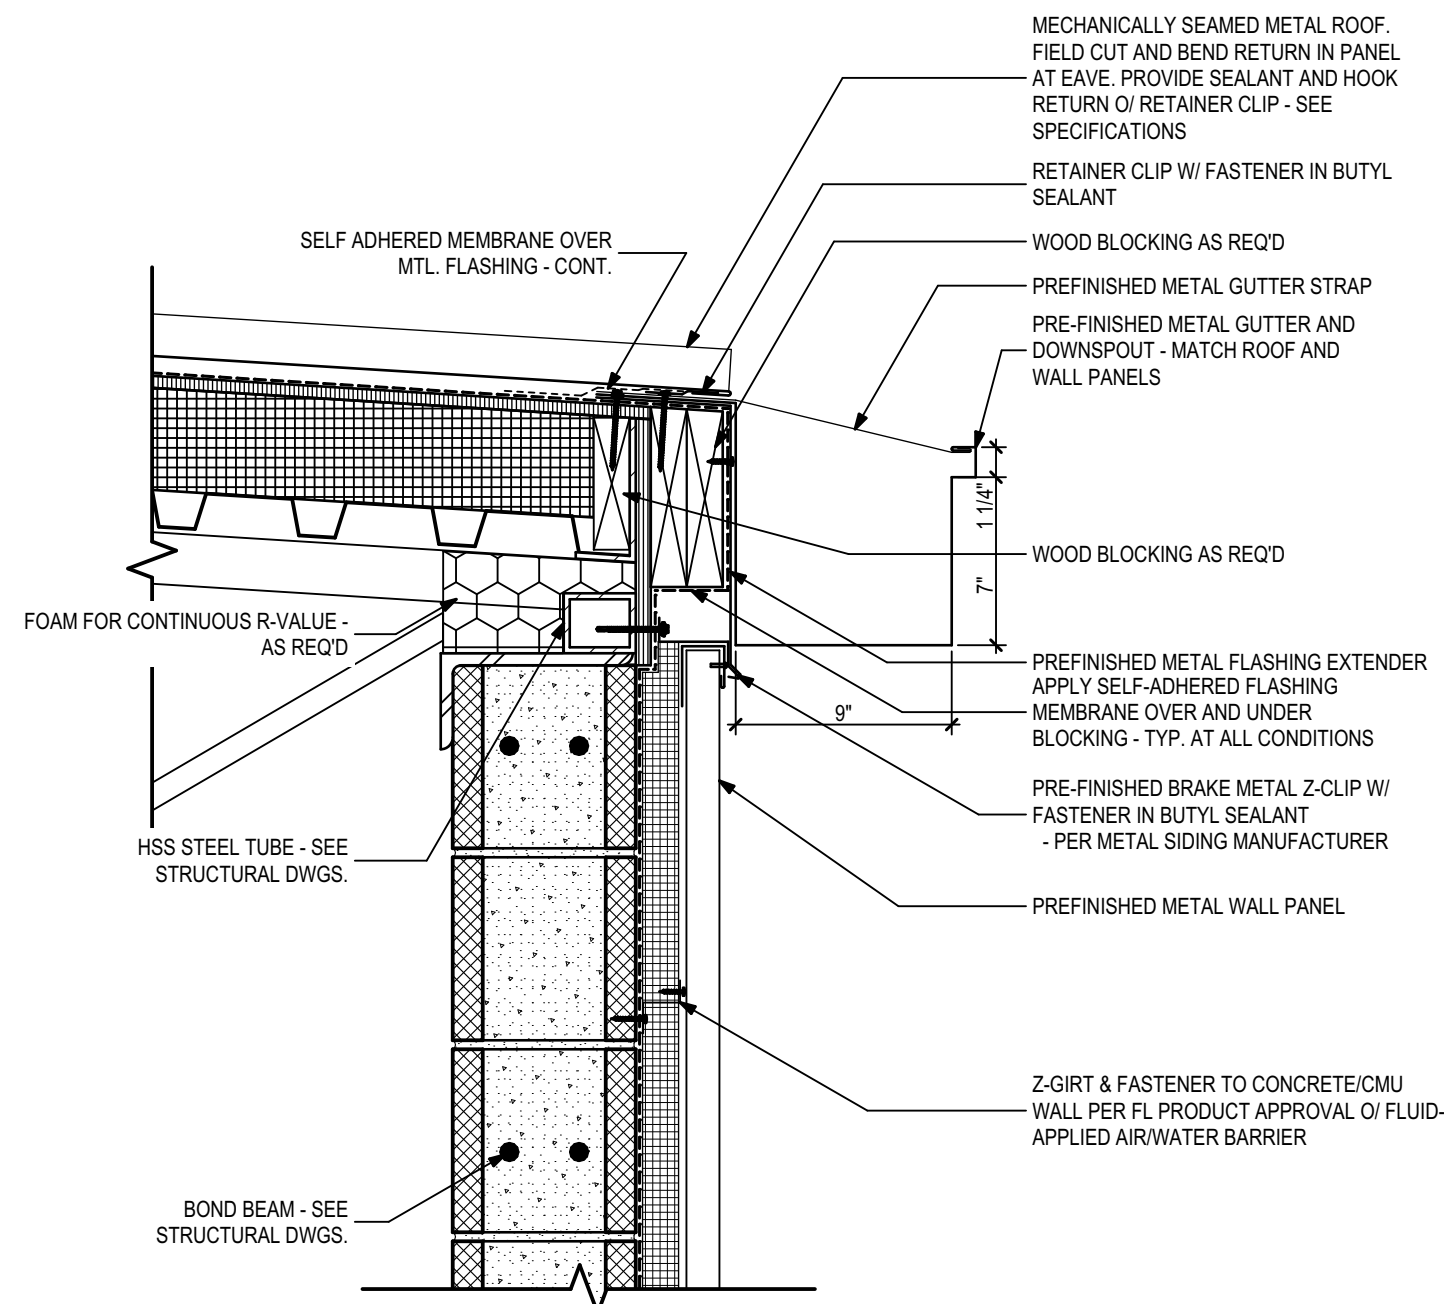


8 Typical Low Peak Roof - Gutter 8" CMU Wall
1 1/2"= 1'-0"

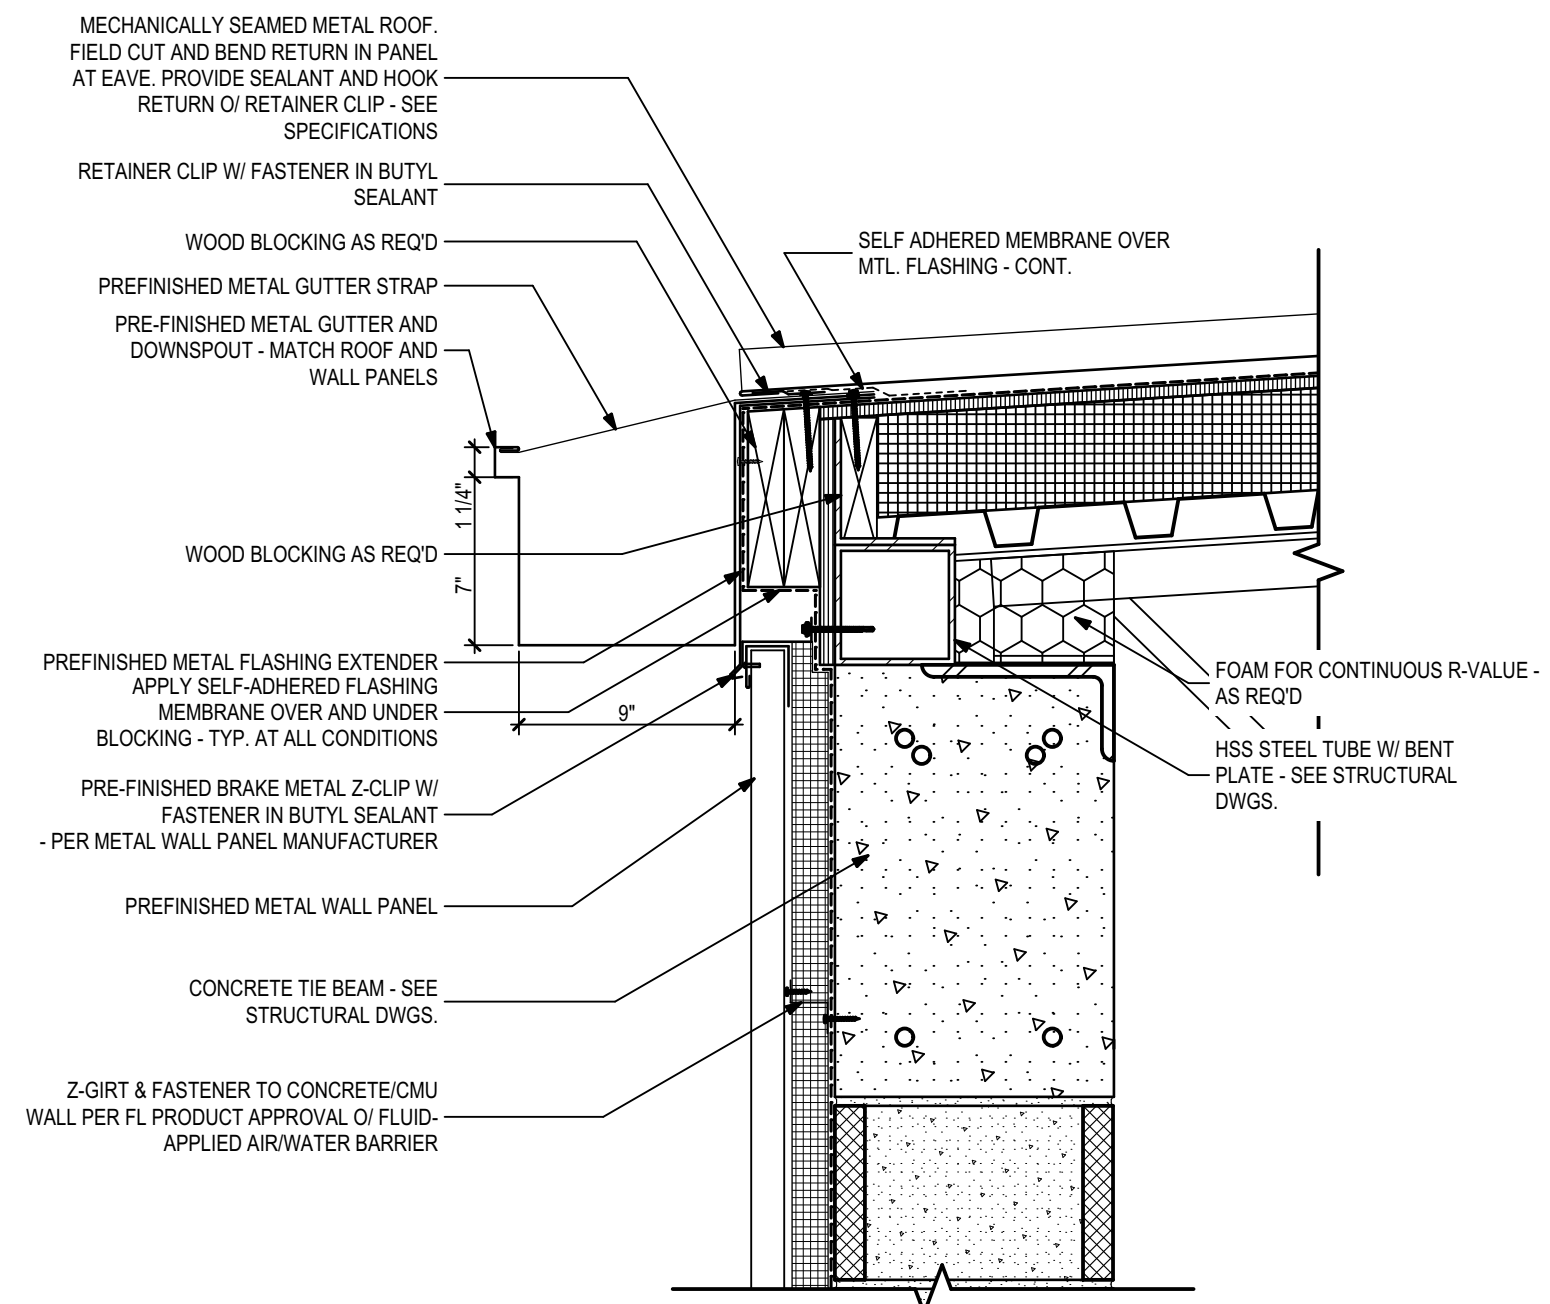


7 Typical Low Peak Roof Gutter 12" CMU Wall
1 1/2"= 1'-0"

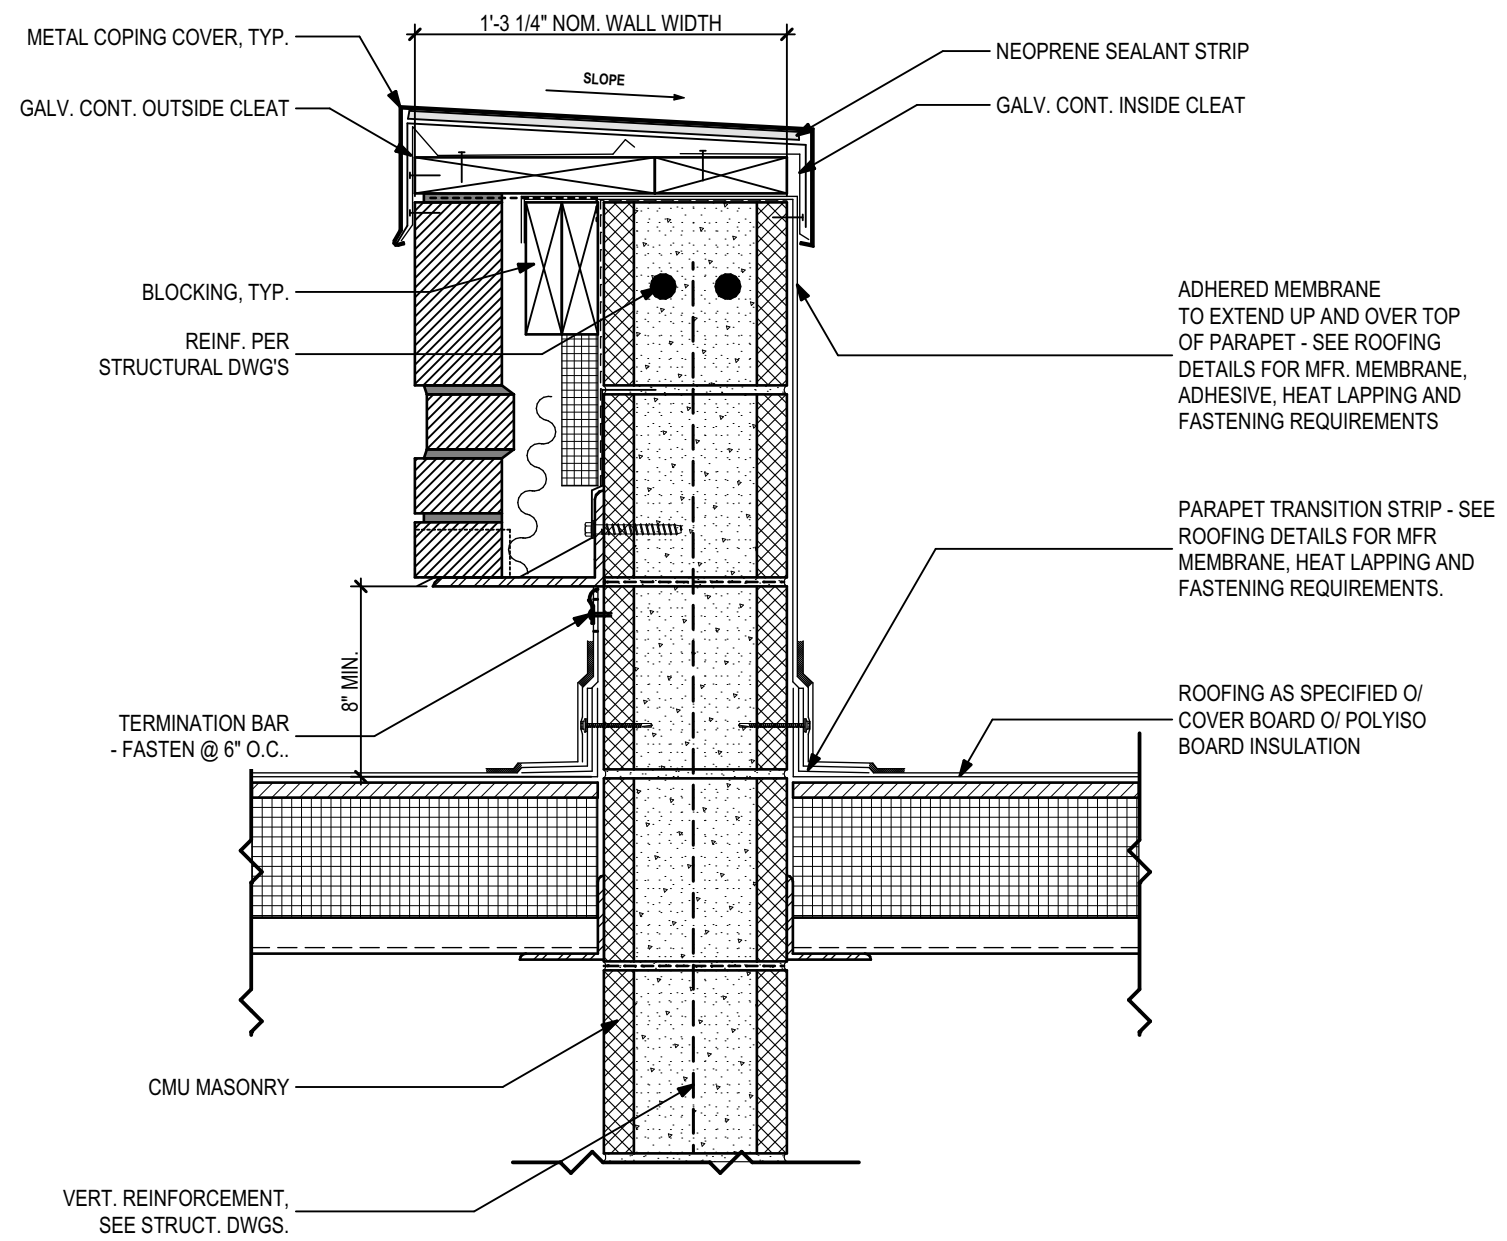


6 Parapet Section @ Electrical Room
1 1/2"= 1'-0"

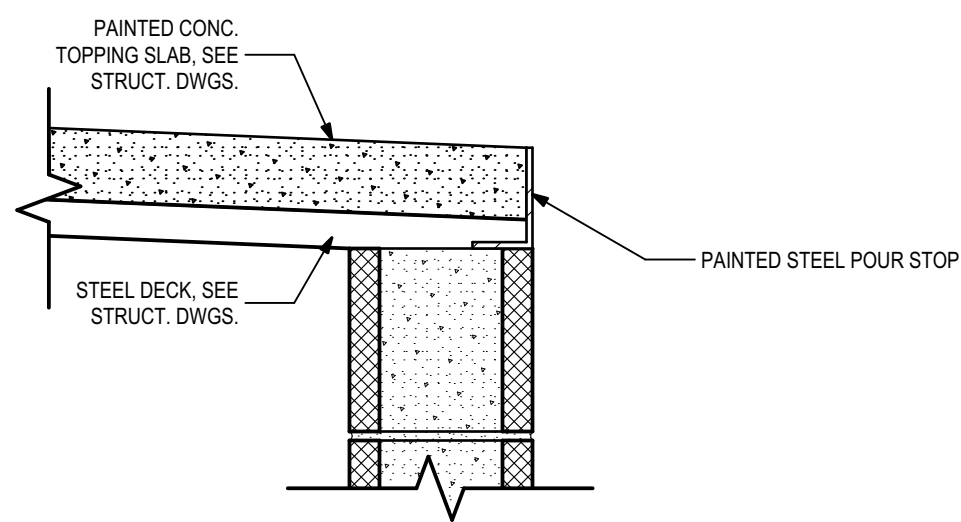


3 Vestibule Roof Section Detail
1 1/2"= 1'-0"

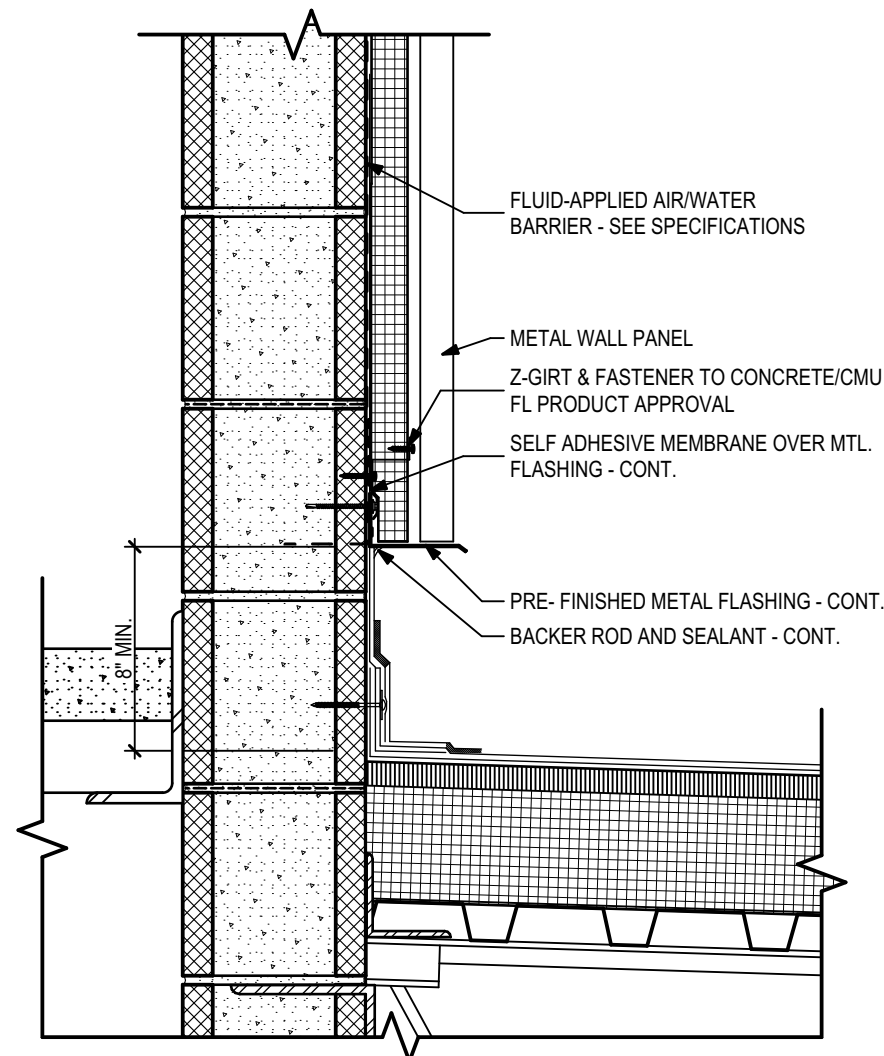


5 Low Roof Section Detail @ Wall 8" CMU Wall
1 1/2"= 1'-0"

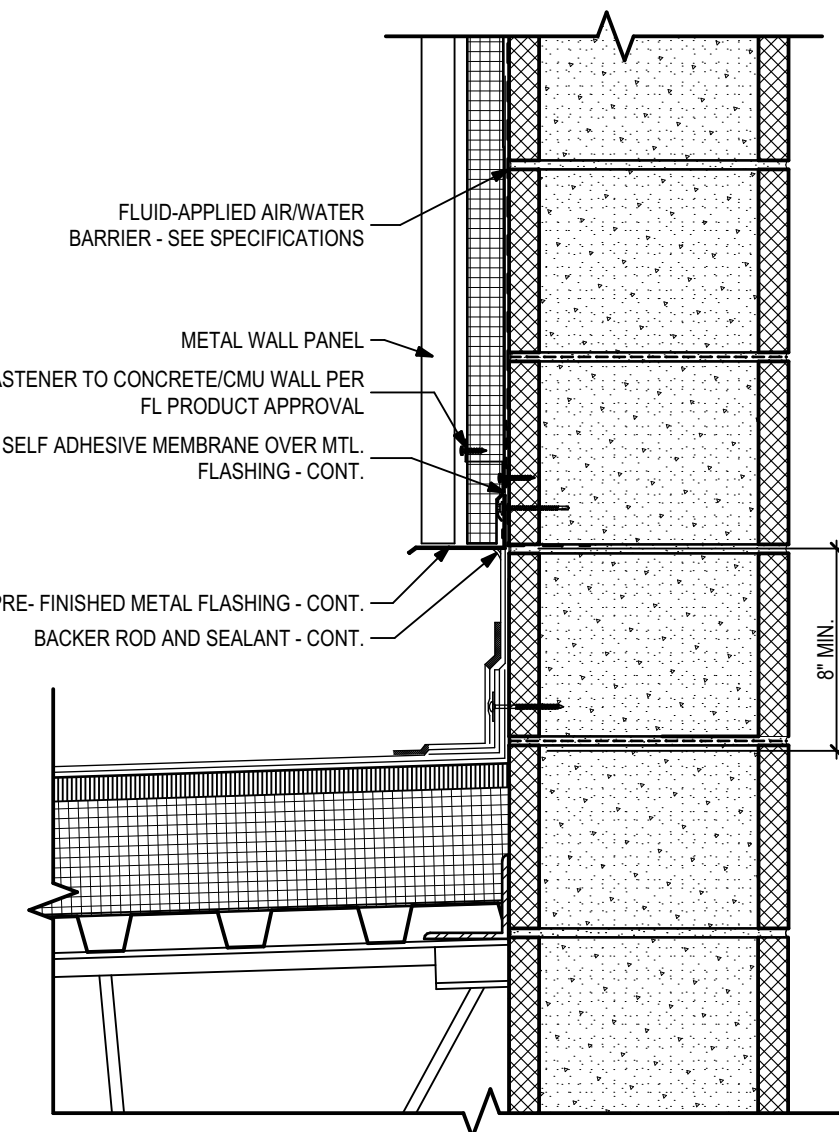

4 Low Roof Section Detail - Wall 12" CMU Wall
1 1/2"= 1'-0"

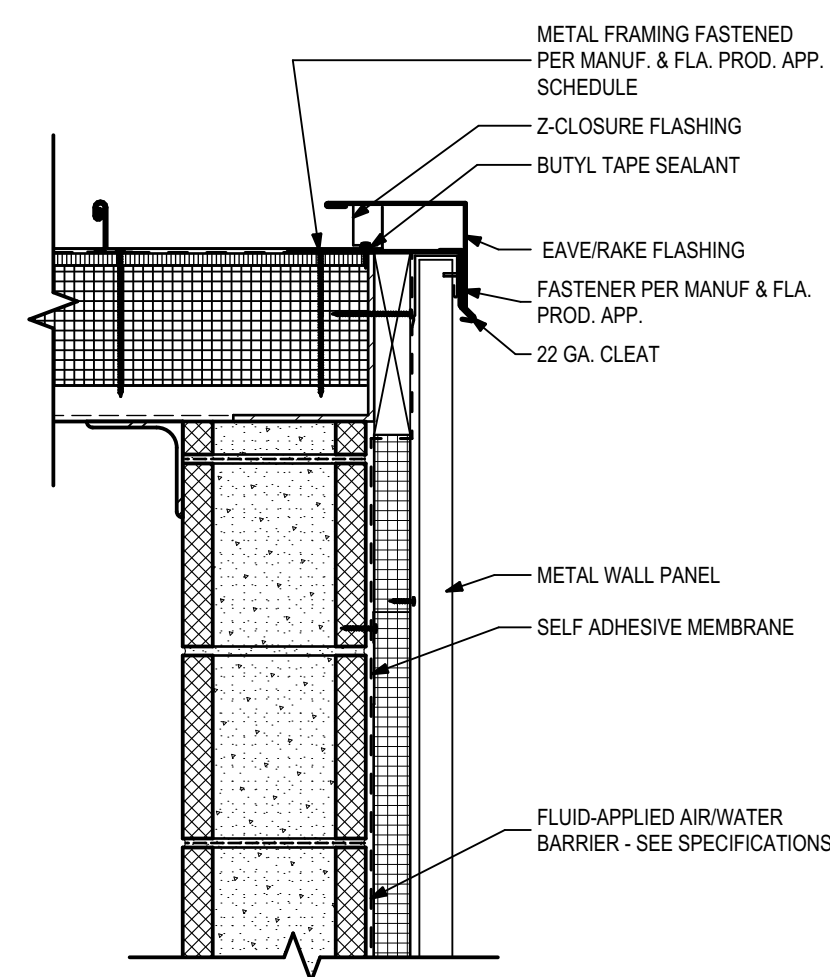

2 High Roof Section Detail - Rake 8" CMU Wall
1 1/2"= 1'-0"

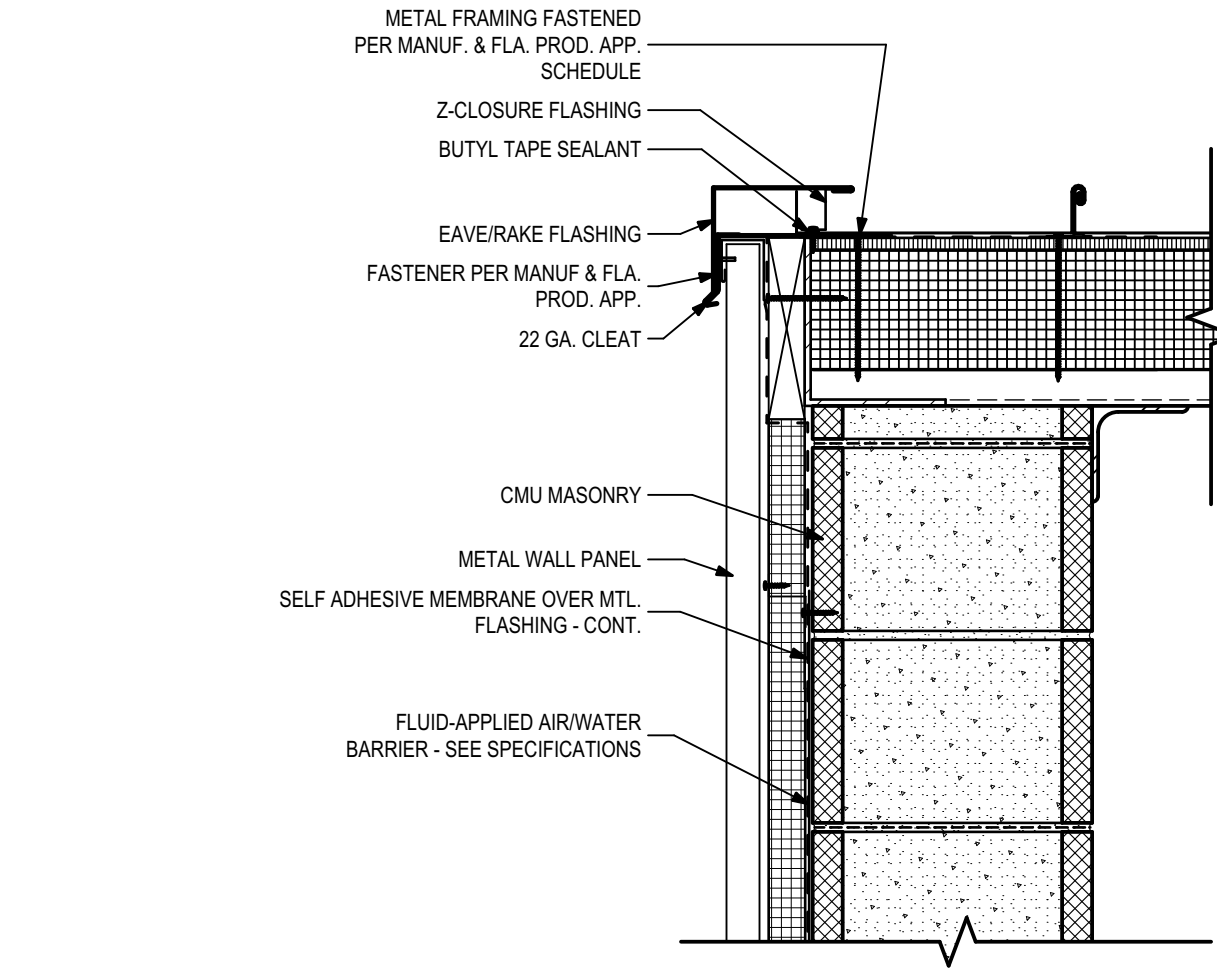

1 High Roof Section Detail - Rake 12" CMU Wall
1 1/2"= 1'-0"

PHASE:	DRAWN:	REVIEWED:	DATE:	ID:	REVISION:	DRAWN:	REVIEWED:	DATE:
CONCEPT SCHEM. DESIGN	BG/RS	C. WHITLOCK	10/8/2024					
DESIGN DEVELOPMENT	BG/RS/MS	C. WHITLOCK	12/20/2024					
EARLY DEMOLITION PACKAGE	BG/RS/MS	C. WHITLOCK	12/20/2024					
80% CONSTRUCTION DOCS	BG/RS/MS	R. LEWIS	03/21/2025					
PERMIT DOCS	BG/RS/MS	R. LEWIS	05/09/2025					
100% CONSTRUCTION DOCS	BG/RS/MS	R. LEWIS	05/09/2025					

LEON COUNTY SCHOOLS

Client: Leon County Schools
3420 W. Tharpe St., Suite 100
Tallahassee, FL 32303

Consultant: 23483
Project #: 100% CDs
Phase:

Job Title: Griffin Middle School - Phase 2
800 Alabama St. Tallahassee, FL 32304

Seal:

ALW


Architects Lewis + Whitlock
206 West Virginia St.
Tallahassee, Florida 32301
850.942.1718
www.think3d.net

Description:
**Roof Section
Details**

Sheet No.:
A3.4


3 Roof Detail- Walkway Pads

1 1/2"= 1'-0"

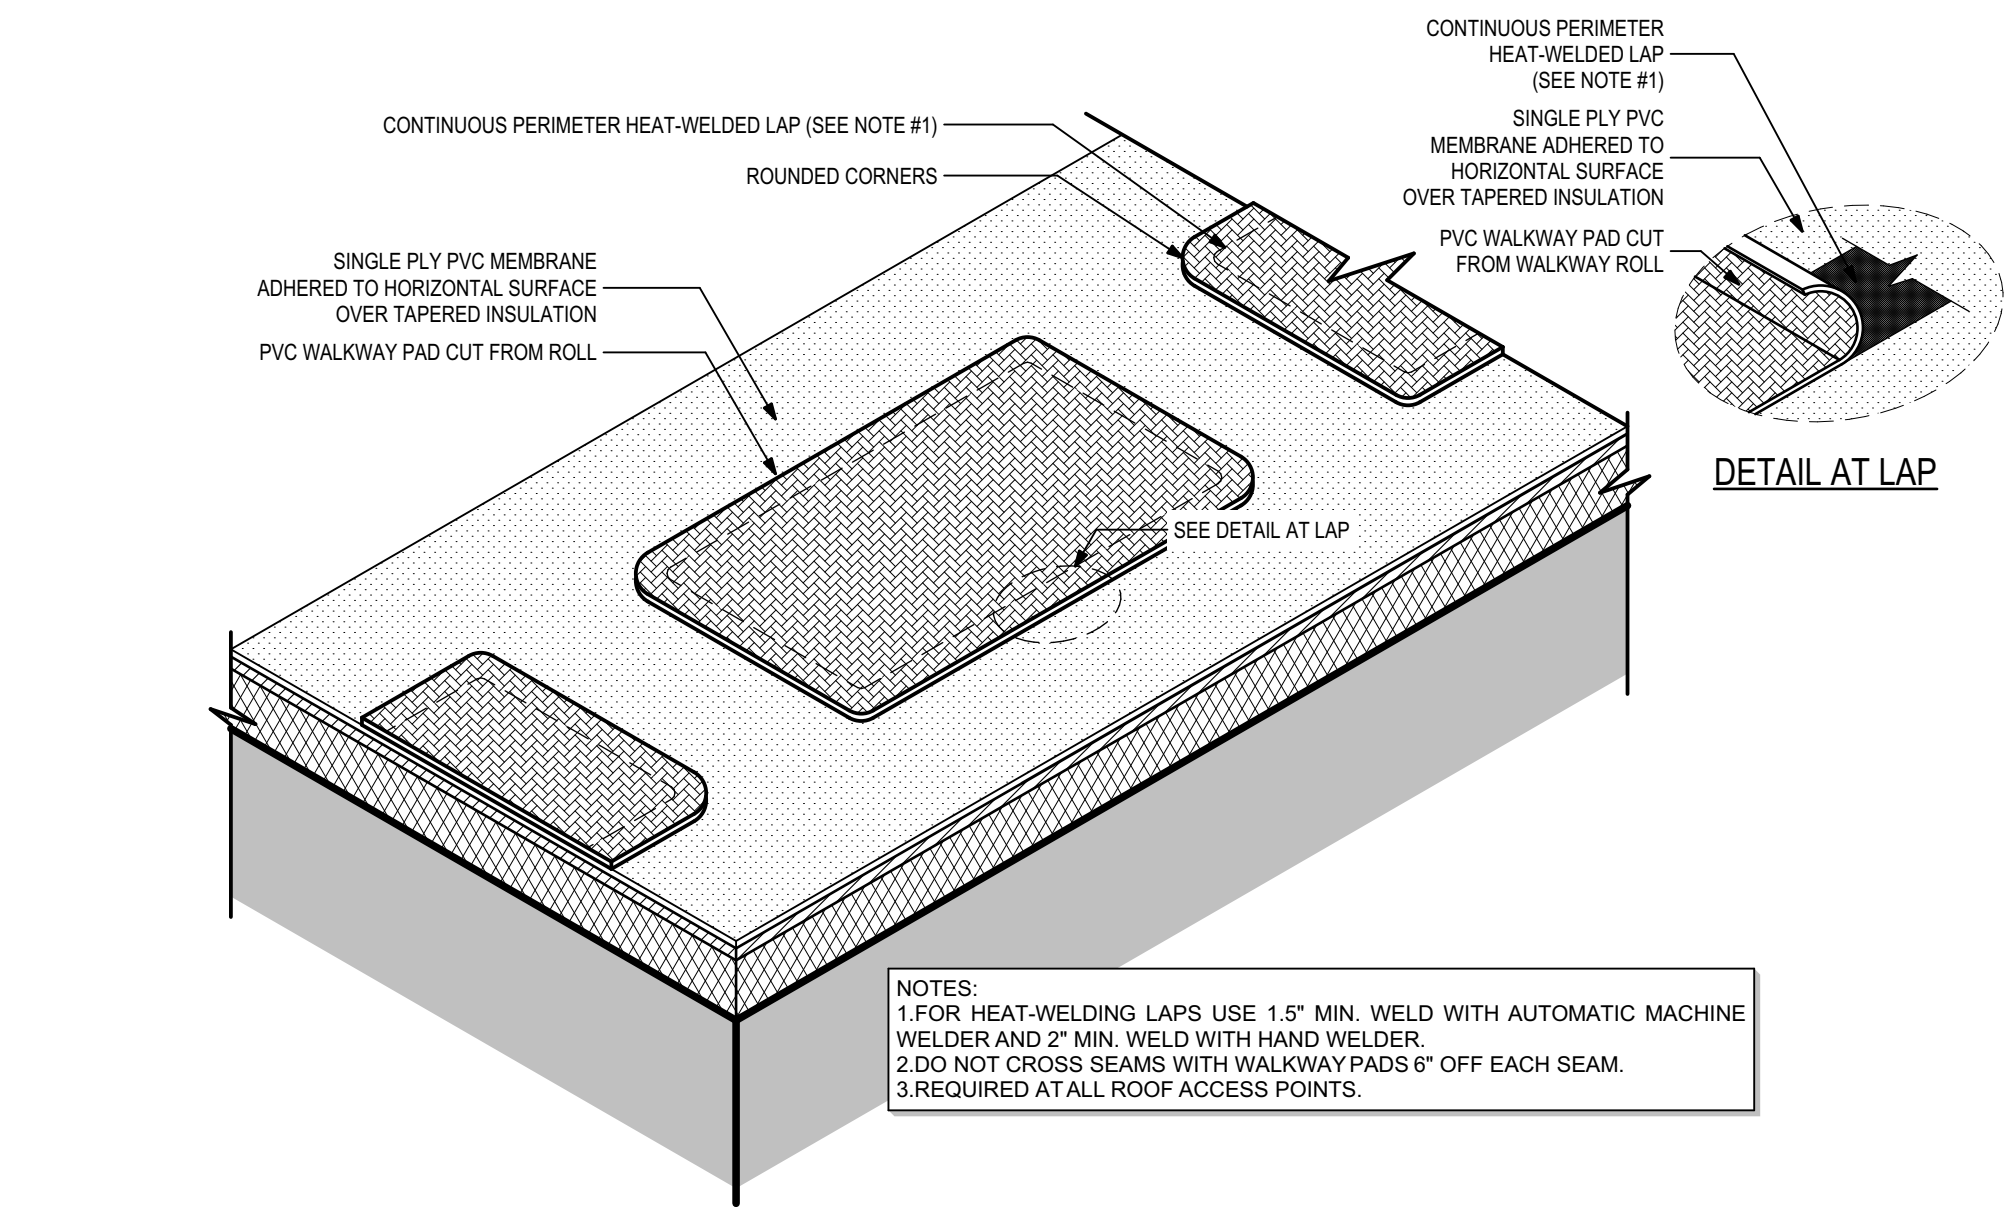


6 Roof Detail-Lap Seam

1 1/2"= 1'-0"

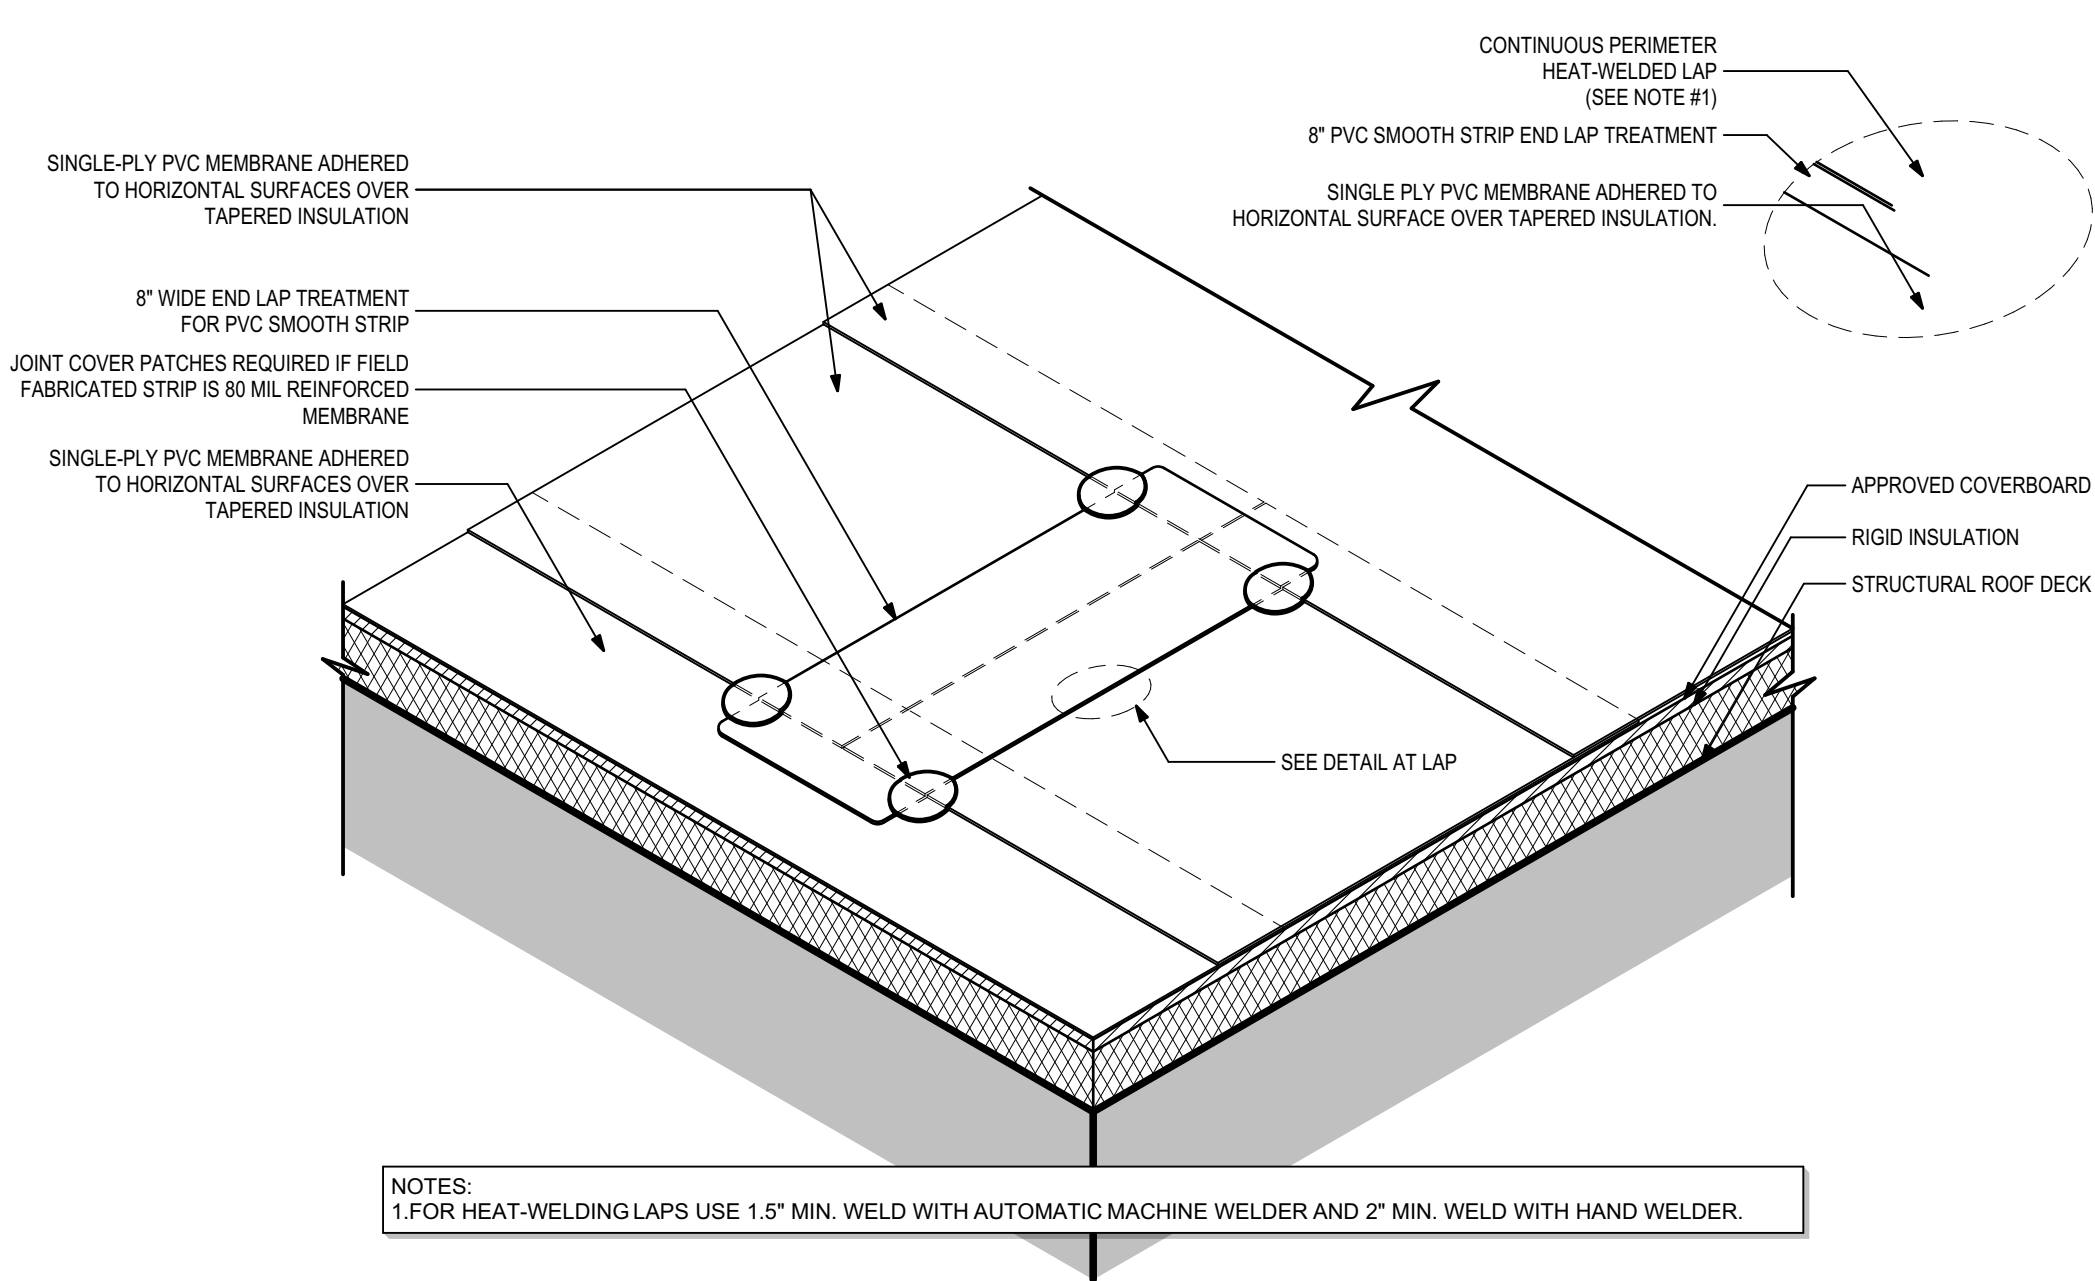


9 Roof Detail- Scupper

3\"/>

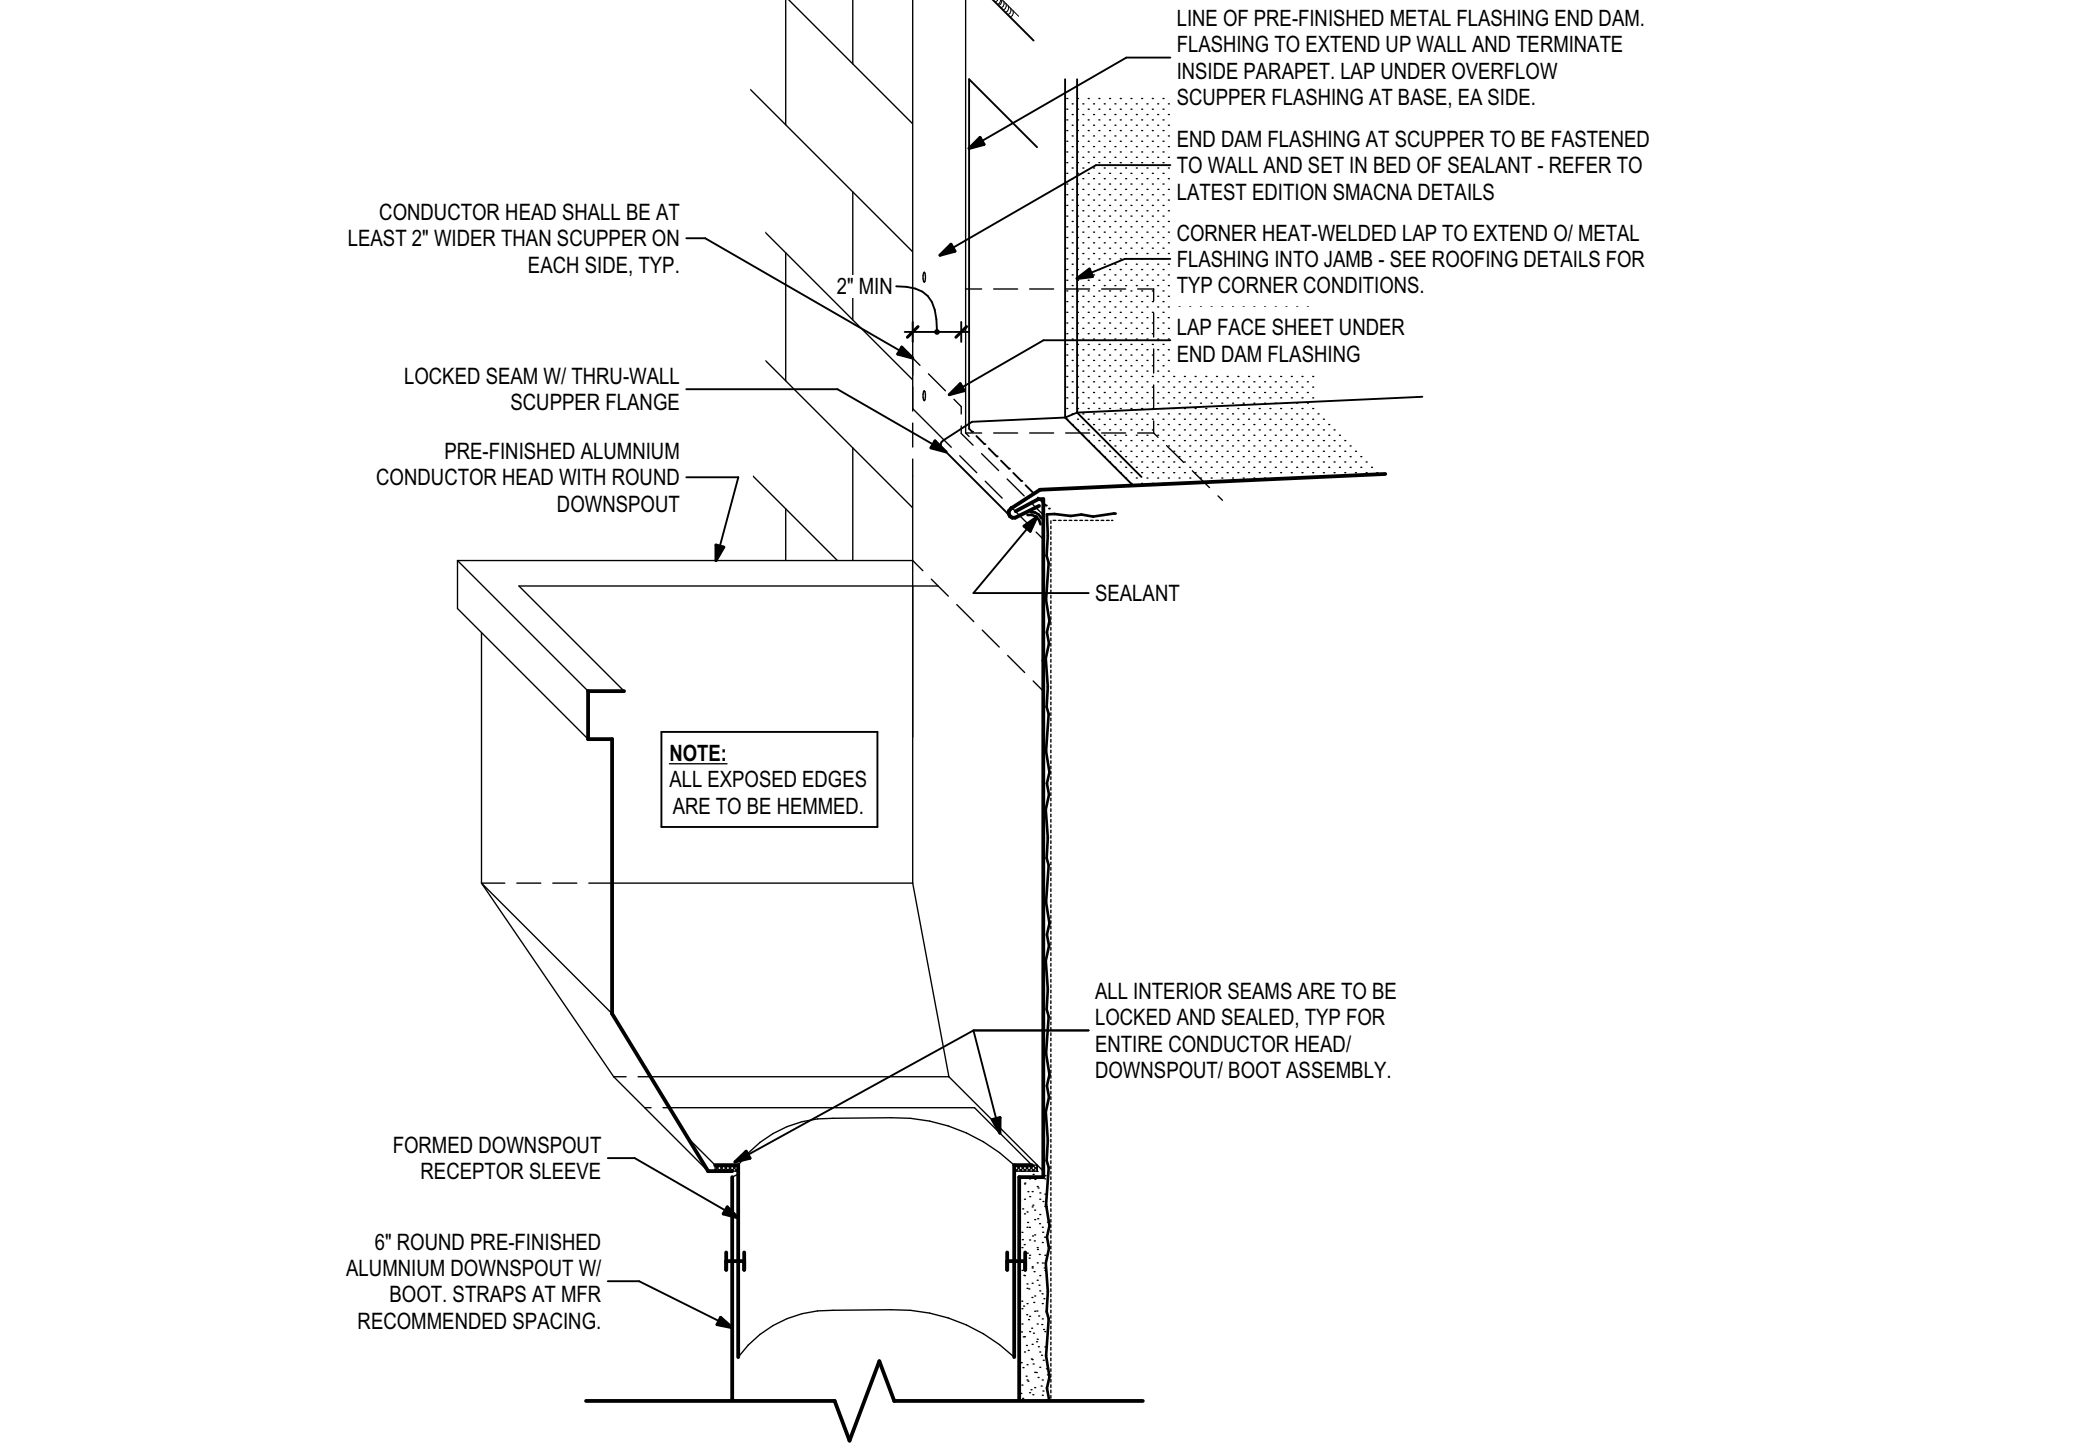


2 PVC-KEE Roof Detail - Typical Drain

3\"/>

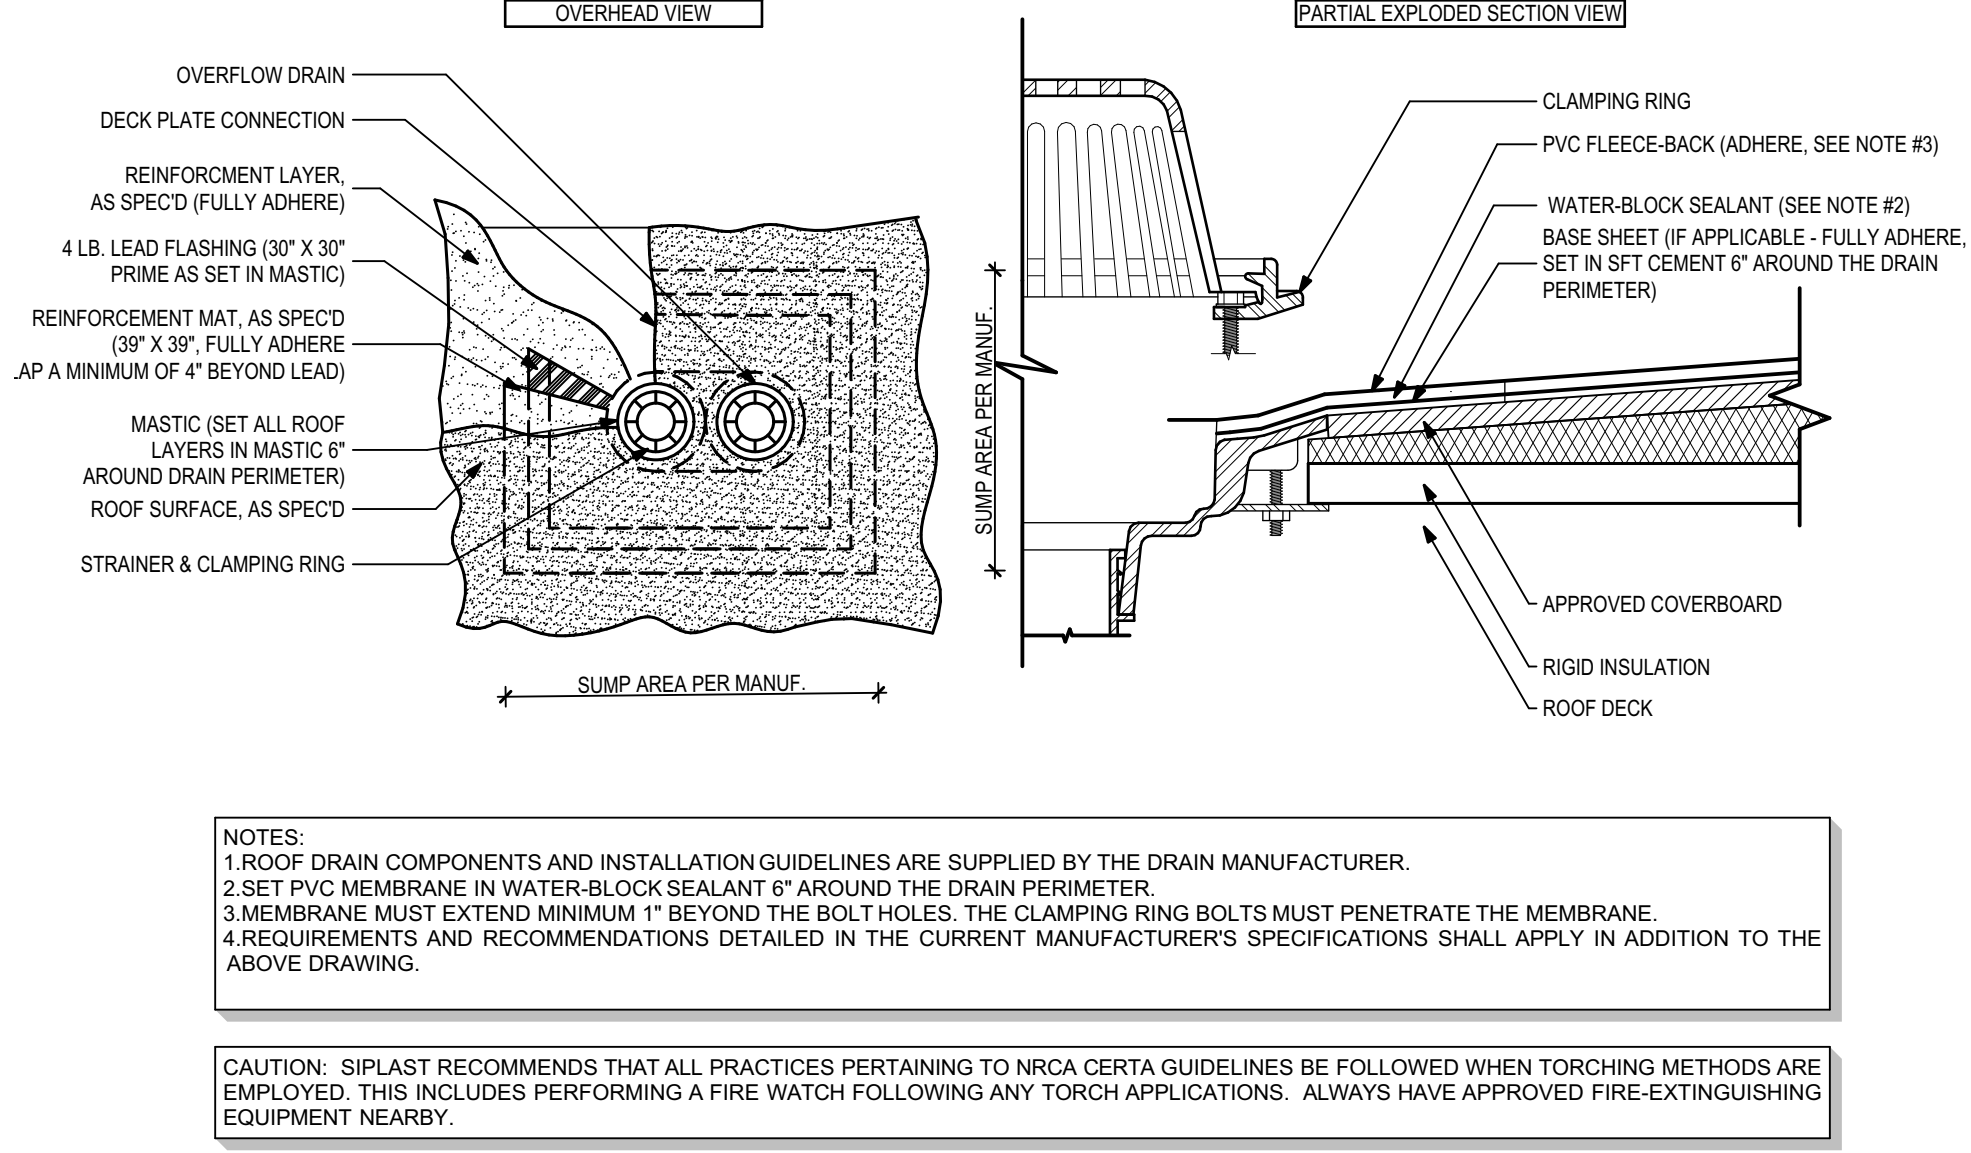


5 PVC-KEE Roof Detail - Typical VTR

3\"/>

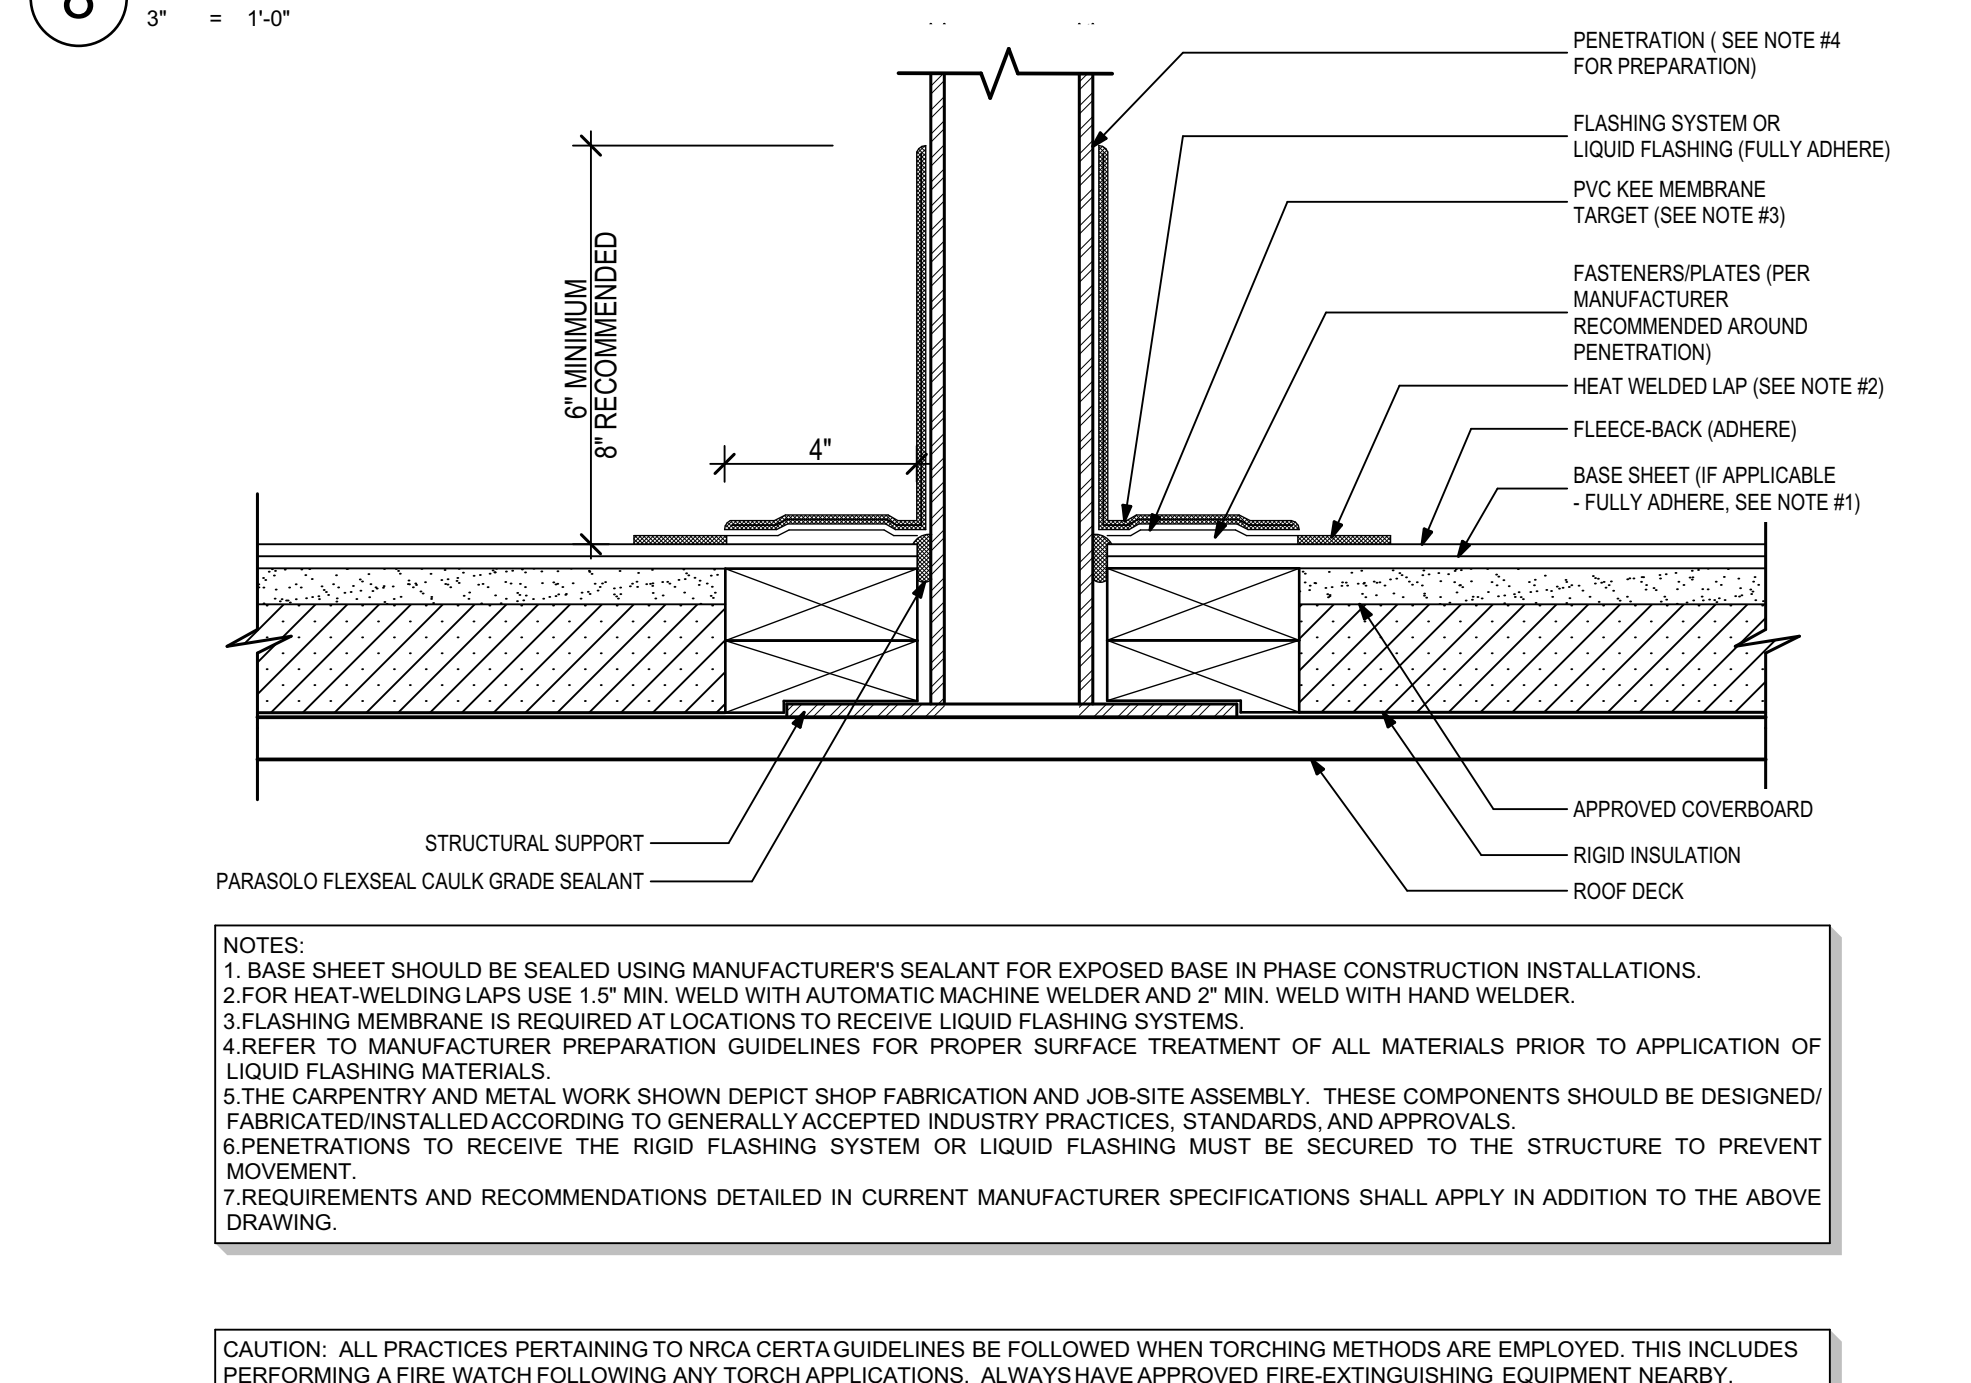


8 PVC-KEE Roof Detail - Typical Vent

3\"/>

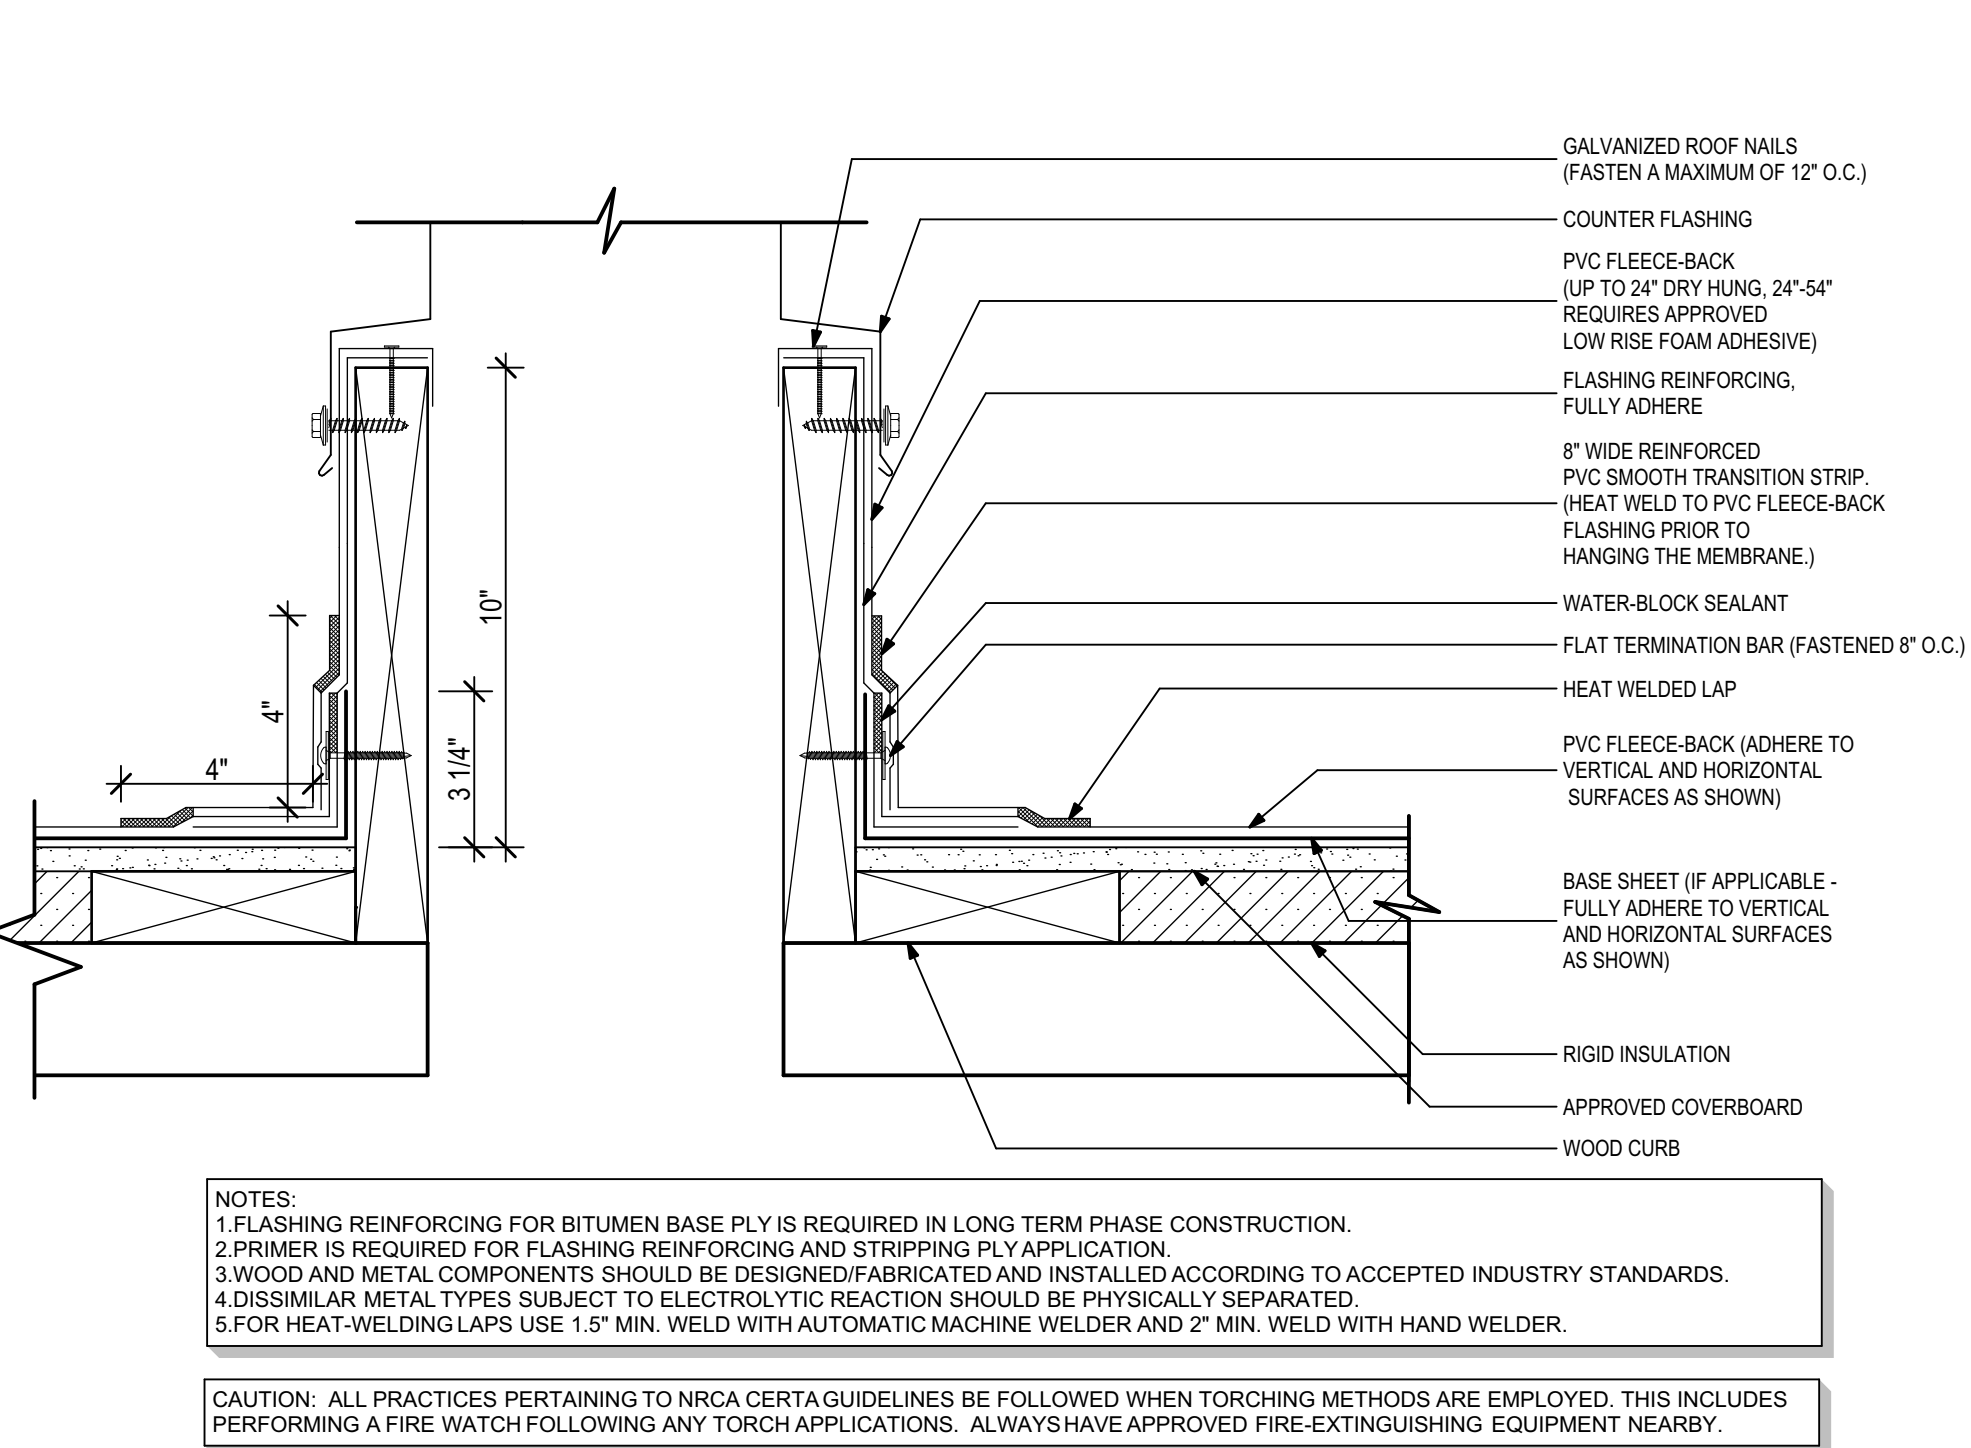


1 Typical Parapet Section at Scupper

1 1/2"= 1'-0"

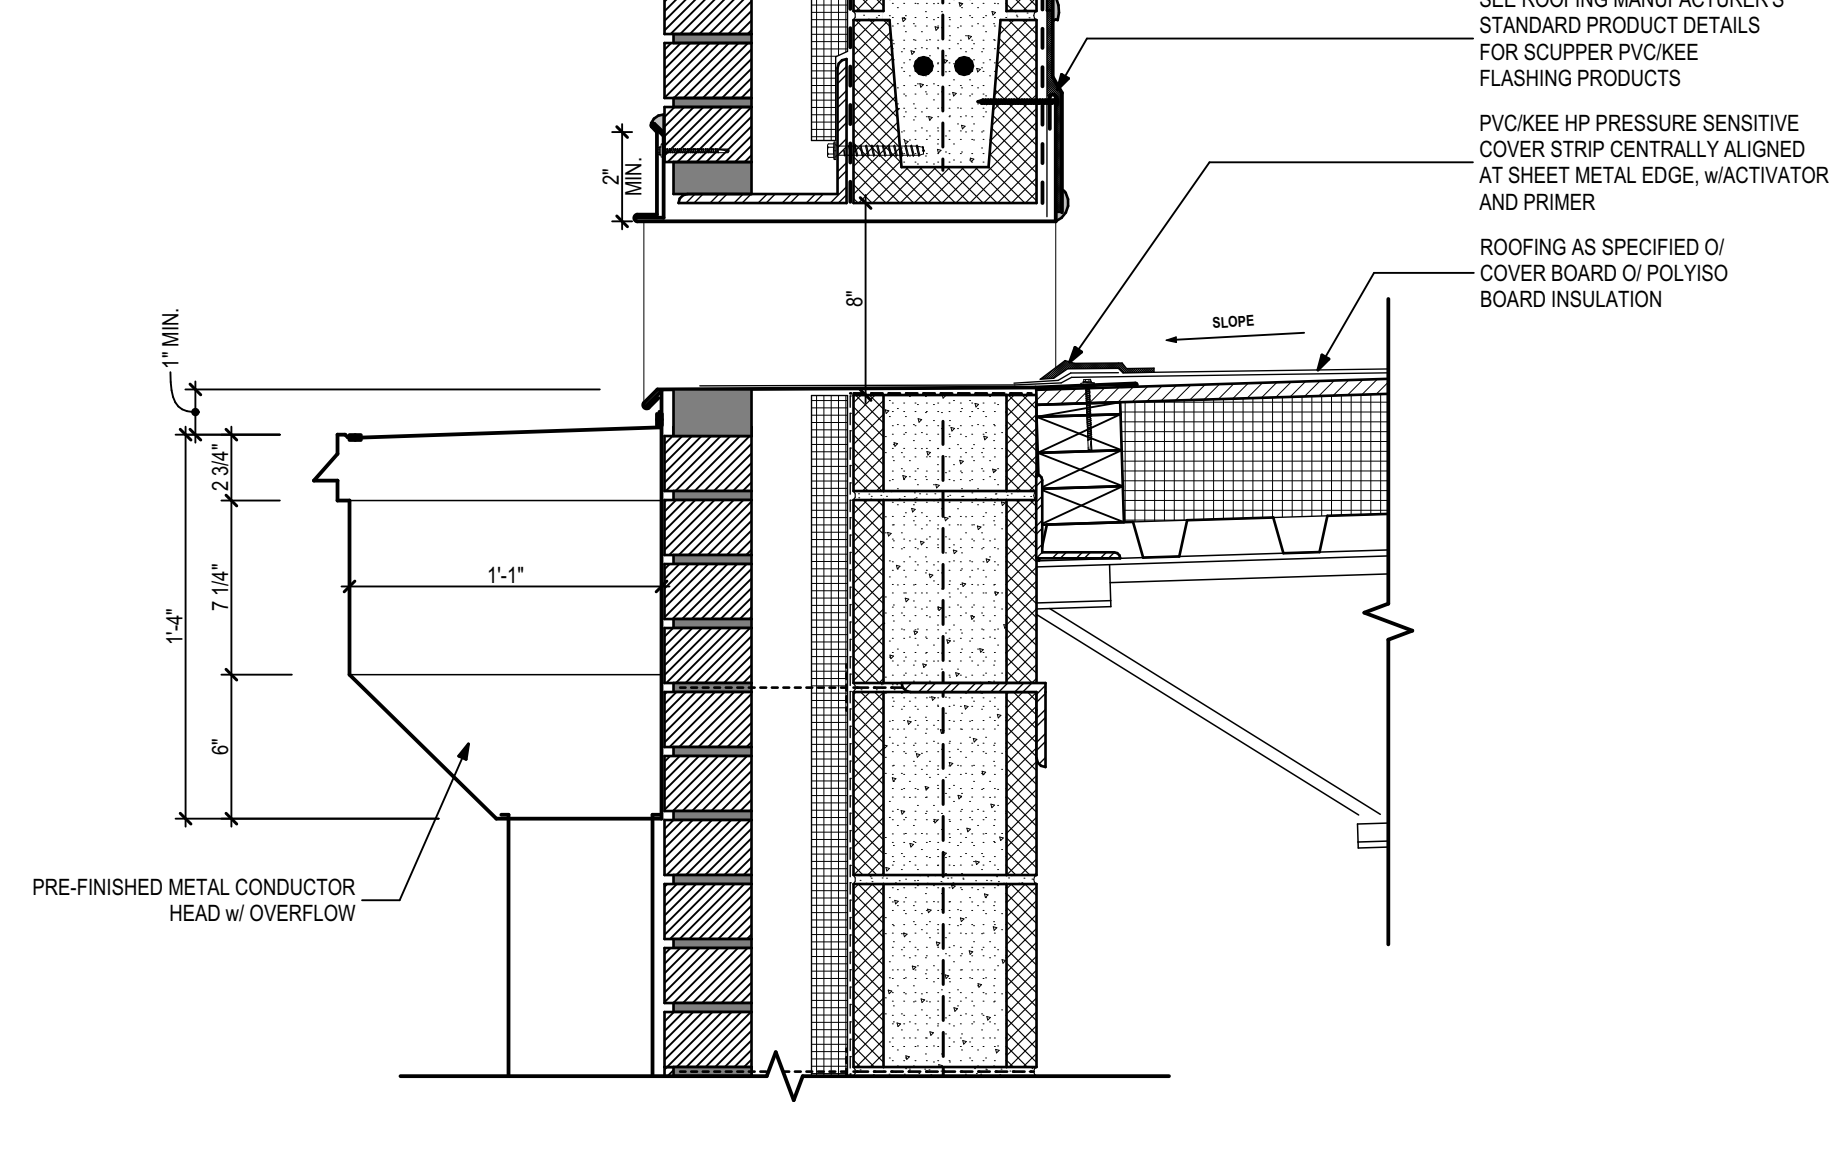


4 Typical Parapet Section

1 1/2"= 1'-0"

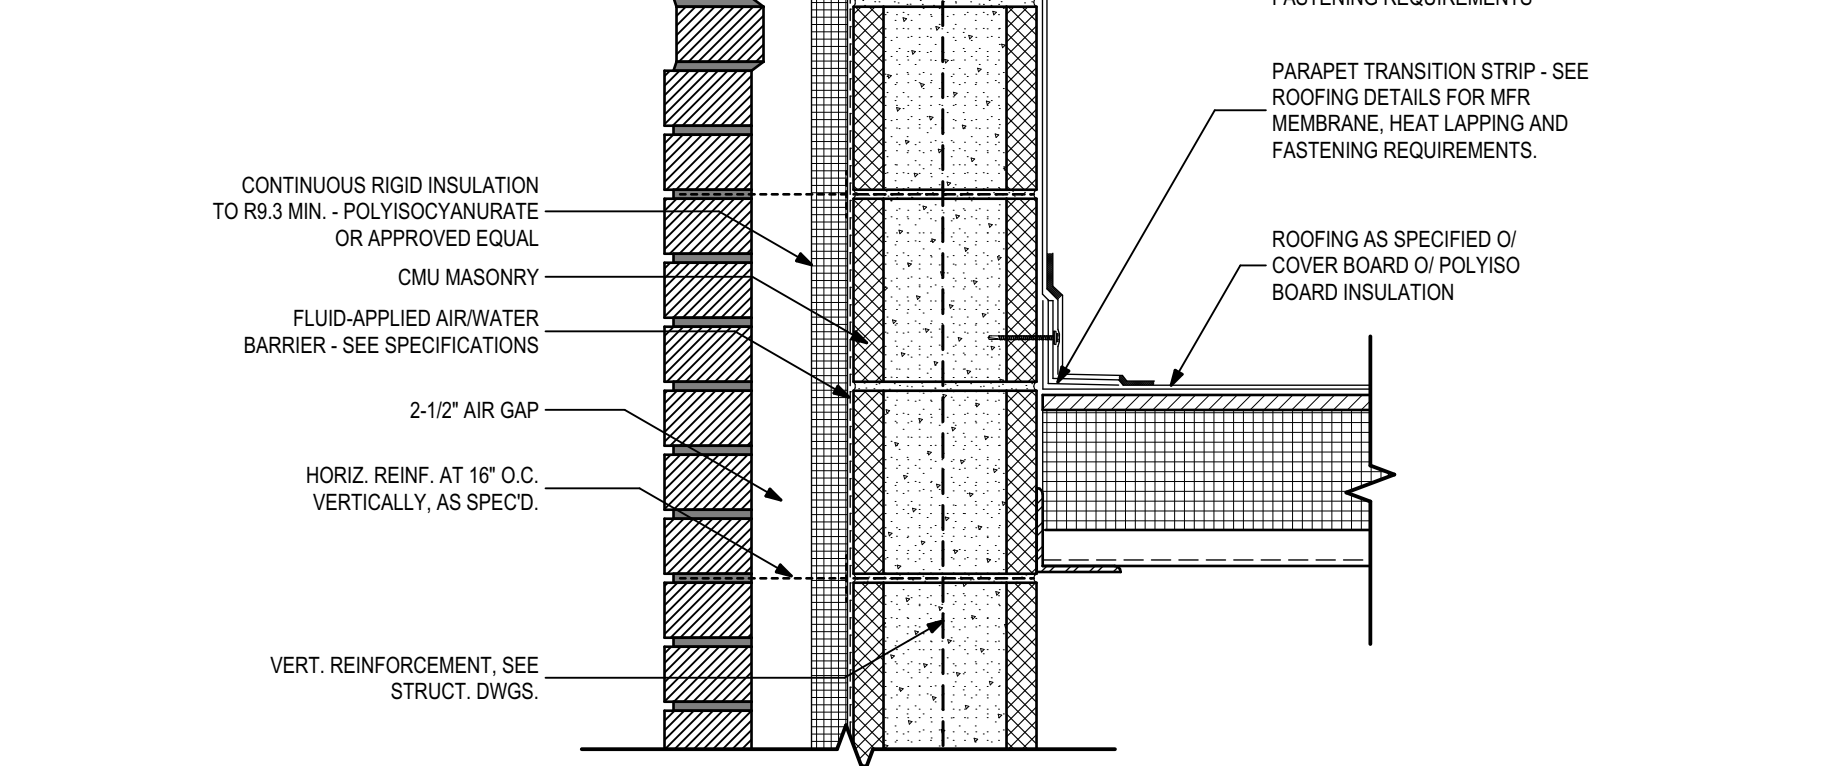


7 Typ. Awning Parapet Cap Detail

3\"/>

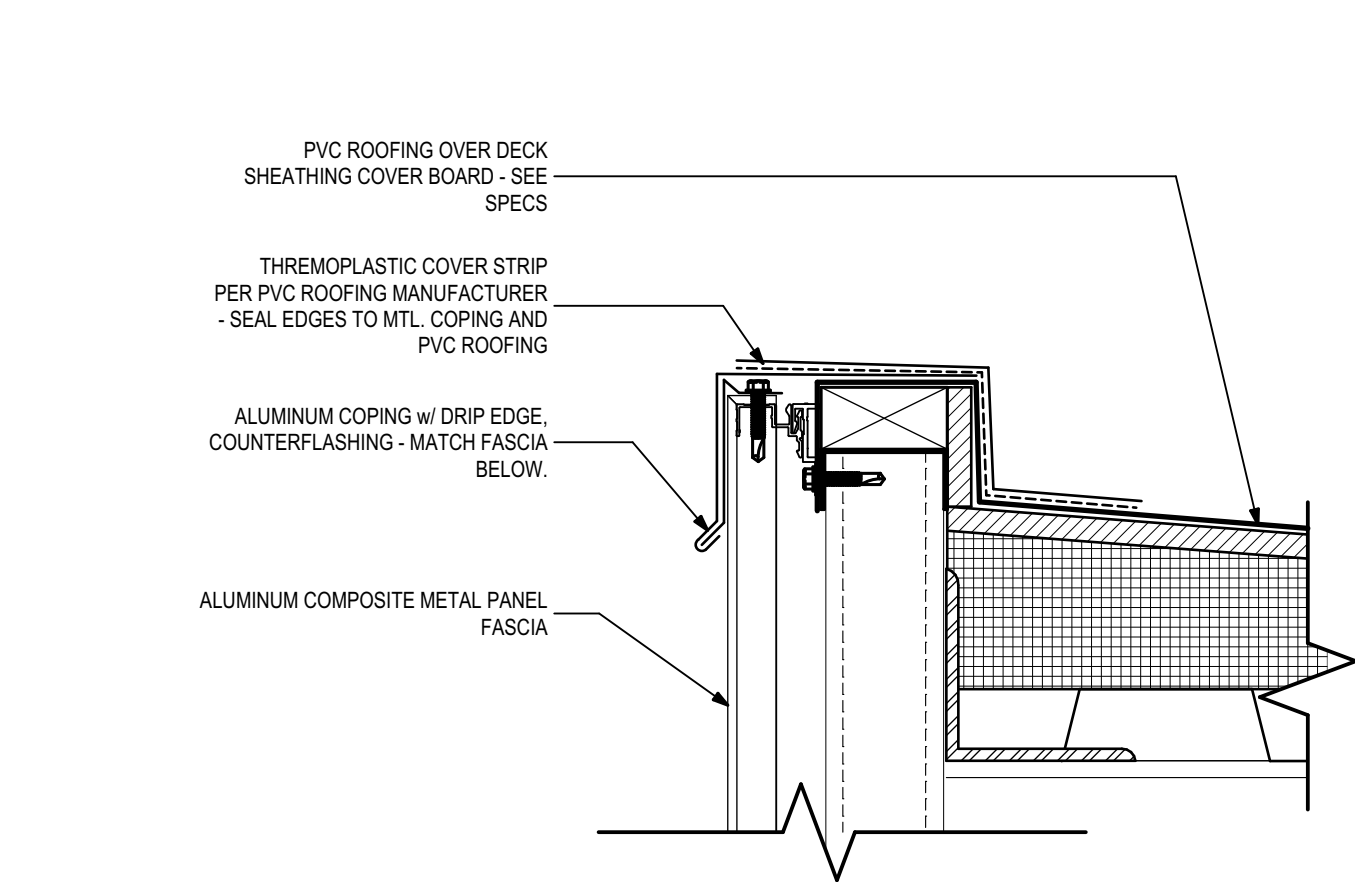


Client:	Leon County Schools	Job Title:	Griffin Middle School - Phase 2
Consultant:	23483	Project #:	23483
Seal:		Phase:	100% CDs
Architects Lewis + Whitlock 206 West Virginia St. Tallahassee, Florida 32301 850.942.1718 www.think3d.net		Roof Section Details	
Sheet No.:		A3.5	


5 Low Roof Section Detail @ Flam. Stor. Building
1 1/2" = 1'-0"

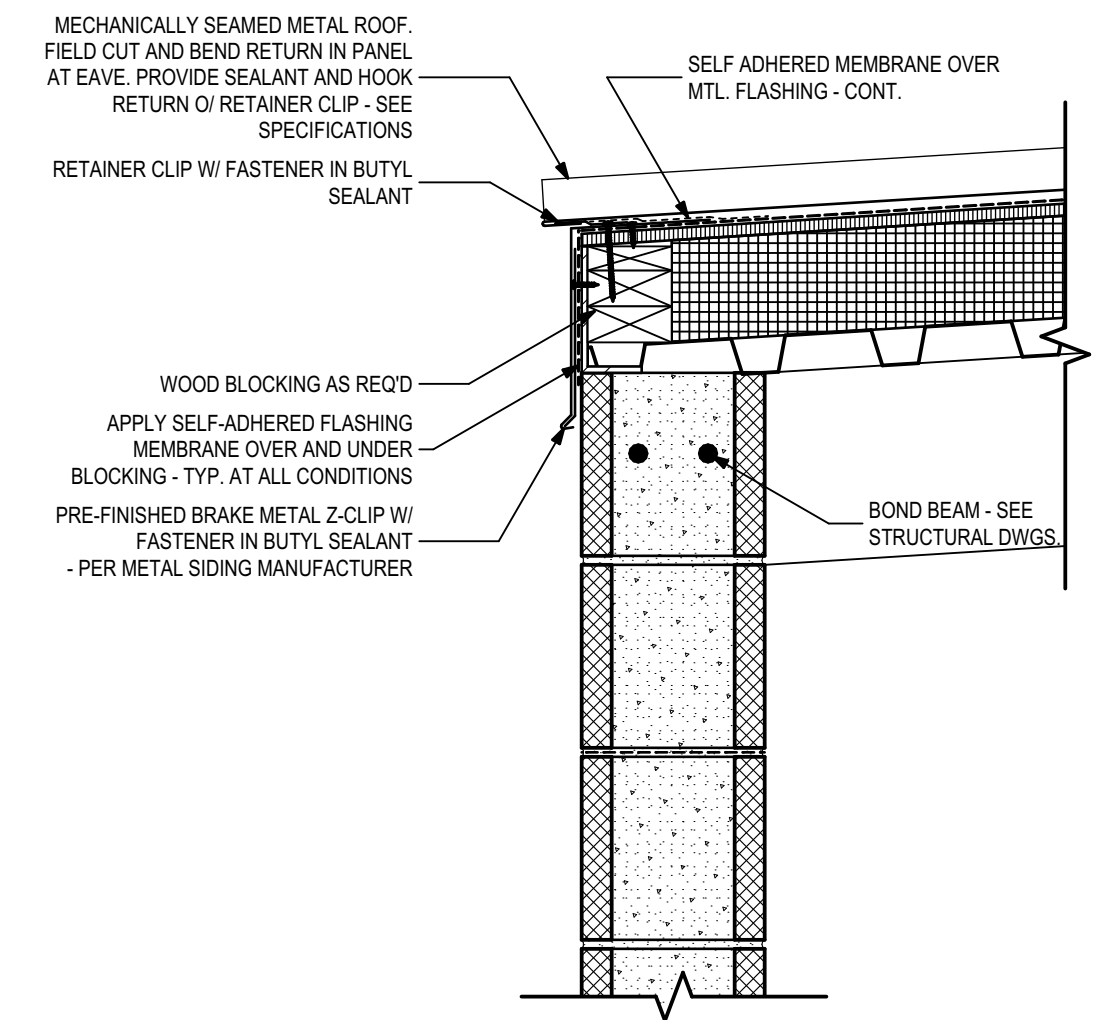


6 High Roof Section Detail @ Flam. Stor. Building
1 1/2" = 1'-0"

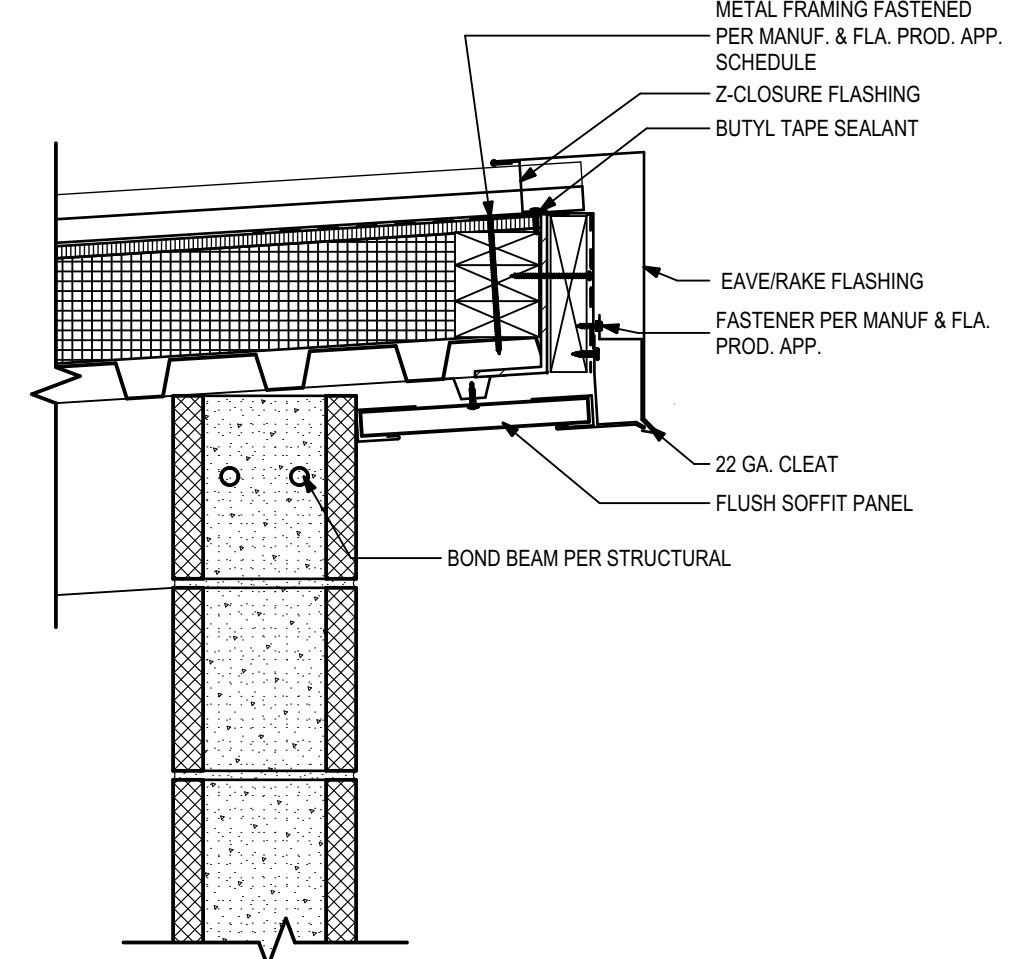


4 Roof Transition Section Detail
1 1/2" = 1'-0"

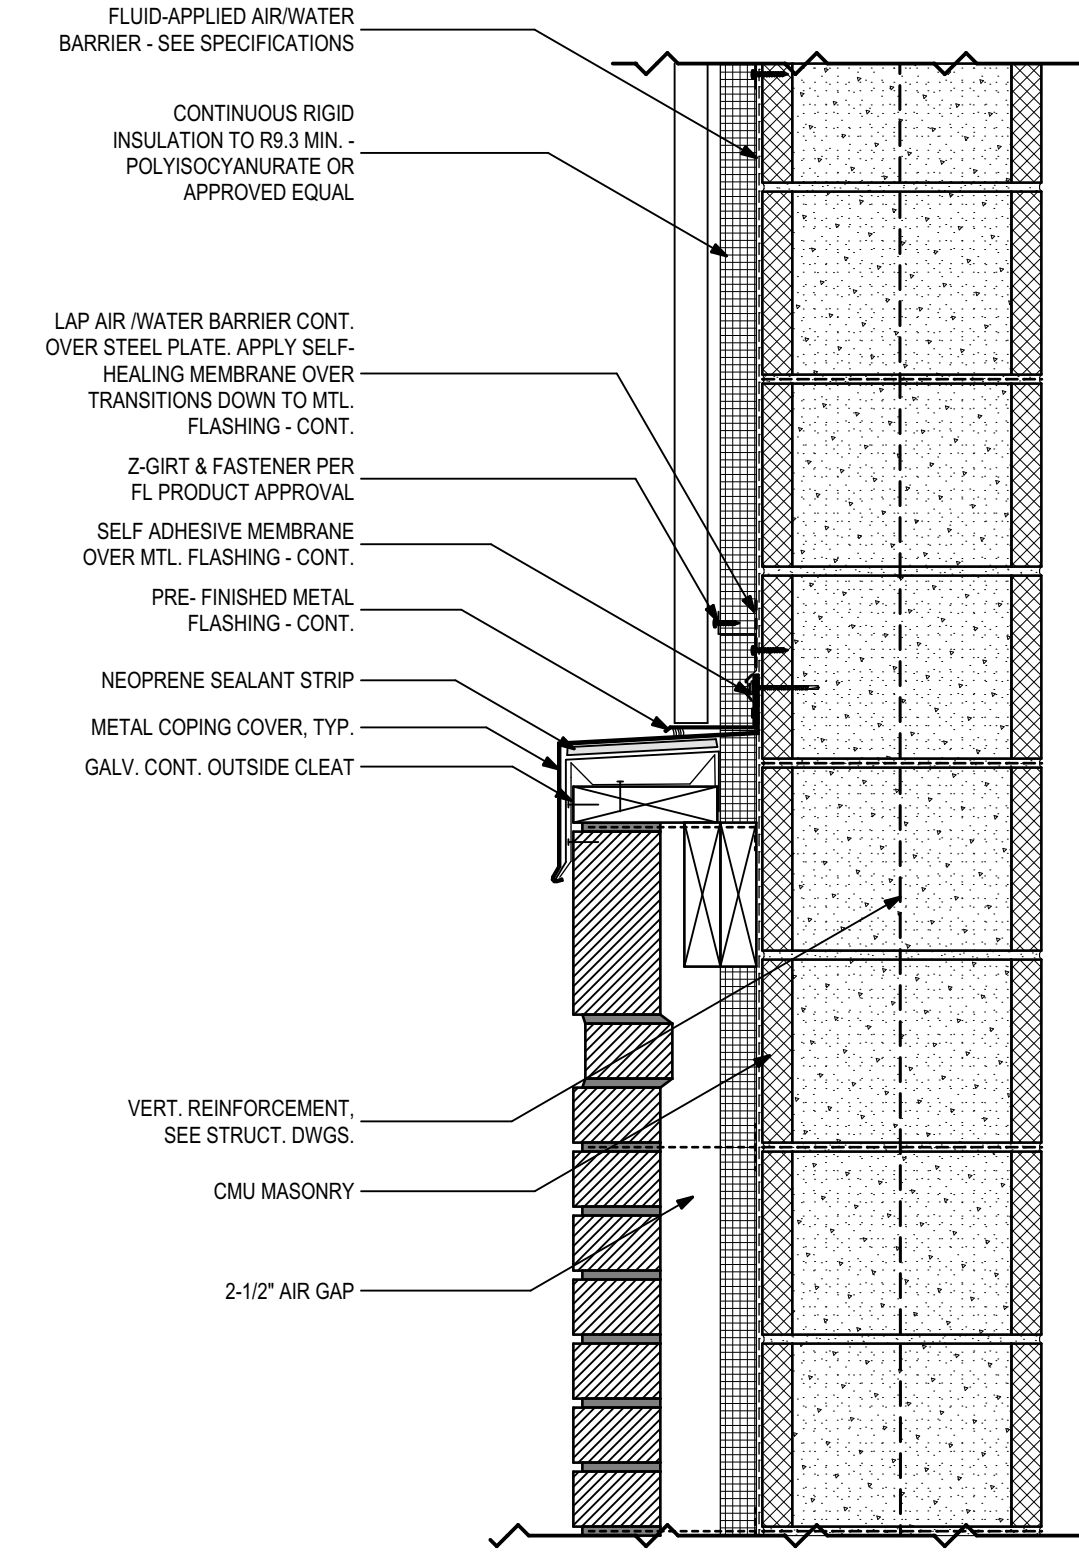


3 Roof Access Ladder Section Detail
3/4" = 1'-0"

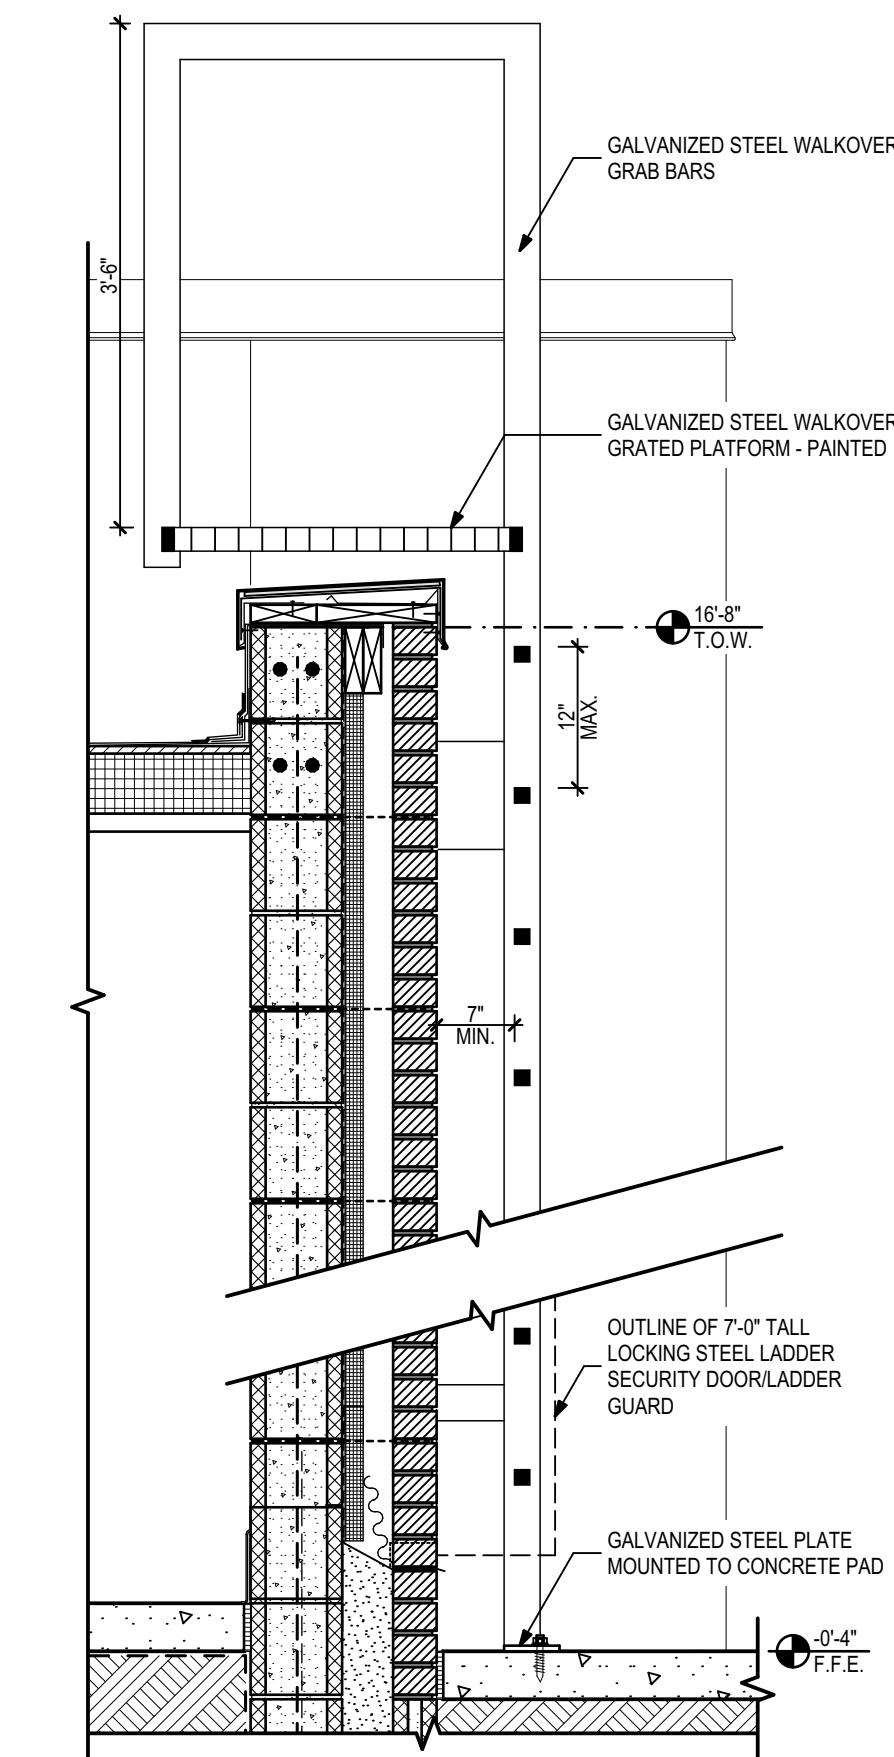

2 Roof Anchor Penetration Detail
3" = 1'-0"

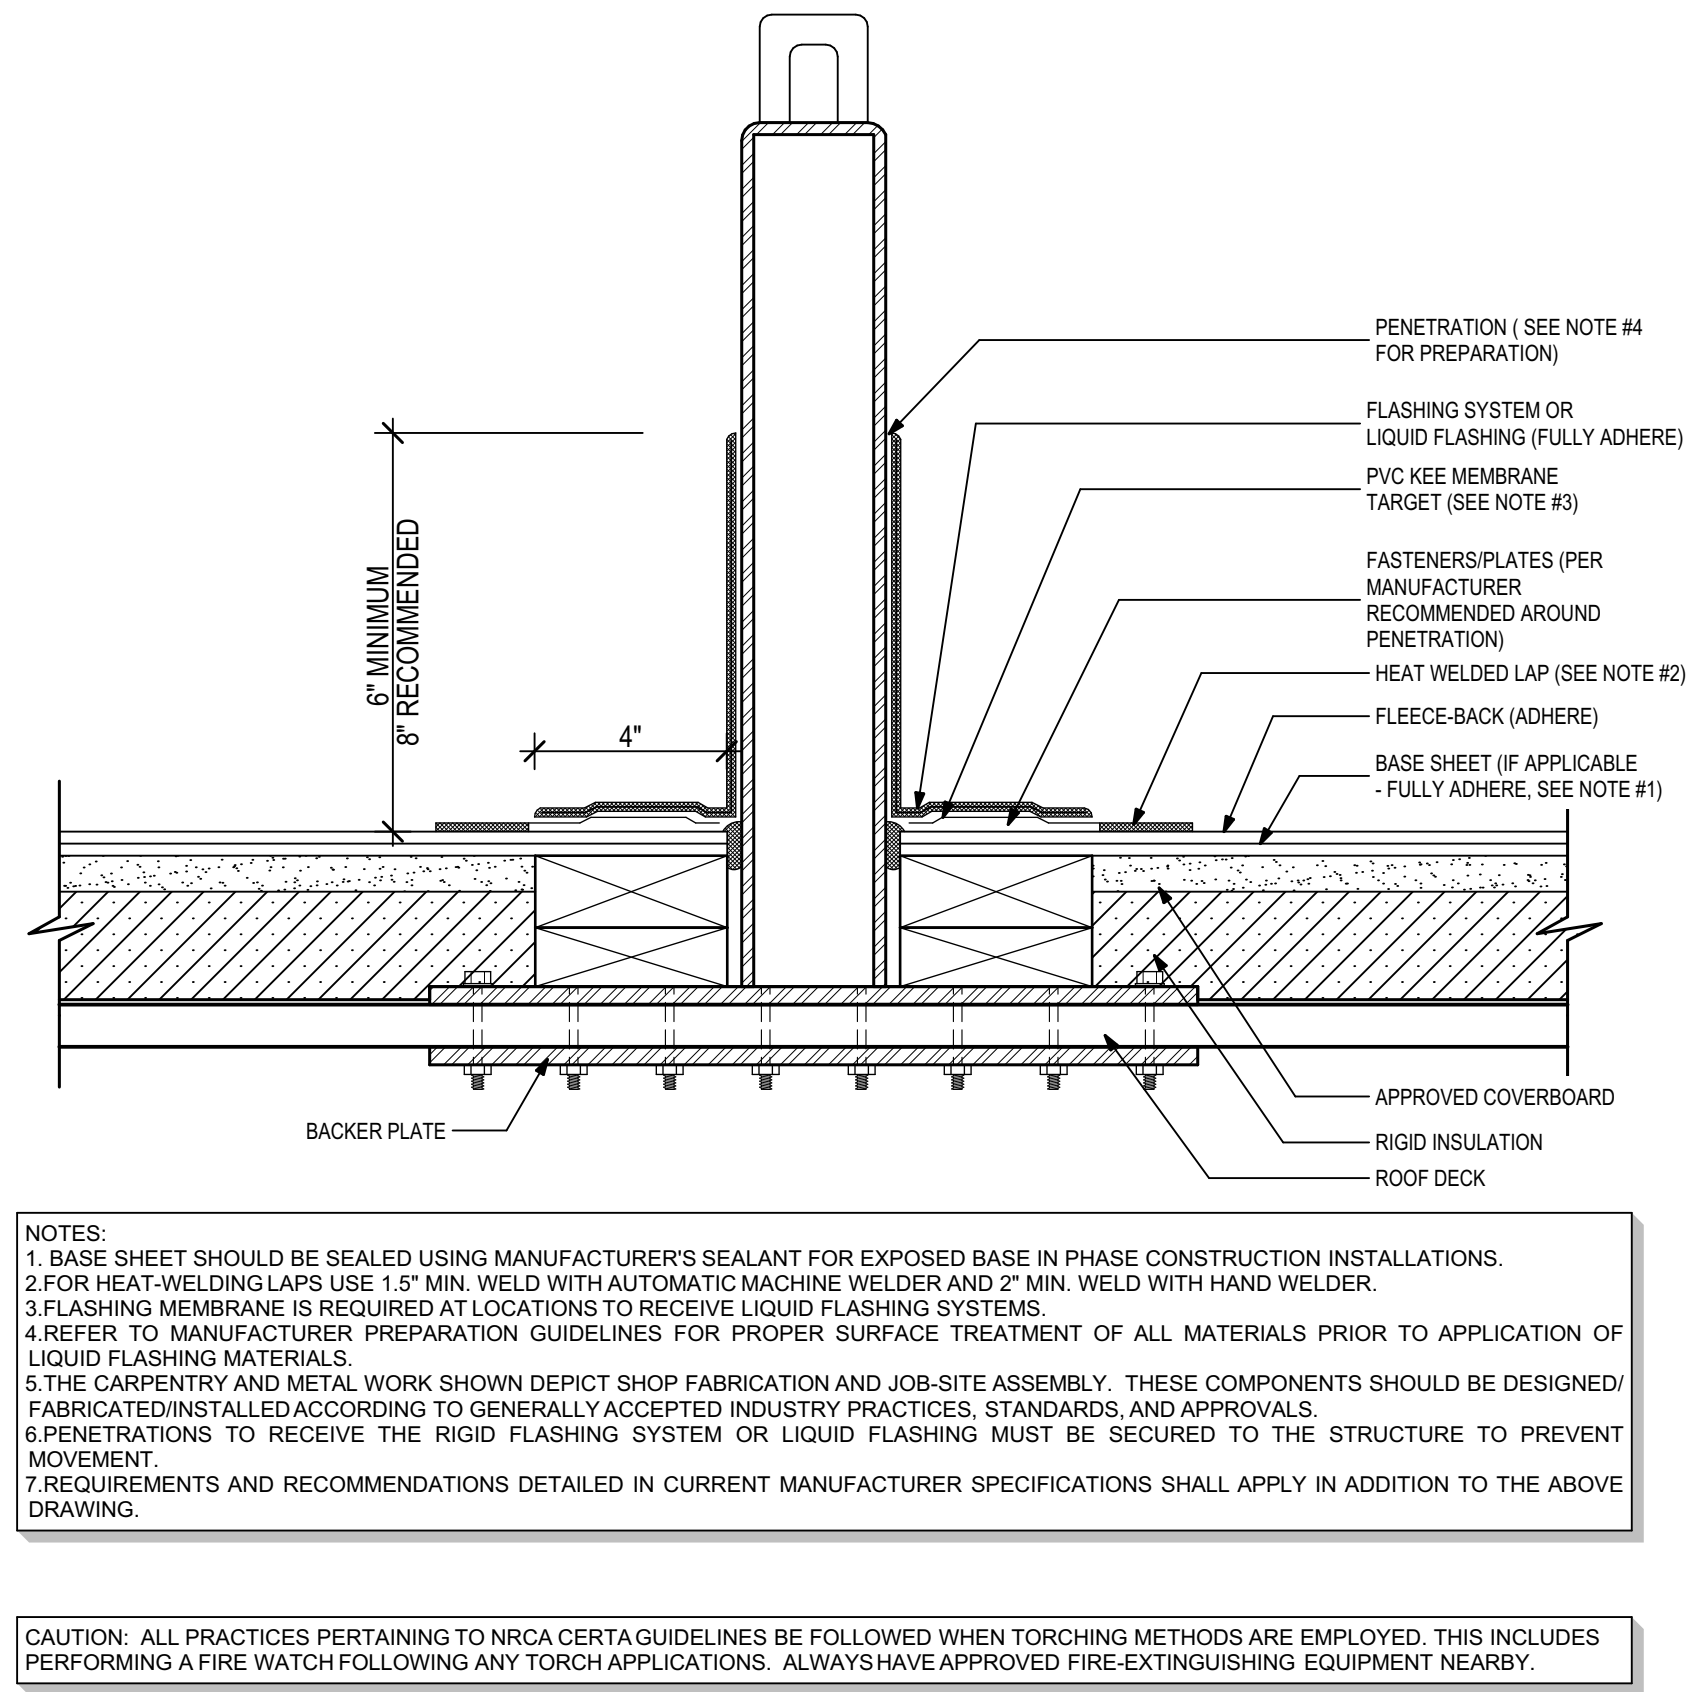


1 Typical Roof Detail @ Spillover Edge
1 1/2" = 1'-0"

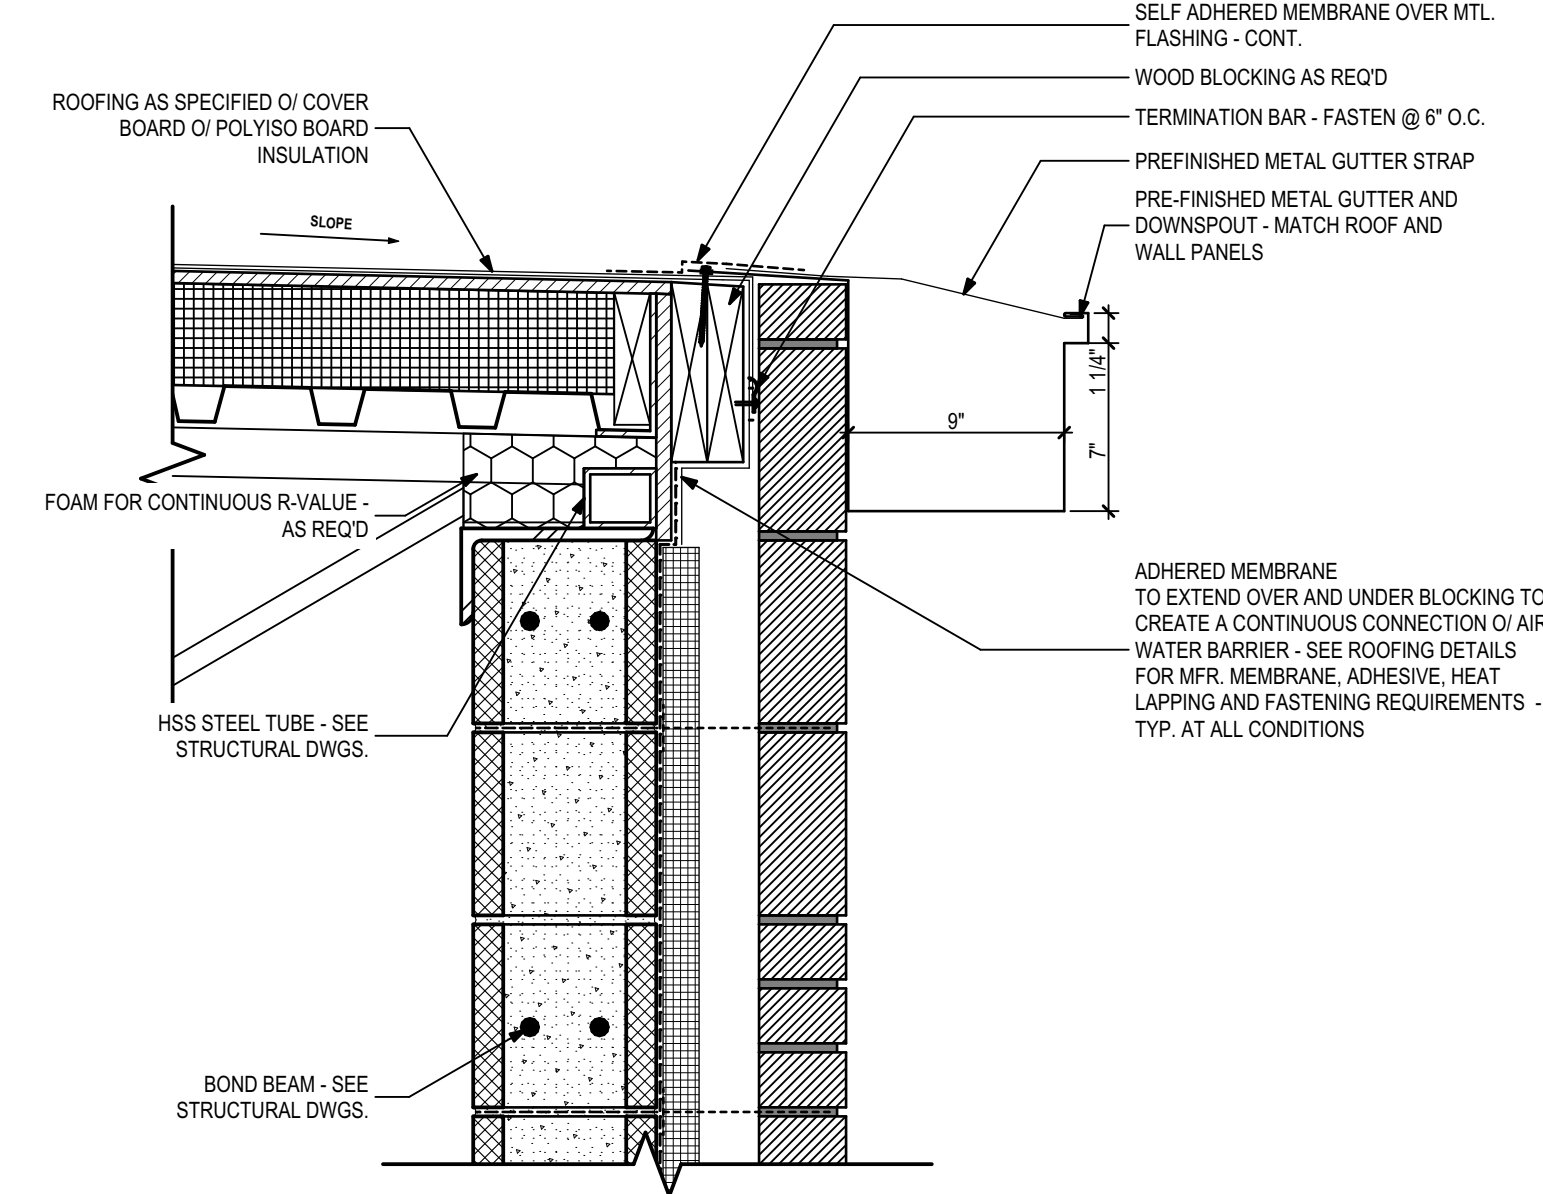


Client:	Leon County Schools 3420 W. Tharpe St., Suite 100 Tallahassee, FL 32303	Job Title:	Griffin Middle School - Phase 2 800 Alabama St. Tallahassee, FL 32304
Consultant:	23483 100% CDs	Project #:	23483 100% CDs
Seal:			
Architects Lewis + Whitlock 206 West Virginia St. Tallahassee, Florida 32301 850.942.1718 www.think3d.net			
Description: Roof Section Details			
Sheet No.: A3.6			

PHASE:	DRAWN:	REVIEWED:	DATE:	ID:	REVISION:	DRAWN:	REVIEWED:	DATE:
CONCEPT SCHEM. DESIGN	BG/RS	C. WHITLOCK	10/8/2024					
DESIGN DEVELOPMENT	BG/RS/MS	C. WHITLOCK	12/20/2024					
EARLY DEMOLITION PACKAGE	BG/RS/MS	R. LEWIS	03/21/2025					
80% CONSTRUCTION DOCS	BG/RS/MS	R. LEWIS	05/09/2025					
PERMIT DOCS	BG/RS/MS	R. LEWIS	05/09/2025					
100% CONSTRUCTION DOCS	BG/RS/MS	R. LEWIS	05/09/2025					

THESE DRAWINGS AND RENDERINGS ARE INSTRUMENTS OF SERVICE. THE DRAWINGS AND ASSOCIATED COPIES THEREOF, INCLUDING ELECTRONIC MEDIA AND CAD FILES, ARE THE PROPERTY OF ARCHITECTS LEWIS + WHITLOCK, P.A.A. THEIR USE, REPRODUCTION OR REPRODUCTION FOR ANY PURPOSE EXCEPT BY WRITTEN AGREEMENT WITH THE ARCHITECT IS PROHIBITED. THIS COPYRIGHT NOTIFICATION SHALL BE TRUE AS F DIRECTLY PLACED ON EACH DRAWING EXHIBIT, CONVEYING ON THE DOCUMENT AND SHALL NOT BE REMOVED FROM THESE DOCUMENTS.

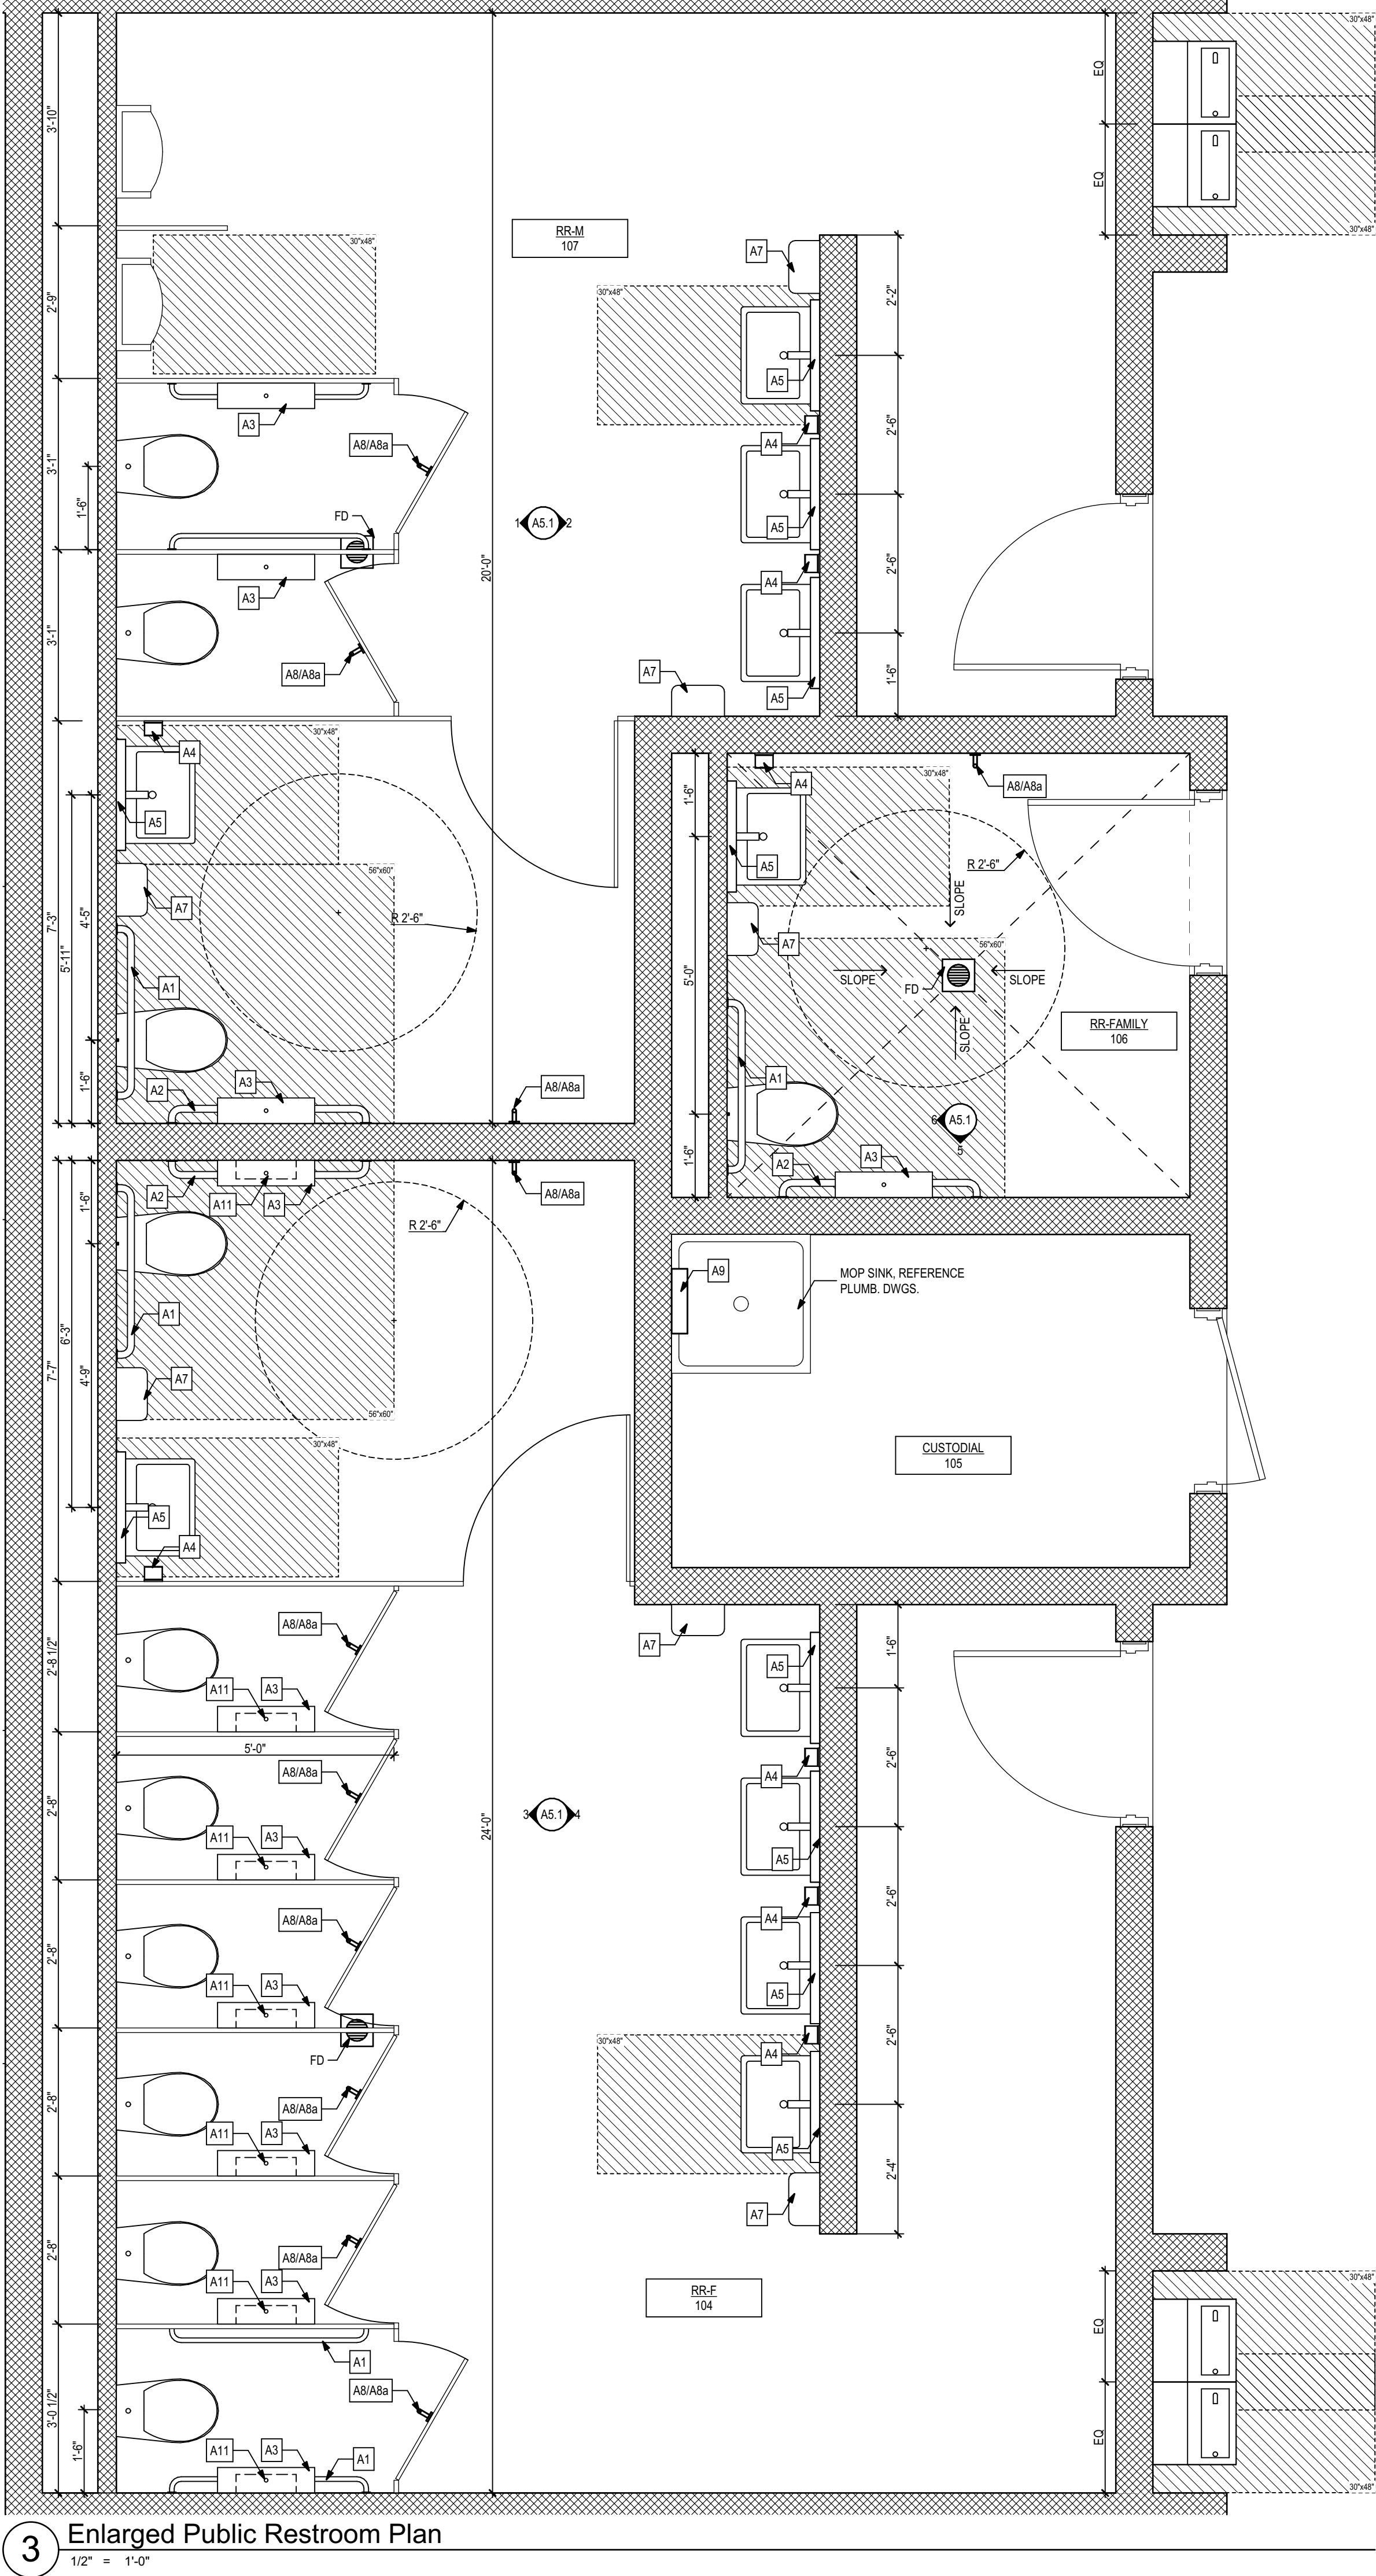



Acc. Mounting Height

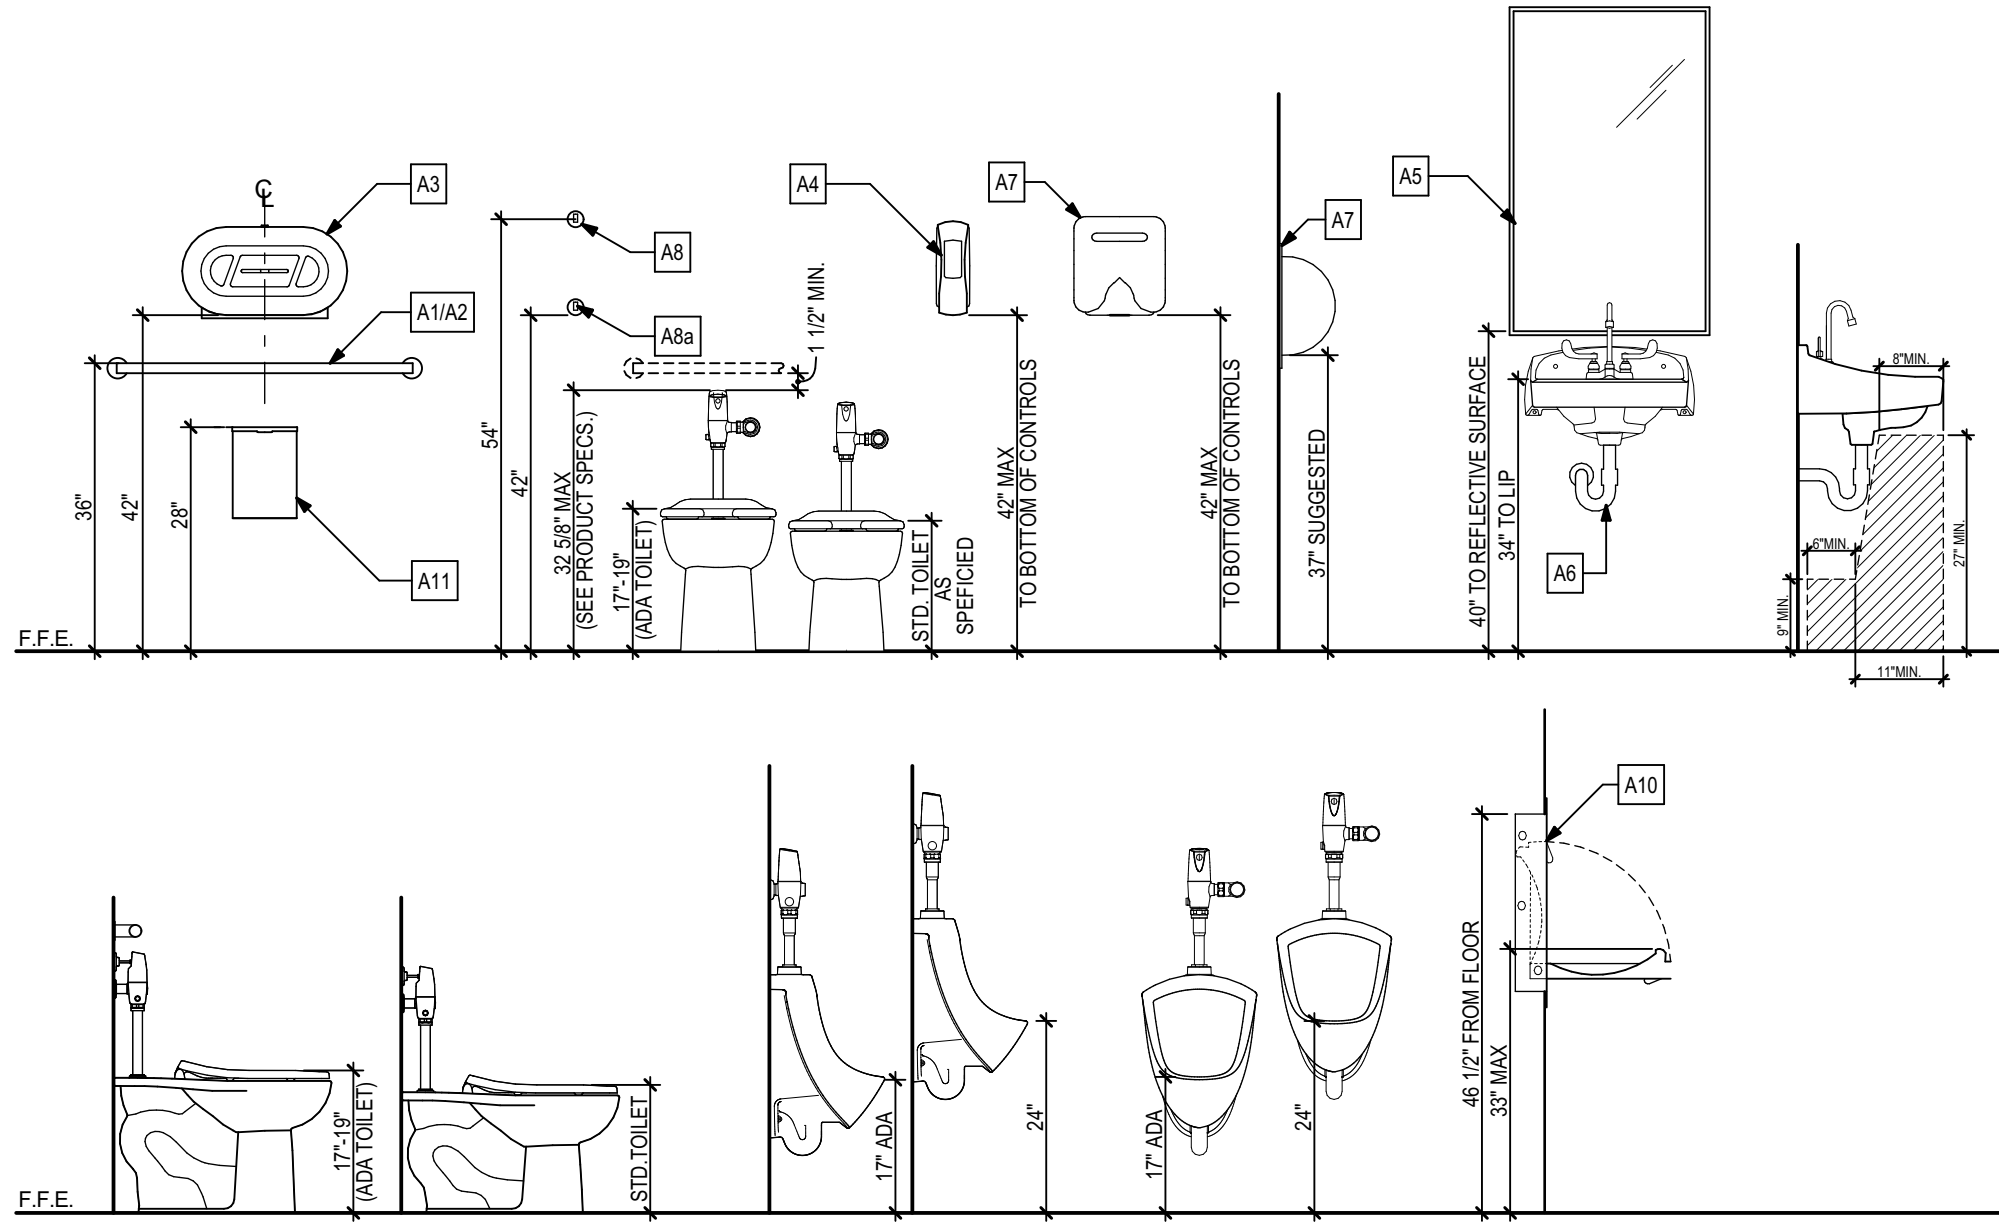

Accessory Schedule

A1	42" GRAB BAR, 1 1/2" DIA - BRADLEY #812
A2	36" GRAB BAR, 1 1/2" DIA - BRADLEY #812
A3	TOILET TISSUE DISPENSER - PROVIDED BY OWNER
A4	SOAP DISPENSER - PROVIDED BY OWNER
A5	36"h x 20"w MIRROR, FRAMELESS - SEE SPECIFICATIONS
A6	INSULATED UNDER SINK PROTECTIONS - MAINLINE ML102EZ LAV GUARD 2, ONE P-TRAP COVER, TWO ANGLE VALVES AND SUPPLY COVERS
A7	AUTOMATIC HAND DRYER - EXCEL XLERATOR XL-BW, SEE ELECTRICAL
A8	CLOTHES HOOK - BRADLEY 9114
A8a	CLOTHES HOOK - BRADLEY 9114 (ADA HEIGHT MOUNTED)
A9	MOP HOLDER - BOBRICK B239 X 34
A10	NOT USED
A11	SANITARY NAPKIN DISPOSAL - AMERICAN SPECIALTIES 0852
A12	16" x 31" 2-WALL GRAB BAR, 1 1/2" DIA - BOBRICK B-6861
A13	FOLDING SHOWER SEAT, BOBRICK B-5181
A14	24" GRAB BAR, 1 1/2" DIA - BRADLEY #812
A15	50" GRAB BAR, 1 1/2" DIA - BRADLEY #812

NOTE:
PLUMBING AND ELECTRICAL FIXTURES ARE SHOWN FOR CLARITY. FINAL LOCATIONS WILL BE DETERMINED BY THE MECHANICAL / ELECTRICAL ENGINEER AND SHOWN ON THEIR RESPECTIVE DRAWINGS

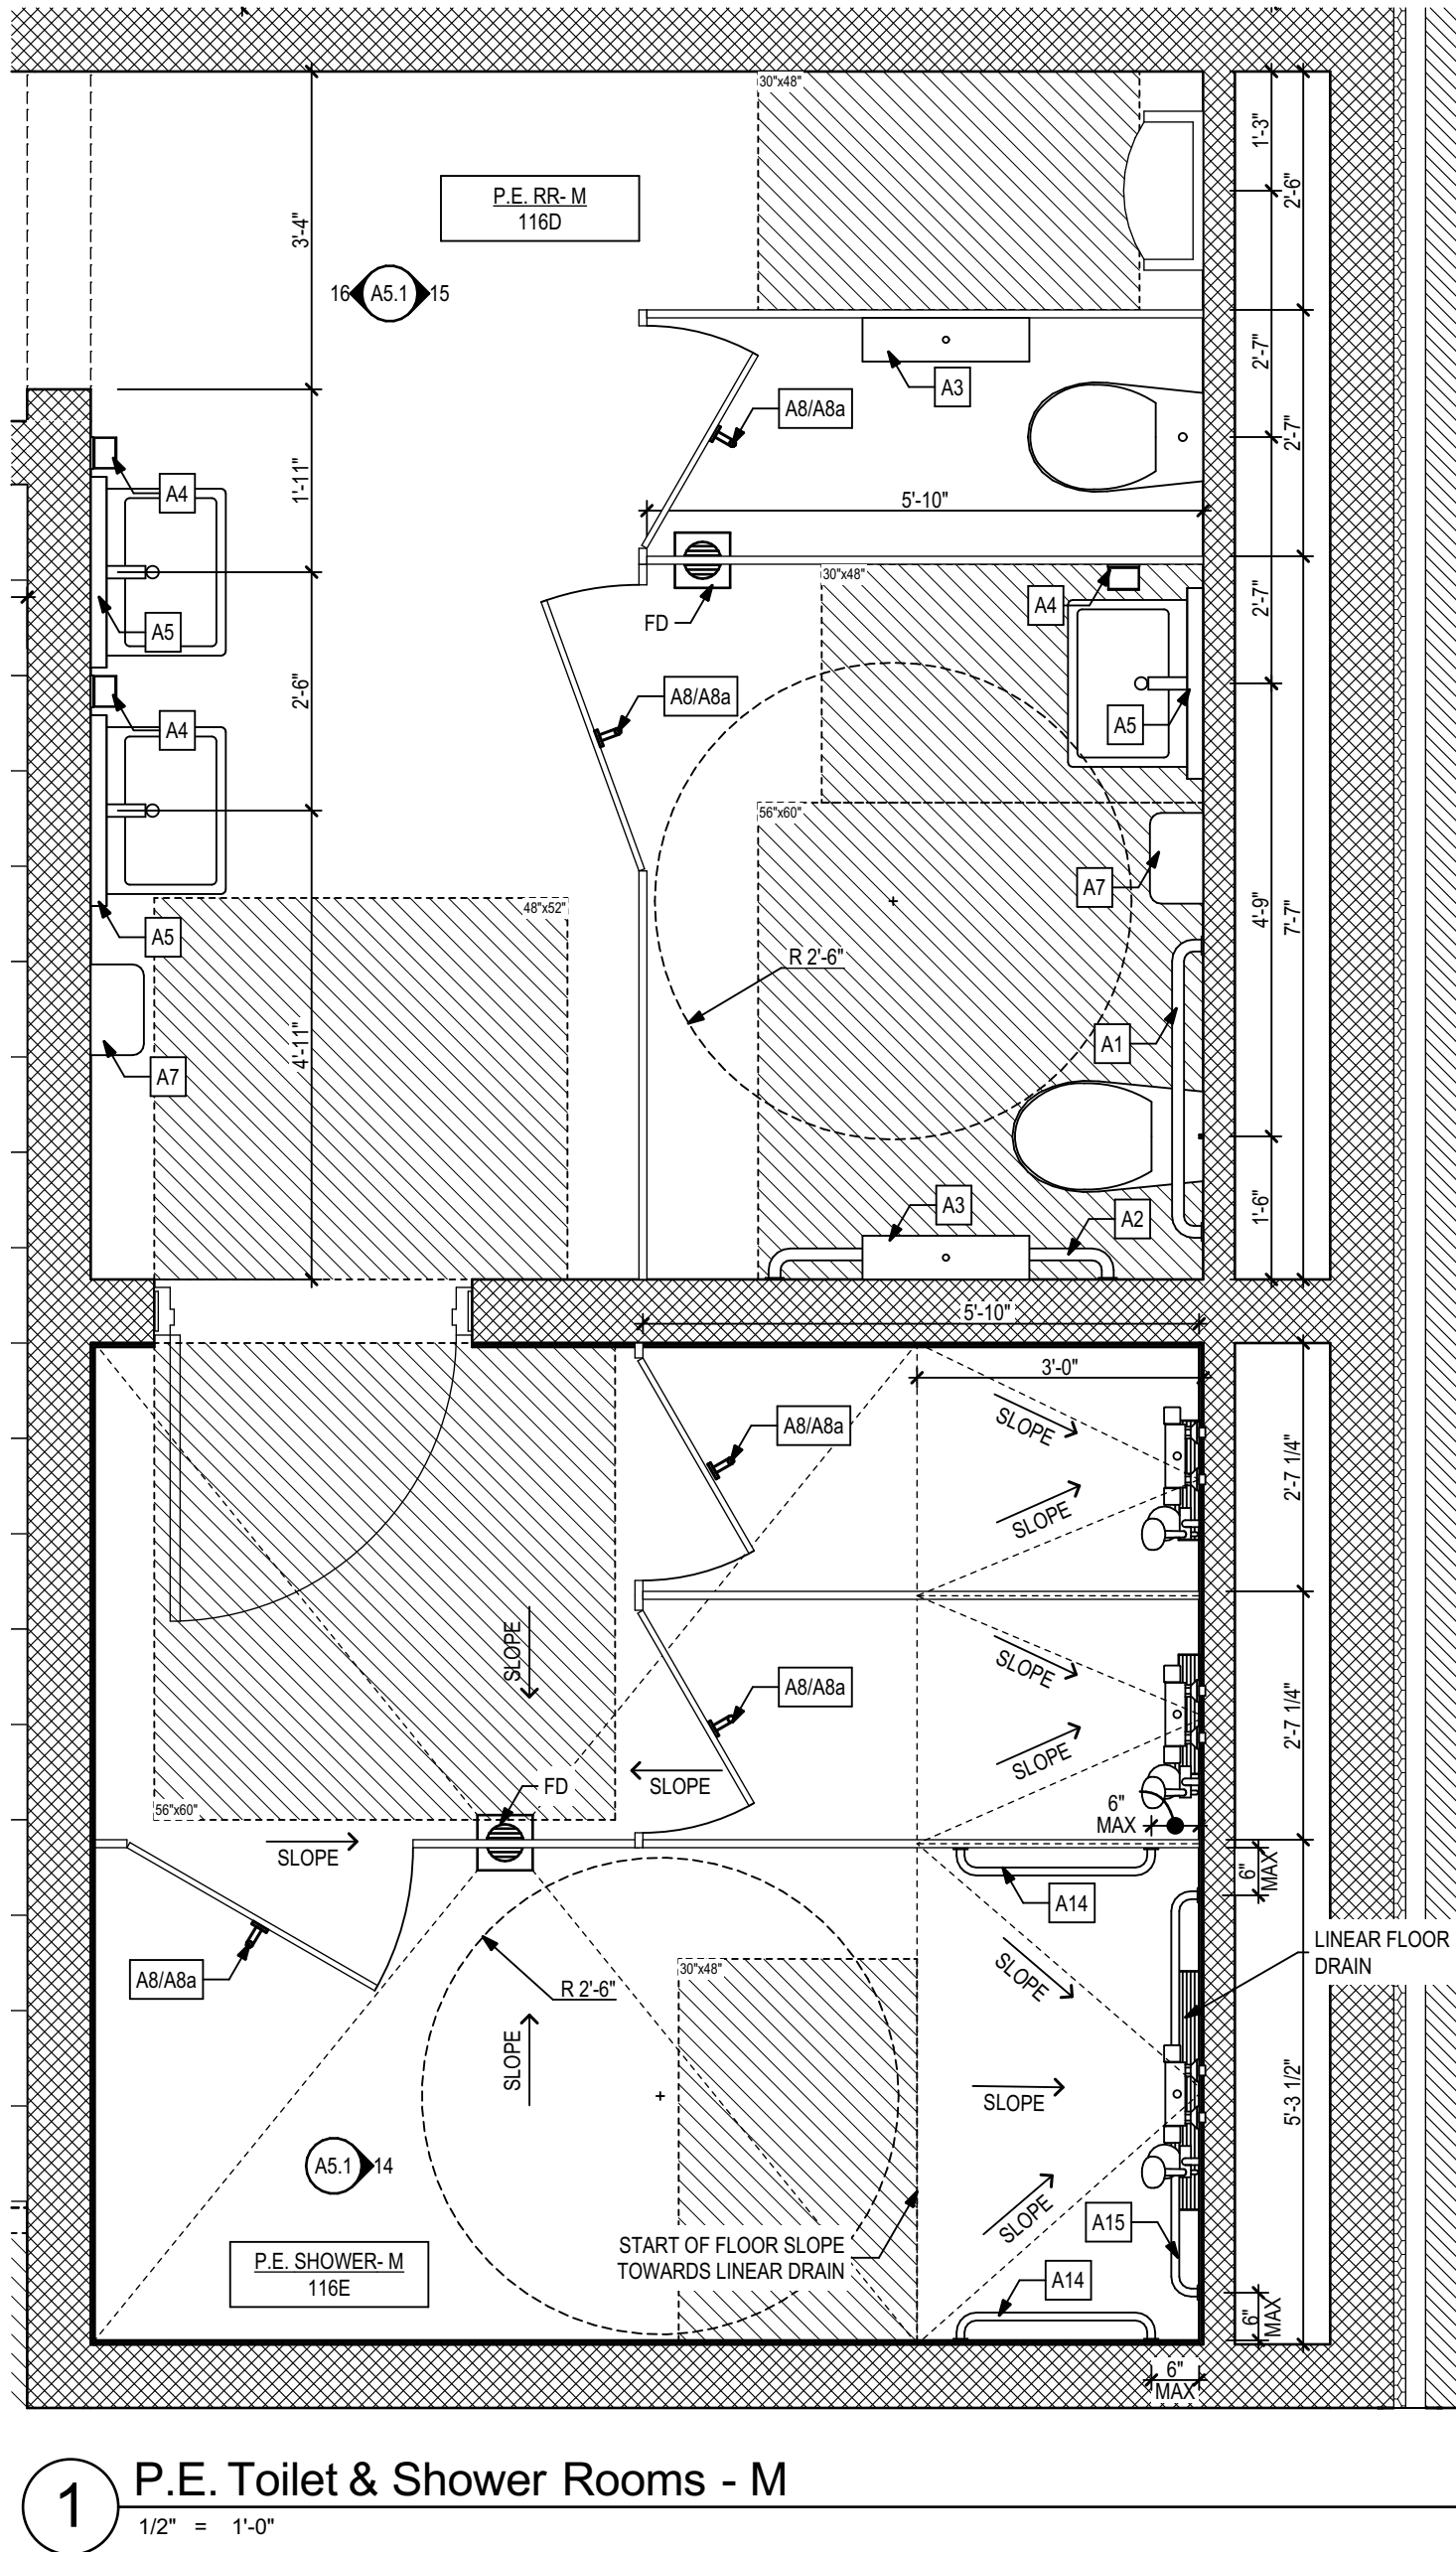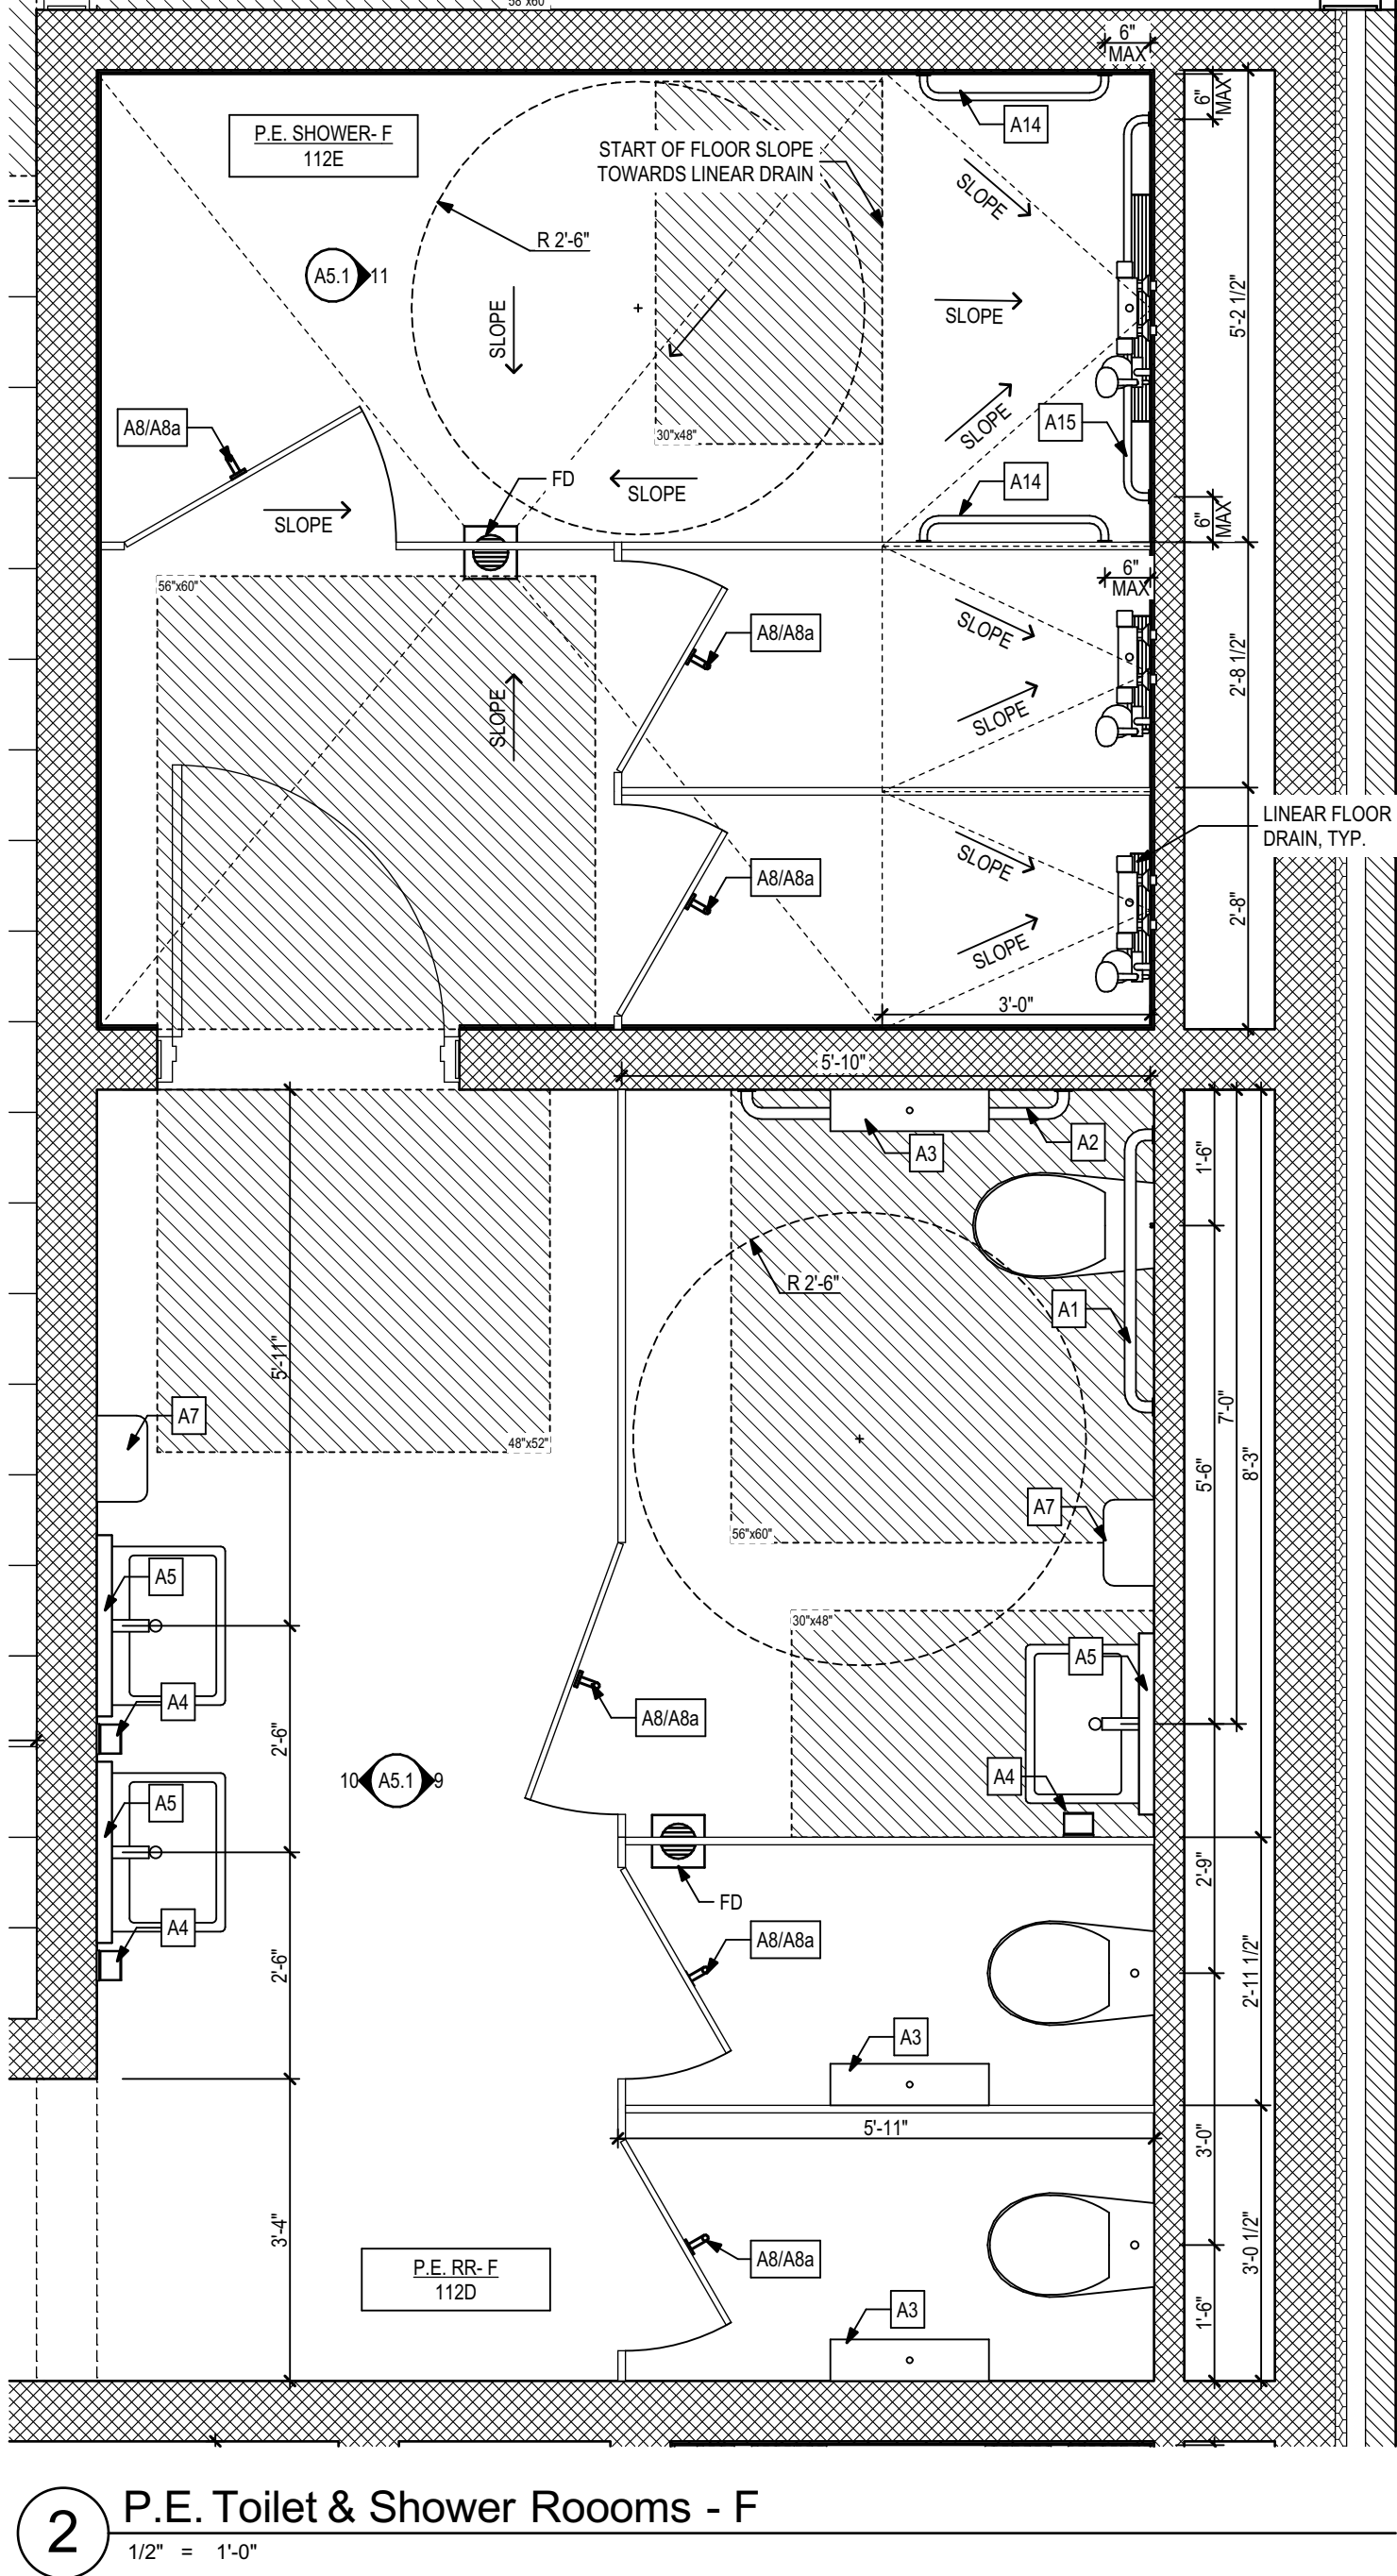

Seal:

Client:
Leon County Schools

Consultant:
23483
100% CDs

Job Title:
Griffin Middle School - Phase 2
3420 W. Tharpe St., Suite 100
Tallahassee, FL 32303

Project #:
23483
100% CDs


Phase:
100% CDs

ALW


Architects Lewis + Whitlock
206 West Virginia St.
Tallahassee, Florida 32301
850.942.1718
www.think3d.net

Description:
Enlarged Plans


Sheet No.:
A4.1

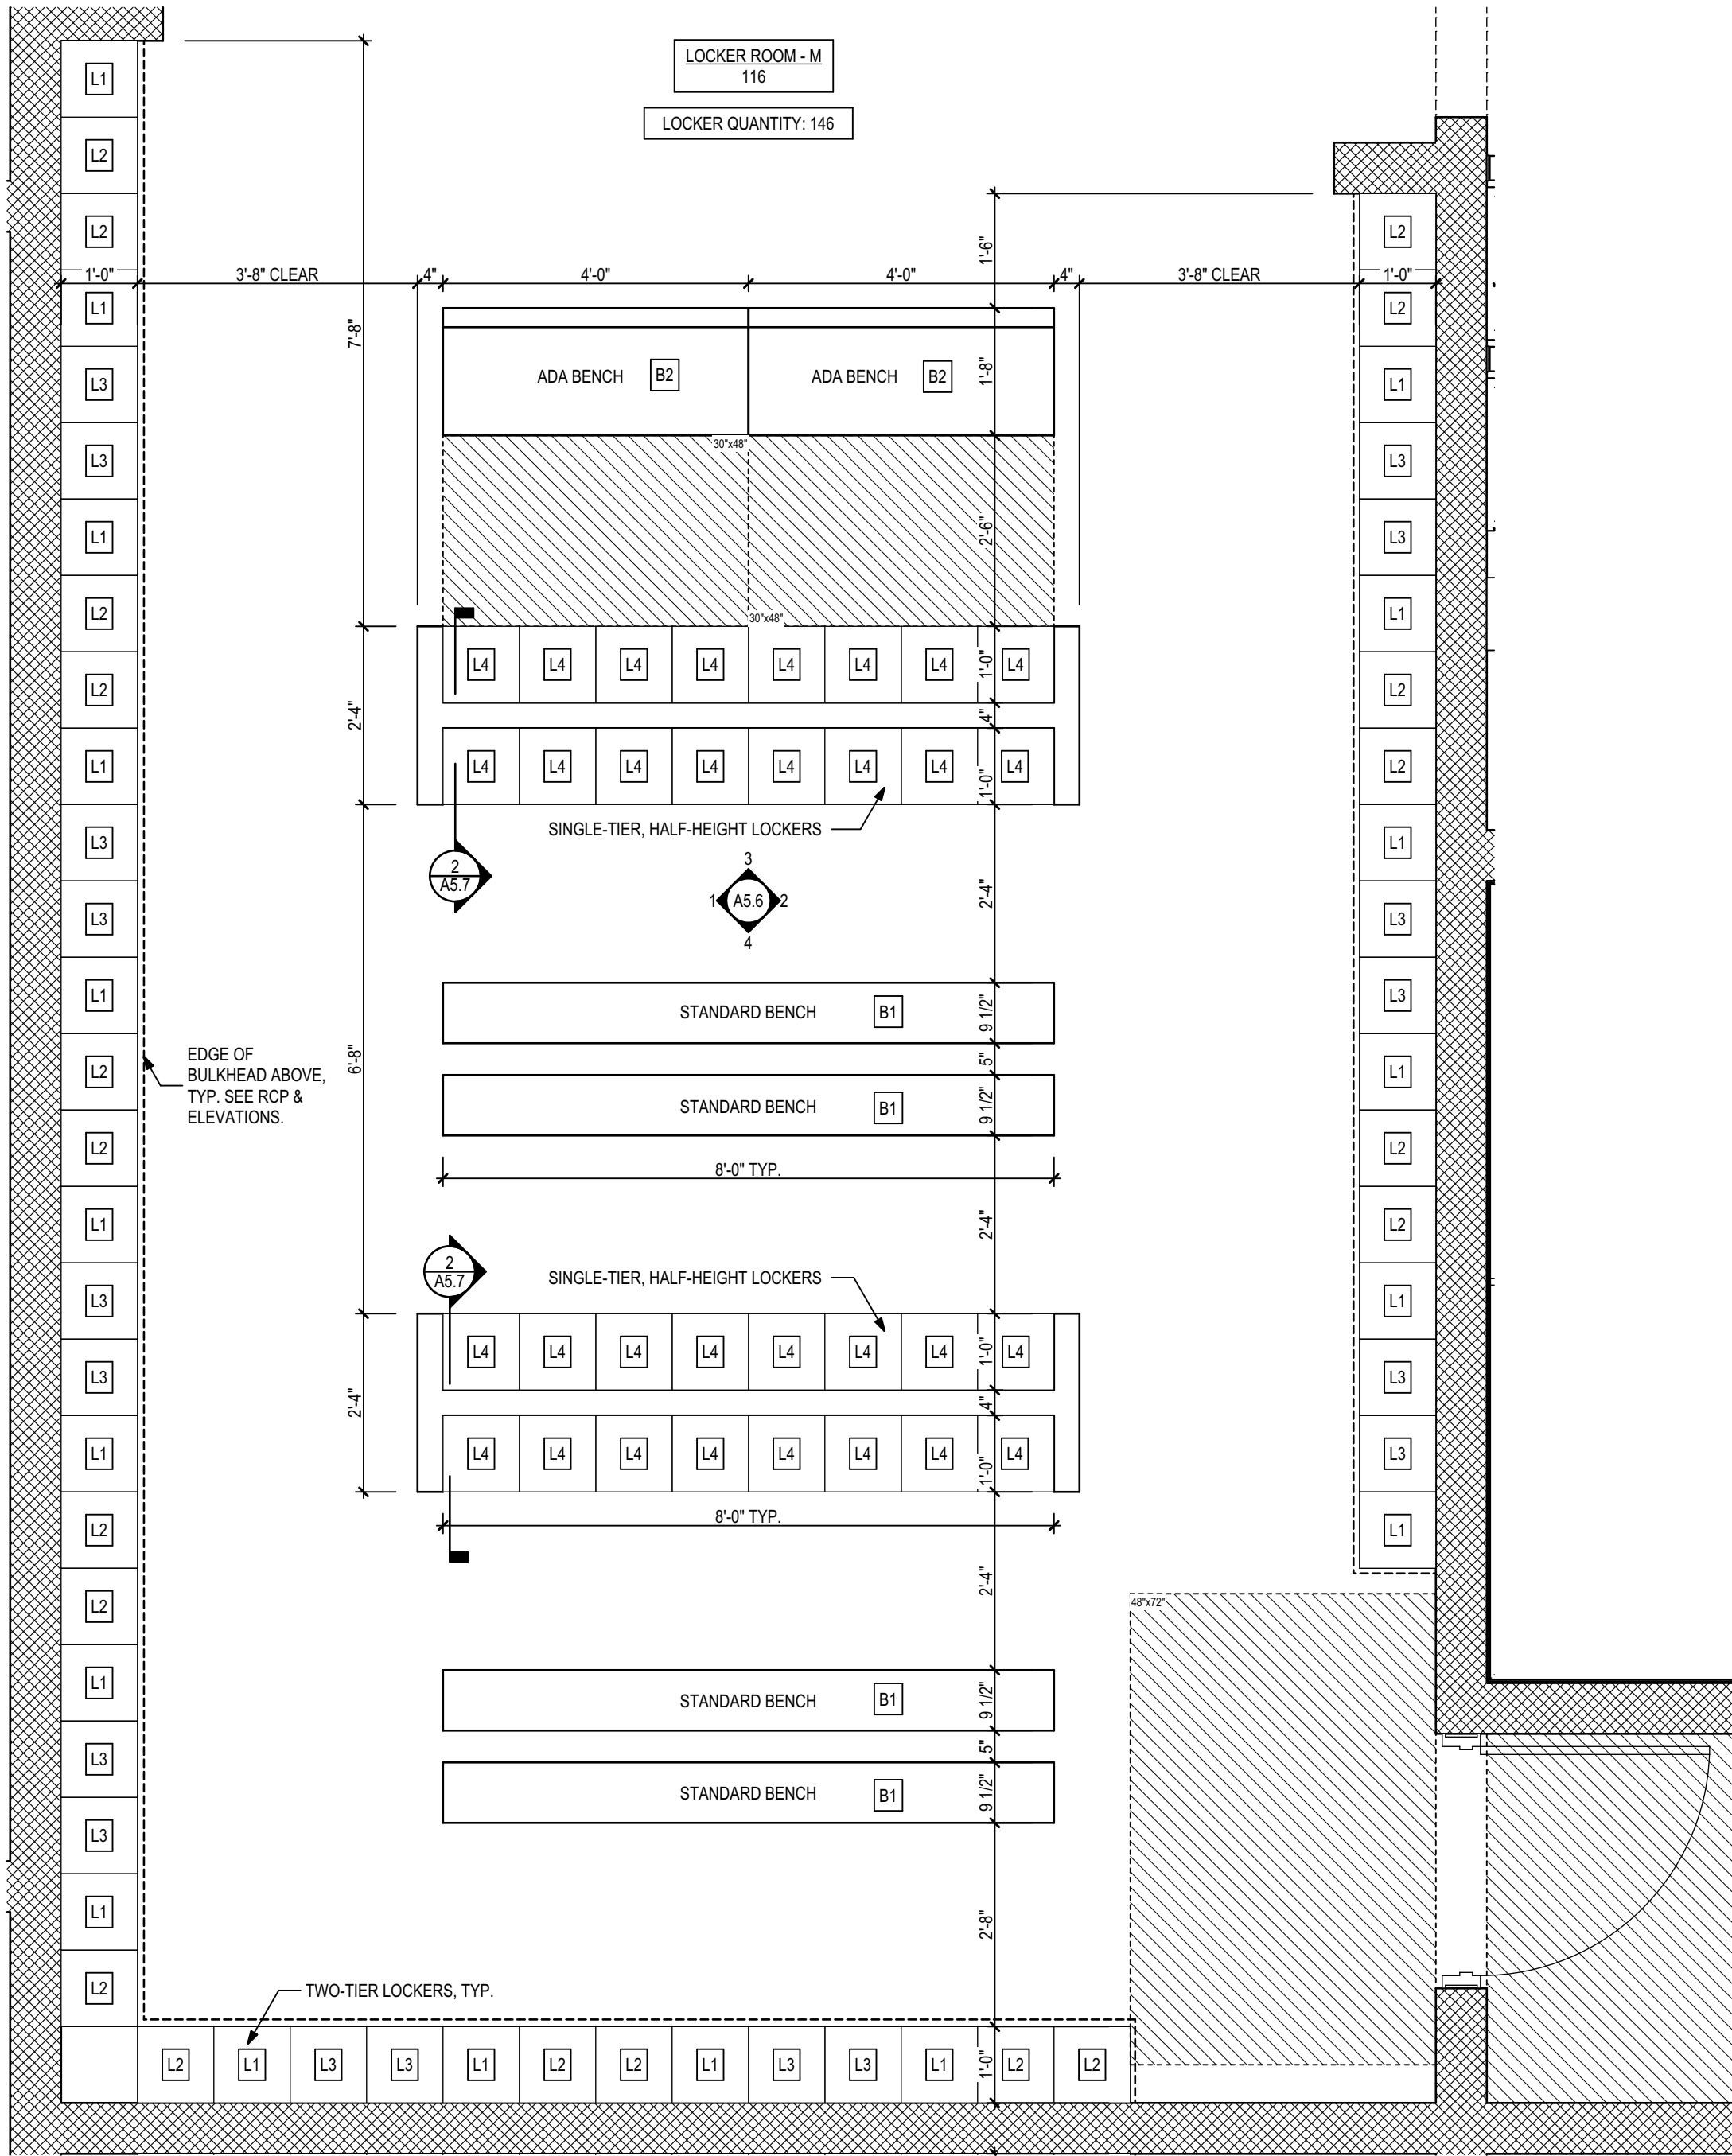


5 Locker Room - M
1/2" = 1'-0"

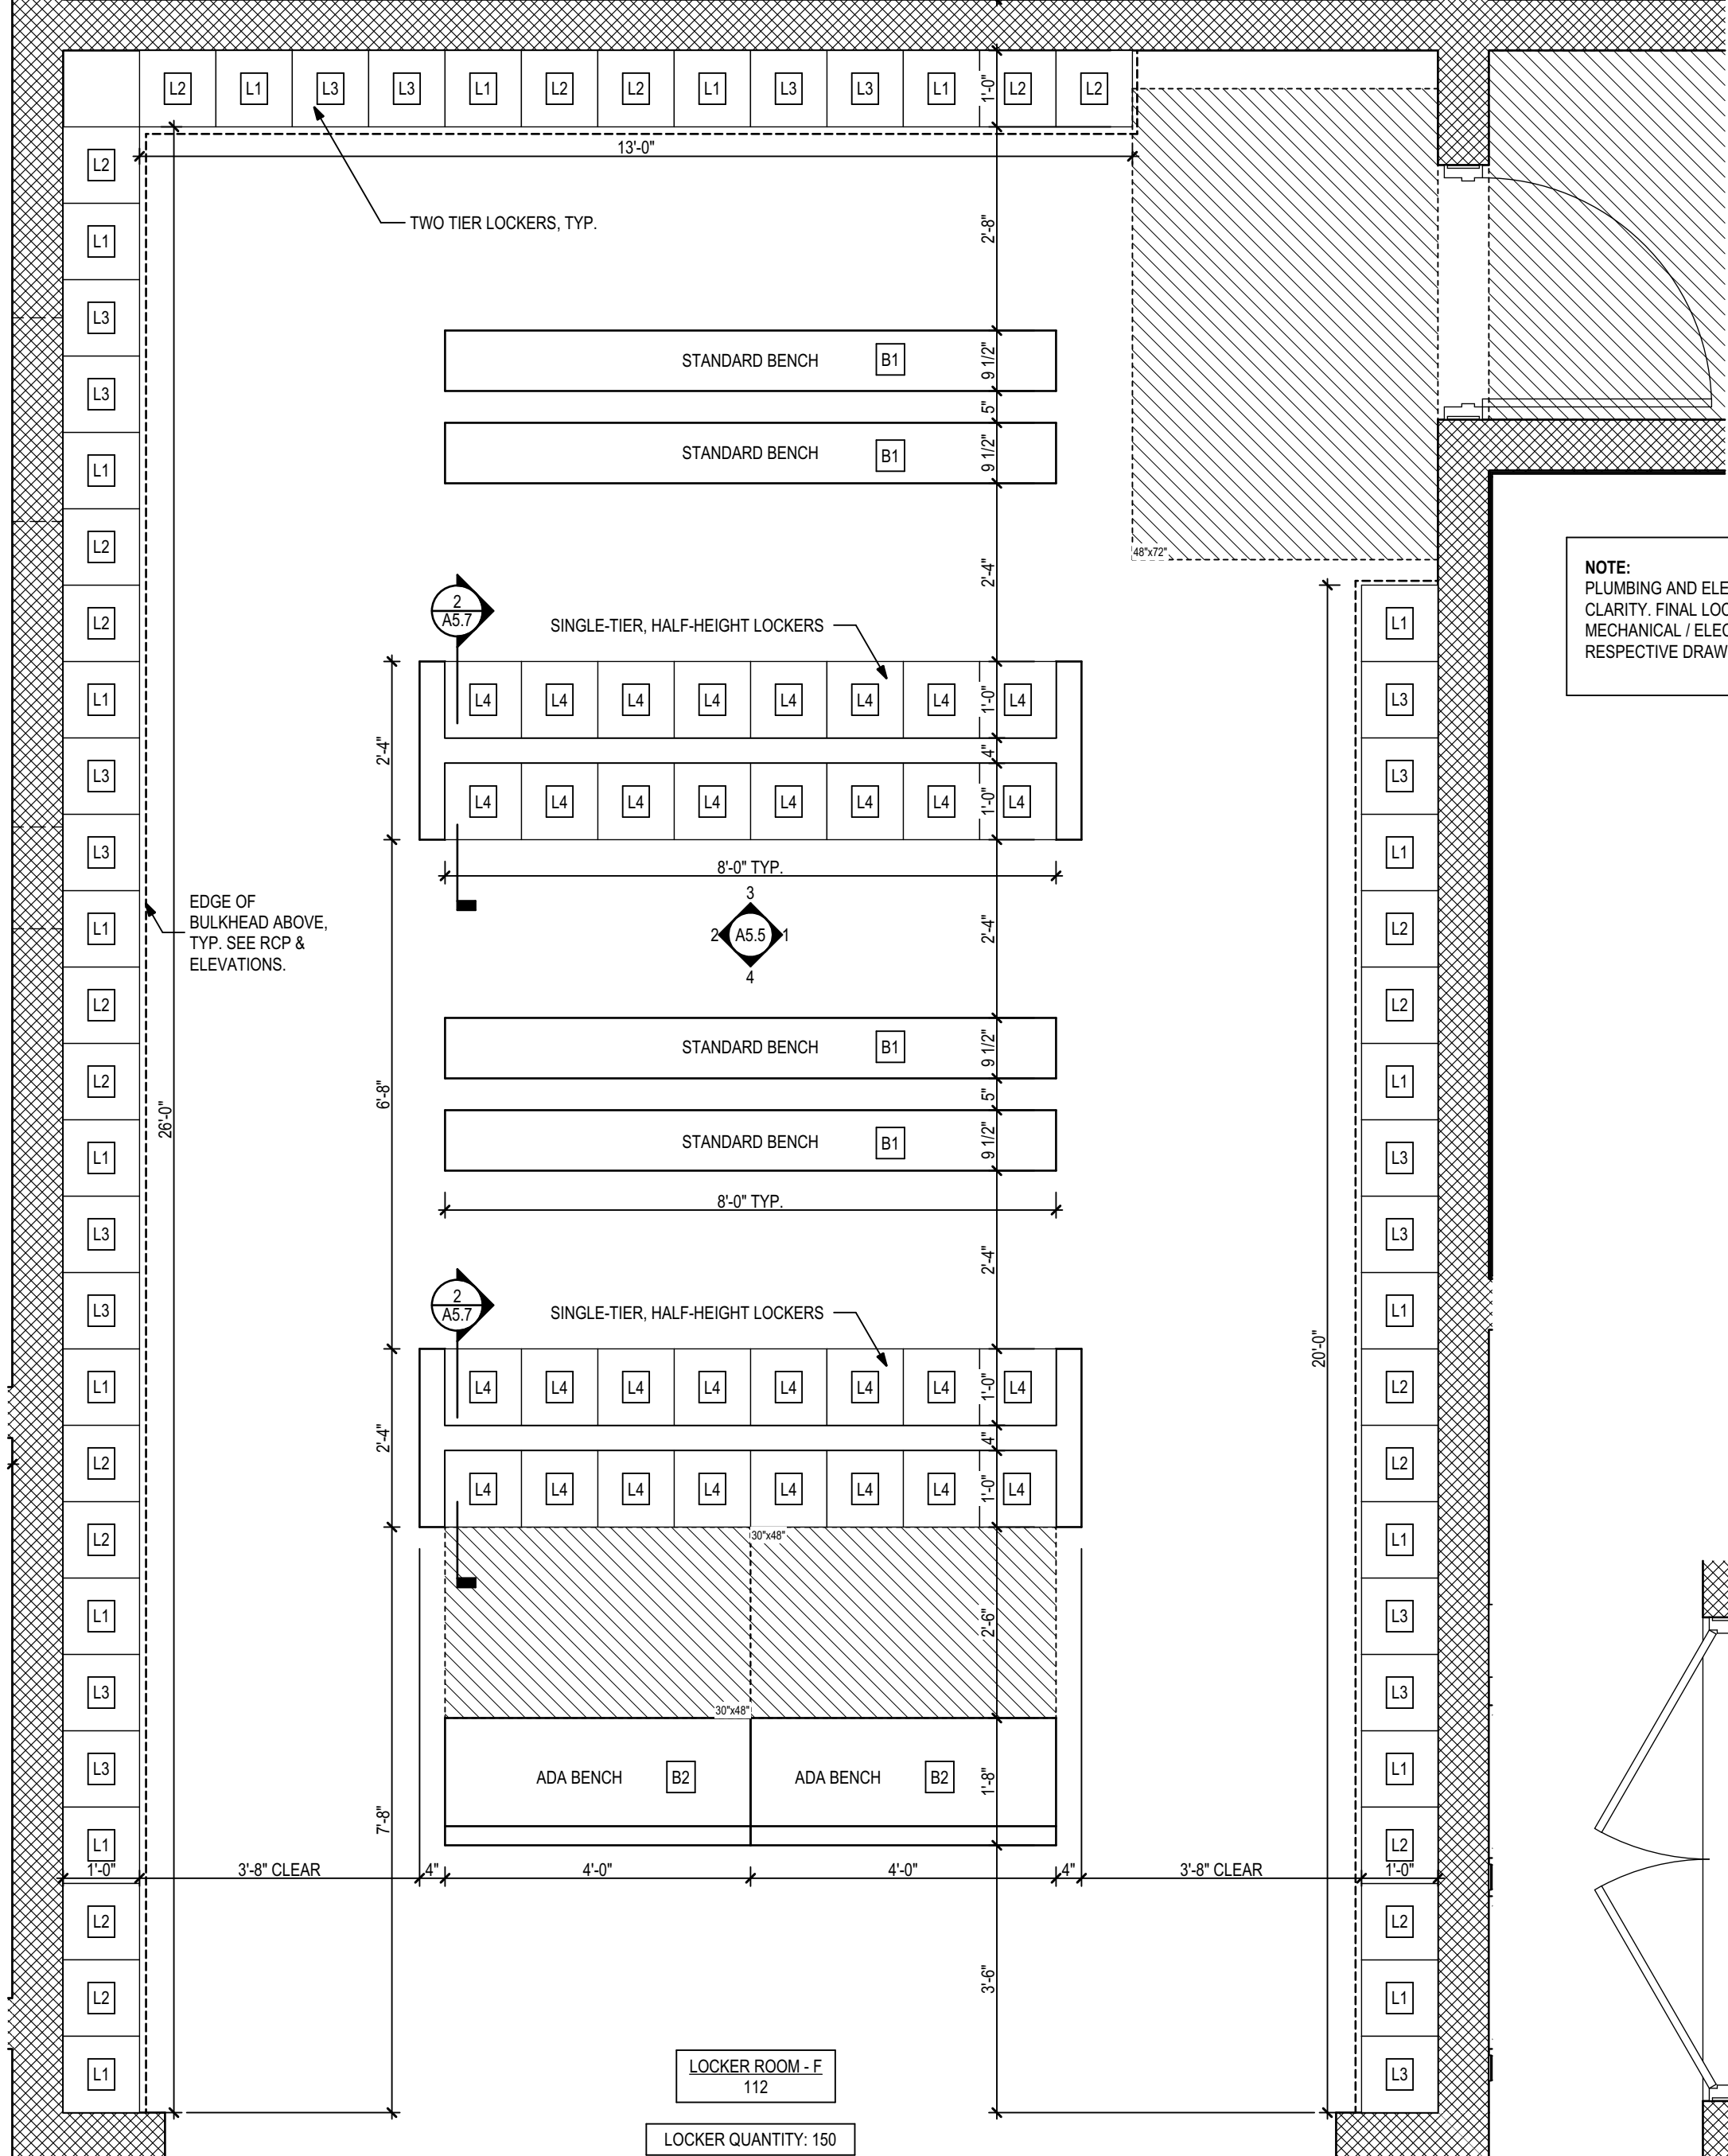


4 Locker Room - F
1/2" = 1'-0"

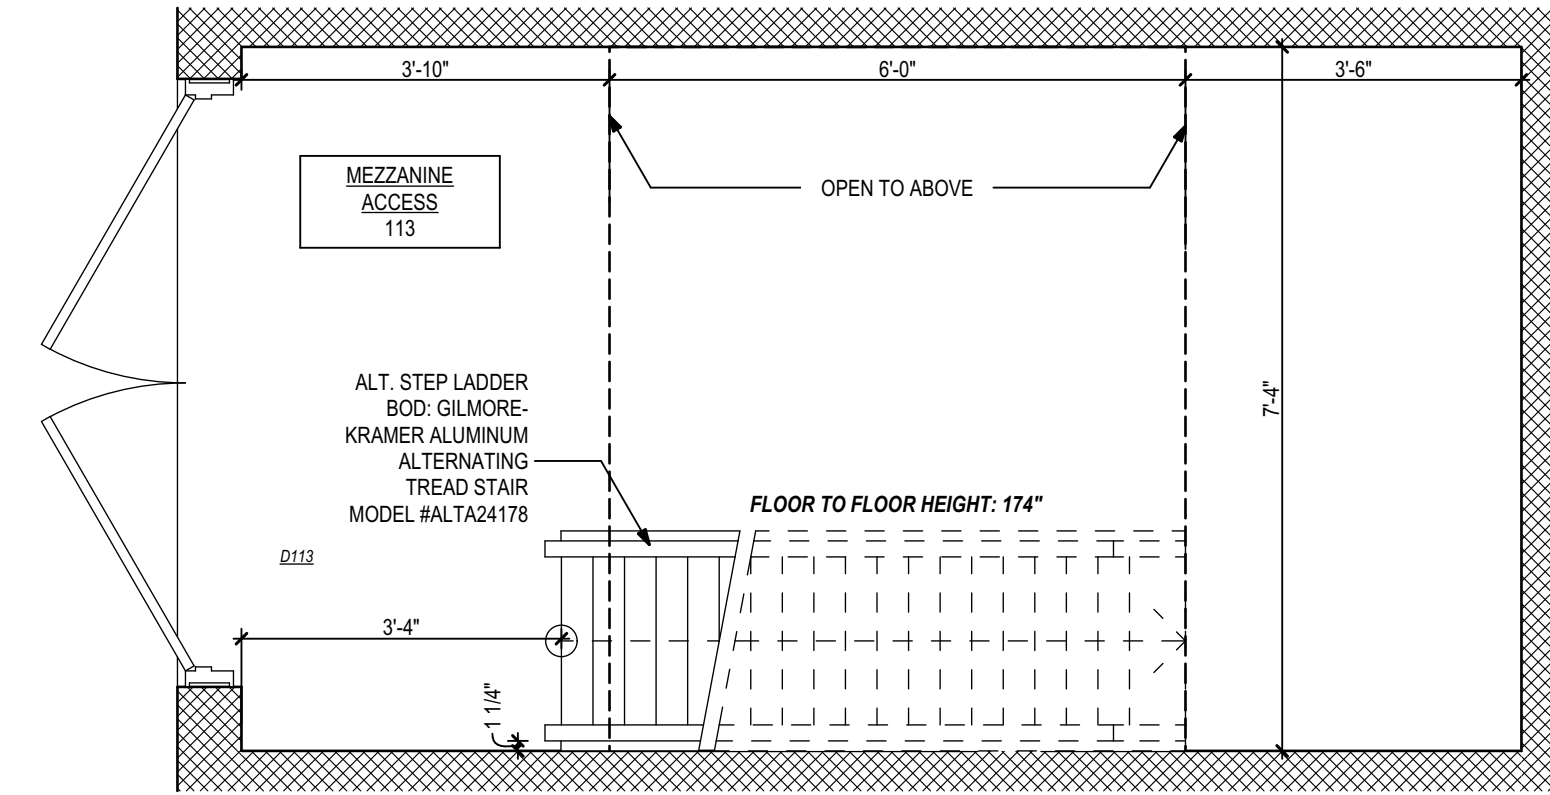

3 Mezzanine Access
1/2" = 1'-0"

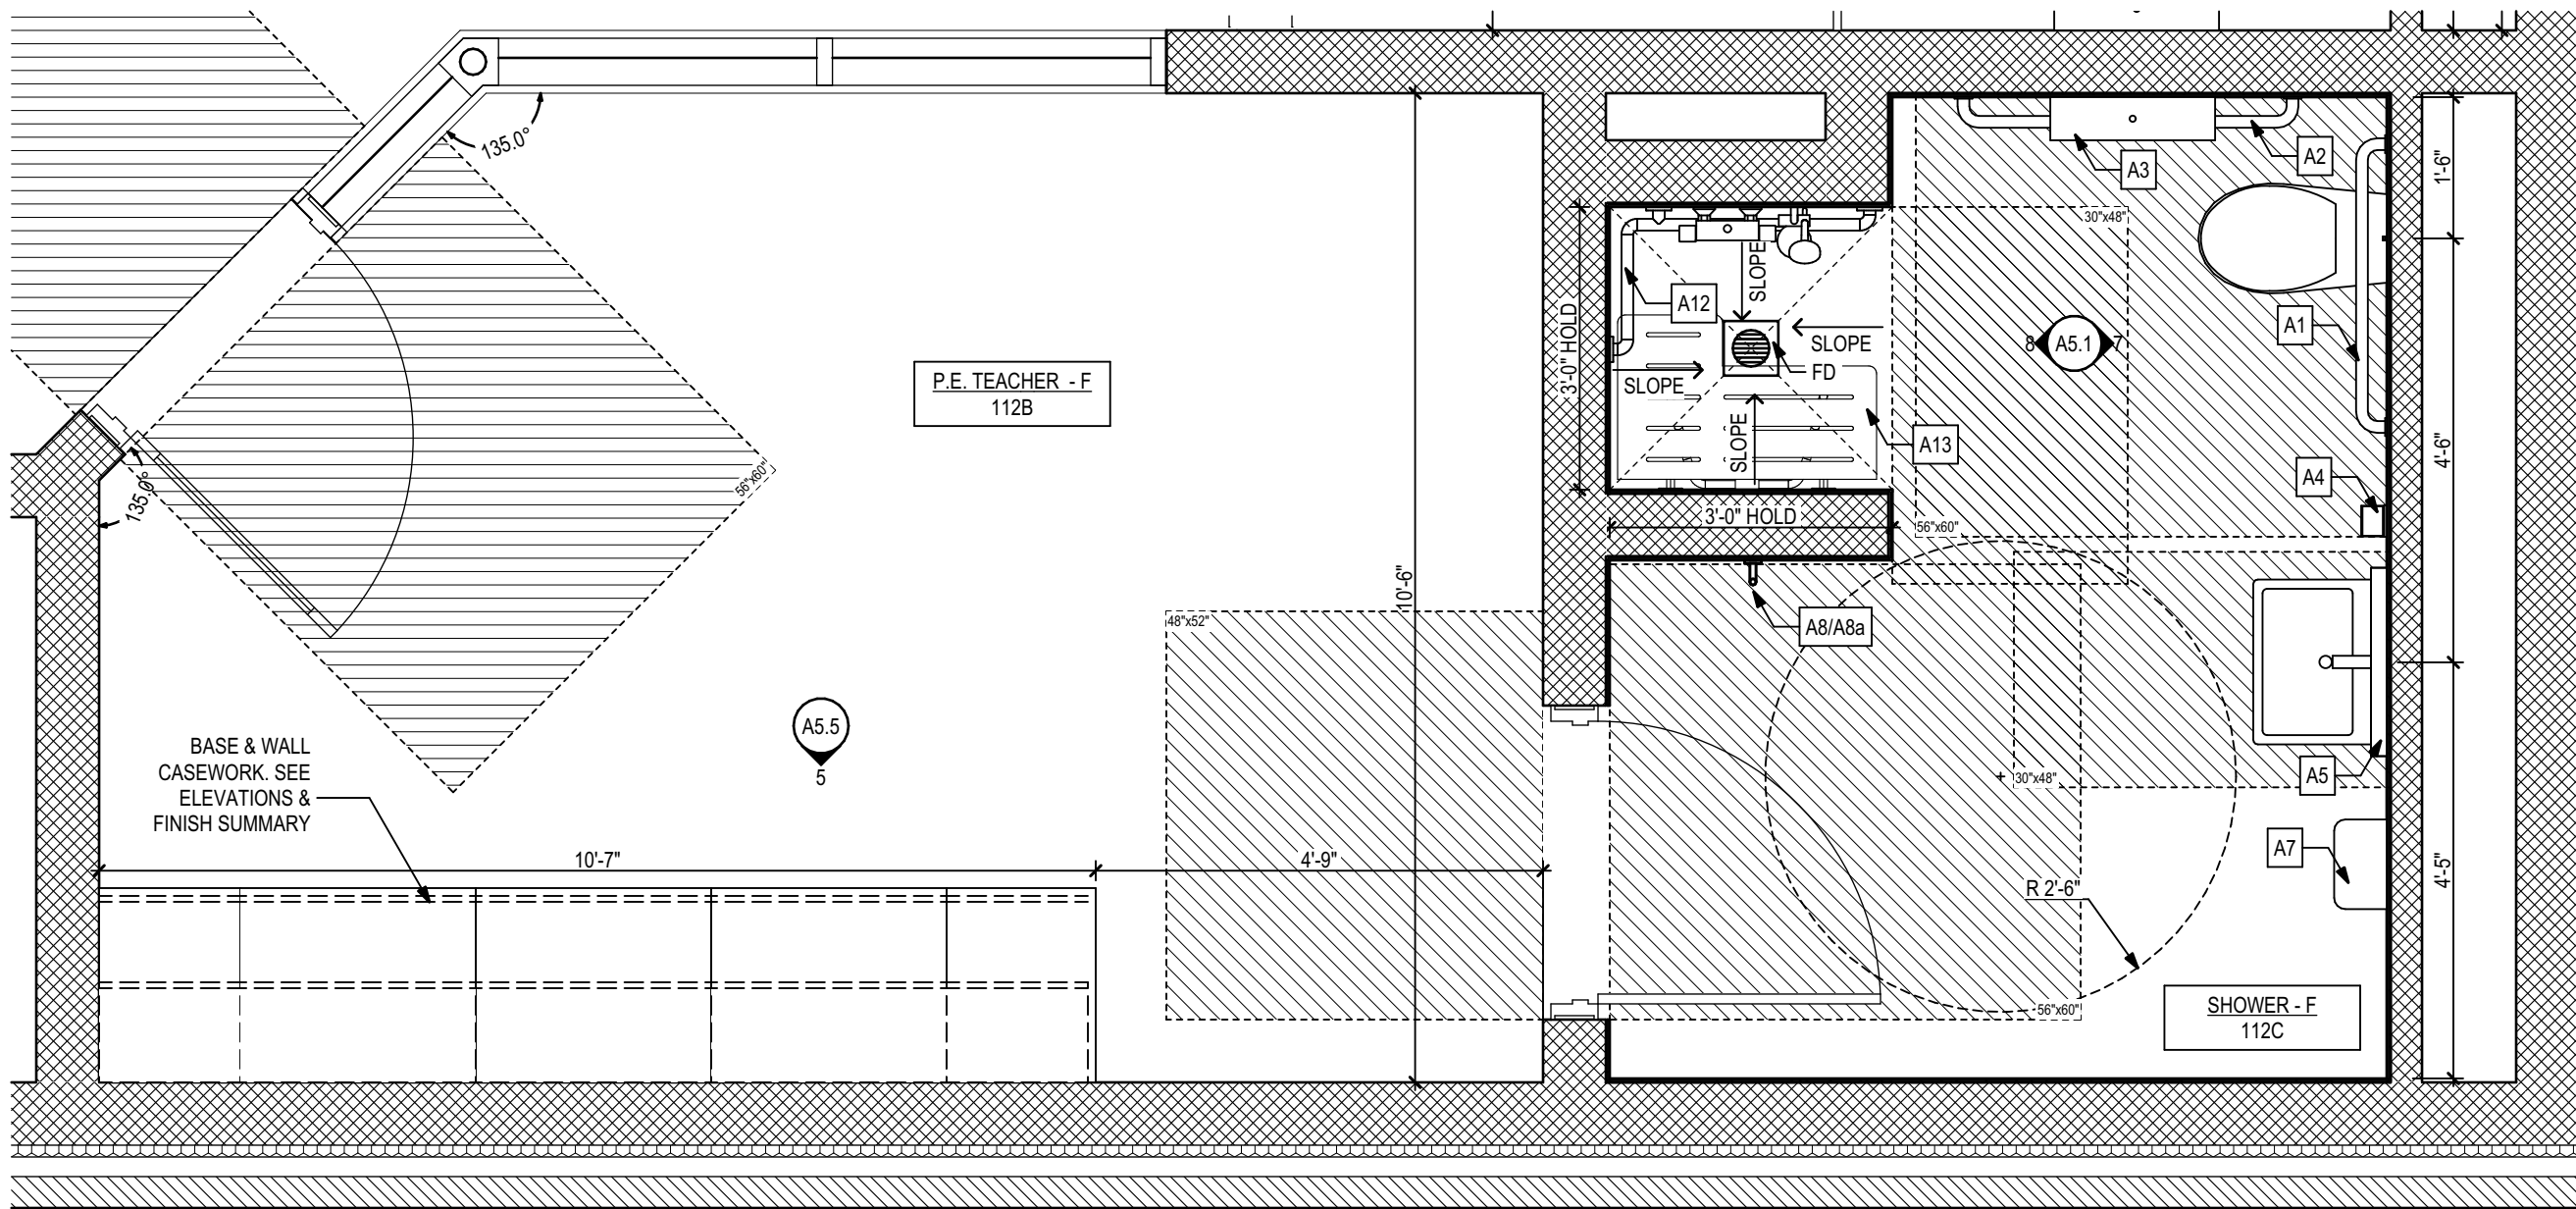

2 P.E. Teacher Office Suite - F
1/2" = 1'-0"

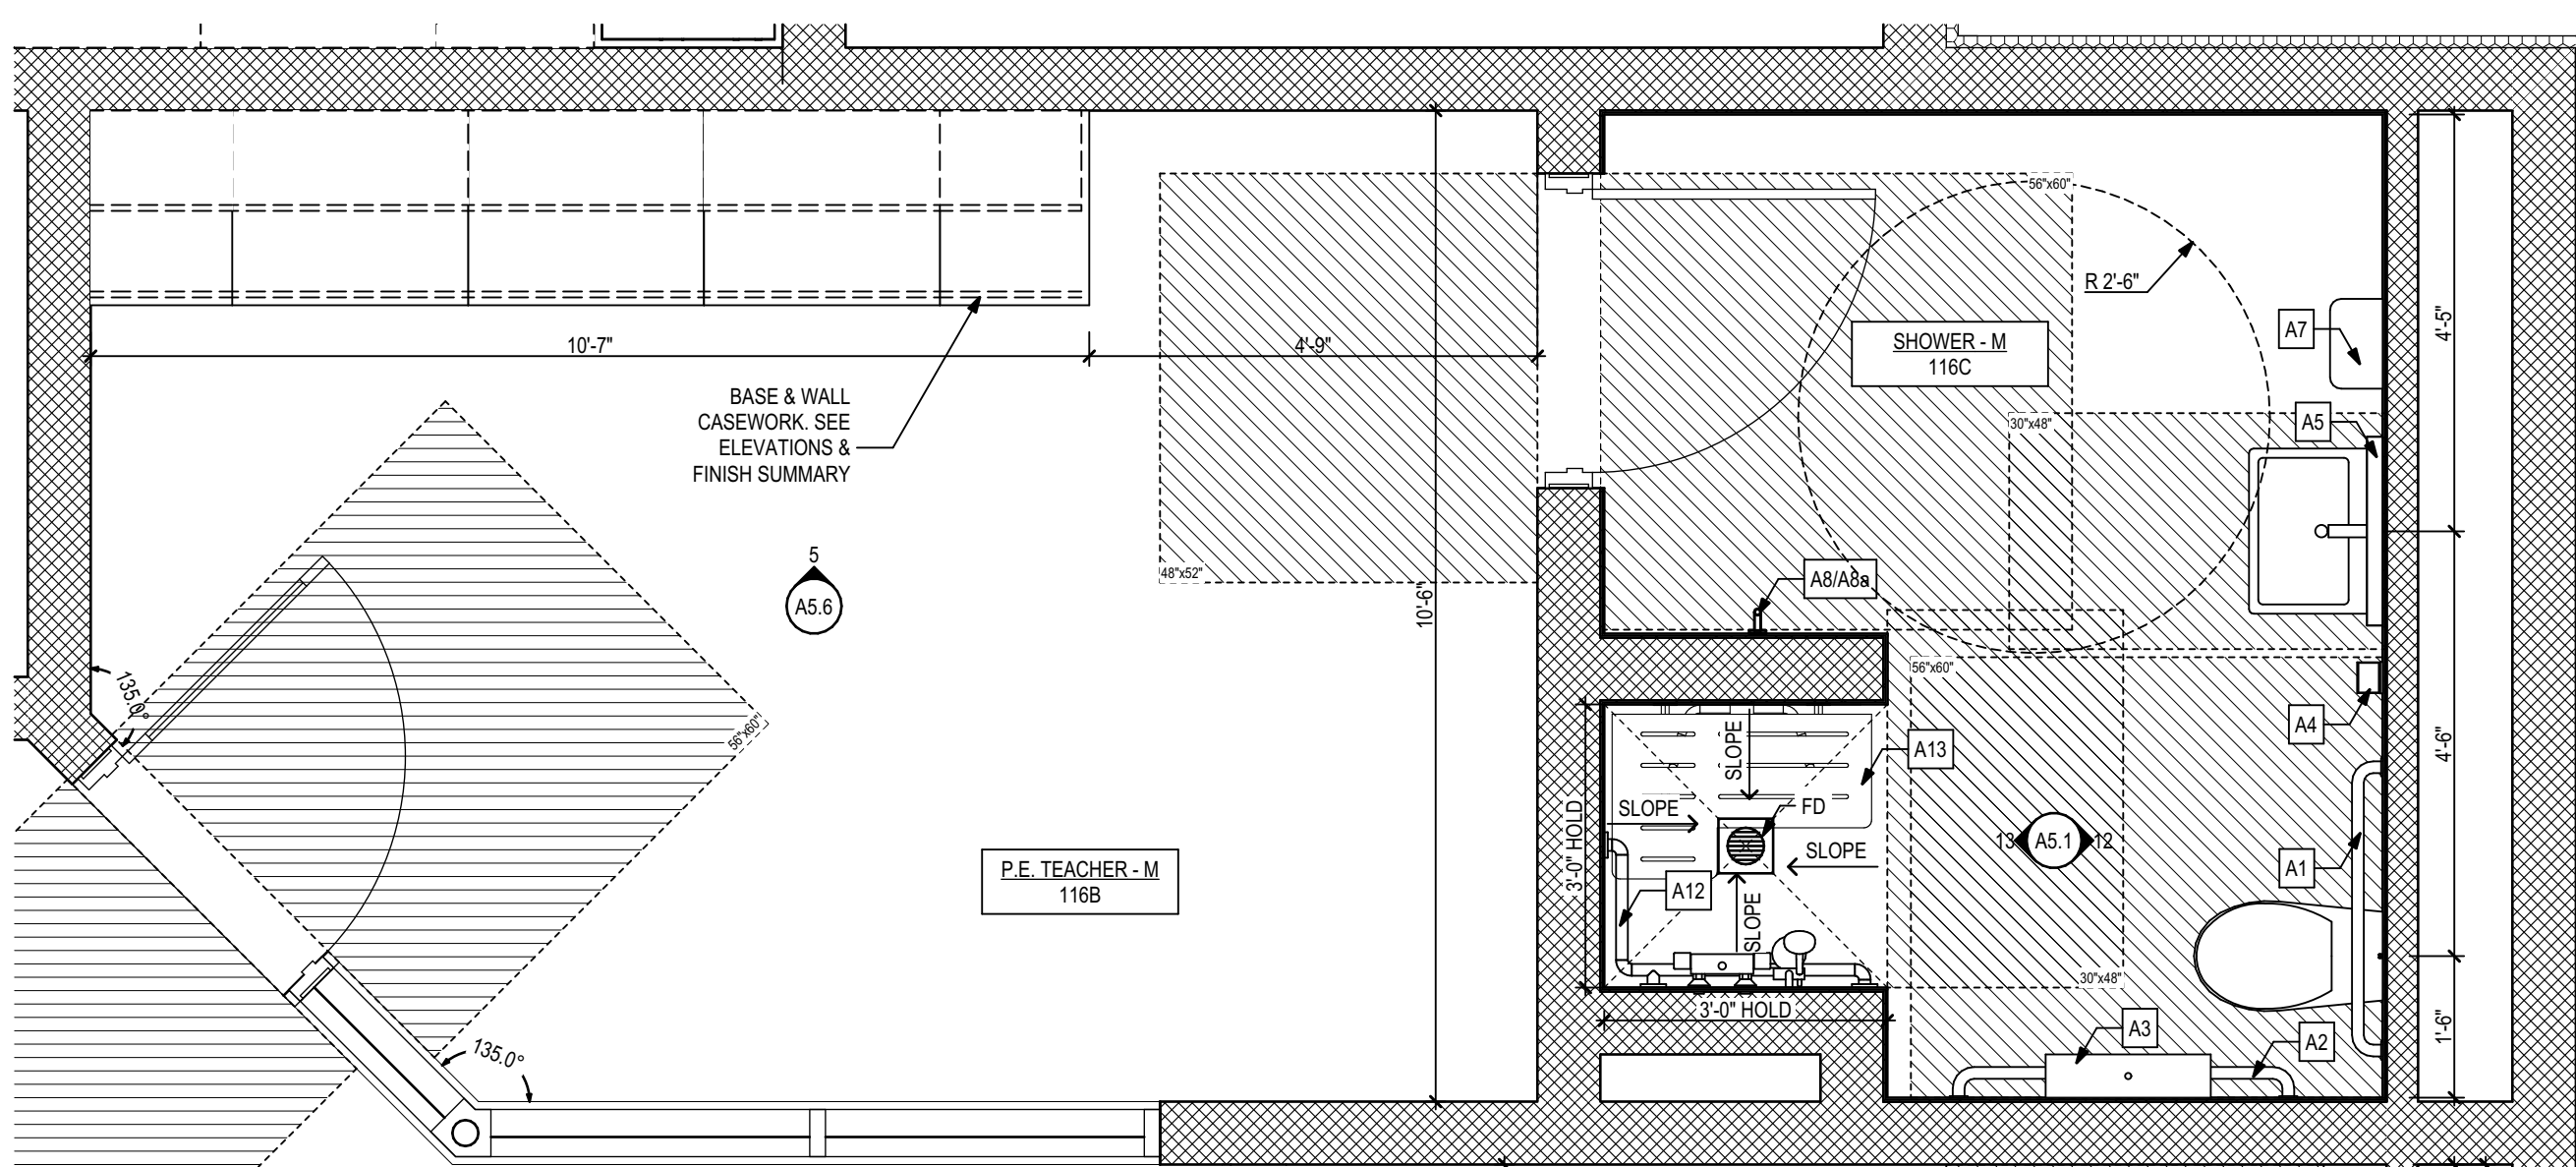

1 P.E. Teacher Office Suite - M
1/2" = 1'-0"

Accessory Schedule

A1	42" GRAB BAR, 1 1/2" DIA - BRADLEY #812
A2	36" GRAB BAR, 1 1/2" DIA - BRADLEY #812
A3	TOILET TISSUE DISPENSER - PROVIDED BY OWNER
A4	SOAP DISPENSER - PROVIDED BY OWNER
A5	36"h x 20"w MIRROR, FRAMELESS - SEE SPECIFICATIONS
A6	INSULATED UNDER SINK PROTECTIONS - MAINLINE ML102EZ LAV GUARD 2, ONE P-TRAP COVER, TWO ANGLE VALVES AND SUPPLY COVERS
A7	AUTOMATIC HAND DRYER - EXCEL XLERATOR XL-BW, SEE ELECTRICAL
A8	CLOTHES HOOK - BRADLEY 9114
A8a	CLOTHES HOOK - BRADLEY 9114 (ADA HEIGHT MOUNTED)
A9	MOP HOLDER - BOBRICK B239 X 34
A10	NOT USED
A11	SANITARY NAPKIN DISPOSAL - AMERICAN SPECIALTIES 0852
A12	16" x 31" 2-WALL GRAB BAR, 1 1/2" DIA - BOBRICK B-6861
A13	FOLDING SHOWER SEAT, BOBRICK B-5181
A14	24" GRAB BAR, 1 1/2" DIA - BRADLEY #812
A15	50" GRAB BAR, 1 1/2" DIA - BRADLEY #812

Locker Schedule

L1	PENCO INVINCIBLE II METAL GYM LOCKER, 2 TIER, COLOR: 021 GRAY ASH
L2	PENCO INVINCIBLE II METAL GYM LOCKER, 2 TIER, COLOR: 822 REGAL BLUE
L3	PENCO INVINCIBLE II METAL GYM LOCKER, 2 TIER, COLOR: 806 MARINE BLUE
L4	PENCO INVINCIBLE II METAL GYM LOCKER, HALF HEIGHT, 1 TIER, 36 1/2" H., COLOR: 806 MARINE BLUE
B1	PENCO FIXED BENCH
B2	PENCO ADA FIXED BENCH

Seal:	Consultant:	Client:	 Leon County Schools 3420 W. Tharpe St., Suite 100 Tallahassee, FL 32303	Phase:	DRAWN:	REVIEWED:	DATE:	ID:	REVISION:	DRAWN:	REVIEWED:	DATE:
				CONCEPT SCHEM. DESIGN	BG / RS	C. WHITLOCK	10/6/2024					
				DESIGN DEVELOPMENT	BG/RS/MS	C. WHITLOCK	12/20/2024					
				EARLY DEMOLITION PACKAGE	BG/RS/MS	R. LEWIS	03/21/2025					
				80% CONSTRUCTION DOCS	BG/RS/MS	R. LEWIS						
				PERMIT DOCS	BG/RS/MS	R. LEWIS						
				100% CONSTRUCTION DOCS	BG/RS/MS	R. LEWIS	05/09/2025					
Project #:	23483	Job Title:	Griffin Middle School - Phase 2	THESE DRAWINGS AND RENDERINGS ARE INSTRUMENTS OF SERVICE. THE DRAWINGS AND ASSOCIATED COPIES THEREOF, INCLUDING ELECTRONIC MEDIA AND CAD FILES, ARE THE PROPERTY OF ARCHITECTS LEWIS + WHITLOCK, P.A. THEIR USE, REPRESENTATION OR REPRODUCTION FOR ANY PURPOSE EXCEPT BY WRITTEN AGREEMENT WITH THE ARCHITECT IS PROHIBITED. THIS COPYRIGHT NOTIFICATION SHALL BE TRUE AS DIRECTLY PLACED ON EACH DRAWING EXHIBIT, ON RENDERINGS ON THIS DOCUMENT AND SHALL NOT BE REMOVED FROM THESE DOCUMENTS.								
Phase:	100% CDs		800 Alabama St. Tallahassee, FL 32304									




Architects Lewis + Whitlock
206 West Virginia St.
Tallahassee, Florida 32301
850.942.1718
www.think3d.net


Description:
Enlarged Plans

Sheet No.:


A4.2

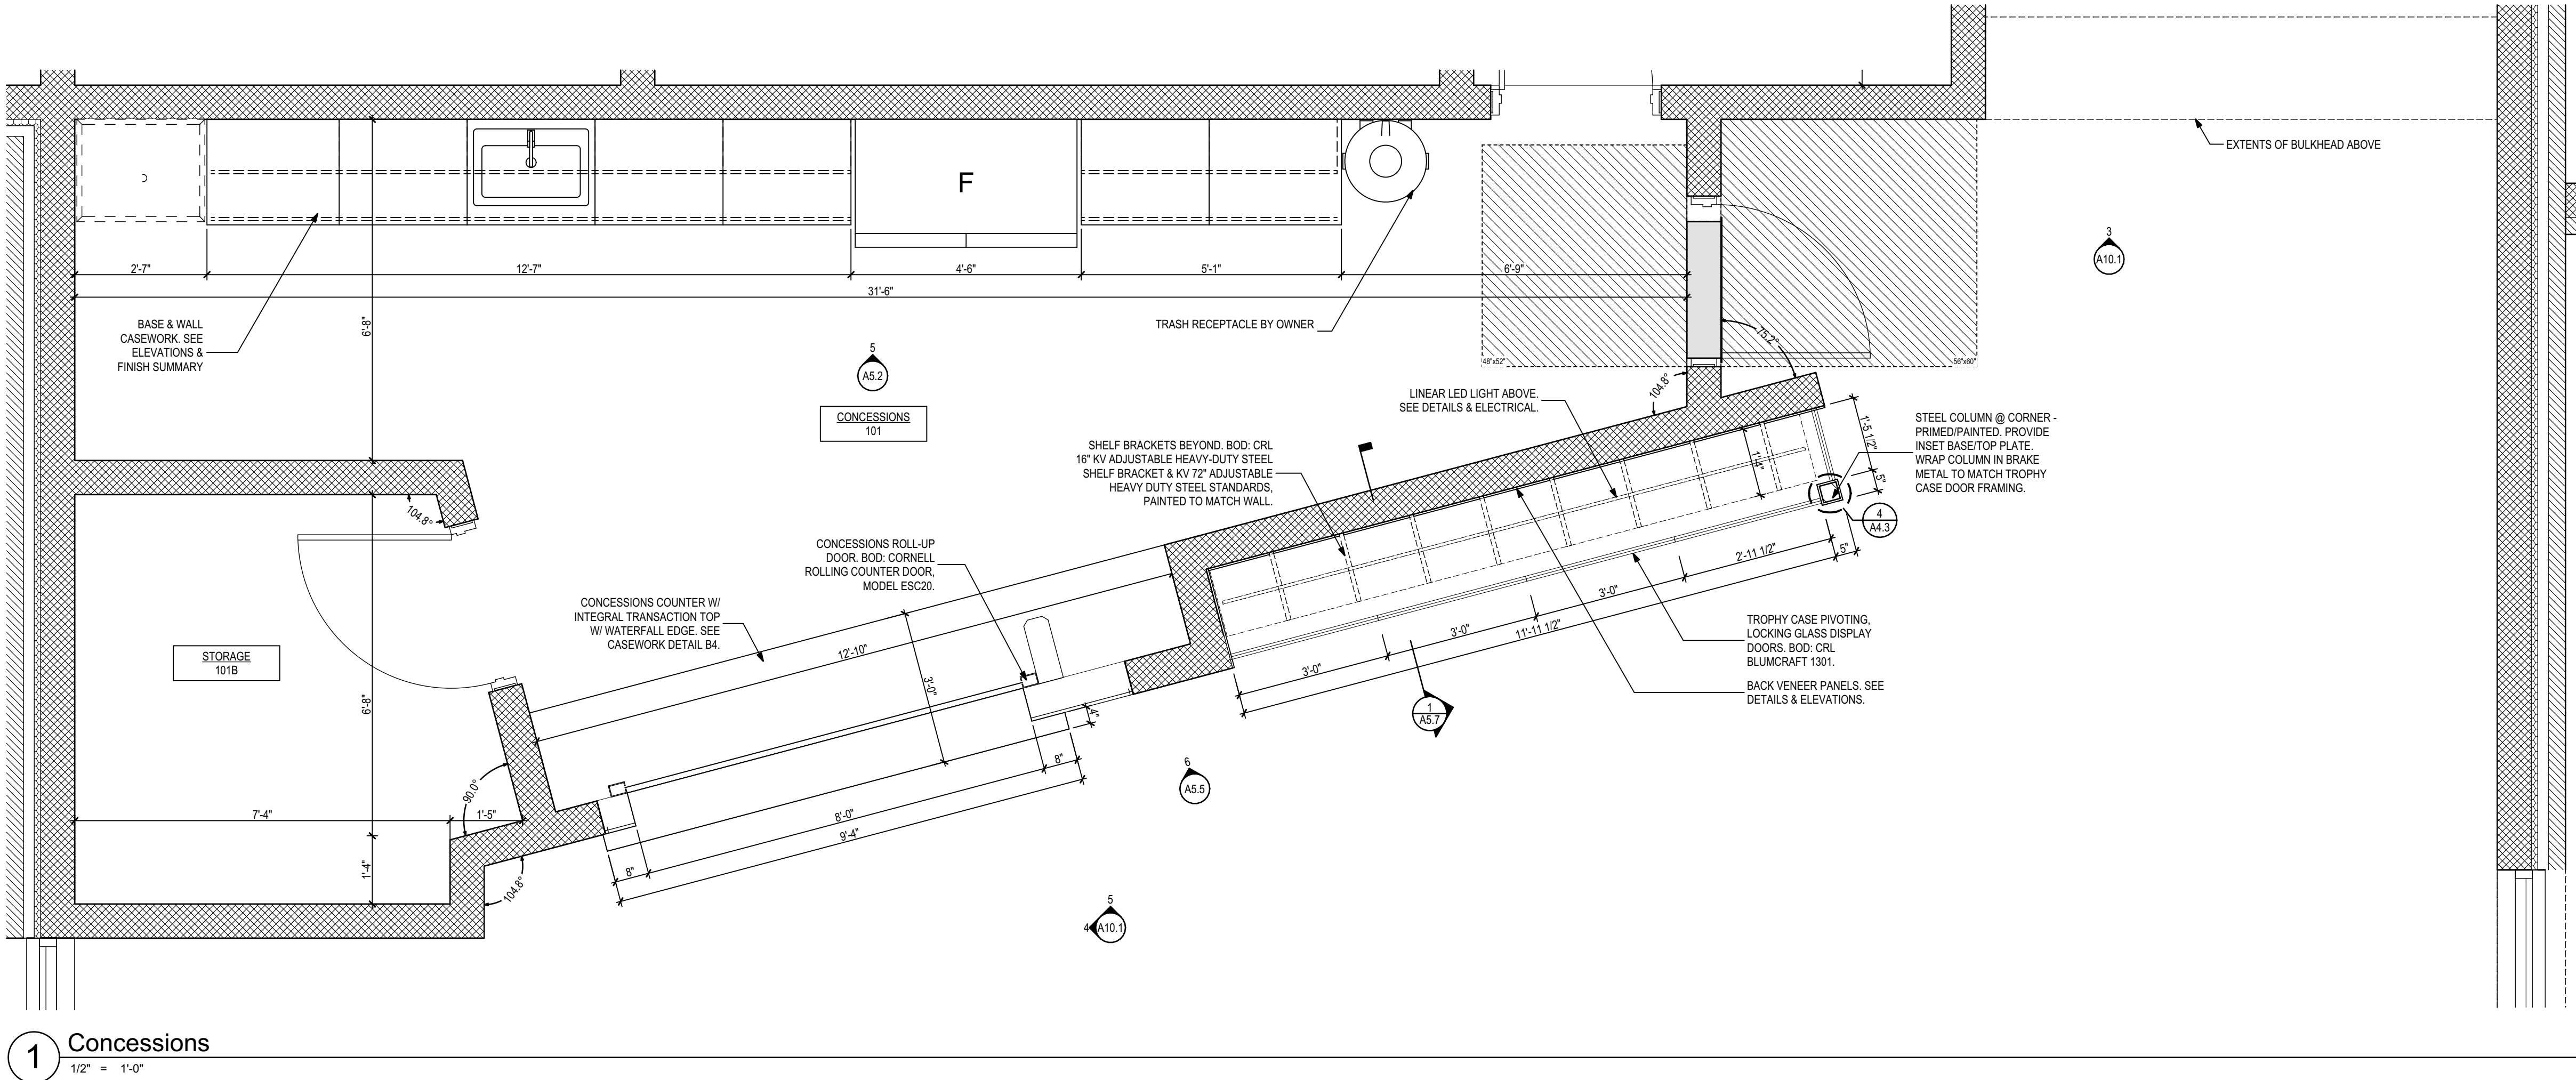


3 Training & First Aid Rooms
1/2" = 1'-0"

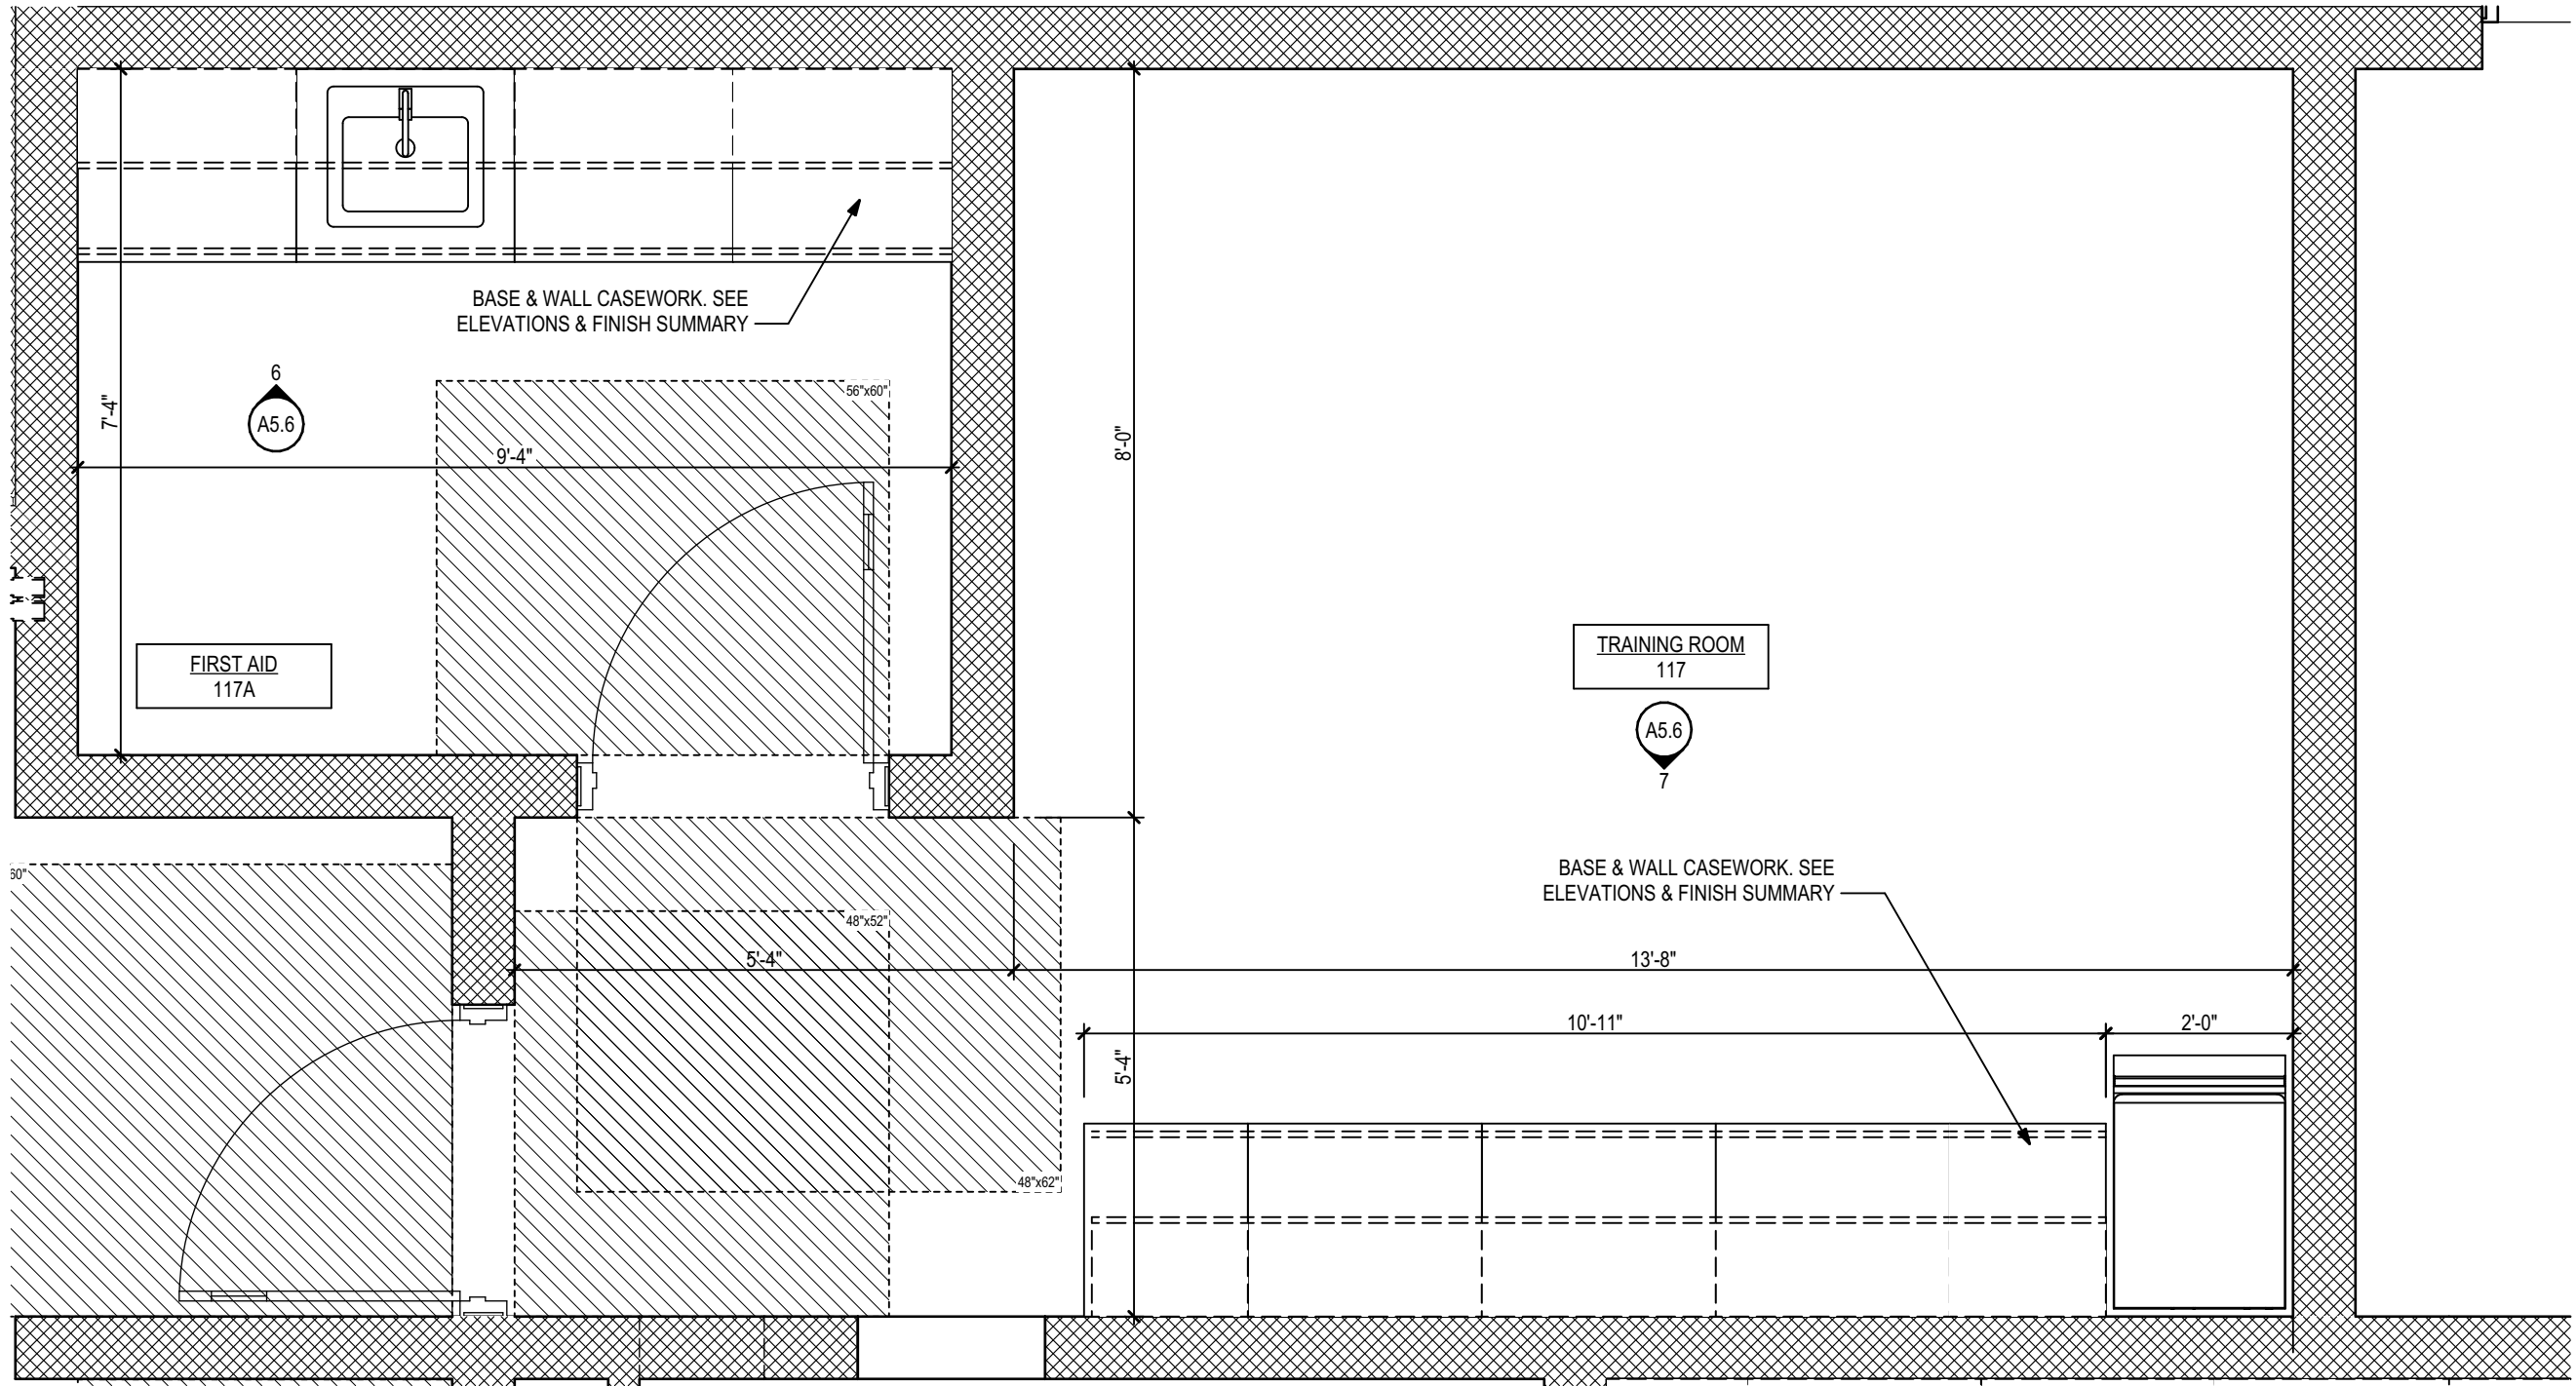

2 Enlarged Plan Band Trophy Case
1/2" = 1'-0"

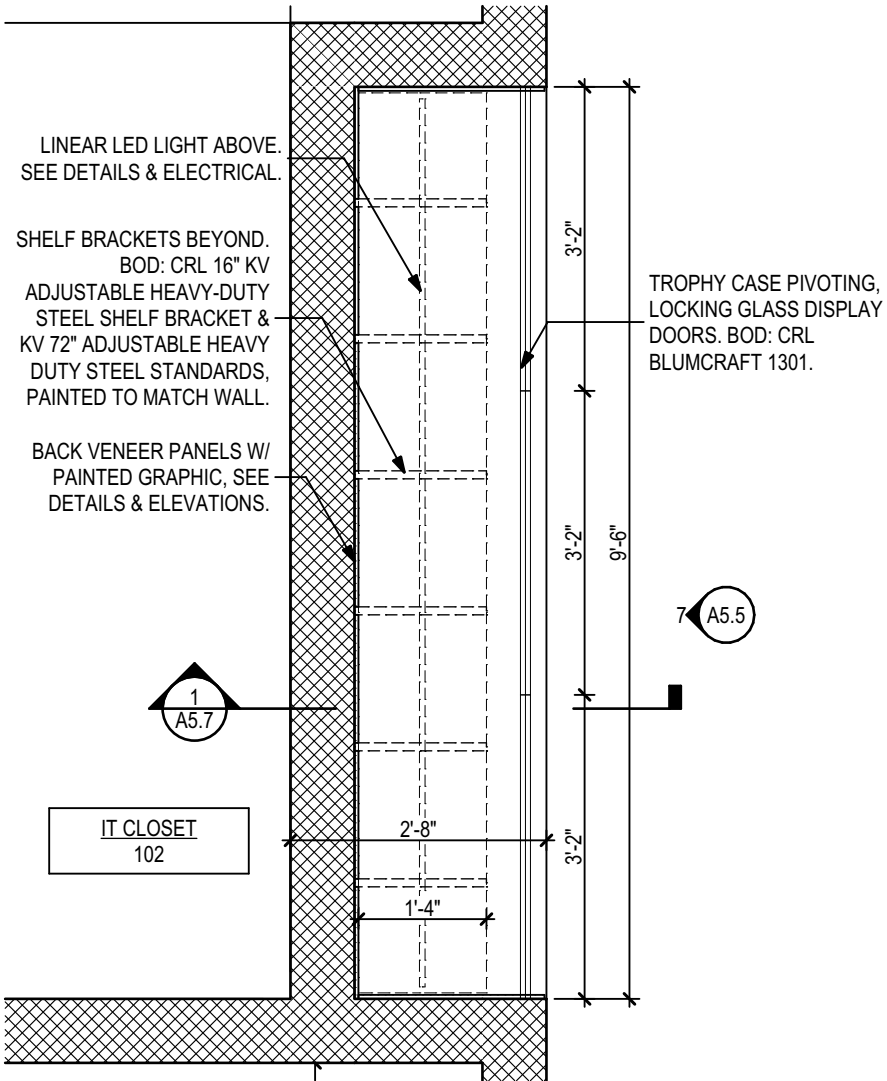

4 Column @ Trophy Case Plan Detail
3" = 1'-0"

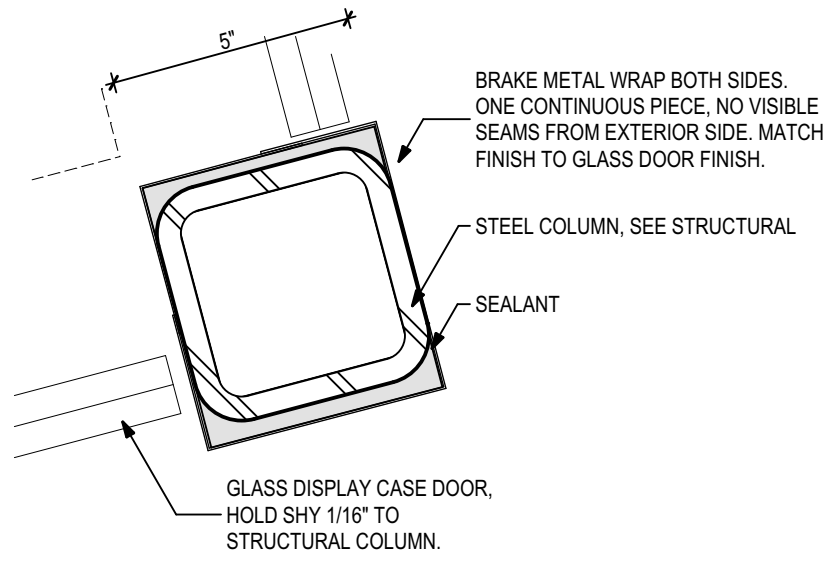

PHASE:	DRAWN:	REVIEWED:	DATE:	ID:	REVISION:	DRAWN:	REVIEWED:	DATE:
CONCEPT SCHEM. DESIGN	BG / RS	C. WHITLOCK	10/8/2024					
DESIGN DEVELOPMENT	BG/RS/MS	C. WHITLOCK	12/20/2024					
EARLY DEMOLITION PACKAGE								
80% CONSTRUCTION DOCS	BG/RS/MS	R. LEWIS	03/21/2025					
PERMIT DOCS								
100% CONSTRUCTION DOCS	BG/RS/MS	R. LEWIS	06/09/2025					

Seal:

Client:
Leon County Schools
3420 W. Tharpe St., Suite 100
Tallahassee, FL 32303

Consultant:
23483
100% CDs


Job Title:
Griffin Middle School - Phase 2
800 Alabama St. Tallahassee, FL 32304

Architects Lewis + Whitlock
206 West Virginia St.
Tallahassee, Florida 32301
850.942.1718
www.think3d.net


Description:
Enlarged Plans

Sheet No.:
A4.3


THESE TRAININGS AND RENDERINGS ARE INSTRUMENTS OF SERVICE. THE DRAWINGS AND ASSOCIATED COPIES THEREOF, INCLUDING ELECTRONIC MEDIA AND CAD FILES, ARE THE PROPERTY OF ARCHITECTS LEWIS + WHITLOCK, P.A.A. THEIR USE, REPRESENTATION OR REPRODUCTION FOR ANY PURPOSE EXCEPT BY WRITTEN AGREEMENT WITH THE ARCHITECT IS PROHIBITED. THIS COPYRIGHT NOTIFICATION SHALL BE TRUE AS F DIRECTLY PLACED ON EACH DRAWING EXHIBIT, OVERLAPPING ON THE DOCUMENT AND SHALL NOT BE REMOVED FROM THESE DOCUMENTS.

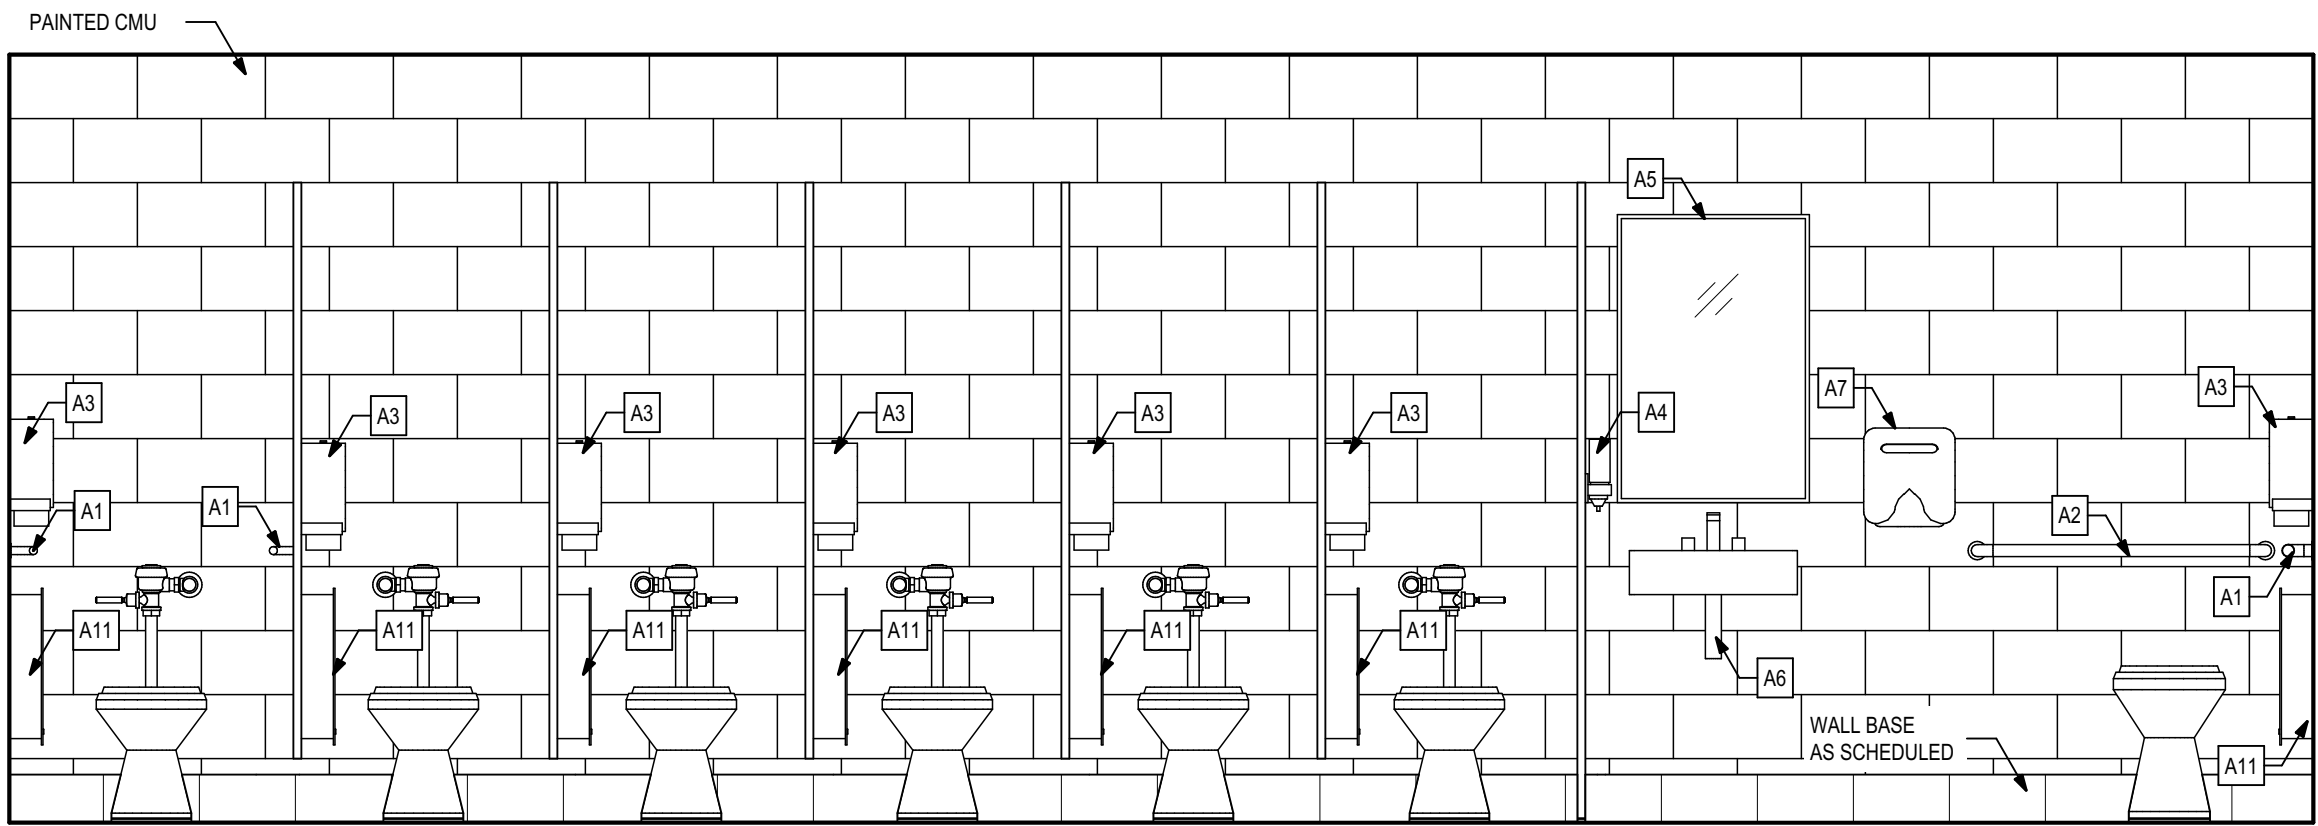


3 Female Public Restroom Interior Elevation
1/2" = 1'-0"

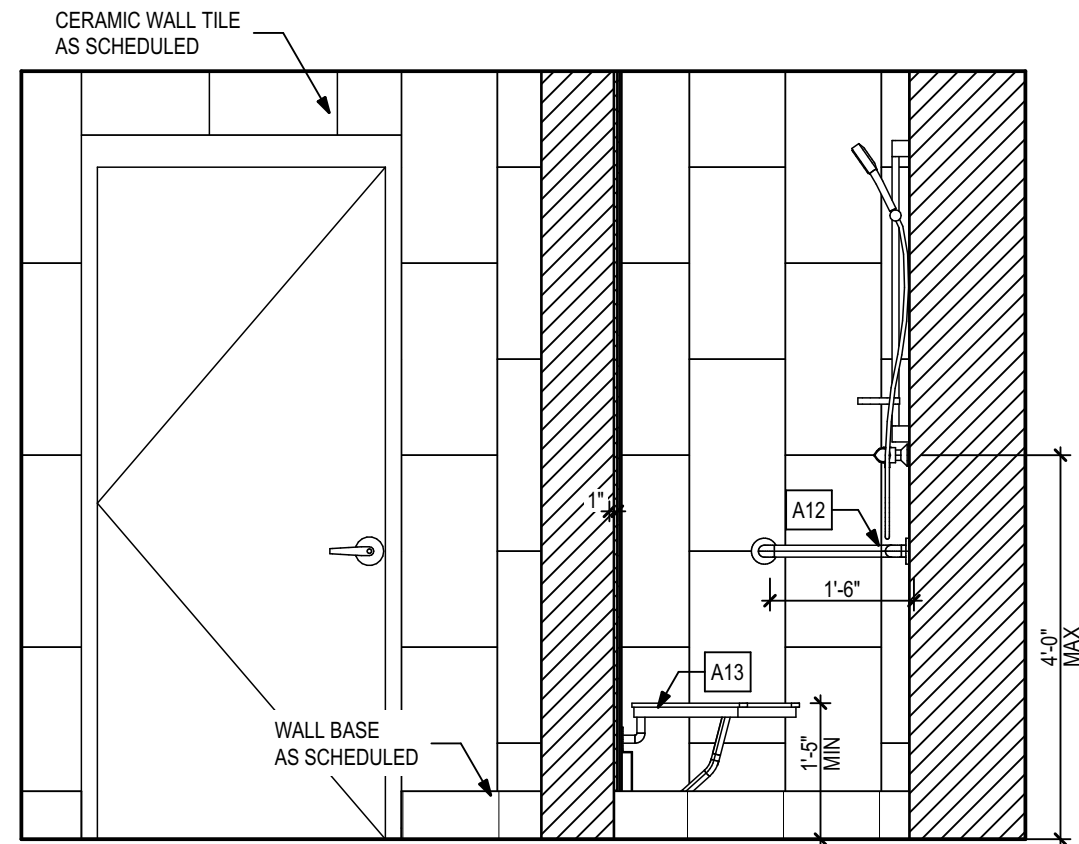


8 Shower - Female Interior Elevation
1/2" = 1'-0"

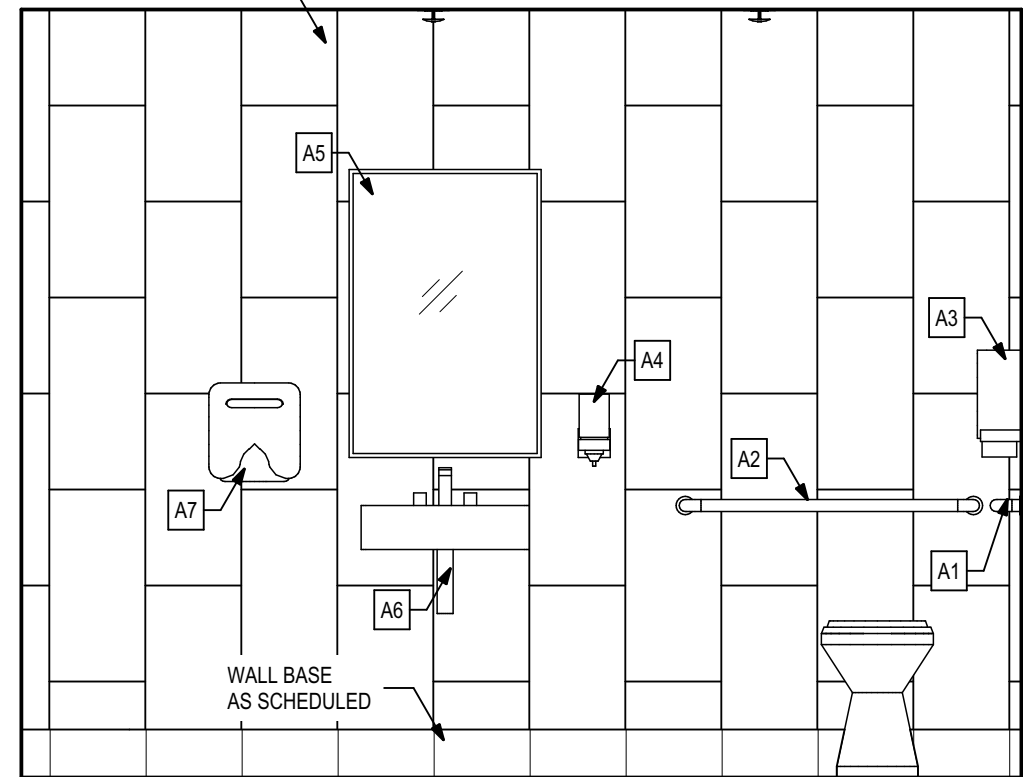


12 Shower - Male Interior Elevation
1/2" = 1'-0"

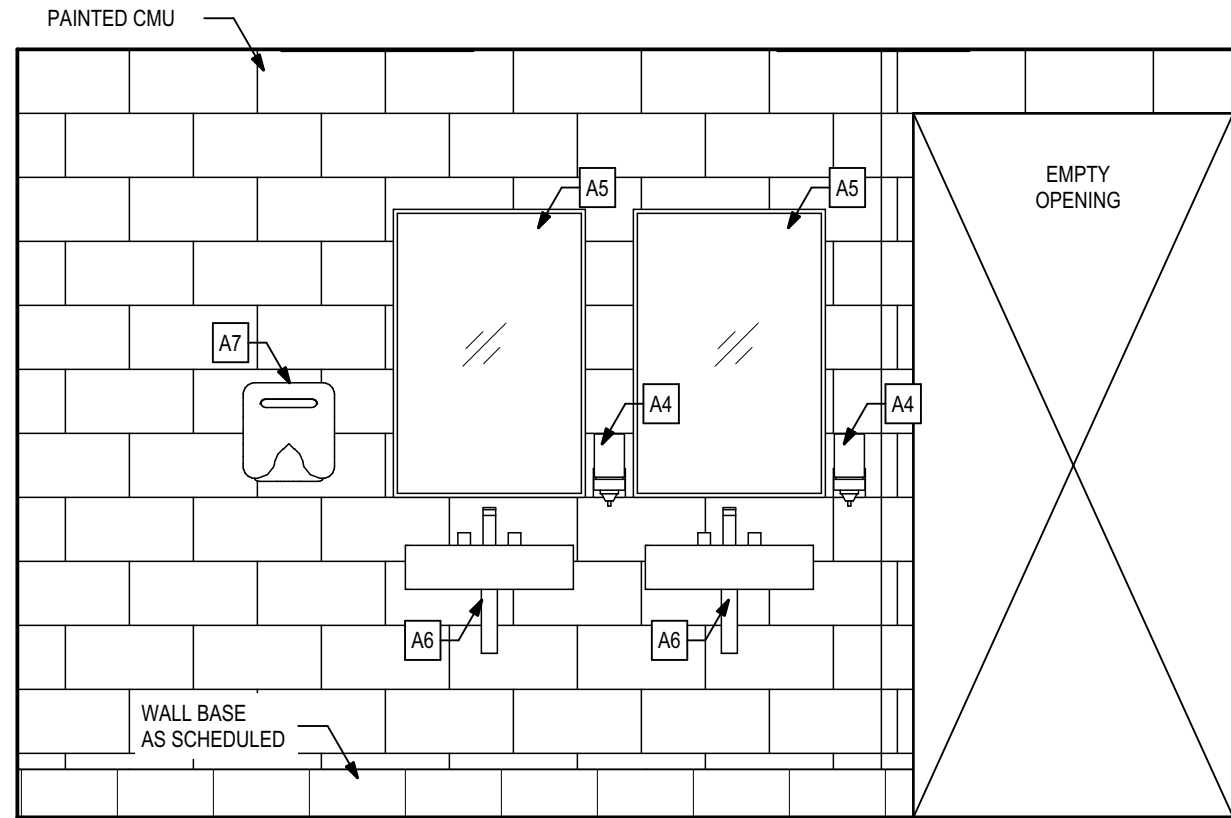


16 P.E. Restroom - Male Interior Elevation
1/2" = 1'-0"

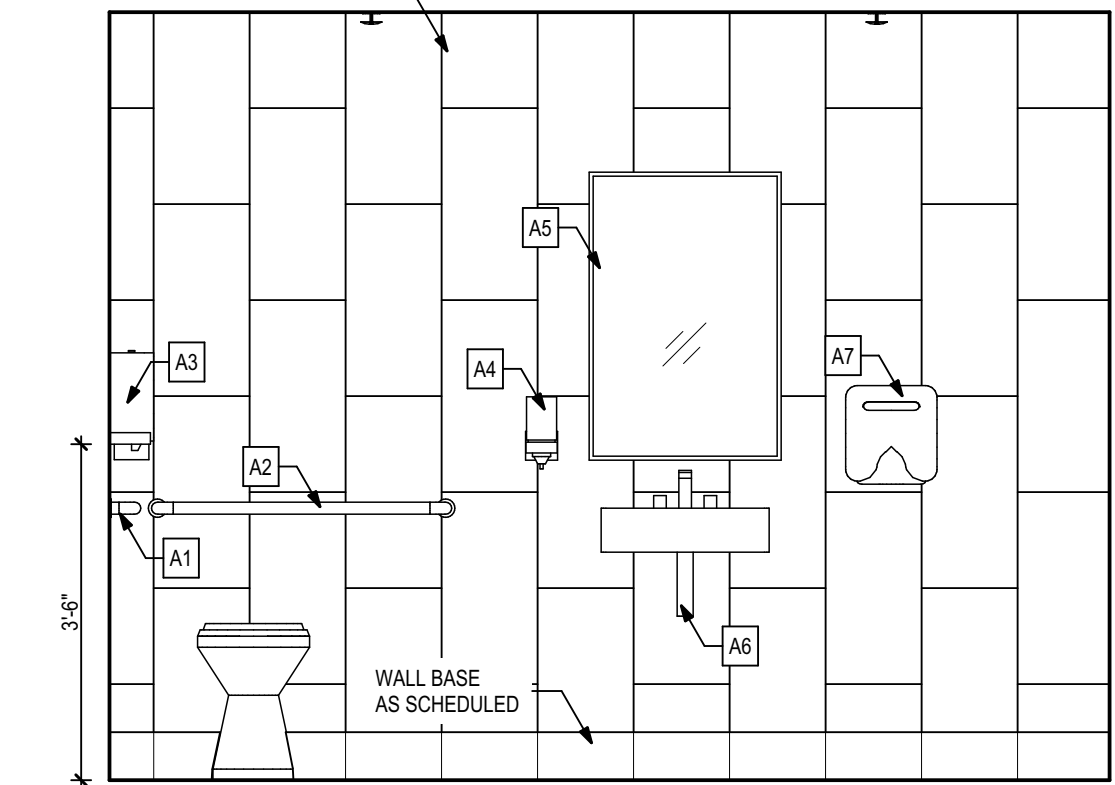


7 Shower - Female Interior Elevation
1/2" = 1'-0"

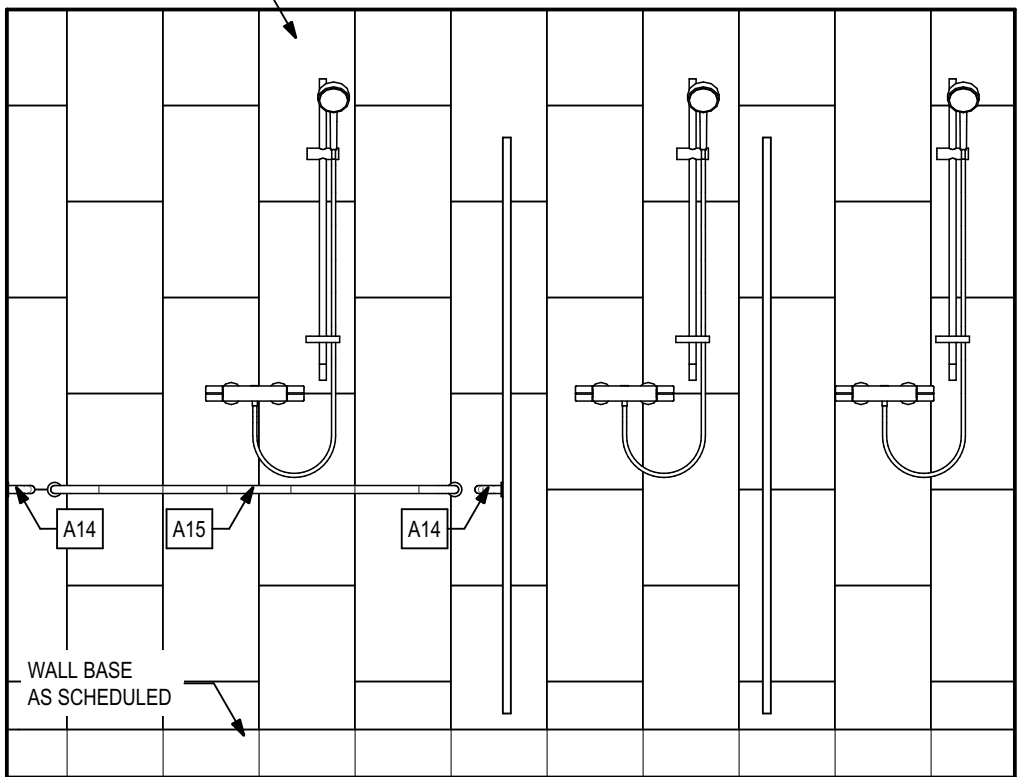


11 P.E. Shower - Female Interior Elevation
1/2" = 1'-0"

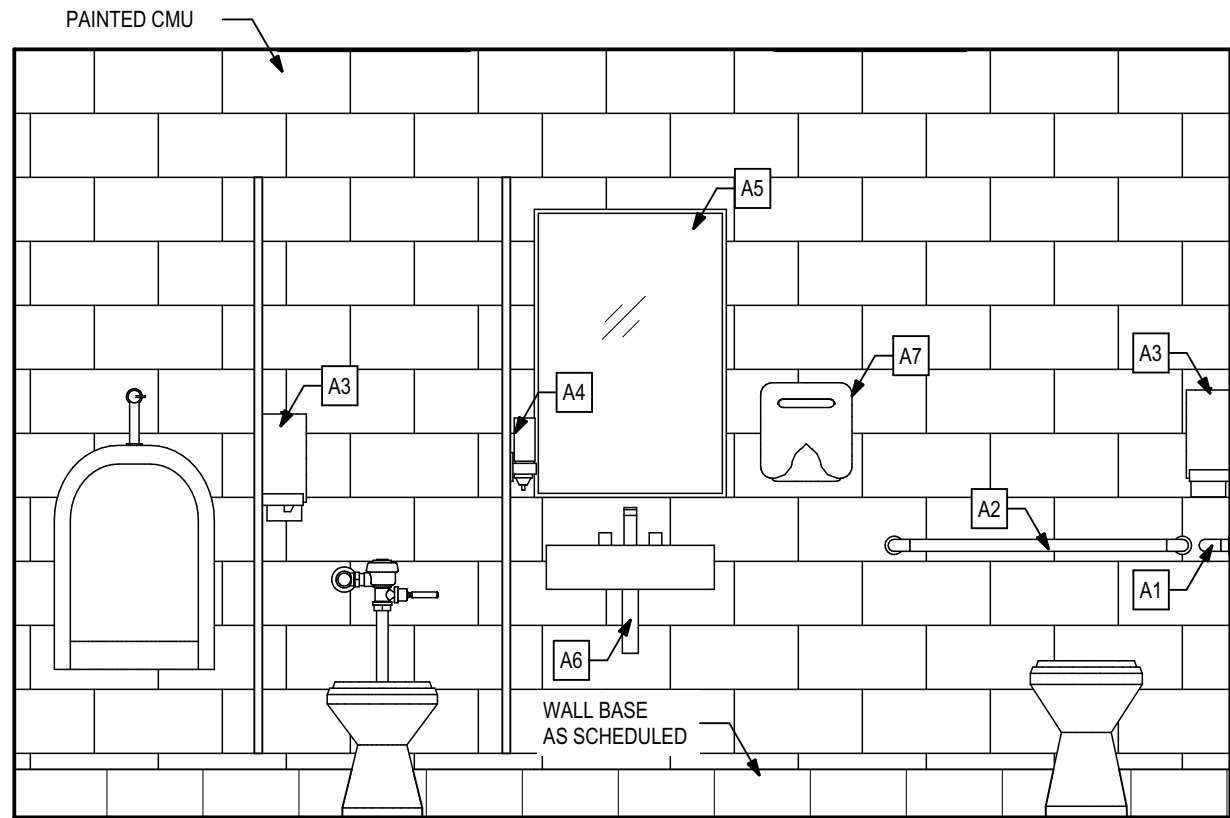


15 P.E. Restroom - Male Interior Elevation
1/2" = 1'-0"

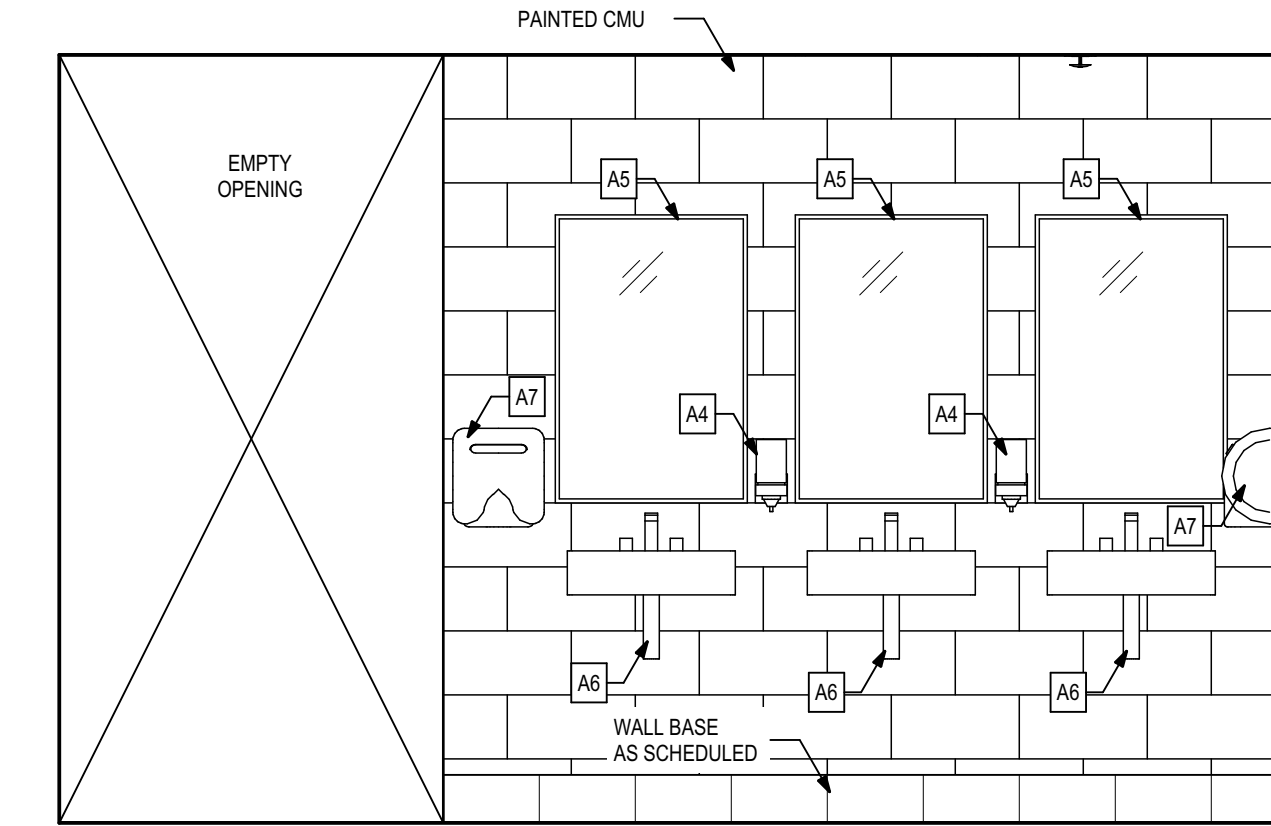


2 Male Public Restroom Interior Elevation
1/2" = 1'-0"

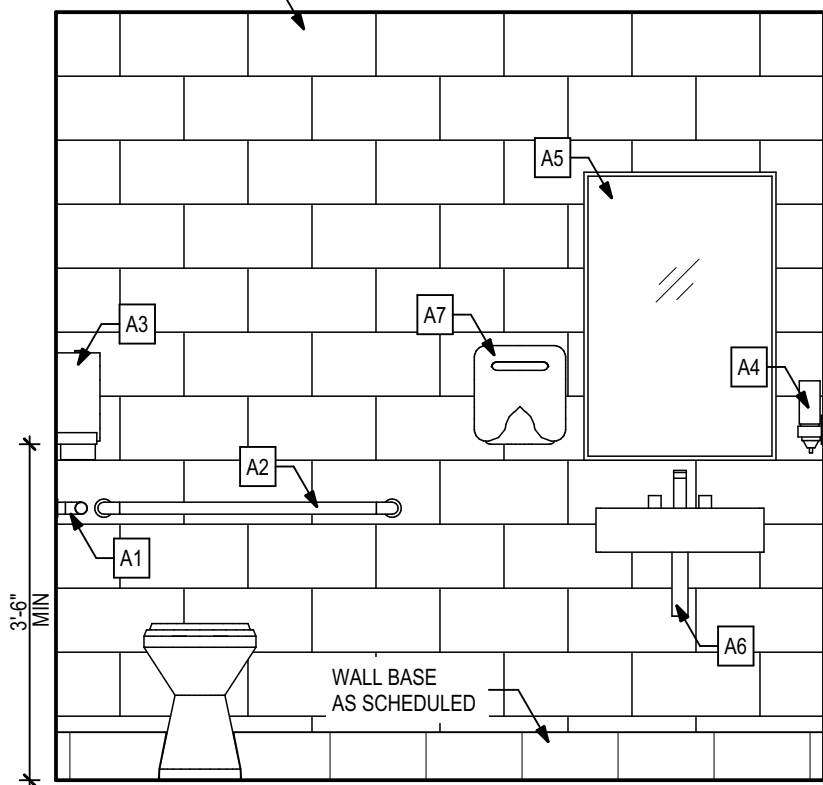


6 Family Restroom Interior Elevation
1/2" = 1'-0"

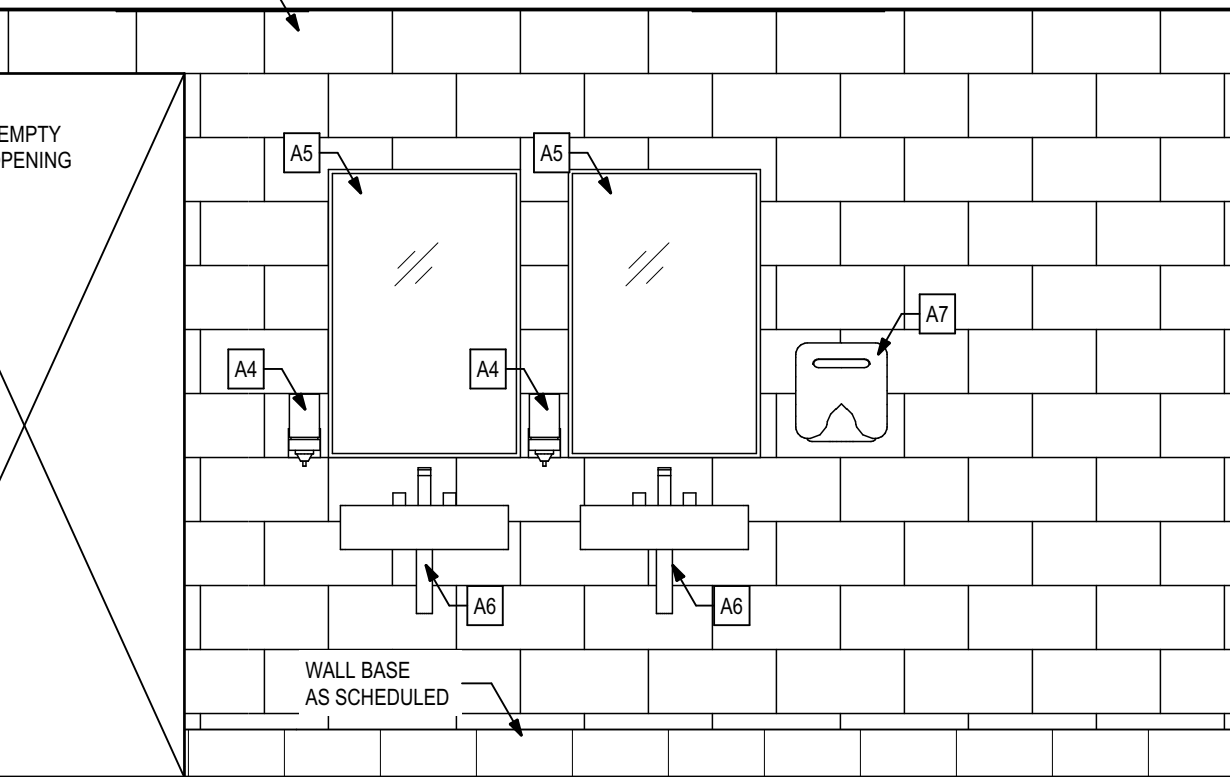


10 P.E. Restroom - Female Interior Elevation
1/2" = 1'-0"

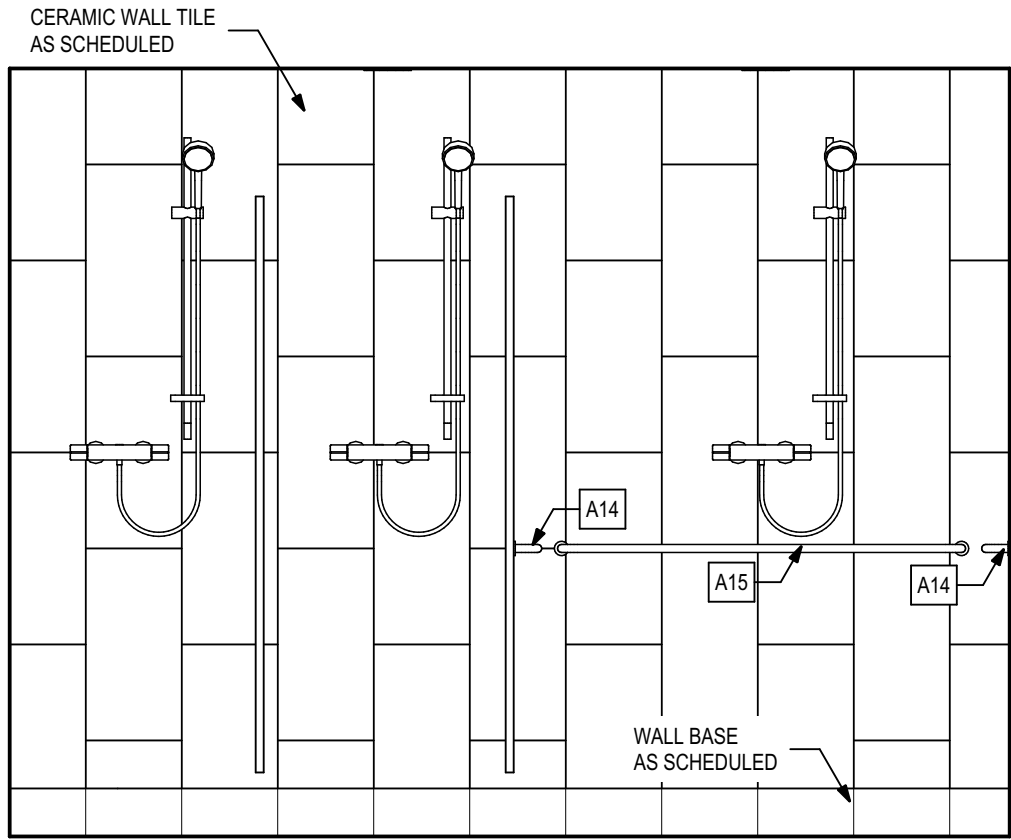


14 P.E. Shower - Male Interior Elevation
1/2" = 1'-0"

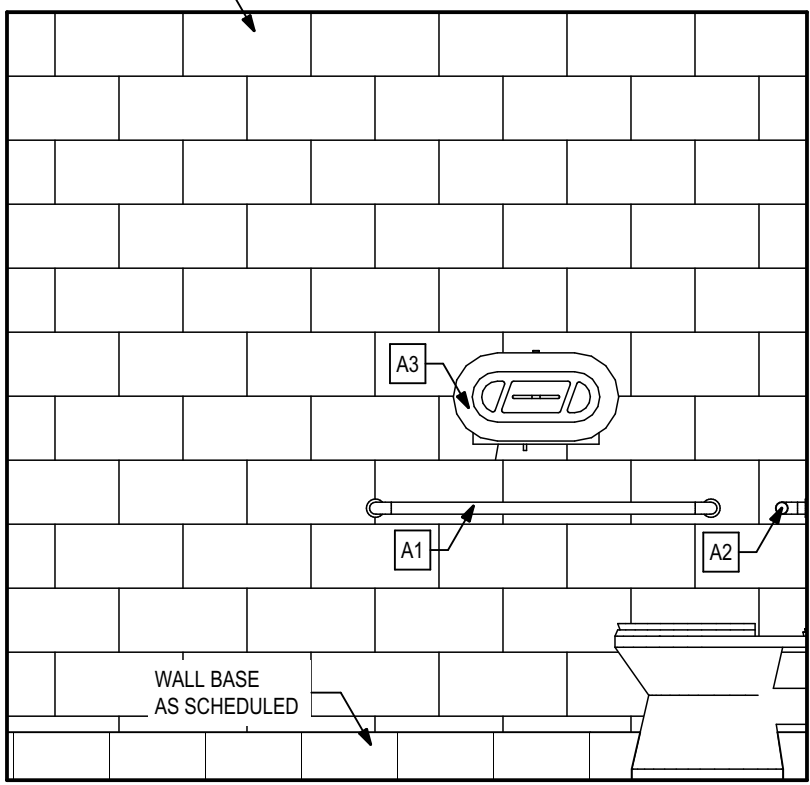


5 Family Restroom Interior Elevation
1/2" = 1'-0"

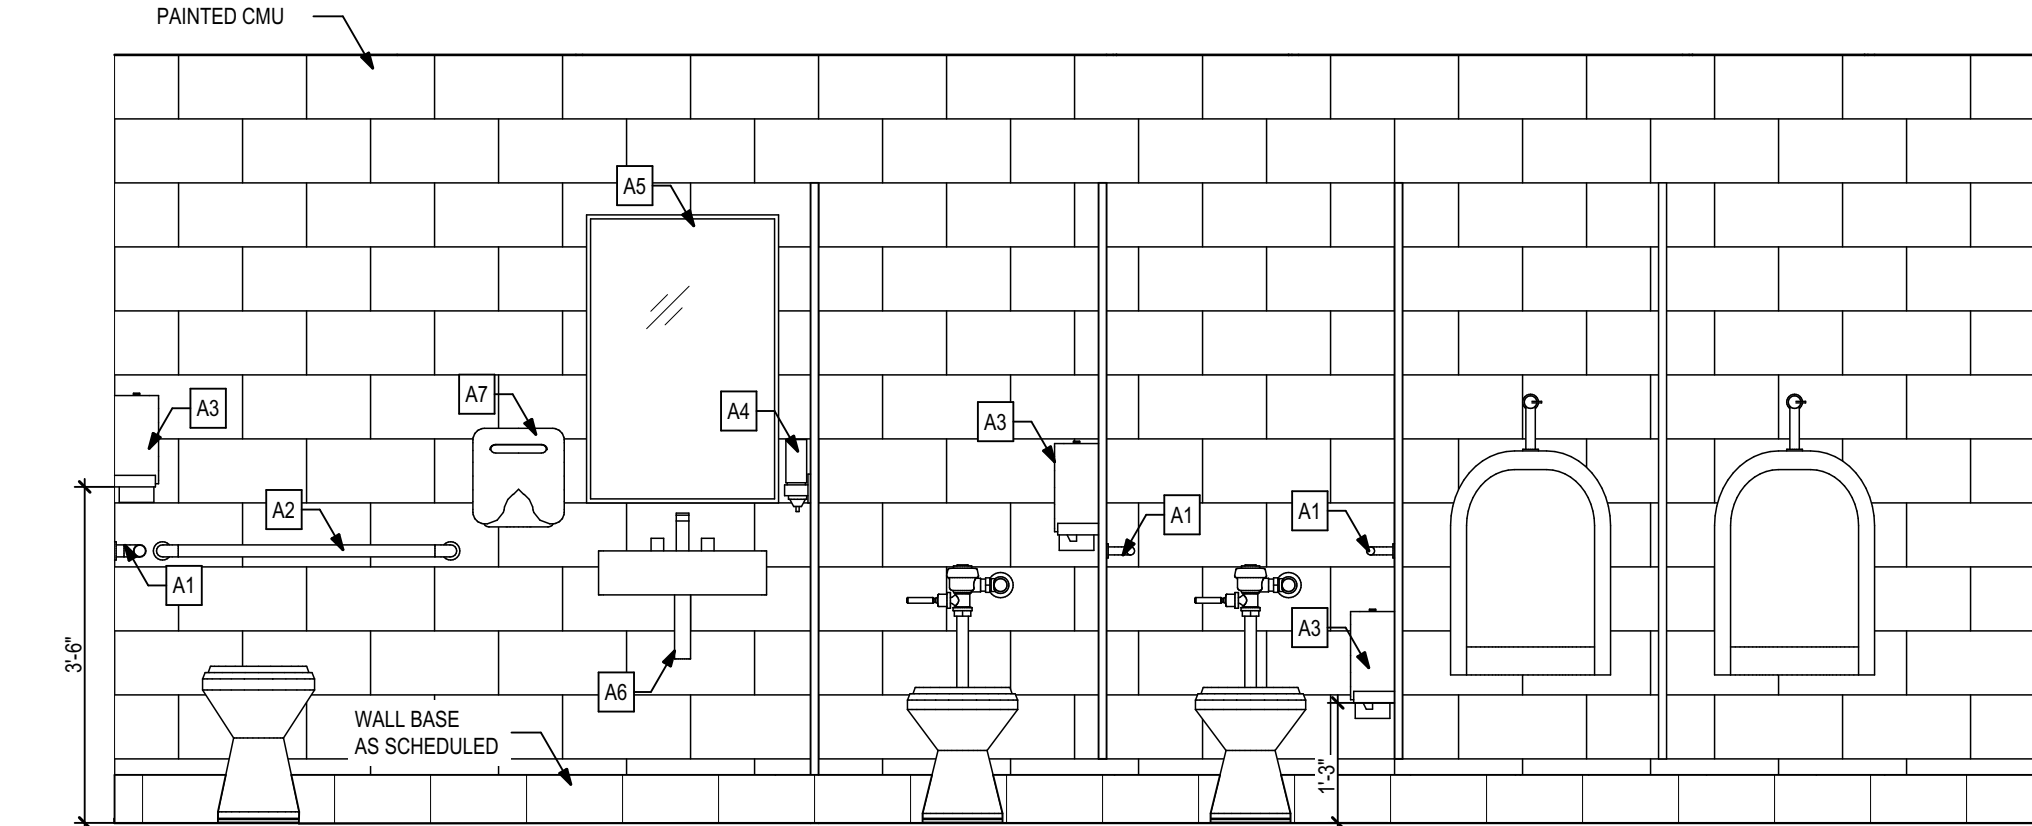


1 Male Public Restroom Interior Elevation
1/2" = 1'-0"

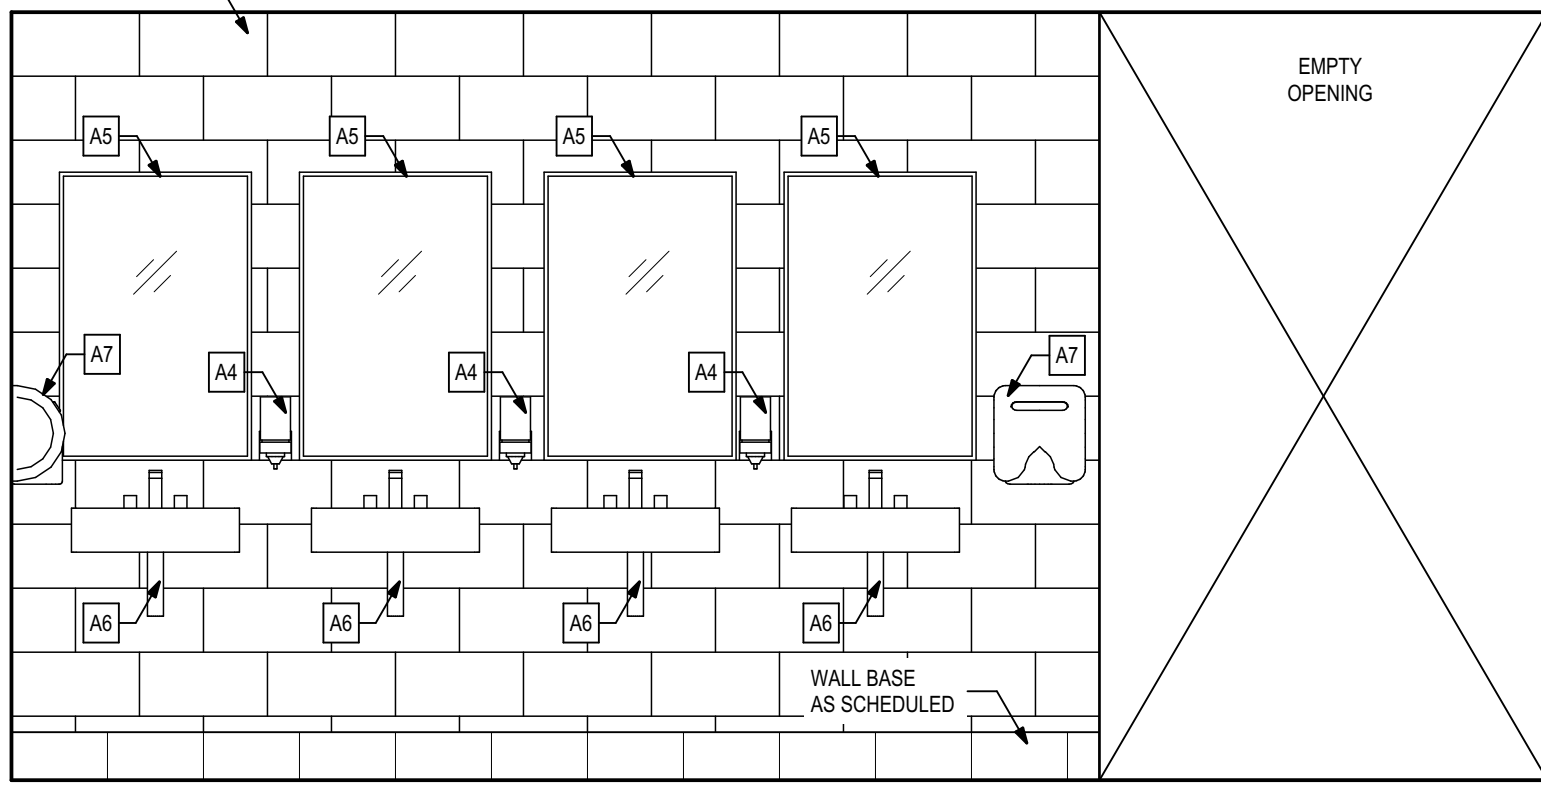

4 Female Public Restroom Interior Elevation
1/2" = 1'-0"

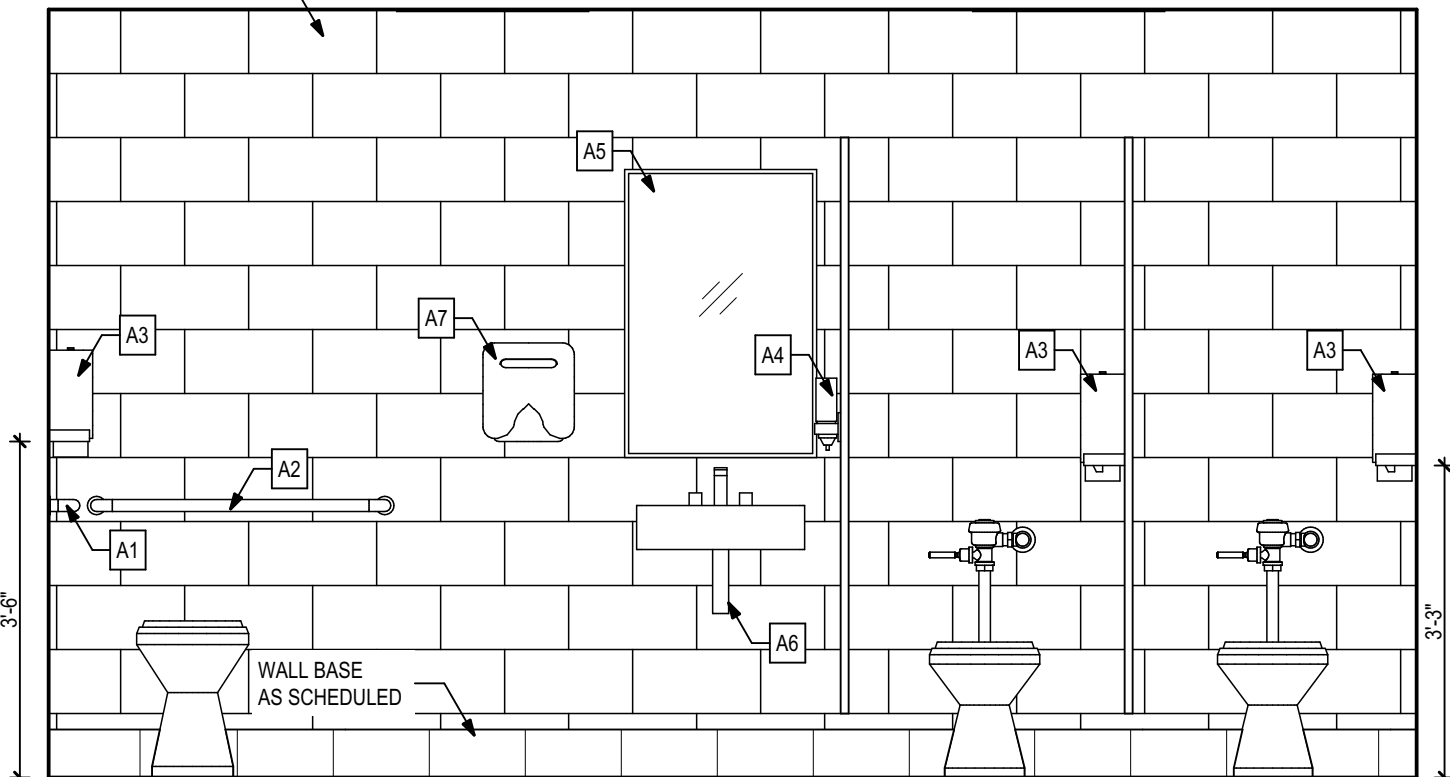

9 P.E. Restroom - Female Interior Elevation
1/2" = 1'-0"

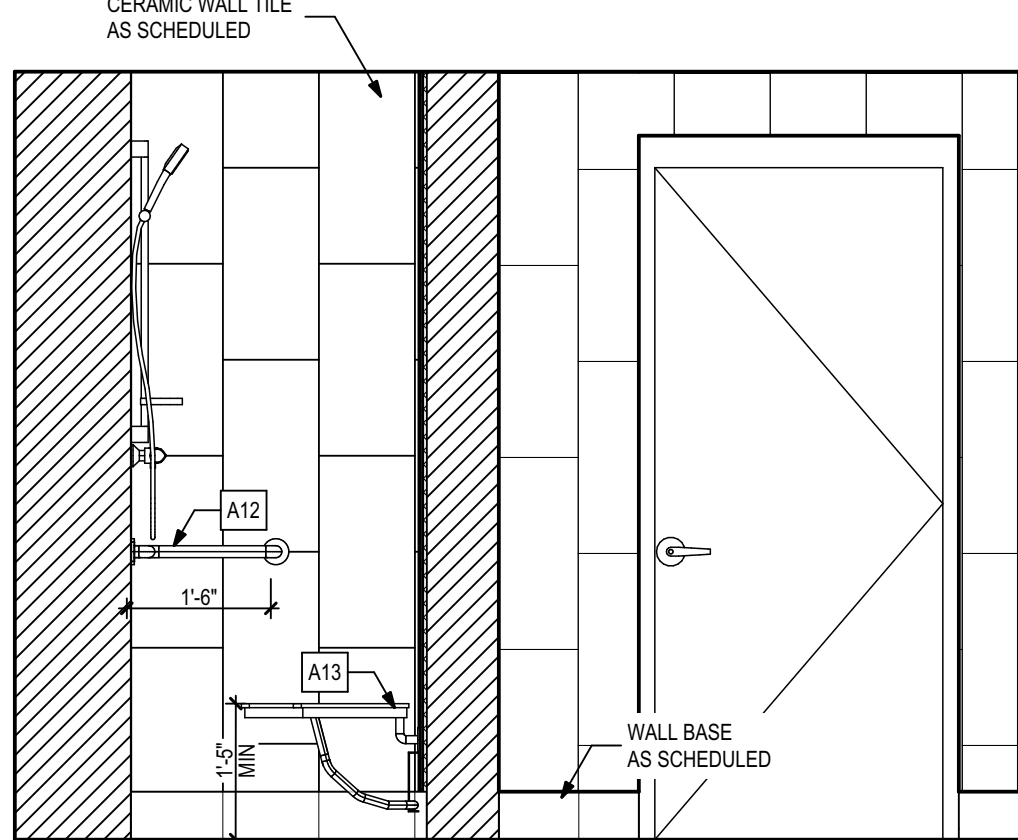

13 Shower - Male Interior Elevation
1/2" = 1'-0"

Accessory Schedule

A1	42" GRAB BAR, 1 1/2" DIA - BRADLEY #812
A2	36" GRAB BAR, 1 1/2" DIA - BRADLEY #812
A3	TOILET TISSUE DISPENSER - PROVIDED BY OWNER
A4	SOAP DISPENSER - PROVIDED BY OWNER
A5	36"h x 20"w MIRROR, FRAMELESS - SEE SPECIFICATIONS
A6	INSULATED UNDER SINK PROTECTIONS - MAINLINE ML102EZ LAV GUARD 2, ONE P-TRAP COVER, TWO ANGLE VALVES AND SUPPLY COVERS
A7	AUTOMATIC HAND DRYER - EXCEL XLERATOR XL-BW, SEE ELECTRICAL
A8	CLOTHES HOOK - BRADLEY 9114
A8a	CLOTHES HOOK - BRADLEY 9114 (ADA HEIGHT MOUNTED)
A9	MOP HOLDER - BOBRICK B239 X 34
A10	NOT USED
A11	SANITARY NAPKIN DISPOSAL - AMERICAN SPECIALTIES 0852
A12	16" x 31" 2-WALL GRAB BAR, 1 1/2" DIA - BOBRICK B-6861
A13	FOLDING SHOWER SEAT, BOBRICK B-5181
A14	24" GRAB BAR, 1 1/2" DIA - BRADLEY #812
...	7" GRAB BAR, 1 1/2" DIA - BRADLEY #812

NOTE:
PLUMBING AND ELECTRICAL FIXTURES ARE SHOWN FOR CLARITY. FINAL LOCATIONS WILL BE DETERMINED BY THE MECHANICAL / ELECTRICAL ENGINEER AND SHOWN ON THEIR RESPECTIVE DRAWINGS

PHASE:	CONCEPT SCHEM. DESIGN	DESIGN DEVELOPMENT	EARLY CONSTRUCTION DOCS	PERMIT DOCS	100% CONSTRUCTION DOCS	DRAWN:	DATE:	REVIEWED:	DATE:	REVISION:	ID:	DATE:	REVIEWED:	DATE:
	BG/RS	C. WHITLOCK	BG/RS	C. WHITLOCK	BG/RS	C. WHITLOCK	10/8/2024							
	BG/RS	C. WHITLOCK	BG/RS	C. WHITLOCK	BG/RS	C. WHITLOCK	12/20/2024							
	BG/RS	C. WHITLOCK	BG/RS	C. WHITLOCK	BG/RS	C. WHITLOCK	03/21/2025							
	BG/RS	C. WHITLOCK	BG/RS	C. WHITLOCK	BG/RS	C. WHITLOCK	05/09/2025							

Client: Leon County Schools
3420 W. Tharpe St., Suite 100
Tallahassee, FL 32303

Job Title: Griffin Middle School - Phase 2
800 Alabama St. Tallahassee, FL 32304

Consultant: 23483
Project #: 100% CDs

Seal:


ALW

Architects Lewis + Whitlock
206 West Virginia St.
Tallahassee, Florida 32301
850.942.1718
www.think3d.net

Description:
Interior Elevations

Sheet No.:
A5.1

2 Gymnasium Interior Elevation
1/4" = 1'-0"

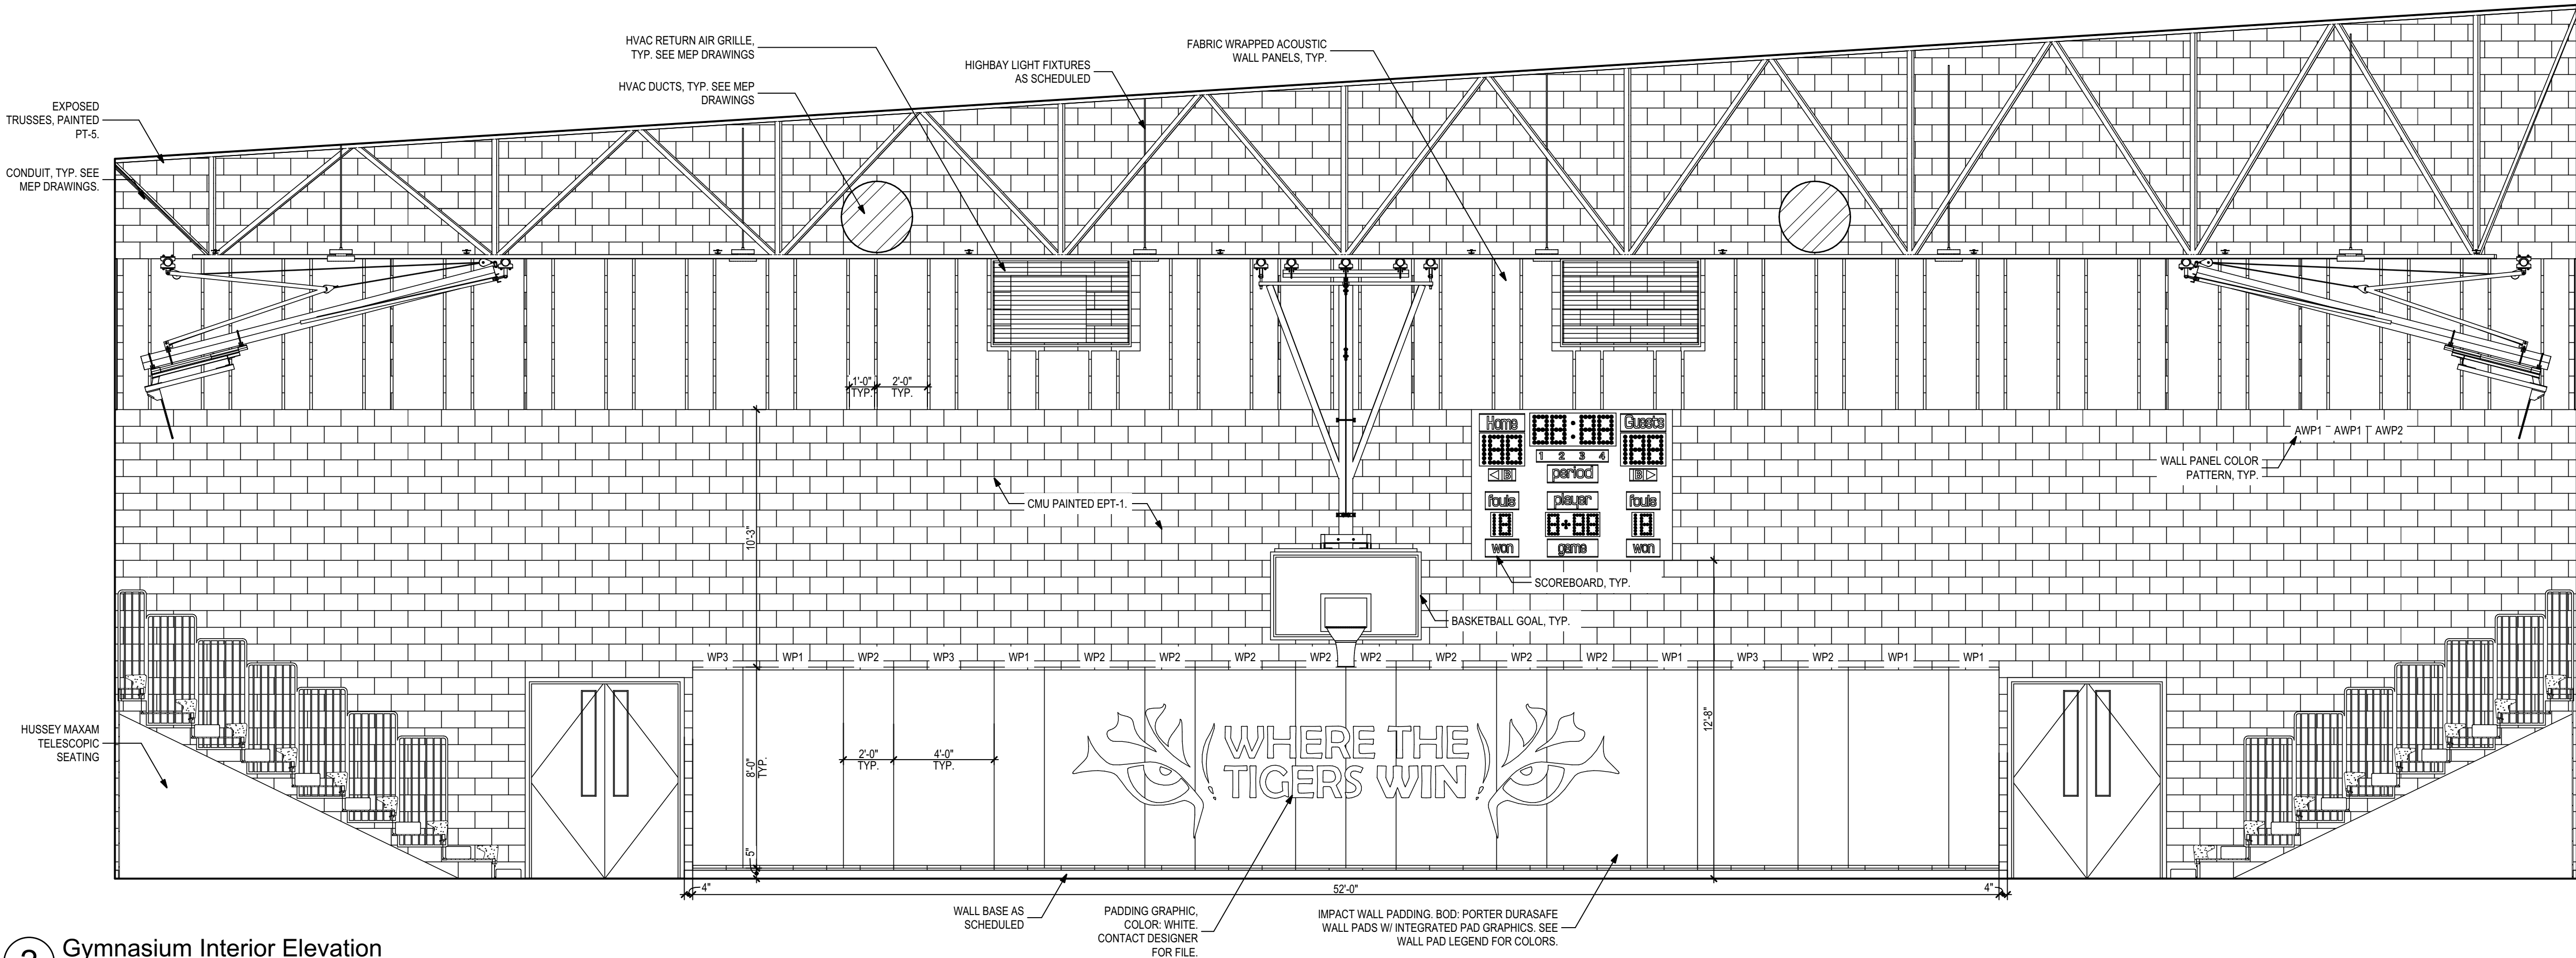


Wall Pad Schedule

WP1	PORTER VINYL, COLOR: NAVY BLUE
WP2	PORTER VINYL, COLOR: ROYAL BLUE
WP3	PORTER VINYL, COLOR: LIGHT BLUE

Acoustic Wall Panel Schedule

AWP1	GUILFORD OF MAINE, METALLATION, COLOR: STAINLESS
AWP2	GUILFORD OF MAINE, METALLATION, COLOR: POLISHED PEWTER
AWP3	GUILFORD OF MAINE, METALLATION, COLOR: FIRED TITANIUM

1 Gymnasium Interior Elevation
1/4" = 1'-0"

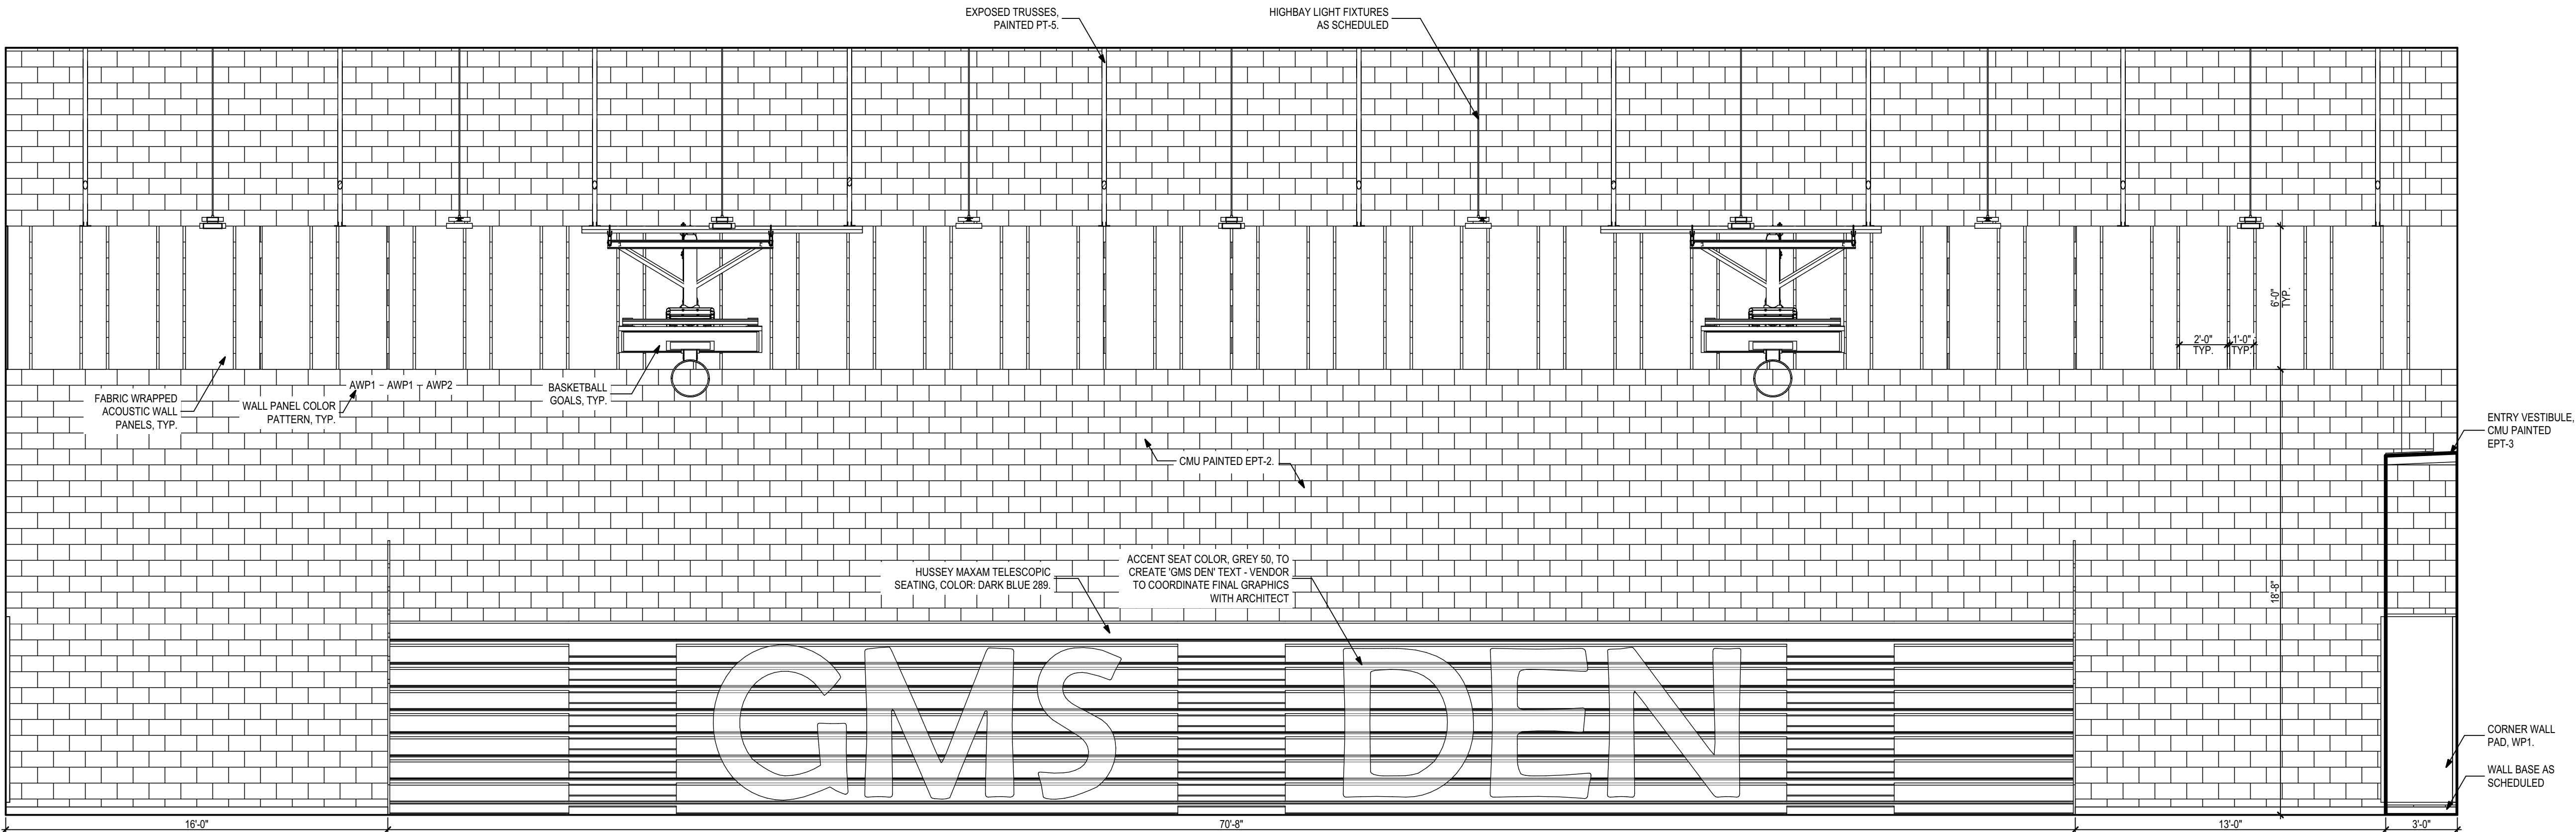

PHASE:	DRAWN:	REVIEWED:	DATE:	ID:	REVISION:	DRAWN:	REVIEWED:	DATE:
CONCEPT SCHEM. DESIGN	BG / RS	C. WHITLOCK	10/8/2024					
DESIGN DEVELOPMENT	BG/RS/MS	C. WHITLOCK	12/20/2024					
EARLY DEMOLITION PACKAGE	BG/RS/MS	C. WHITLOCK	12/20/2024					
80% CONSTRUCTION DOCS	BG/RS/MS	R. LEWIS	03/27/2025					
PERMIT DOCS	BG/RS/MS	R. LEWIS	05/09/2025					
100% CONSTRUCTION DOCS	BG/RS/MS	R. LEWIS	05/09/2025					

THESE DRAWINGS AND RENDERINGS ARE INSTRUMENTS OF SERVICE. THE DRAWINGS AND ASSOCIATED COPIES THEREOF, INCLUDING ELECTRONIC MEDIA AND CAD FILES, ARE THE PROPERTY OF ARCHITECTS LEWIS + WHITLOCK P.A.A. THEIR USE, REPRESENTATION OR REPRODUCTION FOR ANY PURPOSE EXCEPT BY WRITTEN AGREEMENT WITH THE ARCHITECT IS PROHIBITED. THIS COPYRIGHT NOTIFICATION SHALL BE TRUE AS F DIRECTLY PLACED ON EACH DRAWING EXHIBIT. CONVEYING ON THIS DOCUMENT AND SHALL NOT BE REMOVED FROM THESE DOCUMENTS

Client: Leon County Schools
3420 W. Tharpe St., Suite 100
Tallahassee, FL 32303

Job Title: Griffin Middle School - Phase 2
800 Alabama St. Tallahassee, FL 32304

Consultant: 23483
Project #: 23483
Phase: 100% CDs

Seal:

ALW

Architects Lewis + Whitlock
206 West Virginia St.
Tallahassee, Florida 32301
850.942.1718
www.think3d.net


Description:
Interior Elevations

Sheet No.:

A5.3

2 Gymnasium Interior Elevation

1/4" = 1'-0"

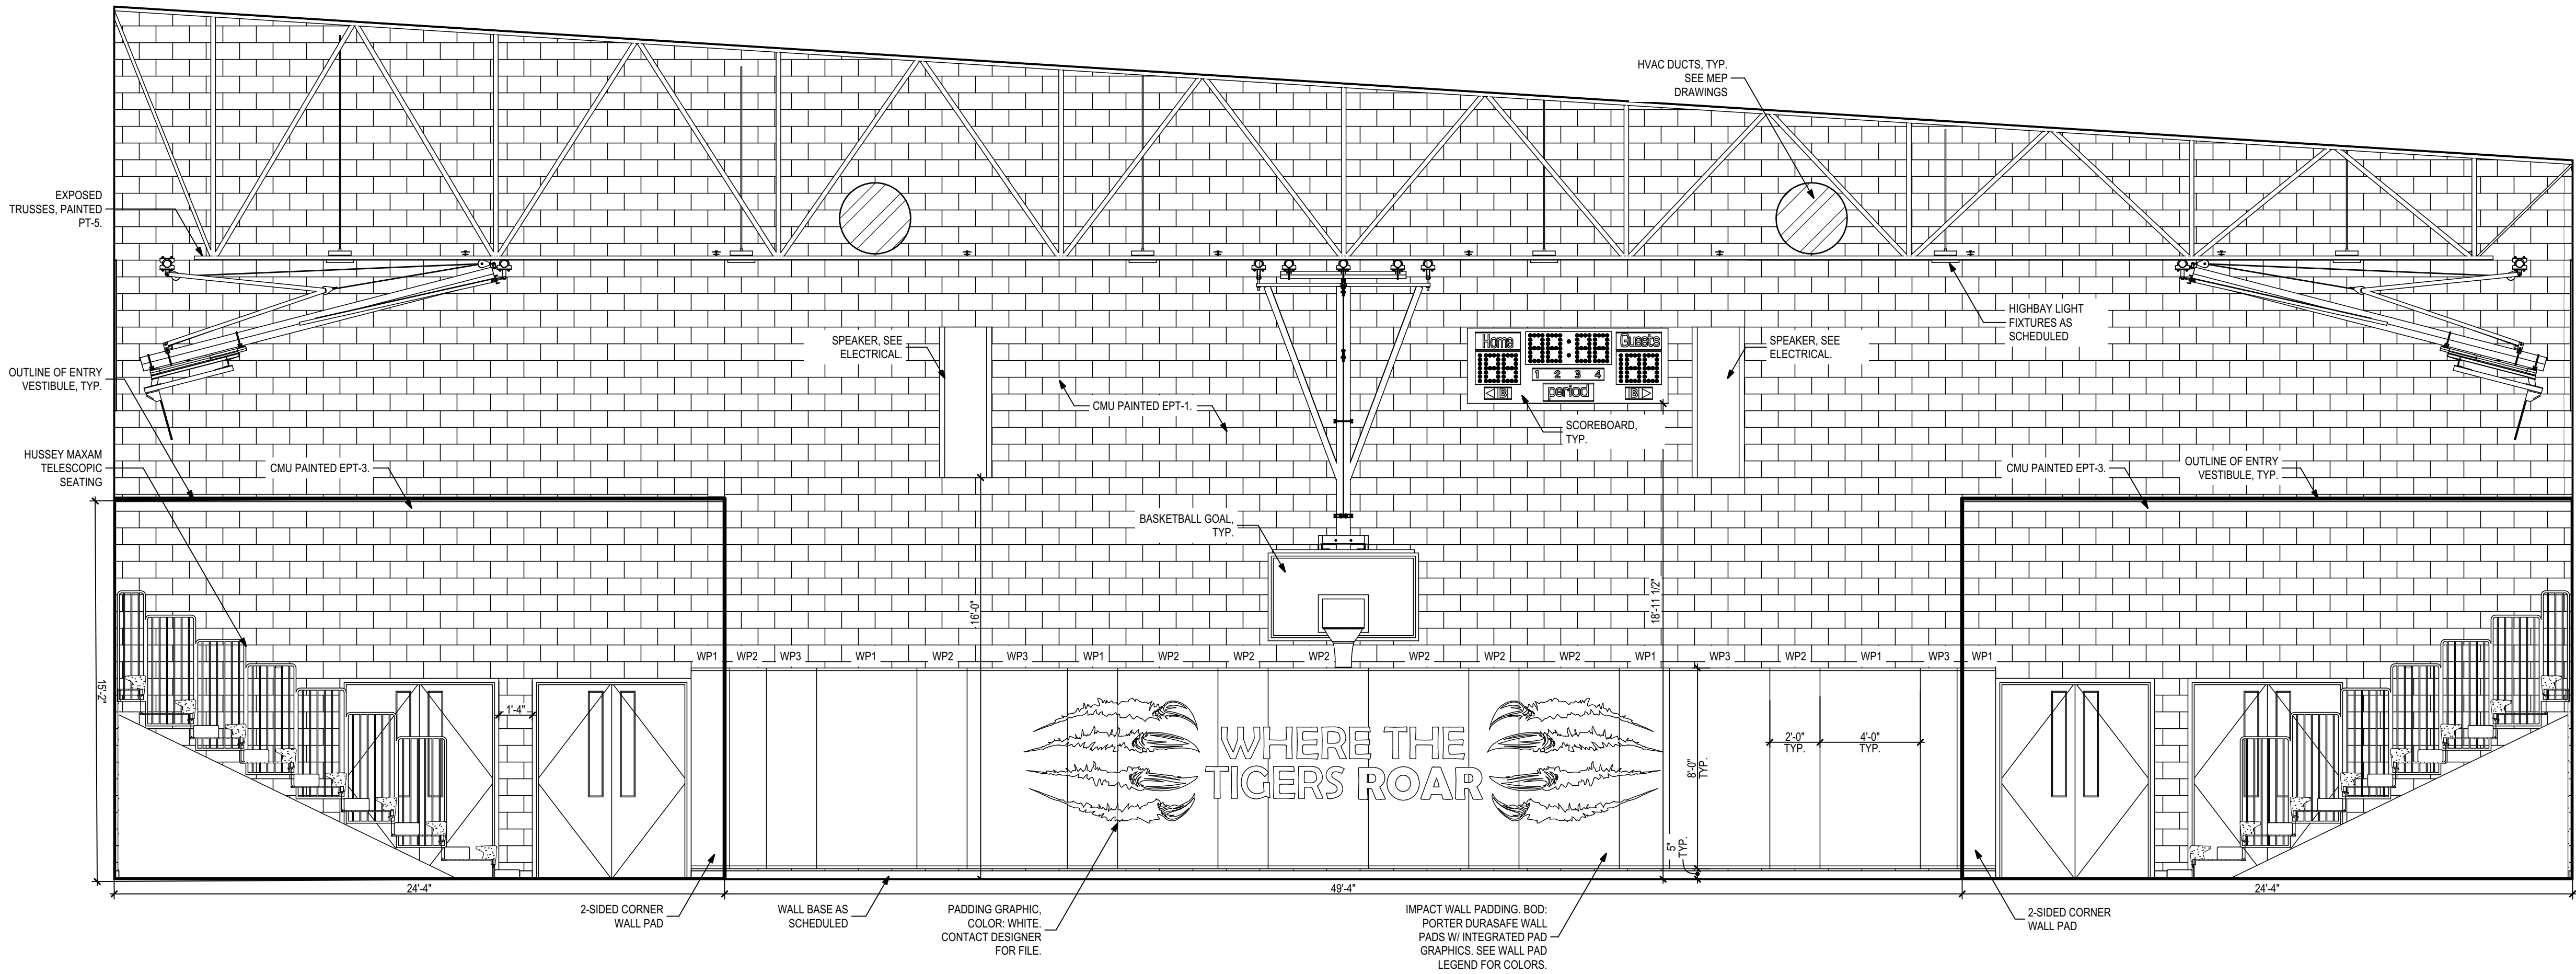


Wall Pad Schedule

WP1	PORTER VINYL, COLOR: NAVY BLUE
WP2	PORTER VINYL, COLOR: ROYAL BLUE
WP3	PORTER VINYL, COLOR: LIGHT BLUE

Acoustic Wall Panel Schedule

AWP1	GUILFORD OF MAINE, METALLATION, COLOR: STAINLESS
AWP2	GUILFORD OF MAINE, METALLATION, COLOR: POLISHED PEWTER
AWP3	GUILFORD OF MAINE, METALLATION, COLOR: FIRED TITANIUM

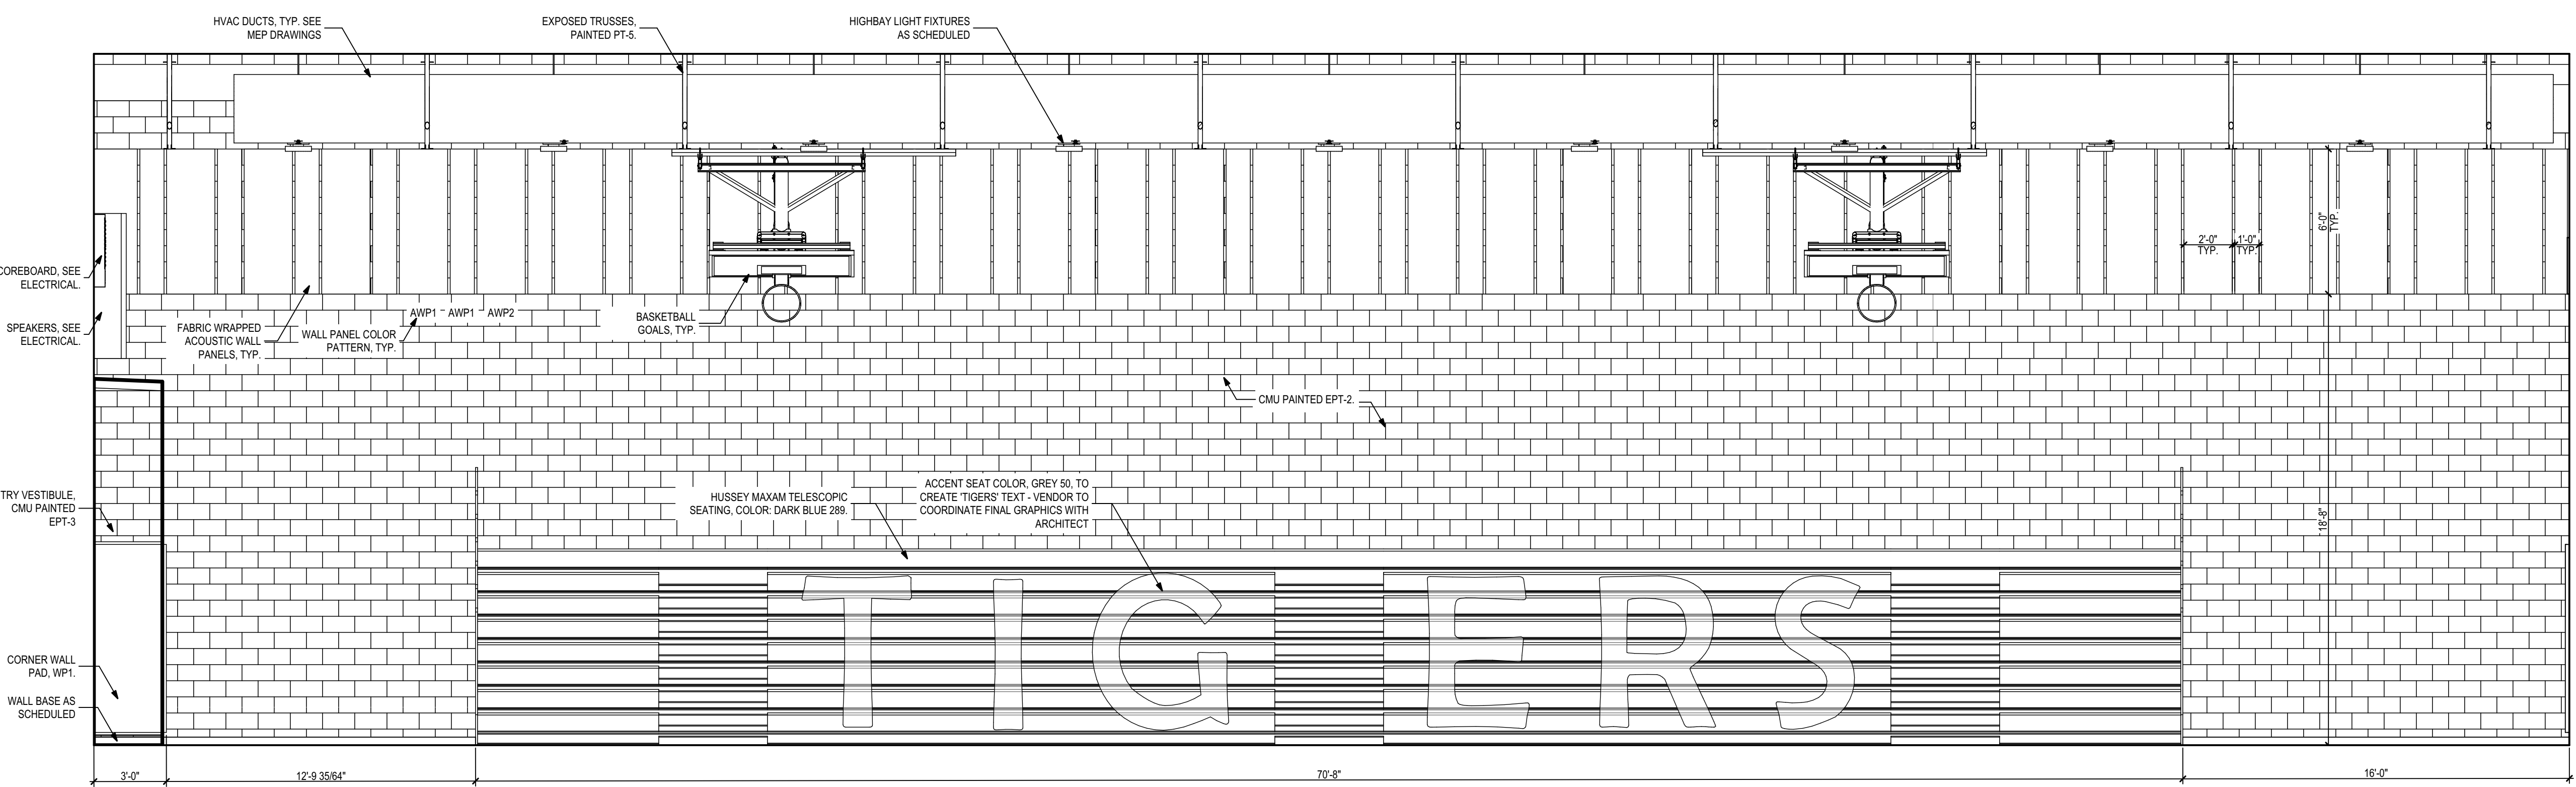

1 Gymnasium Interior Elevation

1/4" = 1'-0"

PHASE:	DRAWN:	REVIEWED:	DATE:	ID:	REVISION:	DRAWN:	REVIEWED:	DATE:
CONCEPT SCHEM. DESIGN	BG/RS	C. WHITLOCK	10/8/2024					
DESIGN DEVELOPMENT	BG/RS/MS	C. WHITLOCK	12/20/2024					
EARLY DEMOLITION PACKAGE	BG/RS/MS	R. LEWIS	03/21/2025					
80% CONSTRUCTION DOCS	BG/RS/MS	R. LEWIS	03/21/2025					
PERMIT DOCS	BG/RS/MS	R. LEWIS	05/09/2025					
100% CONSTRUCTION DOCS	BG/RS/MS	R. LEWIS	05/09/2025					

LEON COUNTY SCHOOLS

Leon County Schools
3420 W. Tharpe St., Suite 100
Tallahassee, FL 32303

Griffin Middle School - Phase 2
800 Alabama St. Tallahassee, FL 32304

Client:

Consultant:

Project #: 23483
Phase: 100% CDs

Job Title:

Seal:


ALW

Architects Lewis + Whitlock
206 West Virginia St.
Tallahassee, Florida 32301
850.942.1718
www.think3d.net


Description:
Interior Elevations

Sheet No.:
A5.4


L1	PENCO INVINCIBLE II METAL GYM LOCKER, 2 TIER, COLOR: 021 GRAY ASH
L2	PENCO INVINCIBLE II METAL GYM LOCKER, 2 TIER, COLOR: 822 REGAL BLUE
L3	PENCO INVINCIBLE II METAL GYM LOCKER, 2 TIER, COLOR: 806 MARINE BLUE
L4	PENCO INVINCIBLE II METAL GYM LOCKER, HALF HEIGHT, 1 TIER, 36 1/2" H., COLOR: 806 MARINE BLUE
B1	PENCO FIXED BENCH
B2	PENCO ADA FIXED BENCH

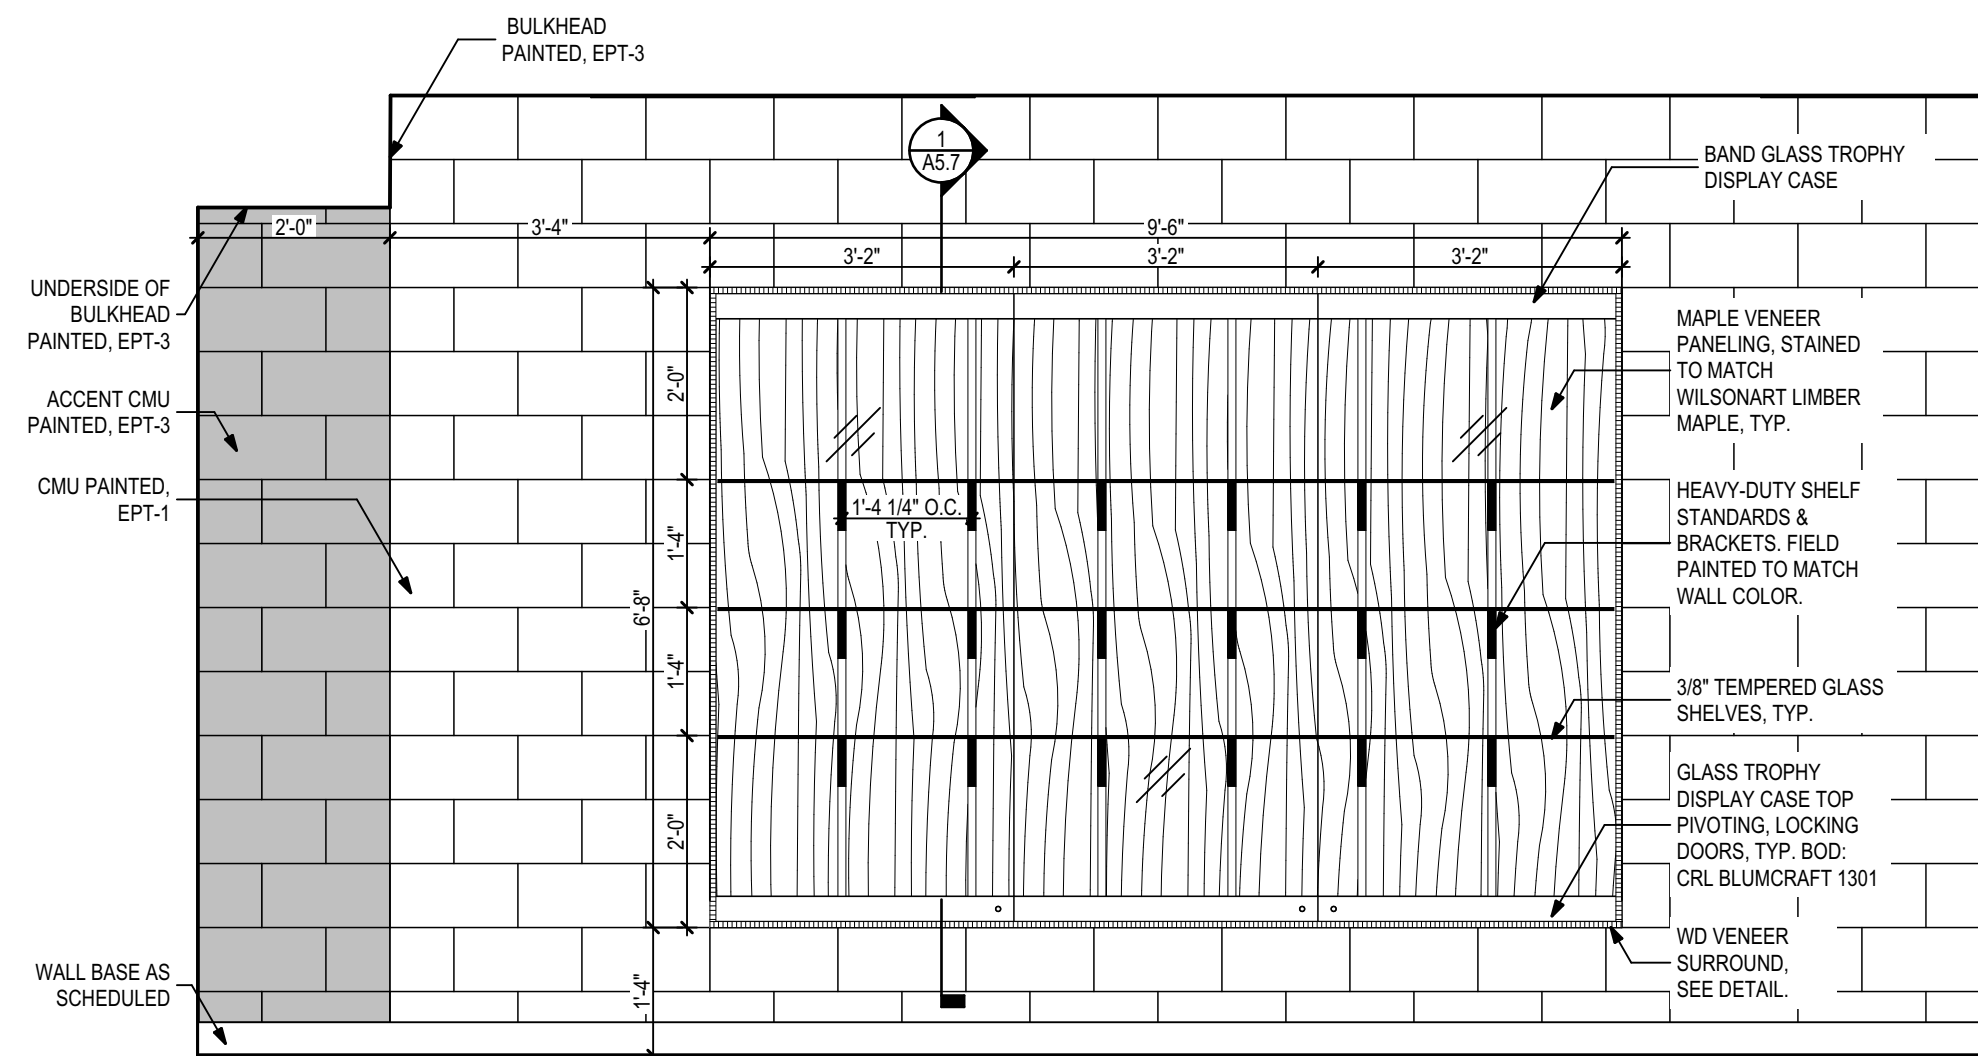


7 Band Trophy Case Interior Elevation
1/2" = 1'-0"

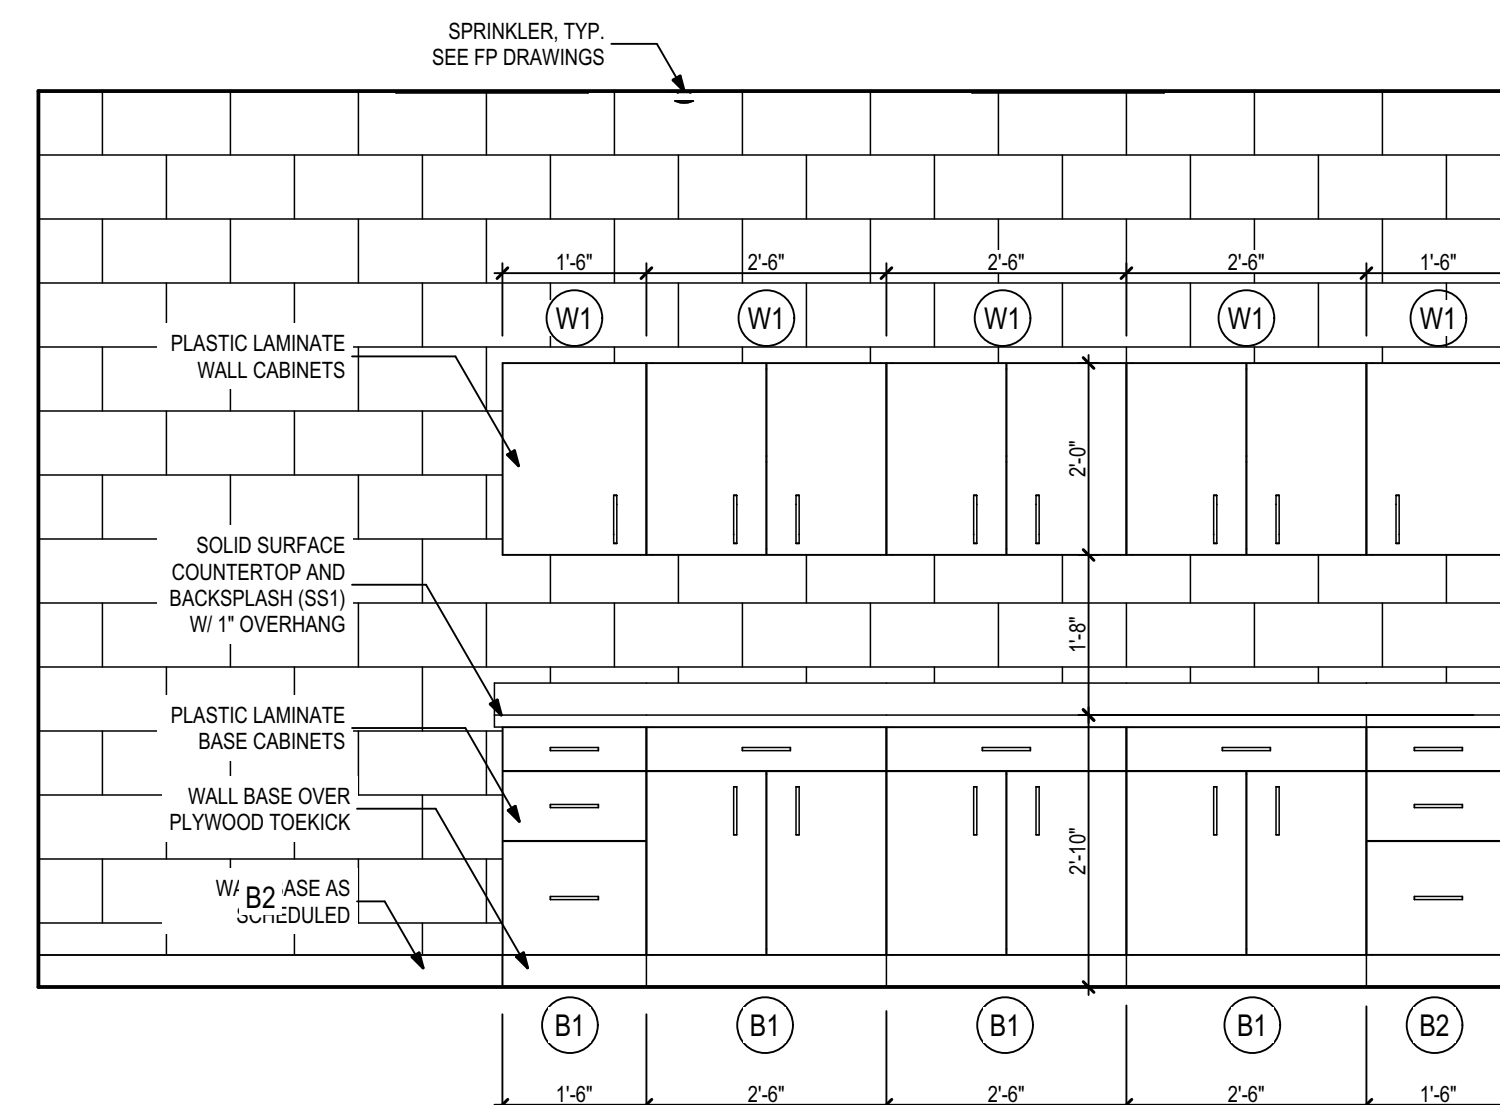


5 P.E. Coaches Office - Female
1/2" = 1'-0"

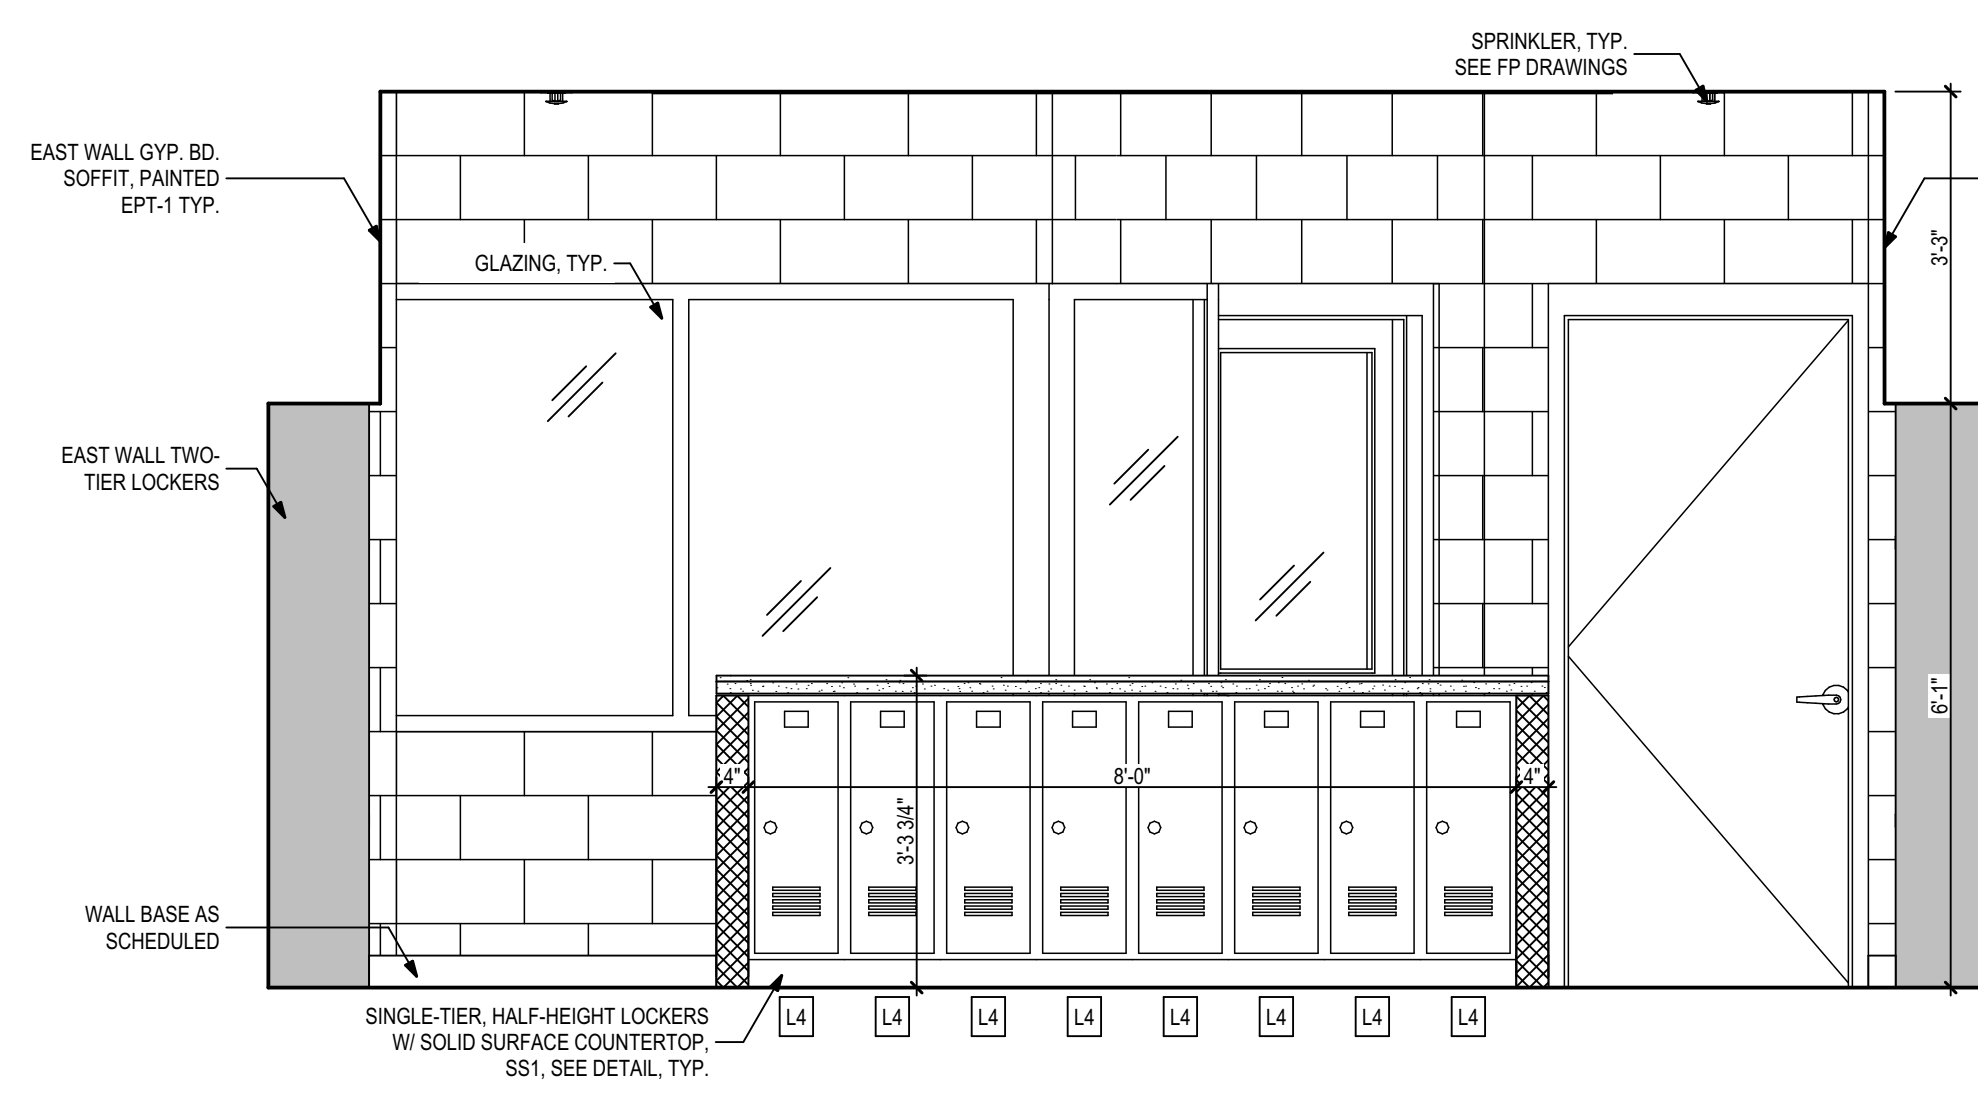


4 Locker Room - Female Interior Elevation
1/2" = 1'-0"

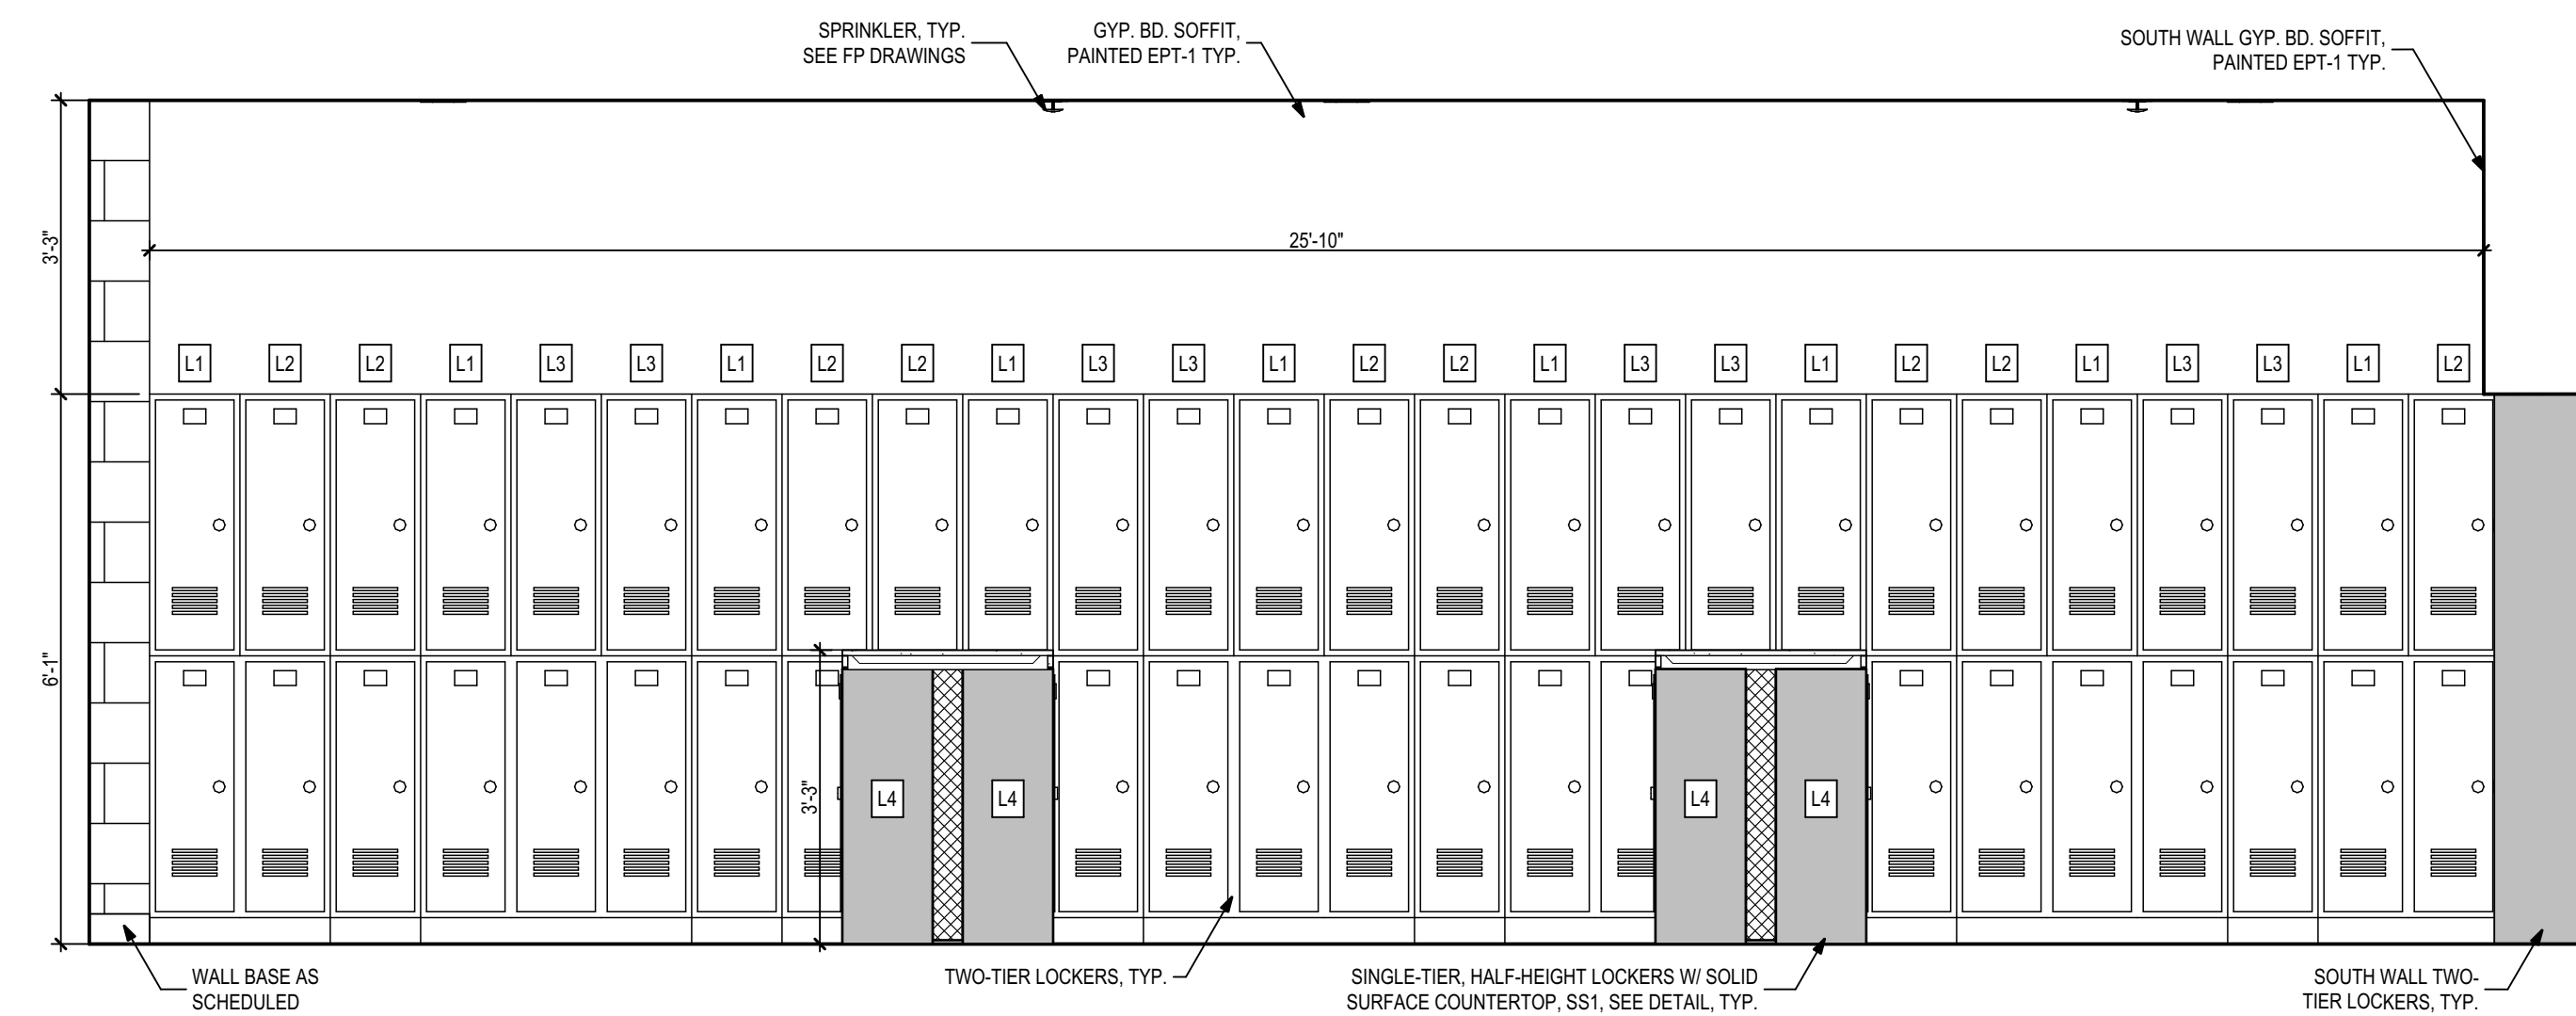


2 Locker Room - Female Interior Elevation
1/2" = 1'-0"

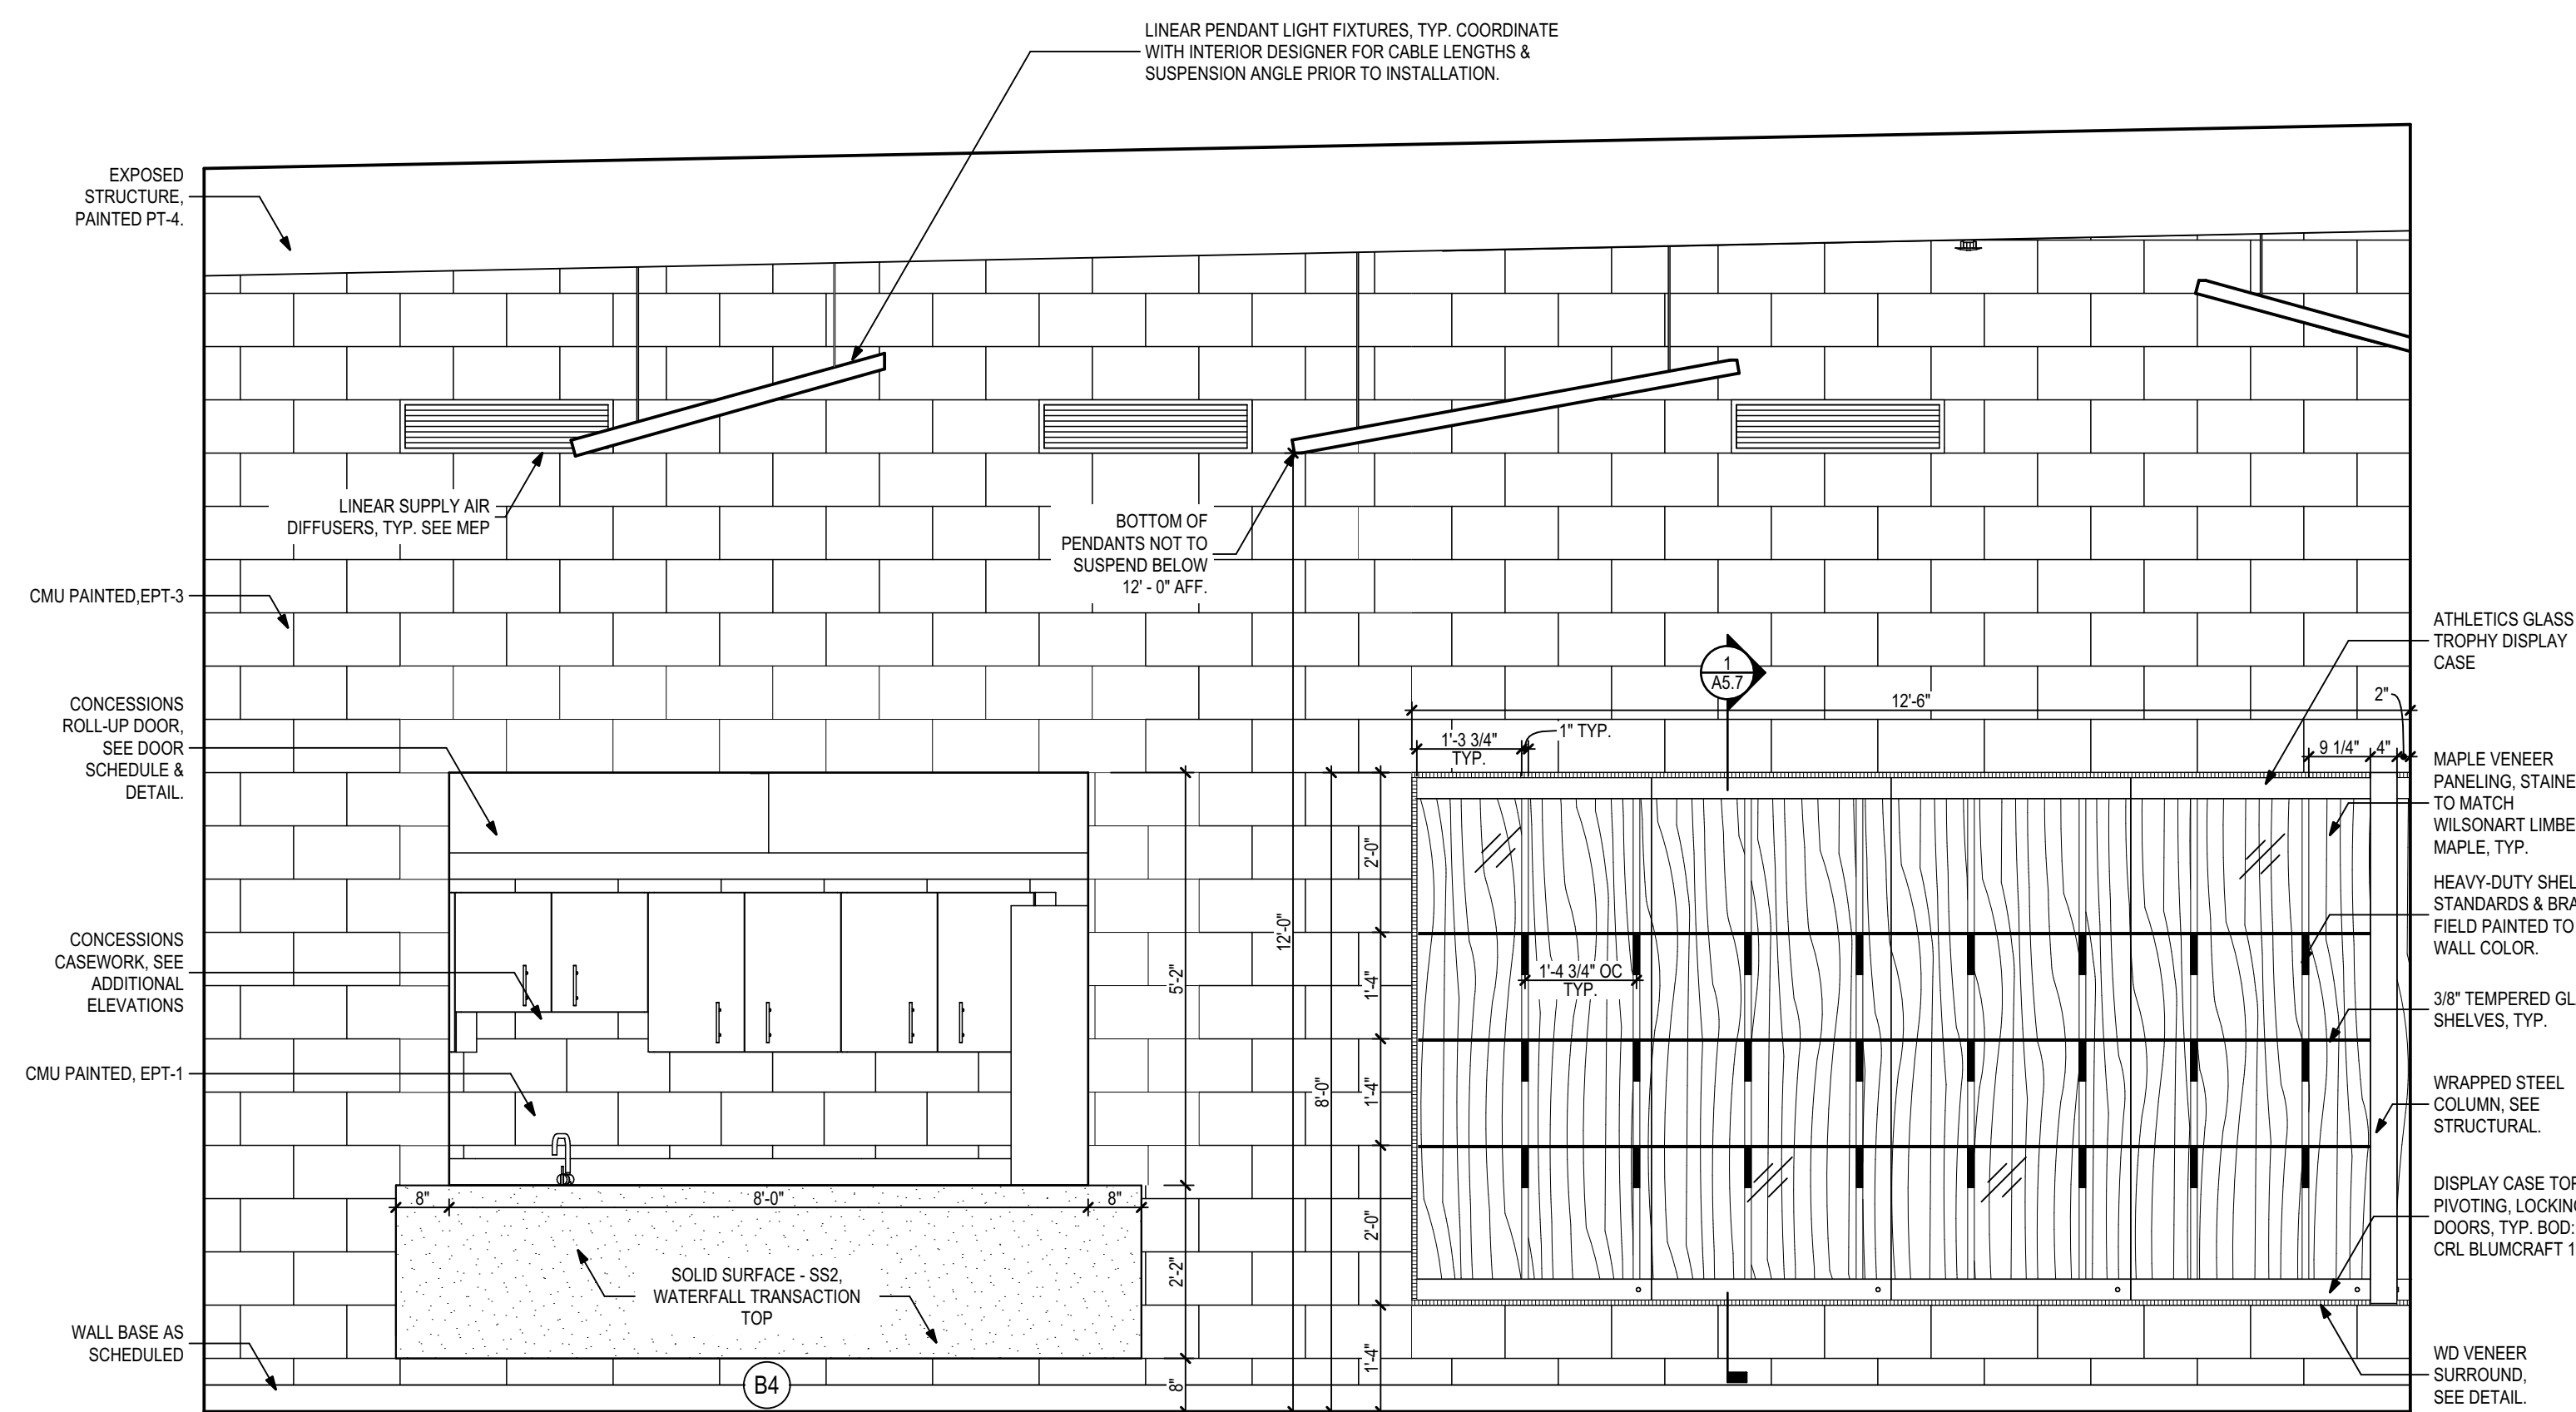

6 Athletics Trophy Case and Concession Stand Interior Elevation
1/2" = 1'-0"

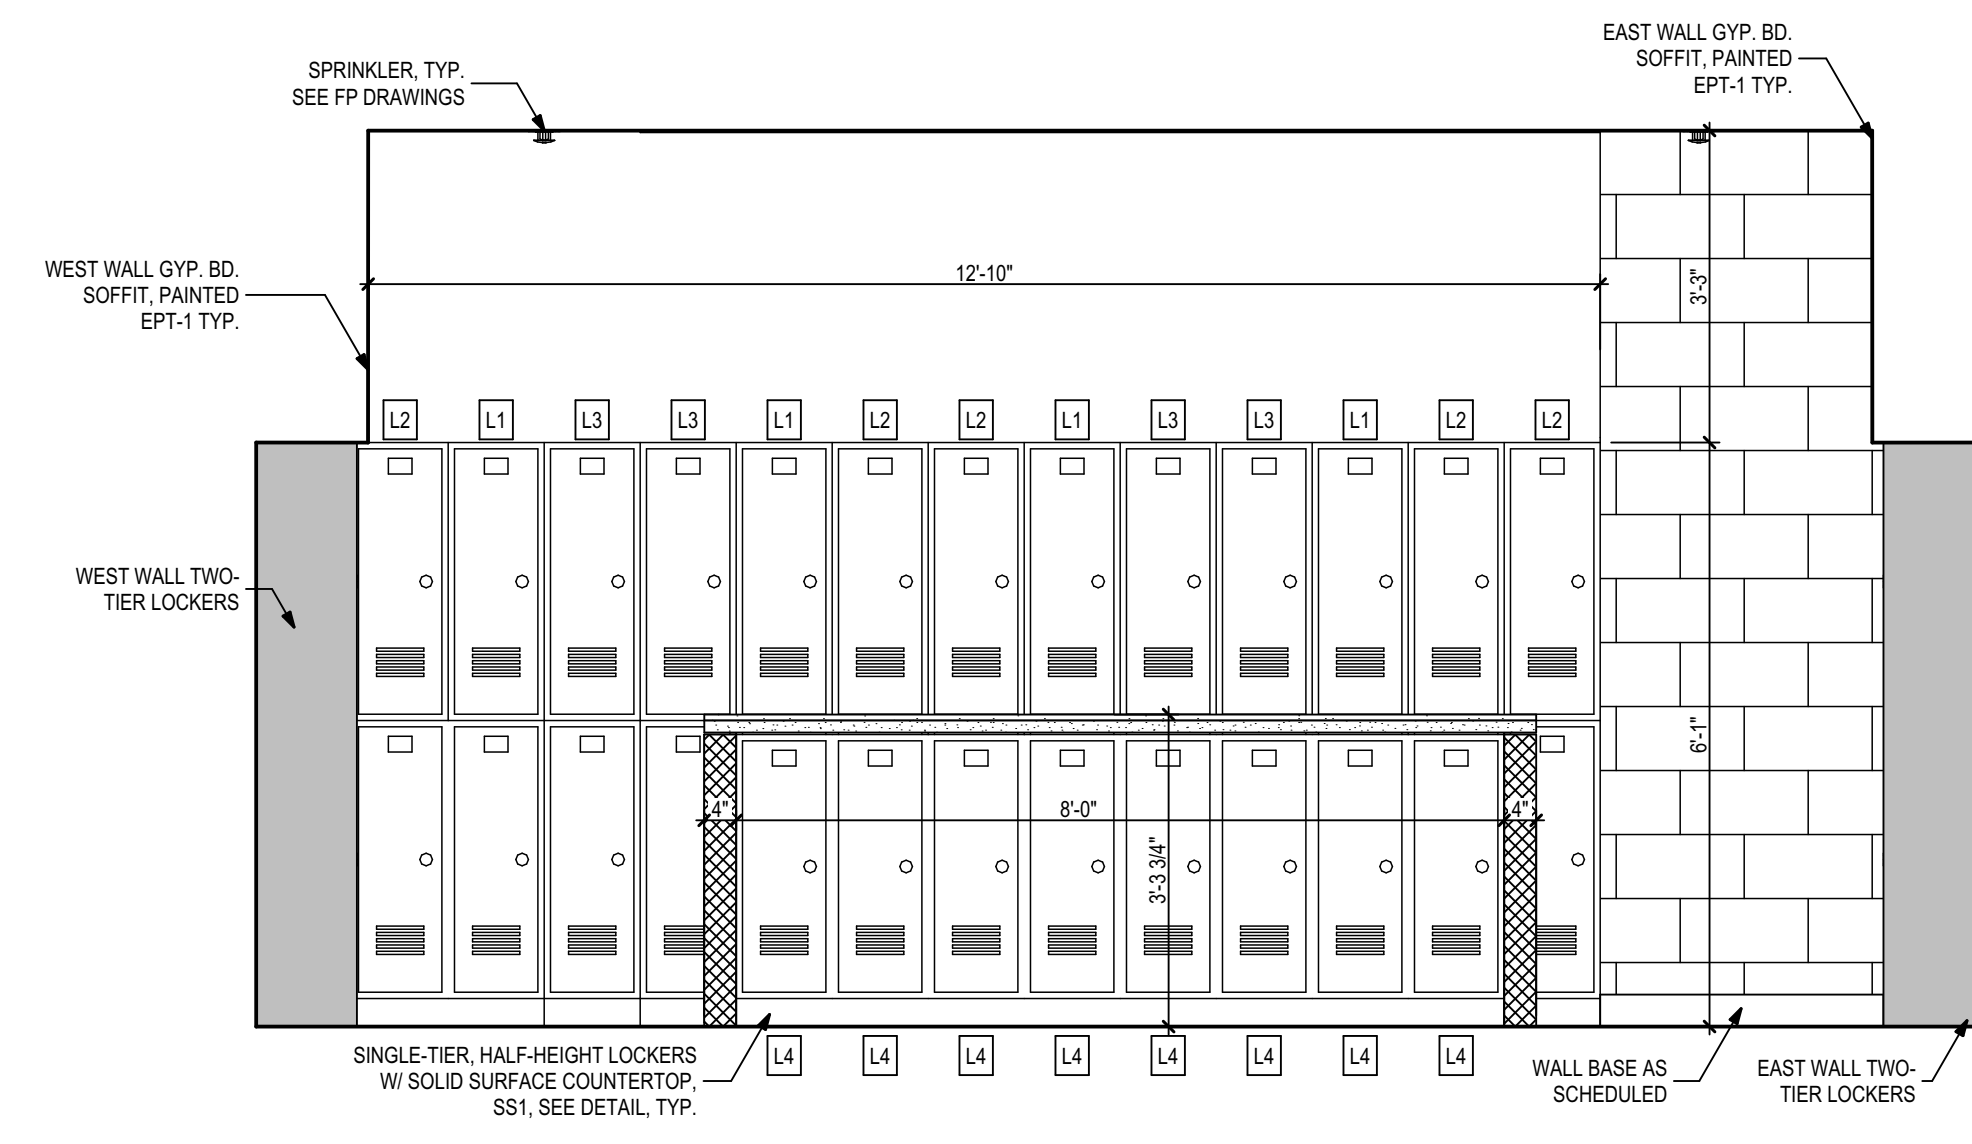

3 Locker Room - Female Interior Elevation
1/2" = 1'-0"

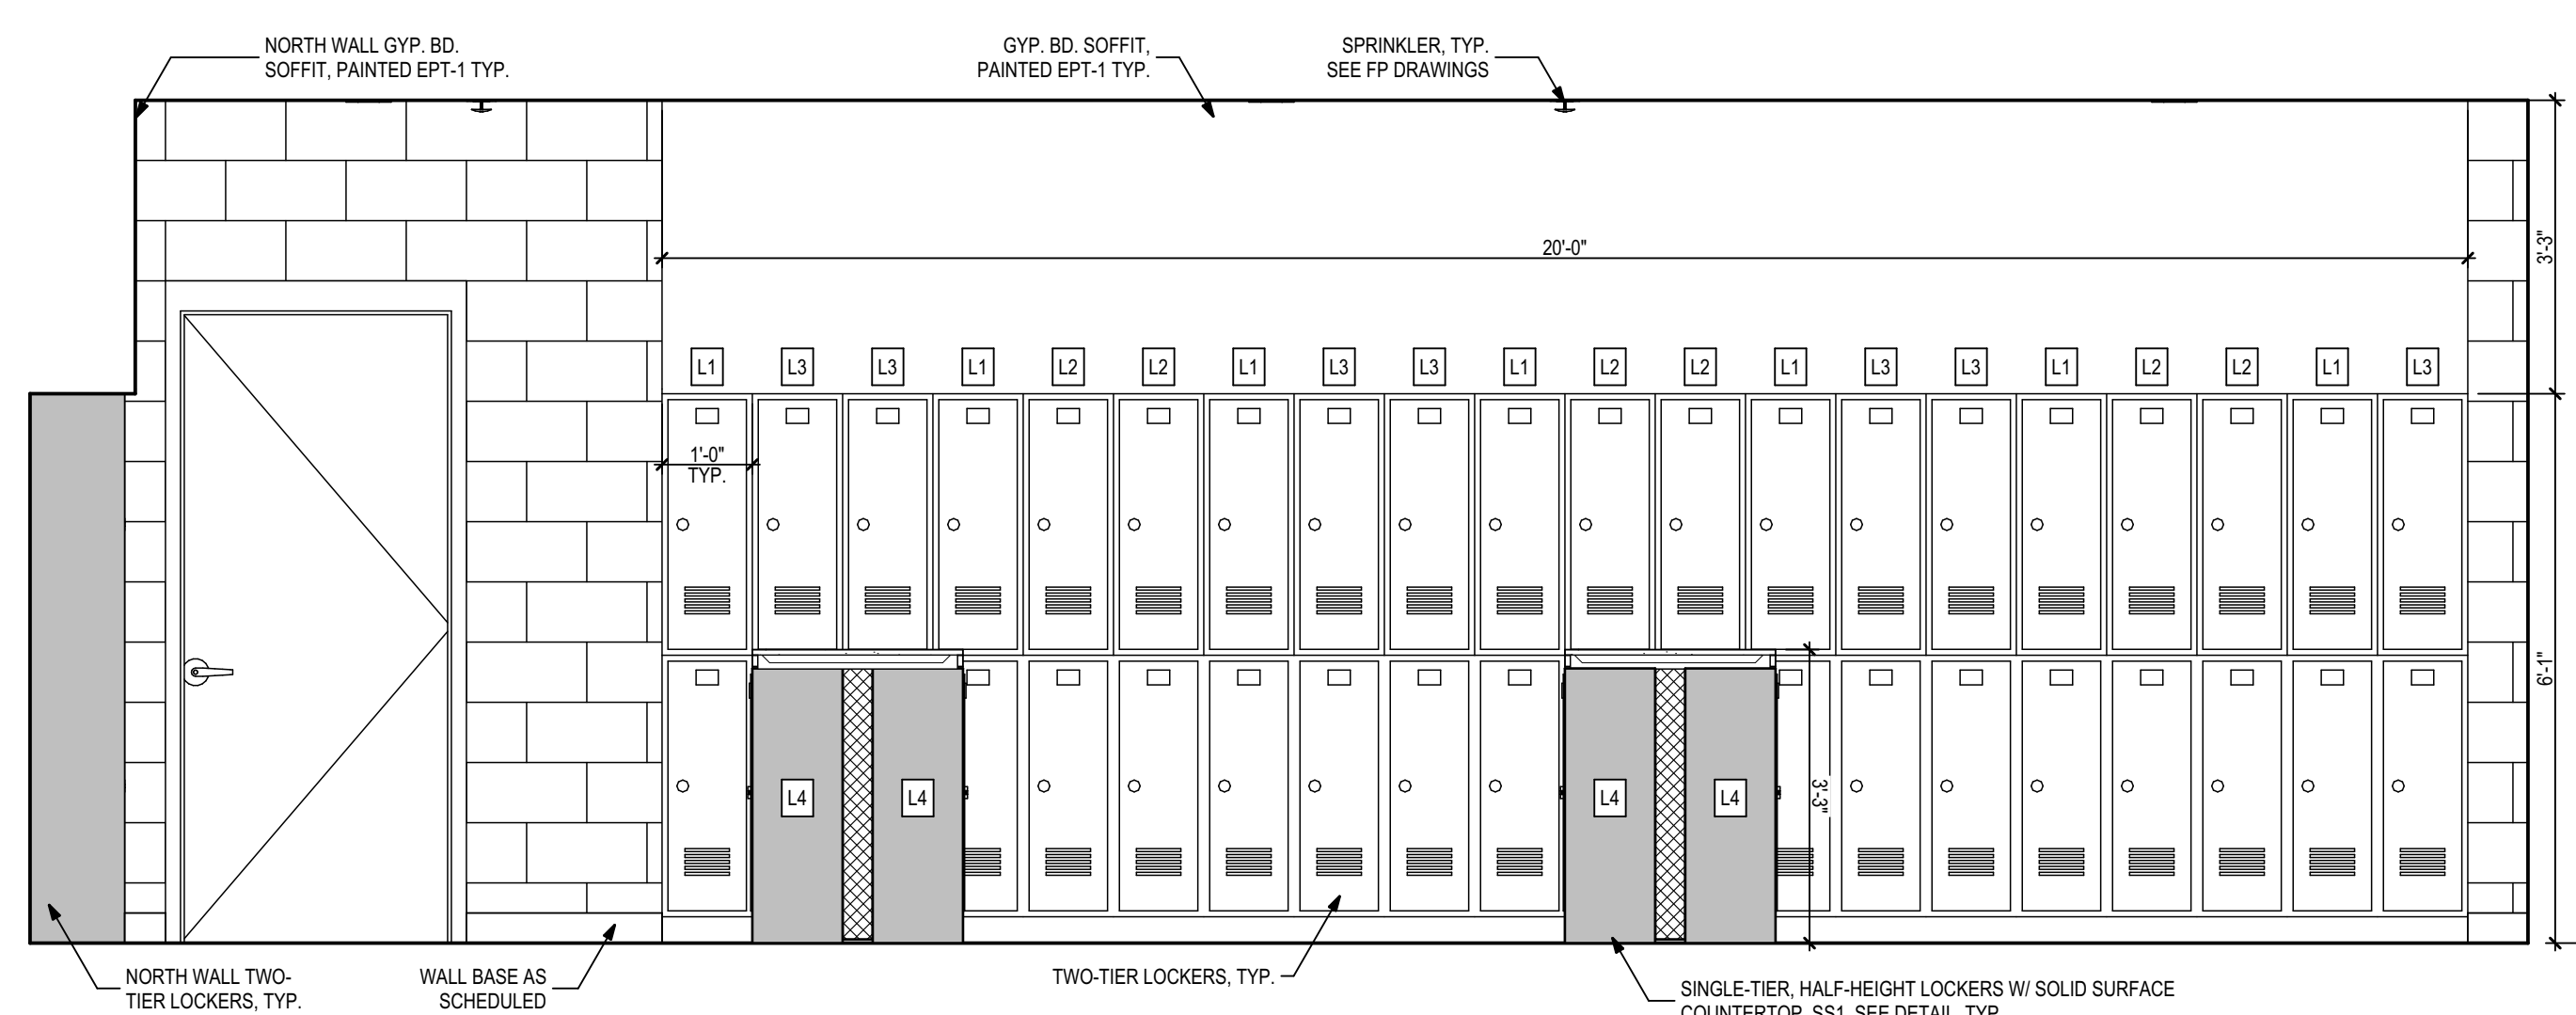


1 Locker Room - Female Interior Elevation
1/2" = 1'-0"


[illegible]

Locker Schedule


L1	PENCO INVINCIBLE II METAL GYM LOCKER, 2 TIER, COLOR: 021 GRAY ASH
L2	PENCO INVINCIBLE II METAL GYM LOCKER, 2 TIER, COLOR: 822 REGAL BLUE
L3	PENCO INVINCIBLE II METAL GYM LOCKER, 2 TIER, COLOR: 806 MARINE BLUE
L4	PENCO INVINCIBLE II METAL GYM LOCKER, HALF HEIGHT, 1 TIER, 36 1/2" H, COLOR: 806 MARINE BLUE
B1	PENCO FIXED BENCH
B2	PENCO ADA FIXED BENCH

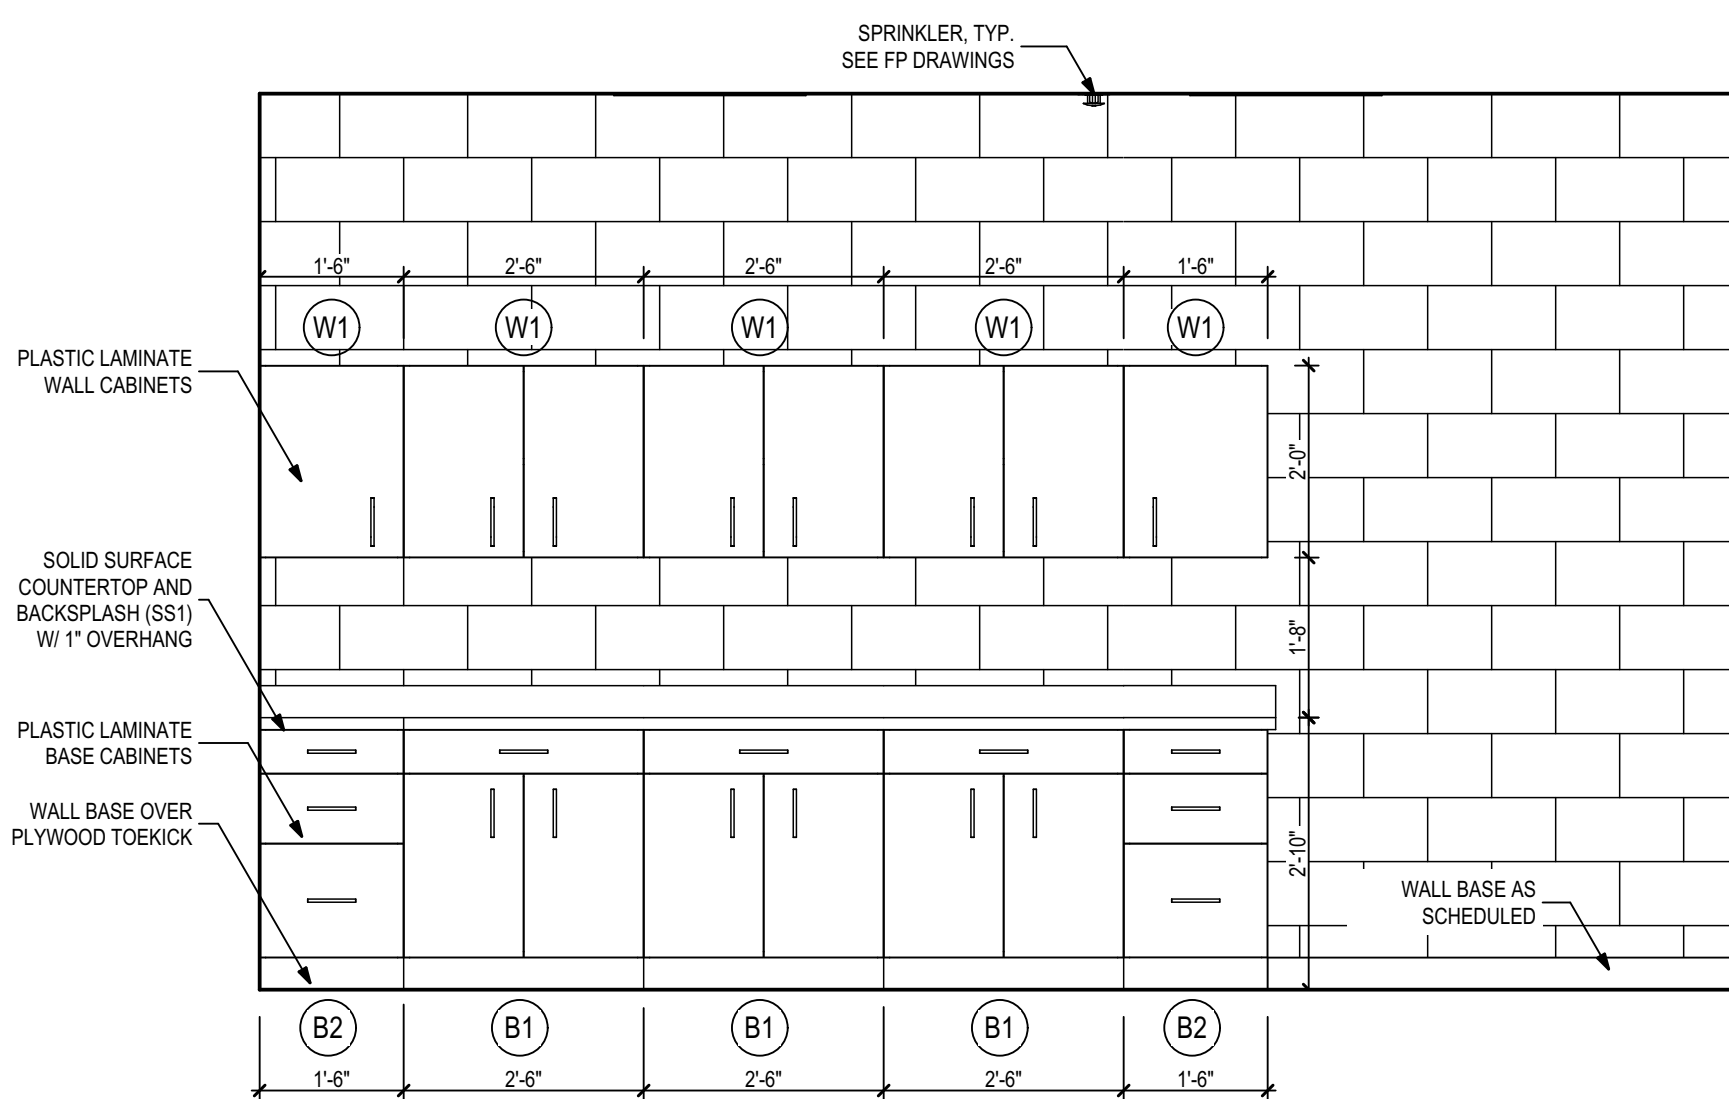


5 P.E. Coach's Office - Male
1/2" = 1'-0"

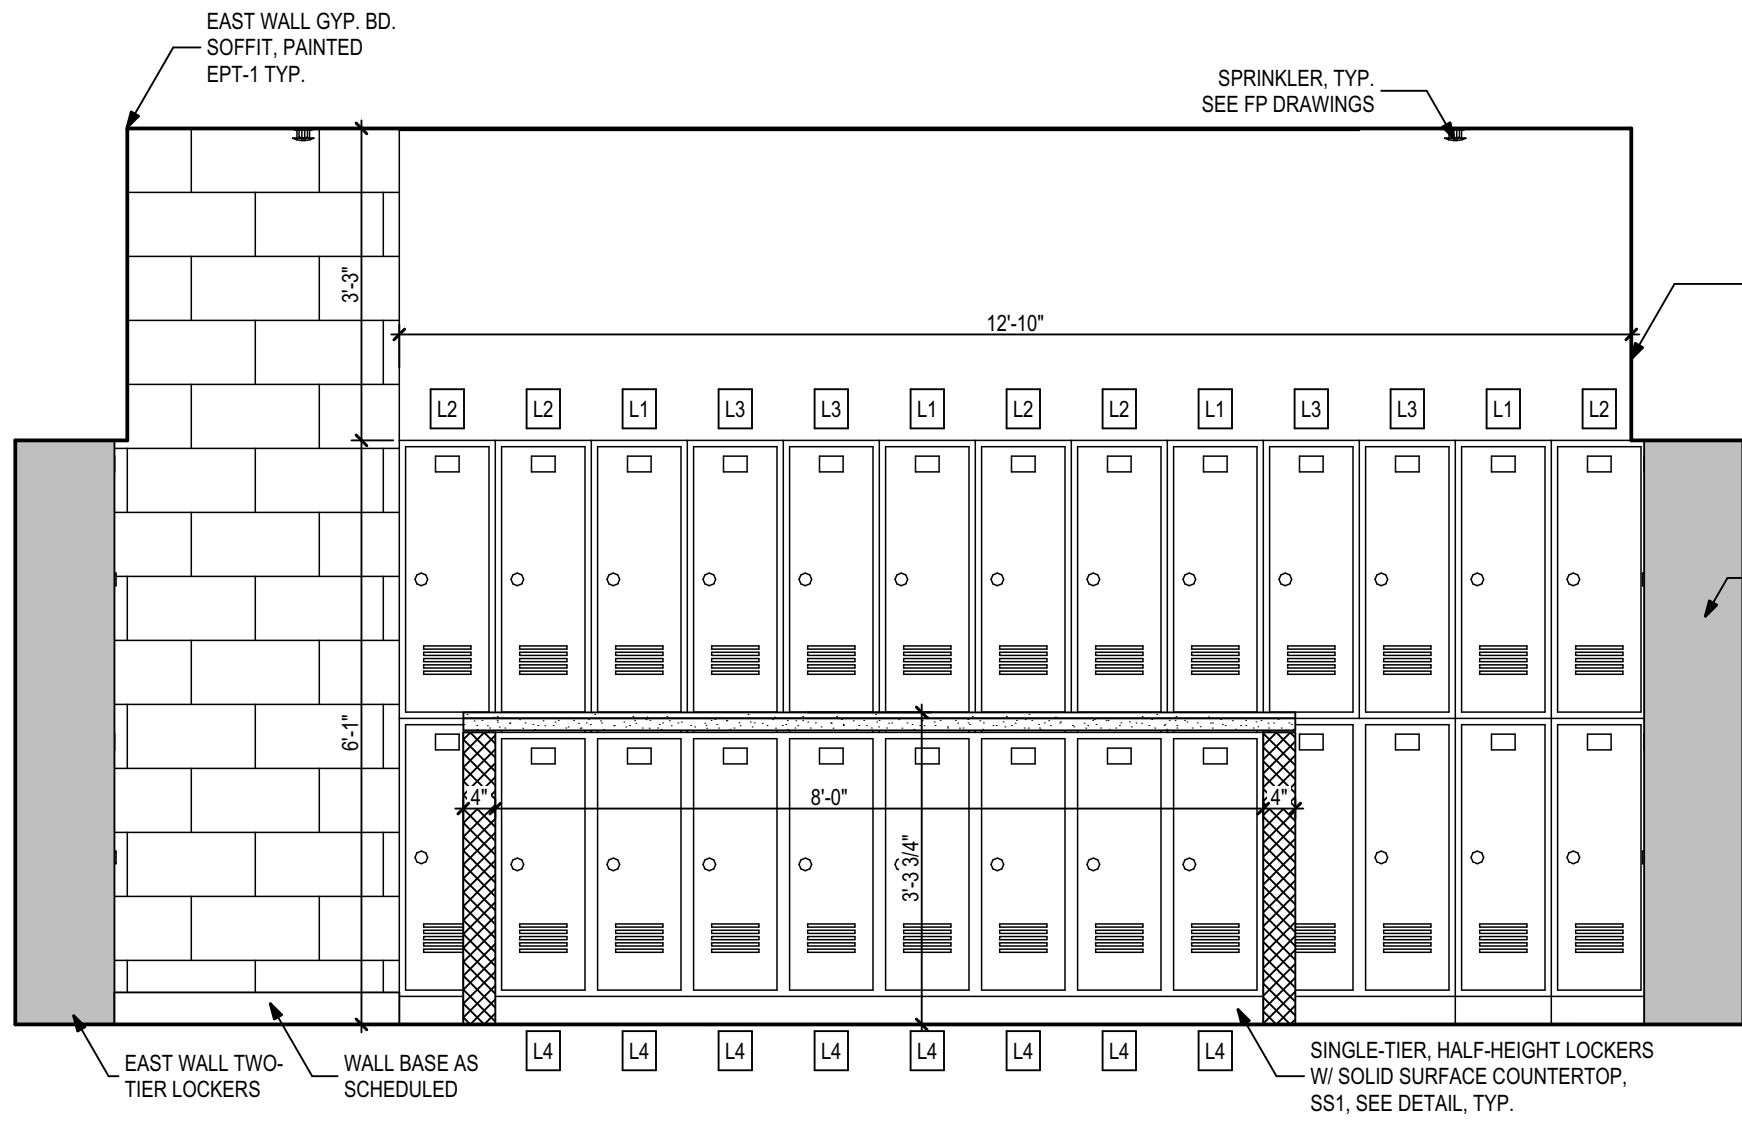


4 Locker Room - Male Interior Elevation
1/2" = 1'-0"

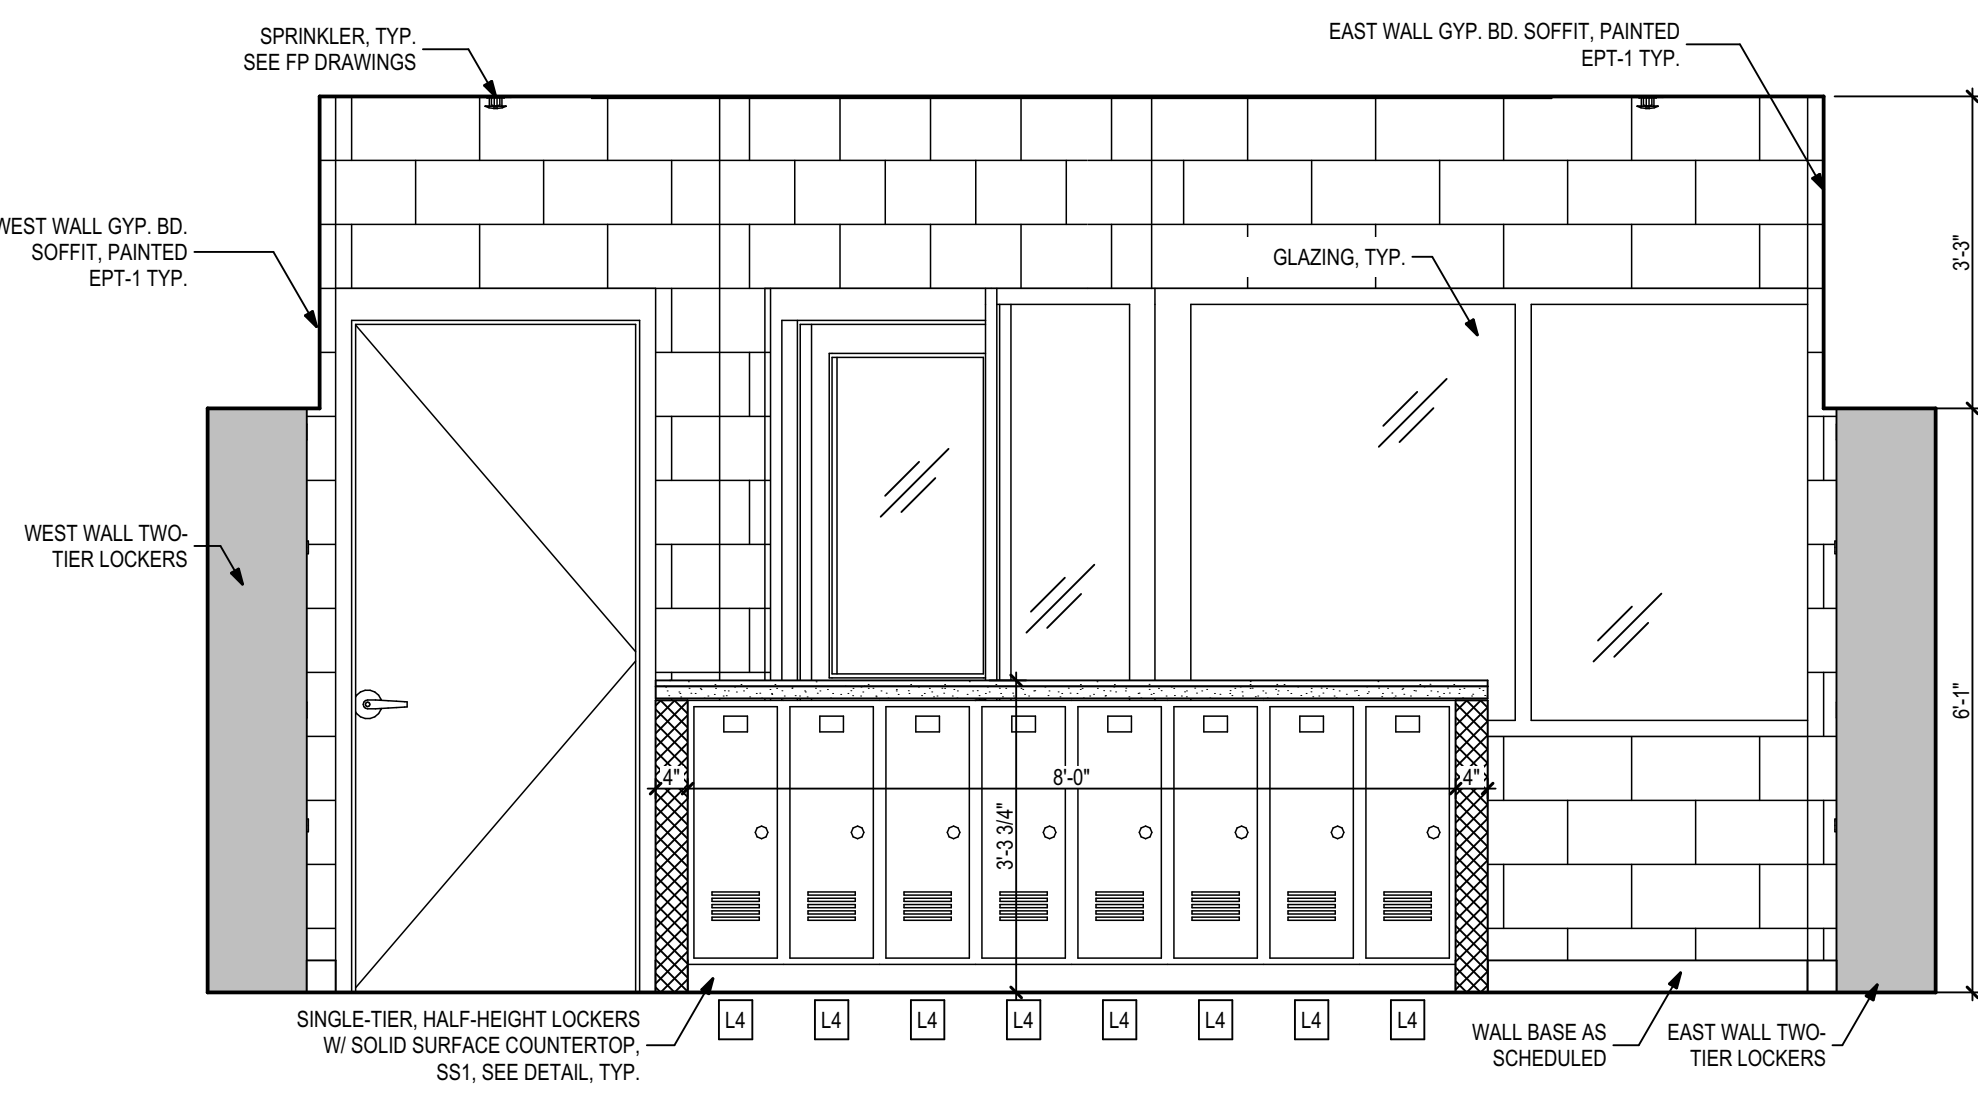


3 Locker Room - Male Interior Elevation
1/2" = 1'-0"

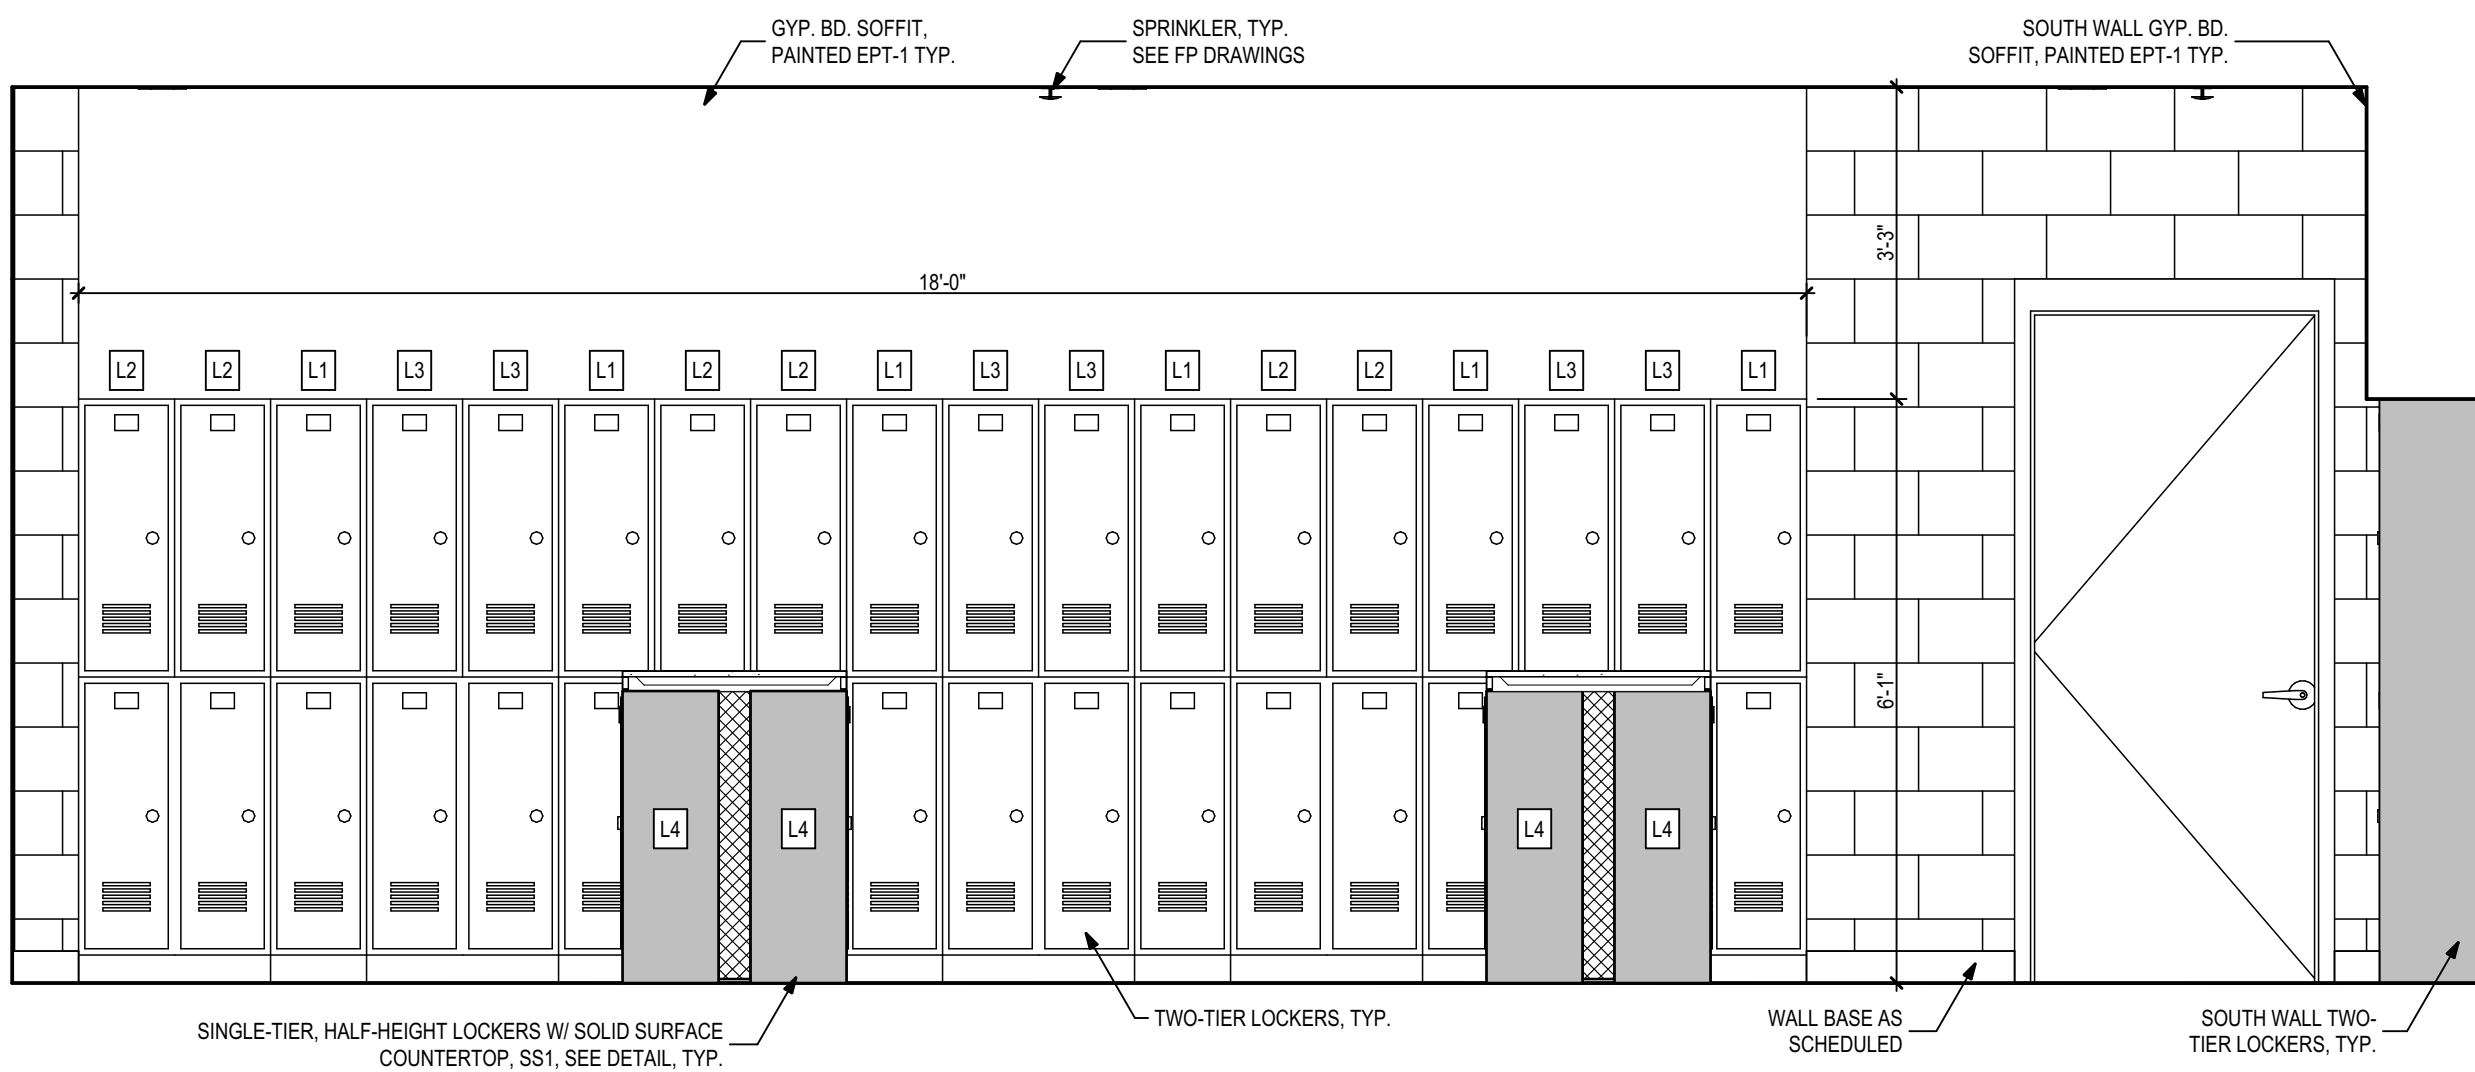

2 Locker Room - Male Interior Elevation
1/2" = 1'-0"

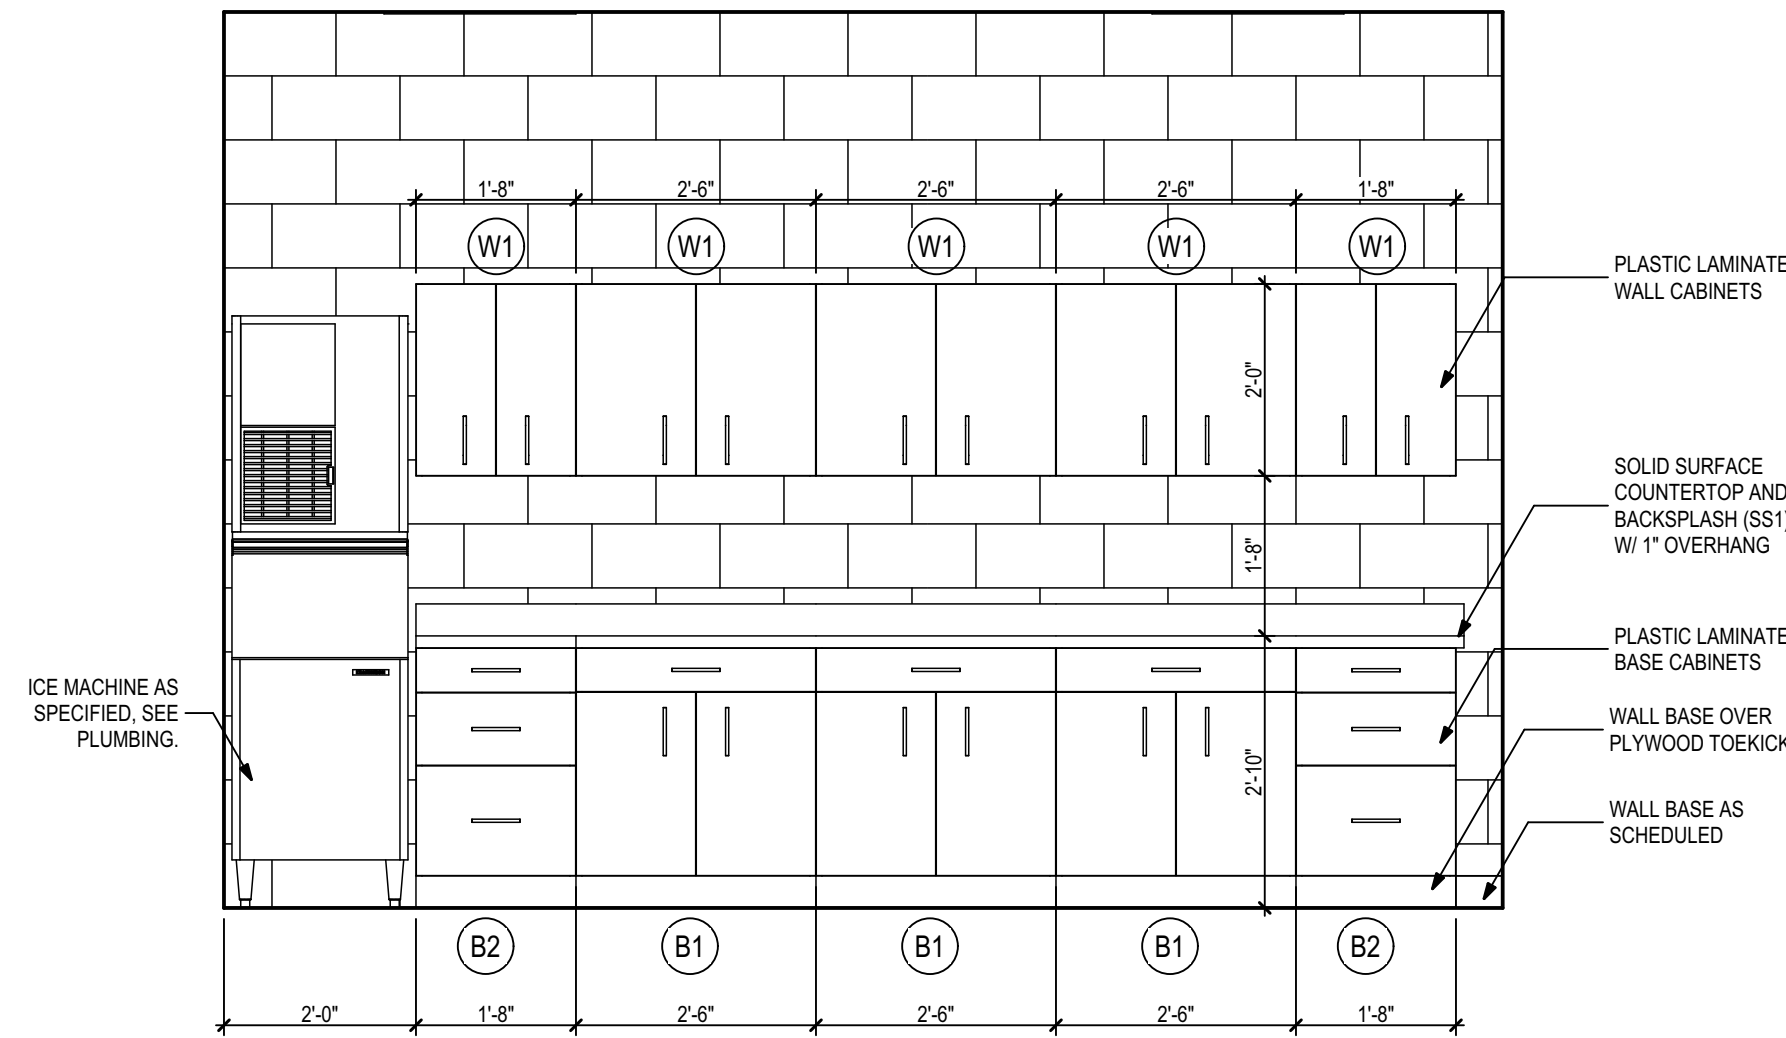

7 Training Room Interior Elevation
1/2" = 1'-0"

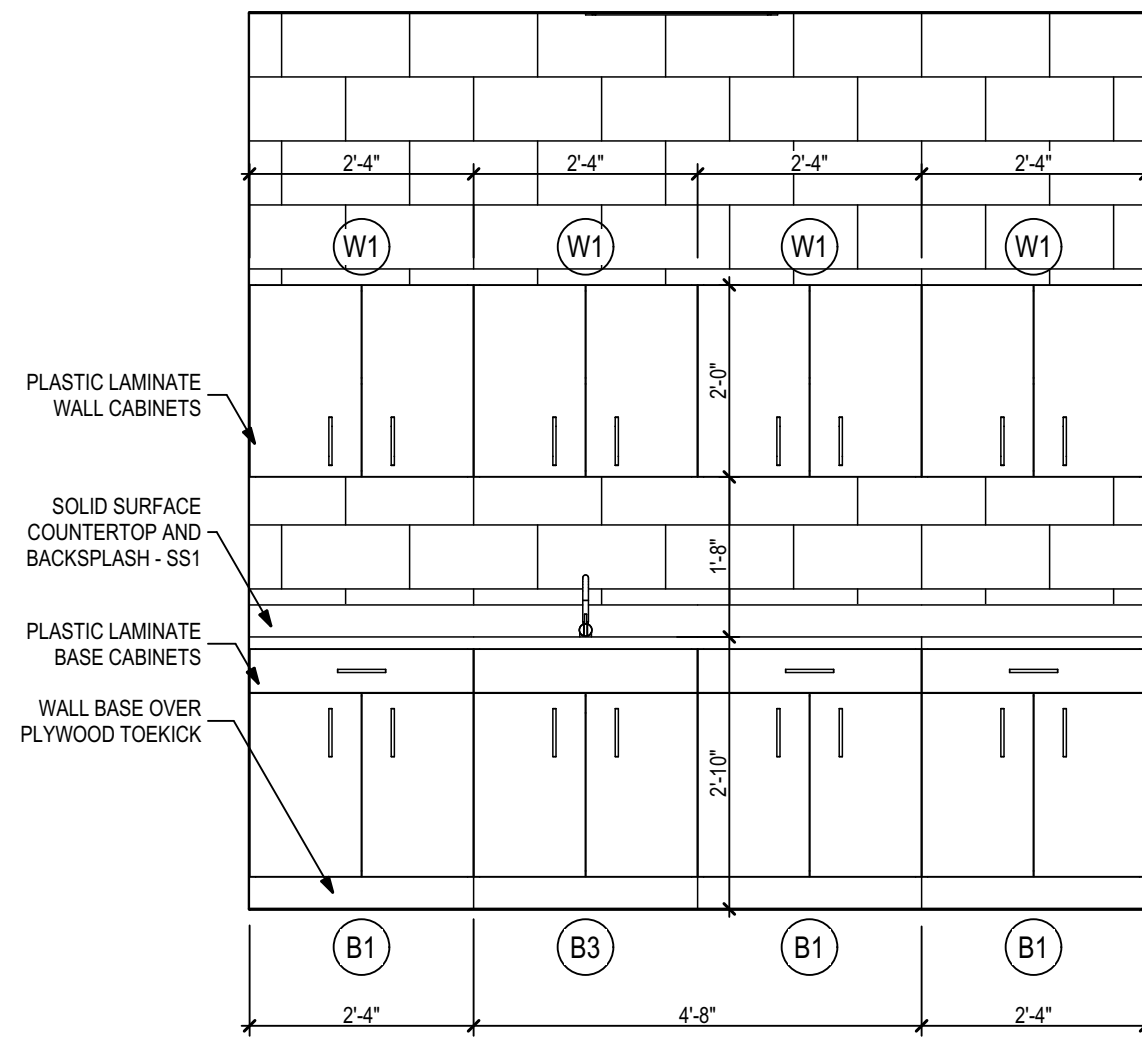

6 First Aid Room Interior Elevation
1/2" = 1'-0"

PHASE:	DRAWN:	REVIEWED:	DATE:	ID:	REVISION:	DRAWN:	REVIEWED:	DATE:
CONCEPT SCHEM. DESIGN	BG/RS	C. WHITLOCK	10/8/2024					
DESIGN DEVELOPMENT	BG/RS/MS	C. WHITLOCK	12/20/2024					
EARLY DEMOLITION PACKAGE	BG/RS/MS	C. WHITLOCK	12/20/2024					
80% CONSTRUCTION DOCS	BG/RS/MS	R. LEWIS	03/21/2025					
PERMIT DOCS	BG/RS/MS	R. LEWIS	03/21/2025					
100% CONSTRUCTION DOCS	BG/RS/MS	R. LEWIS	06/09/2025					

LEON COUNTY SCHOOLS

Client: Leon County Schools
3420 W. Tharpe St., Suite 100
Tallahassee, FL 32303

Job Title: Griffin Middle School - Phase 2
800 Alabama St. Tallahassee, FL 32304

Consultant: 23483
Project #: 100% CDs
Phase:

Seal:


Architects Lewis + Whitlock
206 West Virginia St.
Tallahassee, Florida 32301
850.942.1718
www.think3d.net

Description:
Interior Elevations

Sheet No.:
A5.6

THESE DRAWINGS AND RENDERINGS ARE INSTRUMENTS OF SERVICE. THE DRAWINGS AND ASSOCIATED COPIES THEREOF, INCLUDING ELECTRONIC MEDIA AND CAD FILES, ARE THE PROPERTY OF ARCHITECTS LEWIS + WHITLOCK, P.A.A. THEIR USE, REPRESENTATION OR REPRODUCTION FOR ANY PURPOSE EXCEPT BY WRITTEN AGREEMENT WITH THE ARCHITECT IS PROHIBITED. THIS COPYRIGHT NOTIFICATION SHALL BE TRUE AS F DIRECTLY PLACED ON EACH DRAWING EXHIBIT. ON BEHALF OF THE ARCHITECT, THESE DOCUMENTS SHALL NOT BE REMOVED FROM THESE DOCUMENTS.

Casework Sections

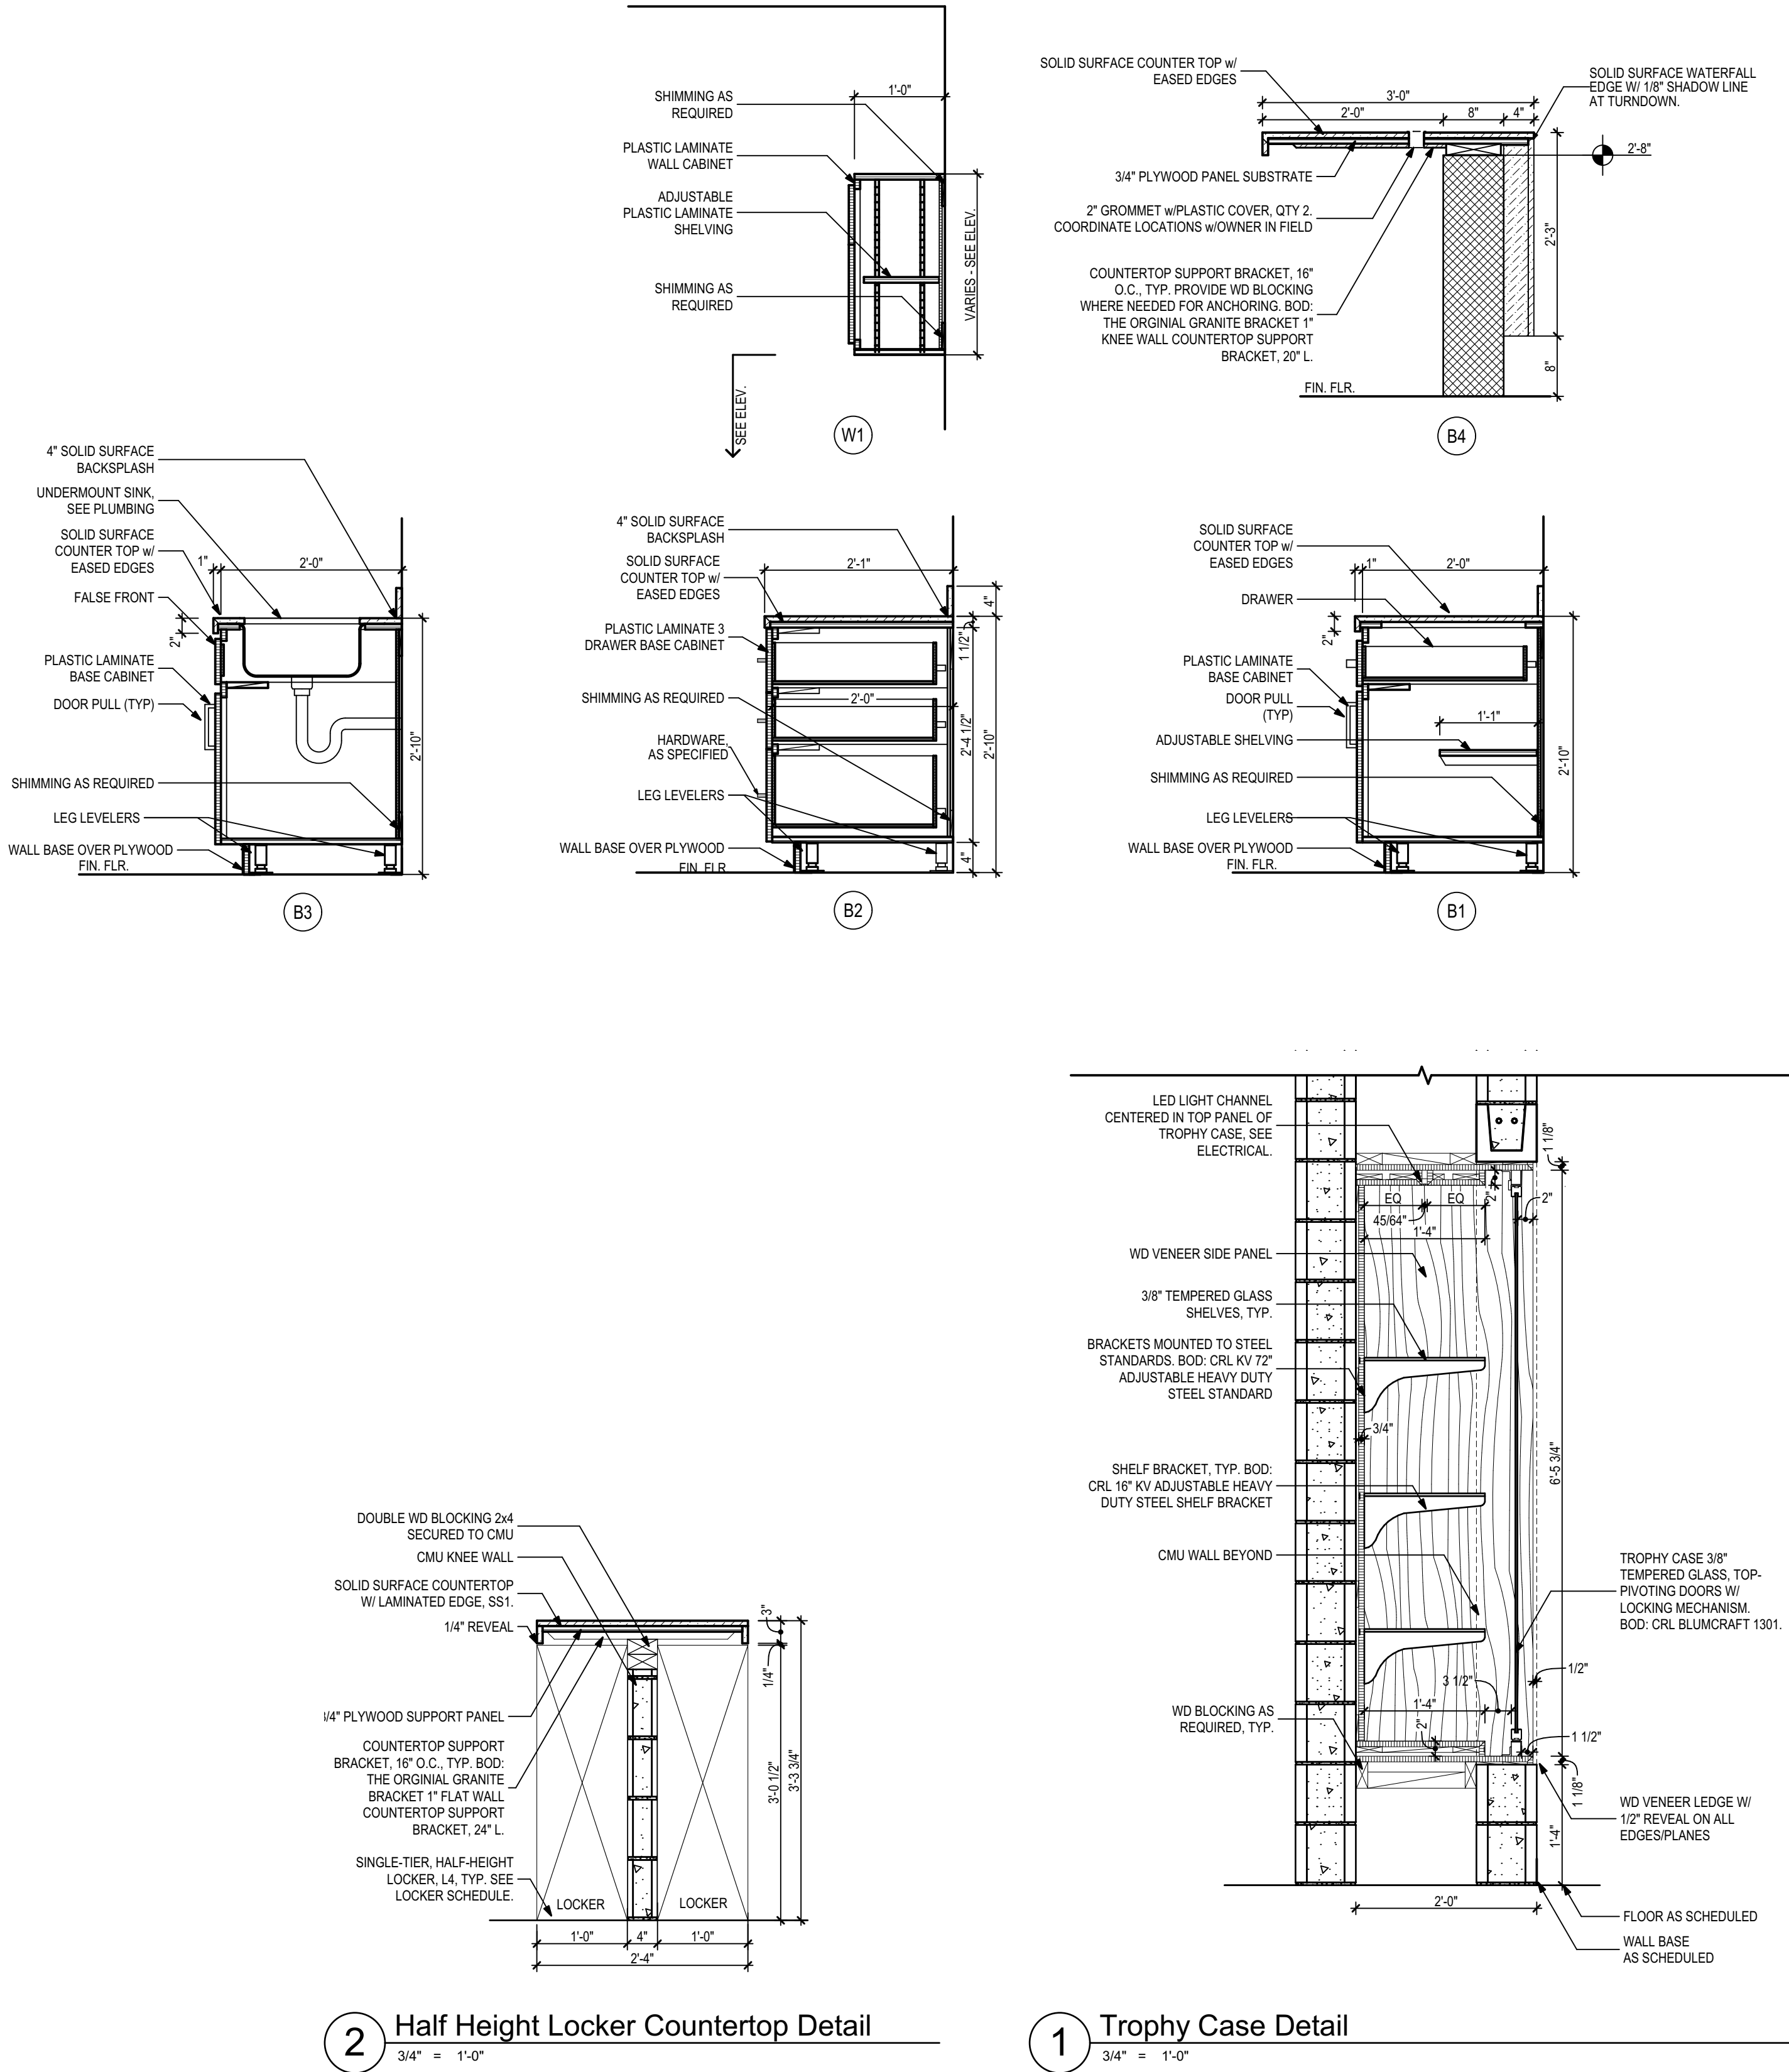

PHASE:	DRAWN:	REVIEWED:	DATE:	ID:	REVISION:	DRAWN:	REVIEWED:	DATE:
CONCEPT SCHEM. DESIGN	BG/RS	C. WHITLOCK	10/8/2024					
DESIGN DEVELOPMENT	BG/RS/MS	C. WHITLOCK	12/20/2024					
EARLY DEMOLITION PACKAGE	BG/RS/MS	C. WHITLOCK	12/20/2024					
80% CONSTRUCTION DOCS	BG/RS/MS	R. LEWIS	03/21/2025					
PERMIT DOCS	BG/RS/MS	R. LEWIS	03/21/2025					
100% CONSTRUCTION DOCS	BG/RS/MS	R. LEWIS	06/09/2025					

LEON COUNTY SCHOOLS

Client: Leon County Schools
3420 W. Tharpe St., Suite 100
Tallahassee, FL 32303

Job Title: Griffin Middle School - Phase 2
800 Alabama St. Tallahassee, FL 32304

Consultant: 23483
Project #: 100% CDs
Phase:


Seal:

These drawings and renderings are instruments of service. The drawings and associated copies thereof, including electronic media and CAD files, are the property of Architects Lewis + Whitlock, P.A.A. Their use, representation or reproduction for any purpose except that written agreement with the architect is prohibited. This copyright notification shall be true as if directly placed on each drawing exhibit, on renderings on this document and shall not be removed from these documents.

Door and Window Elevations

1/4" = 1'-0"

1/4" = 1'-0"

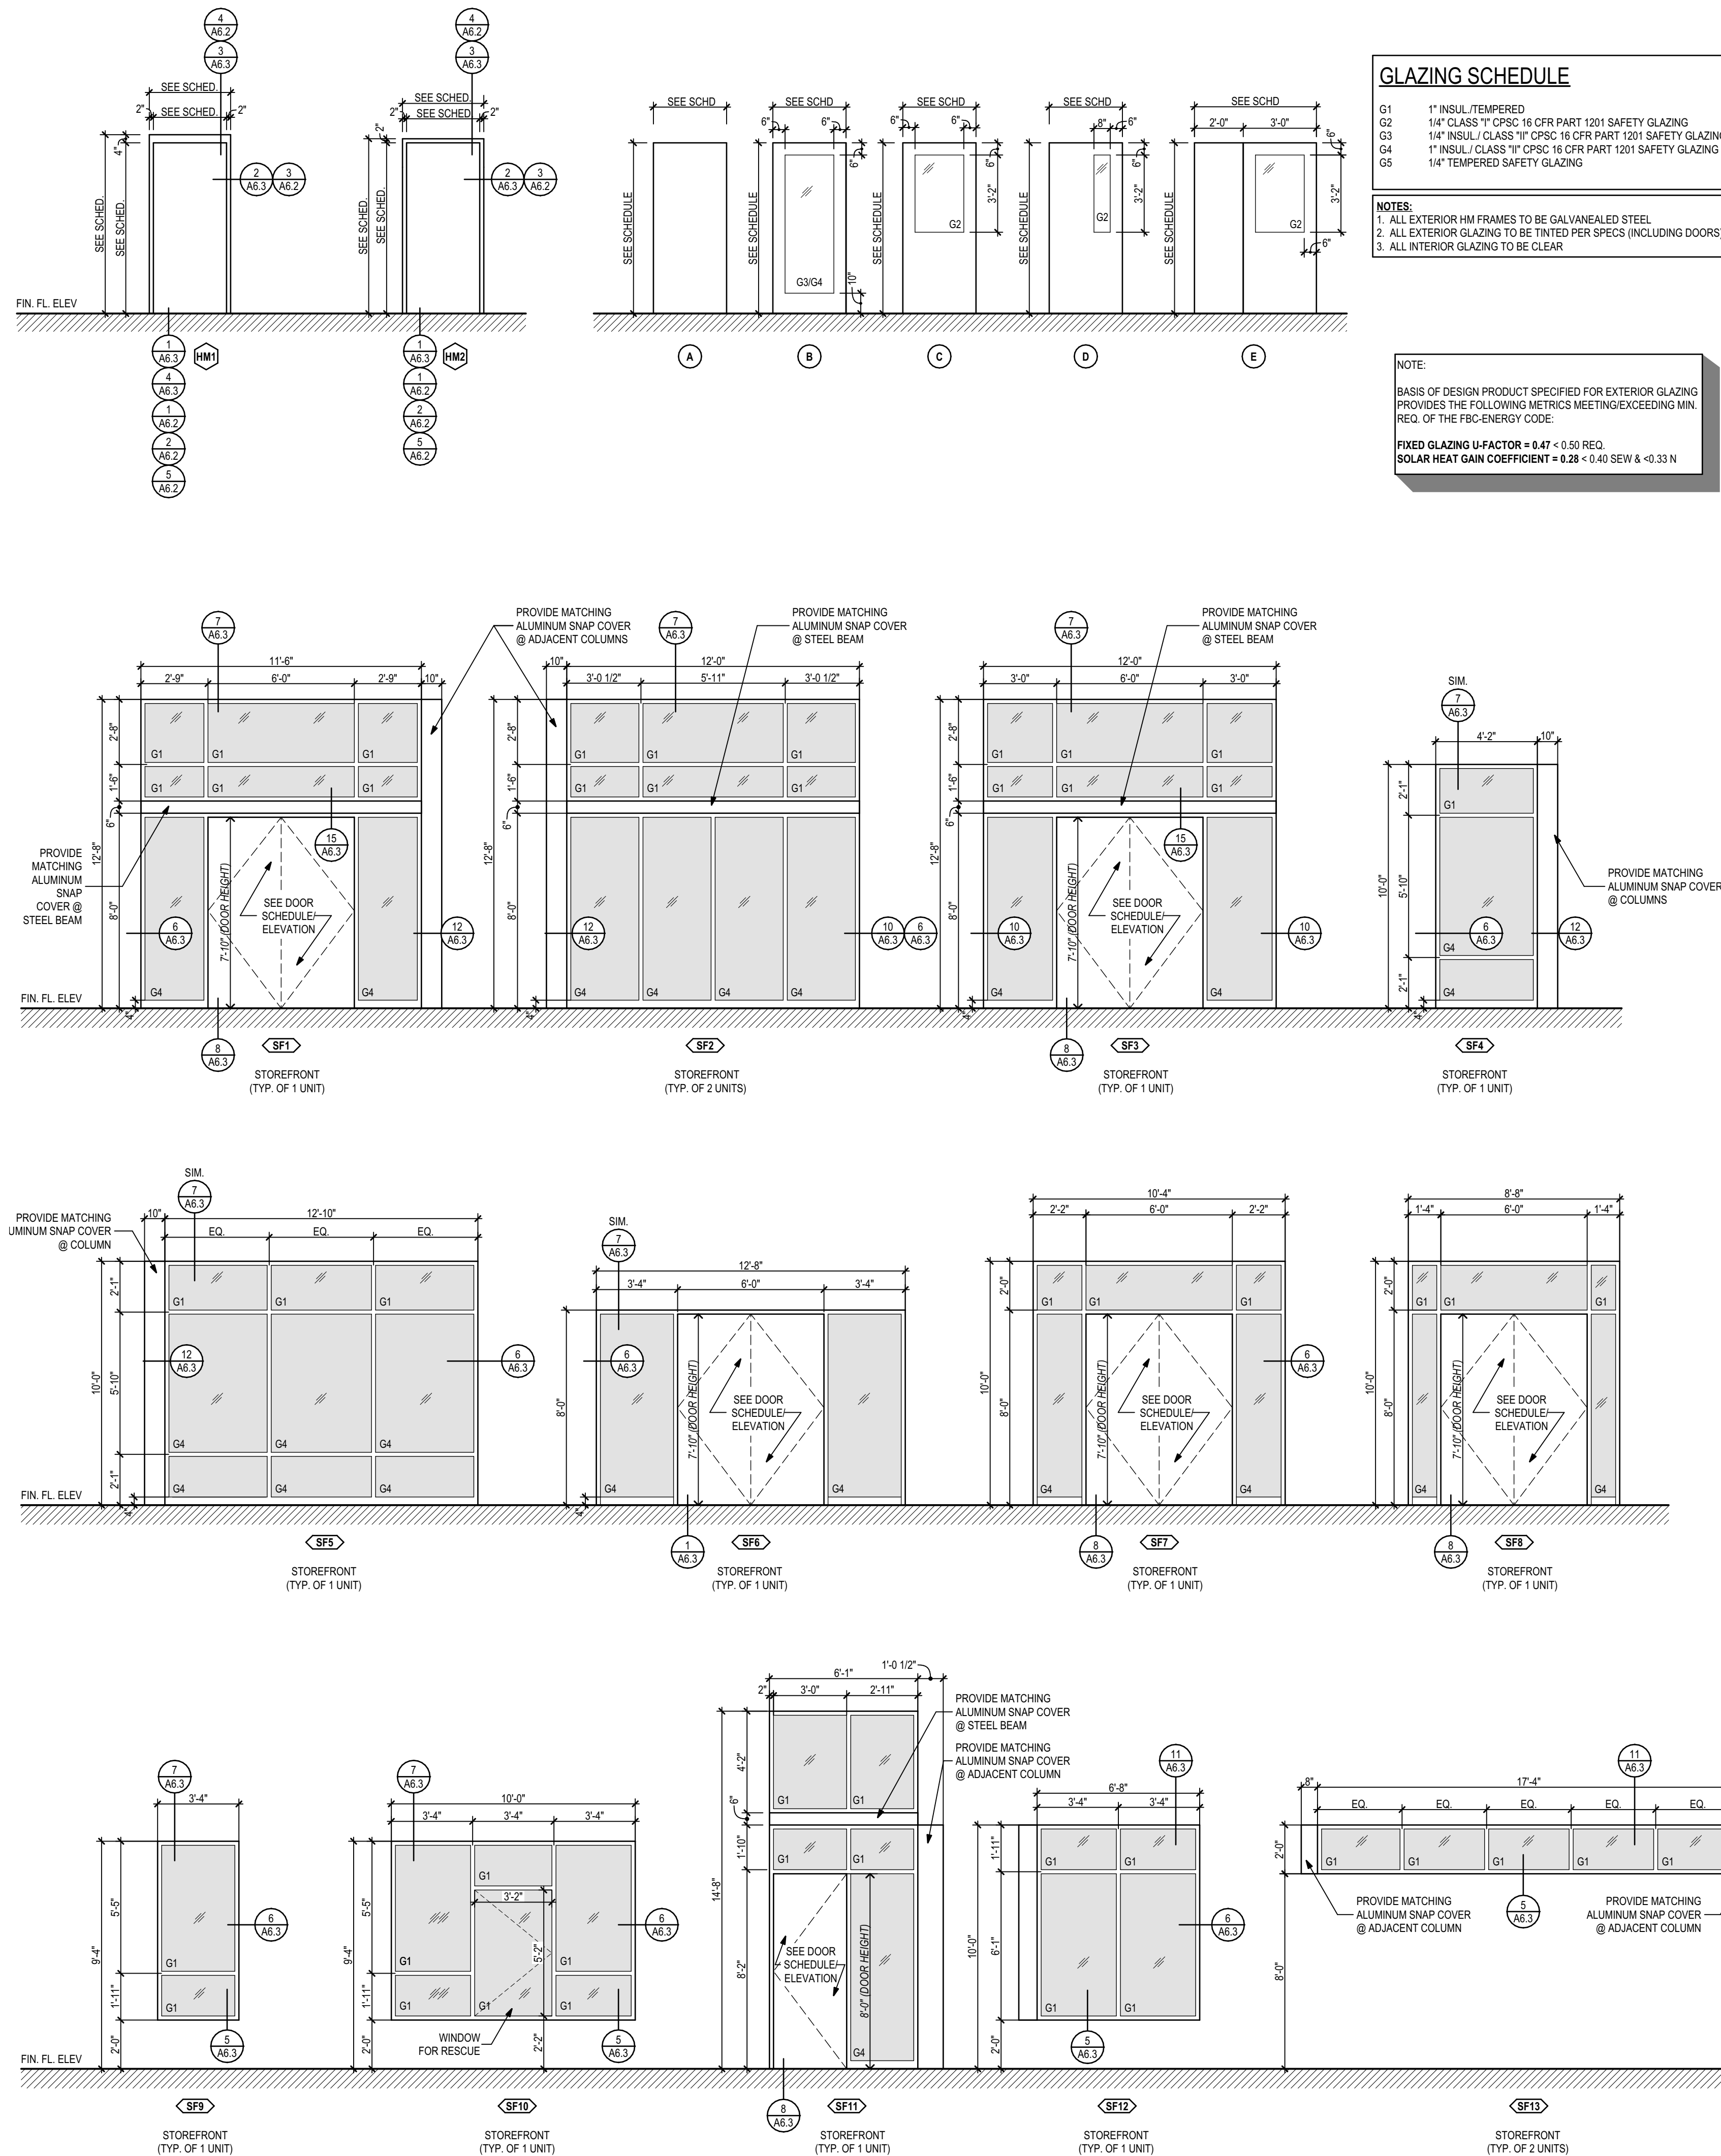


Door Schedule


Door No.	Room Name	Location	Elevation	W	HT	Material	Finish	Elevation	FRAME						Fire Rating	Hardware	Notes
									Detail			Material	Finish				
									Head	Jamb	Sill						
D100	Flam. Stor.	Exterior	A PAIR	6'-0"	7'-0"	HM	PT	HM1	3/A6.3 SIM.	2/A6.3 SIM.	4/A6.3 SIM.	HM	PT	FIRE 45 MIN.	05		
D100A	Lobby	Exterior	B PAIR	6'-0"	7'-10"	ALUM/GL	ANOD.	SF3	14/A6.3	13/A6.3	1/A6.3	ALUM	ANOD.		01	CARD READER	
D100B	Lobby	Exterior	B PAIR	6'-0"	7'-10"	ALUM/GL	ANOD.	SF1	14/A6.3	13/A6.3	1/A6.3	ALUM	ANOD.		01	CARD READER	
D100C	Inside Circ.	Exterior	B PAIR	6'-0"	7'-10"	ALUM/GL	ANOD.	SF8	1/A6.3	13/A6.3	1/A6.3	ALUM	ANOD.		01	CARD READER	
D101	Lobby	Interior	A	3'-0"	7'-0"	HM	PT	HM1	4/A6.2	3/A6.2	2/A6.2	HM	PT		20		
D101A	Stor.	Interior	A	3'-0"	7'-0"	HM	PT	HM1	4/A6.2	3/A6.2	2/A6.2	HM	PT	SMOKE	16		
D101B	Stor.	Interior	A	3'-0"	7'-0"	HM	PT	HM1	4/A6.2	3/A6.2	2/A6.2	HM	PT		17		
D101C	Concessions	Interior	OVERHEAD	8'-0"	5'-4"	HM	FACT.		11/A6.2	10/A6.2	-	HM	PT		26		
D102	I.T.	Interior	A	3'-0"	7'-0"	HM	PT	HM1	4/A6.2	3/A6.2	1/A6.2	HM	PT	SMOKE	18	CARD READER	
D103	Inside Circ.	Interior	D UNEVEN PR	5'-0"	7'-0"	HM/GL	PT	HM1	4/A6.2	3/A6.2	1/A6.2	HM	PT	SMOKE	08	CARD READER	
D103A	Unif. Storage	Interior	D UNEVEN PR	5'-0"	7'-0"	HM	PT	HM1	4/A6.2	3/A6.2	1/A6.2	HM	PT		13		
D103B	Band Classr...	Interior	C	3'-0"	7'-0"	HM/GL	PT	HM1	4/A6.2	3/A6.2	2/A6.2	HM	PT		25		
D103C	Band Classr...	Interior	C	3'-0"	7'-0"	HM/GL	PT	HM1	4/A6.2	3/A6.2	2/A6.2	HM	PT		25		
D103D	Ref. Room	Interior	A	3'-0"	7'-0"	HM	PT	HM1	4/A6.2	3/A6.2	2/A6.2	HM	PT		17		
D103E	Band Classr...	Exterior	B	3'-0"	8'-0"	ALUM/GL	ANOD.	SF11	14/A6.3 SIM.	13/A6.3	1/A6.3	ALUM	ANOD.		02	CARD READER	
D104	RR - F	Interior	A	3'-0"	7'-0"	HM	PT	HM1	4/A6.2	3/A6.2	2/A6.2	HM	PT		24		
D105	Inside Circ.	Interior	A	3'-0"	7'-0"	HM	PT	HM1	4/A6.2	3/A6.2	2/A6.2	HM	PT	SMOKE	19		
D106	RR - Fam.	Interior	A	3'-0"	7'-0"	HM	PT	HM1	4/A6.2	3/A6.2	2/A6.2	HM	PT		23		
D107	RR - M	Interior	A	3'-0"	7'-0"	HM	PT	HM1	4/A6.2	3/A6.2	2/A6.2	HM	PT		24		
D108	Inside Circ.	Interior	D UNEVEN PR	5'-0"	7'-0"	HM/GL	PT	HM1	4/A6.2	3/A6.2	1/A6.2	HM	PT	SMOKE	08	CARD READER	
D109	Mech.	Exterior	A PAIR	6'-0"	7'-0"	HM	PT	HM1	3/A6.3	2/A6.3	4/A6.3	HM	PT		03	INS., CARD READER	
D110A	Inside Circ.	Interior	D PAIR	6'-0"	7'-10"	HM/GL	PT	HM2	4/A6.2	3/A6.2	1/A6.2	HM	PT	SMOKE	07	2 SETS	
D110B	Inside Circ.	Interior	D PAIR	6'-0"	7'-10"	HM/GL	PT	HM2	4/A6.2	3/A6.2	1/A6.2	HM	PT	SMOKE	07	2 SETS	
D110C	Ins. Circ.	Interior	D PAIR	6'-0"	7'-10"	HM/GL	PT	HM2	4/A6.2	3/A6.2	1/A6.2	HM	PT	SMOKE	07		
D110D	Ins. Circ.	Interior	D PAIR	6'-0"	7'-10"	HM/GL	PT	HM2	4/A6.2	3/A6.2	1/A6.2	HM	PT	SMOKE	07		
D111A	Ins. Circ.	Exterior	B PAIR	6'-0"	7'-10"	ALUM/GL	ANOD.	SF6	14/A6.3 SIM.	13/A6.3	1/A6.3	ALUM	ANOD.		01	CARD READER	
D111B	Ins. Circ.	Exterior	B PAIR	6'-0"	7'-10"	ALUM/GL	ANOD.	SF7	14/A6.3 SIM.	13/A6.3	1/A6.3	ALUM	ANOD.		01	CARD READER	
D111C	Ins. Circ.	Interior	D PAIR	6'-0"	7'-10"	HM/GL	PT	HM2	4/A6.2	3/A6.2	2/A6.2	HM	PT	SMOKE	09		
D112	Ins. Circ.	Interior	A	3'-0"	7'-0"	HM	PT	HM1	4/A6.2	3/A6.2	2/A6.2	HM	PT	SMOKE	14		
D112A	Laundry	Interior	A	3'-0"	7'-0"	HM	PT	HM1	4/A6.2	3/A6.2	2/A6.2	HM	PT		16		
D112B	P.E. Teache...	Interior	C	3'-0"	7'-0"	HM/GL	PT	HM1	4/A6.2	3/A6.2	2/A6.2	HM	PT		17		
D112C	Shwr. - F	Interior	A	3'-0"	7'-0"	HM	PT	HM1	4/A6.2	3/A6.2	1/A6.2	HM	PT		22		
D112E	P.E. Shwr. - F	Interior	A	3'-0"	7'-0"	HM	PT	HM1	4/A6.2	3/A6.2	1/A6.2	HM	PT		21		
D112F	Vestibule	Interior	A	3'-0"	7'-0"	HM	PT	HM1	4/A6.2	3/A6.2	2/A6.2	HM	PT	SMOKE	15		
D112G	Vestibule	Exterior	A	3'-0"	7'-0"	HM	PT	HM1	3/A6.3	2/A6.3	1/A6.3	HM	PT	FIRE 45 MIN.	06	INS., CARD READER	
D113	Ins. Circ.	Interior	A PAIR	6'-0"	7'-0"	HM	PT	HM1	4/A6.2	3/A6.2	1/A6.2	HM	PT	SMOKE	10	CARD READER	
D114	P.E. Equip. - F	Interior	A UNEVEN PR	5'-0"	7'-0"	HM	PT	HM1	4/A6.2	3/A6.2	2/A6.2	HM	PT	SMOKE	12		
D115	P.E. Equip. - ...	Interior	A UNEVEN PR	5'-0"	7'-0"	HM	PT	HM1	4/A6.2	3/A6.2	2/A6.2	HM	PT	SMOKE	12		
D116	Ins. Circ.	Interior	A	3'-0"	7'-0"	HM	PT	HM1	4/A6.2	3/A6.2	2/A6.2	HM	PT	SMOKE	14		
D116A	Laundry	Interior	A	3'-0"	7'-0"	HM	PT	HM1	4/A6.2	3/A6.2	2/A6.2	HM	PT		16		
D116B	P.E. Teache...	Interior	C	3'-0"	7'-0"	HM/GL	PT	HM1	4/A6.2	3/A6.2	2/A6.2	HM	PT		17		
D116C	Shwr. - M	Interior	A	3'-0"	7'-0"	HM	PT	HM1	4/A6.2	3/A6.2	1/A6.2	HM	PT		21		
D116E	P.E. Shwr. - M	Interior	A	3'-0"	7'-0"	HM	PT	HM1	4/A6.2	3/A6.2	1/A6.2	HM	PT		22		
D116F	Vestibule	Interior	A	3'-0"	7'-0"	HM	PT	HM1	4/A6.2	3/A6.2	2/A6.2	HM	PT	SMOKE	15		
D116G	Vestibule	Exterior	A	3'-0"	7'-0"	HM	PT	HM1	3/A6.3	2/A6.3	1/A6.3	HM	PT	FIRE 45 MIN.	06	INS., CARD READER	
D117	Ins. Circ.	Interior	D	3'-0"	7'-0"	HM/GL	PT	HM1	4/A6.2	3/A6.2	1/A6.2	HM	PT	SMOKE	16		
D117A	First Aid	Interior	D	3'-0"	7'-0"	HM/GL	PT	HM1	4/A6.2	3/A6.2	2/A6.2	HM	PT		17		
D118	Elec.	Exterior	A PAIR	6'-0"	7'-0"	HM	PT	HM1	3/A6.3	2/A6.3	4/A6.3	HM	PT		04	INS., CARD READER	
D119	Ins. Circ.	Interior	A	3'-0"	7'-0"	HM	PT	HM1	4/A6.2	3/A6.2	2/A6.2	HM	PT	SMOKE	20		
D200	Mech. Mezz.	Exterior	A PAIR	6'-0"	7'-0"	HM	PT	HM1	10/A6.3	9/A6.3	-	HM	PT		03	INS., CARD READER	

ABBREVIATION LEGEND:


HM	HOLLOW METAL (SEE FRAME ELEVATIONS OR SPECS FOR TYPE)
ALUM	ALUMINUM
SF-	STOREFRONT
ANOD	ANODIZED (SEE SPECS FOR TYPE/COLOR)
PT	PAINT (OVER FACTORY PRIME PER SPEC)

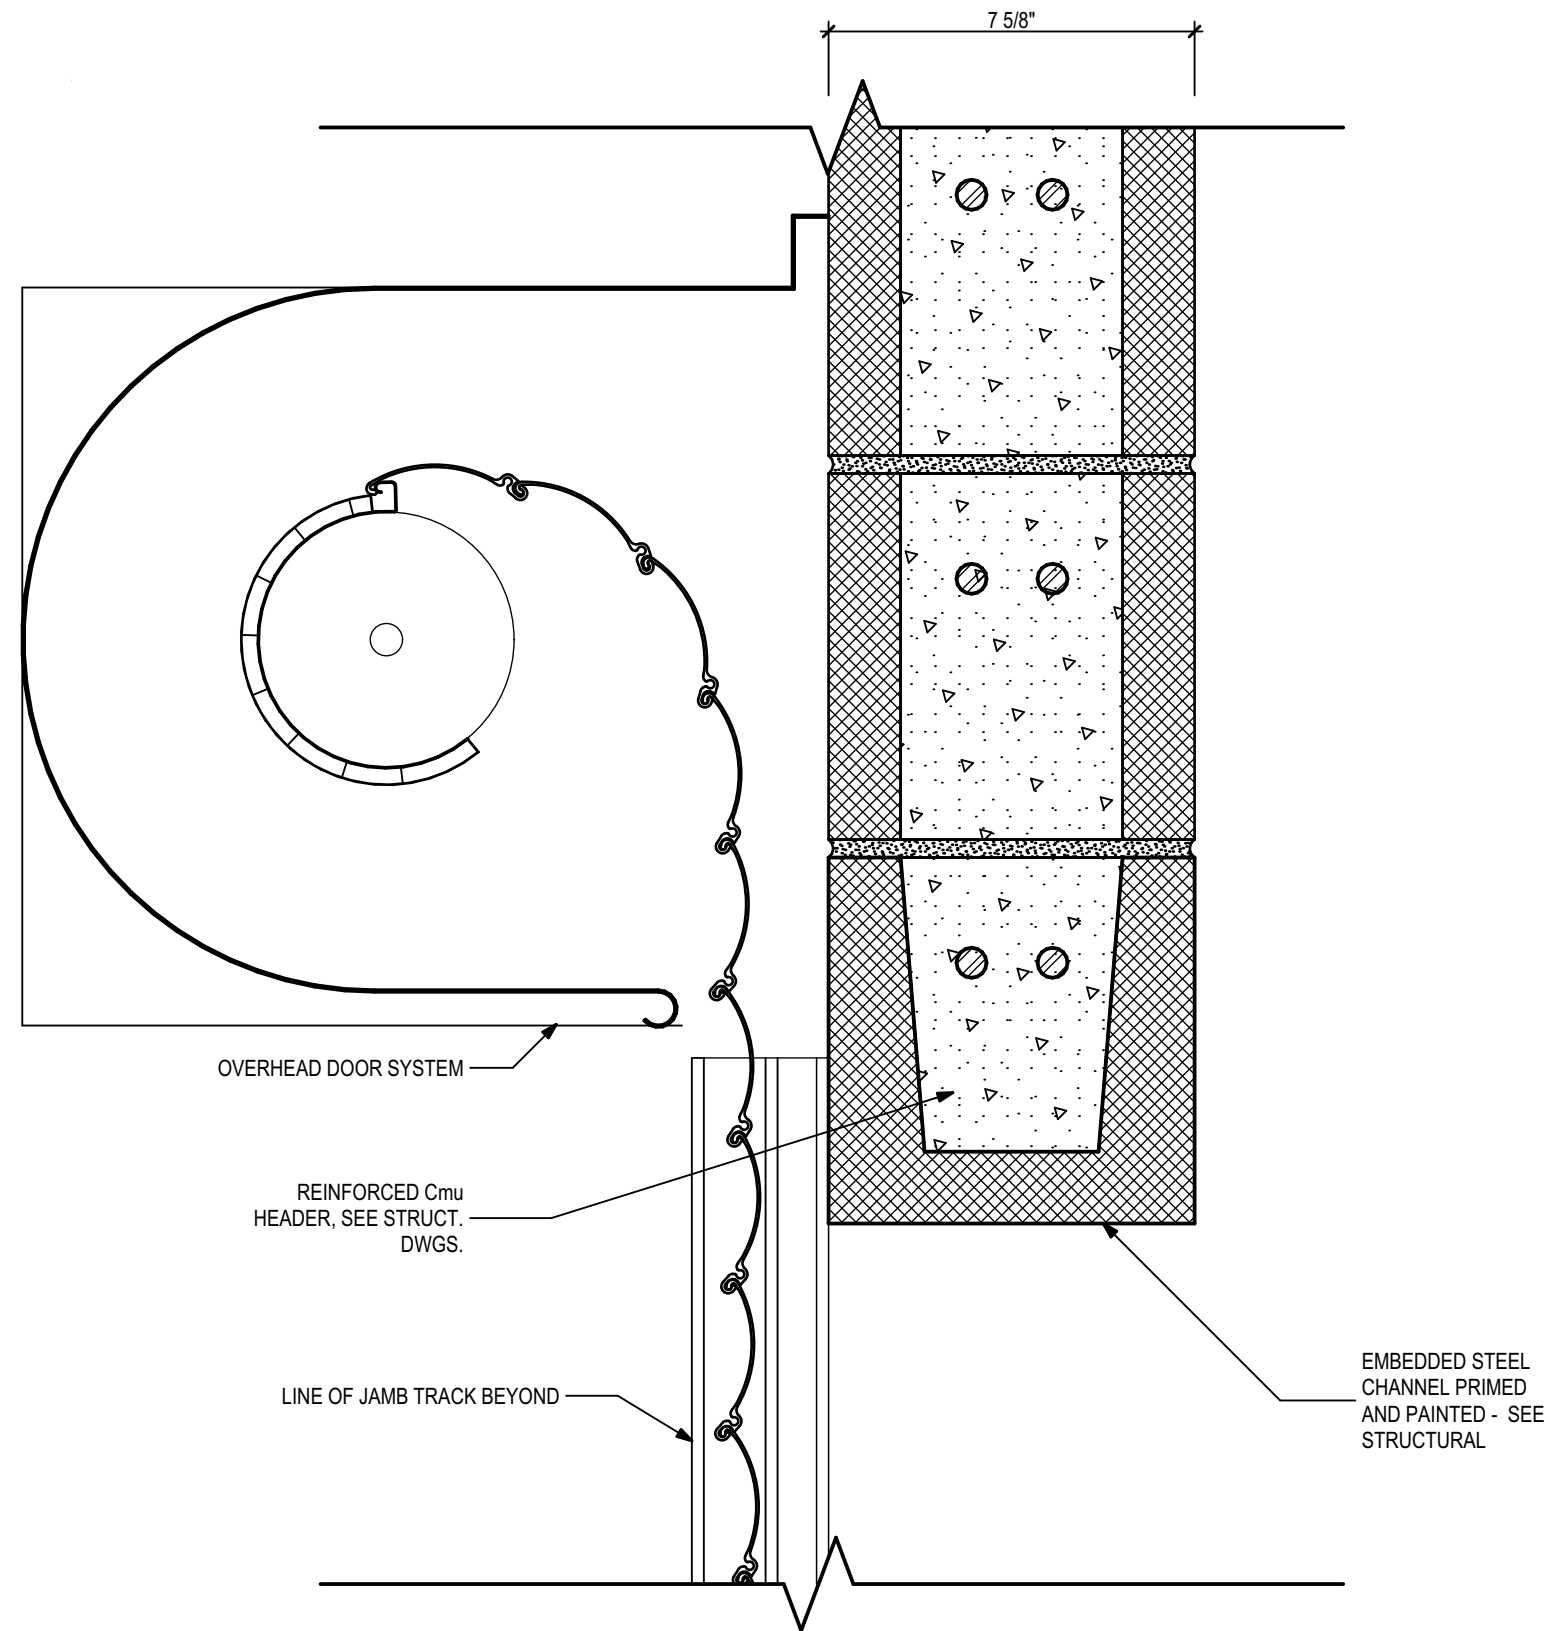


11 Interior Roll-Up Door - CMU Head
3" = 1'-0"

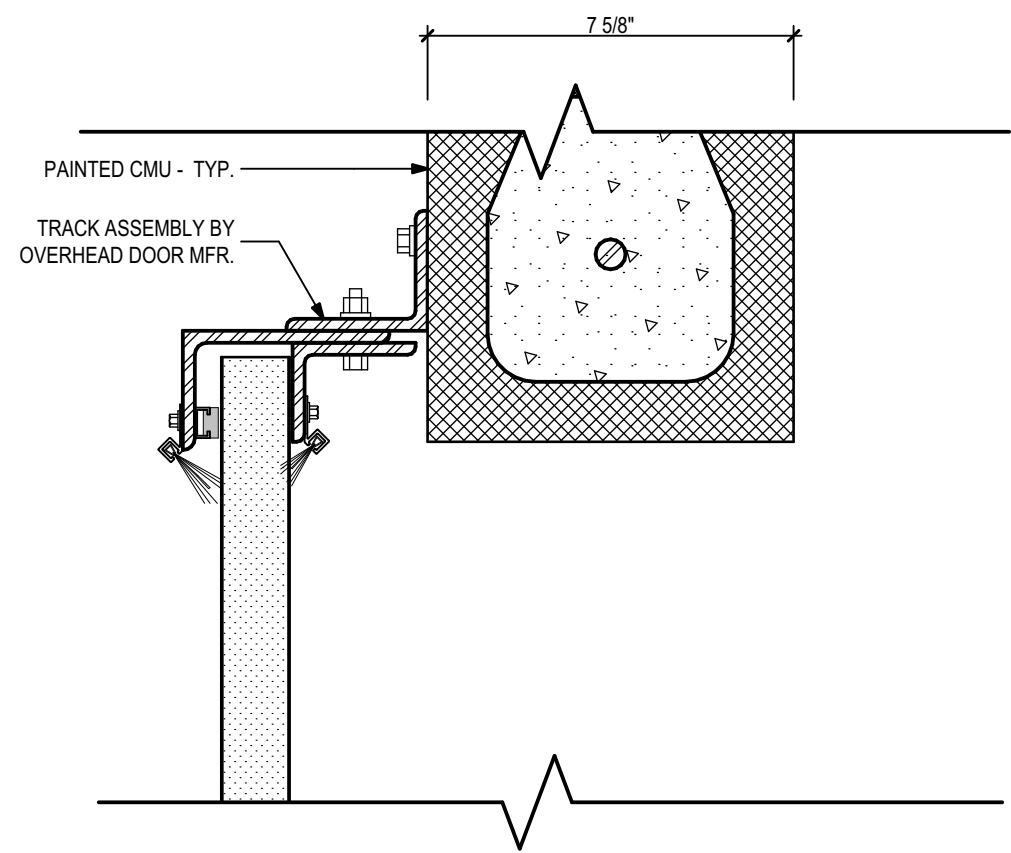


10 Interior Roll-Up Door - CMU Jamb
3" = 1'-0"

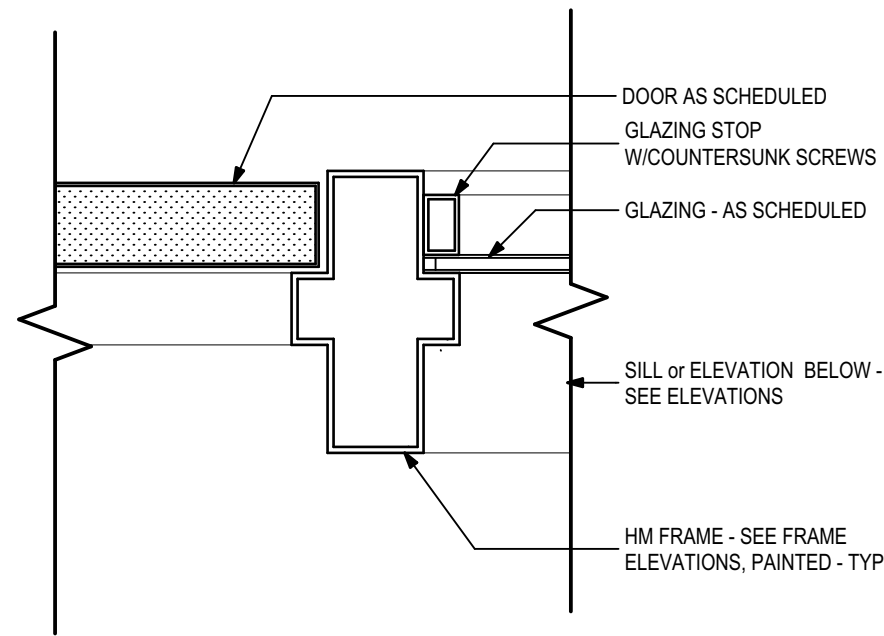


9 Interior HM Window Jamb @ Mtl. Door
3" = 1'-0"

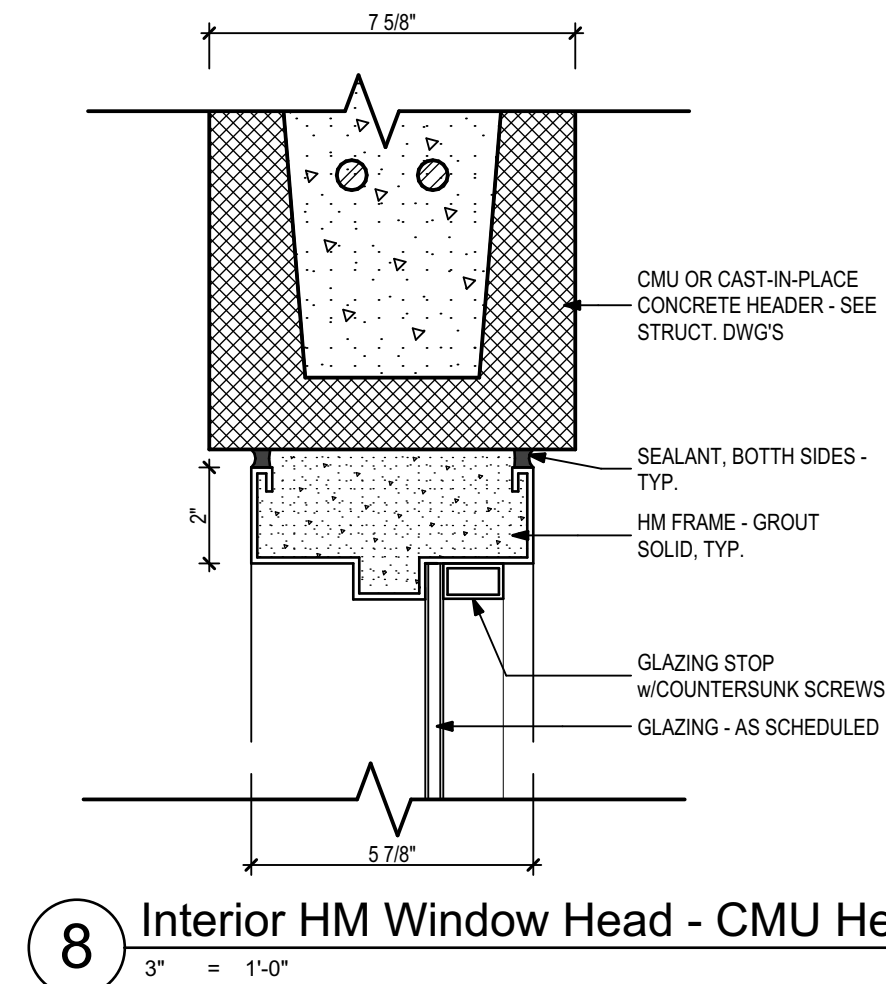


8 Interior HM Window Head - CMU Header
3" = 1'-0"

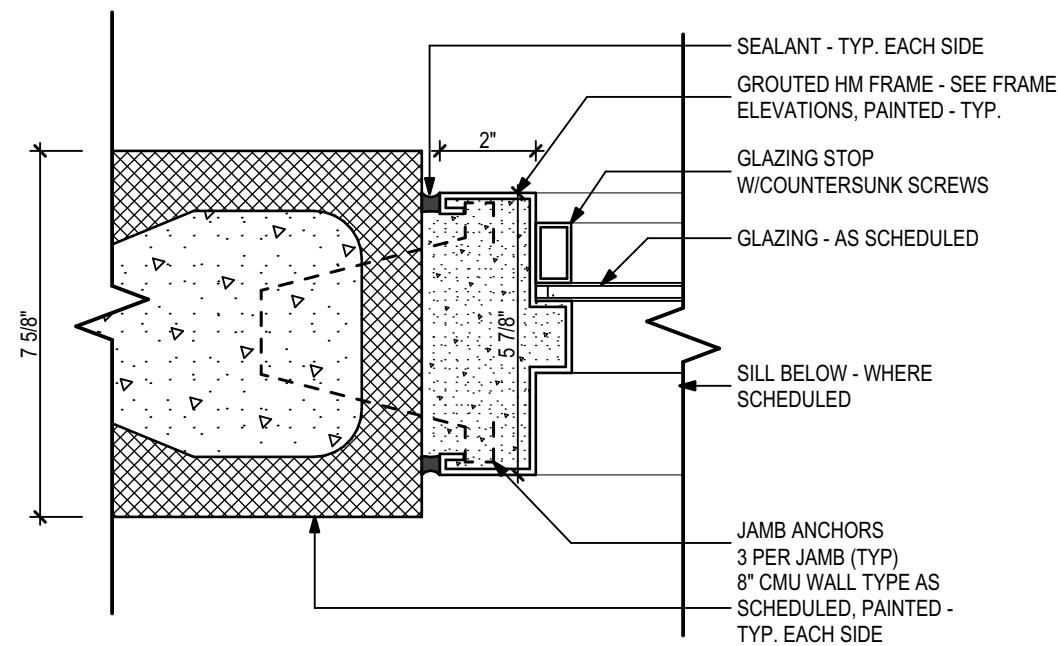


7 Interior HM Window Jamb - CMU
3" = 1'-0"

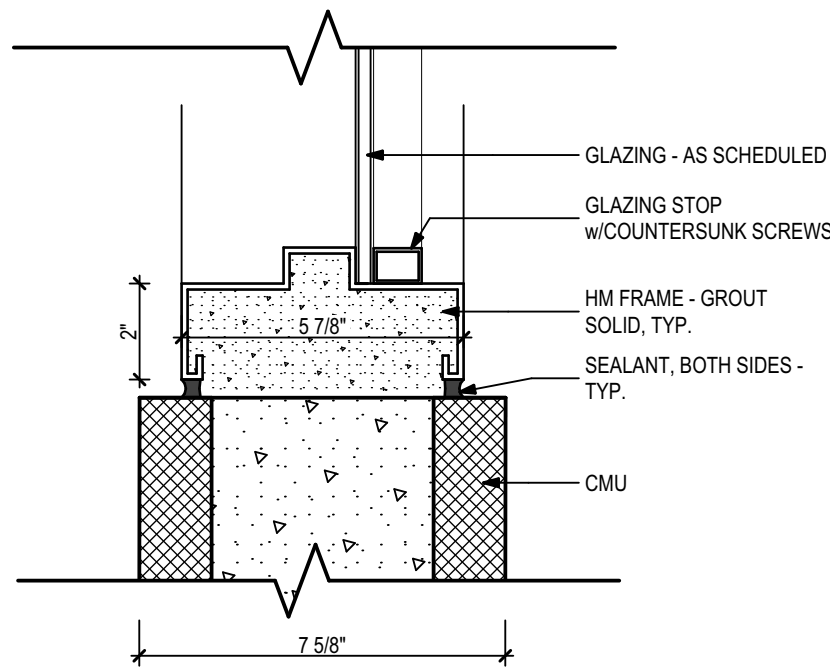


6 Interior HM Window Sill - CMU
3" = 1'-0"

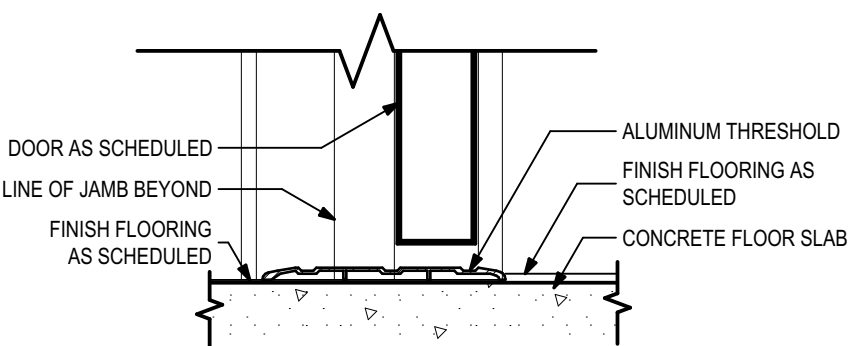


5 Interior Door - Rated Wall
3" = 1'-0"

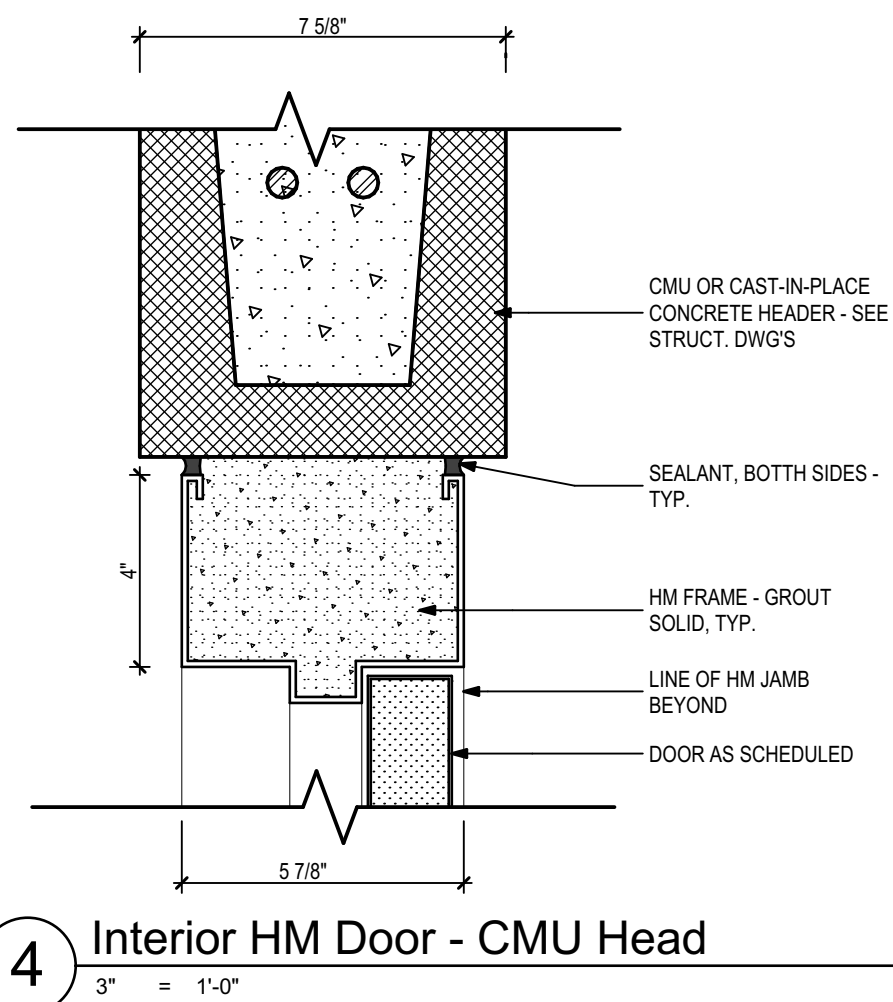


4 Interior HM Door - CMU Head
3" = 1'-0"

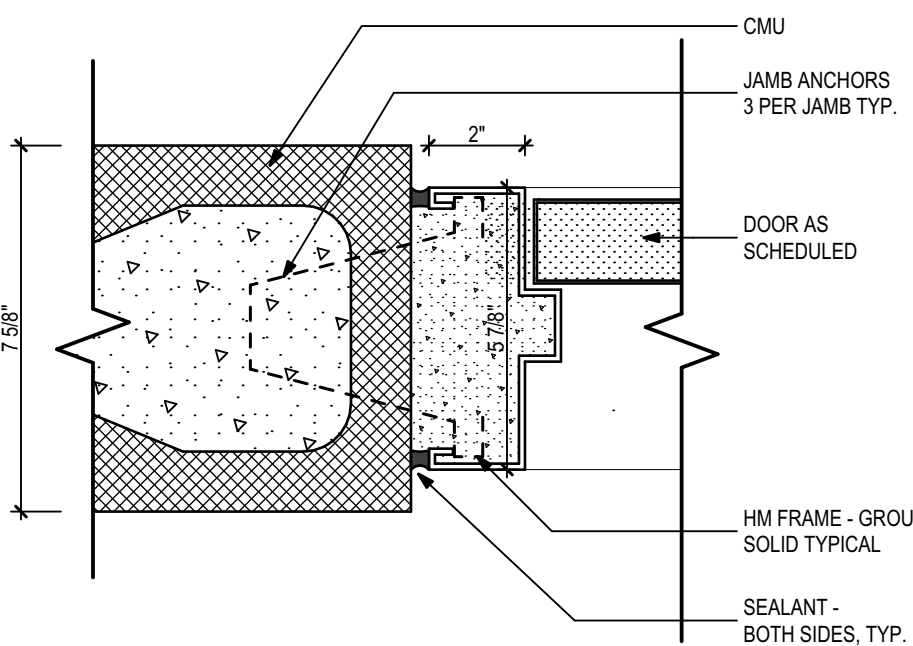

3 Interior HM Door - CMU Jamb
3" = 1'-0"

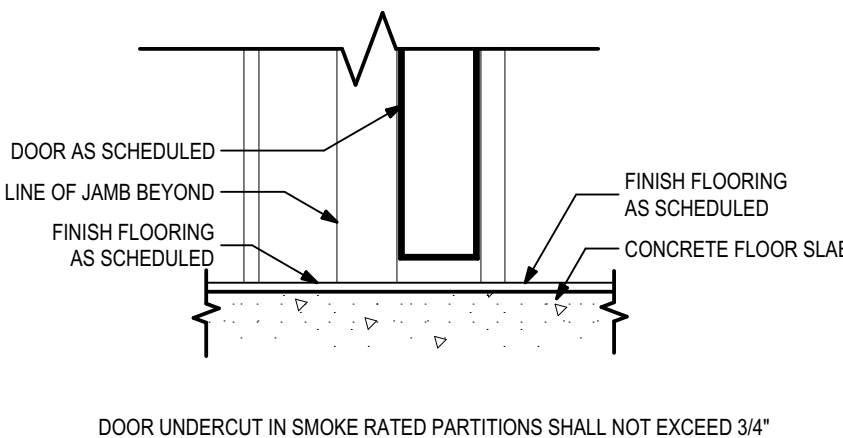

2 Interior Door - No Transition
3" = 1'-0"

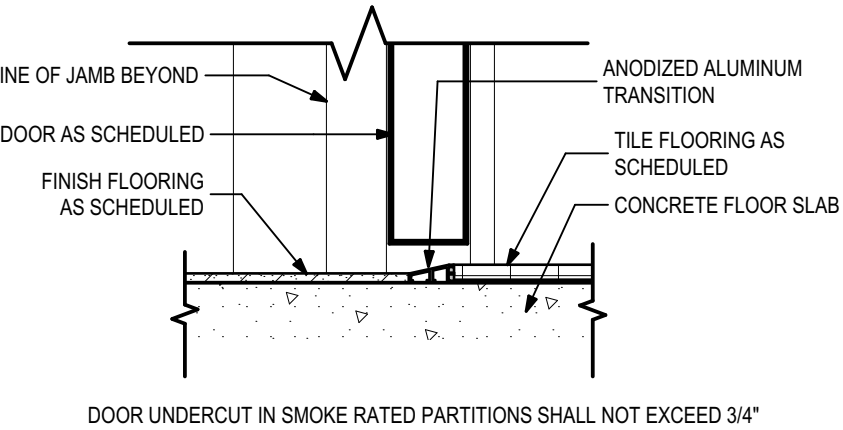

1 Interior Door - Transition
3" = 1'-0"

PHASE:	DRAWN:	REVIEWED:	DATE:	ID:	REVISION:	DRAWN:	REVIEWED:	DATE:
CONCEPT SCHEM. DESIGN	BG/RS	C. WHITLOCK	10/8/2024					
DESIGN DEVELOPMENT	BG/RS/SIMS	C. WHITLOCK	12/20/2024					
EARLY DEMOLITION PACKAGE								
80% CONSTRUCTION DOCS	BG/RS/SIMS	R. LEWIS	03/21/2025					
PERMIT DOCS								
100% CONSTRUCTION DOCS	BG/RS/SIMS	R. LEWIS	06/09/2025					


Seal:	Consultant:	Client:	 Leon County Schools 3420 W. Tharpe St., Suite 100 Tallahassee, FL 32303
Project #:	23483	Job Title:	Griffin Middle School - Phase 2
Phase:	100% CDs		800 Alabama St. Tallahassee, FL 32304




Architects Lewis + Whitlock
206 West Virginia St.
Tallahassee, Florida 32301
850.942.1718
www.think3d.net

Description:
**Door & Window
Details - Interior**


Sheet No.:
A6.2

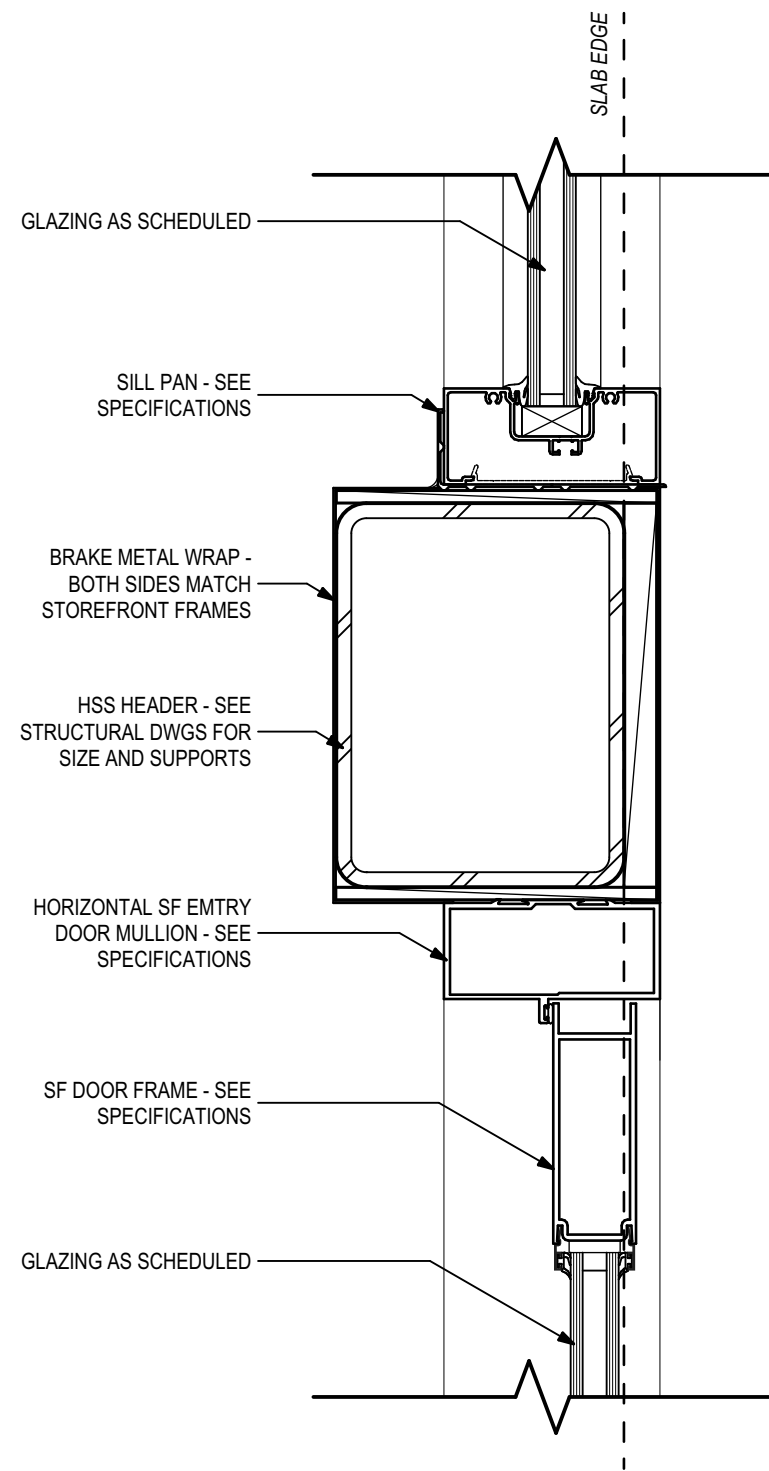


15 Exterior - Storefront Transom - Head
3" = 1'-0"

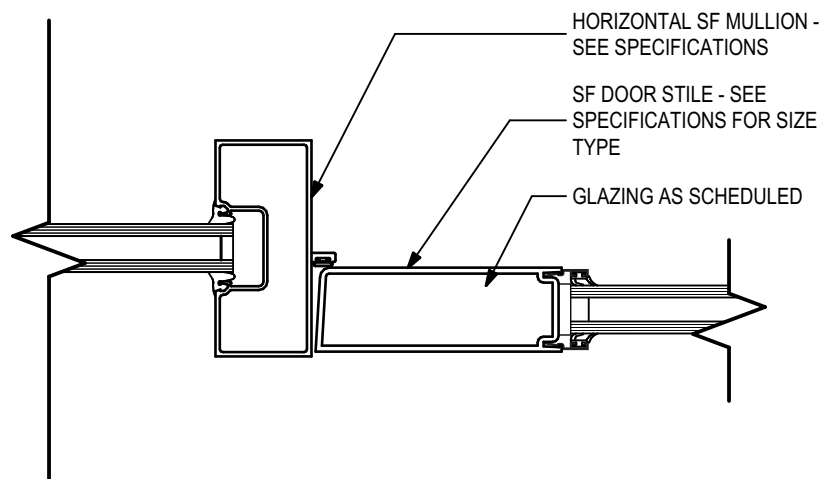


14 Exterior - Storefront Door - Jamb
3" = 1'-0"

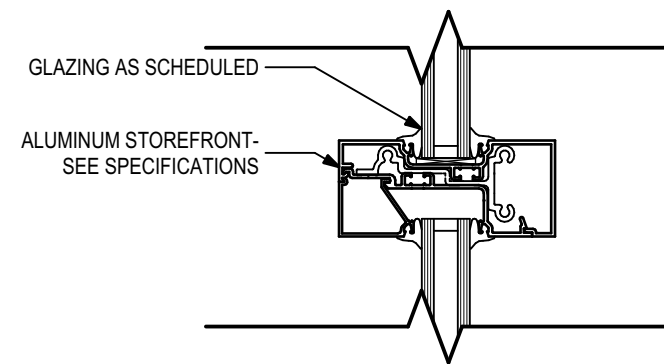


13 Exterior - Storefront Horizontal Mullion
3" = 1'-0"

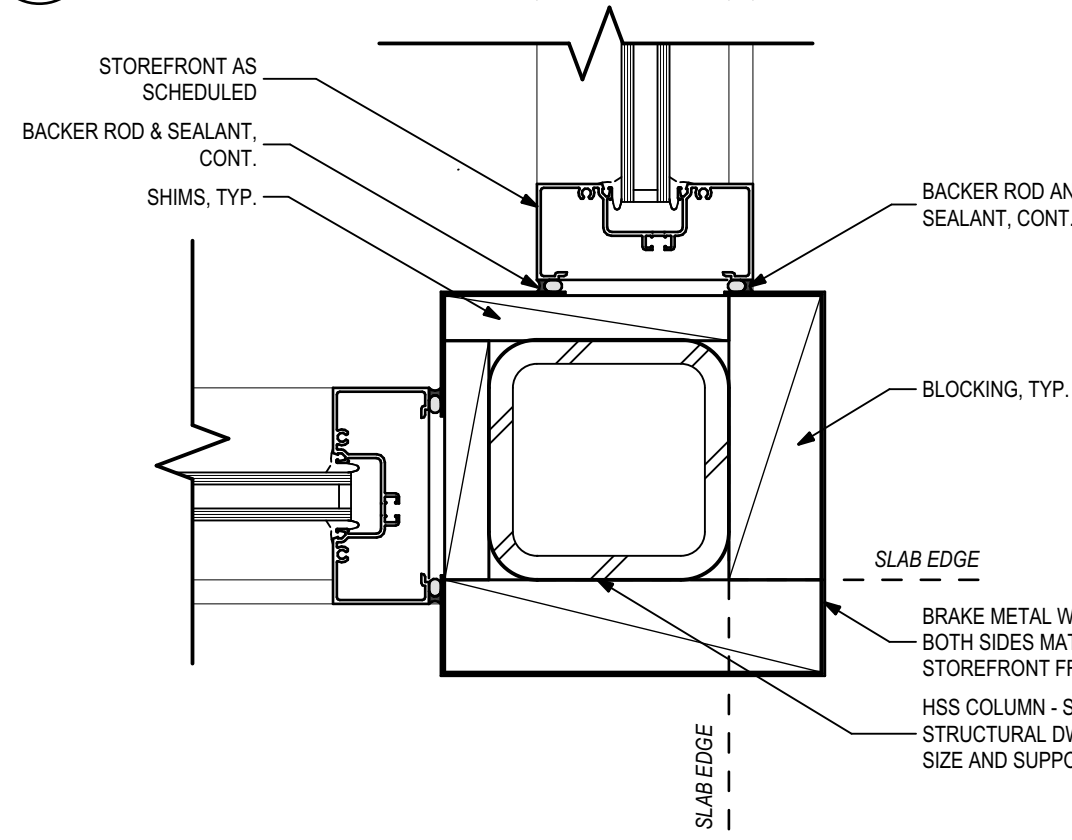


12 Exterior - Storefront Corner @ Lobby
3" = 1'-0"

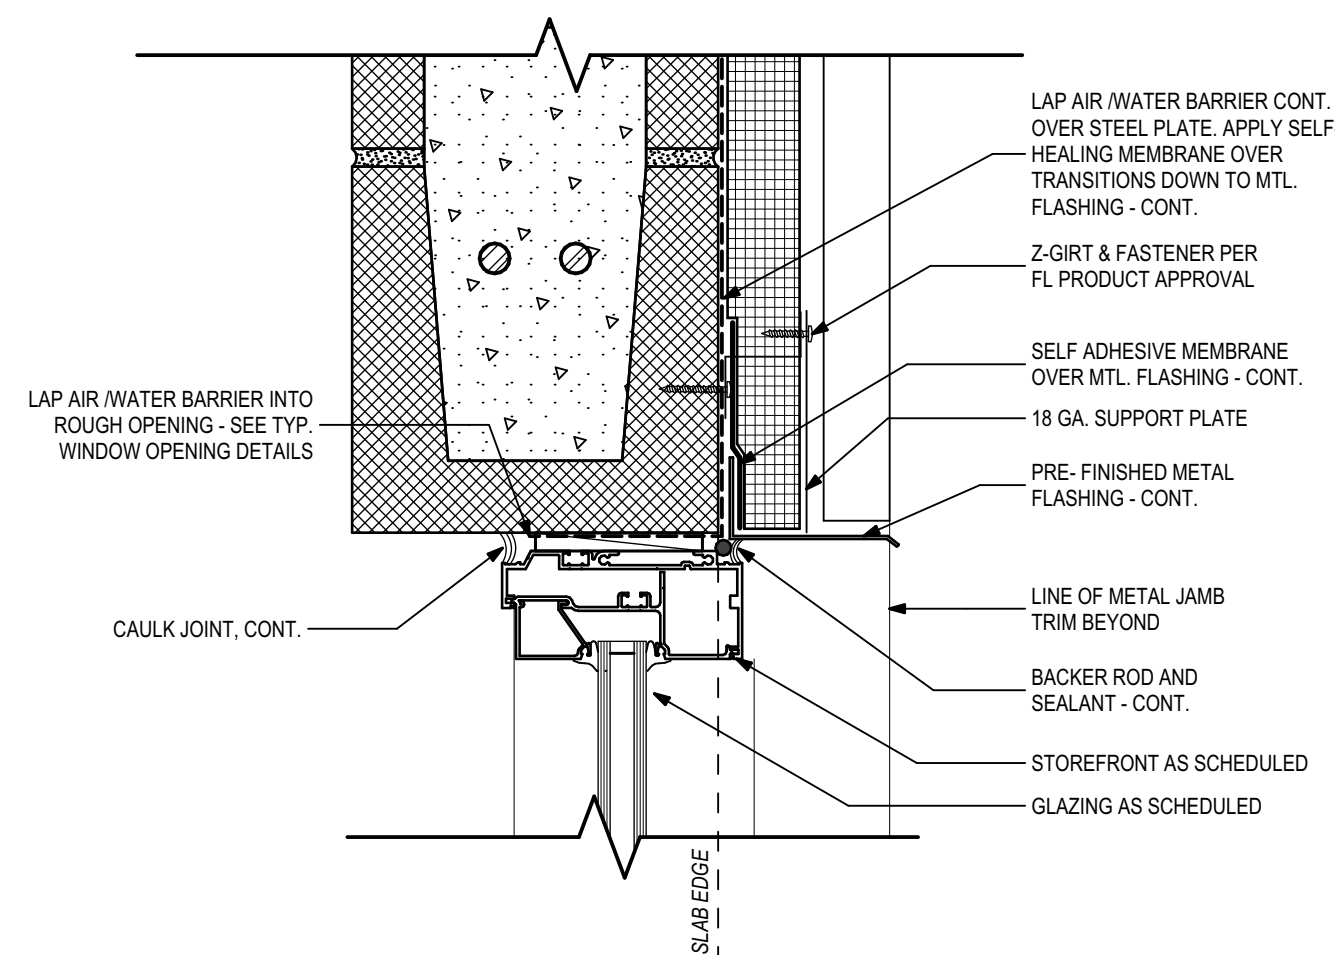


11 Exterior - Storefront @ Metal Panel - Head
3" = 1'-0"

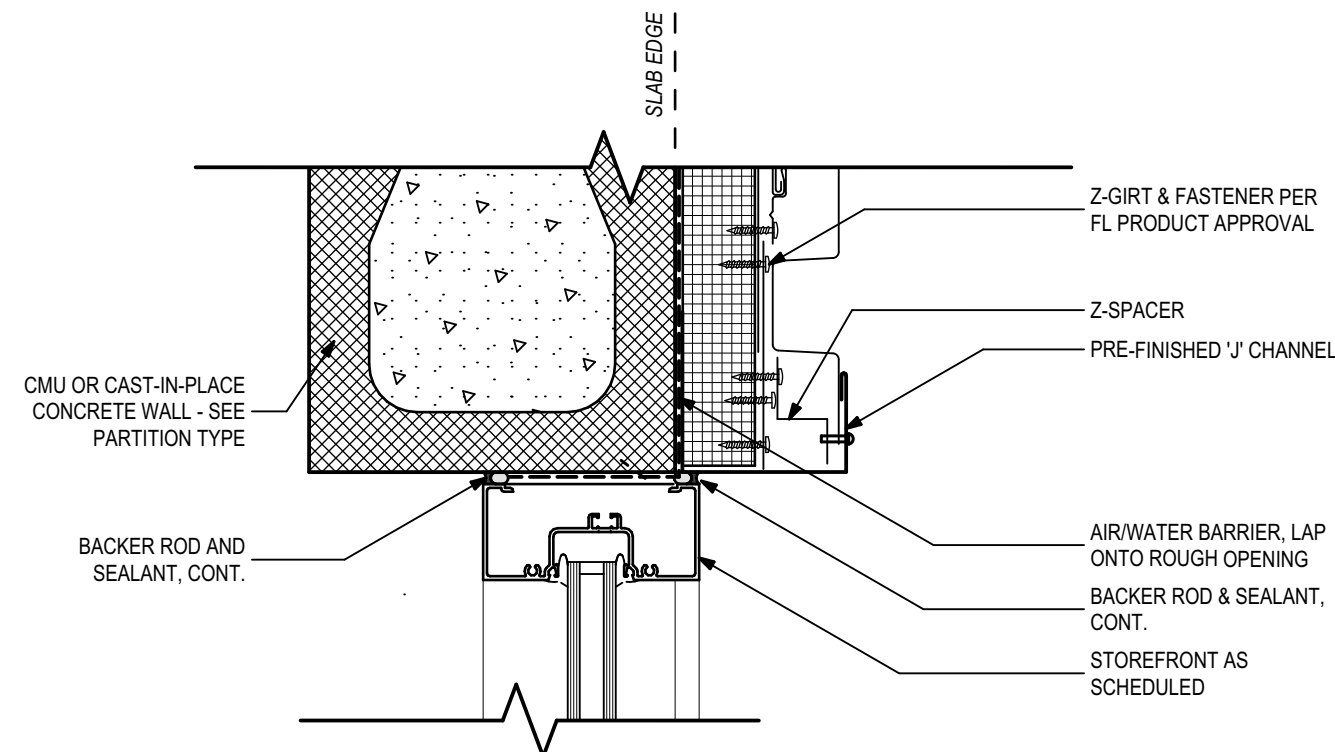


10 Exterior - Storefront @ Metal Panel - Jamb
3" = 1'-0"

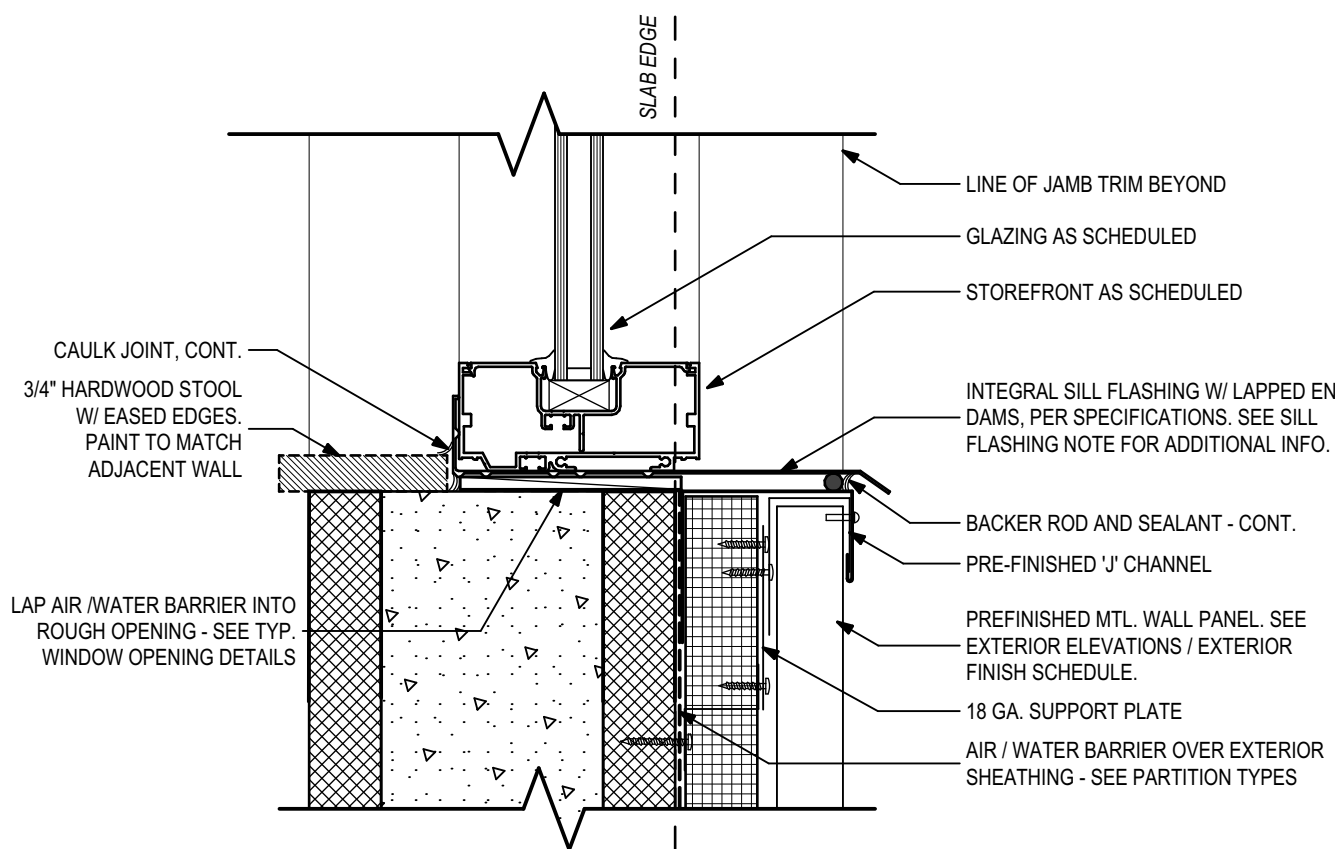


9 Exterior - Storefront @ Metal Panel - Sill
3" = 1'-0"

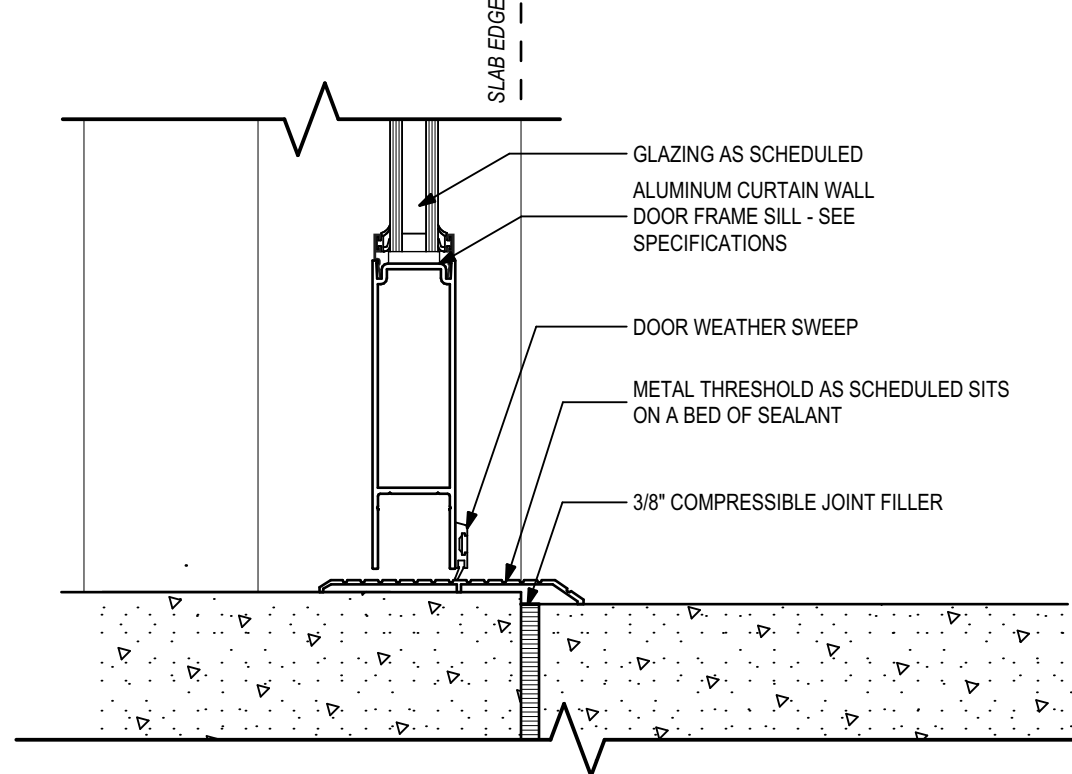


8 Exterior - Storefront Door Threshold
3" = 1'-0"

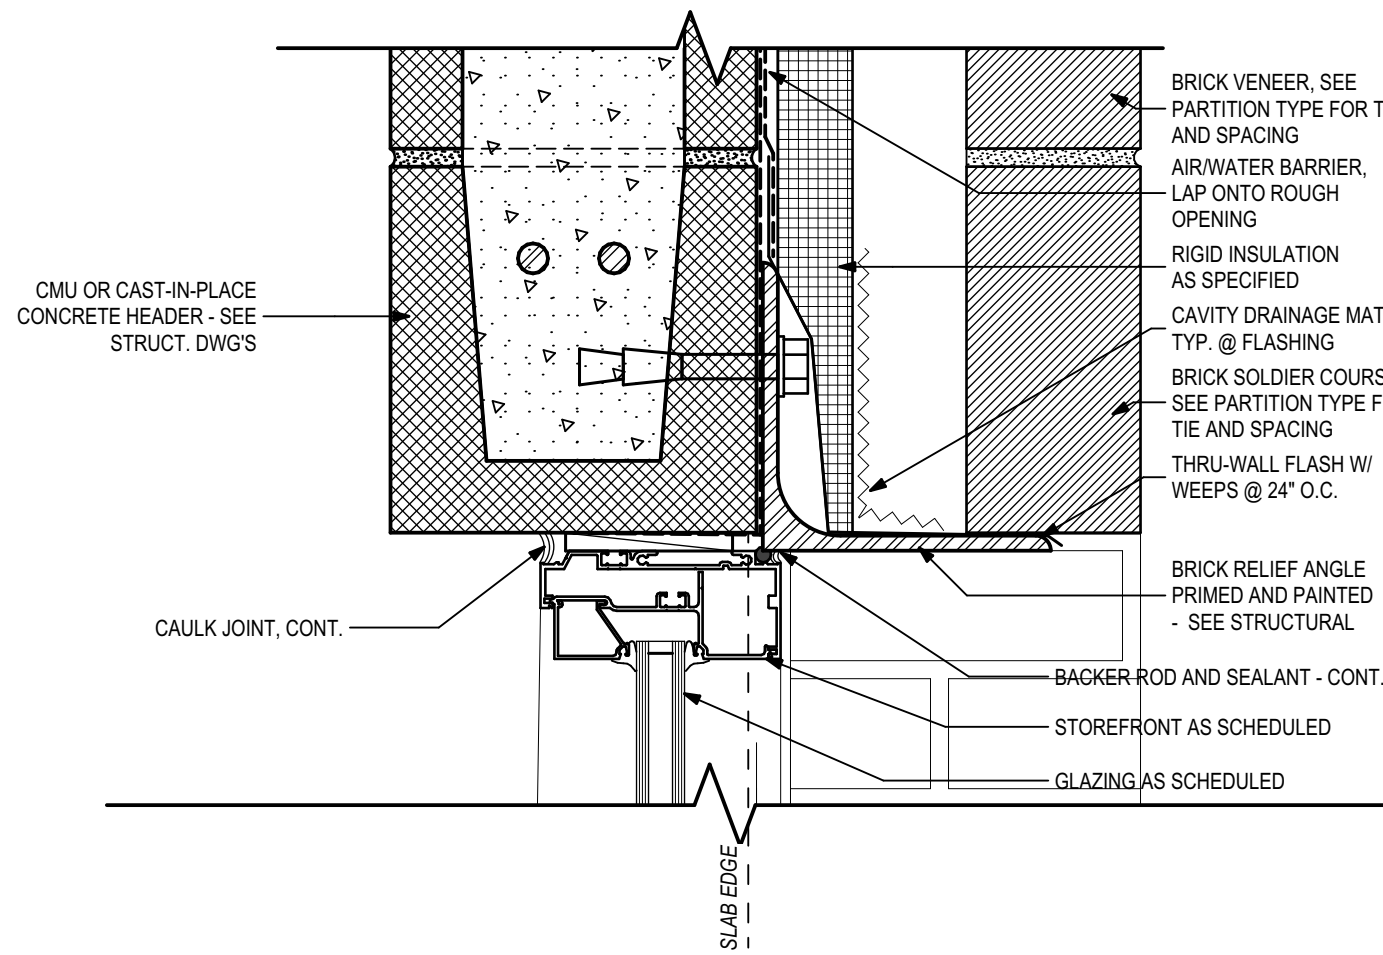


7 Exterior - Storefront - Head
3" = 1'-0"

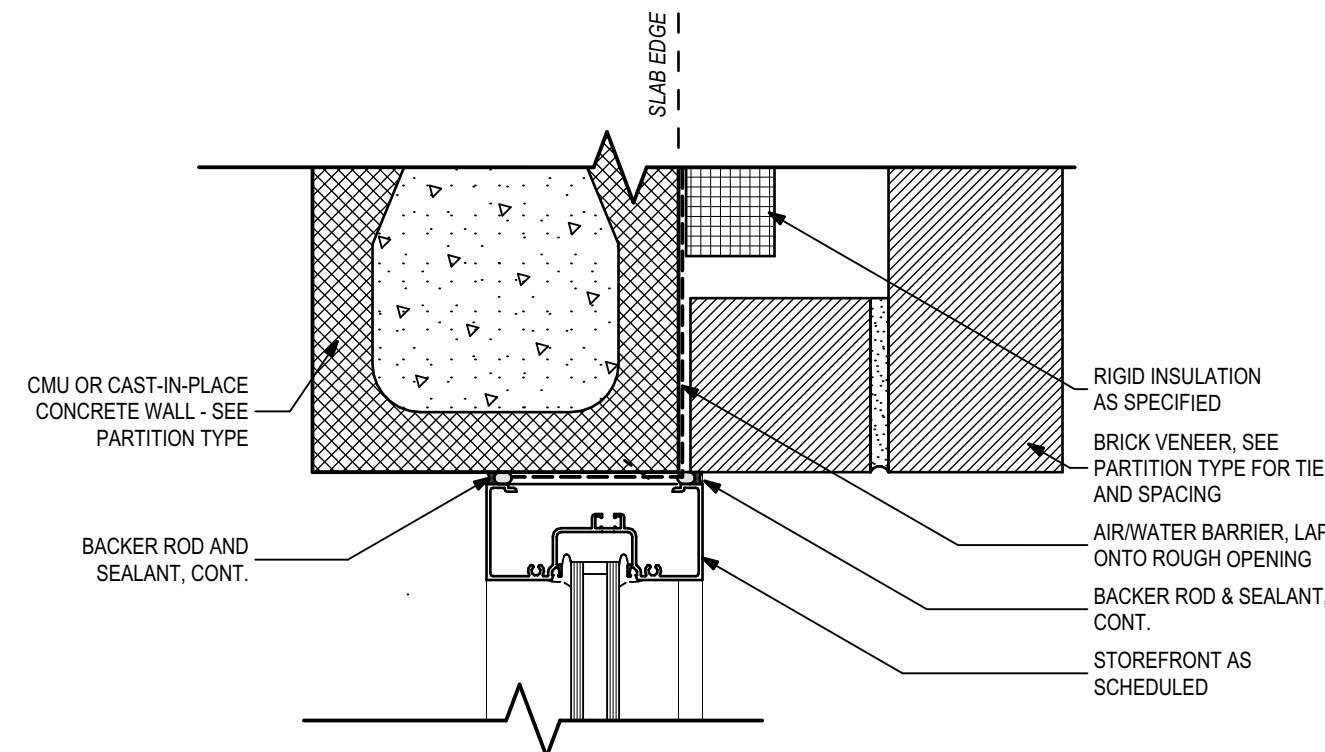


6 Exterior - Storefront - Jamb
3" = 1'-0"

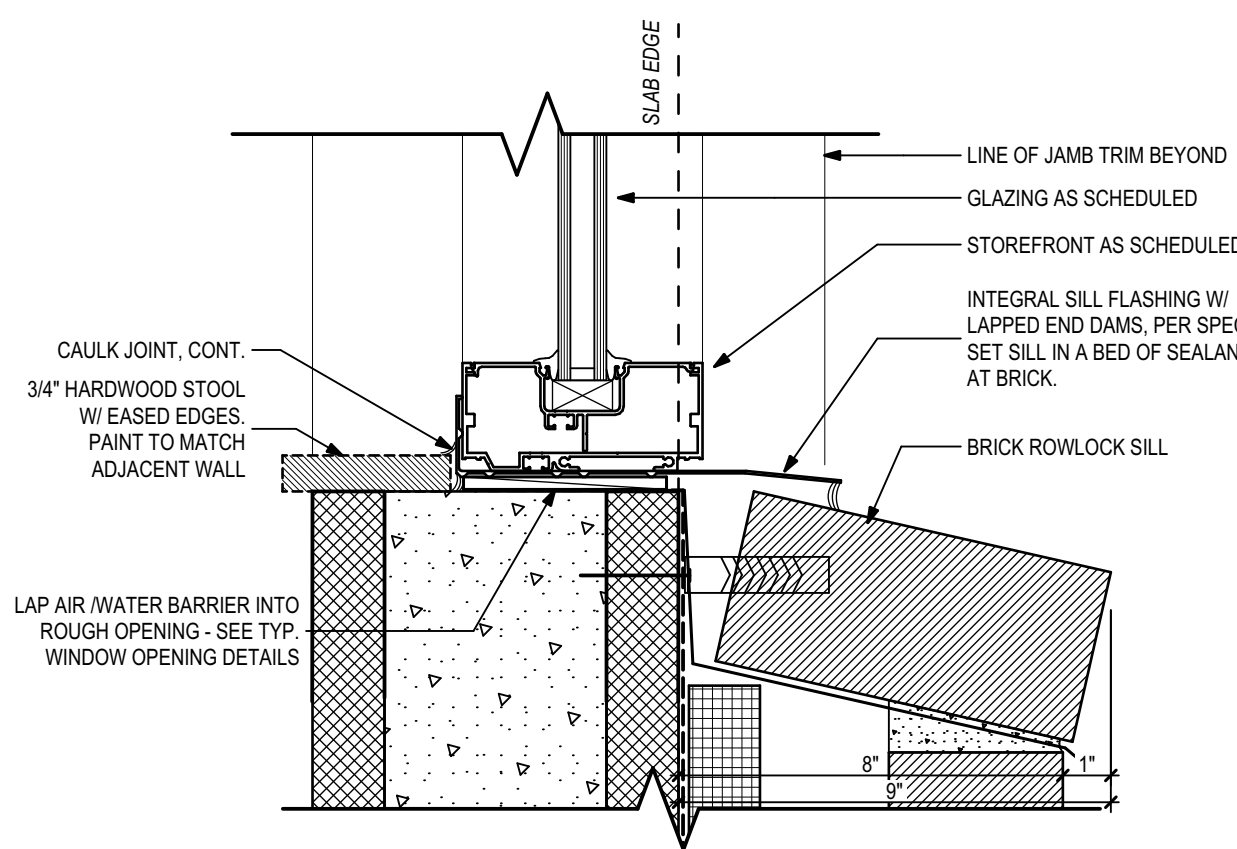


5 Exterior - Storefront - Sill
3" = 1'-0"

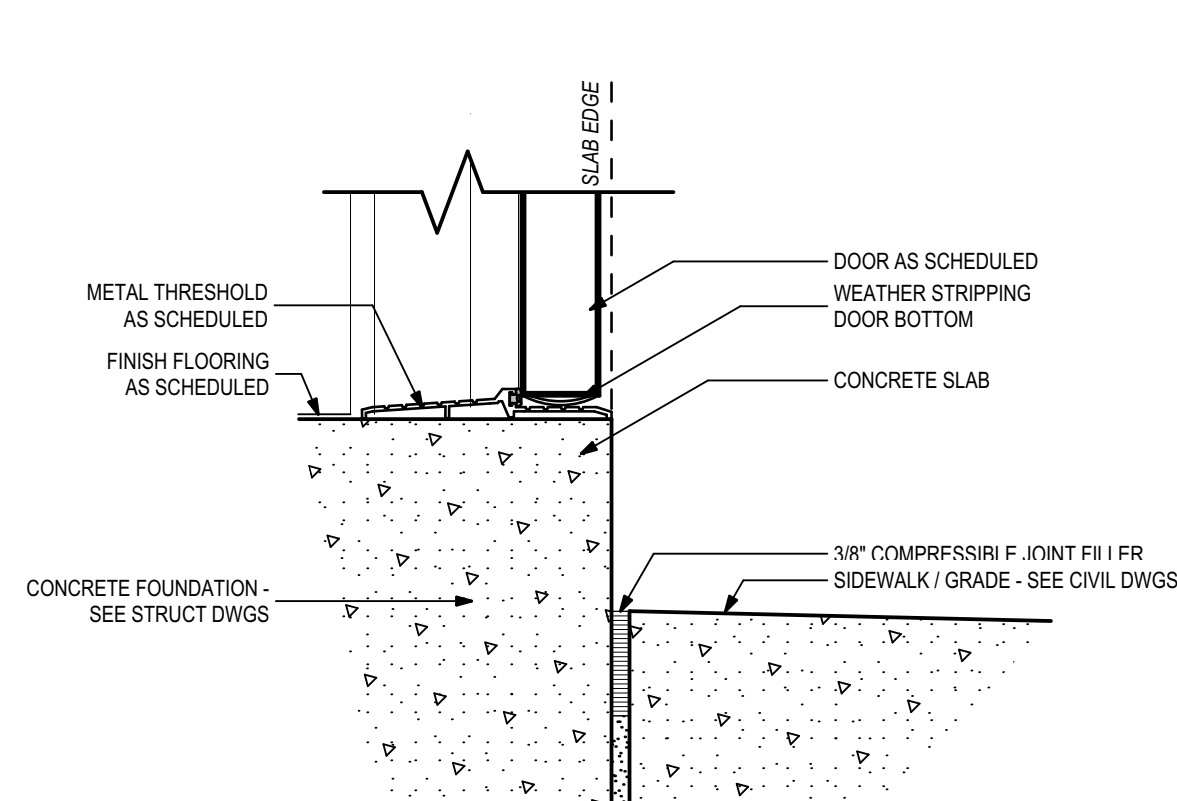


4 Exterior - Door Threshold to Concrete Pad
3" = 1'-0"

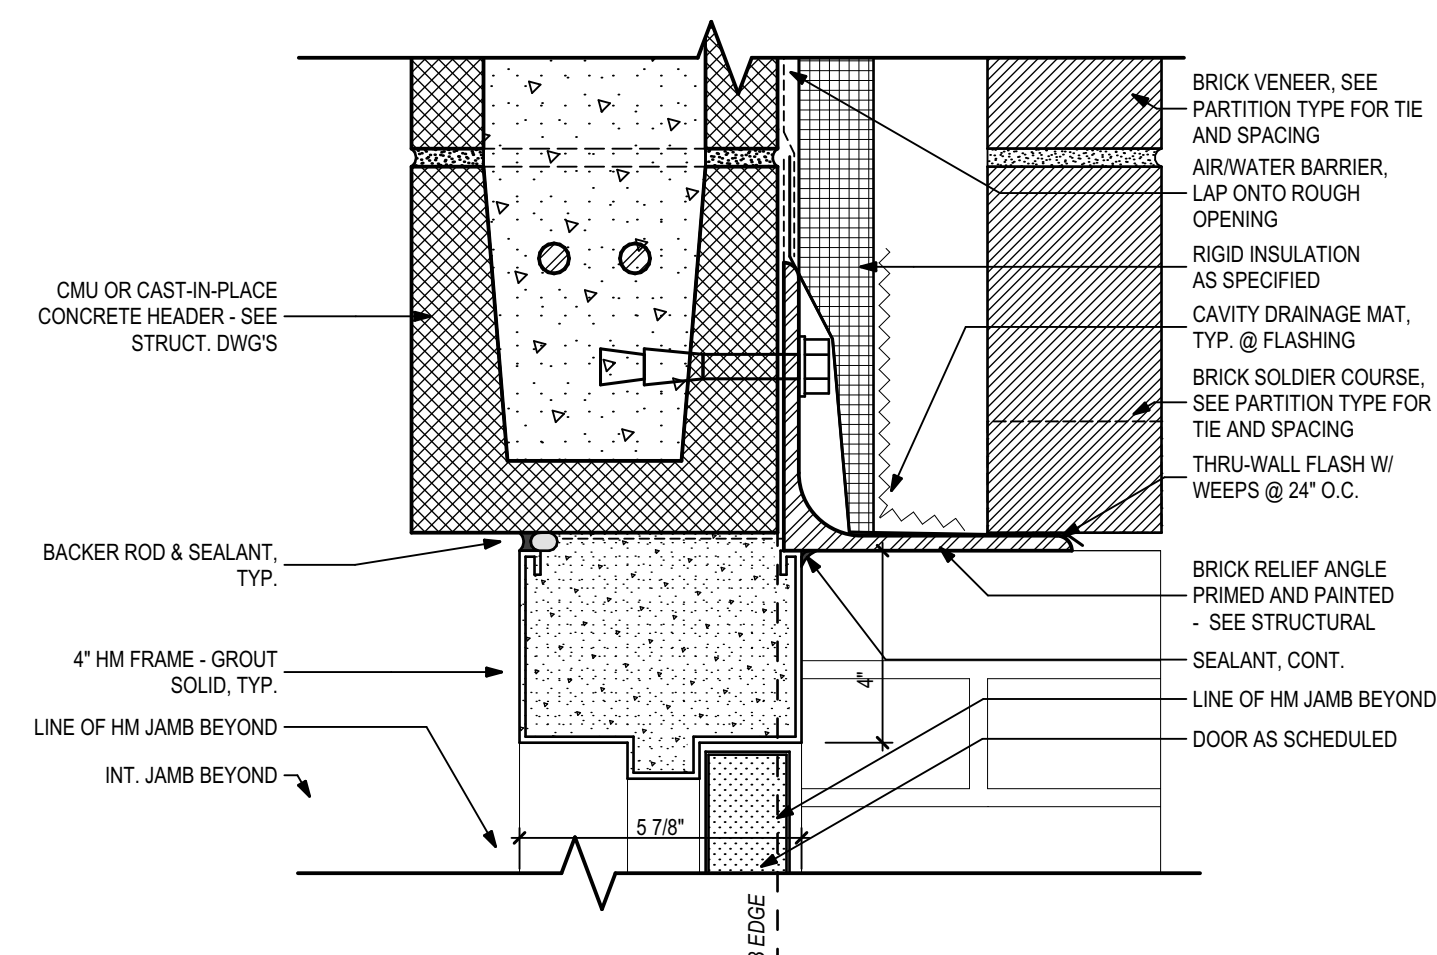

3 Exterior - HM Door Frame - Head
3" = 1'-0"

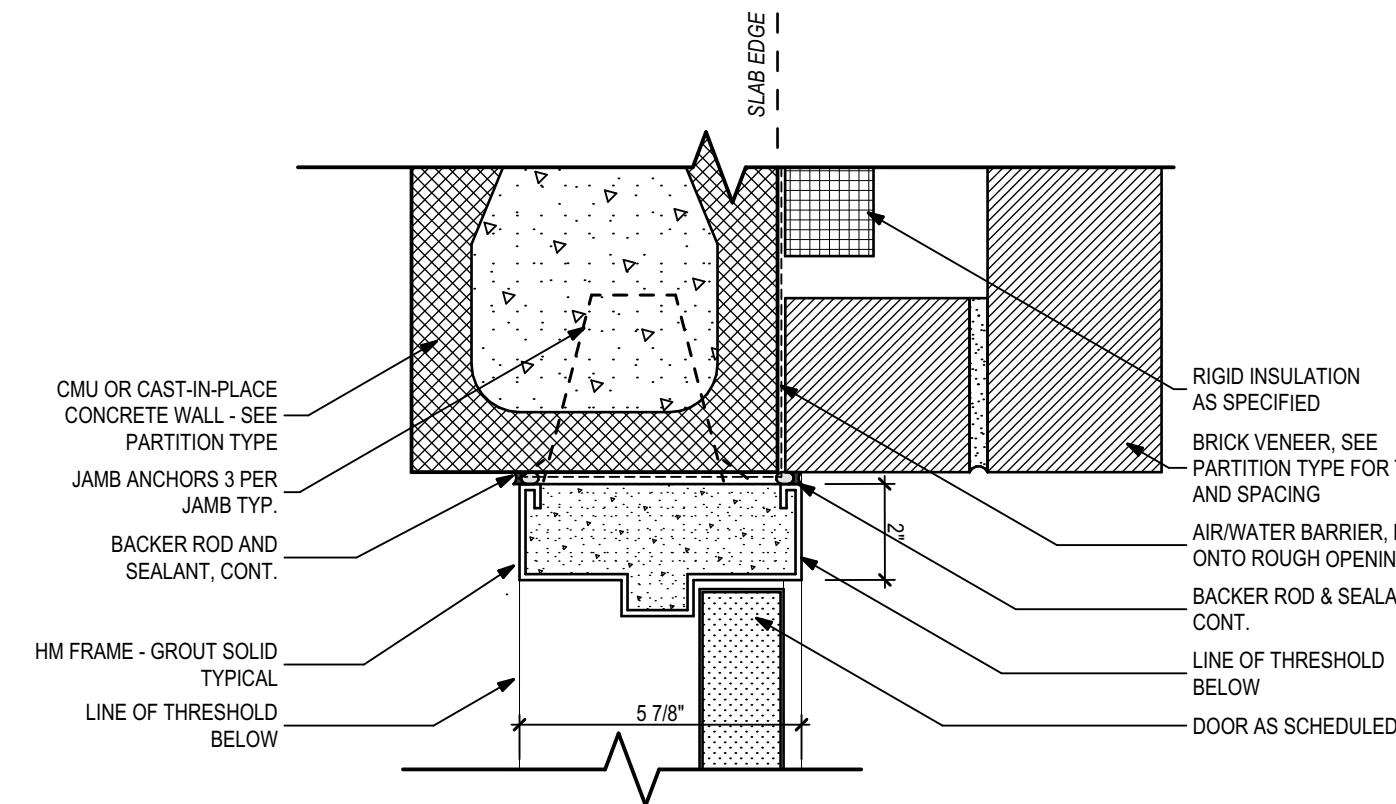

2 Exterior - HM Door Frame - Jamb
3" = 1'-0"

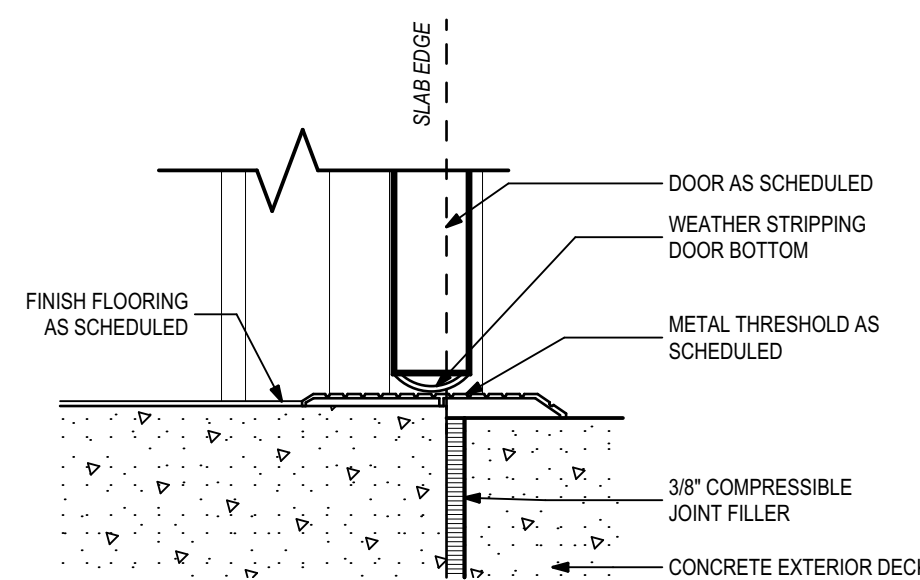

1 Exterior - Mtl Door Threshold
3" = 1'-0"

PHASE:	DRAWN:	REVIEWED:	DATE:	ID:	REVISION:	DATE:
CONCEPT SCHEM. DESIGN	BG / RS	C. WHITLOCK	10/8/2024			
DESIGN DEVELOPMENT	BG/RS/MS	C. WHITLOCK	12/20/2024			
EARLY DEMOLITION PACKAGE	BG/RS/MS	C. WHITLOCK	12/20/2024			
80% CONSTRUCTION DOCS	BG/RS/MS	R. LEWIS	03/21/2025			
PERMIT DOCS	BG/RS/MS	R. LEWIS	03/21/2025			
100% CONSTRUCTION DOCS	BG/RS/MS	R. LEWIS	05/09/2025			

LEON COUNTY SCHOOLS

Client:

Leon County Schools
3420 W. Tharpe St., Suite 100
Tallahassee, FL 32303

Consultant:

Project #:
Phase:

23483
100% CDs

Job Title:

Griffin Middle School - Phase 2
800 Alabama St. Tallahassee, FL 32304

ALW

Architects Lewis + Whitlock
206 West Virginia St.
Tallahassee, Florida 32301
850.942.1718
www.think3d.net

Description:

Door & Window
Details - Exterior

Sheet No.:


A6.3



1

New Gymnasium First Floor Reflected Ceiling Plan

3/32" = 1'-0"

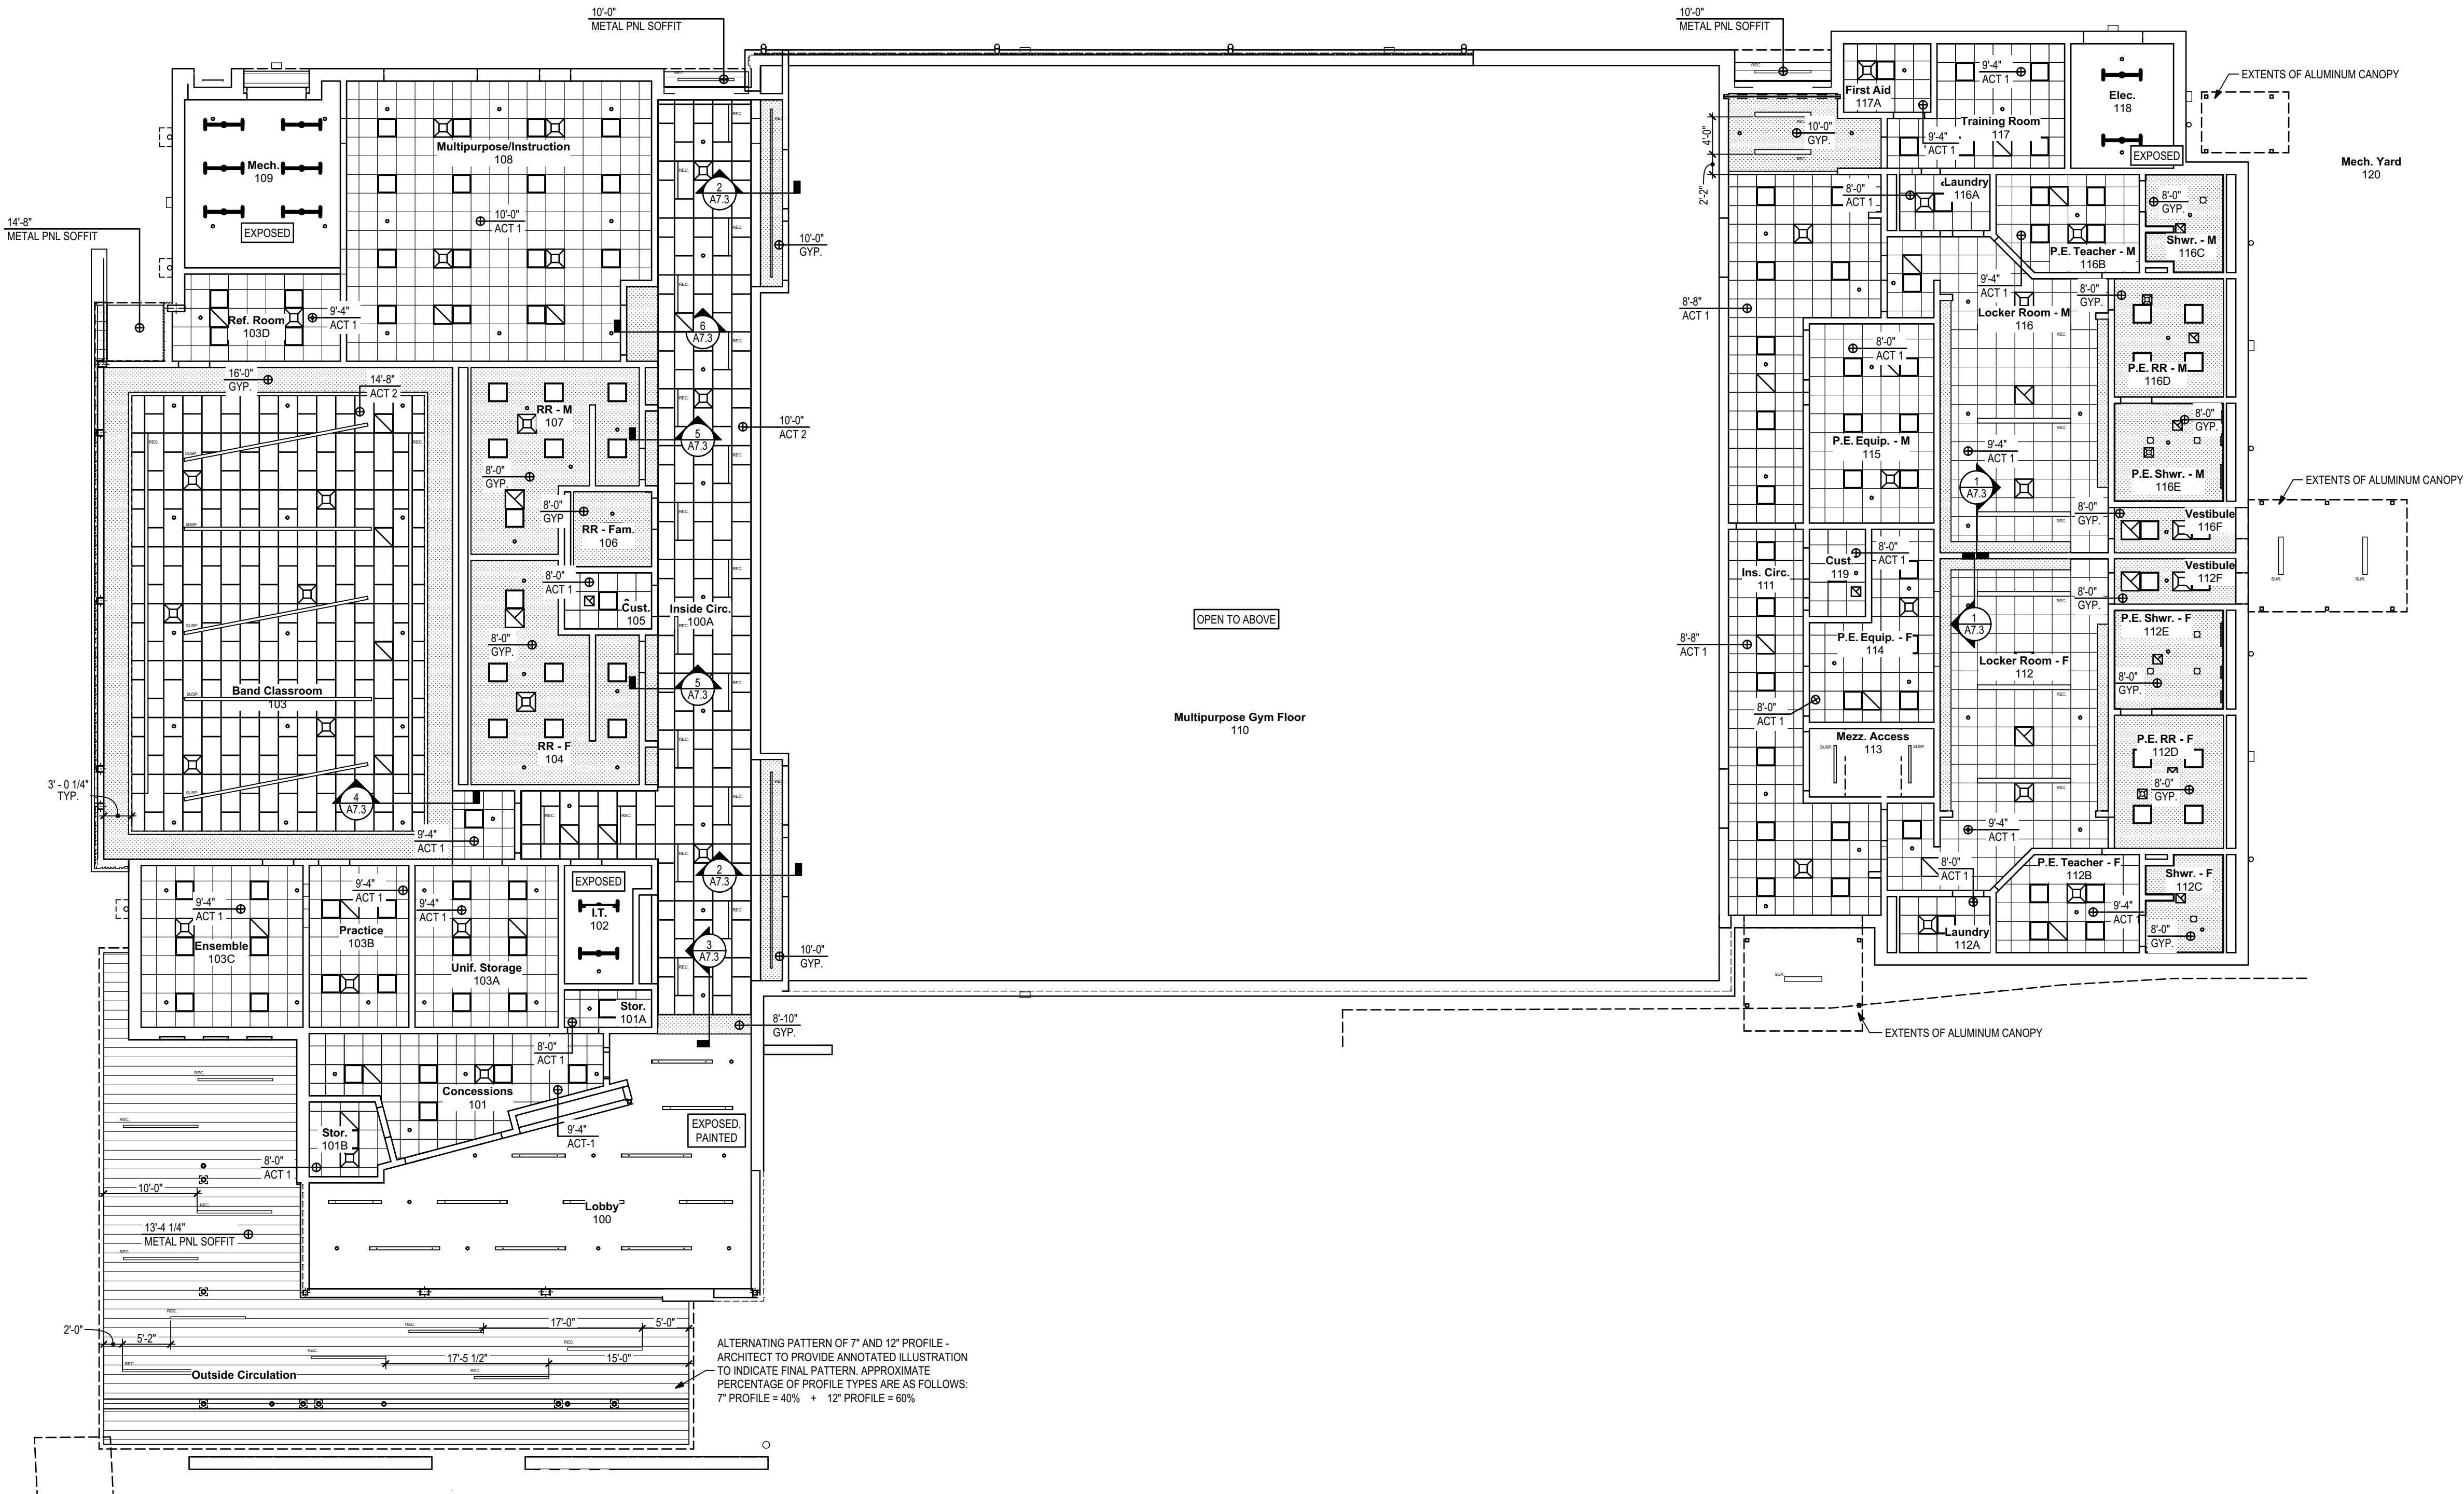


Ceiling Finish Legend

	GYP	GYPSUM BOARD
	ACT 1	ACOUSTICAL CEILING TILE
	ACT 2	ACOUSTICAL CEILING TILE
	EXP	EXPOSED
	METAL PNL	METAL PANEL CEILING SYSTEM

Ceiling Fixture Legend

	SUSPENDED/SURFACE MOUNTED/RECESSED LINEAR FIXTURE. SEE ELECTRICAL FOR SIZING & MOUNT STYLE.
	2' x 2' LED FLAT PANEL
	SQUARE RETURN
	SQUARE AIR DIFFUSER
	SQUARE EXHAUST FAN
	HIGH BAY LIGHT FIXTURE
	UTILITY LIGHT FIXTURE
	SPRINKLER HEAD

Key Plan

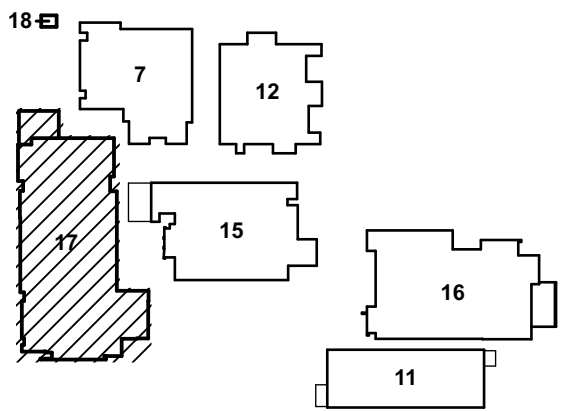

PHASE:	DRAWN:	REVIEWED:	DATE:	REVISION:	DRAWN:	REVIEWED:	DATE:
CONCEPT SCHEM. DESIGN	BG/RS	C. WHITLOCK	10/8/2024				
DESIGN DEVELOPMENT	BG/RS/MS	C. WHITLOCK	12/20/2024				
EARLY DEMOLITION PACKAGE	BG/RS/MS	C. WHITLOCK	12/20/2024				
80% CONSTRUCTION DOCS	BG/RS/MS	R. LEWIS	03/21/2025				
PERMIT DOCS	BG/RS/MS	R. LEWIS	03/21/2025				
100% CONSTRUCTION DOCS	BG/RS/MS	R. LEWIS	05/09/2025				

THESE DRAWINGS AND RENDERINGS ARE INSTRUMENTS OF SERVICE. THE DRAWINGS AND ASSOCIATED COPIES THEREOF, INCLUDING ELECTRONIC MEDIA AND CAD FILES, ARE THE PROPERTY OF ARCHITECTS LEWIS + WHITLOCK, P.A.A. THEIR USE, REPRESENTATION OR REPRODUCTION FOR ANY PURPOSE EXCEPT BY WRITTEN AGREEMENT WITH THE ARCHITECT IS PROHIBITED. THIS COPYRIGHT NOTIFICATION SHALL BE TRUE AS F DIRECTLY PLACED ON EACH DRAWING EXHIBIT. ON RENDERINGS ON THIS DOCUMENT AND SHALL NOT BE REMOVED FROM THESE DOCUMENTS.



Leon County Schools
3420 W. Tharpe St., Suite 100
Tallahassee, FL 32303

Client:

Griffin Middle School - Phase 2
800 Alabama St. Tallahassee, FL 32304

Consultant:

Project #: 23483
Phase: 100% CDs

Seal:



Architects Lewis + Whitlock
206 West Virginia St.
Tallahassee, Florida 32301
850.942.1718
www.think3d.net

Description:
**New Gymnasium
First Floor
Reflected Ceiling
Plan**

Sheet No.:


A7.1




1

New Gymnasium Mech. Mezzanine Reflected Ceiling Plan

3/32" = 1'-0"

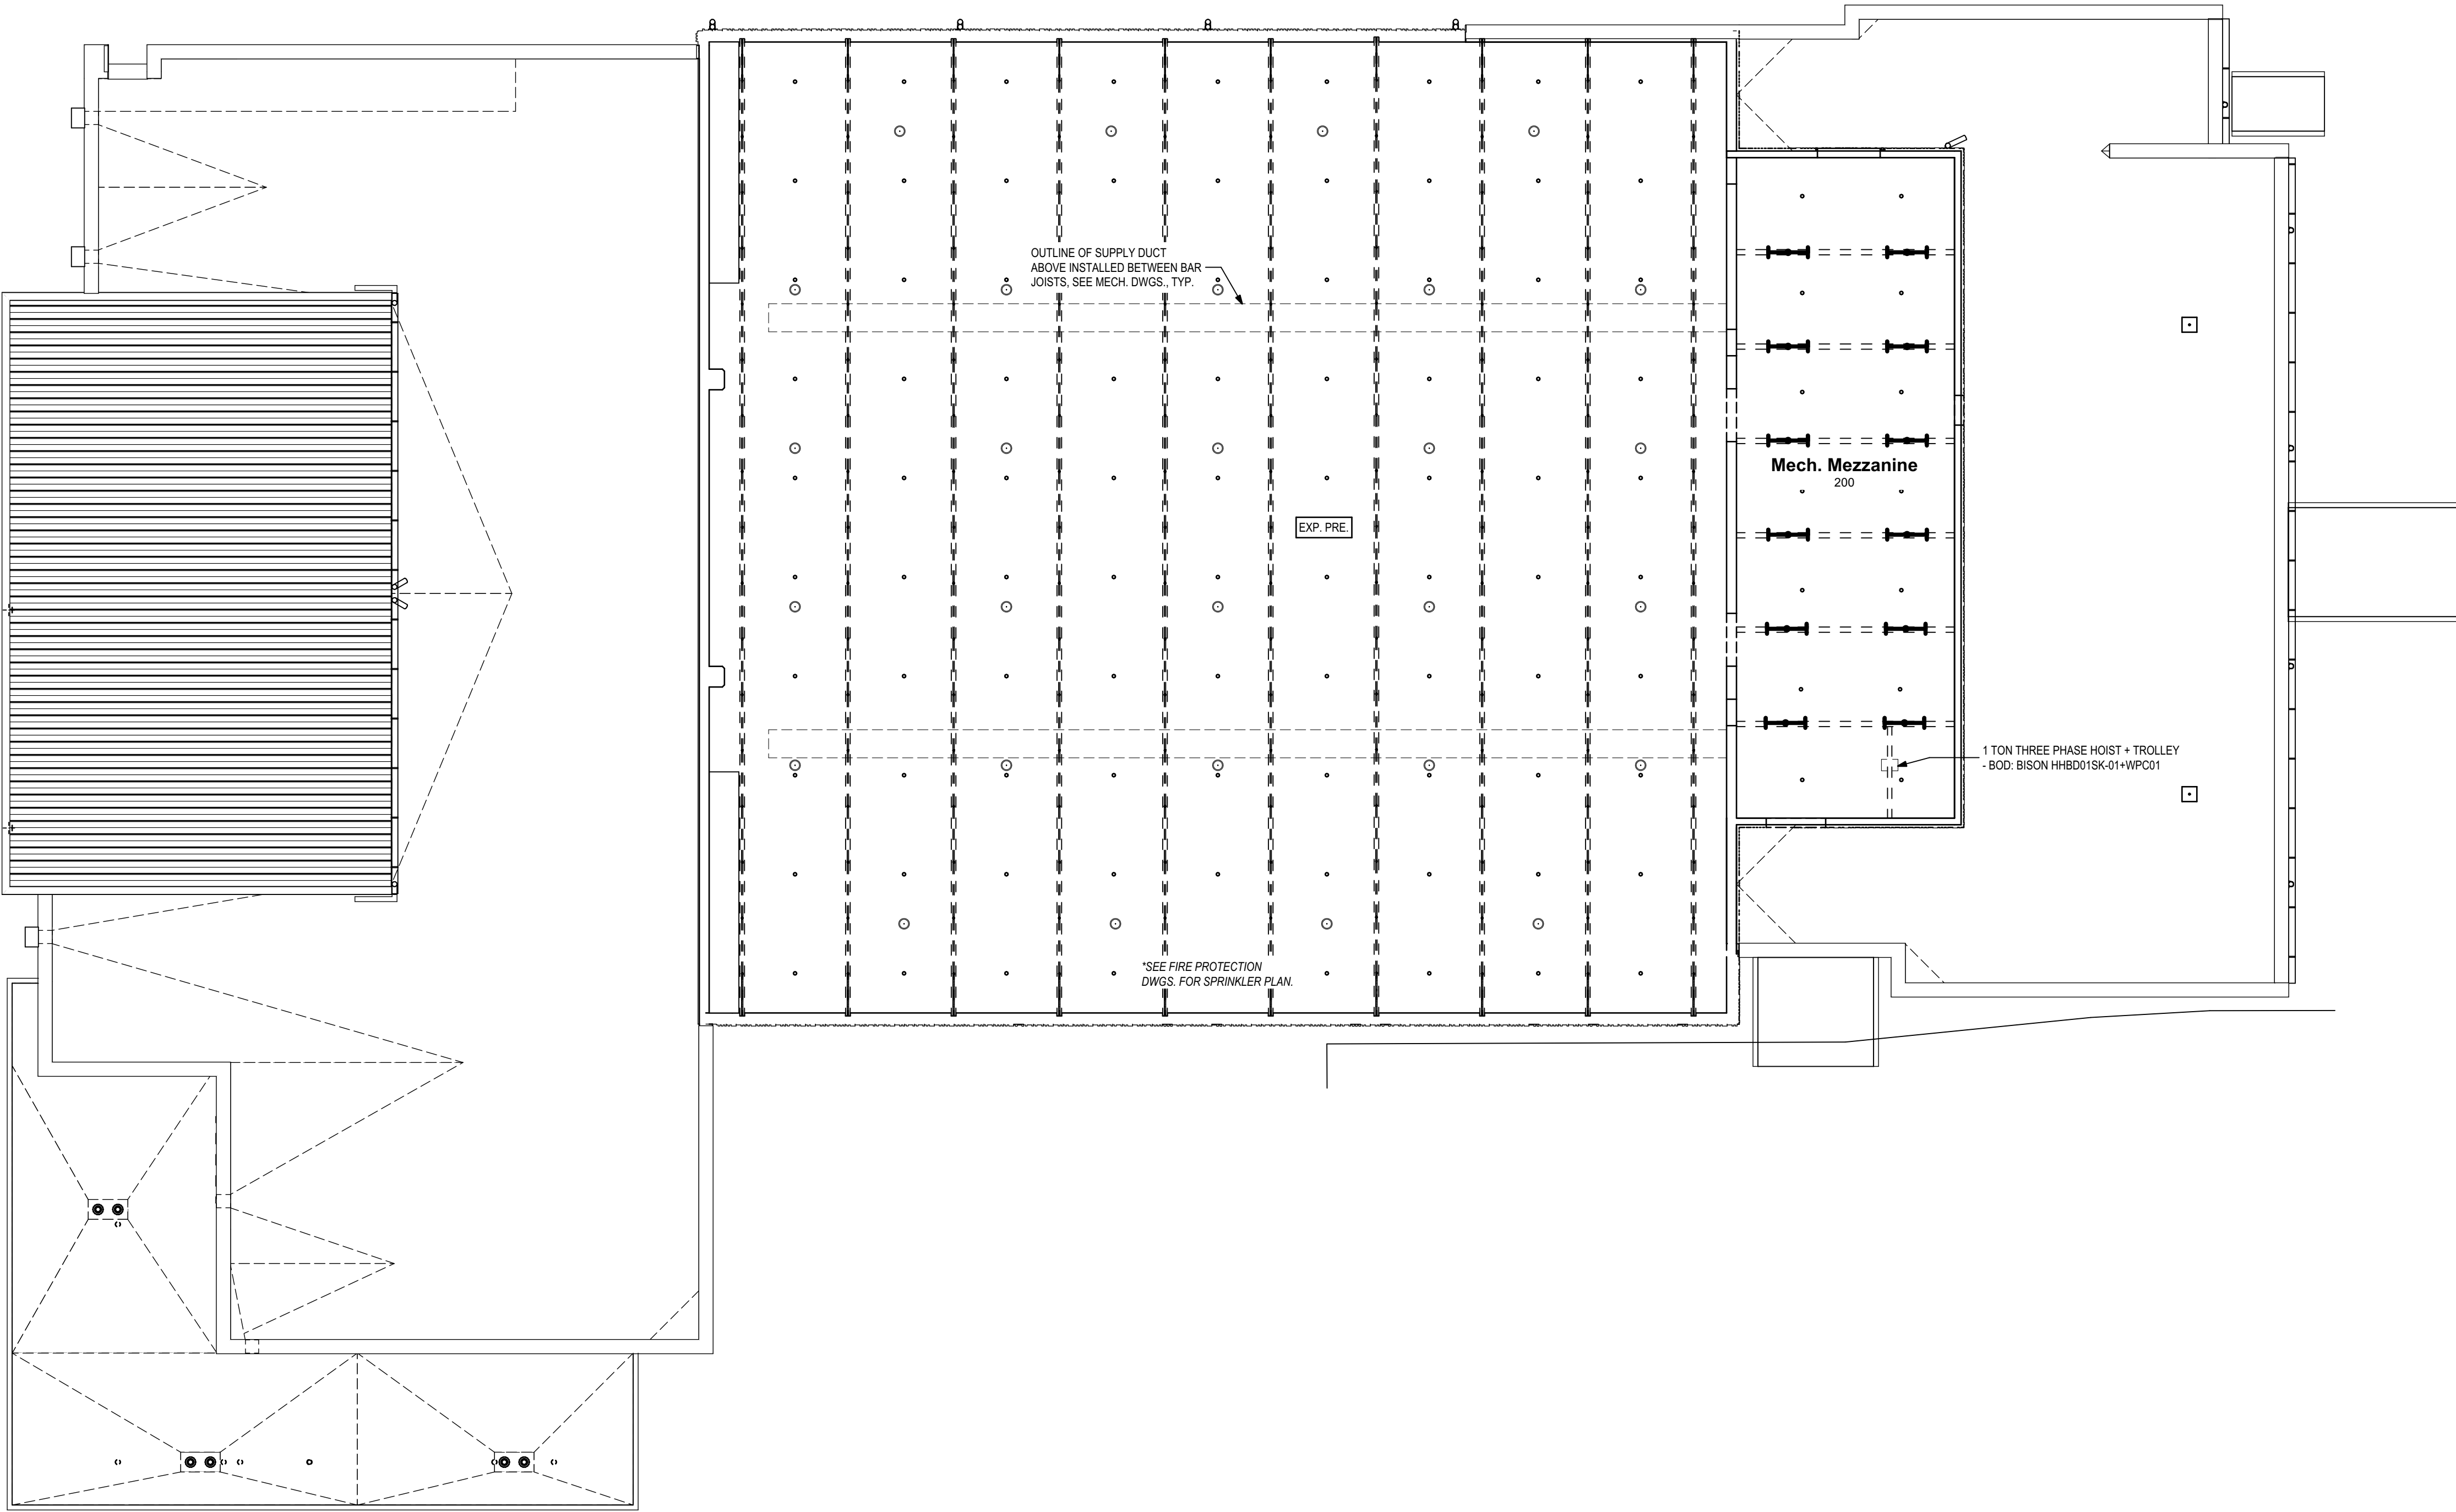

Key Plan

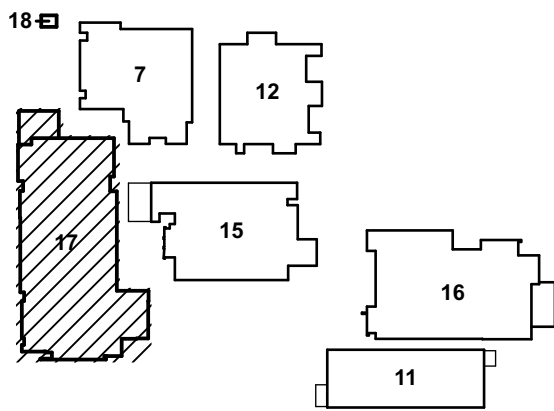

Ceiling Finish Legend

	GYP	GYPSUM BOARD
	ACT 1	ACOUSTICAL CEILING TILE
	ACT 2	ACOUSTICAL CEILING TILE
	EXP	EXPOSED
	METAL PNL	METAL PANEL CEILING SYSTEM

Ceiling Fixture Legend

	SUSPENDED/SURFACE MOUNTED/RECESSED LINEAR FIXTURE. SEE ELECTRICAL FOR SIZING & MOUNT STYLE.
	2' x 2' LED FLAT PANEL
	SQUARE RETURN
	SQUARE AIR DIFFUSER
	SQUARE EXHAUST FAN
	HIGH BAY LIGHT FIXTURE
	UTILITY LIGHT FIXTURE
	SPRINKLER HEAD

PHASE:	DRAWN:	REVIEWED:	DATE:	REVISION:	DRAWN:	REVIEWED:	DATE:
CONCEPT SCHEM. DESIGN	BG/RS	C. WHITLOCK	10/8/2024				
DESIGN DEVELOPMENT	BG/RS/SIMS	C. WHITLOCK	12/20/2024				
EARLY DEMOLITION PACKAGE							
80% CONSTRUCTION DOCS							
PERMIT DOCS							
100% CONSTRUCTION DOCS							

LEON COUNTY SCHOOLS

Leon County Schools
3420 W. Tharpe St., Suite 100
Tallahassee, FL 32303

Client:

Griffin Middle School - Phase 2
800 Alabama St. Tallahassee, FL 32304

Job Title:

23483
100% CDs

Project #:
Phase:

Seal:




Architects Lewis + Whitlock
206 West Virginia St.
Tallahassee, Florida 32301
850.942.1718
www.think3d.net

Description:
**New Gymnasium
Mech. Mezzanine
Reflected Ceiling
Plan**


Sheet No.:

A7.2


THESE DRAWINGS AND RENDERINGS ARE INSTRUMENTS OF SERVICE. THE DRAWINGS AND ASSOCIATED COPIES THEREOF, INCLUDING ELECTRONIC MEDIA AND CAD FILES, ARE THE PROPERTY OF ARCHITECTS LEWIS + WHITLOCK, P.A.A. THEIR USE, REPRESENTATION OR REPRODUCTION FOR ANY PURPOSE EXCEPT BY WRITTEN AGREEMENT WITH THE ARCHITECT IS PROHIBITED. THIS COPYRIGHT NOTIFICATION SHALL BE TRUE AS F DIRECTLY PLACED ON EACH DRAWING EXHIBIT. CONVEYING THIS DOCUMENT AND SHALL NOT BE REMOVED FROM THESE DOCUMENTS.

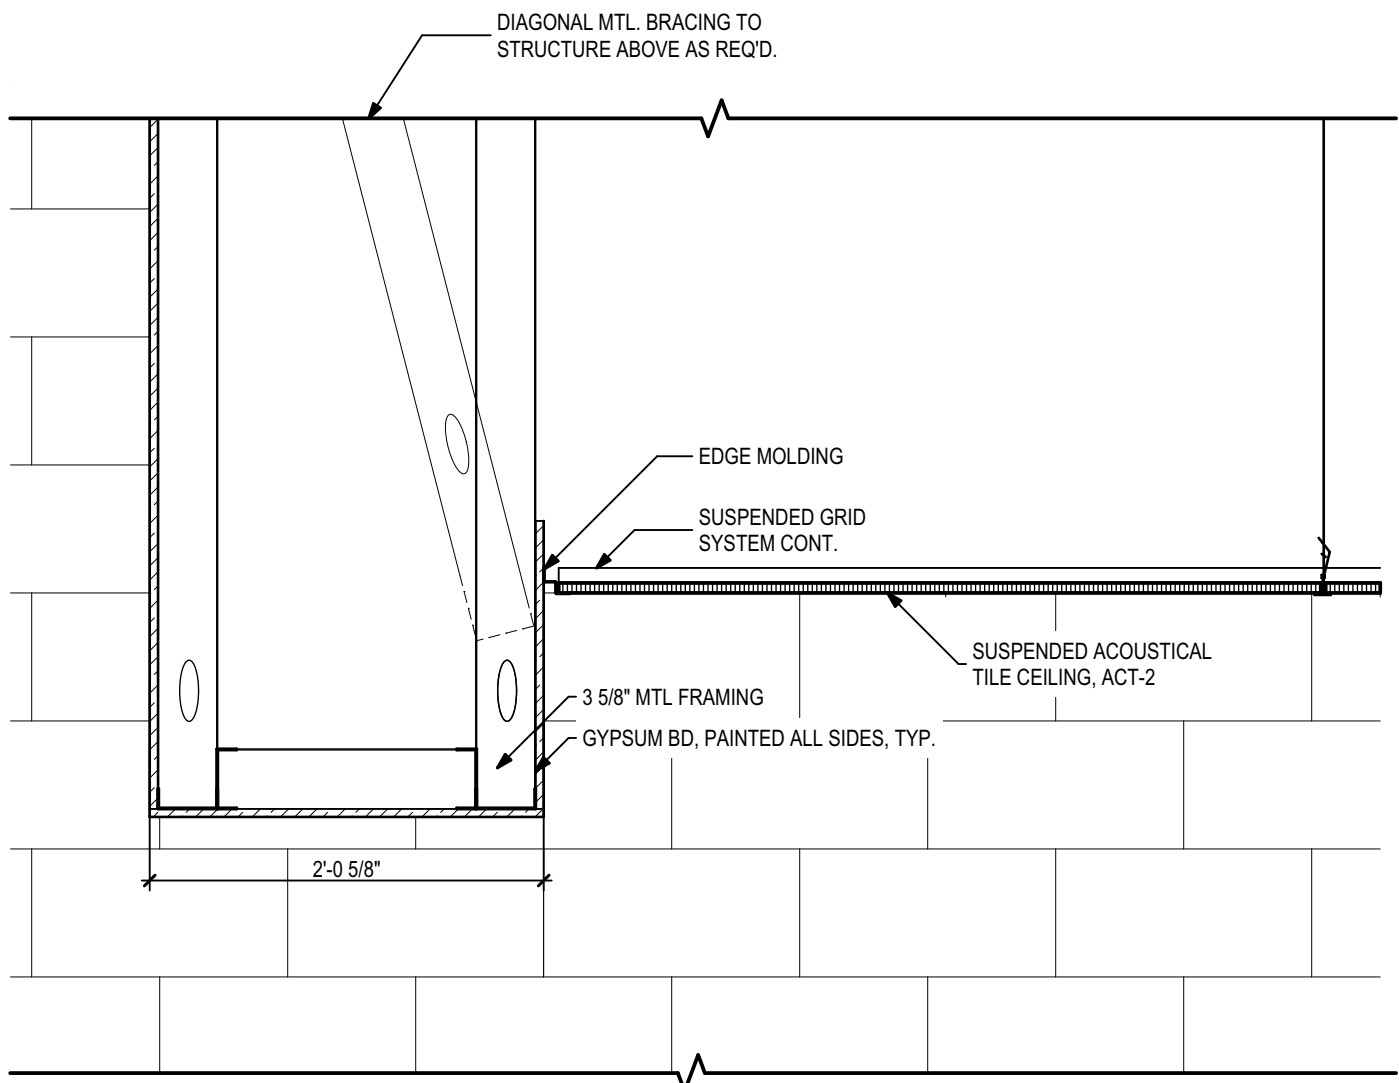


3 Bulkhead at Entrance
1" = 1'-0"

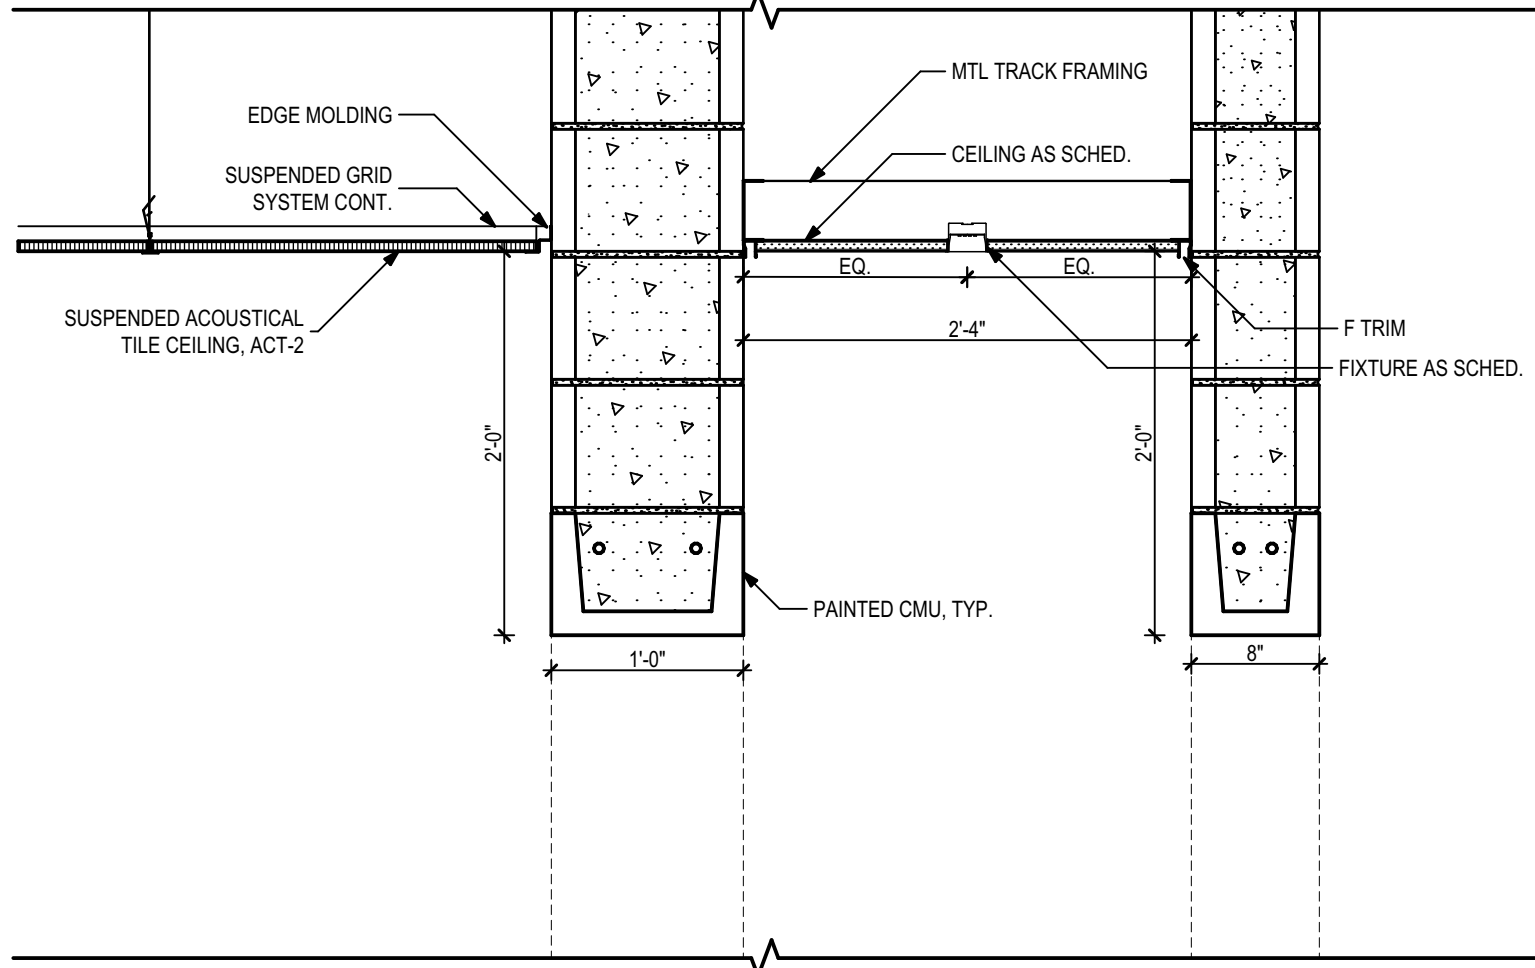


2 Bulkhead Detail
1" = 1'-0"

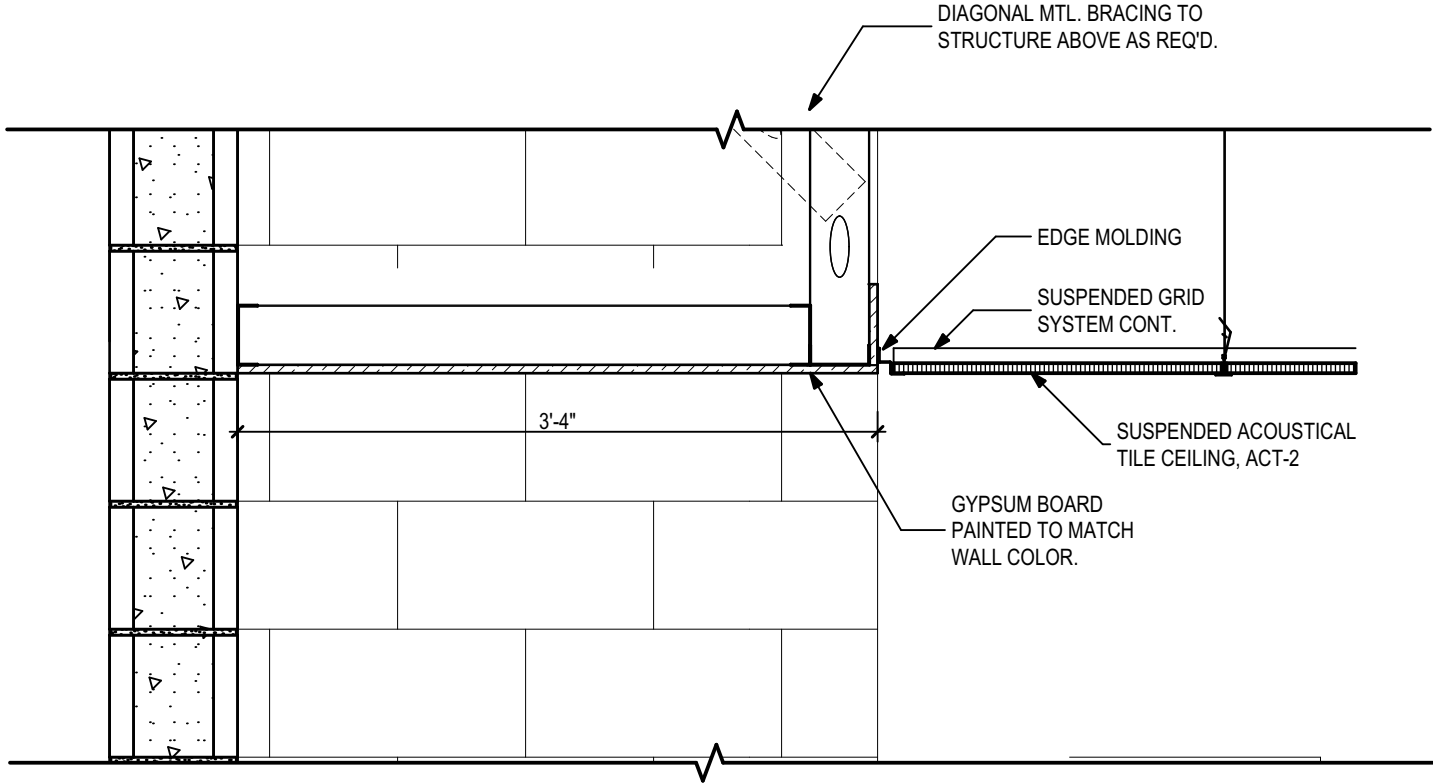


6 Soffit Detail at Corridor
1" = 1'-0"

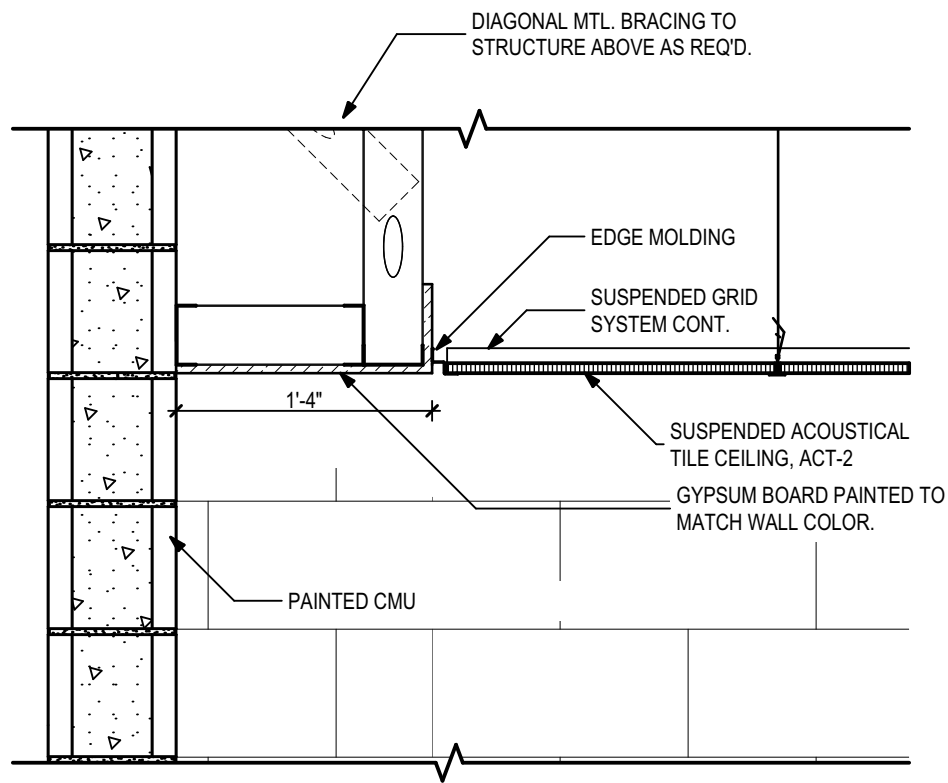

5 Soffit Detail at Corridor
1" = 1'-0"

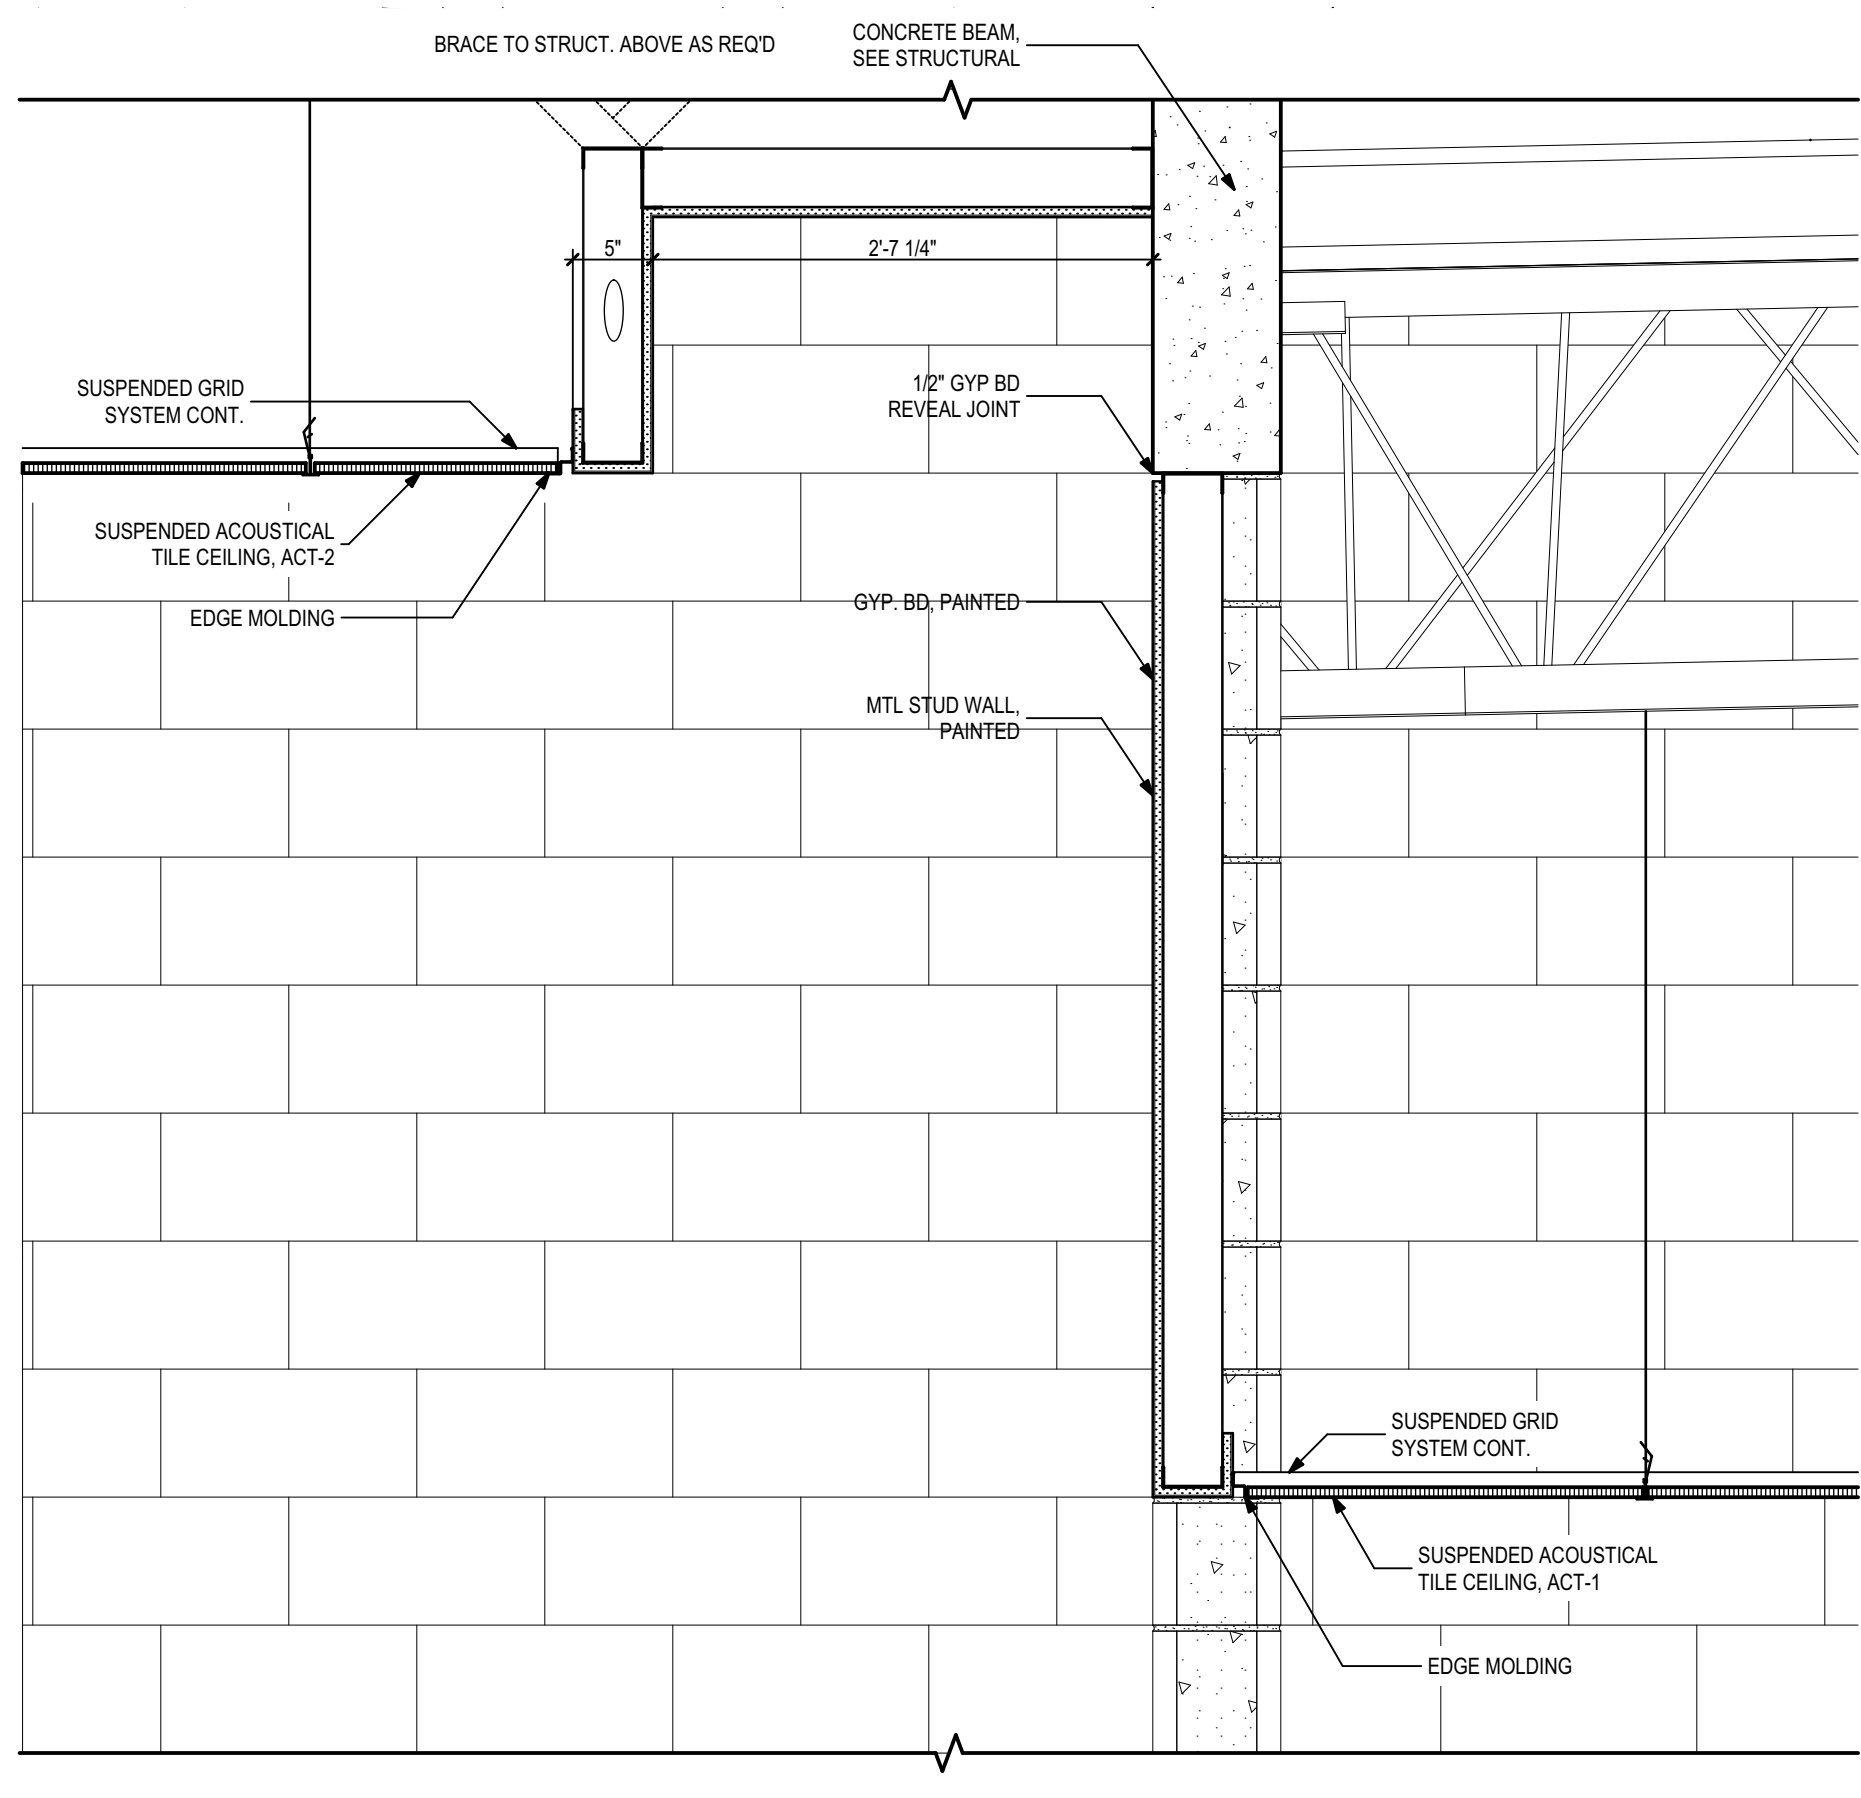

4 Ceiling Transition Detail
1" = 1'-0"

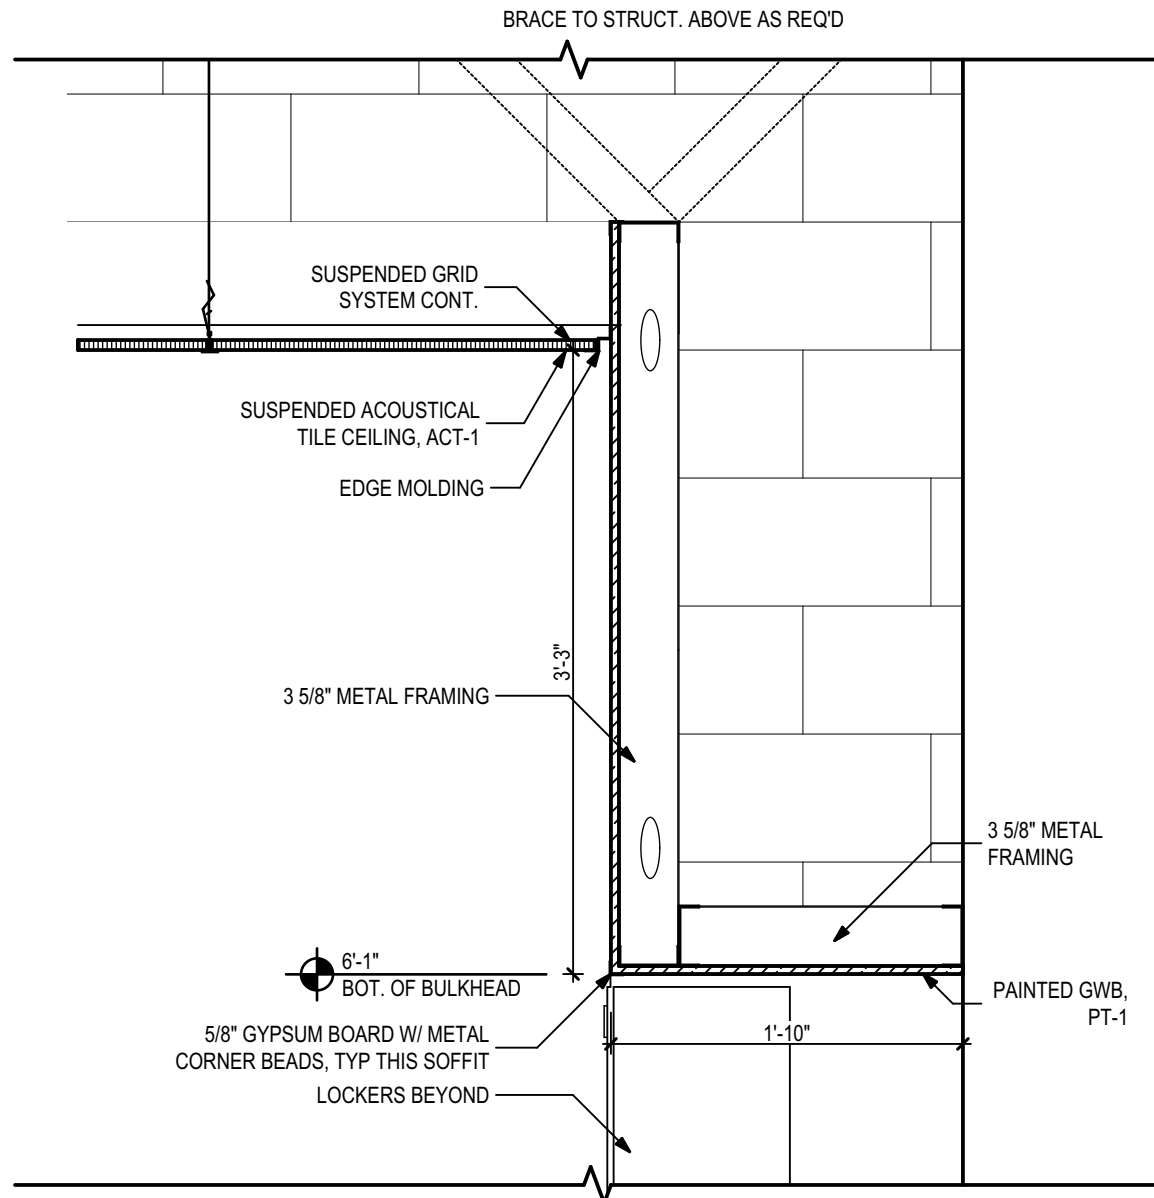

1 Locker Room Soffit Detail
1" = 1'-0"

PHASE:	DRAWN:	REVIEWED:	DATE:	ID:	REVISION:	DRAWN:	REVIEWED:	DATE:
CONCEPT SCHEM. DESIGN	BG/RS	C. WHITLOCK	10/8/2024					
DESIGN DEVELOPMENT	BG/RS/MS	C. WHITLOCK	12/20/2024					
EARLY DEMOLITION PACKAGE	BG/RS/MS	R. LEWIS	03/21/2025					
80% CONSTRUCTION DOCS	BG/RS/MS	R. LEWIS	03/21/2025					
PERMIT DOCS	BG/RS/MS	R. LEWIS	05/09/2025					
100% CONSTRUCTION DOCS	BG/RS/MS	R. LEWIS	05/09/2025					

LEON COUNTY SCHOOLS

Leon County Schools
3420 W. Tharpe St., Suite 100
Tallahassee, FL 32303

Client:

23483
100% CDs

Project #:
Phase:

Griffin Middle School - Phase 2
800 Alabama St. Tallahassee, FL 32304

Job Title:

Seal:	
-------	--

ALW

Architects Lewis + Whitlock
206 West Virginia St.
Tallahassee, Florida 32301
850.942.1718
www.think3d.net

Description:
Ceiling Section
Details

Sheet No.:
A7.3

THESE DRAWINGS AND REPRESENTATIONS ARE INSTRUMENTS OF SERVICE. THE DRAWINGS AND ASSOCIATED COPIES THEREOF, INCLUDING ELECTRONIC MEDIA AND CAD FILES, ARE THE PROPERTY OF ARCHITECTS LEWIS + WHITLOCK, P.A.A. THEIR USE, REPRESENTATION OR REPRODUCTION FOR ANY PURPOSE EXCEPT BY WRITTEN AGREEMENT WITH THE ARCHITECT IS PROHIBITED. THIS COPYRIGHT NOTIFICATION SHALL BE TRUE AS F DIRECTLY PLACED ON EACH DRAWING EXHIBIT OR REFERENCED ON THIS DOCUMENT AND SHALL NOT BE REMOVED FROM THESE DOCUMENTS.

Finish Summary

Mark	Description	Size	Basis of Design	Color	Notes
FLOORS					
CPT-1	Carpet Tile	12" x 48"	Shaw Contract Convene Tile	Clear System	Install: Stagger. See finish Floor Plan for install direction.
CPT-2	Walk-off Carpet Tile	18" x 36"	Mannington Charge	Kinetic	Install: Ashlar. See Finish Floor Plan for install direction.
CT-1	Ceramic Porcelain Floor Tile - Field	12" x 24"	Crossville Tile - Collection TBD	TBS by Architect from MFR full range of products.	See install pattern on finish floor plan.
CT-2	Ceramic Porcelain Floor Tile - Accent 1	12" x 24"	Crossville Tile - Collection TBD	TBS by Architect from MFR full range of products.	See install pattern on finish floor plan.
CT-3	Ceramic Porcelain Floor Tile - Accent 2	12" x 24"	Crossville Tile - Collection TBD	TBS by Architect from MFR full range of products.	See install pattern on finish floor plan.
CT-4	Ceramic Porcelain Floor Tile - Mosaic	-	Crossville Civilization Polygon Mosaic	Communique	
LVT-1	Luxury Vinyl Tile - Field	6" x 36"	Mannington Active Lines - Crisscross	Pop	Install: Stagger. See finish Floor Plan for install direction.
LVT-2	Luxury Vinyl Tile - Accent 1	6" x 36"	Mannington Active Lines - Crisscross	Zoom	Install: Stagger. See finish Floor Plan for install direction.
LVT-3	Luxury Vinyl Tile - Accent 2	6" x 36"	Mannington Active Lines - Crisscross	Zoom Blue	Install: Stagger. See finish Floor Plan for install direction.
RT-1	Rubber Tile - Field	39.53" X 39.53"	Nora Norament Satura Hammered	Castor	Install monolithic.
RT-2	Rubber Tile - Accent 1	39.53" X 39.53"	Nora Norament Satura Hammered	Dorado	Install monolithic.
RT-3	Rubber Tile - Accent 2	39.53" X 39.53"	Nora Norament Satura Hammered	Earth	Install monolithic.
EP	Epoxy Broadcast Flooring System	-	Plexi-Chemi PlexiQuartz	Salt and Pepper	Epoxy to flash up wall for integral wall base.
-	Sealed Concrete	-	W.R. Meadow Yocamp 25 Acrylic Sealer	-	
WD	Wood Gym Floor		Aacer Sports Flooring - Infinity MFMA-RL Second and Better Grade Northern Hard Maple	MFMA approved seal and finish	
TRANSITIONS					
MT	Metal Transition	-	Schluter (profiles vary)	TBS by architect	
WALL BASE					
RB-1	Rubber Wall Base - Cove	6" (coils)	Johnsonite Baseworks	Grey WG	
RB-2	Rubber Wall Base - Cove	4" Sticks	Johnsonite Vent Cove	Black	
CT-5	Ceramic Tile - Bullnose	-	Crossville Tile - Collection TBD	TBS by Architect from MFR full range of products.	
CEILINGS					
ACT-1	Acoustical Panel Ceiling	24" x 24"	Armstrong Ultima Tegaluar	White	Use with Suprafine 9/16" Exposed Tee
ACT-2	Acoustical Panel Ceiling	24" x 24", 24" x 48"	Armstrong Ultima Tegaluar	White	Use with Suprafine 9/16" Exposed Tee. See RCP for layout.
GYP	Gypsum Board	-	-	Varies	See RCP & elevations for color directive.
WALLS & TRIM					
PT-1	Field Paint	-	Sherwin Williams A-100 Latex Satin	Pure White	
PT-2	Accent Paint 1	-	Sherwin Williams A-100 Latex Satin	Gray Shingle	See finish floor plan and elevations for accent paint locations.
PT-3	Accent Paint 2	-	Sherwin Williams A-100 Latex Satin	Indigo Batik	See finish floor plan and elevations for accent paint locations.
PT-4	Accent Paint 3	-	Sherwin Williams A-100 Latex Satin	Secure Blue	See finish floor plan and elevations for accent paint locations.
PT-5	Accent Paint 4	-	Sherwin Williams A-100 Latex Satin	March Wind	
EPT-X	Epoxy Paint	-	Sherwin Williams Pro Industrial Water Based Catalyzed Epoxy Gloss, B73-300 Series	-	Match color designation of standard PT colors.
CT-6	Ceramic Porcelain Wall Tile	12" x 24"	Crossville Tile - Collection TBD	TBS by Architect from MFR full range of products.	See elevations for layout.
AWP1	Fabric-Wrapped Wall Panels	Varies	Armstrong Custom Sound Soak	Guilford of Maine, Metallation - Stainless	See elevations for sizing
AWP2	Fabric-Wrapped Wall Panels	Varies	Armstrong Custom Sound Soak	Guilford of Maine, Metallation - Polished Pewter	See elevations for sizing
AWP3	Fabric-Wrapped Wall Panels	Varies	Armstrong Custom Sound Soak	Guilford of Maine, Metallation - Fired Titanium	See elevations for sizing
CASEWORK					
PL	Plastic Laminate (Cabinets)	-	Wilsonart High Pressure Laminate	Limber Maple	
SS1	Solid Surface (Countertops)		Corian	Domino Terrazo	
SS2	Solid Surface (Concessions Counter)	-	Wilsonart	Arctic Drift	

Finish Schedule

ROOM NUMBER	ROOM NAME/ DESCRIPTION	FLOOR		BASE		WALLS		CEILING		REMARKS
		FINISH	NOTES	FINISH	NOTES	FINISH	NOTES	FINISH	NOTES	
100	Lobby	CT/CPT-2		RB-1		EPT-1	3	EXPOSED PAINTED (PT-4)	1	
0100	Flam. Storage	-		-		-		-		
100A	Inside Circ.	CT/CPT-2		RB-1		EPT-1	3	ACT-2 / PT-3 OVER GYP.		
101	Concessions	CT		CT		EPT-1		ACT-1		
101A	Stor.	CT		CT		EPT-1		ACT-1		
101B	Stor.	CT		CT		EPT-1		ACT-1		
102	I.T.	SEALED CONCRETE		RB-1		PT-1		EXPOSED		
103	Band Classroom	CPT-1/LVT		RB-1		EPT-1	3	ACT-2 / PT-1 OVER GYP.		
103A	Unif. Storage	LVT		RB-1		EPT-1		ACT-1		
103B	Practice	CPT-1		RB-1		EPT-1		ACT-1		
103C	Ensemble	CPT-1		RB-1		EPT-1		ACT-1		
103D	Ref. Room	CPT-1		RB-1		EPT-1		ACT-1		
104	RR-F	CT		CT		EPT-1	3	PT-1 OVER GYP.		
105	Cust.	LVT		RB-1		EPT-1		ACT-1		
106	RR-Fam.	CT		CT		EPT-1		PT-1 OVER GYP.		
107	RR-M	CT		CT		EPT-1	3	PT-1 OVER GYP.		
108	Multipurpose/Instruction	RT-1 thru RT-3		RB-1		EPT-1	3	ACT-1		
109	Mech.	SEALED CONCRETE		RB-1		PT-1		EXPOSED		
110	Multipurpose Gym Floor	WD		RB-2		EPT-1	3	EXPOSED	2	
111	Ins. Circ.	LVT/CPT-2		RB-1		EPT-1	3	ACT-1		
112	Locker Room - F	EP		EP		EPT-1	3	ACT-1		
112A	Laundry	EP		EP		EPT-1		ACT-1		
112B	P.E. Teacher-F	EP		EP		EPT-1		ACT-1		
112C	Shwr.-F	CT		CT		CT		PT-1 OVER GYP.		
112D	P.E. RR-F	EP		EP		EPT-1	3	PT-1 OVER GYP.		
112E	P.E. Shwr.-F	CT		CT		EPT-1/CT		PT-1 OVER GYP.		
112F	Vestibule	EP		EP		EPT-1		ACT-1		
113	Mezz. Access	SEALED CONCRETE		RB-1		PT-1		EXPOSED		
114	P.E. Equip.-F	LVT		RB-1		EPT-1		ACT-1		
115	P.E. Equip.-M	LVT		RB-1		EPT-1		ACT-1		
116	Locker Room - M	EP		EP		EPT-1	3	ACT-1		
116A	Laundry	EP		EP		EPT-1		ACT-1		
116B	P.E. Teacher-M	EP		EP		EPT-1		ACT-1		
116C	Shwr.-M	CT		CT		EPT-1/CT		PT-1 OVER GYP.		
116D	P.E. RR-M	EP		EP		EPT-1	3	PT-1 OVER GYP.		
116E	P.E. Shwr.-M	CT		CT		CT		PT-1 OVER GYP.		
116F	Vestibule	EP		EP		EPT-1		ACT-1		
117	Training Room	LVT		RB-1		EPT-1		ACT-1		
117A	First Aid	LVT		RB-1		EPT-1		ACT-1		
118	Elec.	SEALED CONCRETE		RB-1		PT-1		EXPOSED		
119	Cust.	SEALED CONCRETE		RB-1		EPT-1		ACT-1		
120	Mech. Yard	-		-		-		-		
200	Mech. Mezzanine	SEALED CONCRETE		RB-1		PT-1		EXPOSED		

General Finish Notes:

- EXPOSED BEAMS TO BE PAINTED PT-3.
- EXPOSED OPEN WEB TRUSSES TO BE PAINTED PT-5.
- SEE FINISH FLOOR PLAN & ELEVATIONS FOR ACCENT WALL PAINT LOCATIONS.

PHASE:

CONCEPT SCHEM. DESIGN
DESIGN DEVELOPMENT
EARLY DEMOLITION PACKAGE
80% CONSTRUCTION DOCS
PERMIT DOCS

DRAWN:

BG / RS
BG/SRS/MS
BG/SRS/MS
BG/SRS/MS
BG/SRS/MS

REVIEWED:

C. WHITLOCK
C. WHITLOCK
C. WHITLOCK
R. LEWIS
R. LEWIS

DATE:

10/8/2024
12/20/2024
03/21/2025
06/09/2025

REVISION:

DRAWN:

REVIEWED:

DATE:

LEON COUNTY SCHOOLS

Client:

Leon County Schools
3420 W. Tharpe St., Suite 100
Tallahassee, FL 32303

Consultant:

23483
100% CDs

Job Title:

Griffin Middle School - Phase 2
800 Alabama St. Tallahassee, FL 32304

Seal:

ALW

Architects Lewis + Whitlock
206 West Virginia St.
Tallahassee, Florida 32301
850.942.1718
www.think3d.net

Description:

Finish Schedules

Sheet No.:

A8.0

THESE DRAWINGS AND RENDERINGS ARE INSTRUMENTS OF SERVICE. THE DRAWINGS AND ASSOCIATED COPIES THEREOF, INCLUDING ELECTRONIC MEDIA AND CAD FILES, ARE THE PROPERTY OF ARCHITECTS LEWIS + WHITLOCK, P.A.A. THEIR USE, REPRESENTATION OR REPRODUCTION FOR ANY PURPOSE EXCEPT BY WRITTEN AGREEMENT WITH THE ARCHITECT IS PROHIBITED. THIS COPYRIGHT NOTIFICATION SHALL BE TRUE AS F DIRECTLY PLACED ON EACH DRAWING EXHIBIT, OR REFERENCED ON THIS DOCUMENT AND SHALL NOT BE REMOVED FROM THESE DOCUMENTS.

5 Shower Floor Detail - Student Showers
1 1/2"= 1'-0"



SYSTEM TO BE COMPLIANT W/ TCNA B421C-24

ONLY INSTALLED IN SHOWER ROOMS.
(SYSTEM TO BE COMPLIANT W/ TCNA F112-24)


ALL AREAS EXCEPT FOR SHOWER ROOMS TO RECEIVE THIS INSTALL METHOD.
(SYSTEM TO BE COMPLIANT W/ TCNA F111-24)

PHASE:	DRAWN:	REVIEWED:	DATE:	ID:	REVISION:	DRAWN:	REVIEWED:	DATE:
DESIGN SCHEM. DESIGN	BG RS	C. WHITLOCK	10/16/2024					
CONCEPT DEVELOPMENT	BG RS	C. WHITLOCK	12/20/2024					
EARLY DEMOLITION PACKAGE	BG RS	R. LEWIS	03/21/2025					
80% CONSTRUCTION DOCS	BG RS	R. LEWIS	03/21/2025					
PERMIT DOCS	BG RS	R. LEWIS	05/09/2025					
100% CONSTRUCTION DOCS	BG RS	R. LEWIS	05/09/2025					

ALW

Architects Lewis + Whitlock
206 West Virginia St.
Tallahassee, Florida 32301
850.942.1718
www.think3d.net

Description: New Gymnasium First Floor Finish Plan
Sheet No.: A8.1

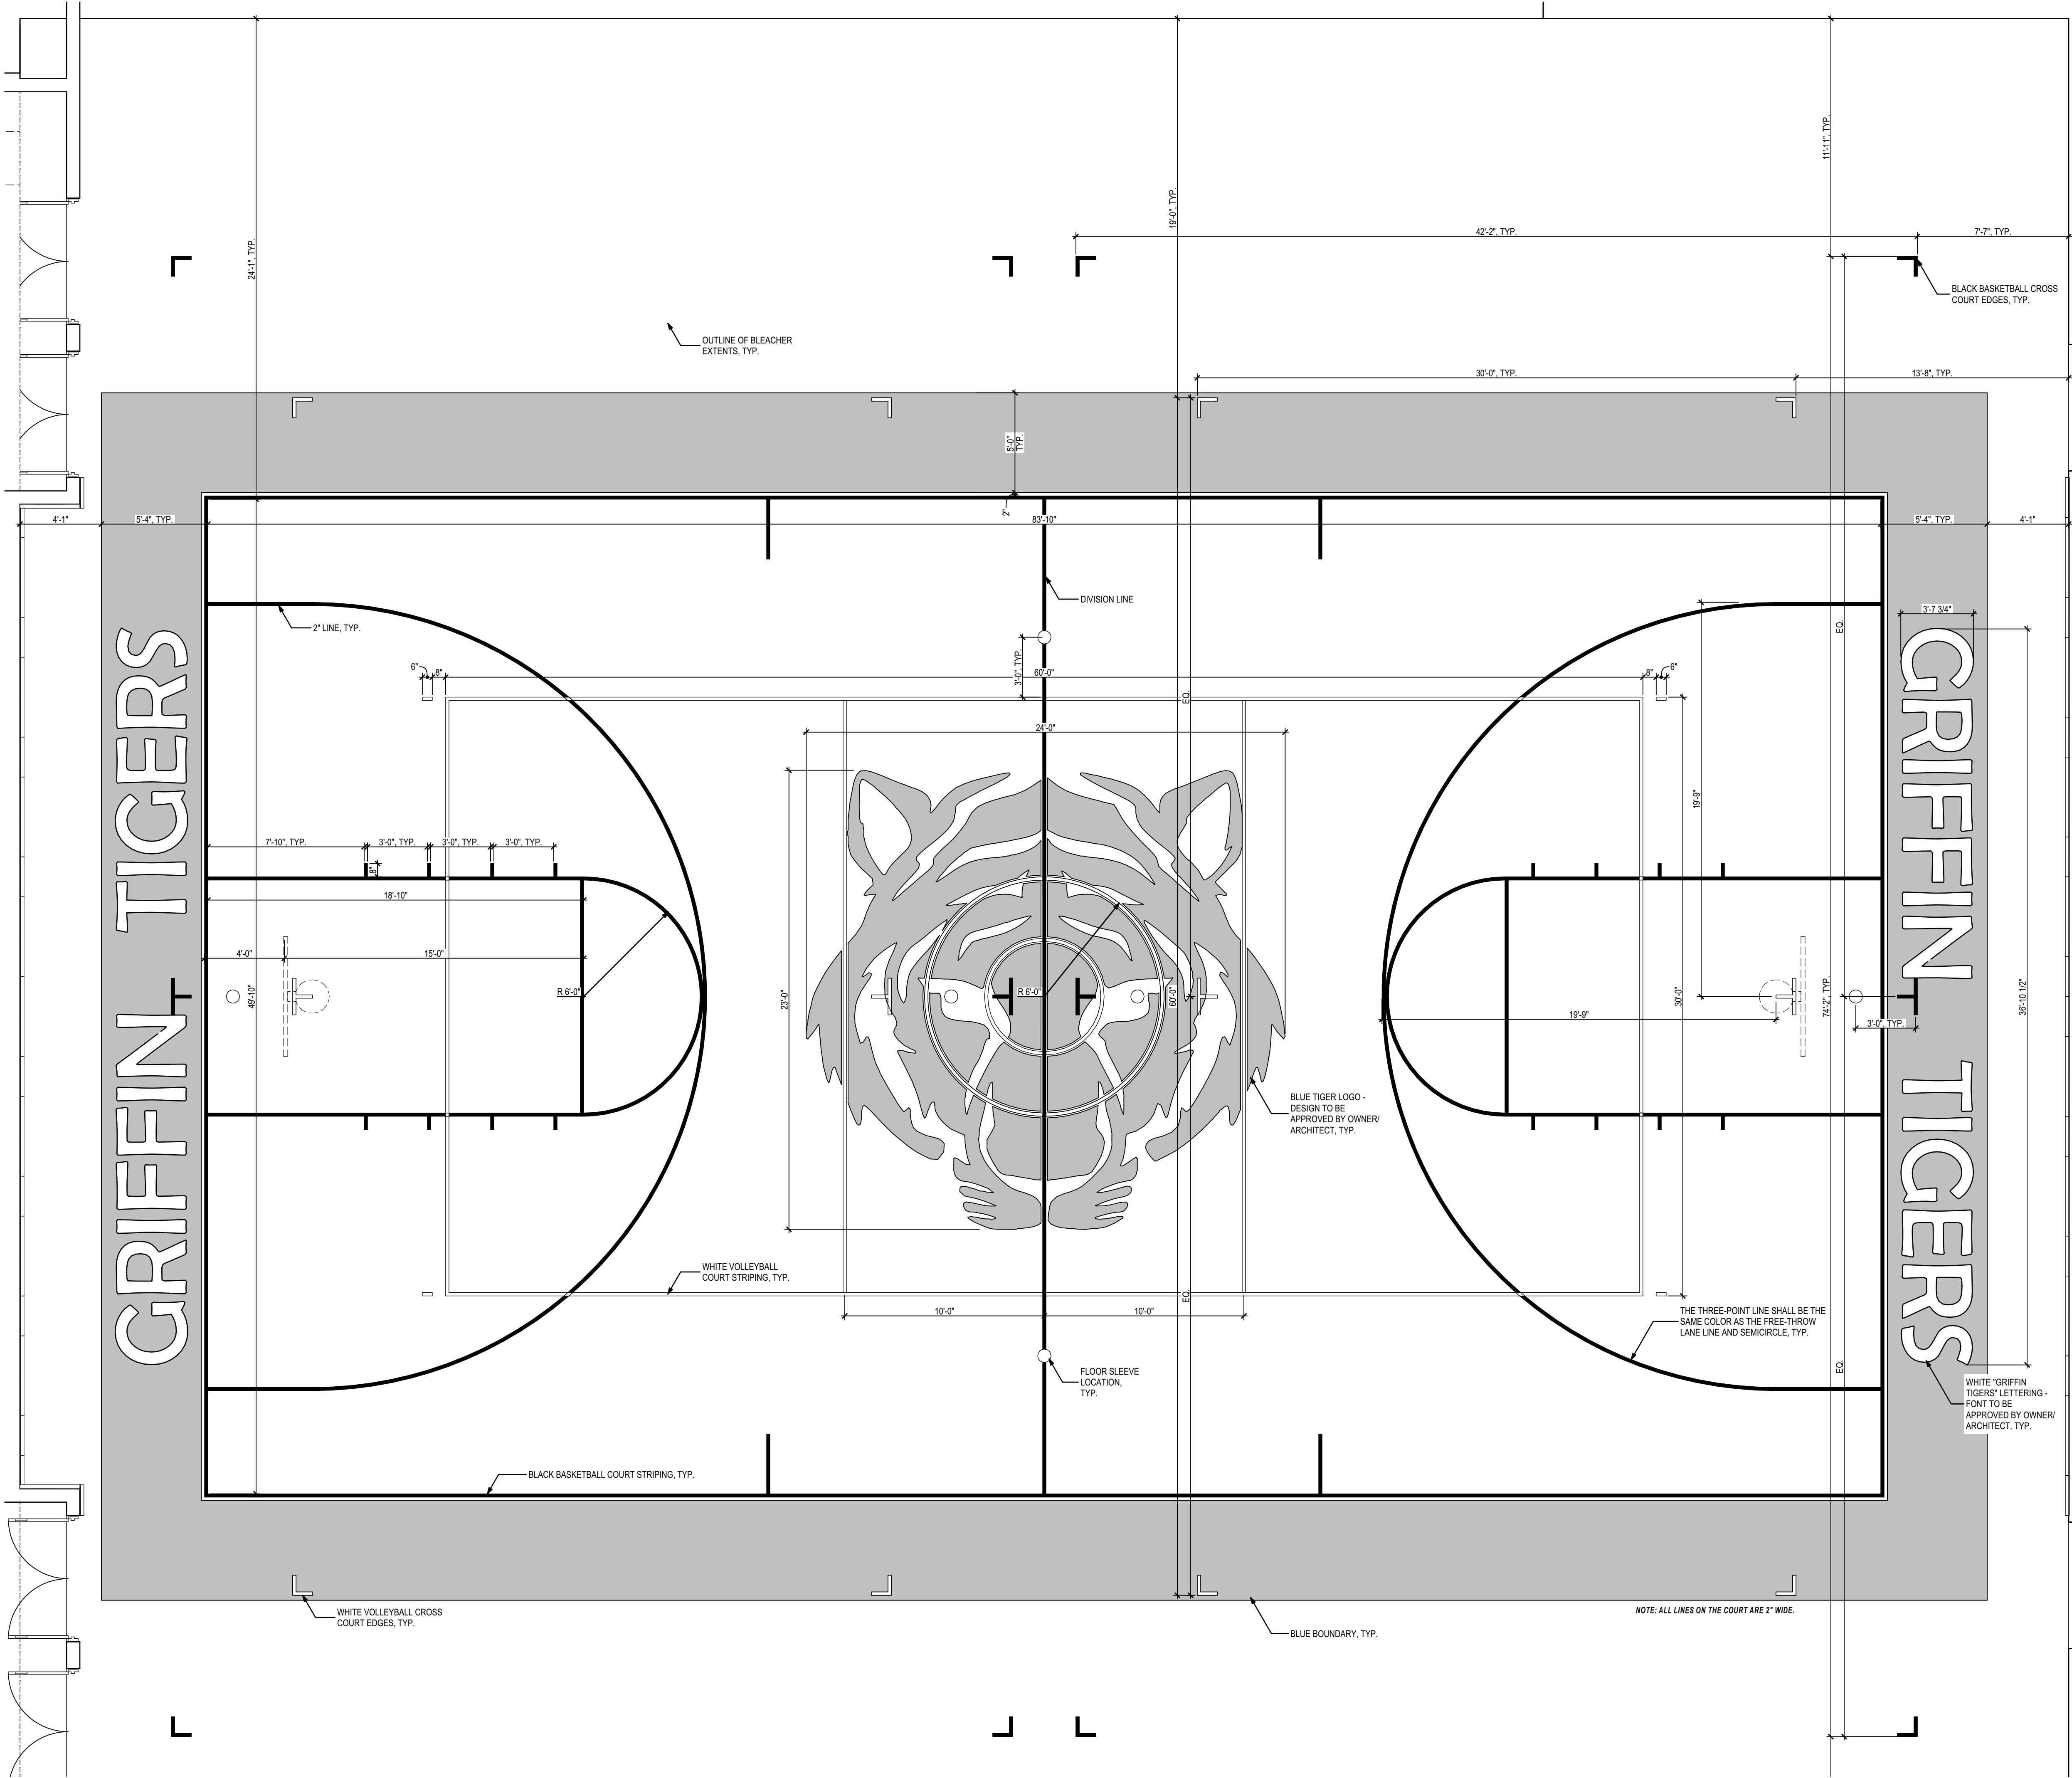

1 Enlarged Gym Floor Plan @ Striping
1/4" = 1'-0"

PHASE:	DRAWN:	REVIEWED:	DATE:	ID:	REVISION:	DRAWN:	REVIEWED:	DATE:
CONCEPT SCHEM. DESIGN	BG / RS	C. WHITLOCK	10/8/2024					
DESIGN DEVELOPMENT	BG/RS/MS	C. WHITLOCK	12/20/2024					
EARLY DEMOLITION PACKAGE	BG/RS/MS	C. WHITLOCK	12/20/2024					
80% CONSTRUCTION DOCS	BG/RS/MS	R. LEWIS	03/21/2025					
PERMIT DOCS	BG/RS/MS	R. LEWIS	03/21/2025					
100% CONSTRUCTION DOCS	BG/RS/MS	R. LEWIS	05/09/2025					

Seal:	Client:	Consultant:	Project #:	23483	Job Title:
	Leon County Schools		Phase:	100% CDs	Griffin Middle School - Phase 2
	3420 W. Tharpe St., Suite 100				800 Alabama St. Tallahassee, FL 32304
	Tallahassee, FL 32303				




Architects Lewis + Whitlock
206 West Virginia St.
Tallahassee, Florida 32301
850.942.1718
www.think3d.net


Description:
**New Gymnasium
Court Striping Plan**

Sheet No.:
A8.2


THESE DRAWINGS AND RENDERINGS ARE INSTRUMENTS OF SERVICE. THE DRAWINGS AND ASSOCIATED COPIES THEREOF, INCLUDING ELECTRONIC MEDIA AND CAD FILES, ARE THE PROPERTY OF ARCHITECTS LEWIS + WHITLOCK, P.A.A. THEIR USE, REPRESENTATION OR REPRODUCTION FOR ANY PURPOSE EXCEPT BY WRITTEN AGREEMENT WITH THE ARCHITECT IS PROHIBITED. THIS COPYRIGHT NOTIFICATION SHALL BE TRUE AS F DIRECTLY PLACED ON EACH DRAWING EXHIBIT. CONVEYING ON THIS DOCUMENT AND SHALL NOT BE REMOVED FROM THESE DOCUMENTS.

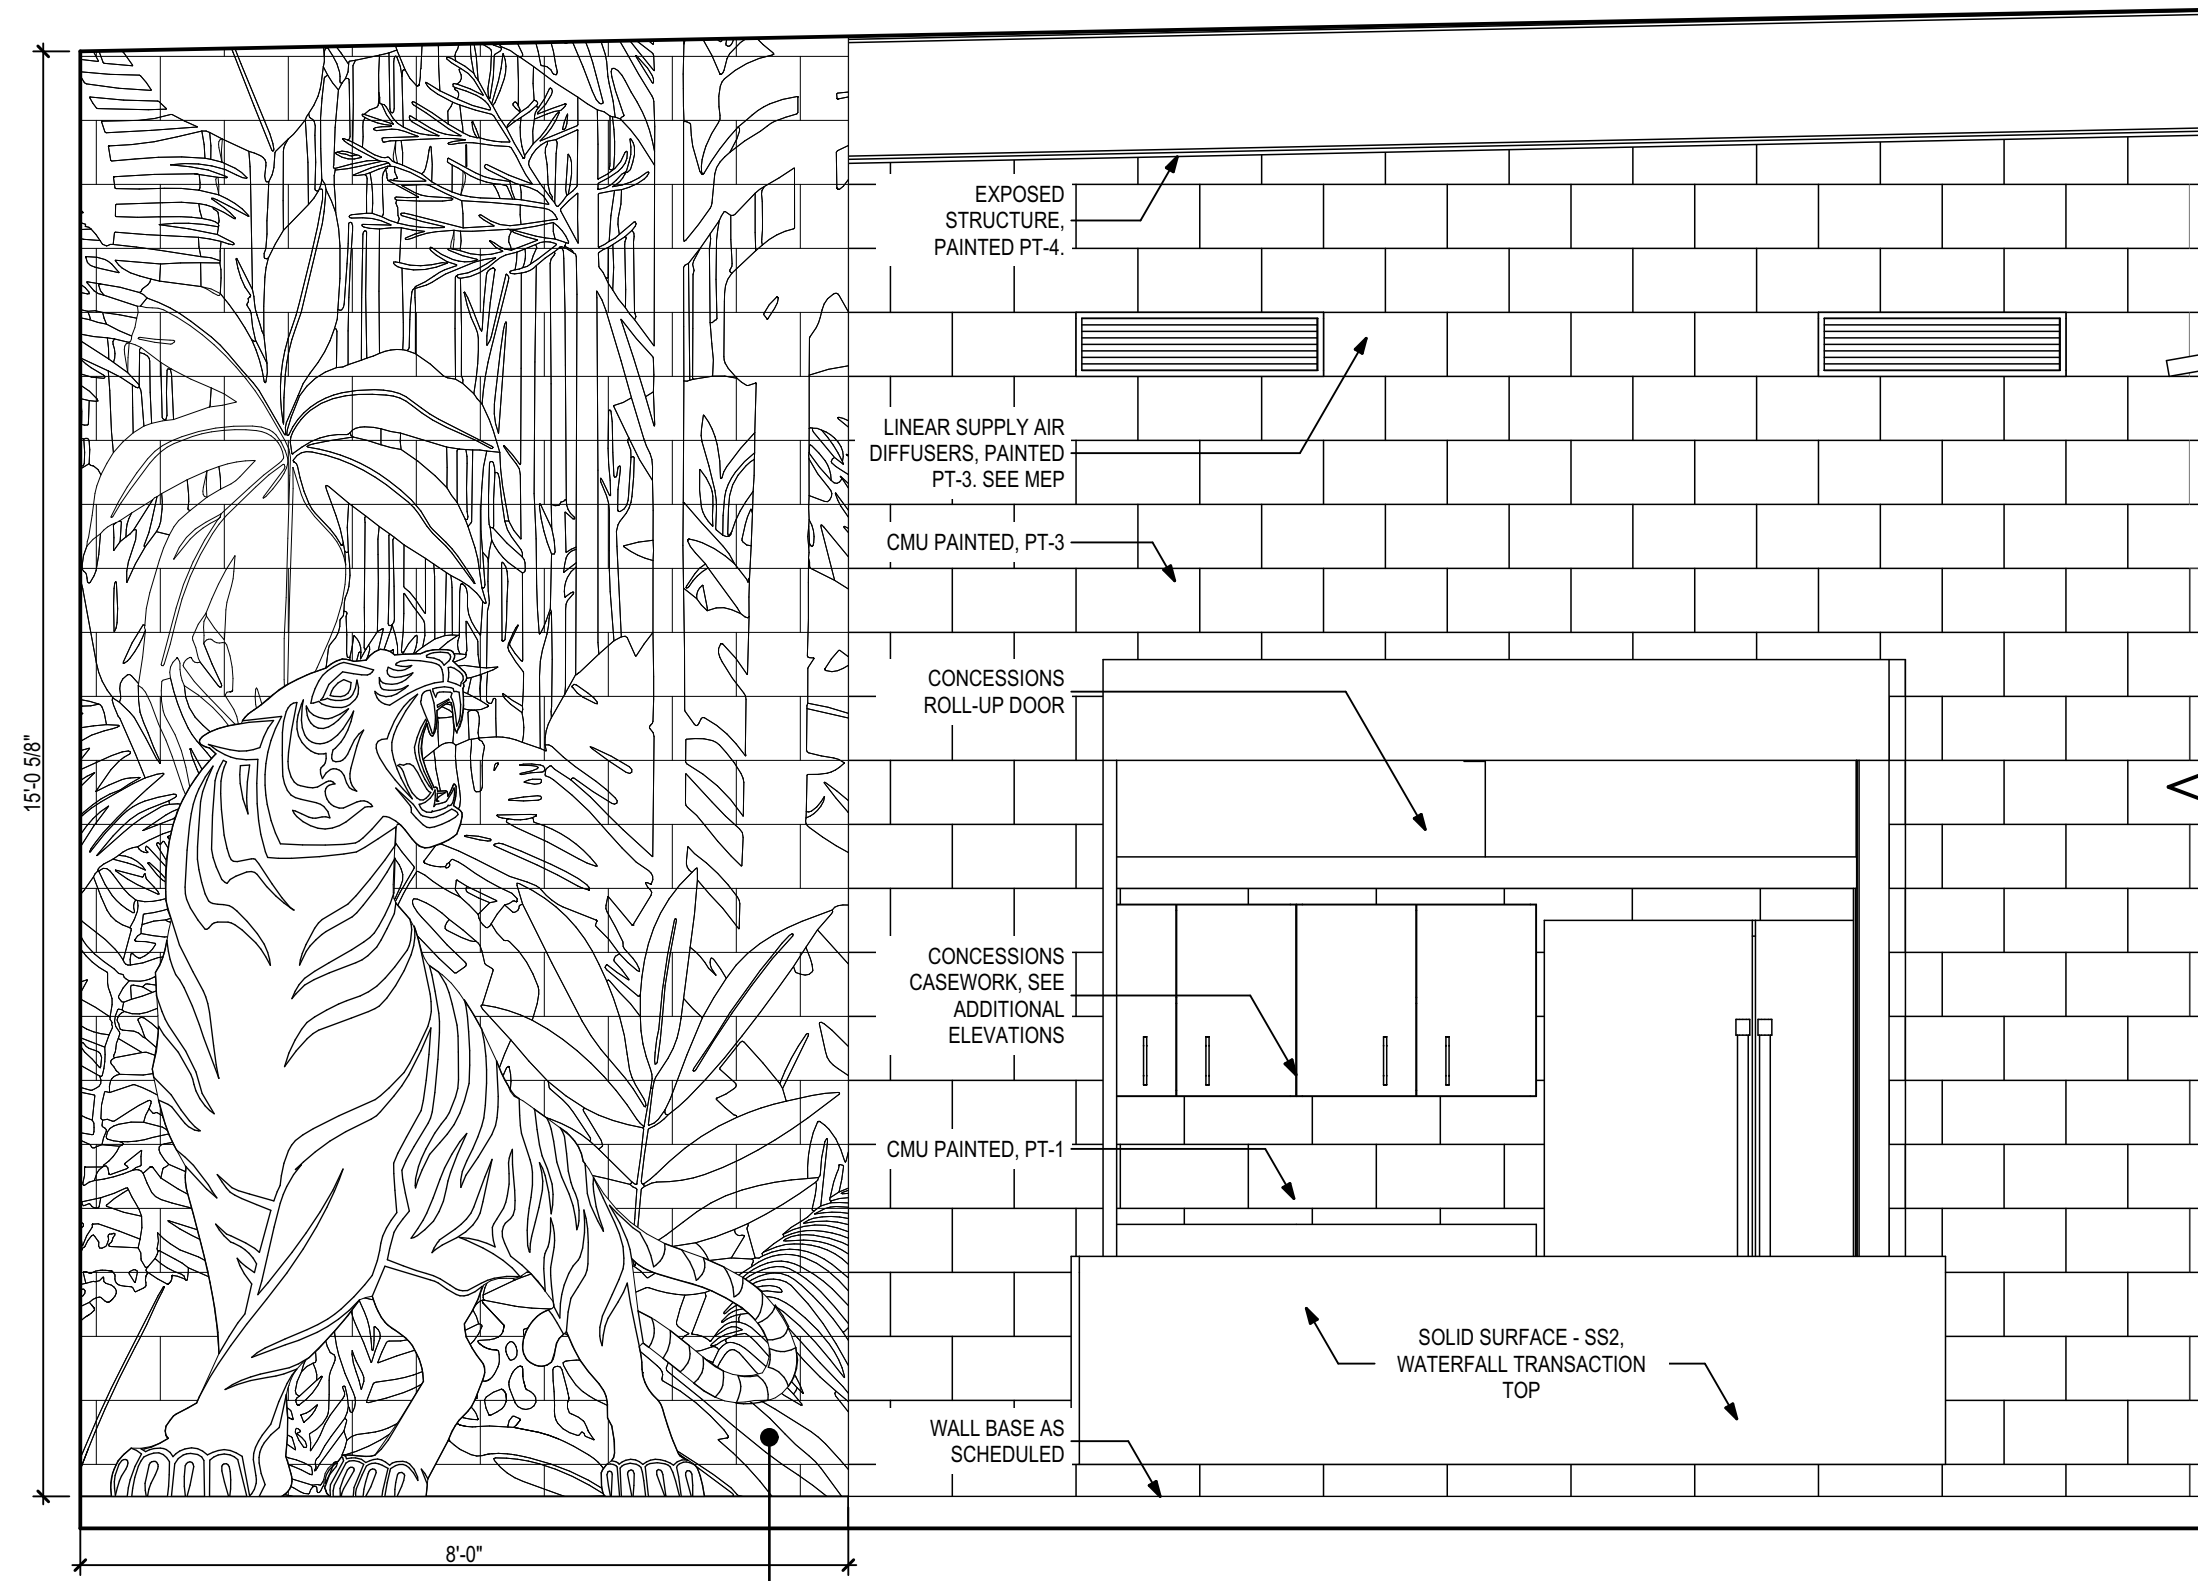



5 Lobby West - Environmental Graphics - Alternate
1/2" = 1'-0"

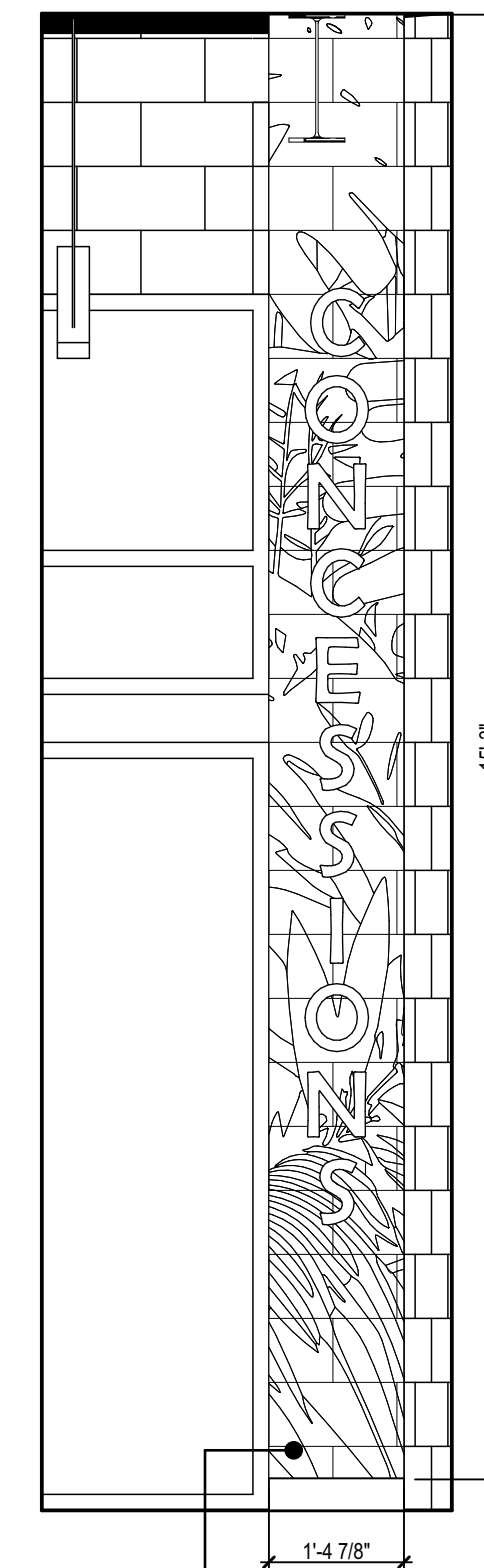


4 Lobby S - Environmental Graphics - Alt.
1/2" = 1'-0"

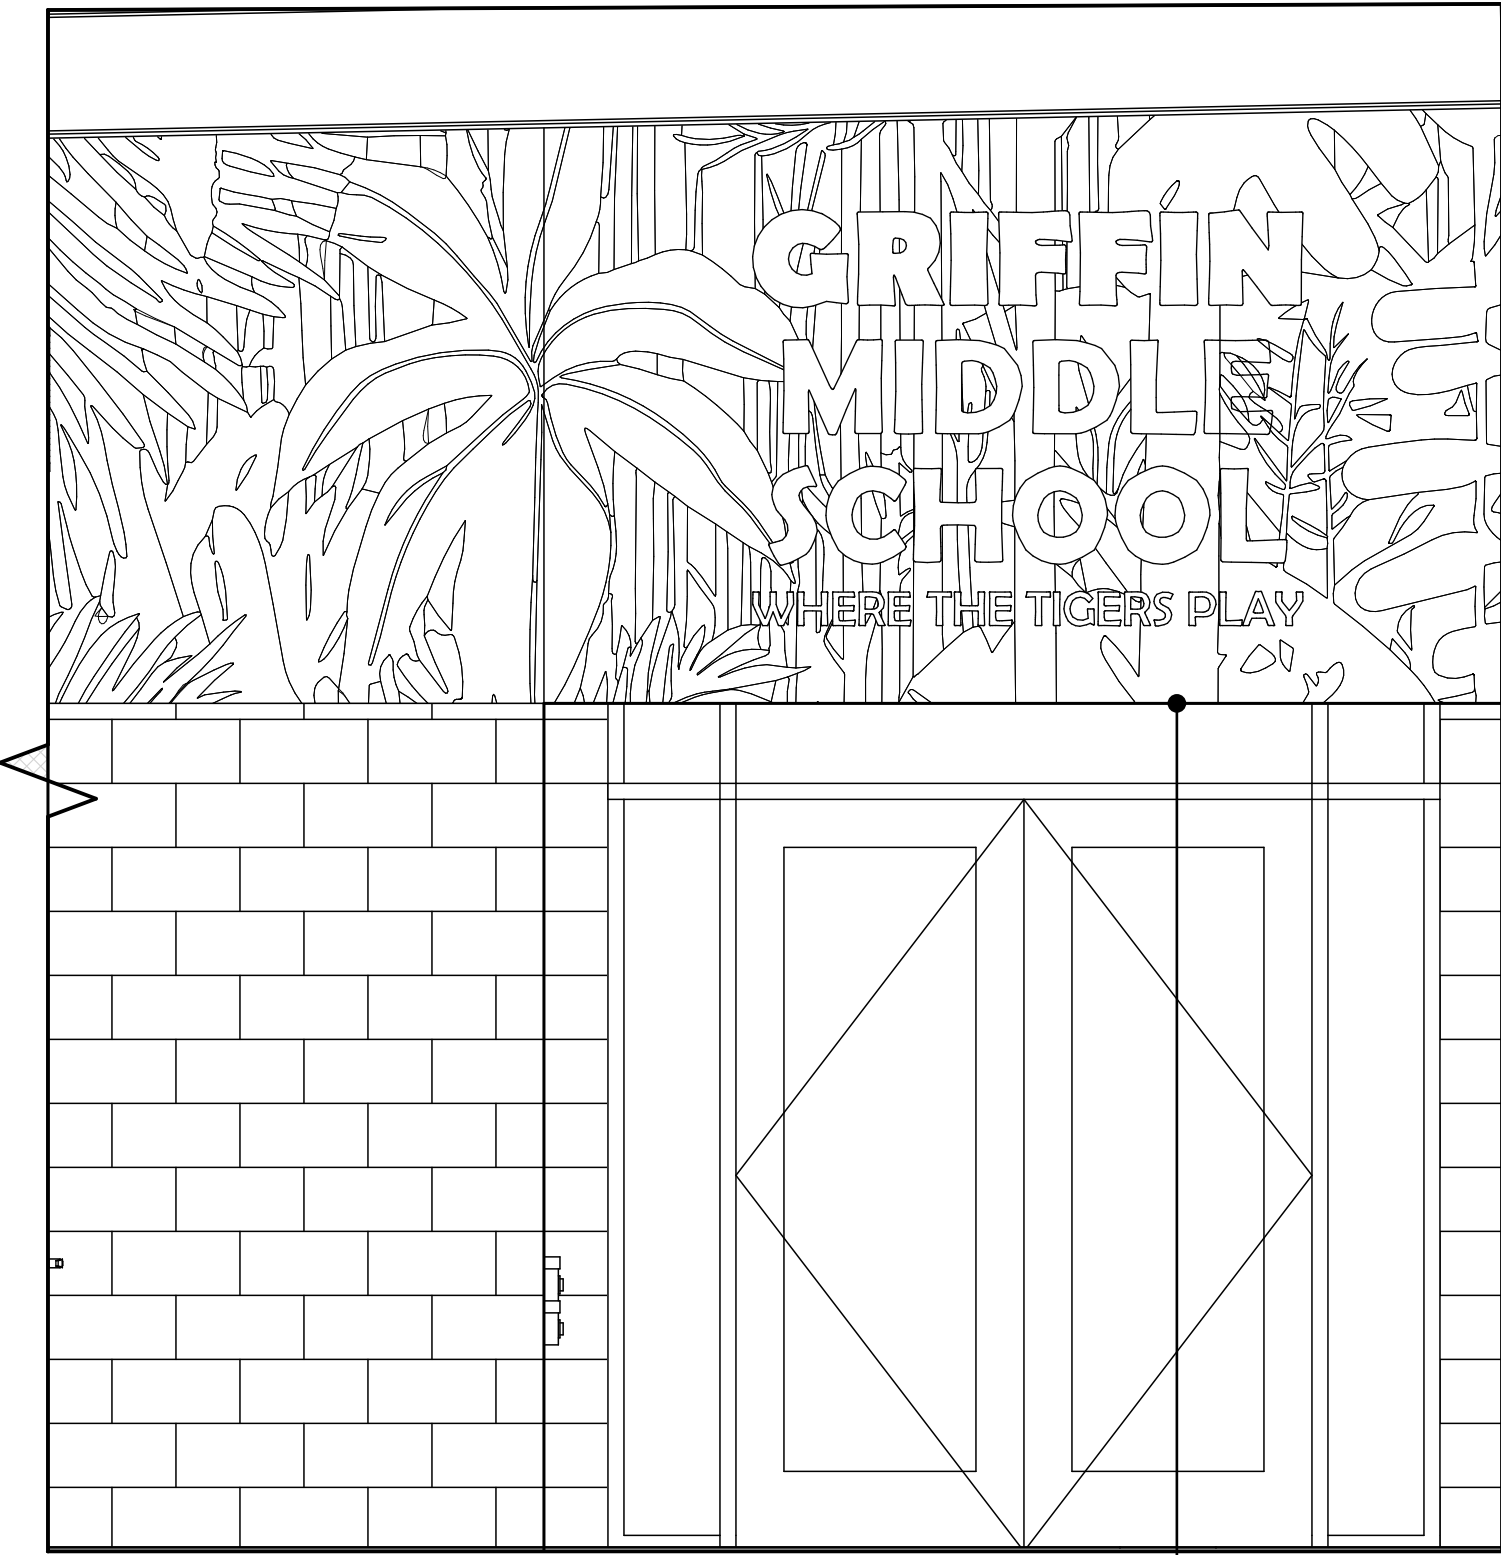

3 Lobby West - Environmental Graphics - Alternate
1/2" = 1'-0"

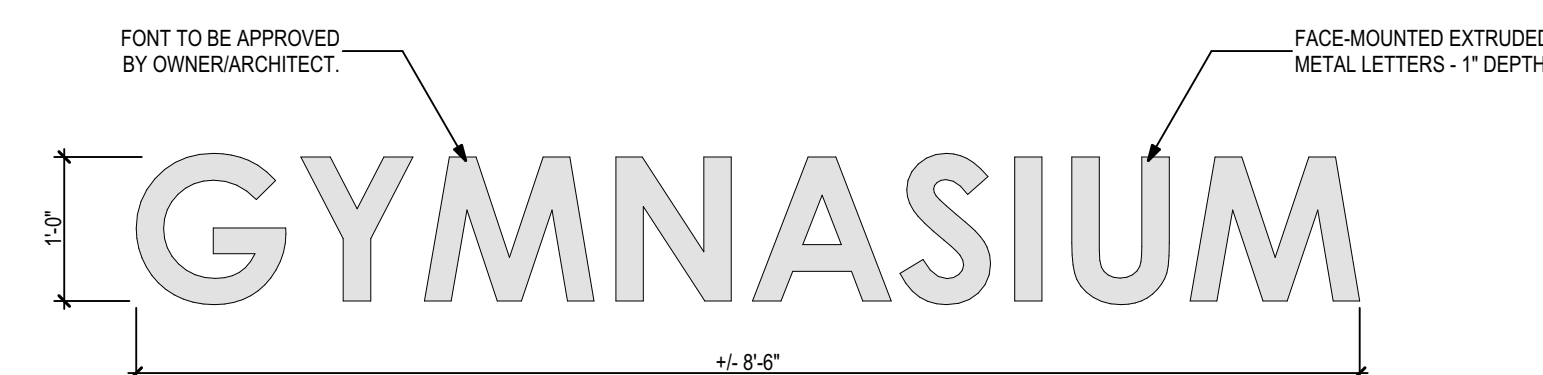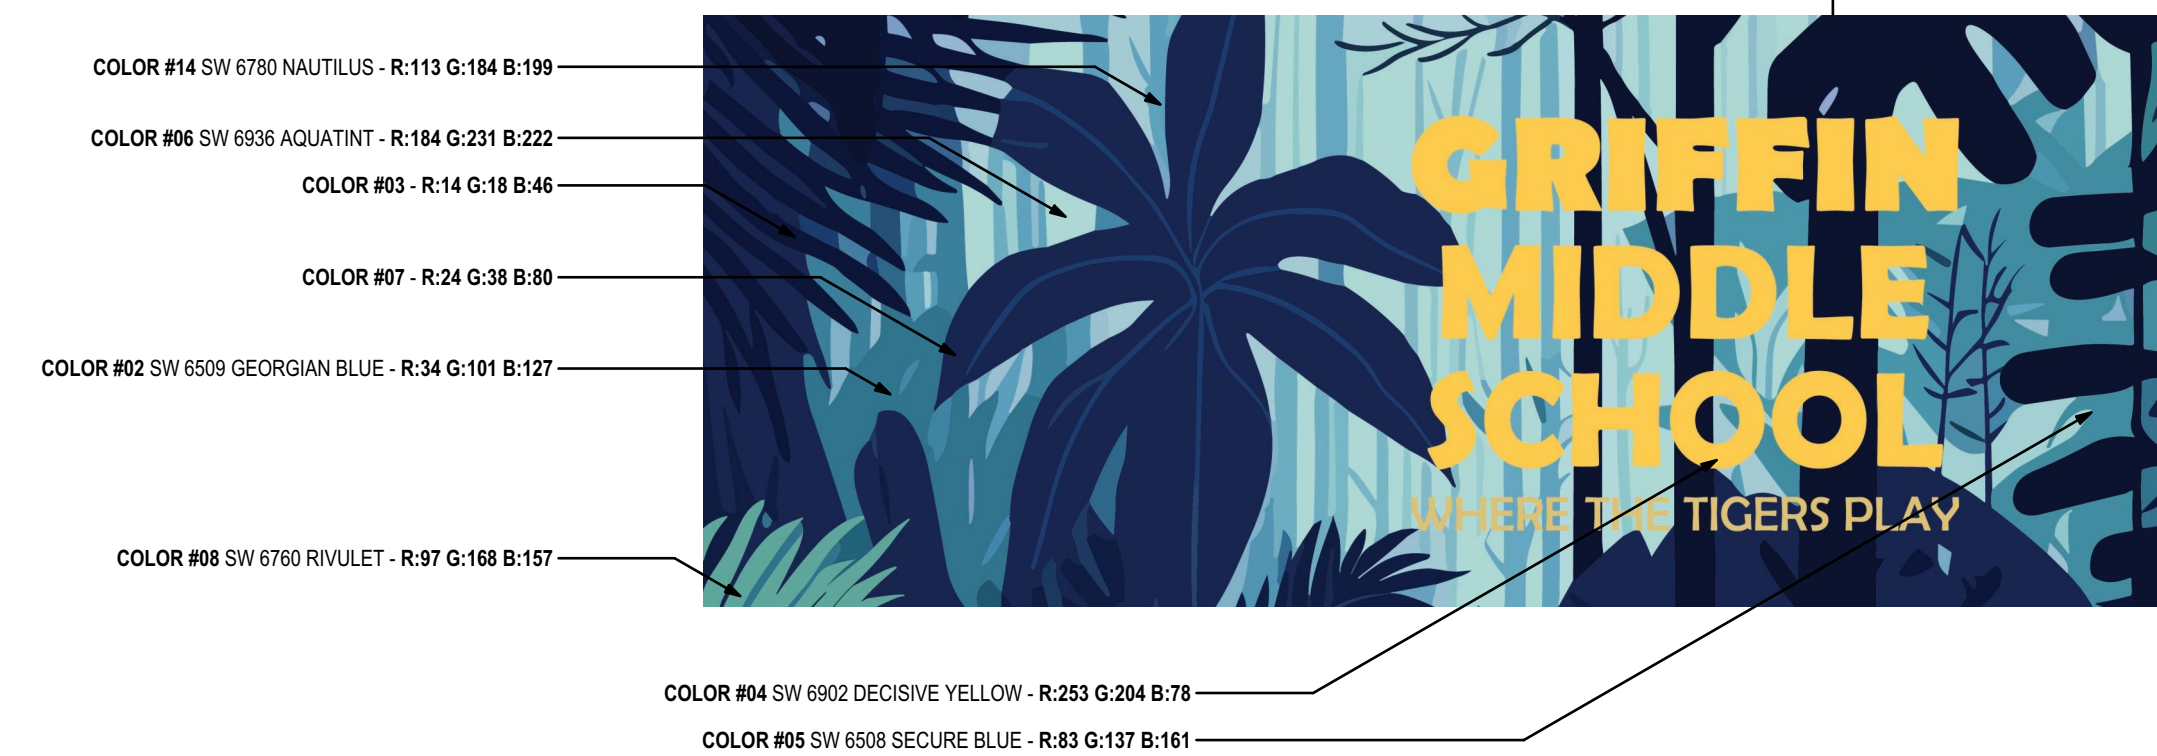

2 Gymnasium Signage - Alternate

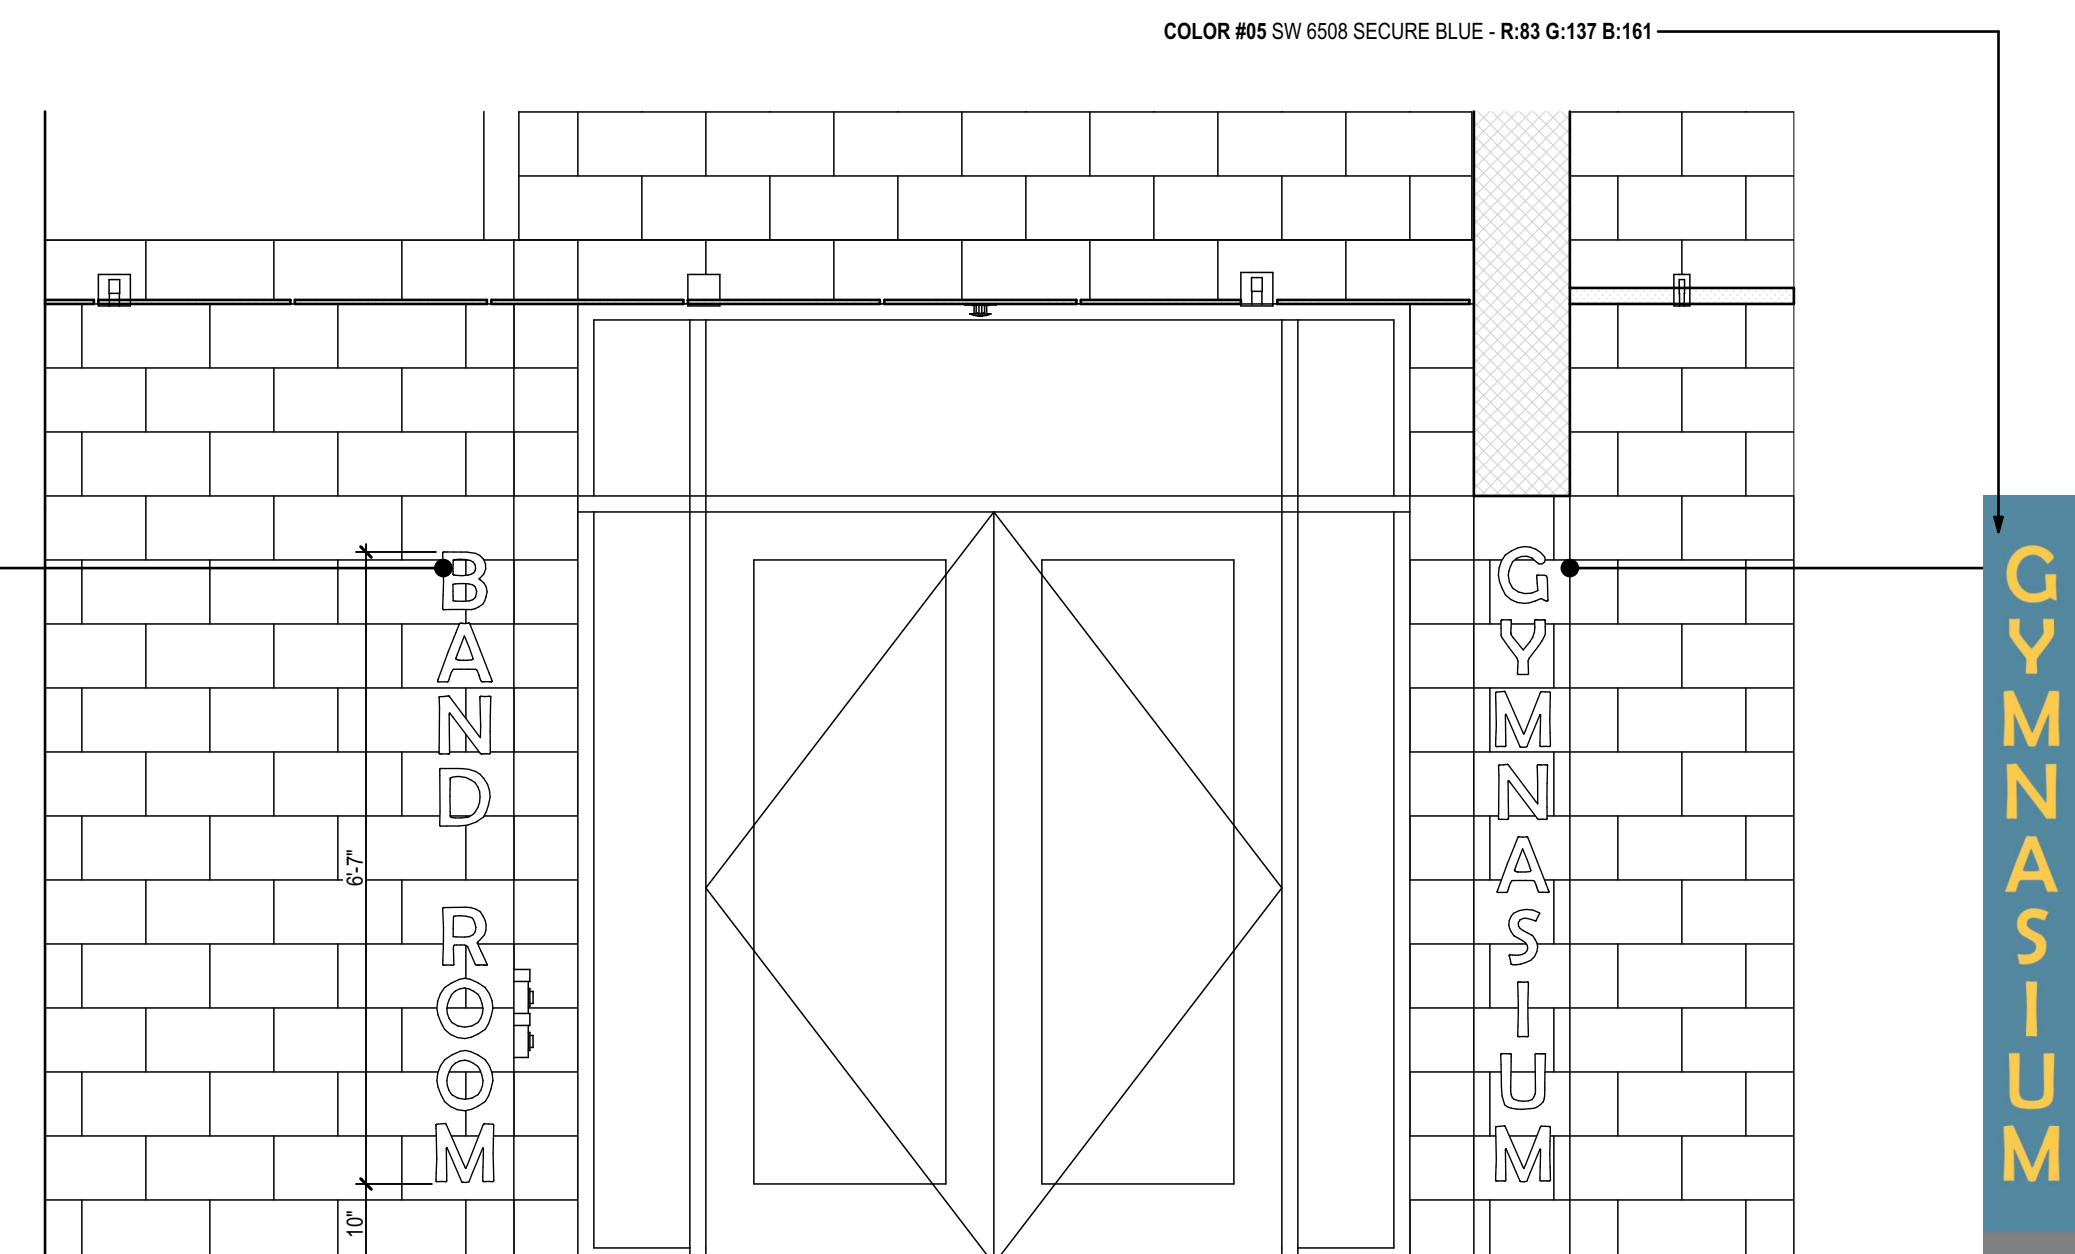

1 Corridor Wayfinding - Alternate

NOTE: THIS SHEET SHOULD BE PRINTED IN COLOR FOR OPTIMUM GRAPHIC CLARITY.

Seal:	Consultant:	Client:	 Leon County Schools 3420 W. Tharpe St., Suite 100 Tallahassee, FL 32303	<table><tr><th>PHASE:</th><th>DRAWN:</th><th>REVIEWED:</th><th>DATE:</th><th>ID:</th><th>REVISION:</th><th>DRAWN:</th><th>REVIEWED:</th><th>DATE:</th></tr><tr><td>CONCEPT SCHEM. DESIGN</td><td>BG RS</td><td>C. WHITLOCK</td><td>10/8/2024</td><td></td><td></td><td></td><td></td><td></td></tr><tr><td>DESIGN DEVELOPMENT</td><td>BG/KS/RS/MS</td><td>C. WHITLOCK</td><td>12/20/2024</td><td></td><td></td><td></td><td></td><td></td></tr><tr><td>EARLY DEMOLITION PACKAGE</td><td></td><td></td><td></td><td></td><td></td><td></td><td></td><td></td></tr><tr><td>80% CONSTRUCTION DOCS</td><td>BG/RS/MS</td><td>R. LEWIS</td><td>03/21/2025</td><td></td><td></td><td></td><td></td><td></td></tr><tr><td>PERMIT DOCS.</td><td></td><td></td><td></td><td></td><td></td><td></td><td></td><td></td></tr><tr><td>100% CONSTRUCTION DOCS.</td><td>BG/RS/MS</td><td>R. LEWIS</td><td>05/09/2025</td><td></td><td></td><td></td><td></td><td></td></tr></table>	PHASE:	DRAWN:	REVIEWED:	DATE:	ID:	REVISION:	DRAWN:	REVIEWED:	DATE:	CONCEPT SCHEM. DESIGN	BG RS	C. WHITLOCK	10/8/2024						DESIGN DEVELOPMENT	BG/KS/RS/MS	C. WHITLOCK	12/20/2024						EARLY DEMOLITION PACKAGE									80% CONSTRUCTION DOCS	BG/RS/MS	R. LEWIS	03/21/2025						PERMIT DOCS.									100% CONSTRUCTION DOCS.	BG/RS/MS	R. LEWIS	05/09/2025						Project #: 23483 Phase: 100% CDs Job Title: Griffin Middle School - Phase 2 800 Alabama St. Tallahassee, FL 32304 THESE DRAWINGS AND PERMITTERS ARE INSTRUMENTS OF SERVICE. THE DRAWINGS AND ASSOCIATED COPIES THEREOF, INCLUDING ELECTRONIC MEDIA AND CAD FILES, ARE THE PROPERTY OF ARCHITECTS LEWIS + WHITLOCK, P.A.A. THEIR USE, REPRESENTATION OR REPRODUCTION FOR ANY PURPOSE EXCEPT BY WRITTEN AGREEMENT WITH THE ARCHITECT IS PROHIBITED. THIS COPYRIGHT NOTIFICATION SHALL BE TRUE AS IF DIRECTLY PLACED ON EACH DRAWING EXCEPT BY WRITING OR OTHERWISE ON THIS DOCUMENT AND SPREAD SHEET. REMOVAL FROM THESE DOCUMENTS
PHASE:	DRAWN:	REVIEWED:	DATE:	ID:	REVISION:	DRAWN:	REVIEWED:	DATE:																																																												
CONCEPT SCHEM. DESIGN	BG RS	C. WHITLOCK	10/8/2024																																																																	
DESIGN DEVELOPMENT	BG/KS/RS/MS	C. WHITLOCK	12/20/2024																																																																	
EARLY DEMOLITION PACKAGE																																																																				
80% CONSTRUCTION DOCS	BG/RS/MS	R. LEWIS	03/21/2025																																																																	
PERMIT DOCS.																																																																				
100% CONSTRUCTION DOCS.	BG/RS/MS	R. LEWIS	05/09/2025																																																																	

ALW

Architects Lewis + Whitlock
206 West Virginia St.
Tallahassee, Florida 32301
850.942.1718
www.think3d.net

Description:

Alternates

Sheet No.:

A10.1