

PLUMBING FIXTURE SCHEDULE (BASIS OF DESIGN)							
TYPE	DESCRIPTION	TRIM & ACCESSORIES	FIXTURE CONNECTIONS				
			CW	HW	WASTE	VENT	
WC-1	ADA WATER CLOSET, FLOOR MOUNT, VITREOUS CHINA, 16 $\frac{1}{2}$ " RIM HGT, ELONGATED BOWL, FLUSHOMETER VALVE SIPHON, 1-1/2" TOP SPUD, 1.6 GALLON FLUSH.	KOHLER HIGHCLIFF ULTRA K-96057			3"	2"	
L-1	21 $\frac{1}{2}$ "x18 $\frac{1}{2}$ " WALL-HUNG VITREOUS CHINA LAVATORY, SINGLE HOLE INSTALLATION, ADA COMPLIANT.	KOHLER K-2007-0	1/2"	1/2"	2"	1 1/2"	
L-2	21 $\frac{1}{2}$ "x18 $\frac{1}{2}$ " WALL-HUNG VITREOUS CHINA LAVATORY, SINGLE HOLE INSTALLATION, ADA COMPLIANT.	KOHLER K-2007-0	1/2"		2"	1 1/2"	
U-1	URINAL - WALL MOUNT, WHITE VITREOUS CHINA, $\frac{3}{4}$ " TOP SPUD, 1.0 GALLON FLUSH, 14" EXTENDED RIM. SEE ARCHITECTURAL PLANS FOR MOUNTING HEIGHTS.	KOHLER BARDON K-4991-ETSS			2"	2"	
U-2	URINAL - WALL MOUNT, WHITE VITREOUS CHINA, $\frac{3}{4}$ " TOP SPUD, 1.0 GALLON FLUSH, 14" EXTENDED RIM. SEE ARCHITECTURAL PLANS FOR MOUNTING HEIGHTS. ADA COMPLIANT.	KOHLER BARDON K-4991-ETSS			2"	2"	
SH-1	PREFABRICATED STAINLESS STEEL SHOWER UNIT	ZURN Z7500-I2	1/2"	1/2"	2"	2"	
SH-2	PREFABRICATED STAINLESS STEEL SHOWER UNIT. ADA COMPLIANT.	ZURN Z7500-HW	1/2"	1/2"	2"	2"	
SK-1	SINGLE BOWL UNDERMOUNT SINK, 18 GA. TYPE 304 STAINLESS STEEL SINK. 23 $\frac{1}{2}$ "x18 $\frac{1}{4}$ "x7 $\frac{1}{2}$ " DEEP.	JUST US1824A-J	1/2"	1/2"	2"	1 1/2"	
SK-2	SINGLE BOWL UNDERMOUNT SINK, 18 GA. TYPE 304 STAINLESS STEEL SINK. 21 $\frac{1}{2}$ "x18 $\frac{1}{2}$ "x7 $\frac{1}{2}$ " DEEP.	JUST US1821A-J	1/2"	1/2"	2"	1 1/2"	
SK-3	SINGLE BOWL WALL HUNG HANDWASH SINK KIT W/FAUCET, DRAIN, AND P-TRAP. TYPE 304 STAINLESS STEEL. 16 $\frac{1}{2}$ "x15 $\frac{1}{2}$ "x6" DEEP.	ELKAY CHS1716C	1/2"	1/2"	2"	1 1/2"	
MS-1	32"x32"x12" PRECAST TERRAZZO MOP SERVICE BASIN	FIAT TSBC1611	1/2"	1/2"	3"	2"	
US-1	1-COMPARTMENT SINK. 16 GAUGE 300 SERIES STAINLESS STEEL. CENTER DRAIN. 29"x29 $\frac{3}{16}$ "x43 $\frac{3}{4}$ ".	ELKAY 14-1C24X24-0X	1/2"	1/2"	3"	2"	
EW-1	BOTTLE FILLING STATION AND BI-LEVEL ADA COOLER, FILTERED REFRIGERATED LIGHT GRAY GRANITE. CHILLING CAPACITY OF 8.0 GPH (GALLONS PER HOUR) OF 50° F DRINKING WATER BASED ON 80° F INLET WATER AND 90° F AMBIENT, PER ASHRAE 18 TESTING. BOTTLE FILLER TO BE ON THE RIGHT SIDE.	ELKAY LMABFTL8WSLK	1/2"		2"	1 1/2"	
HB-1	WALL FAUCET, POLISHED CHROME	T&S BRASS B-0737-POL	3/4"				
IMB-1	RECESSED ICE MAKER HOOK-UP BOX	GUY GRAY BIM 875	1/2"				
WMB-1	HOT-DIPPED GALVANIZED STEEL WASHING MACHING OUTLET BOX	GUY GRAY B200	1/2"	1/2"	2"	1 1/2"	
IM-1	ICE MACHINE/ICE STORAGE BIN	HOSHIZAKI KM-350MAJ/B-300SF	1/2"		(2) 3/4" INDIRECT WASTE		
IMF-1	ICE MACHINE WATER FILTER	HOSHIZAKI H9320-51	(2) 3/8"				

PLUMBING FIXTURE SCHEDULE (BASIS OF DESIGN)							
TYPE	DESCRIPTION	TRIM & ACCESSORIES	FIXTURE CONNECTIONS				
			CW	HW	WASTE	VENT	
PRV-1	WATER PRESSURE REDUCING VALVE WITH STRAINER	ZURN 50XL3					
TMV-1	THERMOSTATIC WATER CONTROLLER. 110° SET TEMP.	LAWLER 66-50	2 1/2"				
TMV-2	THERMOSTATIC WATER CONTROLLER. 110° SET TEMP.	LAWLER 66-80	3/4"	3/4" IN 3/4" OUT			
TP-1	PRESSURE DROP ACTIVATED TRAP PRIMER	PPP PR-500	1"	1" IN 1 1/4" OUT			
FCO	ADJUSTABLE FLOOR CLEANOUT, DURA-COATED CAST IRON BODY WITH GAS AND WATERTIGHT ABS TAPERED THREAD PLUG AND ROUND SCORRIATED CAST IRON EXTRA-HEAVY-DUTY SECURED POLISHED BRONZE TOP ADJUSTABLE TO FINISHED FLOOR.	ZURN Z1400	1/2"				
WCO	CLEANOUT TEE, DURA-COATED CAST IRON BODY, GAS AND WATERTIGHT ABS TAPERED THREAD PLUG, AND ROUND, SMOOTH STAINLESS STEEL WALL ACCESS COVER WITH SECURING SCREW.	ZURN Z1446					
ECO	ADJUSTABLE FLOOR CLEANOUT, DURA-COATED CAST IRON BODY WITH GAS AND WATERTIGHT ABS TAPERED THREAD PLUG AND ROUND SCORRIATED CAST IRON EXTRA-HEAVY-DUTY SECURED POLISHED BRONZE TOP ADJUSTABLE TO FINISHED FLOOR.	ZURN Z1400					
WHA	WATER HAMMER ARRESTOR	ZURN 1260XL					
BFP-1	DUAL CHECK BACKFLOW PREVENTER	ZURN 740					

DRAIN SCHEDULE (BASIS OF DESIGN)						
TYPE	DESCRIPTION	MODEL	TRIM & ACCESSORIES	FIXTURE CONNECTIONS		
				CW	WASTE	VENT
FD-1	CAST IRON GENERAL SERVICE FLOOR DRAIN WITH SQUARE TOP AND AUXILIARY TRAP PRIMER FITTING.	ZURN Z415S	DUCO COATED CAST IRON BODY W/ FLASHING COLLAR AND ADJUSTABLE 7"x7" SQUARE POLISHED BRONZE STRAINER HEAD, TRAP PRIMER FITTING 1/2" NPT TAPPING.	1/2"	3"	2"
FD-2	CAST IRON GENERAL SERVICE FLOOR DRAIN WITH ROUND TOP.	ZURN Z415B	DUCO COATED CAST IRON BODY W/ FLASHING COLLAR AND ADJUSTABLE 8" ROUND NICKEL BRONZE STRAINER, SEDIMENT BUCKET. PROVIDE J.R. SMITH 2692 TRAP SEAL IN LIEU OF TRAP PRIMER CONNECTION.		3"	2"
HD-1	CAST IRON FIXED AIR GAP FITTING.	ZURN Z1024	DUCO CAST IRON WITH SET SCREW AND DEEP SEAL P-TRAP.		2"	
HD-2	BELLMOUTH HUB DRAIN		PVC REDUCER, 3"x2" W/ P-TRAP. PROVIDE J.R. SMITH 2692 TRAP SEAL IN LIEU OF TRAP PRIMER CONNECTION.		2"	2"
CD-1	CAST IRON CONDENSATE RECEPTOR	ZURN Z4151	DURA COATED CAST IRON BODY W/ FLASHING COLLAR AND ADJUSTABLE 7" ROUND NICKEL BRONZE STRAINER, WITH RAISED FLANGE. PROVIDE J.R. SMITH 2692 TRAP SEAL IN LIEU OF TRAP PRIMER CONNECTION.	0"	3"	2"
SD-1	STAINLESS STEEL LINEAR SHOWER DRAIN	ZURN ZS880	TYPE 304 STAINLESS STEEL LINEAR SHOWER DRAIN. 2" NO-HUB CENTER OUTLET, SECURED, LIGHT-DUTY, SLOTTED HEEL-PROOF GRATE. 12" LONG DRAIN, 14" LONG FRAME.		2"	2"
SD-2	STAINLESS STEEL LINEAR SHOWER DRAIN	ZURN ZS880	TYPE 304 STAINLESS STEEL LINEAR SHOWER DRAIN. 2" NO-HUB CENTER OUTLET, SECURED, LIGHT-DUTY, SLOTTED HEEL-PROOF GRATE. 28" LONG DRAIN, 30" LONG FRAME.		2"	2"
RD-1 OD-1	COMBINATION MAIN ROOF AND OVERFLOW DRAIN	ZURN Z163	15" DIAMETER ROOF DRAIN AND OVERFLOW DRAIN, DURA-COATED CAST IRON BODIES WITH COMBINATION MEMBRANE FLASHING CLAMP/GRAVEL GUARDS, DOUBLE TOP-SET DECK PLATE, AND LOW SILHOUETTE POLY-DOMES.	SEE PLANS FOR SIZES		


PHASE:	DRAWN:	REVIEWED:	DATE:	ID:	REVISION:	DRAWN/REVIEWED DATE:			
						TEP	JB		

CONCEPT SCHEM. DESIGN	TEP	JB	12/20/2024	1	Address #1				
DESIGN DEVELOPMENT	TEP	JB							
EARLY DEMOLITION PACKAGE									
80% CONSTRUCTION DOCS									
PERMIT DOCS									
100% CONSTRUCTION DOCS									

Client:	Leon County Schools 3420 W. Tharpe St., Suite 100 Tallahassee, FL 32303
Consultant:	MCGINNIS + FLEMING ENGINEERING 401 MONROE BLVD, SUITE 100 TALLAHASSEE, FL 32301 WWW.MFCOM.ORG
Seal:	Professional Engineer No. 55427 STATE OF FLORIDA JON M. BARBER
Project #:	23483
Phase:	100% Construction Documents
Job Title:	Griffin Middle School - Phase 2 800 Alabama St. Tallahassee, FL 32304

Architects Lewis + Whitlock 206 West Virginia St. Tallahassee, Florida 32301 850.942.1718 www.think3d.net

Description: Plumbing Schedules
Sheet No.: P1.1

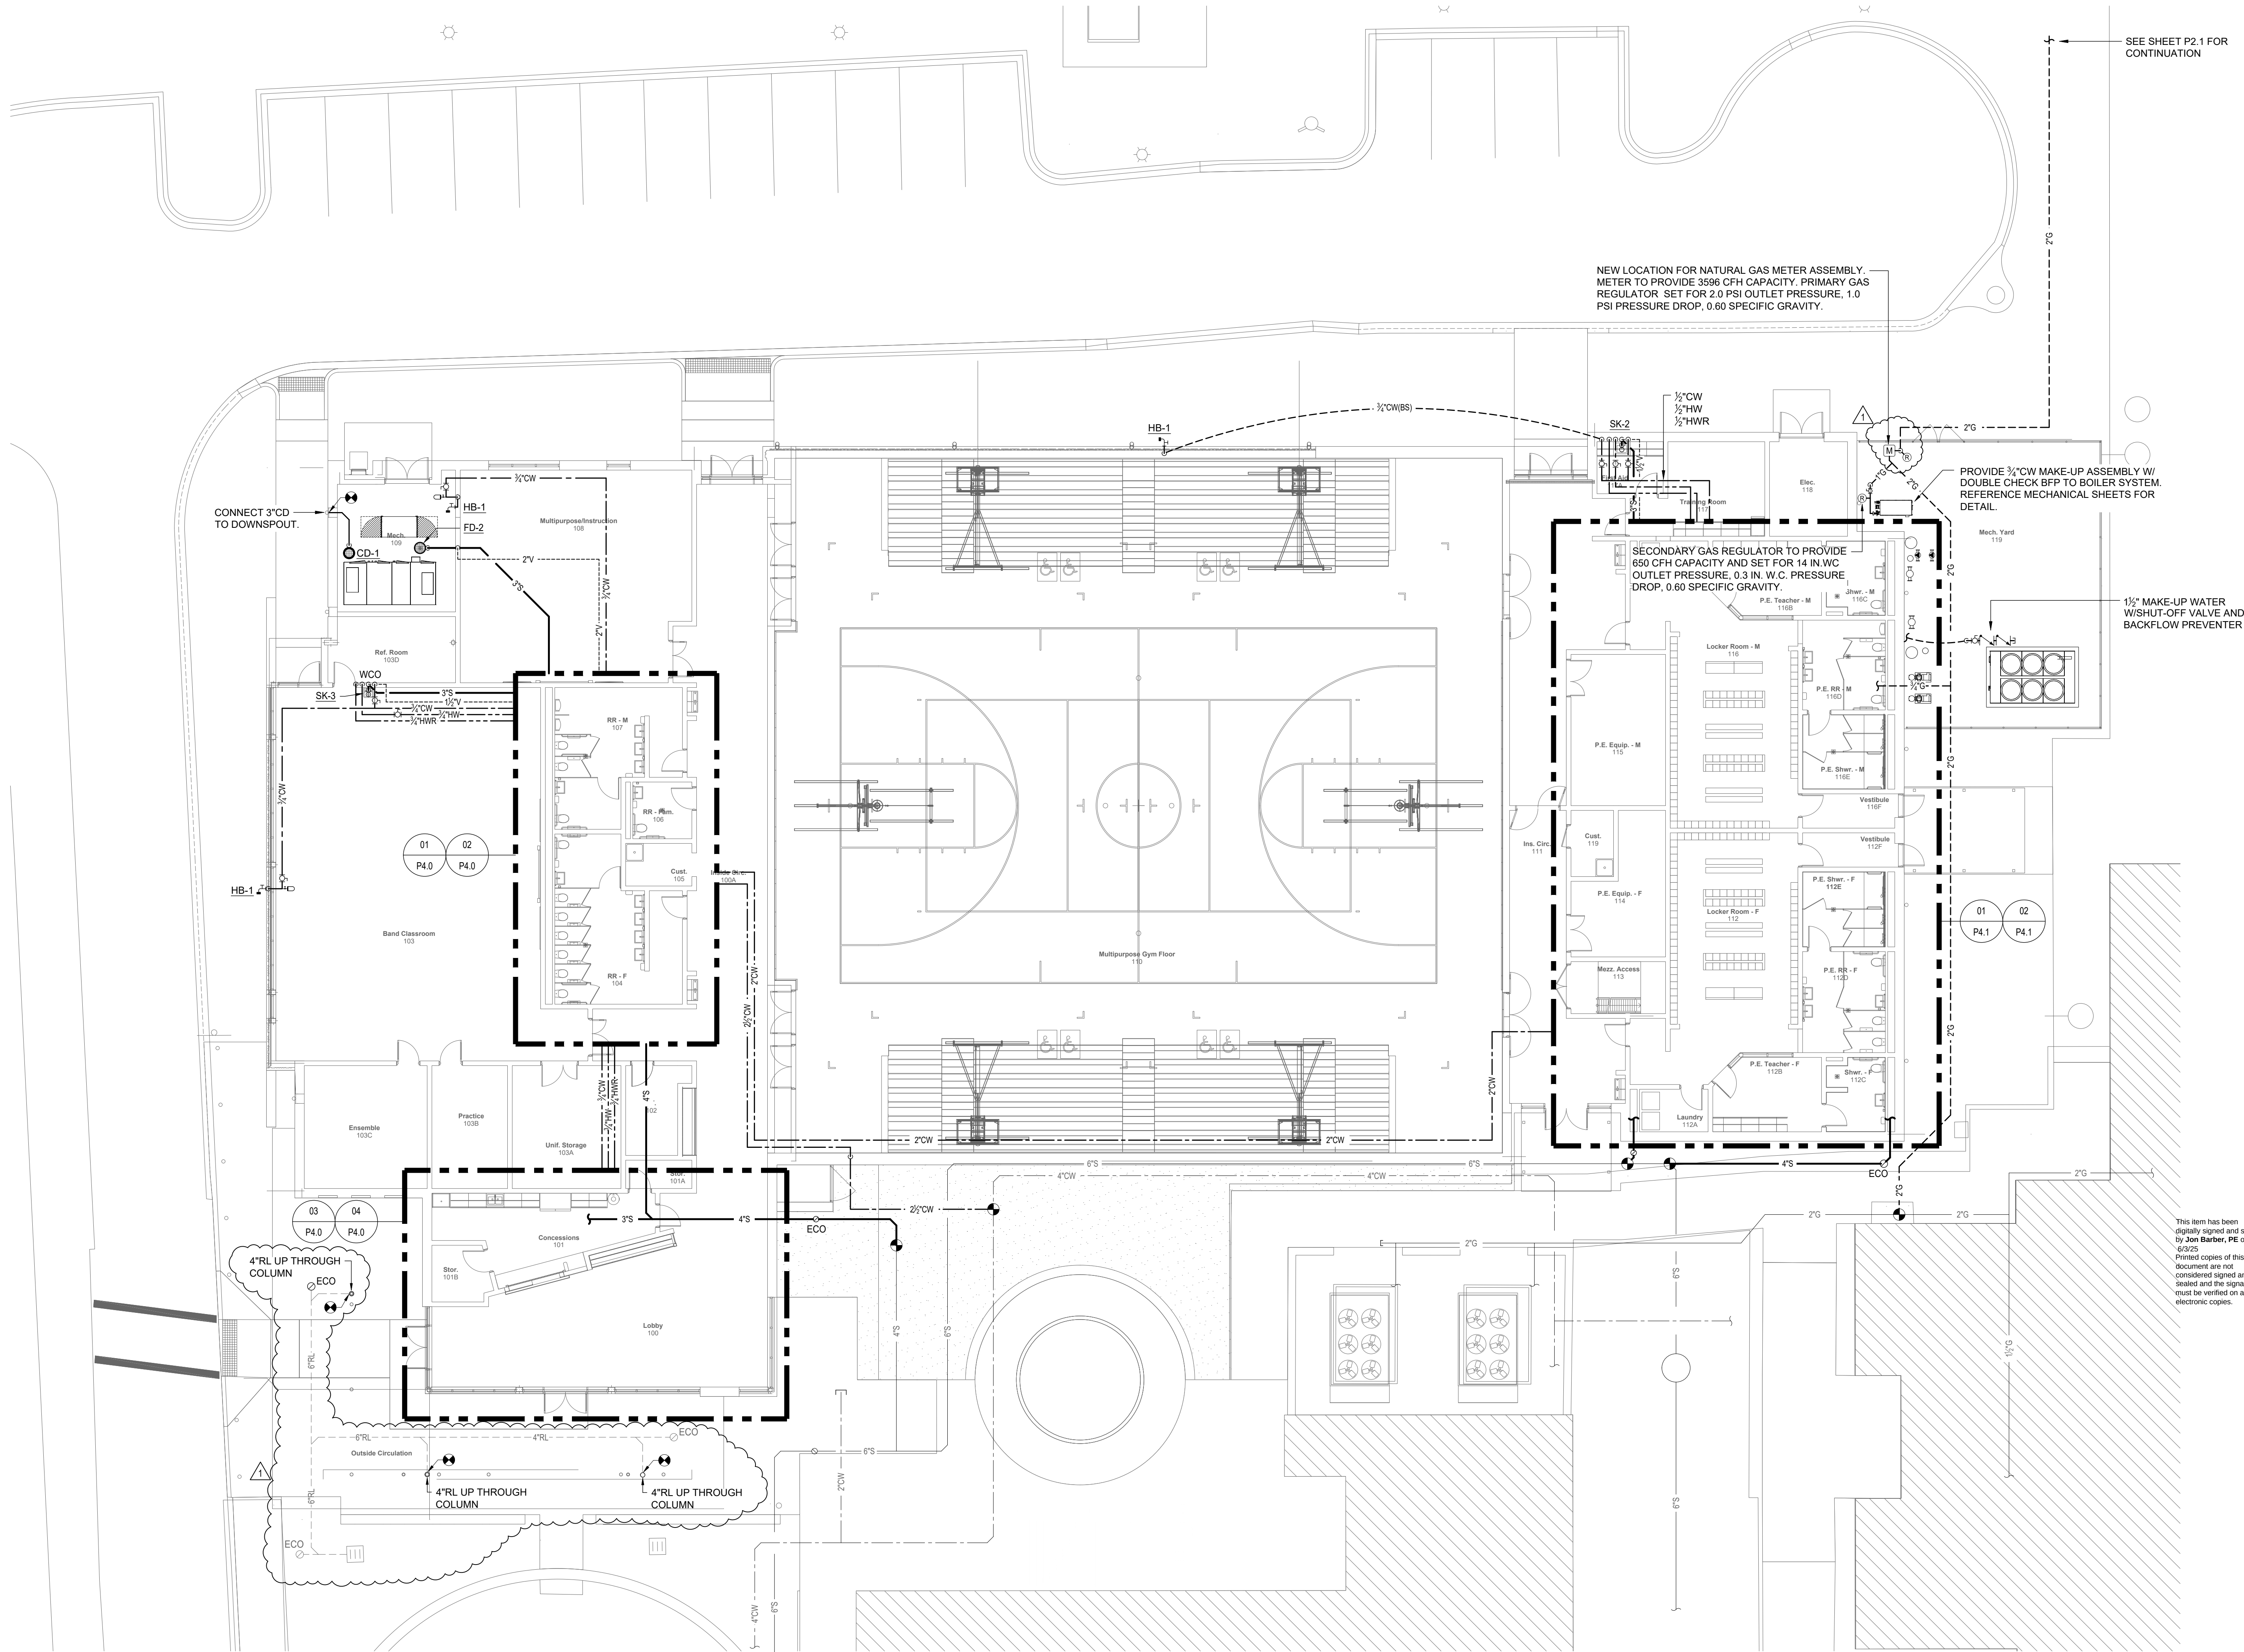


NEW LOCATION FOR NATURAL GAS METER ASSEMBLY.
METER TO PROVIDE 3596 CFH CAPACITY. PRIMARY GAS
REGULATOR SET FOR 2.0 PSI OUTLET PRESSURE, 1.0
PSI PRESSURE DROP, 0.60 SPECIFIC GRAVITY.

SECONDARY GAS REGULATOR TO PROVIDE
650 CFH CAPACITY AND SET FOR 14 IN. WC
OUTLET PRESSURE, 0.3 IN. W.C. PRESSURE
DROP, 0.60 SPECIFIC GRAVITY.

PROVIDE 3/4\"/>

1 1/2\"/>

 This item has been
digitally signed and sealed
by Jon Barber, PE on
6/9/25
Printed copies of this
document are not
considered signed and
sealed and the signature
must be verified on any
electronic copies.

 **1** Gym Plumbing Plan
3/32" = 1'-0"

PHASE:	DRAWN:	REVIEWED:	DATE:	ID:	REVISION:	DRAWN/REVIEWED DATE:
CONCEPT SCHEM. DESIGN	TEP	JB	12/20/2024	1	Addendum #1	6/3/2025
DESIGN DEVELOPMENT	TEP	JB				
EARLY DEMOLITION PACKAGE	TEP	JB				
80% CONSTRUCTION DOCS	TEP	JB				
PERMIT DOCS	TEP	JB				
100% CONSTRUCTION DOCS	TEP	JB				

THESE DRAWINGS AND PERMITTINGS ARE INSTRUMENTS OF SERVICE. THE DRAWINGS AND ASSOCIATED COPIES THEREOF, INCLUDING ELECTRONIC MEDIA AND CAD FILES, ARE THE PROPERTY OF ARCHITECTS LEWIS + WHITLOCK P.A. THEIR USE, REPRESENTATION OR REPRODUCTION FOR ANY PURPOSE EXCEPT BY WRITTEN AGREEMENT WITH THE ARCHITECT IS PROHIBITED. THIS COPYRIGHT NOTICE SHALL BE TRUE AS IF DIRECTLY PLACED ON EACH DRAWING EXHIBIT OR REVISIONS ON THIS DOCUMENT AND SHALL NOT BE REPRODUCED FROM THESE DOCUMENTS.

Client:
Leon County Schools
3420 W. Tharpe St., Suite 100
Tallahassee, FL 32303

Job Title:
Griffin Middle School - Phase 2
800 Alabama St. Tallahassee, FL 32304

Consultant:
MCGINNIS + FLEMING ENGINEERING
JON BARBER, PE
501 W. PARK AVE., SUITE 200, TALLAHASSEE, FL 32301
WWW.MCE.COM 904.681.1848

Seal:
JON M. BARBER
LICENSE
No. 55427
STATE OF FLORIDA
PROFESSIONAL ENGINEER


Project #:
23483

Phase:
100% Construction Documents

ALW
Architects Lewis + Whitlock
206 West Virginia St.
Tallahassee, Florida 32301
850.942.1718
www.think3d.net

Description:
**New Gymnasium
Plumbing
First Floor Plan**

Sheet No.:
P3.0

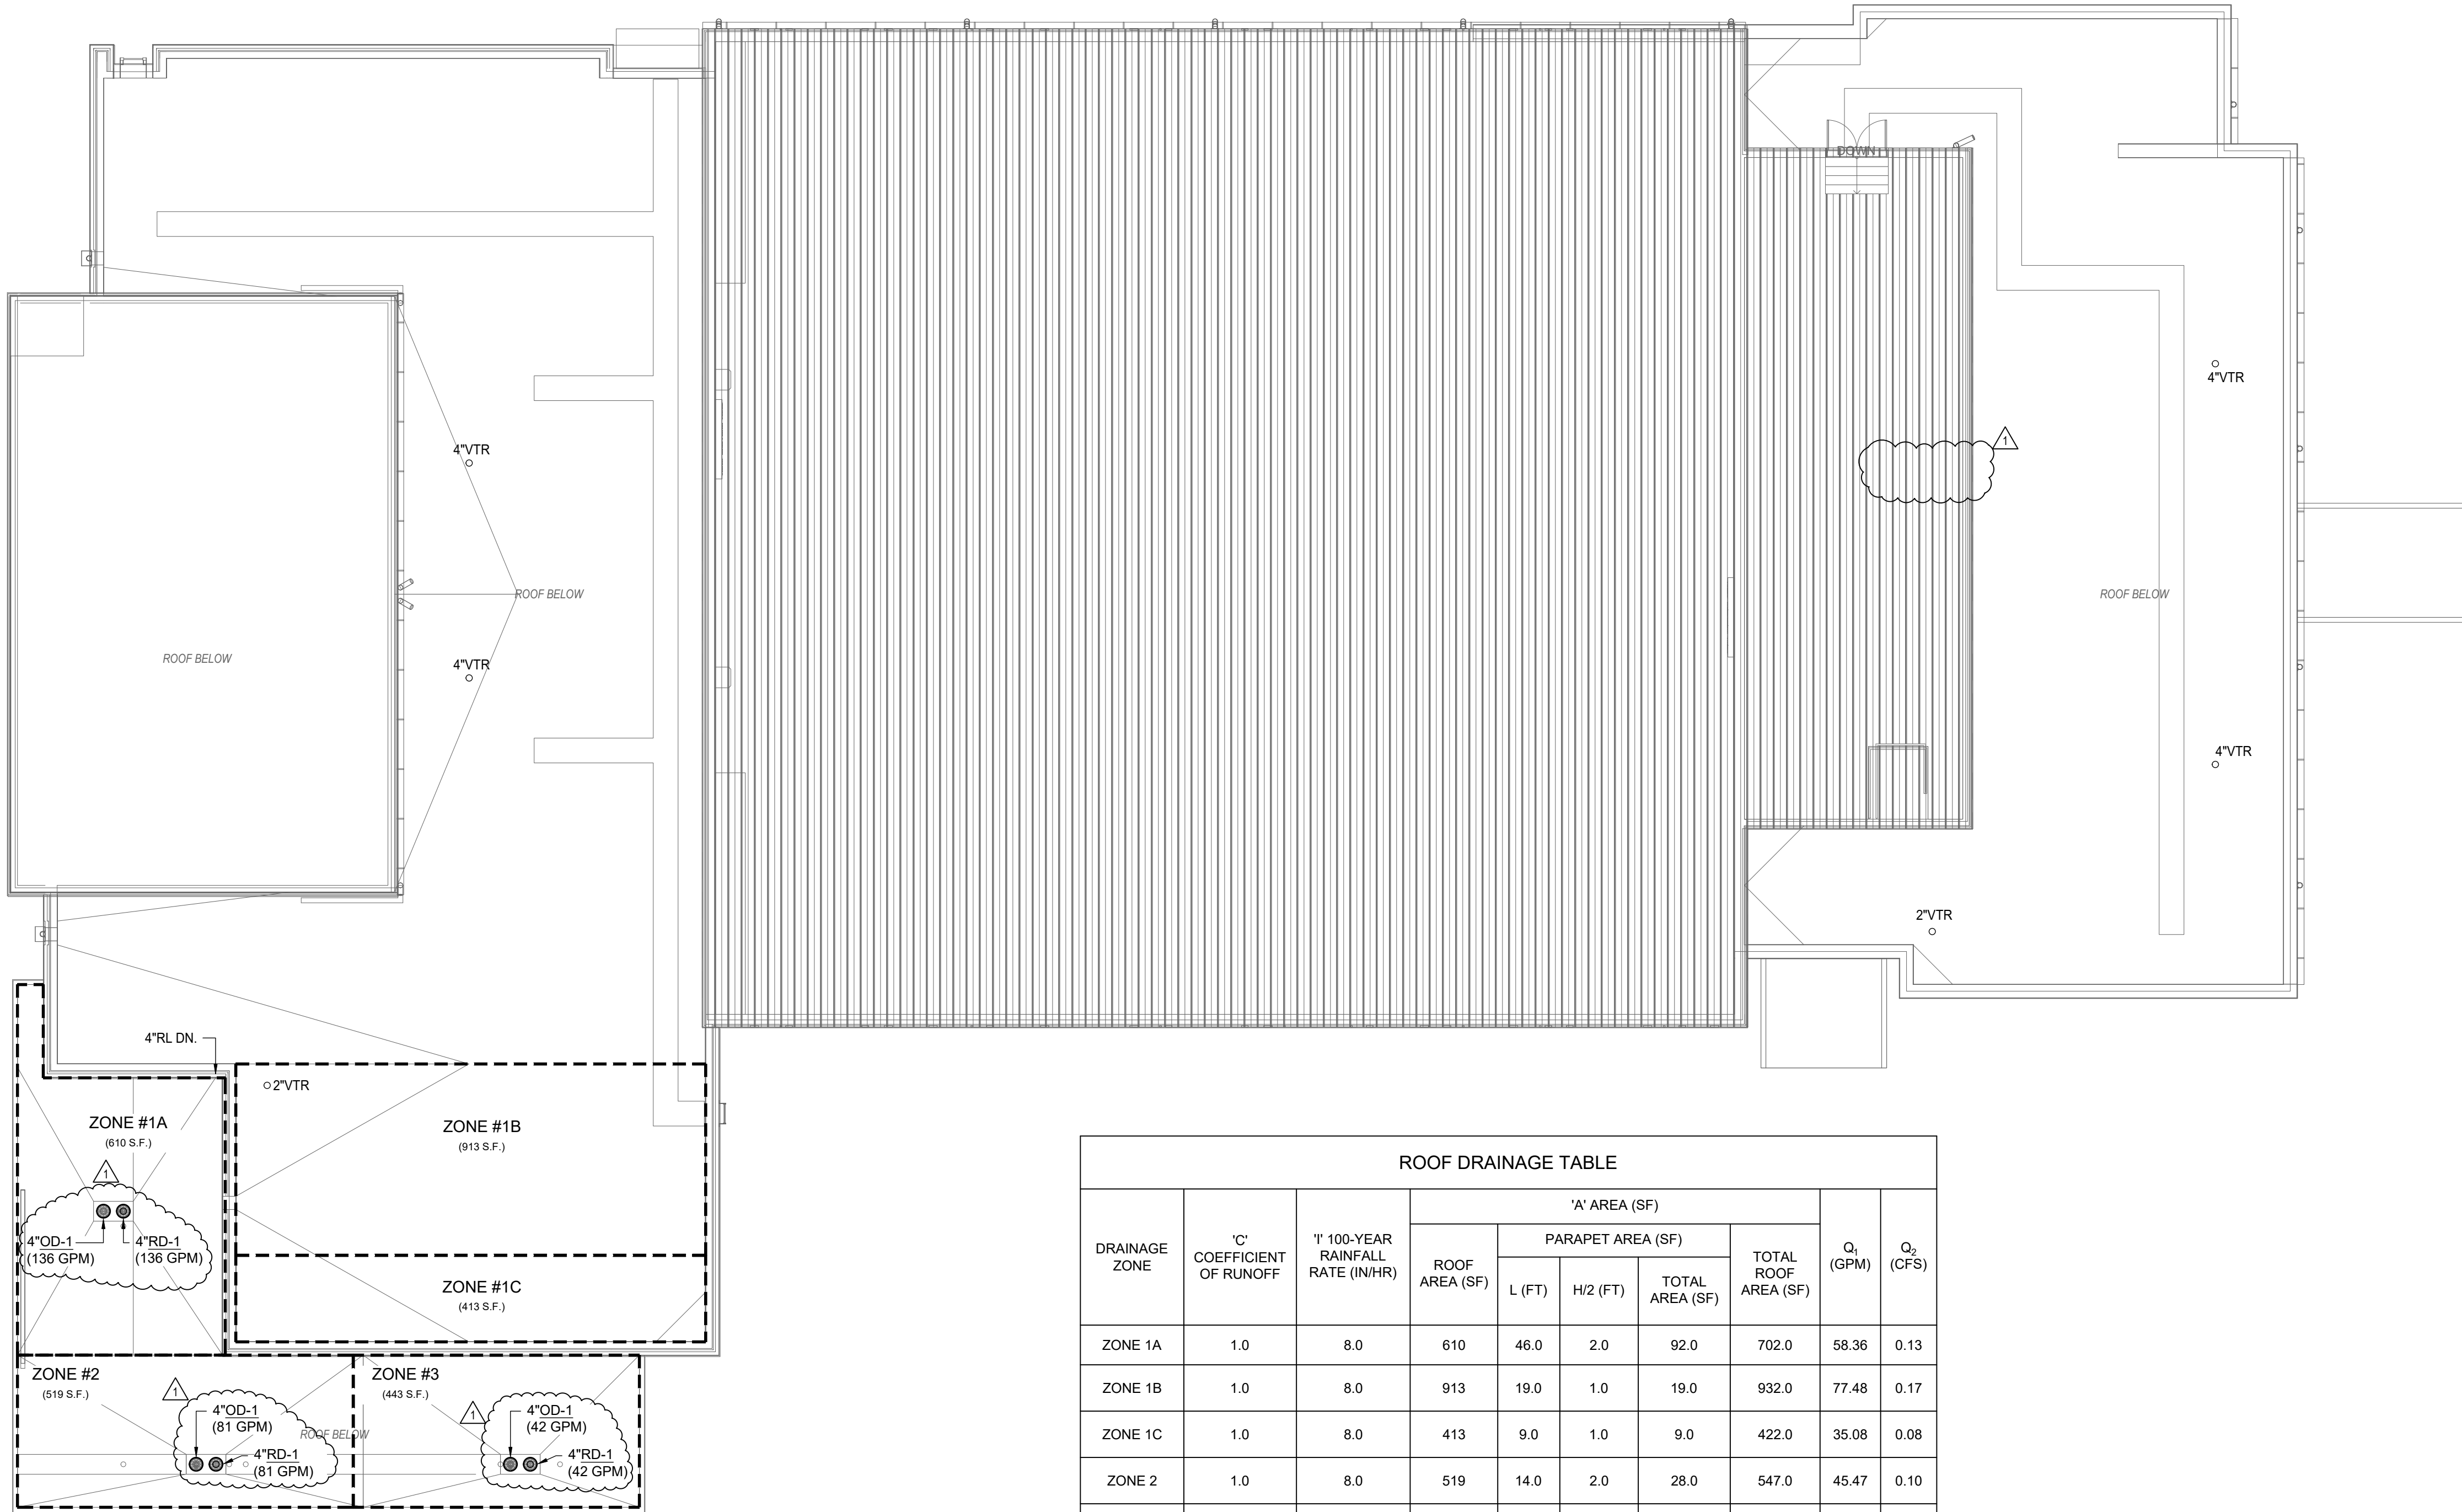

NOTE:
REFERENCE ARCHITECTURAL SECTION
DETAIL AT DOWNSPOUT COLUMN / CANOPY
ROOF DRAIN, 3/A3.3.

ROOF DRAINAGE TABLE									
DRAINAGE ZONE	'C' COEFFICIENT OF RUNOFF	'I' 100-YEAR RAINFALL RATE (IN/HR)	'A' AREA (SF)					Q ₁ (GPM)	Q ₂ (CFS)
			ROOF AREA (SF)	PARAPET AREA (SF)			TOTAL ROOF AREA (SF)		
				L (FT)	H/2 (FT)	TOTAL AREA (SF)			
ZONE 1A	1.0	8.0	610	46.0	2.0	92.0	702.0	58.36	0.13
ZONE 1B	1.0	8.0	913	19.0	1.0	19.0	932.0	77.48	0.17
ZONE 1C	1.0	8.0	413	9.0	1.0	9.0	422.0	35.08	0.08
ZONE 2	1.0	8.0	519	14.0	2.0	28.0	547.0	45.47	0.10
ZONE 3	1.0	8.0	443	29.0	2.0	58.0	501.0	41.65	0.09
TOTAL ALL ZONES								258.05	0.57
RATIONAL CALCULATION METHOD									
Q = (C x I x A)/96.23 where:									
Q ₁ = Storm Water Runoff (in gallons per minute)									
Q ₂ = Storm Water Runoff (in cubic feet per second)									
C = Coefficient of Runoff									
I = Rainfall Intensity (in inches per hour)									
A = Area of Drainage Zone (in square feet)									

3/32" = 1'-0" Gym Roof Plumbing Plan

PHASE:	DRAWN:	REVIEWED:	DATE:	ID:	REVISION:	DRAWN/REVIEWED/DATE:
CONCEPT SCHEM. DESIGN	TEP	JB	12/20/2024	1	Addendum #1	TEP JB 6/3/2025
DESIGN DEVELOPMENT						
EARLY DEMOLITION PACKAGE						
80% CONSTRUCTION DOCS	TEP	JB	03/21/2025			
PERMIT DOCS						
100% CONSTRUCTION DOCS	TEP	JB	06/09/2025			

Client: Leon County Schools
3420 W. Tharpe St., Suite 100
Tallahassee, FL 32303

Job Title: Griffin Middle School - Phase 2
800 Alabama St. Tallahassee, FL 32304

Consultant: MCGINNIS + FLEMING ENGINEERING
JON BARBER, PE
100 EAST PARK AVE., 2ND FLOOR, TALLAHASSEE, FL 32301
WWW.MFC.COM 850.681.1848

Seal: JON M. BARBER, LICENSE No. 55427, STATE OF FLORIDA, PROFESSIONAL ENGINEER


Project #: 23483
Phase: 100% Construction Documents

This item has been digitally signed and sealed by Jon Barber, PE on 6/3/25. Printed copies of this document are not considered signed and sealed and the signature must be verified on any electronic copies.


ALW Architects Lewis + Whitlock
206 West Virginia St.
Tallahassee, Florida 32301
850.942.1718
www.think3d.net

Description: New Gymnasium
Plumbing
Roof Plan


Sheet No.: P3.1

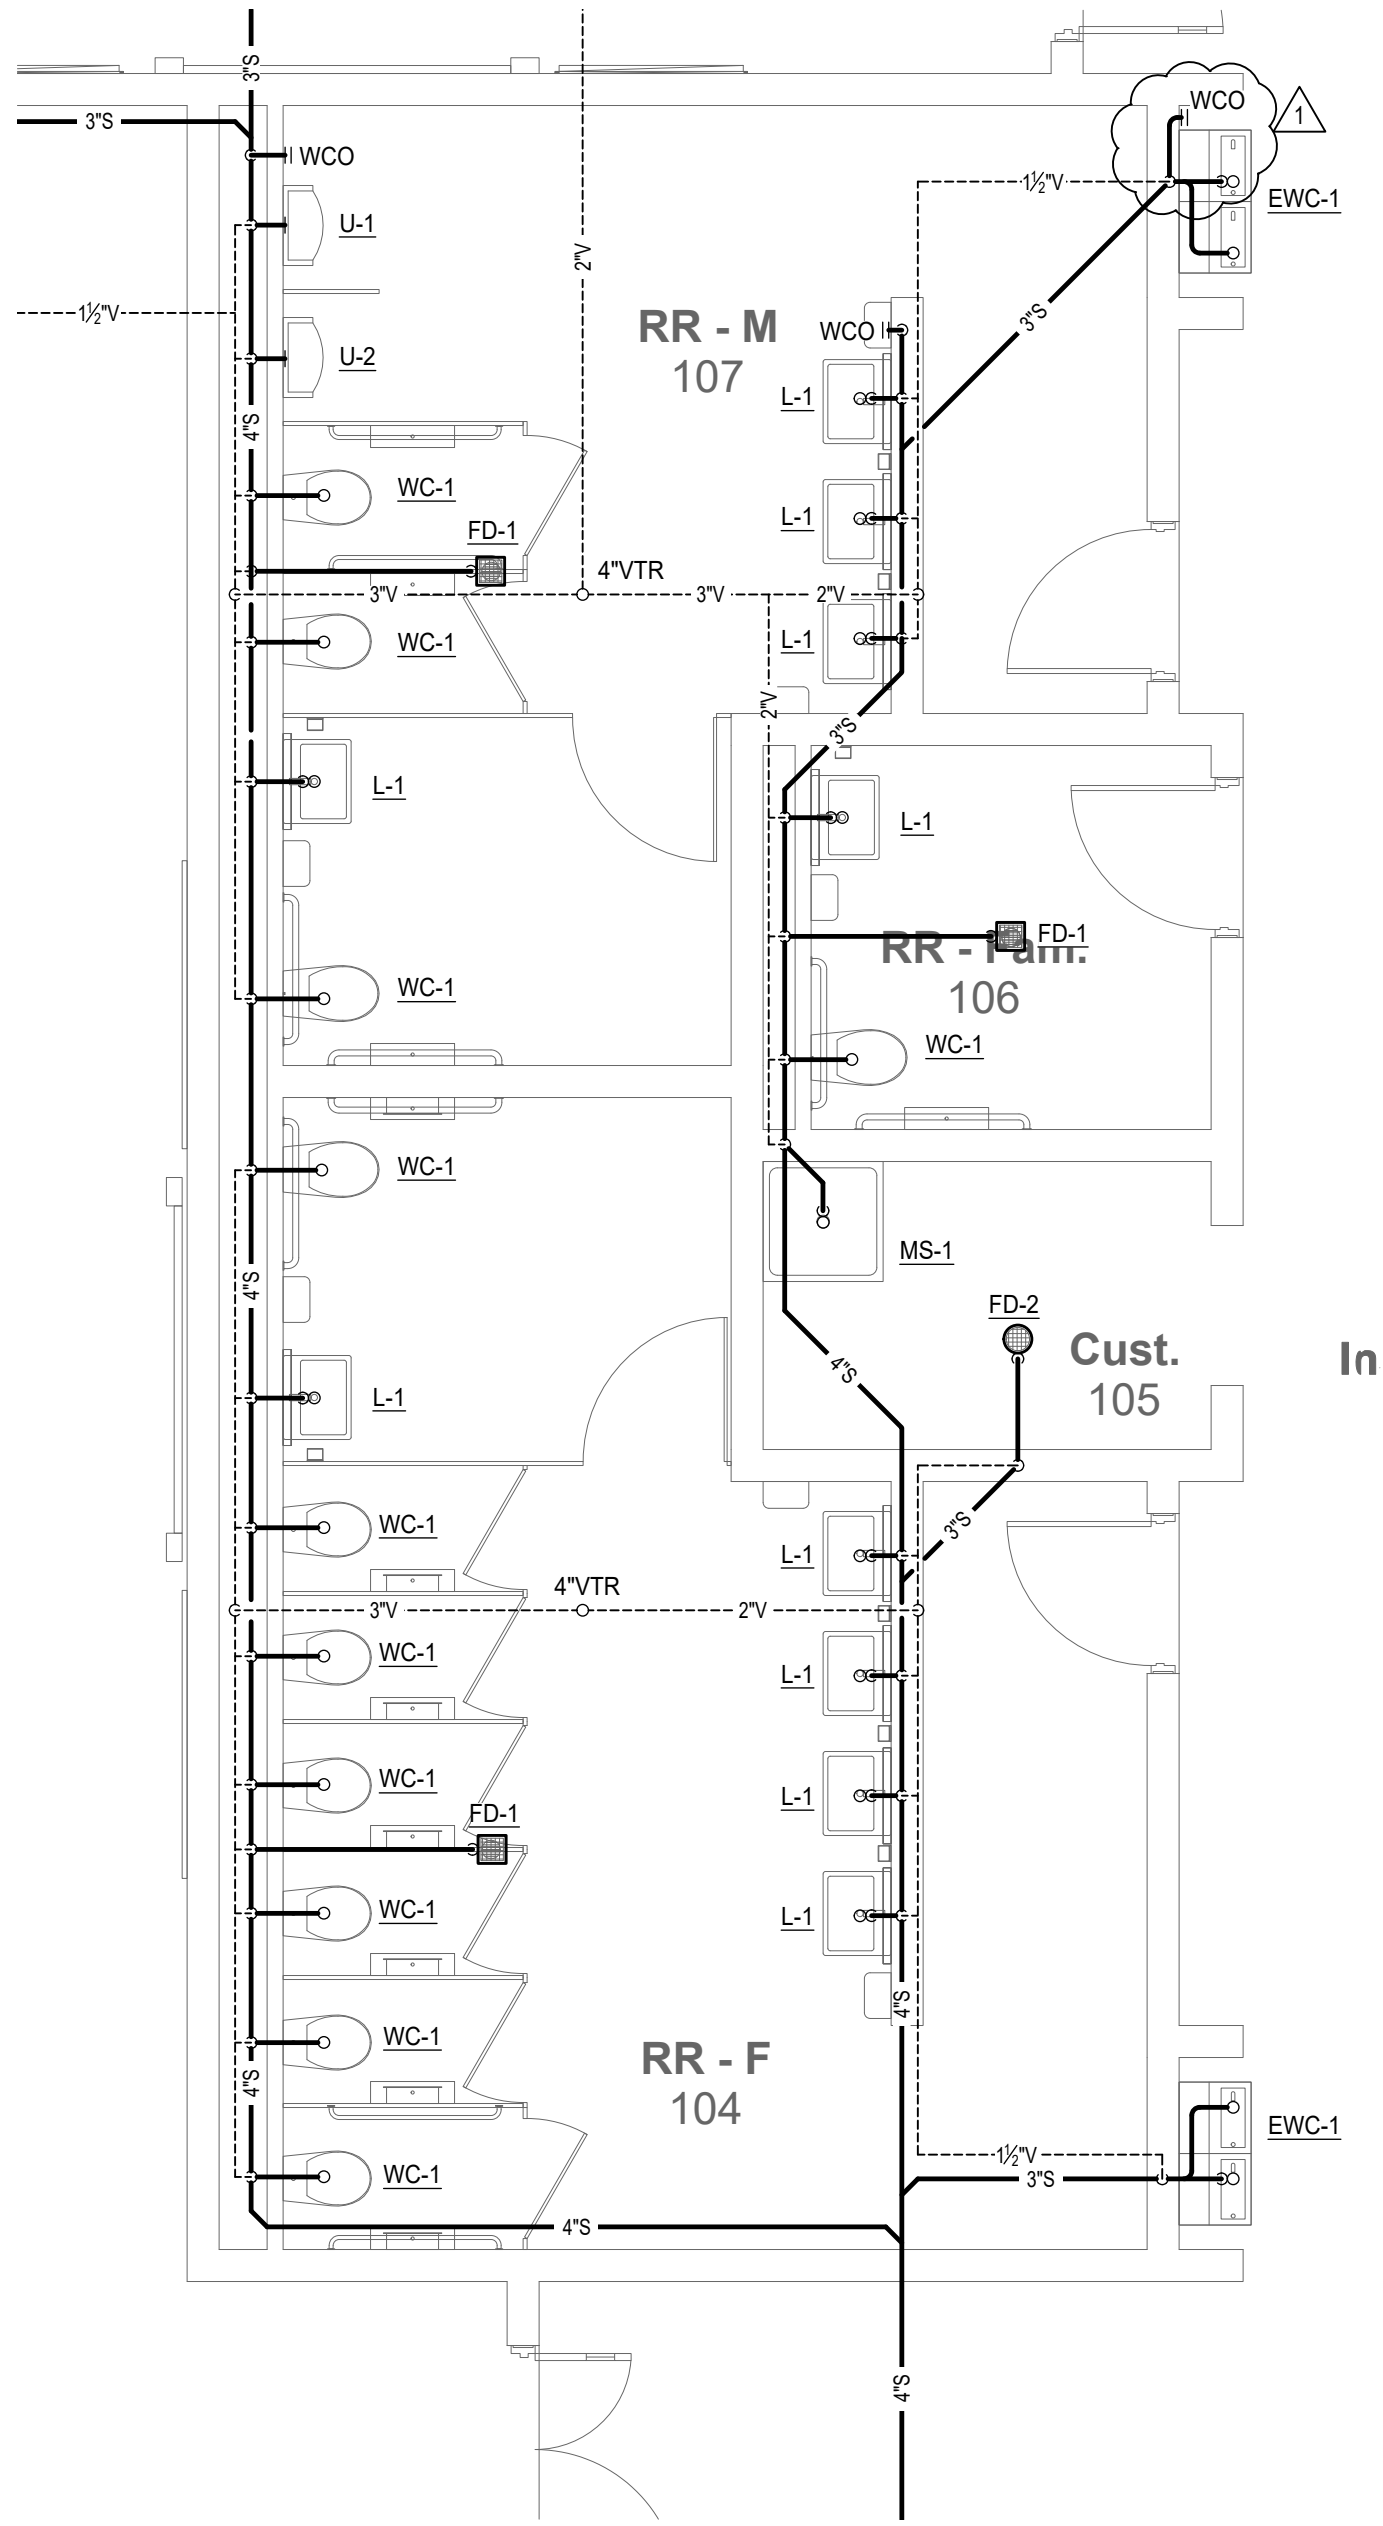


1 Plumbing Enlarged Plan - Sanitary
1/4" = 1'-0"

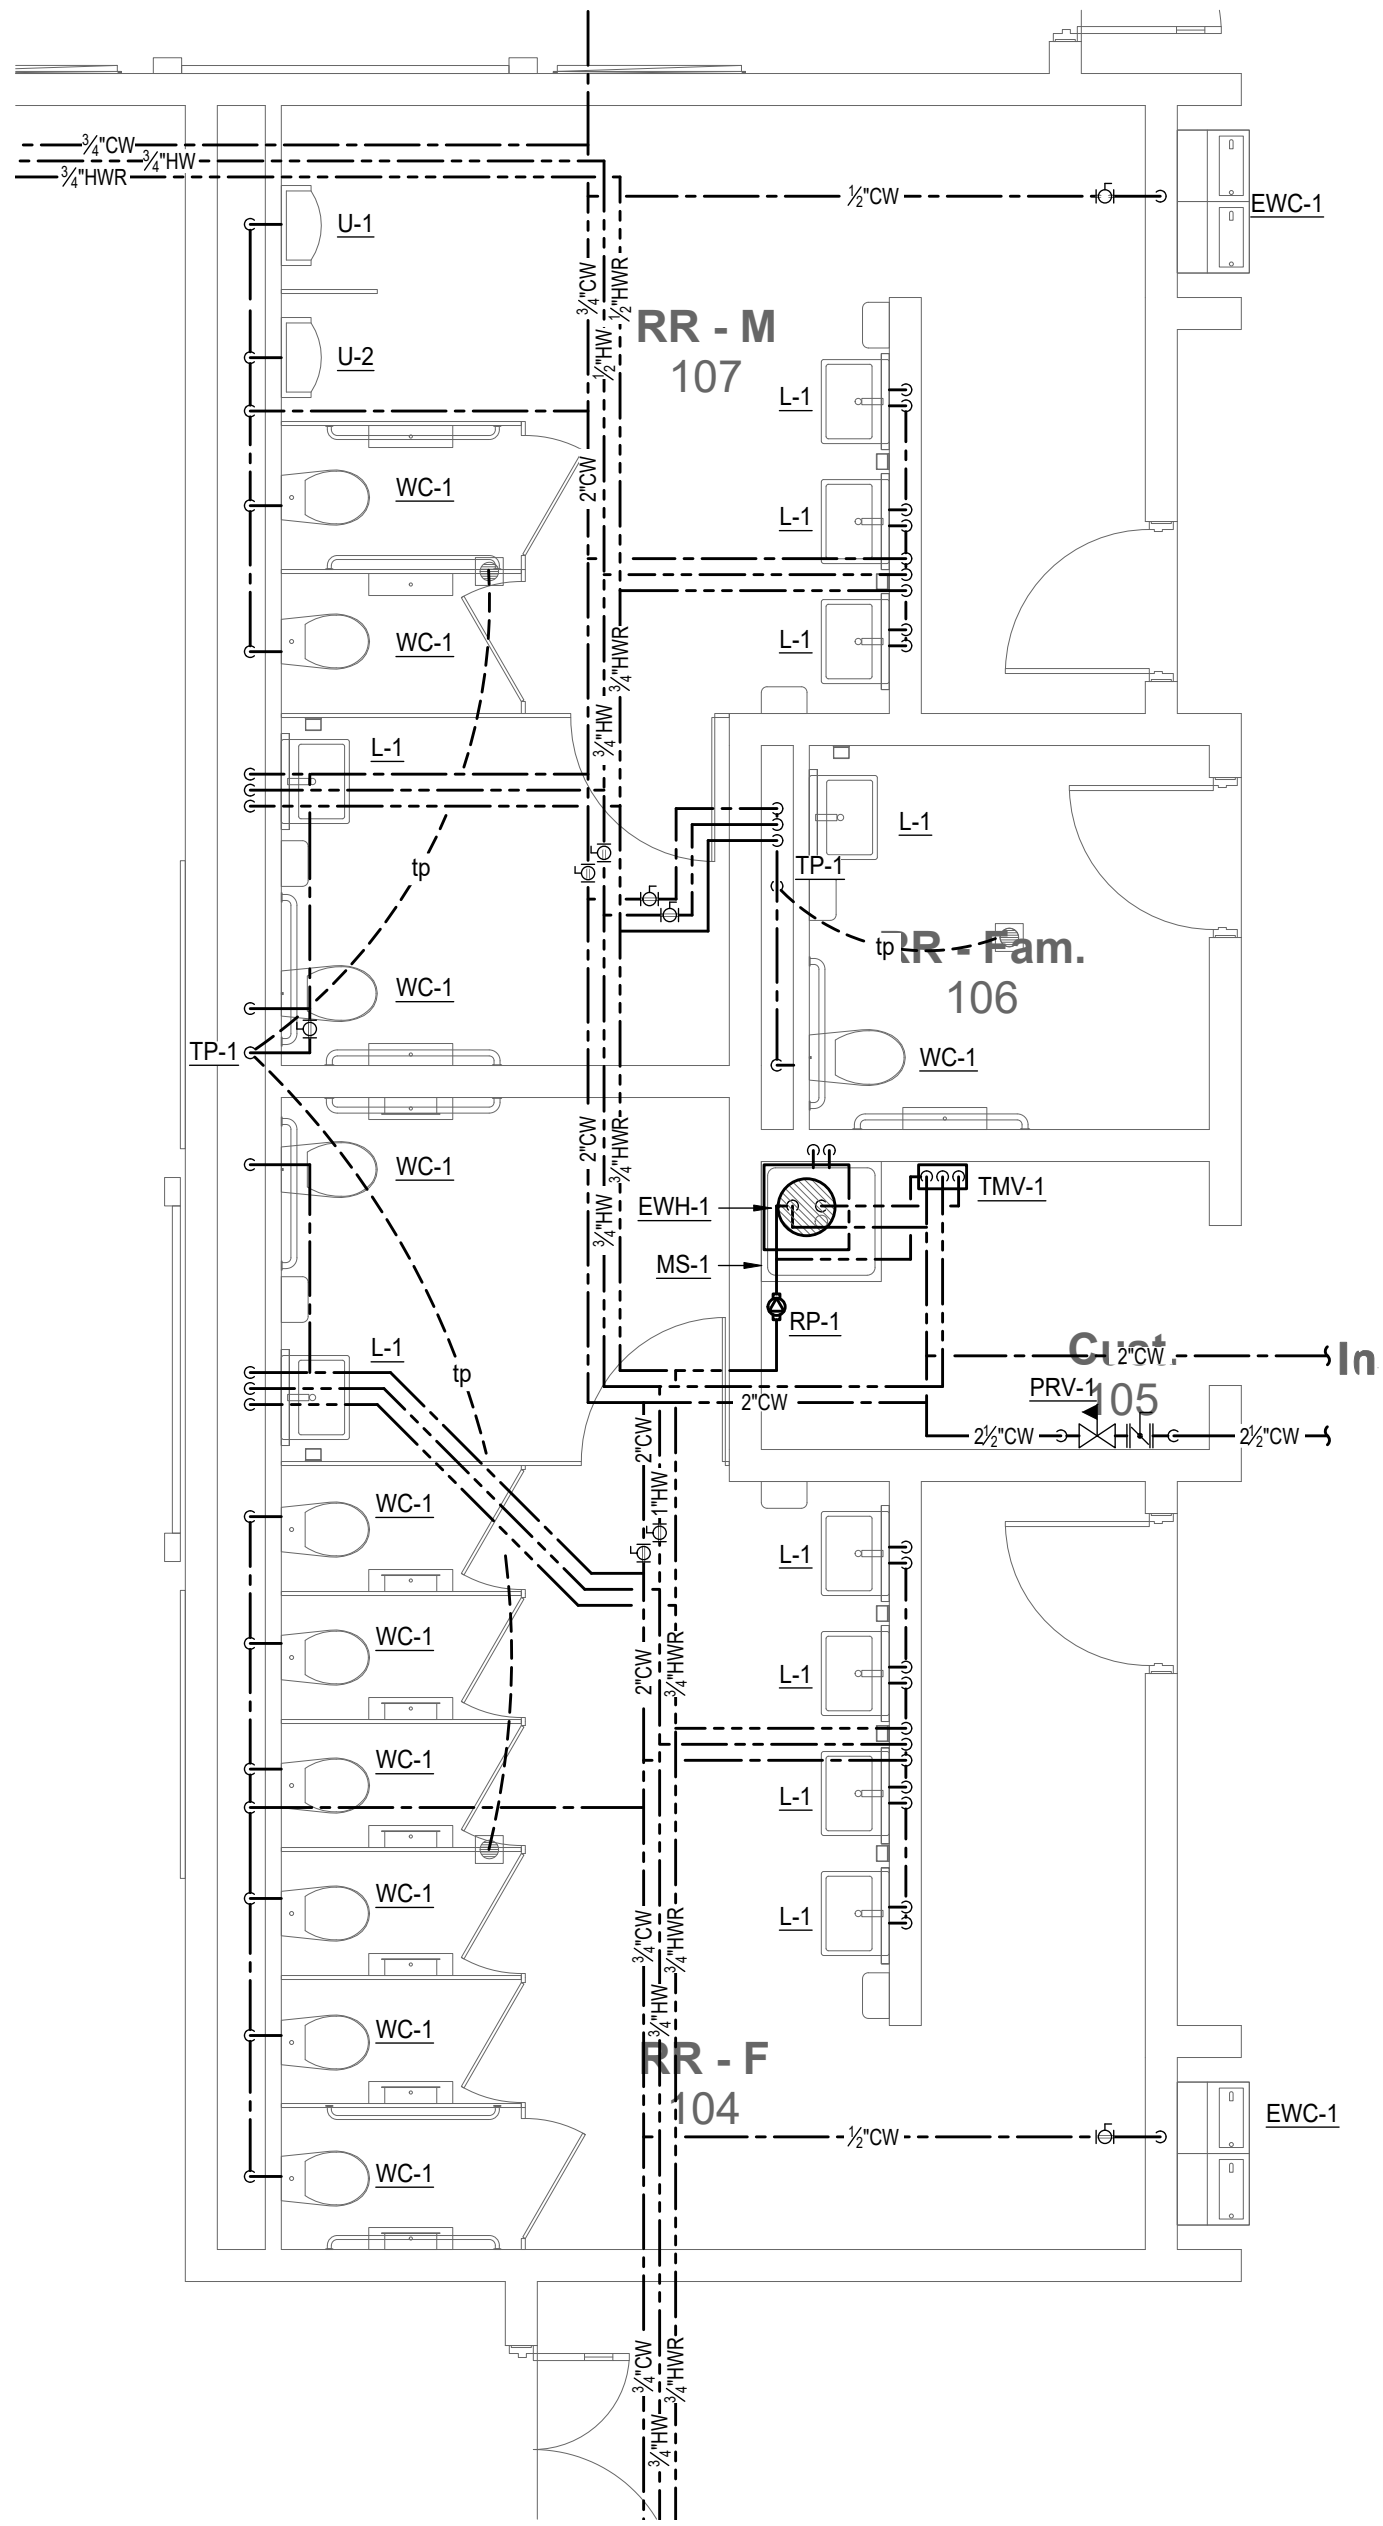

2 Plumbing Enlarged Plan - Domestic Water
1/4" = 1'-0"

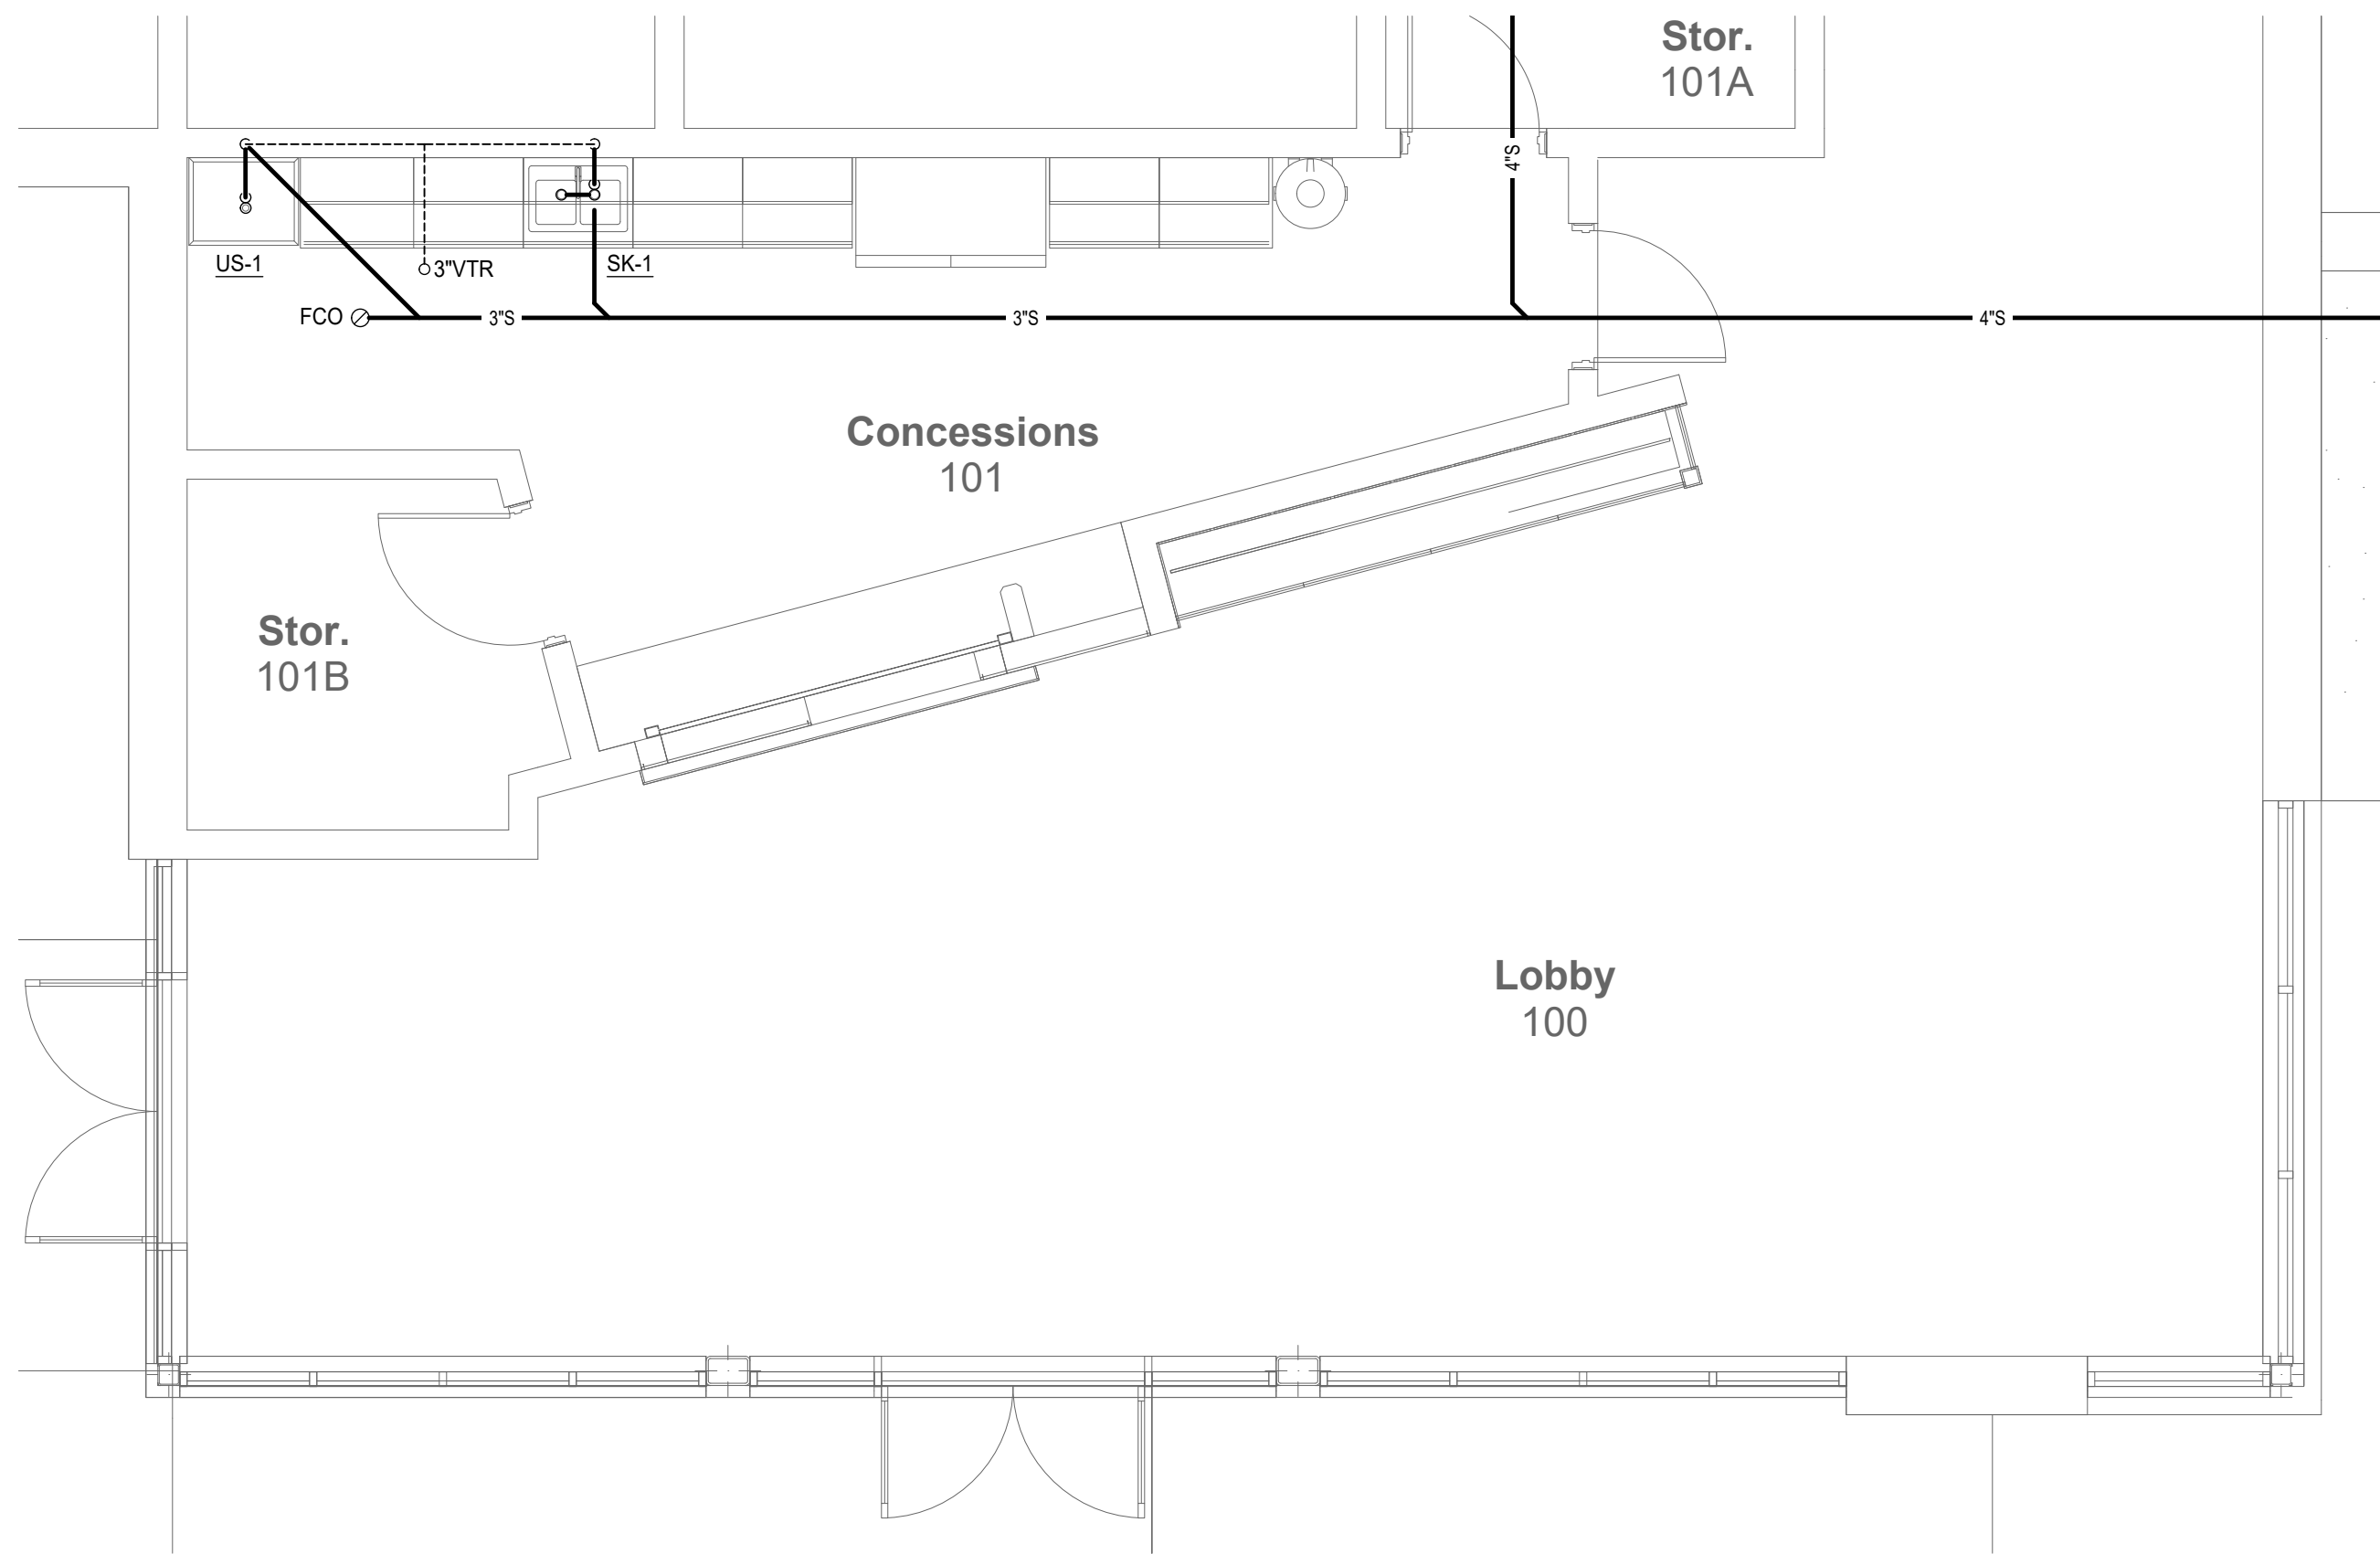

3 Plumbing Enlarged Plan - Sanitary
1/4" = 1'-0"

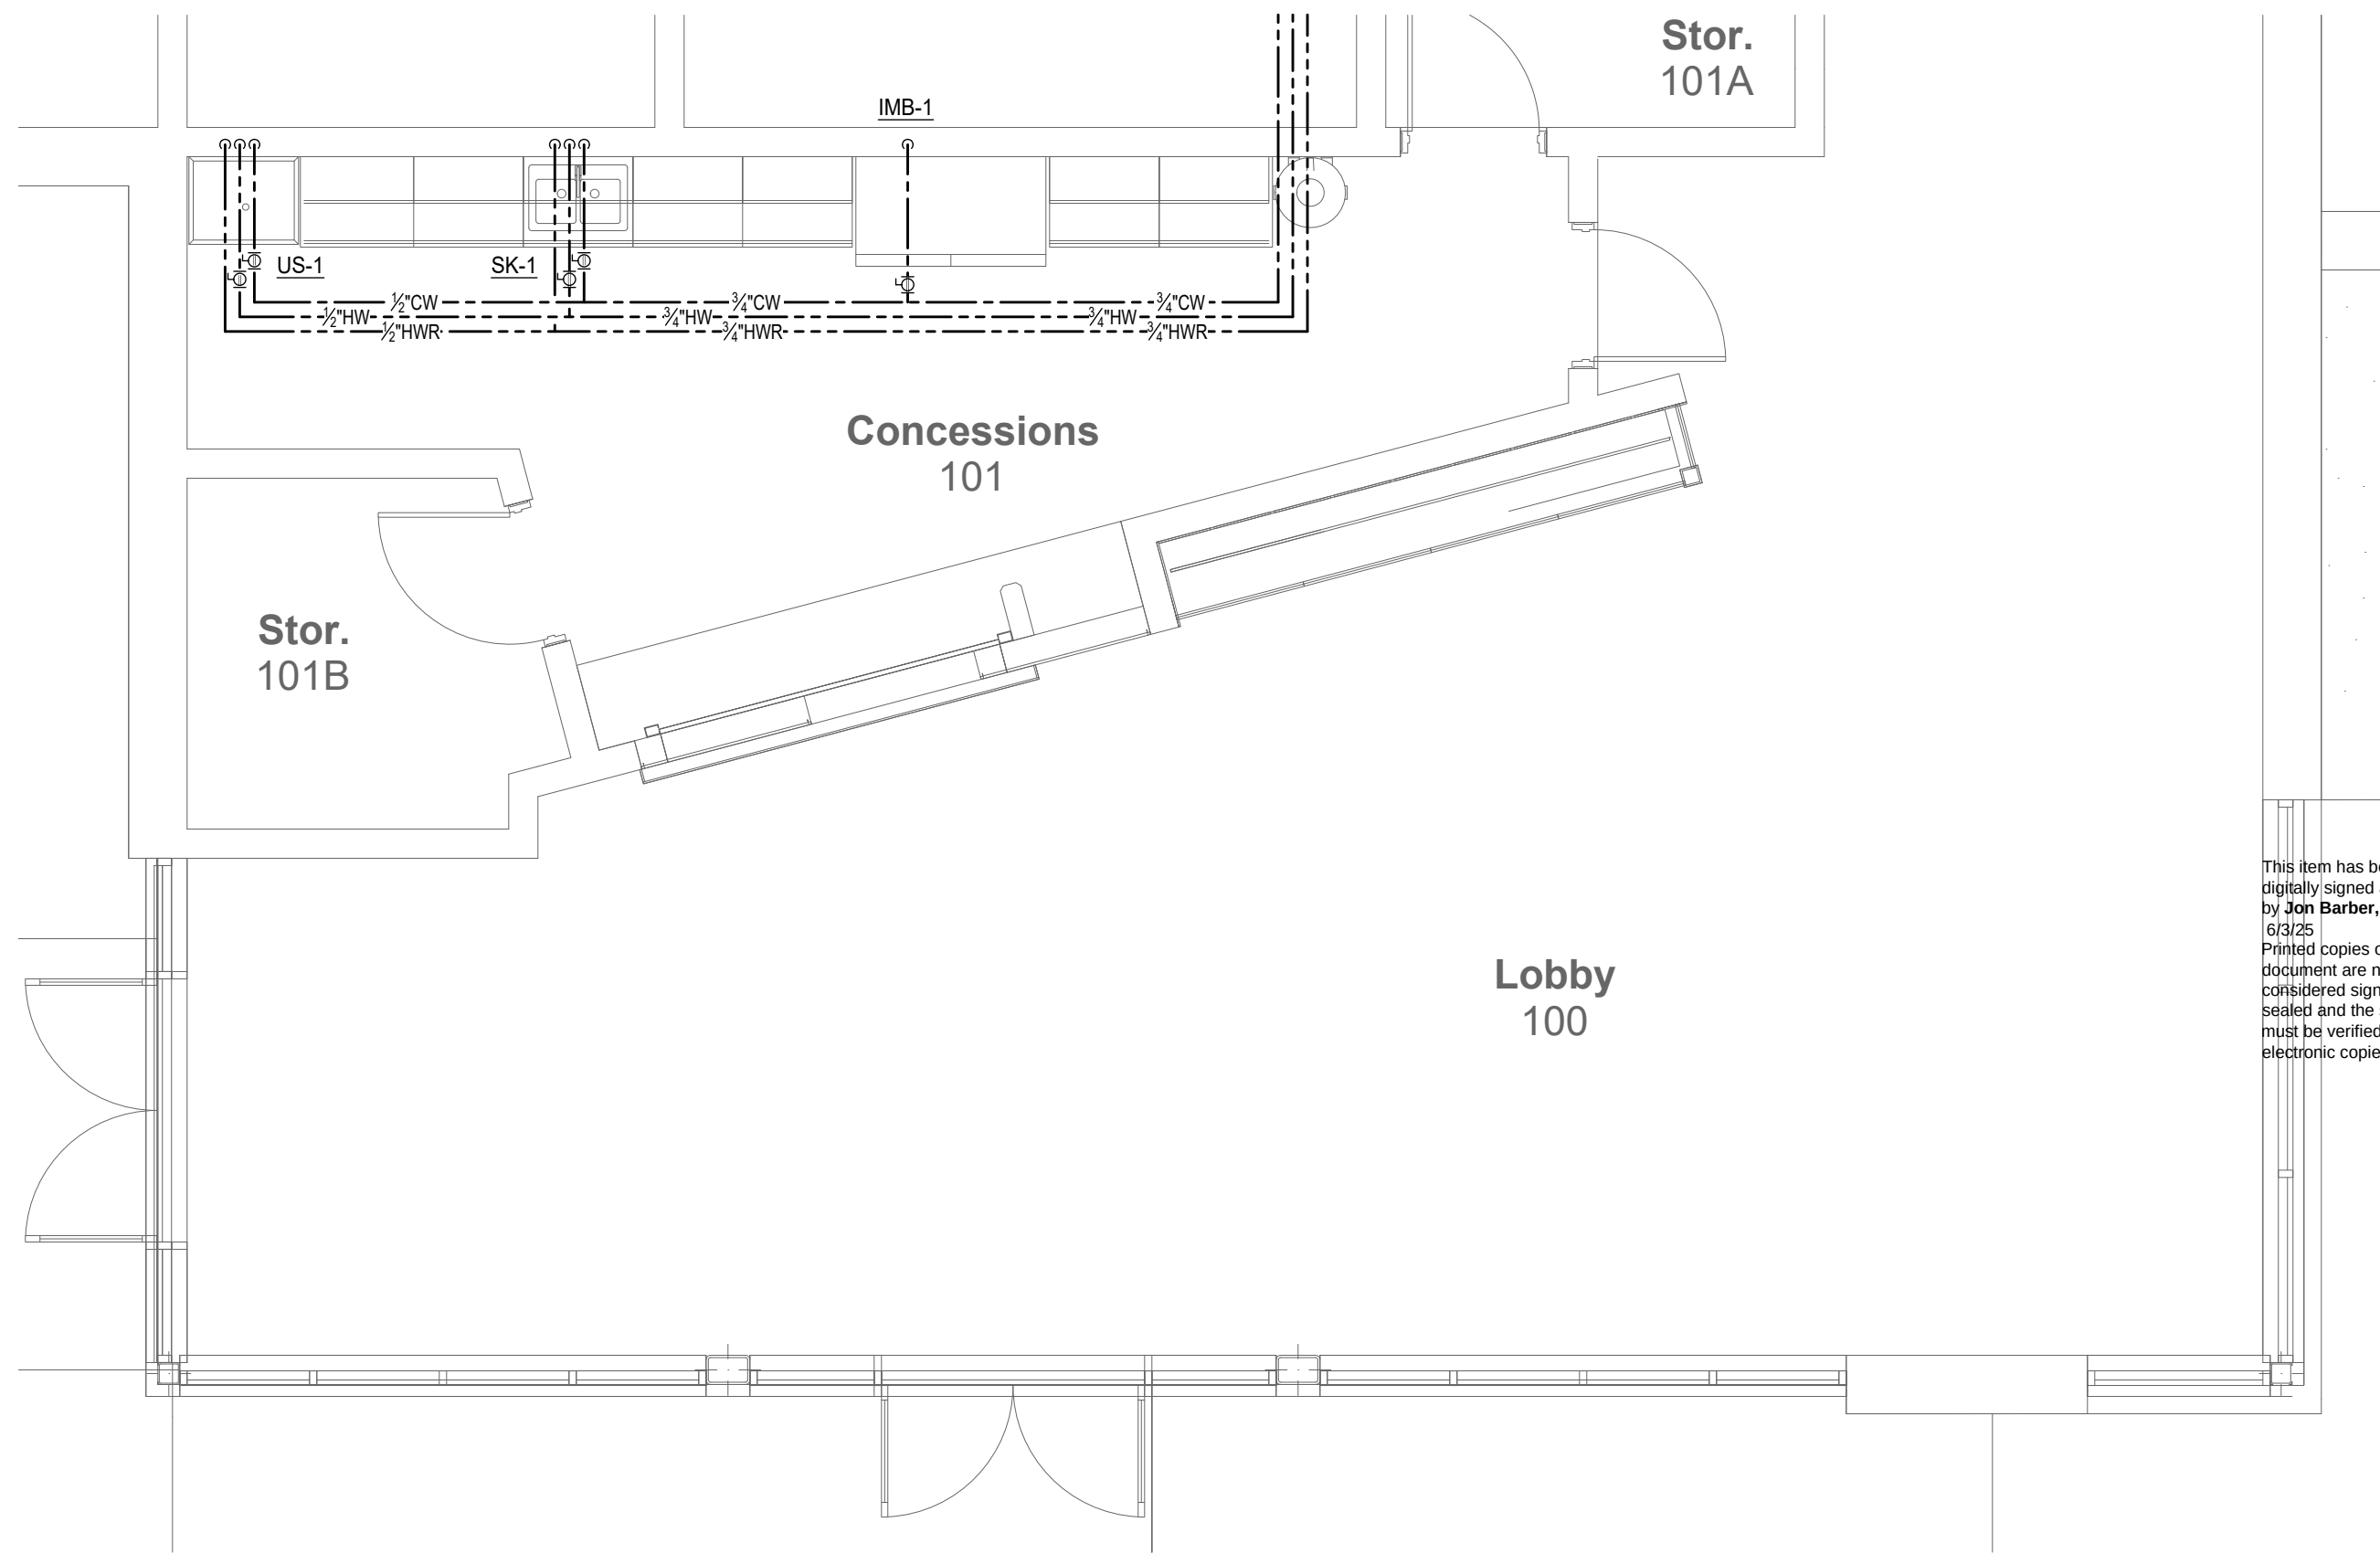

4 Plumbing Enlarged Plan - Domestic Water
1/4" = 1'-0"

This item has been
digitally signed and sealed
by Jon Barber, PE on
6/3/25. Printed copies of this
document are not
considered signed and
sealed and the signature
must be verified on any
electronic copies.

PHASE:	DRAWN:	REVIEWED:	DATE:	ID:	REVISION:	DRAWN/REVIEWED DATE:
CONCEPT SCHEM. DESIGN	TEP	JB	12/20/2024	1	Addendum #1	6/3/2025
DESIGN DEVELOPMENT	TEP	JB				
EARLY DEMOLITION PACKAGE	TEP	JB	03/21/2025			
80% CONSTRUCTION DOCS	TEP	JB				
PERMIT DOCS	TEP	JB				
100% CONSTRUCTION DOCS	TEP	JB				

THESE DRAWINGS AND PERMITTING ARE INSTRUMENTS OF SERVICE. THE DRAWINGS AND ASSOCIATED COPIES THEREOF, INCLUDING ELECTRONIC MEDIA AND CAD FILES, ARE THE PROPERTY OF ARCHITECTS LEWIS + WHITLOCK P.A. THEIR USE, REPRESENTATION OR REPRODUCTION FOR ANY PURPOSE EXCEPT BY WRITTEN AGREEMENT WITH THE ARCHITECT IS PROHIBITED. THIS COPYRIGHT NOTICE SHALL BE TRUE AS IF DIRECTLY PLACED ON EACH DRAWING EXHIBIT OR REVISIONS ON THIS DOCUMENT AND SHALL NOT BE REPRODUCED FROM THESE DOCUMENTS.

Client:
Leon County Schools
3420 W. Tharpe St., Suite 100
Tallahassee, FL 32303

Job Title:
Griffin Middle School - Phase 2
800 Alabama St. Tallahassee, FL 32304

Consultant:
MCGINNIS + FLEMING ENGINEERING
JON MCGINNIS, PE, FACET, LEED AP, P.E. 10000
800 EAST PARK AVE., SUITE 100, TALLAHASSEE, FL 32301
WWW.MFCOM.COM 904.681.1848

Seal:
JON M. BARBER
LICENSE
No. 55427
STATE OF FLORIDA
PROFESSIONAL ENGINEER

Project #:
23483

Phase:
100% Construction Documents

ALW
Architects Lewis + Whitlock
206 West Virginia St.
Tallahassee, Florida 32301
850.942.1718
www.think3d.net

Description:
Plumbing Enlarged Plans

Sheet No.:
P4.0



A circular professional engineer seal for Jon M. Barber. The outer ring contains the text "JON M. BARBER" at the top and "PROFESSIONAL ENGINEER" at the bottom, separated by two stars. Inside this ring, the word "LICENSE" is at the top, "No. 55427" is in the center, and "STATE OF FLORIDA" is at the bottom, also separated by two stars. The seal is stamped over a vertical line labeled "Seal" on the left.

P4.1


Phase:

consultant:

1

THESE DRAWINGS AND RENDERINGS ARE INSTRUMENTS OF SERVICE. THE DRAWINGS AND RENDERINGS ARE INSTRUMENTS OF SERVICE. INCLUDING ELECTRONIC MEDIA AND CAD FILES ARE THE PROPERTY OF ARCHITECTS LEWIS + WHITLOCK P.A.A. THEIR USE, REPRESENTATION OR REPRODUCTION FOR ANY PURPOSES EXCEPT BY WRITTEN AGREEMENT WITH THE ARCHITECT IS PROHIBITED. THIS COPYRIGHT NOTIFICATION SHALL BE TRUE AS IF DIRECTLY PURCHASED FROM ARCHITECTS LEWIS + WHITLOCK P.A.A. NO COPY SHOULD BE MADE FROM THESE DOCUMENTS.


100% CONSTRUCTION DOCS.	TEP	JB	10/05/2025
-------------------------	-----	----	------------

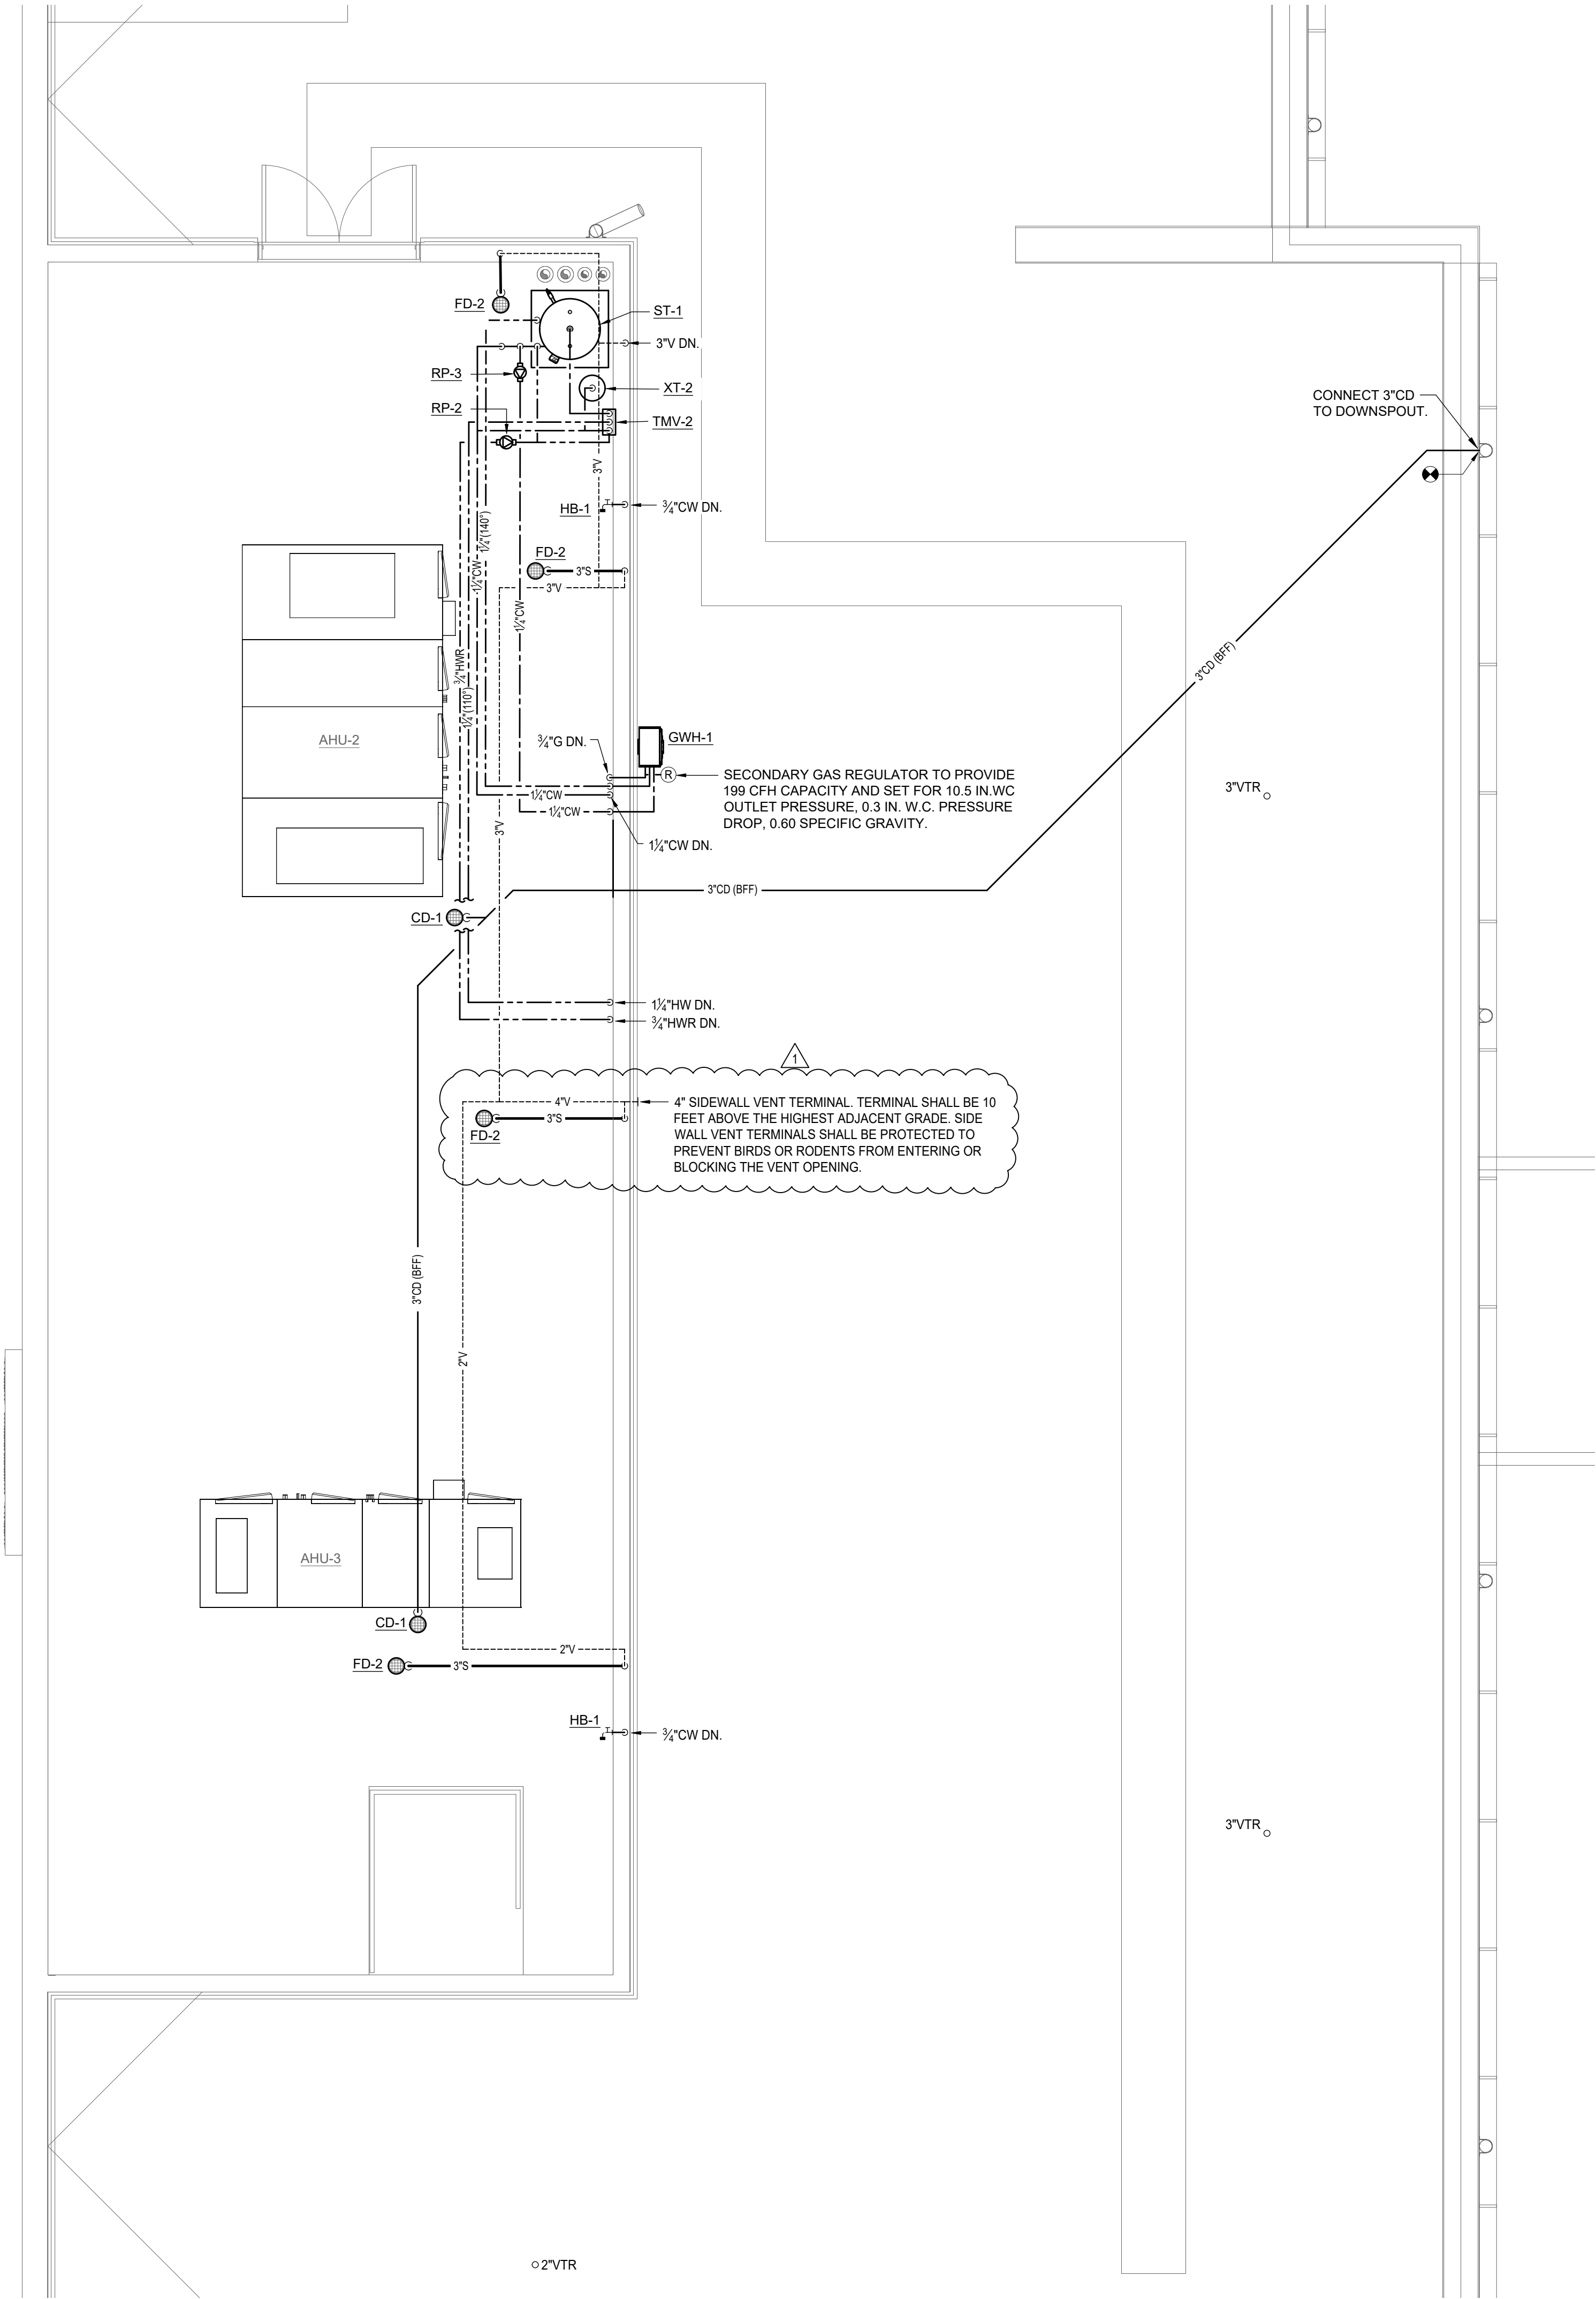

1 Plumbing Enlarged Plan - Equipment Platform

1/4" = 1'-0"

This item has been digitally signed and sealed by Jon Barber, PE on 6/3/25. Printed copies of this document are not considered signed and sealed and the signature must be verified on any electronic copies.

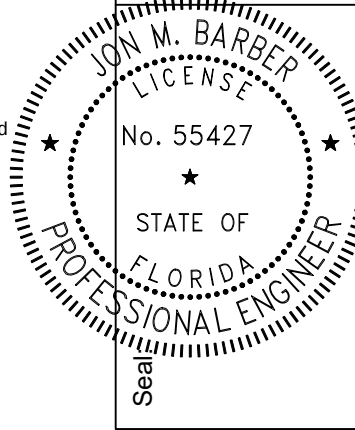

Architects Lewis + Whitlock
206 West Virginia St.
Tallahassee, Florida 32301
850.942.1718
www.think3d.net

Description:
Plumbing Enlarged Plan

Sheet No.:

P4.2

Client:
Leon County Schools
3420 W. Tharpe St., Suite 100
Tallahassee, FL 32303




Job Title:
Griffin Middle School - Phase 2
800 Alabama St. Tallahassee, FL 32304

Project #:
23483
Phase:
100% Construction Documents


PHASE:	DRAWN:	REVIEWED:	DATE:	ID:	REVISION:	DRAWN/REVIEWED/DATE:
CONCEPT SCHEM. DESIGN	TEP	JB	12/20/2024	1	Addendum #1	TEP JB 6/3/2025
DESIGN DEVELOPMENT						
EARLY DEMOLITION PACKAGE						
80% CONSTRUCTION DOCS	TEP	JB	03/21/2025			
PERMIT DOCS						
100% CONSTRUCTION DOCS	TEP	JB	06/03/2025			

THESE DRAWINGS AND ENDORSEMENTS ARE INSTRUMENTS OF SERVICE. THE DRAWINGS AND ASSOCIATED COPIES THEREOF, INCLUDING ELECTRONIC MEDIA AND CAD FILES, ARE THE PROPERTY OF ARCHITECTS LEWIS + WHITLOCK P.A. THEIR USE, REPRESENTATION OR REPRODUCTION FOR ANY PURPOSE EXCEPT BY WRITTEN AGREEMENT WITH THE ARCHITECT IS PROHIBITED. THIS COPYRIGHT NOTICE SHALL BE TRUE AS IF DIRECTLY PLACED ON EACH DRAWING EXHIBIT OR REVISIONS ON THIS DOCUMENT AND SHALL NOT BE REPRODUCED FROM THESE DOCUMENTS.

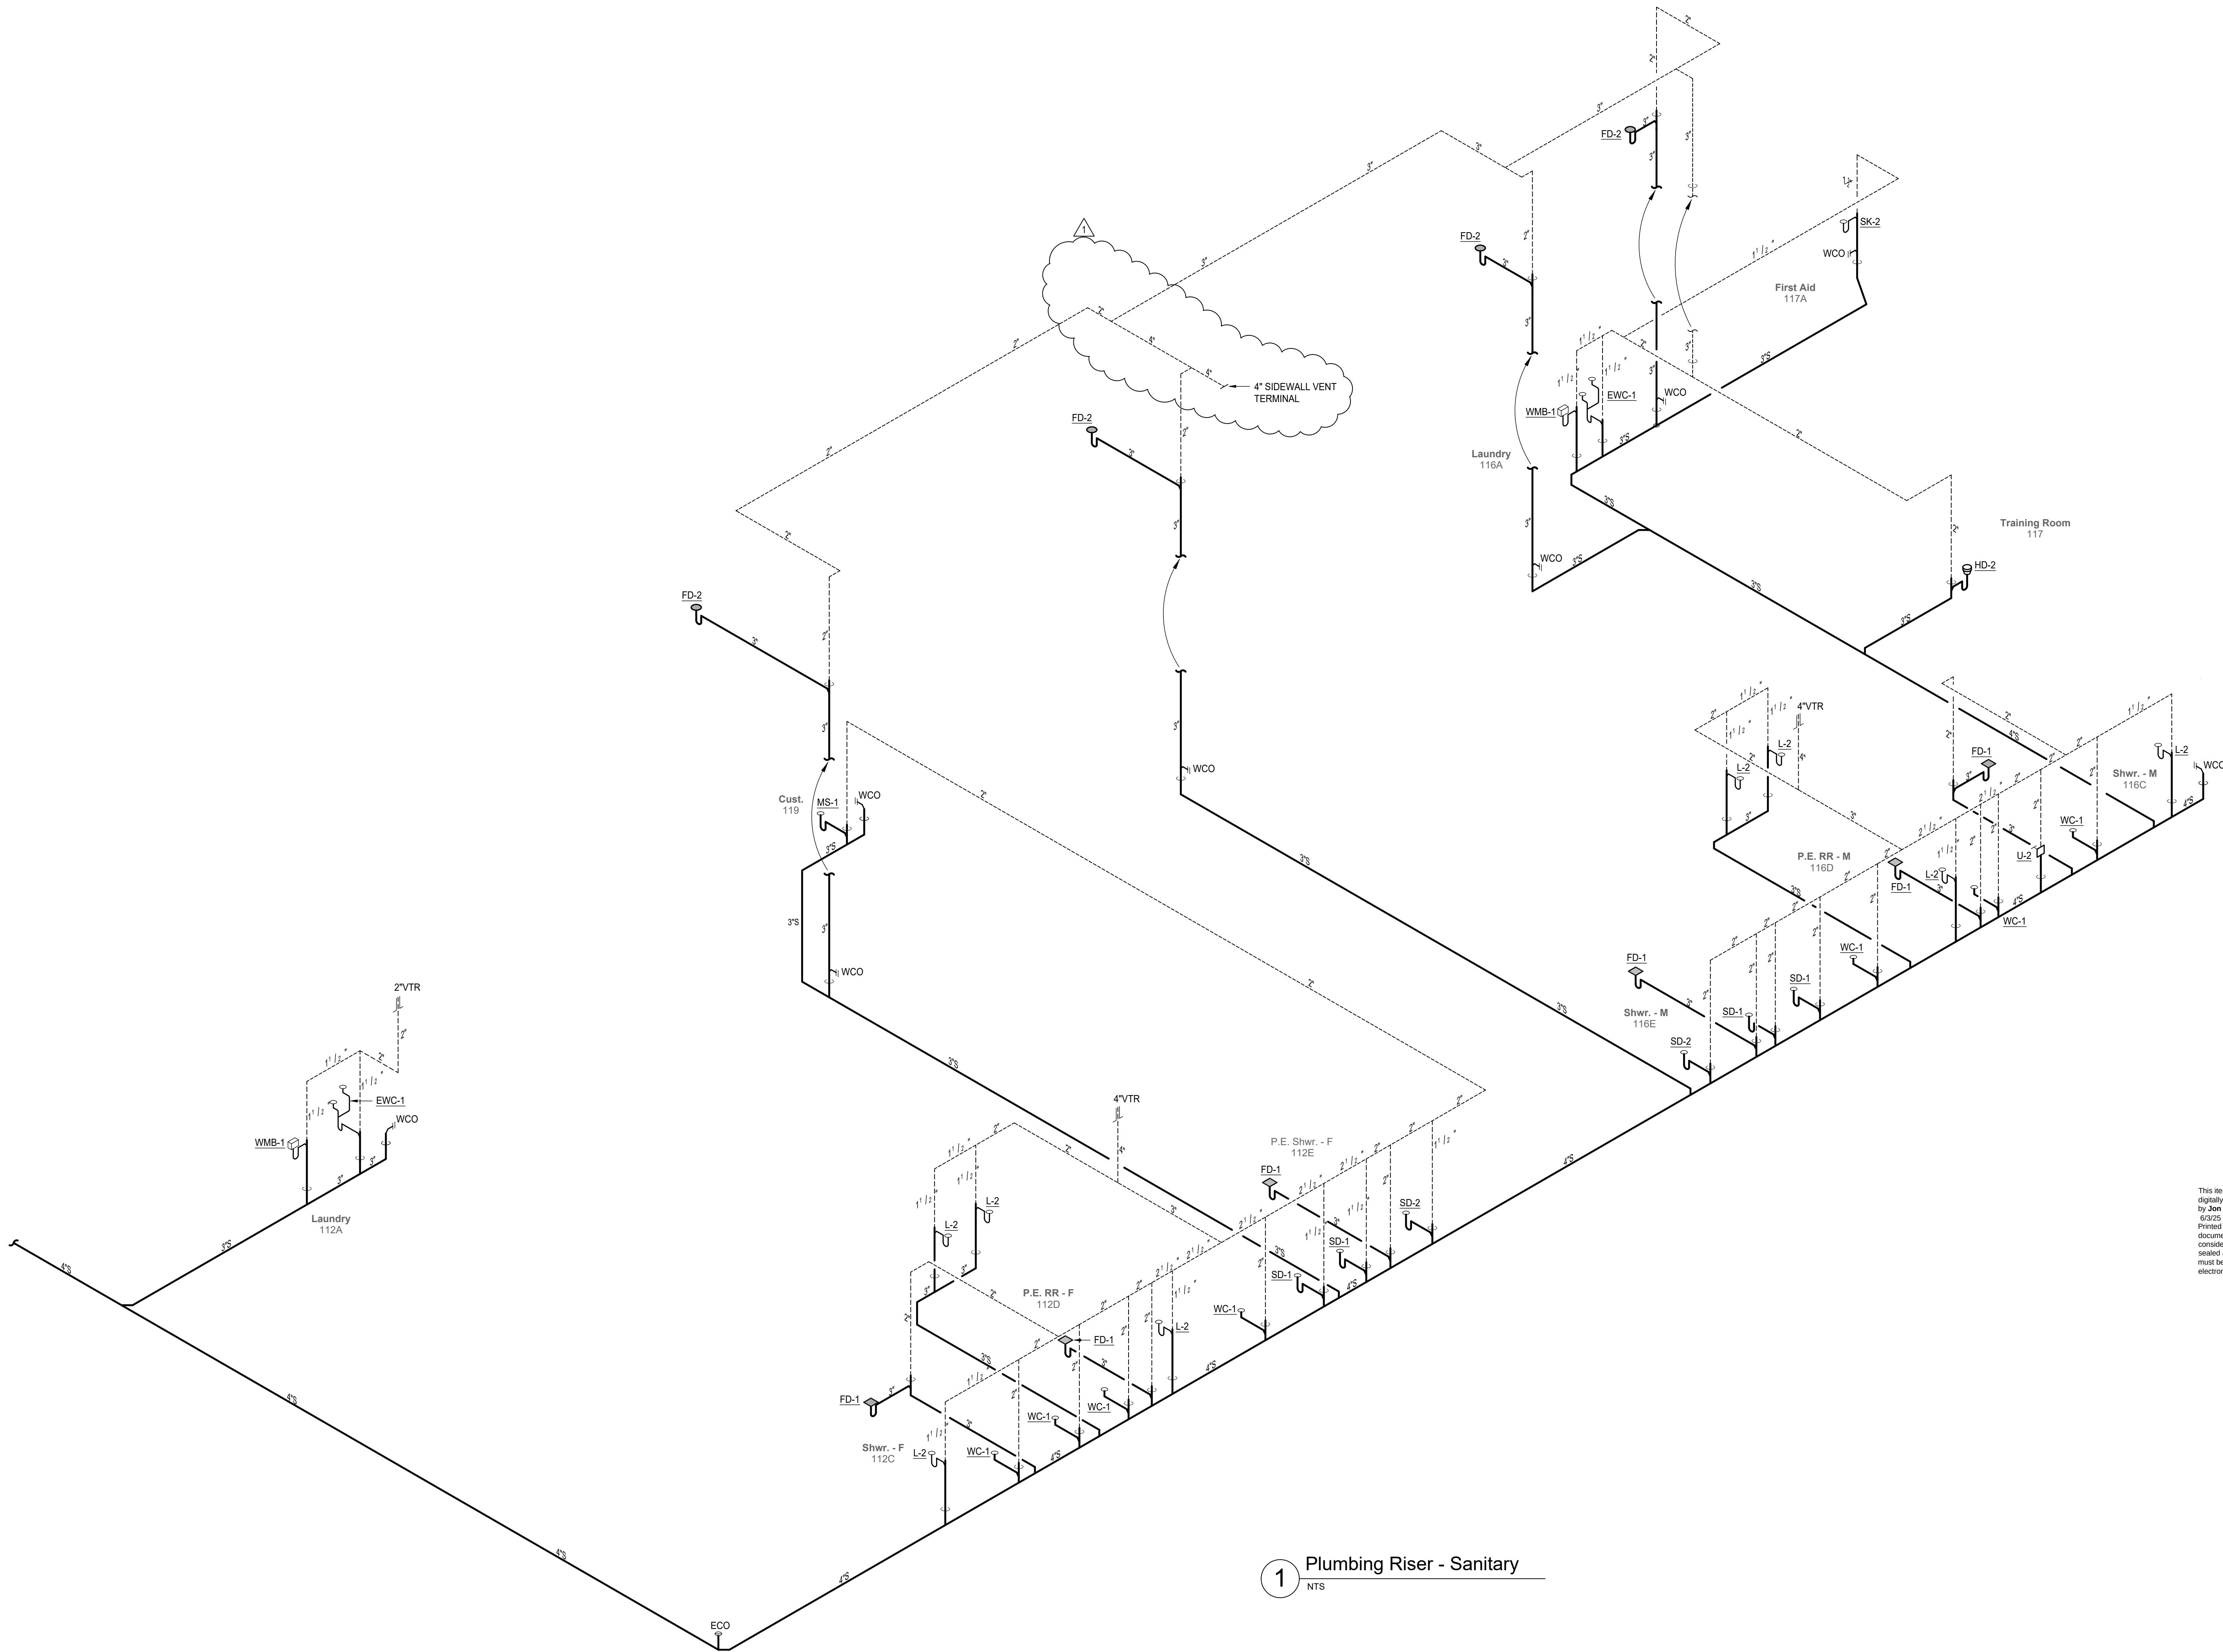

1 Plumbing Riser - Sanitary
NTS

This item has been
digitally signed and sealed
by Jon Barber, PE on
6/9/25
Printed copies of this
document are not
considered signed and
sealed and the signature
must be verified on any
electronic copies.

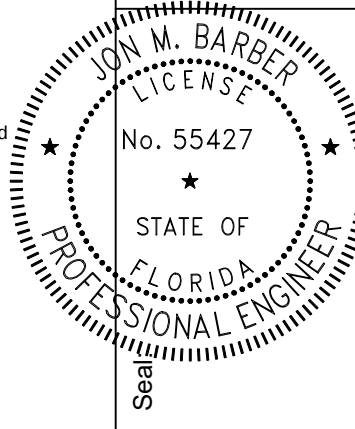

Architects Lewis + Whitlock
206 West Virginia St.
Tallahassee, Florida 32301
850.942.1718
www.think3d.net

Description:
Plumbing Riser -
Sanitary

Sheet No.:

P5.1

Client:



Consultant:

Project #:

23483

Phase:


100% Construction Documents

Leon County Schools
3420 W. Tharpe St., Suite 100
Tallahassee, FL 32303

Griffin Middle School - Phase 2
800 Alabama St. Tallahassee, FL 32304

PHASE:	DRAWN:	REVIEWED:	DATE:	ID:	REVISION:	DRAWN/REVIEWED/DATE:
CONCEPT SCHEM. DESIGN	TEP	JB	12/20/2024	1	Addendum #1	TEP JB 6/3/2025
DESIGN DEVELOPMENT						
EARLY DEMOLITION PACKAGE						
80% CONSTRUCTION DOCS	TEP	JB	03/21/2025			
PERMIT DOCS						
100% CONSTRUCTION DOCS	TEP	JB	06/09/2025			

THESE DRAWINGS AND ENDORSEMENTS ARE INSTRUMENTS OF SERVICE. THE DRAWINGS AND ASSOCIATED COPIES THEREOF, INCLUDING ELECTRONIC MEDIA AND CAD FILES, ARE THE PROPERTY OF ARCHITECTS LEWIS + WHITLOCK P.A. THEIR USE, REPRESENTATION OR REPRODUCTION FOR ANY PURPOSE EXCEPT BY WRITTEN AGREEMENT WITH THE ARCHITECT IS PROHIBITED. THIS COPYRIGHT NOTICE SHALL BE TRUE AS IF DIRECTLY PLACED ON EACH DRAWING EXHIBIT OR REVISIONS ON THIS DOCUMENT AND SHALL NOT BE REPRODUCED FROM THESE DOCUMENTS.

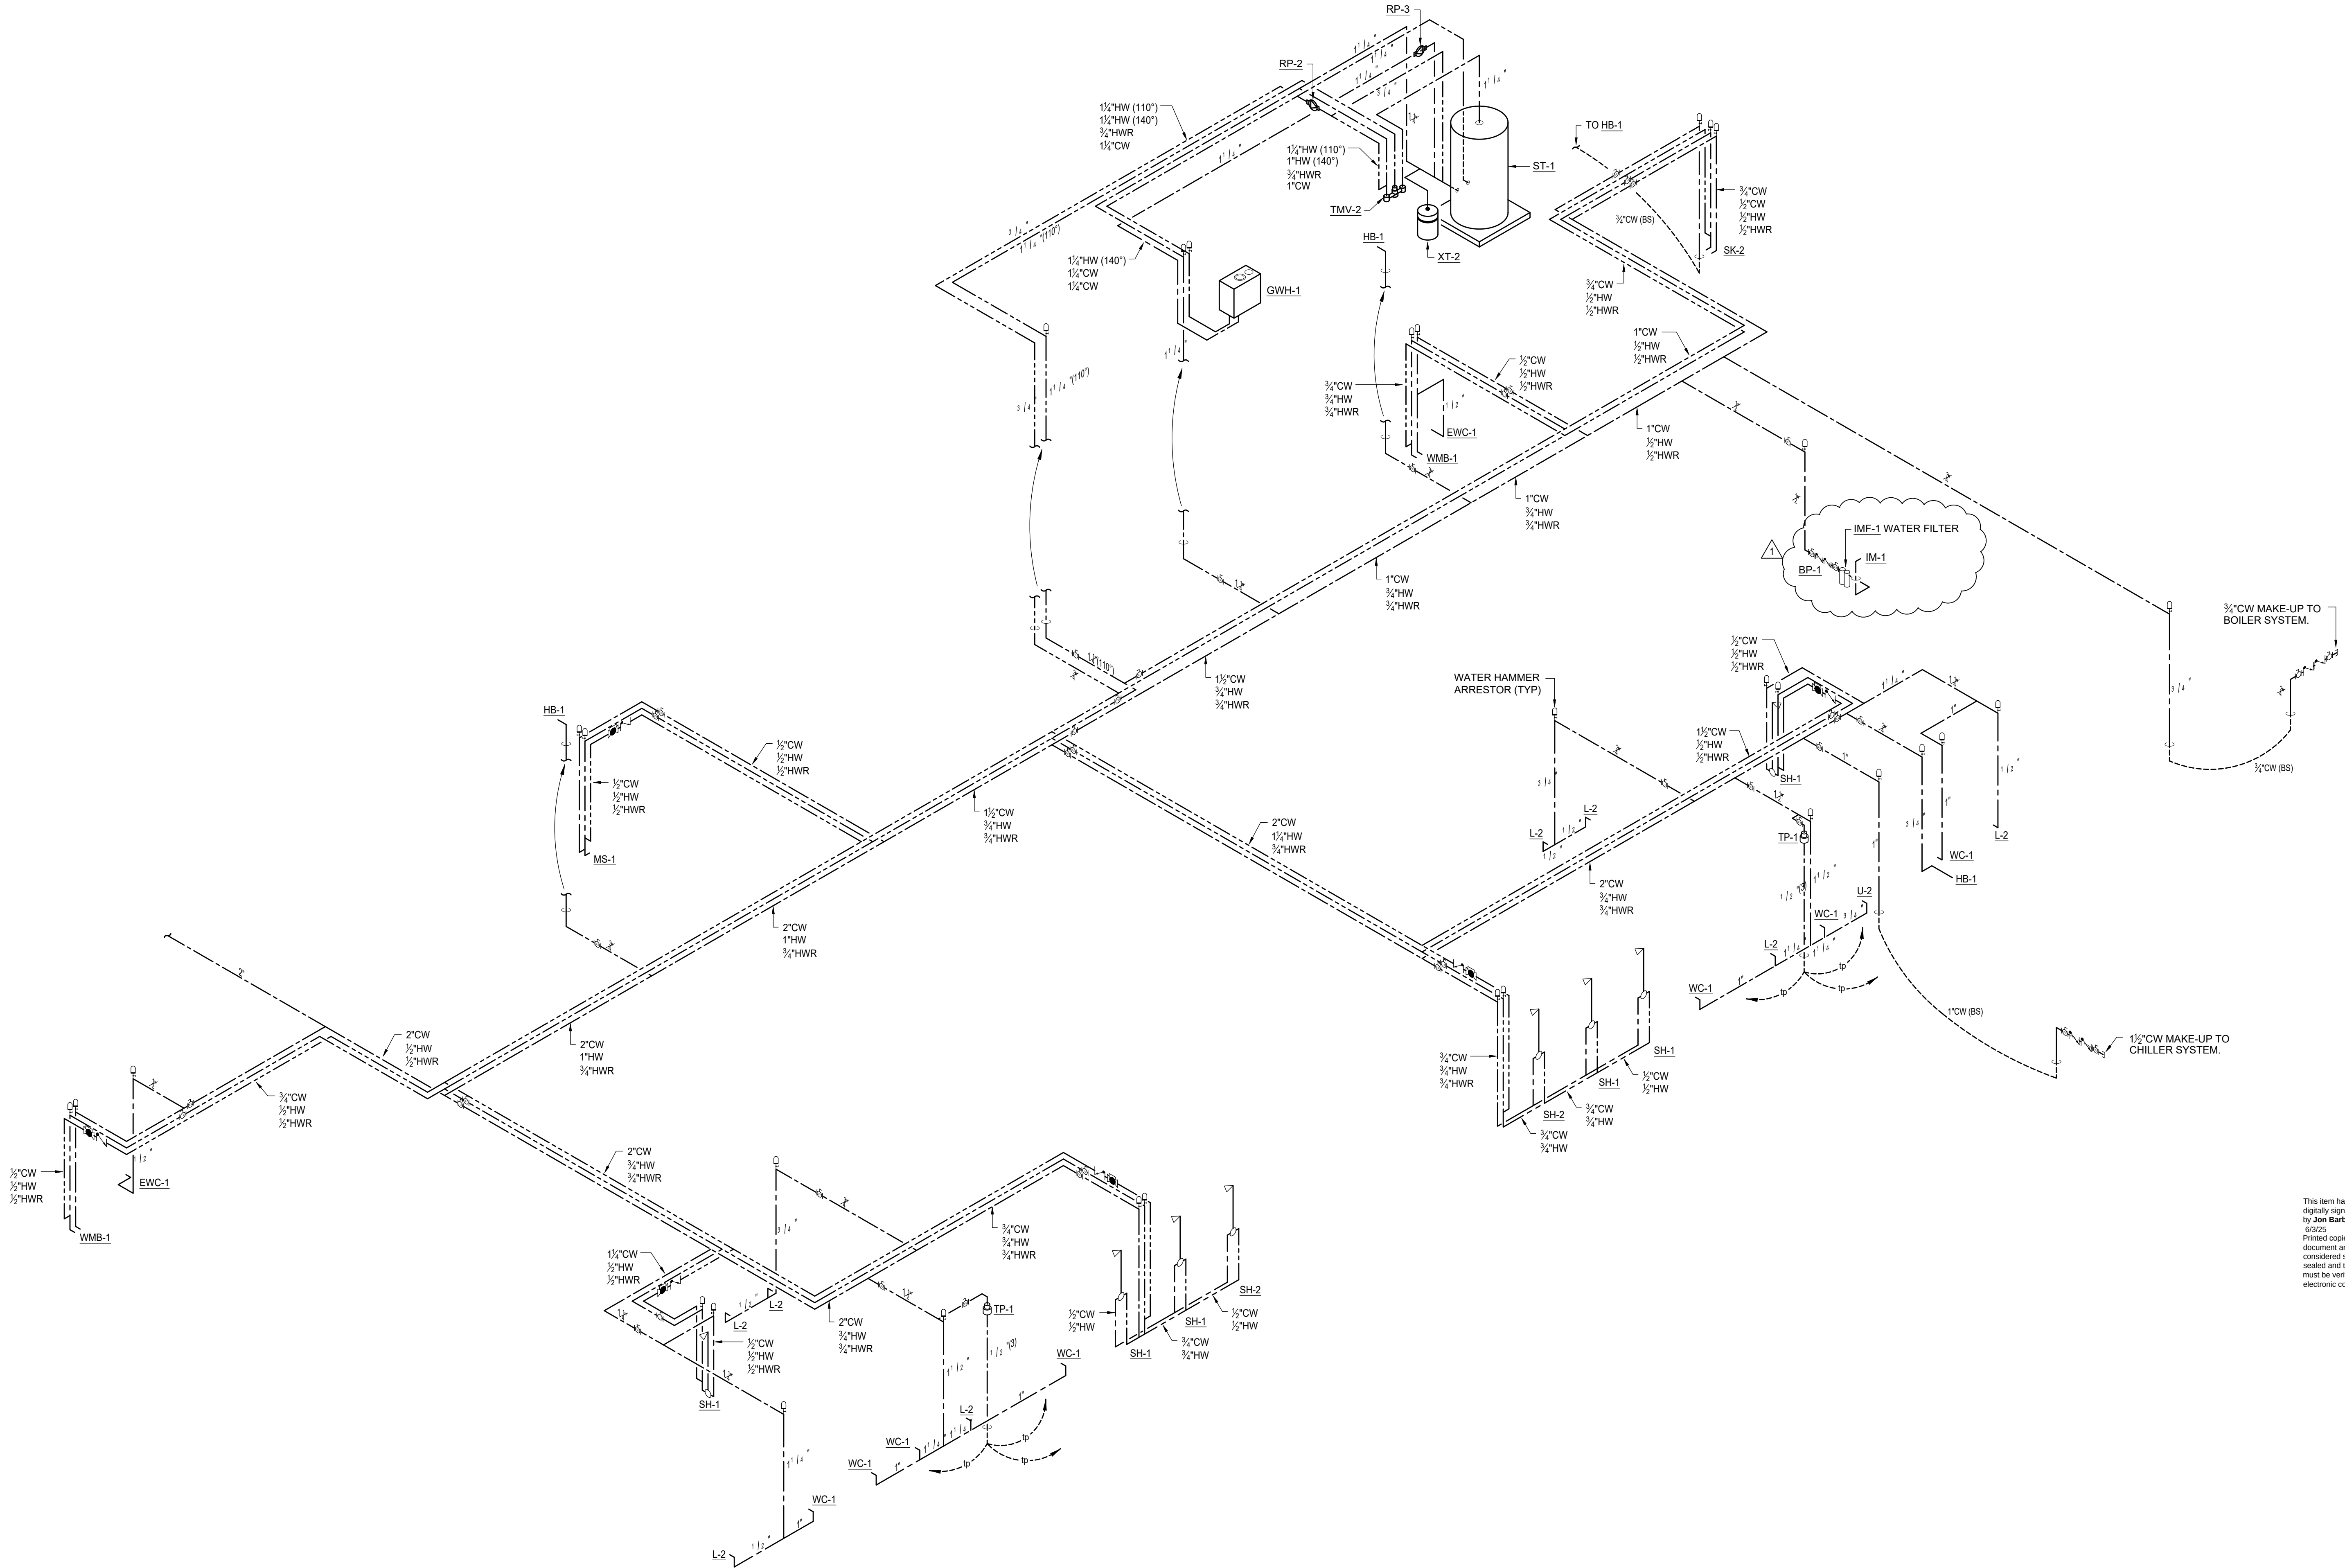

1 Plumbing Riser - Domestic Water
NTS

PHASE:	DRAWN:	REVIEWED:	DATE:	ID:	REVISION:	DRAWN/REVIEWED DATE:
CONCEPT SCHEM. DESIGN	TEP	JB	12/20/2024	1	Addendum #1	TEP JB 6/3/2025
DESIGN DEVELOPMENT	TEP	JB	03/21/2025			
EARLY DEMOLITION PACKAGE	TEP	JB	03/21/2025			
80% CONSTRUCTION DOCS	TEP	JB	03/21/2025			
PERMIT DOCS	TEP	JB	03/21/2025			
100% CONSTRUCTION DOCS	TEP	JB	03/21/2025			

Client:
Leon County Schools
3420 W. Tharpe St., Suite 100
Tallahassee, FL 32303

Job Title:
Griffin Middle School - Phase 2
800 Alabama St. Tallahassee, FL 32304

Consultant:
McGinniss + Fleming Engineering
401 W. Park Ave., Suite 100
Tallahassee, FL 32301
www.mcfem.com

Project #:
23483

Phase:
100% Construction Documents

ALW
Architects Lewis + Whitlock
206 West Virginia St.
Tallahassee, Florida 32301
850.942.1718
www.think3d.net

Description:
Plumbing Riser - Domestic Water

Sheet No.:
P5.3