



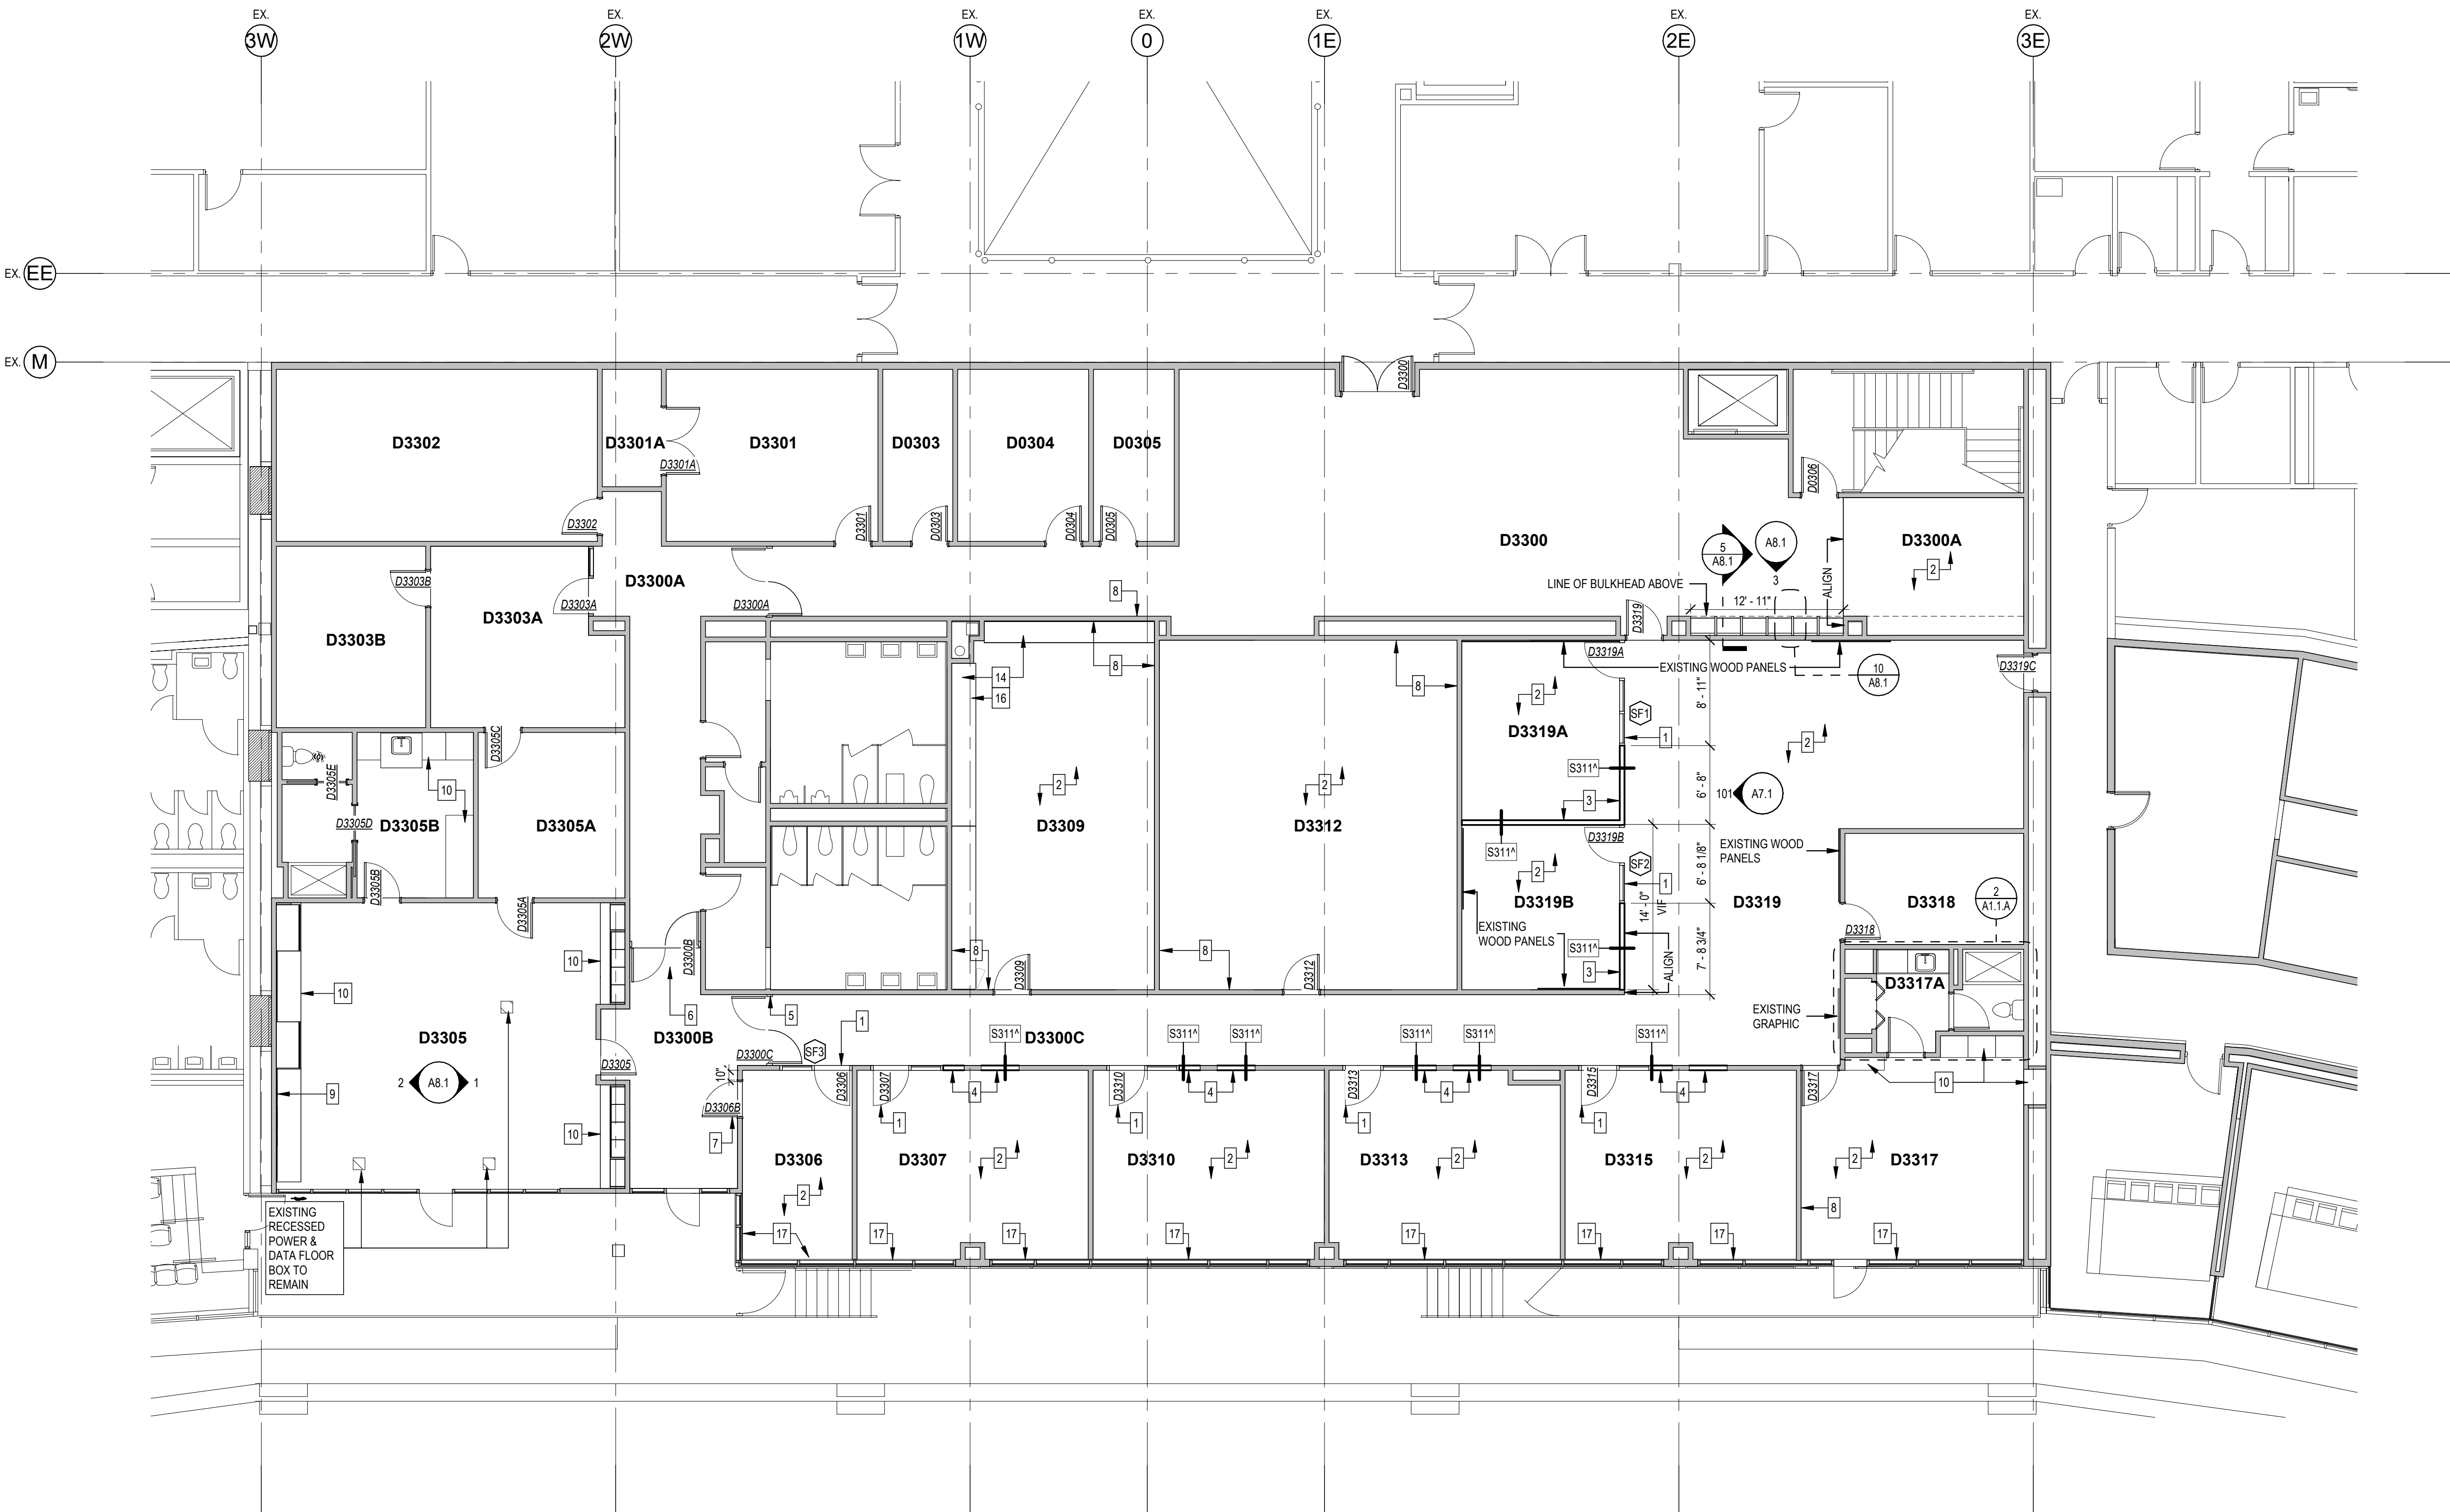


TOILET ACCESSORIES SCHEDULE

A1	ADA TOILET TISSUE DISPENSER - BRADLEY - ELVARI 5B2, BRUSHED NICKEL
A2	FRAMED MIRROR, BLACK - BRADLEY - 36" H X 60" W
A3	SANITARY NAPKIN RECEPTACLE - BRADLEY - ELVARI 4B2, BRUSHED NICKEL
A4	TOWEL RING, TBD.
A5	TOWEL BAR, TBD.
A6	HEAVY DUTY SHOWER CURTAIN ROD AND HOOKS. CURTAIN BY OWNER/USER.

PARTITION TYPE: METAL PARTIAL HT.

SYMBOL	DESCRIPTION	STC	FIRE RATING	NOTES
S311^	PARTIAL HT. MTL. STUD/GWB	38		

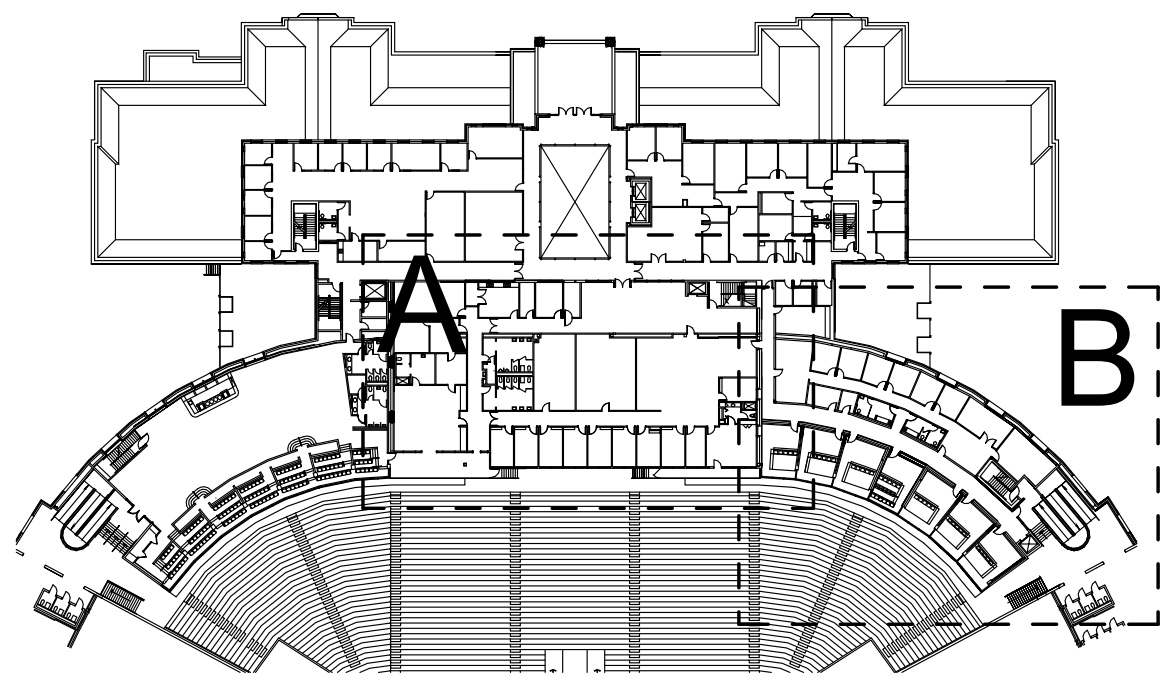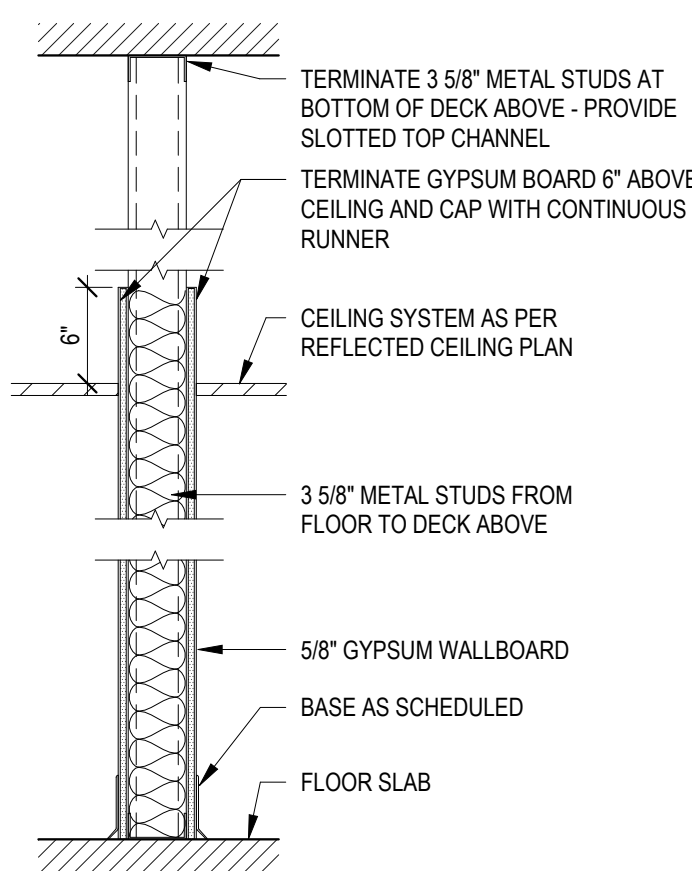


Key Plan
1" = 80'-0"

CONSTRUCTION KEYED NOTES

2. INSTALL NEW DARK BRONZE ALUMINUM STOREFRONT SYSTEM.
3. INSTALL NEW FLOORING AND WALL BASE. SEE FINISH FLOOR PLAN.
4. INSTALL NEW PARTITION.
5. INSTALL WALL WHERE INDICATED ON FLOOR PLAN.
6. INSTALL NEW CARD READER SYSTEM ON EXISTING DOOR.
7. INSTALL NEW DOOR, FRAME AND HARDWARE WITH CARD READER SYSTEM.
8. INSTALL NEW DOOR.
9. REPAIR EXISTING SURFACES AND FOOTBALL REINFORCED, WHITE BOARD CASEWORK AND FOOTBALL REINFORCED GRAPHICS AND PANELS HAVE BEEN REMOVED. PREPARE WALLS TO RECEIVE NEW FINISHES.
10. REPAIR DOOR OPERATOR.
11. PAINT EXISTING CASEWORK.
12. INSTALL NEW CEILING SYSTEM WITH RECESSED LINEAR LIGHT FIXTURES. NEW LIGHTING INDICATED ON LIGHTING PLAN - SEE ELEC.
13. INSTALL NEW SUSPENDED LIGHT FIXTURES.
14. INSTALL NEW PLUMBING FIXTURES.
15. NEW P-LAMINATE CASEGOODS BY FURNITURE VENDOR.
16. NEW CEILING FINISHES ONLY. EXISTING FRAMING & GYP. SUBSTRATE TO REMAIN.
17. INSTALL NEW UNDERCOUNTER LINING IN CASEGOODS PROVIDED BY VENDOR.
18. NEW MANUAL ROLLER SHADES. BREAK PANELS AT STOREFRONT MULLIONS. BOD: DRAPER CLUTCH SHADOW EXISTENCE P/WP44000000-3% OPENNESS SHADE FABRIC
19. REPAIR CABINET DOORS WITH SQUARE PROFILE SHAKER DOORS. MATCH EXISTING DIMENSIONS. PAINT EXISTING BOOKS AND DOORS PT-2. PROVIDE NEW CABINET DOOR PULLS: AMEROCK URBANITE 5" BRUSHED GOLD AND MATTE BLACK.
20. NEW WALL TILE, ALL VERTICAL SURFACES, THIS ROOM. SEE FINISH SCHEDULE.
21. NEW QUARTZ COUNTERTOP AND BACKSIDE SPLASH. PREPARE FOR NEW UNDERMOUNT SINK. SEE PLUMBING

 
FLOOR PLAN LEGEND

- | | |
|---|-----------------------------------|
| #### | DOOR TAG - REFER TO DOOR SCHEDULE |
|  | EXISTING PARTITION TO REMAIN |
|  | NEW PARTITION |
|  | EXISTING CONSTRUCTION TO REMAIN |
|  | NEW CONSTRUCTION |
|  | CONSTRUCTION OVERHEAD |
|  | CONSTRUCTION BELOW |

GENERAL NOTES - FLOOR PLAN

- A. REFER TO WALL TYPES ON SHEET G.3 FOR CONSTRUCTION ASSEMBLIES.
- B. ALL INTERIOR WALLS ARE DIMENSIONED TO FINISH FACE OF WALL. UNLESS OTHERWISE NOTED.
- C. REFER TO LIFE SAFETY PLAN FOR FIRE RATED SEPARATIONS.
- D. DO NOT SCALE DRAWINGS. VERIFY ALL EXISTING CONDITIONS AT SITE BEFORE PROCEEDING WITH WORK. IF EXISTING CONDITIONS ARE ENCOUNTERED THAT ARE SIGNIFICANTLY DIFFERENT THAN SHOWN OR INDICATED ON THE PLANS, NOTIFY ARCHITECT FOR CLARIFICATION AND FURTHER DIRECTION BEFORE PROCEEDING WITH WORK IN THAT AREA.
- E. ENSURE FINISH SURFACES ARE FLUSH AND SEAMLESS WHERE PARTITIONS AND/OR FURRING ARE COPLANAR.
- F. ALL PIPING, CONDUITS AND RELATED MECHANICAL AND ELECTRICAL ITEMS SHALL BE CONCEALED IN WALLS AND CEILING DRYWALL ASSEMBLY IN FINISHED AREAS UNLESS NOTED OTHERWISE.
- G. PROVIDE BLOCKING REQUIRED FOR MOUNTING AND ANCHORING WALL AND CEILING MOUNTED ITEMS SUCH AS, BUT NOT LIMITED TO: TOILET ROOM ACCESSORIES, MILLWORK, CASEWORK, HARDWARE, EQUIPMENT, RAILS, AND OTHER SPECIALTIES AND ACCESSORIES. REFER TO SHEET A-10 FOR TYPICAL TOILET ACCESSORY MOUNTING HEIGHTS.
- H. UNLESS NOTED OTHERWISE, SLOPE FLOOR 1/8" PER FOOT AT ALL NEW FLOOR DRAIN LOCATIONS.
- I. WHERE ACCESS PANELS ARE REQUIRED FOR EQUIPMENT, UTILITIES, OR DEVICES, THOSE PANELS SHALL BE INSTALLED WHETHER OR NOT THEY ARE SPECIFICALLY SHOWN ON THE DRAWINGS, WHEN INSTALLED IN A FIRE RATED ASSEMBLY, THE ACCESS PANEL MUST BE FIRE RATED TO MATCH THE RATING OF THAT ASSEMBLY. VERIFY ALL LOCATIONS WITH OWNER AND ARCHITECT BEFORE INSTALLING.
- J. INSTALL ACOUSTIC INSULATION IN ALL FRAMED WALLS CONTAINING PLUMBING PIPES.
- K. ALL EXPOSED PIPES, VENTS, AND CONDUITS, PENETRATING WALLS, FLOORS OR CEILINGS SHALL HAVE FINISHED TRIM RINGS (ESCUTCHEONS).
- L. ALL MATERIAL AND MEP ITEMS ARE SHOWN FOR REFERENCE.
- M. REFER TO SPECIFIC DISCIPLINE FOR MORE INFORMATION.

Consultant:	Client:	PHASE:	DRAWN:	REVIEWED:	DATE:	ID:	REVISION:	DRAWN:	REVIEWED:	DATE:
Project #: 19370.69 Phase: 100% Construction Documents	Florida State University	50% CONSTRUCTION DOCUMENTS	EE/AJK	RL	10-31-2025					
		100% CONSTRUCTION DOCUMENTS	EE/AJK	RL	11-4-2025					
Job Title: UCD - Third Floor Office Improvements Tallahassee, FL										
Project #:										
Phase:										
THESE DRAWINGS AND REVISIONS ARE INSTRUMENTS OF SERVICE. THE PHASES AND ASSOCIATED COVER SHEET(S) INDICATE THE CURRENT STATUS OF THE PROJECT. THESE DRAWINGS ARE THE PROPERTY OF AIA. THEIR USE, REPRODUCTION OR REPRODUCTION FOR ANY OTHER PROJECT WITHOUT THE ARCHITECT'S PERMISSION IS STRICTLY PROHIBITED. THIS COPYRIGHT NOTIFICATION SHALL BE THE AIA'S PROPERTY PLACED ON THIS DOCUMENT AND SHALL NOT BE REMOVED FROM THESE DOCUMENTS										

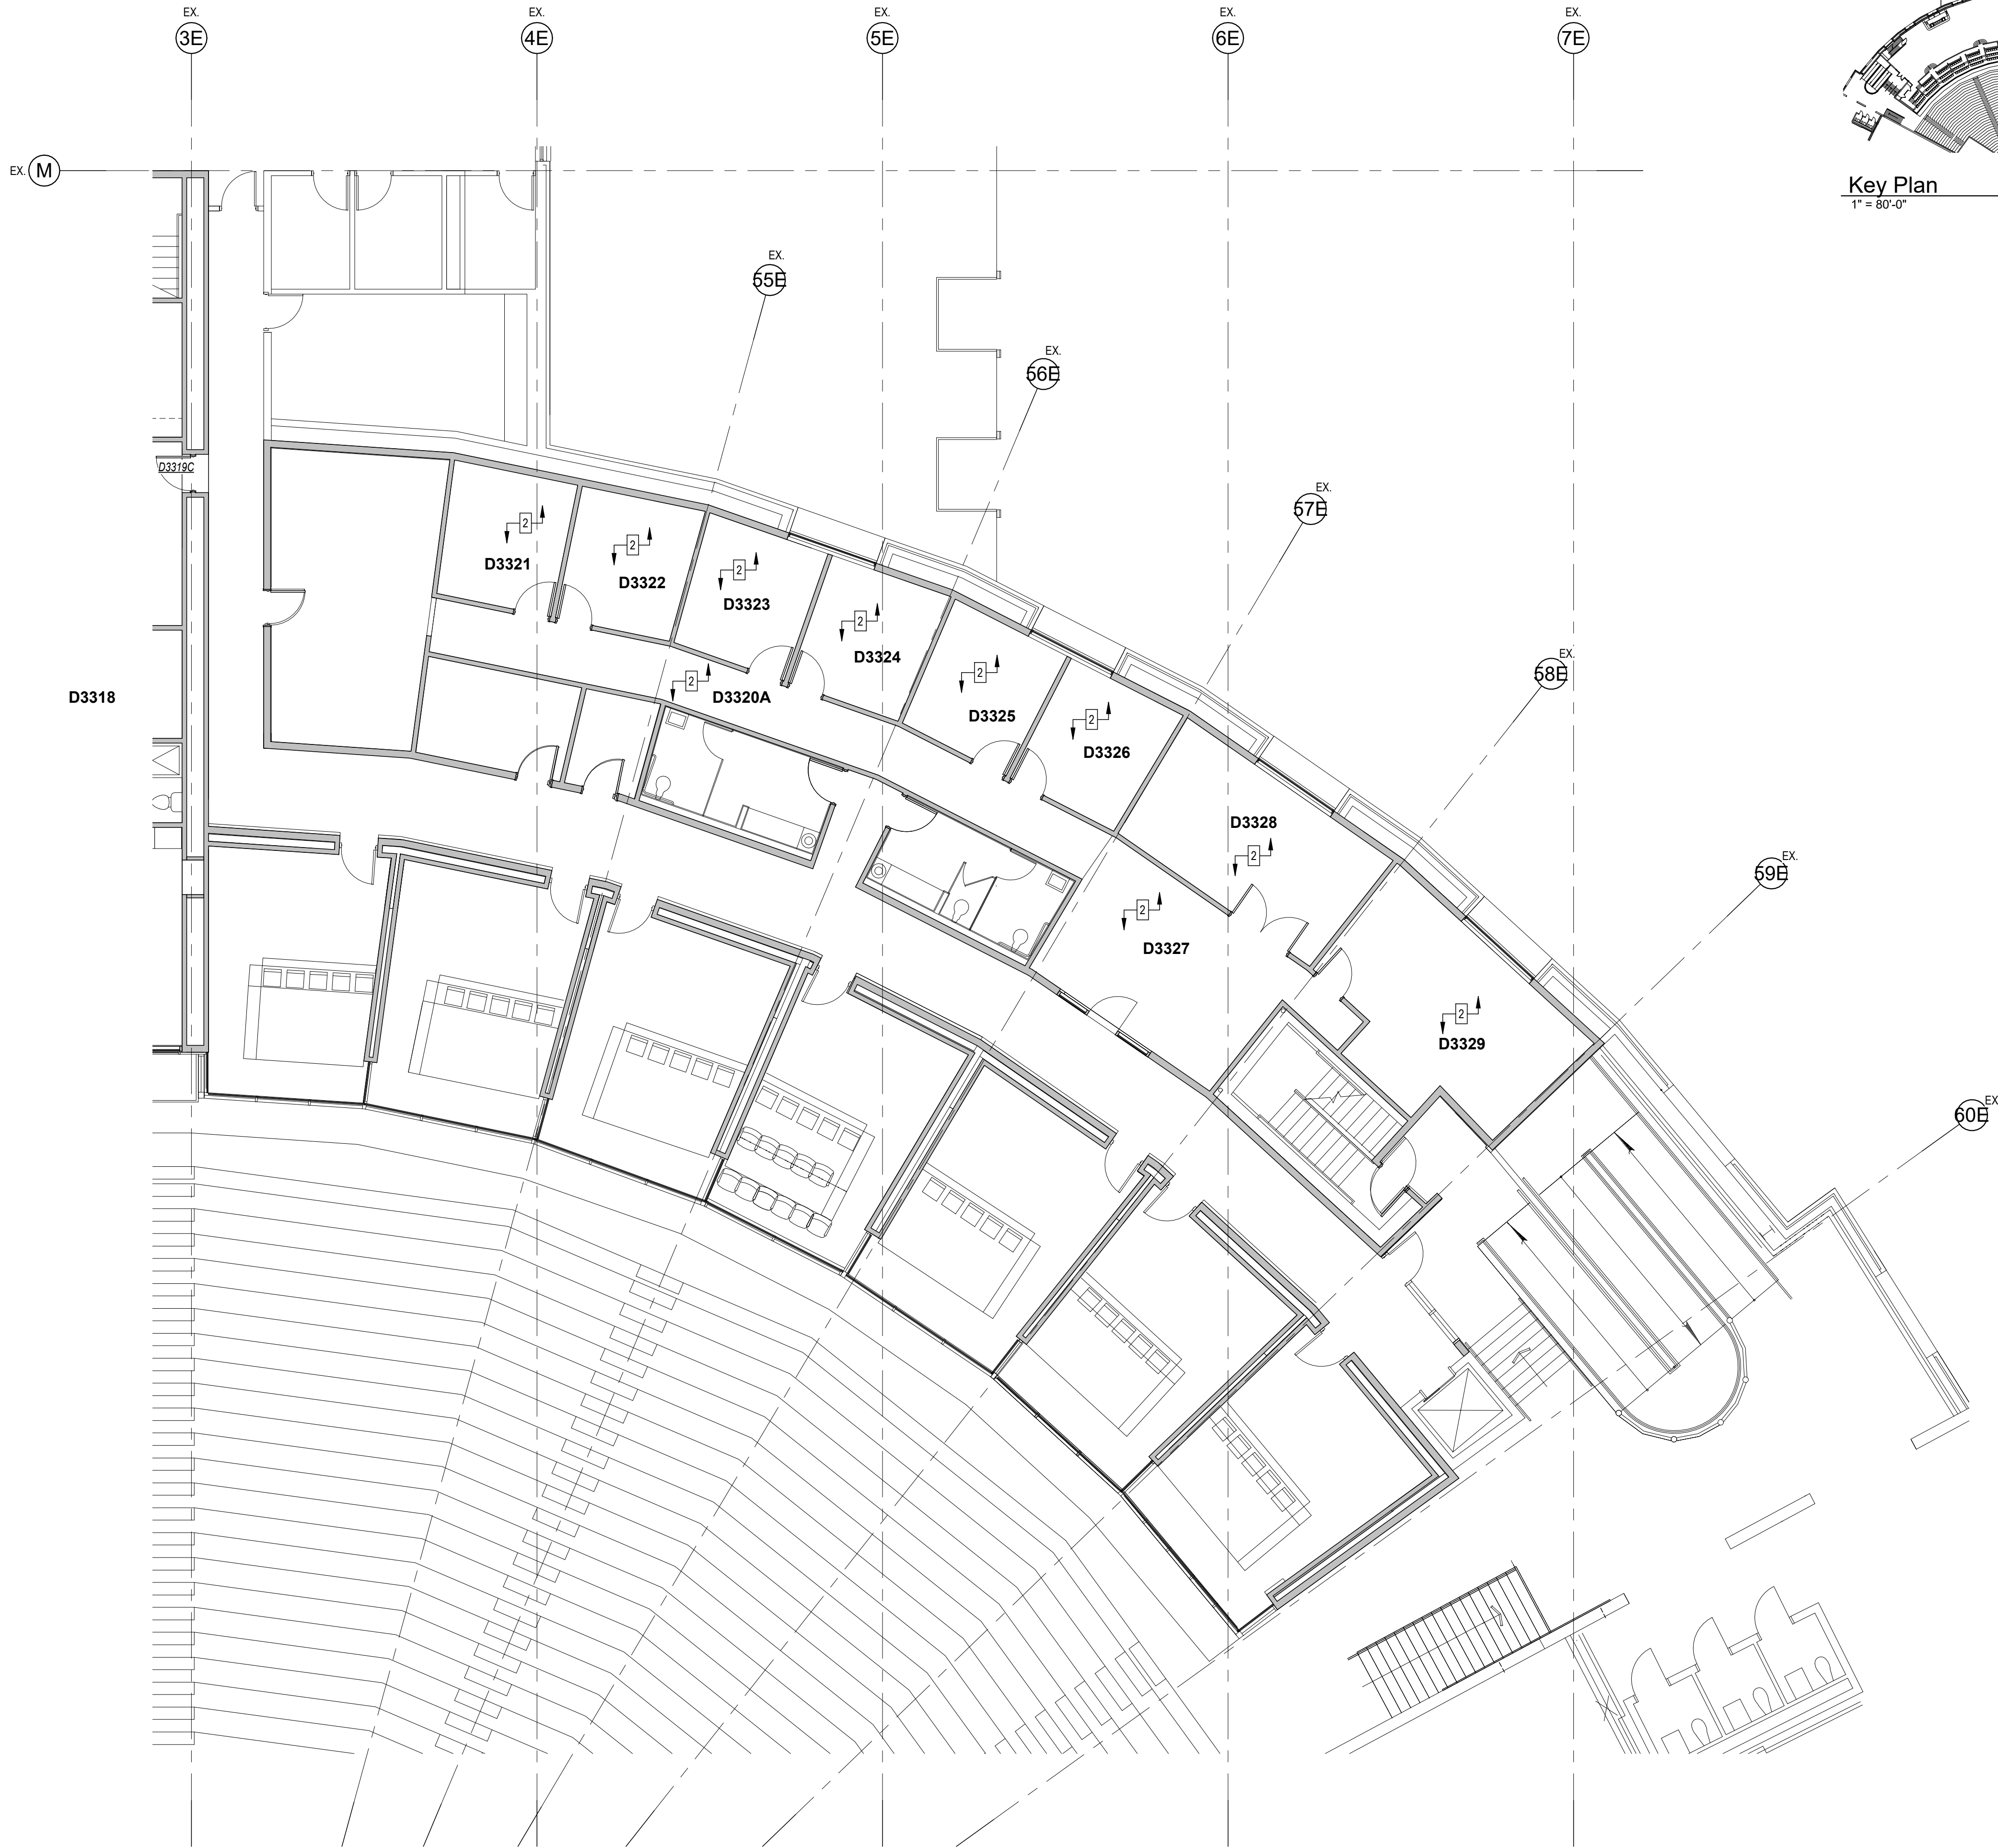

Key Plan

1" = 80'-0"

CONSTRUCTION KEYED NOTES

1. INSTALL NEW DARK BRONZE ALUMINUM STOREFRONT SYSTEM.
2. INSTALL NEW FLOORING AND WALL BASE, SEE FINISH FLOOR PLAN.
3. INSTALL NEW PARTITION.
4. INFILL WALL WHERE INDICATED ON FLOOR PLAN.
5. INSTALL NEW CARD READER SYSTEM ON EXISTING DOOR.
6. INSTALL NEW DOOR, FRAME AND HARDWARE WITH CARD READER SYSTEM.
7. INSTALL NEW DOOR.
8. REPAIR EXISTING SURFACES WHERE WAINSCOTTING, WHITE BOARDS, CASEWORK AND FOOTBALL RELATED GRAPHICS AND PANELS HAVE BEEN REMOVED. PREPARE WALLS TO RECEIVE NEW FINISHES.
9. REPAIR DOOR OPERATOR.
10. PAINT EXISTING CASEWORK.
11. INSTALL NEW CEILING SYSTEM WITH RECESSED LINEAR LIGHT FIXTURES WHERE INDICATED ON LIGHTING PLAN - SEE ELECT.
12. INSTALL NEW SUSPENDED LIGHT FIXTURES.
13. INSTALL NEW PLUMBING FIXTURES.
14. NEW P-LAMINATE CASEGOODS BY FURNITURE VENDOR.
15. NEW CEILING FINISHES ONLY. EXISTING FRAMING & GYP. SUBSTRATE TO REMAIN.
16. INSTALL NEW UNDERCOUNTER FRIDGE IN CASEGOODS PROVIDED BY VENDOR.
17. NEW MANUAL ROLLER SHADES. BREAK PANELS AT STOREFRONT MULLIONS. BOD: DRAPER CLUTCH OPERATED FLEXSHADE w/PW4400 PW4455-U64 3% OPENNESS SHADE FABRIC
18. REPLACE CABINET DOORS WITH SQUARE PROFILE SHAKER DOORS. MATCH EXISTING DIMENSIONS. PAINT EXISTING BOXES AND NEW DOORS PT-2. PROVIDE NEW CABINET DOOR PULLS: AMEROCK URBANITE 5" BRUSHED GOLD AND MATTE BLACK.
19. NEW WALL TILE, ALL VERTICAL SURFACES, THIS ROOM. SEE FINISH SCHEDULE.
20. NEW QUARTZ COUNTERTOP AND BACK/SIDE SPLASH. PREPARE FOR NEW UNDERMOUNT SINK, SEE PLUMBING

FLOOR PLAN LEGEND

- #### DOOR TAG - REFER TO DOOR SCHEDULE
- EXISTING PARTITION TO REMAIN
- NEW PARTITION
- EXISTING CONSTRUCTION TO REMAIN
- NEW CONSTRUCTION
- CONSTRUCTION OVERHEAD
- CONSTRUCTION BELOW

Consultant:	Project #:	19370.69	Phase:	100% Construction Documents	Client:	Florida State University	Job Title:	UCD - Third Floor Office Improvements	Tallahassee, FL
Reviewed:	Date:	10-31-2025	Reviewed:	Date:	11-14-2025	Drawn:	Date:	Reviewed:	Date:
Drawn:	Date:	10-31-2025	Drawn:	Date:	11-14-2025	ID:	Date:	Reviewed:	Date:

Seal:


 
ALW

Architects Lewis + Whitlock
206 West Virginia St.
Tallahassee, Florida 32301
850.942.1718
www.think3d.net

Description:
Third Floor Renovation
Plan - B

Sheet No.:

A1.1.B

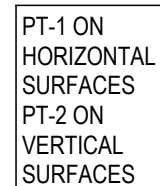


1. INSTALL NEW DARK BRONZE ALUMINUM STOREFRONT SYSTEM.
2. INSTALL NEW FLOORING AND WALL BASE. SEE FINISH FLOOR PLAN.
3. INSTALL NEW PARTITION.
4. INFILL WALL WHERE INDICATED ON FLOOR PLAN.
5. INSTALL NEW CARD READER SYSTEM ON EXISTING DOOR.
6. INSTALL NEW DOOR, FRAME AND HARDWARE WITH CARD READER SYSTEM
7. INSTALL NEW DOOR.
8. REPAIR EXISTING SURFACES WHERE WAINSCOTTING, WHITE BOARDS, CASEWORK AND FOOTBALL RELATED GRAPHICS AND PANELS HAVE BEEN REMOVED. PREPARE WALLS TO RECEIVE NEW FINISHES.
9. REPAIR DOOR OPERATOR.
10. PAINT EXISTING CASEWORK.
11. INSTALL NEW CEILING SYSTEM WITH RECESSED LINEAR LIGHT FIXTURES WHERE INDICATED ON LIGHTING PLAN. SEE ELECT.
12. INSTALL NEW SUSPENDED LIGHT FIXTURES.
13. INSTALL NEW PLUMBING FIXTURES.
14. NEW PLAMINATE CASEGOODS BY FURNITURE VENDOR.
15. NEW CEILING FINISHES ONLY. EXISTING FRAMING & GYP. SUBSTRATE TO REMAIN.
16. INSTALL NEW UNDERCOUNTER FRIDGE IN CASEGOODS PROVIDED BY VENDOR.
17. NEW MANUAL ROLLER SHADES. BREAK PANELS AT STOREFRONT MULLIONS. DOOR. BREAK CLUTCH OPERATOR FLEXSHADE WP#P44000 P#4455-064 3/8" OPENNESS SHADE FABRIC.
18. NEW CABINET DOOR ON SQUARE PROFILE SHAKER DOORS. MATCH EXISTING DIMENSIONS. PAINT EXISTING BOXES AND NEW DOORS P#T-2. PROVIDE NEW CABINET DOOR PULLS: AMEROCK URBANITE S' BRUSHED GOLD AND MATTE BLACK.
19. NEW WALL TILE, ALL VERTICAL SURFACES, THIS ROOM. SEE FINISH SCHEDULE.
20. NEW QUARTZ COUNTERTOP AND BACKSIDE SPLASH. PREPARE FOR NEW UNDERMOUNT SINK, SEE PLUMBING.

	2x2 ACT PANELS		PAINTED GYPSUM
	2x4 ACT PANELS		WOOD FINISH
	DIFFUSER - SUPPLY		
	DIFFUSER - RETURN		
	EXHAUST FAN		
	EXIT SIGN		
	LIGHT FIXTURE - LINEAR		
	LIGHT FIXTURE - SUSPENDED PENDANT		
	LIGHT FIXTURE - RECESSED		

- A. CEILING HEIGHTS ARE DIMENSIONED FROM FLOOR DATA ELEVATION TO FINISHED CEILING AND ARE NOTED ON THE DRAWINGS AS (XX'-XX").
- B. ACOUSTICAL CEILING GRID SHALL BE CENTERED IN ROOM UNLESS OTHERWISE NOTED.
- C. CENTER LIGHT FIXTURES, SPEAKERS, SMOKE DETECTORS, GRILLES, SPRINKLER HEADS, ELECTRICAL, MECHANICAL AND OTHER DEVICES IN CEILING TILES UNLESS OTHERWISE NOTED.
- D. ALL GYPSUM BOARD CEILINGS ARE TO BE PAINTED PT-XX UNLESS OTHERWISE NOTED.
- E. PROVIDE RECESSED / CONCEALED SPRINKLER HEADS IN GYPSUM BOARD CEILINGS, SOFFITS AND CLOUDS UNLESS OTHERWISE NOTED. SPRINKLER HEAD LOCATIONS ARE NOT SHOWN FOR CLARITY. FIRE PROTECTION INSTALLER SHALL PROVIDE THE SPRINKLER HEADS, IN AREAS WITHOUT SUSPENDED CEILINGS, COORDINATE LOCATIONS OF SPRINKLER HEADS WITH HVAC DUCTS, EQUIPMENT, BEAMS, COLUMNS, LIGHTS, AND ANY OTHER OBSTRUCTIONS IN ACCORDANCE WITH APPLICABLE CODE REQUIREMENTS. IN AREAS WITH SUSPENDED CEILINGS, COORDINATE SPRINKLER MAINS, RUNS, AND SPRINKLER HEAD LOCATIONS WITH OTHER ROOM OR SUITE CEILING HEIGHTS, LIGHTING, DIFFUSERS, AND OTHER CEILING DEVICES. CEILINGS ARE MAINTAINED AS SHOWN OR AS REQUIRED TO COMPLY WITH APPLICABLE CODE REQUIREMENTS. ADVISE ARCHITECTS OF ANY CONFLICTS WHICH MUST BE RESOLVED PRIOR TO INSTALLATION.
- G. ACCESS PANELS SHOWN IN GENERAL LOCATIONS ON RCPS. CONTRACTOR TO COORDINATE AND CONFIRM FINAL ACCESS PANEL LOCATIONS WITH SPECIALTIES AND SUBMIT PROPOSED LOCATIONS TO ARCHITECT FOR APPROVAL.
- H. PROVIDE CUT-OUTS AND OPENINGS FOR ITEMS WHICH PENETRATE THROUGH CEILING SYSTEMS (INCLUDING SPECIAL EQUIPMENT HANGERS AND DEVICES, CONDUIT, PIPING, ELECTRICAL REQUIREMENTS, ETC.). COORDINATE LOCATIONS WITH ARCHITECT AND SPECIALTY DISCIPLINE.
- I. ROWS OF LIGHT FIXTURES TO ALIGN ACROSS ADJACENT AREAS UNLESS OTHERWISE NOTED. REFER TO ELECTRICAL DRAWINGS AND SPECIFICATIONS FOR EXACT FIXTURE TYPES.
- J. ALL STRUCTURAL AND MEP ITEMS ARE SHOWN FOR REFERENCE. REFER TO SPECIALTY DISCIPLINE FOR MORE INFORMATION.
- K. MANUAL ROLLER SHADES TO BE INCLUDED IN THE FF&E PACKAGE. LOCATION FOR SHADES SHOWN FOR REFERENCE ONLY. FOR MOTORIZED SHADES, ELECTRICAL CONDUIT, PIPING, AND TERMINATION TO SHADE LOCATION TO BE PROVIDED IN BASE BUILDING BID.

ALW

A1.3.A

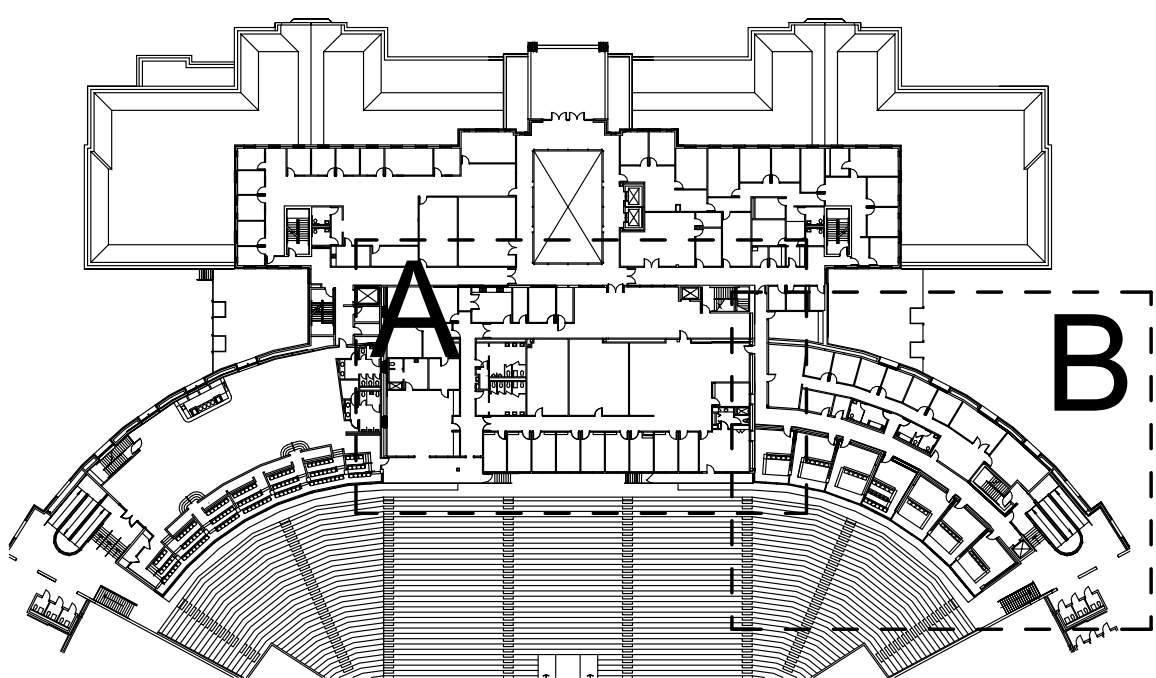

Key Plan
1" = 80'-0"

2.	INSTALL NEW DARK BRONZE ALUMINUM STOREFRONT SYSTEM.
3.	INSTALL NEW FLOORING AND WALL BASE. SEE FINISH FLOOR PLAN.
4.	INSTALL NEW PARTITION.
5.	INFILL WALL WHERE INDICATED ON FLOOR PLAN.
6.	INSTALL NEW CARD READER SYSTEM ON EXISTING DOOR.
7.	INSTALL NEW DOOR, FRAME AND HARDWARE WITH CARD READER SYSTEM.
8.	REPAIR EXISTING SURFACES WHERE WAINSCOTTING, WHITE BOARDS, CASEWORK AND FOOTBALL RELATED GRAPHICS AND PANELS HAVE BEEN REMOVED. PREPARE WALLS TO RECEIVE NEW FINISHES.
9.	REPAIR DOOR OPERATOR.
10.	PAINT EXISTING CASEWORK.
11.	INSTALL NEW CEILING SYSTEM WITH RECESSED LINEAR LIGHT FIXTURES. NEW CEILING INDICATED ON LIGHTING PLAN - SEE ELEC.
12.	INSTALL NEW SUSPENDED LIGHT FIXTURES.
13.	INSTALL NEW PLUMBING FIXTURES.
14.	NEW P-LAMINATE CASEGOODS BY FURNITURE VENDOR.
15.	NEW CEILING FINISHES ONLY. EXISTING FRAMING & GYP. SUBSTRATE TO REMAIN.
16.	INSTALL NEW UNDERCOUNTER LINING IN CASEGOODS PROVIDED BY VENDOR.
17.	NEW MANUAL ROLLER SHADES. BREAK PANELS AT STOREFRONT MULLIONS. BOO: DRAPER CLUTCH OPERATOR FLEXSHADE WP#P400 PW445-044 3% OPNESS SHADE FABRIC.
18.	NEW CABINET DOORS WITH SQUARE PROFILE SHAKER DOORS. MATCH EXISTING DIMENSIONS. PAINT EXISTING BOARDS AND DOORS PT-2. PROVIDE NEW CABINET DOOR PULLS: AMERCOCK URBANITE 5" BRUSHED GOLD AND MATTE BLACK.
19.	NEW WALL TILE, ALL VERTICAL SURFACES, THIS ROOM. SEE FINISH SCHEDULE.
20.	NEW QUARTZ COUNTERTOP AND BACKSIDE SPLASH. PREPARE FOR NEW UNDERMOUNT SINK, SEE PLUMBING.

	2x2 ACT PANELS		PAINTED GYPSUM
	2x4 ACT PANELS		WOOD FINISH
	DIFFUSER - SUPPLY		
	DIFFUSER - RETURN		
	EXHAUST FAN		
	EXIT SIGN		
	LIGHT FIXTURE - LINEAR		
	LIGHT FIXTURE - SUSPENDED PENDANT		
	LIGHT FIXTURE - RECESSED		

Consulant:	Client:	PHASE:	DRAWN:	REVIEWED:	DATE:	ID:	REVISION:	DRAWN:	REVIEWED:	DATE:	
Project # 19370.69 Phase: 100% Construction Documents	 Florida State University	50% CONSTRUCTION DOCUMENTS	EE/AJK	RL	10-31-2025						
		100% CONSTRUCTION DOCUMENTS	EE/AJK	RL	11-14-2025						
Job Title:	UCD - Third Floor Office Improvements Tallahassee, FL										

THESE DRAWINGS AND REVISIONS ARE THE PROPERTY OF THE ARCHITECT AND ARE NOT TO BE REPRODUCED OR TRANSMITTED IN ANY FORM OR BY ANY MEANS, ELECTRONIC OR MECHANICAL, INCLUDING PHOTOCOPYING, RECORDING, OR BY ANY INFORMATION STORAGE AND RETRIEVAL SYSTEM. ANY UNAUTHORIZED USE, REPRODUCTION, OR TRANSMISSION OF THESE DRAWINGS IS PROHIBITED. THIS COPYRIGHT NOTIFICATION IS HEREBY ACKNOWLEDGED AND AGREED TO BY THE USER OF THESE DRAWINGS. THESE DRAWINGS SHALL NOT BE REMOVED FROM THESE DOCUMENTS

ALW
Architects Lewis + Whitlock
206 West Virginia St.
Tallahassee, Florida 32301
850.942.1718
www.think3d.net

Sheet No.:

A1.3.B

NARROW LITE

FULL GLASS

DBL EGRESS w/LITE

BIFOLD

***NOTE:**
- ALL GLAZING IN DOORS SHALL USE GLAZING TYPE 'GL-1' UNLESS NOTED OTHERWISE

- ALL FIRE RATED DOORS CONTAINING GLASS SHALL USE GLAZING TYPE 'FG'

01

02

The technical drawings show three window configurations with dimensions in inches:

- Configuration 1 (Left):** Three separate windows. Total width is 8' - 11". Individual window widths are 2' - 9 5/8" (left), 2' - 9 5/8" (middle), and 3' - 3 3/4" (right). Total height is 9' - 0". Individual window heights are 7' - 0" (left), 7' - 0" (middle), and 7' - 0" (right). Each window is labeled GL-1.
- Configuration 2 (Middle):** Two windows with a central door. Total width is 6' - 7 1/2". Individual window widths are 3' - 3 3/4" (left) and 3' - 3 3/4" (right). Total height is 9' - 0". Individual window heights are 7' - 0" (left) and 7' - 0" (right). Each window is labeled GL-1. The central door is labeled GL-1.
- Configuration 3 (Right):** A single large window with a central door. Total width is 6' - 1 1/2". Individual window widths are 3' - 3 3/4" (left) and 2' - 9 3/4" (right). Total height is 9' - 0". Individual window heights are 7' - 0" (left) and 7' - 0" (right). Each window is labeled GL-1. The central door is labeled GL-1.

SF-1SF-2SF-3

REFER TO SCHEDULE FOR MATERIALS AND FINISHES

9 Storefront Door Head Detail
3" = 1'-0"

$$3'' = 1'-0''$$

11 Storefront Door Jamb Detail

3" = 1'-0"

Door Number	Type	Door Panel				Door Frame			Access Control	Hardware	New Room Sign	Notes
		W	HT	Material	Finish	Type	Material	Finish				
LEVEL THREE												
D0303	Exist.	3'-0"	7'-0"	Exist.	PT-2	Exist.	Exist.	PT-2		Exist.	Yes	
D0304	Exist.	3'-0"	7'-0"	Exist.	PT-2	Exist.	Exist.	PT-2		Exist.	Yes	
D0305	Exist.	3'-0"	7'-0"	Exist.	PT-2	Exist.	Exist.	PT-2		Exist.	Yes	
D0306	Exist.	3'-0"	7'-0"	Exist.	PT-2	Exist.	Exist.	PT-2		Exist.	Yes	
D0309		4'-0"	6'-8"								Yes	
D3300	Exist.	6'-0"	7'-0"	Exist.	PT-2	Exist.	Exist.	PT-2		Exist.		PAIN'T DOOR AND FRAME ON D3300 SIDE ONLY
D3300A	Exist.	5'-8"	7'-0"	Exist.	PT-2	1	HM	PT-2		Exist.		
D3300B	DAL	5'-8"	7'-0"	Wood	PT-2	2	HM	PT-2	Y	Set 2		FIRE RATED - SMOKE RATED
D3300C	Exist.	5'-8"	7'-0"	Exist.	PT-2	Exist.	Exist.	PT-2	Y	Set 1		
D3301	Exist.	3'-0"	7'-0"	Exist.	PT-2	Exist.	Exist.	PT-2		Exist.	Yes	
D3301A	Exist.	5'-8"	7'-0"	Exist.	PT-2	Exist.	Exist.	PT-2		Exist.	Yes	
D3302	Exist.	3'-0"	7'-0"	Exist.	PT-2	Exist.	Exist.	PT-2		Exist.	Yes	
D3303A	Exist.	3'-0"	7'-0"	Exist.	PT-2	1	Exist.	PT-2		Exist.	Yes	
D3303B	Exist.	3'-0"	7'-0"	Exist.	PT-2	Exist.	Exist.	PT-2		Exist.	Yes	
D3305	Exist.	3'-0"	7'-0"	Exist.	PT-2	Exist.	Exist.	PT-2		Exist.	Yes	
D3305A	Exist.	3'-0"	7'-0"	Exist.	PT-2	Exist.	Exist.	PT-2		Exist.		
D3305B	Exist.	3'-0"	7'-0"	Exist.	PT-2	Exist.	Exist.	PT-2		Exist.		
D3305C	Exist.	3'-0"	7'-0"	Exist.	PT-2	Exist.	Exist.	PT-2		Exist.	Yes	
D3305D	Exist.	3'-0"	7'-0"	Exist.	PT-2	Exist.	Exist.	PT-2		Exist.		
D3305E	Exist.	2'-6"	7'-0"	Exist.	PT-2	Exist.	Exist.	PT-2		Exist.		
D3306	FG	3'-0"	7'-0"	Wood	PT-2	SF-3	Wood	PT-2		Set 3	Yes	
D3306B	NL	3'-0"	7'-0"	Wood	PT-2	1	HM	PT-2		Set 4	Yes	FIRE RATED - SMOKE RATED
D3307	FG	3'-0"	7'-0"	Wood	PT-2	SF-3	Wood	PT-2		Set 3	Yes	
D3309	Exist.	3'-0"	7'-0"	Exist.	PT-2	Exist.	Exist.	PT-2		Exist.	Yes	
D3310	FG	3'-0"	7'-0"	Wood	PT-2	SF-3	Wood	PT-2		Set 3	Yes	
D3312	Exist.	3'-0"	7'-0"	Exist.	PT-2	Exist.	Exist.	PT-2		Exist.	Yes	
D3313	FG	3'-0"	7'-0"	Wood	PT-2	SF-3	Wood	PT-2		Set 3	Yes	
D3315	FG	3'-0"	7'-0"	Wood	PT-2	SF-3	Wood	PT-2		Set 3	Yes	
D3317	Exist.	3'-0"	7'-0"	Exist.	PT-2	Exist.	Exist.	PT-2		Exist.	Yes	INSTALL NEW LITE KIT IN EXISTING DOOR. MATCH DOOR "FG"
D3317A	Exist.	3'-0"	7'-0"	Exist.	PT-2	Exist.	Exist.	PT-2		Exist.		
D3317B	Exist.	3'-0"	7'-0"	Exist.	PT-2	Exist.	Exist.	PT-2		Exist.		
D3317C	BF	4'-0"	6'-8"	Wood	PT-2	-	Wood	PT-2		-		FLAT SHAKER BIFOLD DOORS ON TRACK W/INTEGRAL HDWE. VERIFY EXISTING OPENING
D3318	Exist.	3'-0"	7'-0"	Exist.	PT-2	Exist.	Exist.	PT-2		Exist.	Yes	
D3319	Exist.	3'-0"	7'-0"	Exist.	PT-2	Exist.	Exist.	PT-2		Exist.	Yes	
D3319A	FG	3'-0"	7'-0"	AL/GL	DARK BRONZE	SF-1	AL	DARK BRONZE		Set 3	Yes	
D3319B	Exist.	3'-0"	7'-0"	AL/GL	DARK BRONZE	SF-2	AL	DARK BRONZE		Set 3	Yes	
D3319C	Exist.	3'-0"	7'-0"	Exist.	PT-2	Exist.	Exist.	PT-2		Exist.	Yes	
D3321	Exist.	3'-0"	7'-0"	Exist.	PT-2	Exist.	Exist.	PT-2		Exist.	Yes	
D3322	Exist.	3'-0"	7'-0"	Exist.	PT-2	Exist.	Exist.	PT-2		Exist.	Yes	
D3323	Exist.	3'-0"	7'-0"	Exist.	PT-2	Exist.	Exist.	PT-2		Exist.	Yes	
D3324	Exist.	3'-0"	7'-0"	Exist.	PT-2	Exist.	Exist.	PT-2		Exist.	Yes	
D3325	Exist.	3'-0"	7'-0"	Exist.	PT-2	Exist.	Exist.	PT-2		Exist.	Yes	
D3326	Exist.	3'-0"	7'-0"	Exist.	PT-2	Exist.	Exist.	PT-2		Exist.	Yes	
D3327	Exist.	3'-0"										

4 HM Frame Head - G.W.B.

$$4 \overline{) 3'' = 1'-0''}$$

6 HM Frame Jamb - G.W.B.

$$3'' = 1'-0''$$

10 HM Frame Head - G.W.B. @Existing Wall

$$\overline{3'' = 1'-0''}$$

7 HM Frame Jamb - G.W.B. @Existing Wall

$$\overline{3'' = 1' - 0''}$$

5 Storefront Head Detail

$$3'' = 1'-0''$$

1. DOOR AND FRAME ASSEMBLIES SHALL COMPLY WITH REQUIREMENTS INDICATED IN THE DOOR AND FRAME SCHEDULE UNLESS OTHERWISE NOTED
2. THE "DOOR NUMBER" REFERS TO THE DOOR TAG FOR EACH DOOR OPENING AS INDICATED ON THE FLOOR PLANS
3. ALL GLASS INSTALLED IN DOORS AND FRAMES SHALL BE TEMPERED, SAFETY GLAZING
4. THE "DOOR PANEL TYPE" REFERS TO THE DOOR PANEL ASSEMBLY INDICATED BY THE "DOOR PANEL TYPE DIAGRAM"
5. THE "DOOR FRAME TYPE," "DOOR PANEL FINISH" AND "DOOR GLASS TYPE" INDICATE REQUIREMENTS FOR THE DOOR PANEL(S), AS DESCRIBED IN THE CORRESPONDING LEGENDS
6. DOOR THICKNESSES SHALL BE 1-3/4" (45MM), UON
7. THE "DOOR PANEL HEIGHT" INDICATES THE NOMINAL HEIGHT OF DOOR PANEL(S) IN THE ASSEMBLY, SHOWN IN INCHES
8. THE "DOOR FRAME TYPE" REFERS TO THE FRAME ASSEMBLY INDICATED BY THE "DOOR FRAME TYPE DIAGRAM". THE FRAME TYPE DIAGRAM REFERENCES HEAD, LAMB, MULLION, SILL DETAILS RELATED TO THE ASSEMBLY, UON
9. THE "DOOR FRAME TYPE," "DOOR FRAME FINISH" INDICATE REQUIREMENTS FOR THE FRAME ASSEMBLY, AS DESCRIBED IN THE CORRESPONDING LEGENDS
10. THE "FIRE RATING" IS THE FIRE RATING MINUTES OF THE ASSEMBLY, AS DESCRIBED IN THE CORRESPONDING LEGEND
11. THE "HARDWARE GROUP" INDICATES THE HARDWARE GROUP APPLICABLE TO THE DOOR-FRAME ASSEMBLY
12. DOOR FRAME INSTALLED 4" FROM FINISH FACE OF WALL TO RABBIT, UON
13. ALL FRAMES ARE TO BE "WRAP AROUND" STYLE TO FULLY CAPTURE FINISH UON. COORDINATION WITH OPENING REQUIREMENTS IN FIELD ACCORDINGLY WITH DOOR DETAILS AND NOMINAL DESIGNATIONS
14. NOT USED

AL	ALUMINUM
GL	GLASS - GLASS TYPE AS SCHEDULED
HM	HOLLOW METAL DOOR ASSEMBLY
HO	HOLD OPEN DOOR & FRAME ASSEMBLY
SS	STAINLESS STEEL
ST	STEEL
WD	SOLID CORE WOOD
FB	FIBERGLASS

PT	PAINT
FA	FACTORY FINISH
AL	ALUMINUM

HM	HOLLOW METAL ASSEMBLY
WD	WOOD

GL-1	1/4" CLEAR, TEMPERED
GL-FR	1/4" CLEAR, TEMPERED, RATED

SEE 088000 SPECIFICATION FOR MORE INFORMATION ON GLAZING CONSTRUCTION

-	NO RATING
20	20 MIN RATED DOOR, GLASS AND FRAME ASSEMBLY AS SCHEDULED
45	45 MIN RATED GLASS AND FRAME ASSEMBLY AS SCHEDULED
	NOTE THAT DOOR IN THIS ASSEMBLY SHALL BE 20 MIN RATED UON
60	60 MIN RATED DOOR, GLASS AND FRAME ASSEMBLY AS SCHEDULED
90	90 MIN RATED DOOR, GLASS AND FRAME ASSEMBLY AS SCHEDULED
180	180 MIN RATED DOOR AND FRAME ASSEMBLY AS SCHEDULED

A. ACCESSIBILITY COMPLIANCE: SIGNS ARE REQUIRED TO COMPLY WITH ADA STANDARDS AND ICC A117.1, UNLESS OTHERWISE INDICATED; IN THE EVENT OF CONFLICTING REQUIREMENTS, COMPLY WITH THE MOST COMPREHENSIVE AND SPECIFIC REQUIREMENTS.

B. ROOM AND DOOR SIGNS: PROVIDE A SIGN FOR EVERY DOORWAY, WHETHER IT HAS A DOOR OR NOT, NOT INCLUDING CORRIDORS, LOBBIES, AND SIMILAR OPEN AREAS.

1. SIGN TYPE: FLAT SIGNS WITH ENGRAVED PANEL MEDIA AS SPECIFIED
2. PROVIDE "TACTILE" SIGNAGE, WITH LETTERS RAISED MINIMUM 1/32IN AND GRADE II BRAILLE.
3. CHARACTER HEIGHT: 1 INCH
4. SIGN HEIGHT: SEE DRAWINGS FOR DIMENSIONS.
5. POSITION: OPPOSITE HINGE SIDE.

BASIS OF DESIGN: BESTSIGNS

Seal:

ALW

Architects Lewis + Whitlock
206 West Virginia St.
Tallahassee, Florida 32301
850.942.1718
www.think3d.net

Description:
Door Schedules &
Elevations

Sheet No.:

A7.1

A8.1


Architectural floor plan of the second floor of a building, showing various rooms and their specifications. The plan includes rooms such as D3300, D3300A, D3309, D3312, D3319A, D3319B, D3319, D3317A, D3310, D3313, D3315, and D3317. Each room contains a list of items and materials, including ACT, PT, CPT, WB, and EXIST. The plan also shows existing wood panels, environmental graphics, and case work. The layout is divided into sections by walls and doors, with a central corridor area. The plan is oriented with North at the top.

Room Specifications:

- D3300:** EXIST, PT-1, CPT-1, WB-1
- D3300A:** EXIST, PT-1, CPT-1, WB-1
- D3309:** ACT-1, PT-1, CPT-1, WB-1
- D3312:** ACT-2, PT-3, CPT-1, WB-1
- D3319A:** ACT-1, PT-1, CPT-1, WB-1
- D3319B:** ACT-1, PT-1, CPT-1, WB-1
- D3319:** ACT-1, PT-1, FL-1, WB-1
- D3317A:** EXIST, PT-1/TL-3, TL-1, WB-2, EXIST, PT-1/TL-3, TL-1/2, WB-2/AL
- D3310:** ACT-2, PT-1, CPT-1, WB-1
- D3313:** ACT-2, PT-1, CPT-1, WB-1
- D3315:** ACT-2, PT-1, CPT-1, WB-1
- D3317:** ACT-2, PT-1, CPT-1, EXIST
- D3300C:** ACT-1, PT-1, FL-1, WB-1

Other Labels:

- ENVIRONMENTAL GRAPHIC IS OWNER PROVIDED, CONTRACTOR INSTALLED. IF ENVIRONMENTAL GRAPHIC IS NOT PROVIDED, WALLS TO RECEIVE PAINT.
- PROVIDE LINEAR LIGHT FIXTURES AT VERTICAL ELEMENTS - SEE ELECT.
- EXISTING WOOD PANELS
- EXISTING WOOD PANELS
- EXISTING CASEWORK AND MOLDING TO RECEIVE PT-2
- PT-3
- PT-2
- WC-1
- WC-2

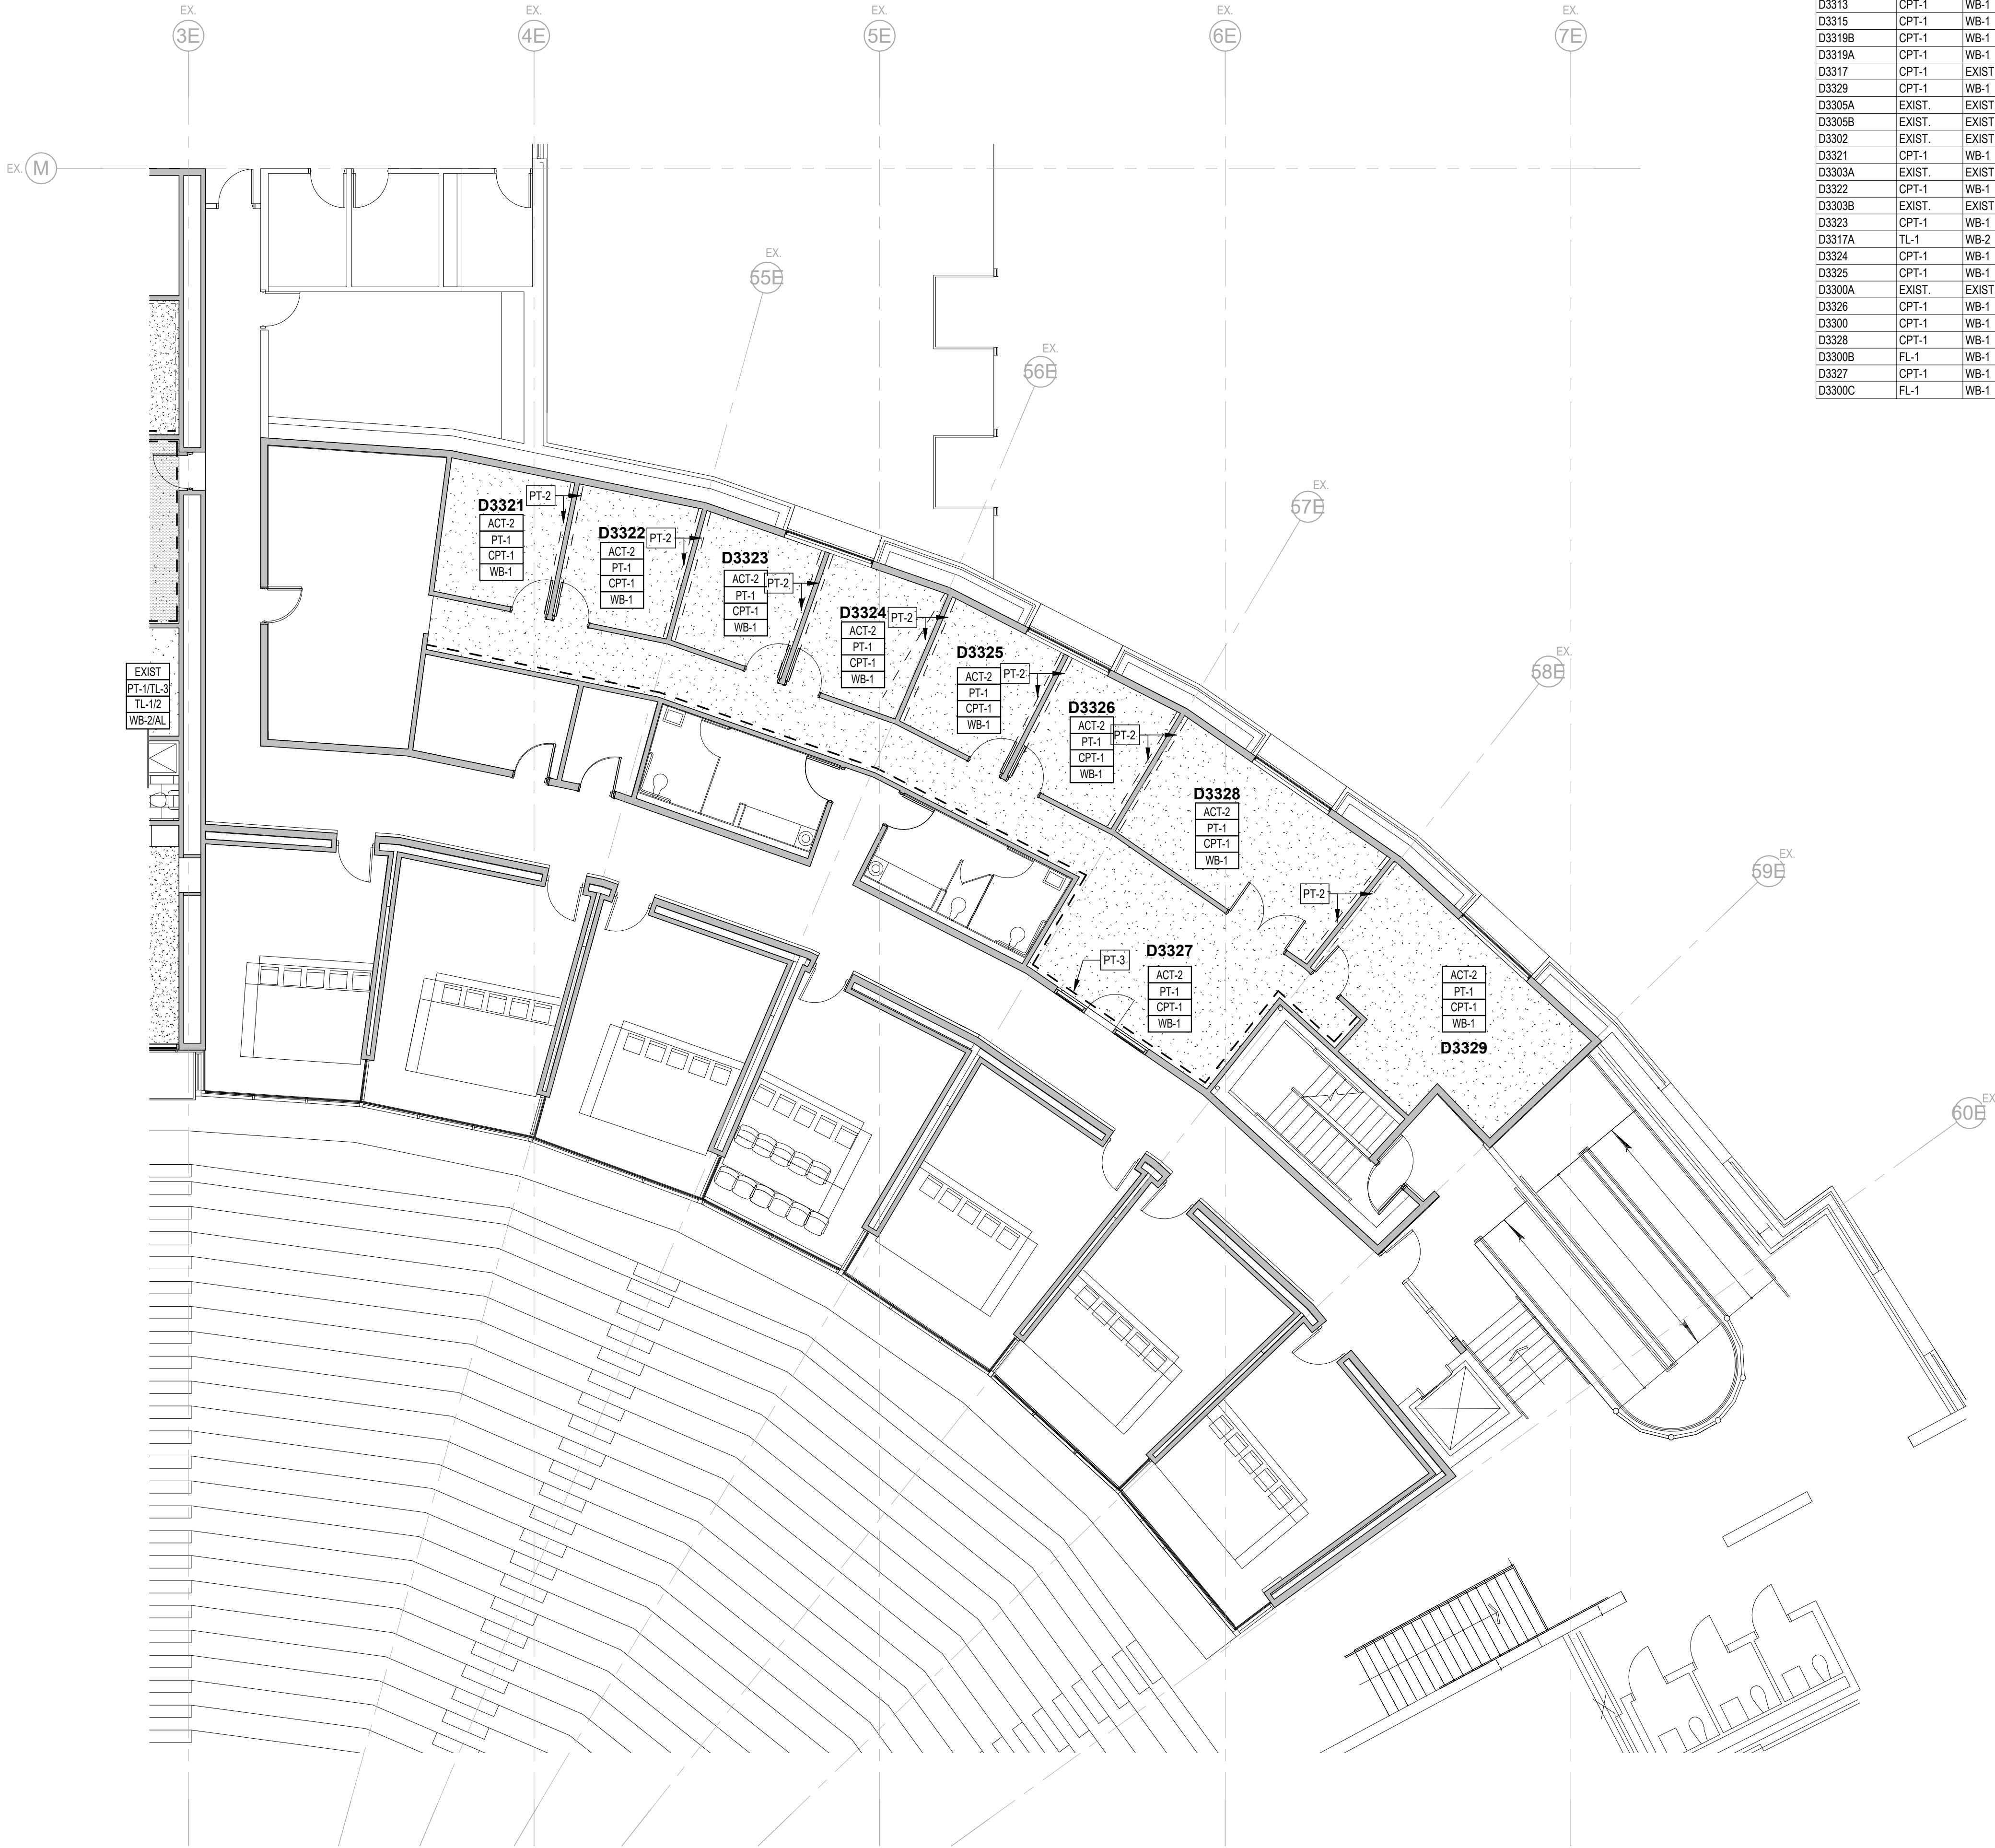

FINISH SCHEDULE

ROOM NAME	FLOOR		WALLS	CEILING		REMARKS
	FLOOR	BASE	FINISH	MAT'L	FINISH	
D3305	CPT-2	EXIST.	PT-1	GYP	C-1	Existing Wall Base to Receive PT -2
D3319	FL-1	WB-1	PT-1	ACT	ACT-1	
D3312	CPT-1	WB-1	PT-3	ACT	ACT-2	
D3309	CPT-1	WB-1	PT-1	ACT	ACT-1	
Room	TL-1/2	WB-2/AL	PT-1/TL-3		EXIST	
D3307	CPT-1	WB-1	PT-1	ACT	ACT-2	
D3306	CPT-1	WB-1	PT-1	ACT	ACT-2	
D3310	CPT-1	WB-1	PT-1	ACT	ACT-2	
D3313	CPT-1	WB-1	PT-1	ACT	ACT-2	
D3315	CPT-1	WB-1	PT-1	ACT	ACT-2	
D3319B	CPT-1	WB-1	PT-1	ACT	ACT-1	
D3319A	CPT-1	WB-1	PT-1	ACT	ACT-1	
D3317	CPT-1	EXIST	PT-1	ACT	ACT-2	
D3329	CPT-1	WB-1	PT-1	ACT	ACT-2	
D3305A	EXIST.	EXIST.	PT-2	ACT	EXIST.	
D3305B	EXIST.	EXIST.	PT-1	GYP	EXIST.	
D3302	EXIST.	EXIST.	PT-1	ACT	EXIST.	
D3321	CPT-1	WB-1	PT-1	ACT	ACT-2	
D3303A	EXIST.	EXIST.	PT-1	ACT	EXIST.	
D3322	CPT-1	WB-1	PT-1	ACT	ACT-2	
D3303B	EXIST.	EXIST.	PT-1	ACT	EXIST.	
D3323	CPT-1	WB-1	PT-1	ACT	ACT-2	
D3317A	TL-1	WB-2	PT-1/TL-3	GYP	EXIST.	
D3324	CPT-1	WB-1	PT-1	ACT	ACT-2	
D3325	CPT-1	WB-1	PT-1	ACT	ACT-2	
D3300A	EXIST.	EXIST.	PT-1	ACT	EXIST.	
D3326	CPT-1	WB-1	PT-1	ACT	ACT-2	
D3300	CPT-1	WB-1	PT-1	ACT	EXIST.	
D3328	CPT-1	WB-1	PT-1	ACT	ACT-2	
D3300B	FL-1	WB-1	PT-1	ACT	ACT-1	
D3327	CPT-1	WB-1	PT-1	ACT	ACT-2	
D3300C	FL-1	WB-1	PT-1	ACT	ACT-1	

GENERAL NOTES - FINISH PLAN

- ALL FLOOR FINISH TRANSITIONS TO OCCUR AT CENTERLINE OF DOOR UNLESS OTHERWISE NOTED.
- VERIFY LOCATIONS OF ALL APPLIED WALL MATERIALS ON ELEVATIONS. WHERE MORE THAN ONE FINISH IS USED WITHIN A ROOM, THE PREDOMINANT FINISH(ES) ARE INDICATED IN THE ROOM TAG AND SPECIAL TREATMENTS ARE NOTED ON THE PLAN & ELEVATIONS.
- ALL GYPSUM BOARD WALLS TO RECEIVE PAINT WITH EGGSHELL FINISH, UNLESS OTHERWISE NOTED. SEMI-GLOSS TO BE USED IN "WET" LOCATIONS SUCH AS LAUNDRY, FOOD PREP, RESTROOMS, DRINKING FOUNTAINS, ETC.
- ALL RESTROOM CEILINGS TO BE EPOXY PAINT EP-1.
- PAINT ALL EXISTING-TO-REMAIND WOOD AND HM DOORS WITHIN PROJECT BOUNDARY PT-2.
- ALL TRIM AND HOLLOW METAL DOOR FRAMES TO BE PAINTED SAME COLOR AS ADJACENT DOOR IN SEMI-GLOSS FINISH.
- PAINT ALL BUILDING ELEMENTS MOUNTED IN INTERIOR PARTITIONS TO MATCH WALL FINISH. ALL ELEMENTS MOUNTED IN WOOD OR OTHER SPECIALTY FINISHES SHALL BE PAINTED TO MATCH WOOD UNLESS OTHERWISE NOTED. PAINTED BUILDING ELEMENTS INCLUDE ACCESS PANELS, DIFFUSERS, GRILLES, AND SPEAKERS.

FLOOR FINISH LEGEND

- EXISTING TILE
- CARPET TILE (CPT-1)
- CARPET TILE - AREA RUG (CPT-2)
- CARPET TILE (CPT-3)

FINISH TAG KEY

- *REFER TO FINISH PLANS AND ELEVATIONS FOR ACCENT FINISH CALL-OUTS
- MATERIAL TRANSITION REFER TO FINISH SCHEDULE
- FINISH TAG WHERE MULTIPLE FINISHES ARE USED WITHIN A SPACE
- FLOORING DIRECTION INDICATOR

THESE DOCUMENTS AND ANY REVISIONS ARE THE PROPERTY OF ALW AND ASSOCIATES. NO PART OF THESE DOCUMENTS OR ANY INFORMATION CONTAINED HEREIN IS TO BE REPRODUCED OR TRANSMITTED IN ANY FORM OR BY ANY MEANS, ELECTRONIC OR MECHANICAL, INCLUDING PHOTOCOPYING, RECORDING, OR BY ANY INFORMATION STORAGE AND RETRIEVAL SYSTEM, WITHOUT THE WRITTEN PERMISSION OF ALW AND ASSOCIATES. THIS COPYRIGHT NOTIFICATION SHALL BE TRUE AND CORRECTLY PLACED ON ALL REVISIONS AND SHALL NOT BE REMOVED FROM THESE DOCUMENTS.		DATE:	
DRAWN:	REVIEWED:	DATE:	
REVISION:			
ID:			
DATE:	10-31-2025		
REVIEWED:	RL	11-14-2025	
DRAWN:	EE/AK		
PHASE:	50% CONSTRUCTION DOCUMENTS		
	100% CONSTRUCTION DOCUMENTS		
Client:	Florida State University	Job Title:	UCD - Third Floor Office Improvments Tallahassee, FL
Consultant:	Project #: 19370.69 Phase: 100% Construction Documents		

Seal:

ALW

Architects Lewis + Whitlock
206 West Virginia St.
Tallahassee, Florida 32301
850.942.1718
www.think3d.net

Description:
Third Floor Finish Plan - B

Sheet No.:

A9.1.B