


K:\Projects\23\23019\DWG\23019\23019_3_Beach_Club\Sheets\23019_3-A130.dwg Plotted: Nov 14, 2025 - 1:19pm by Caeblawrence

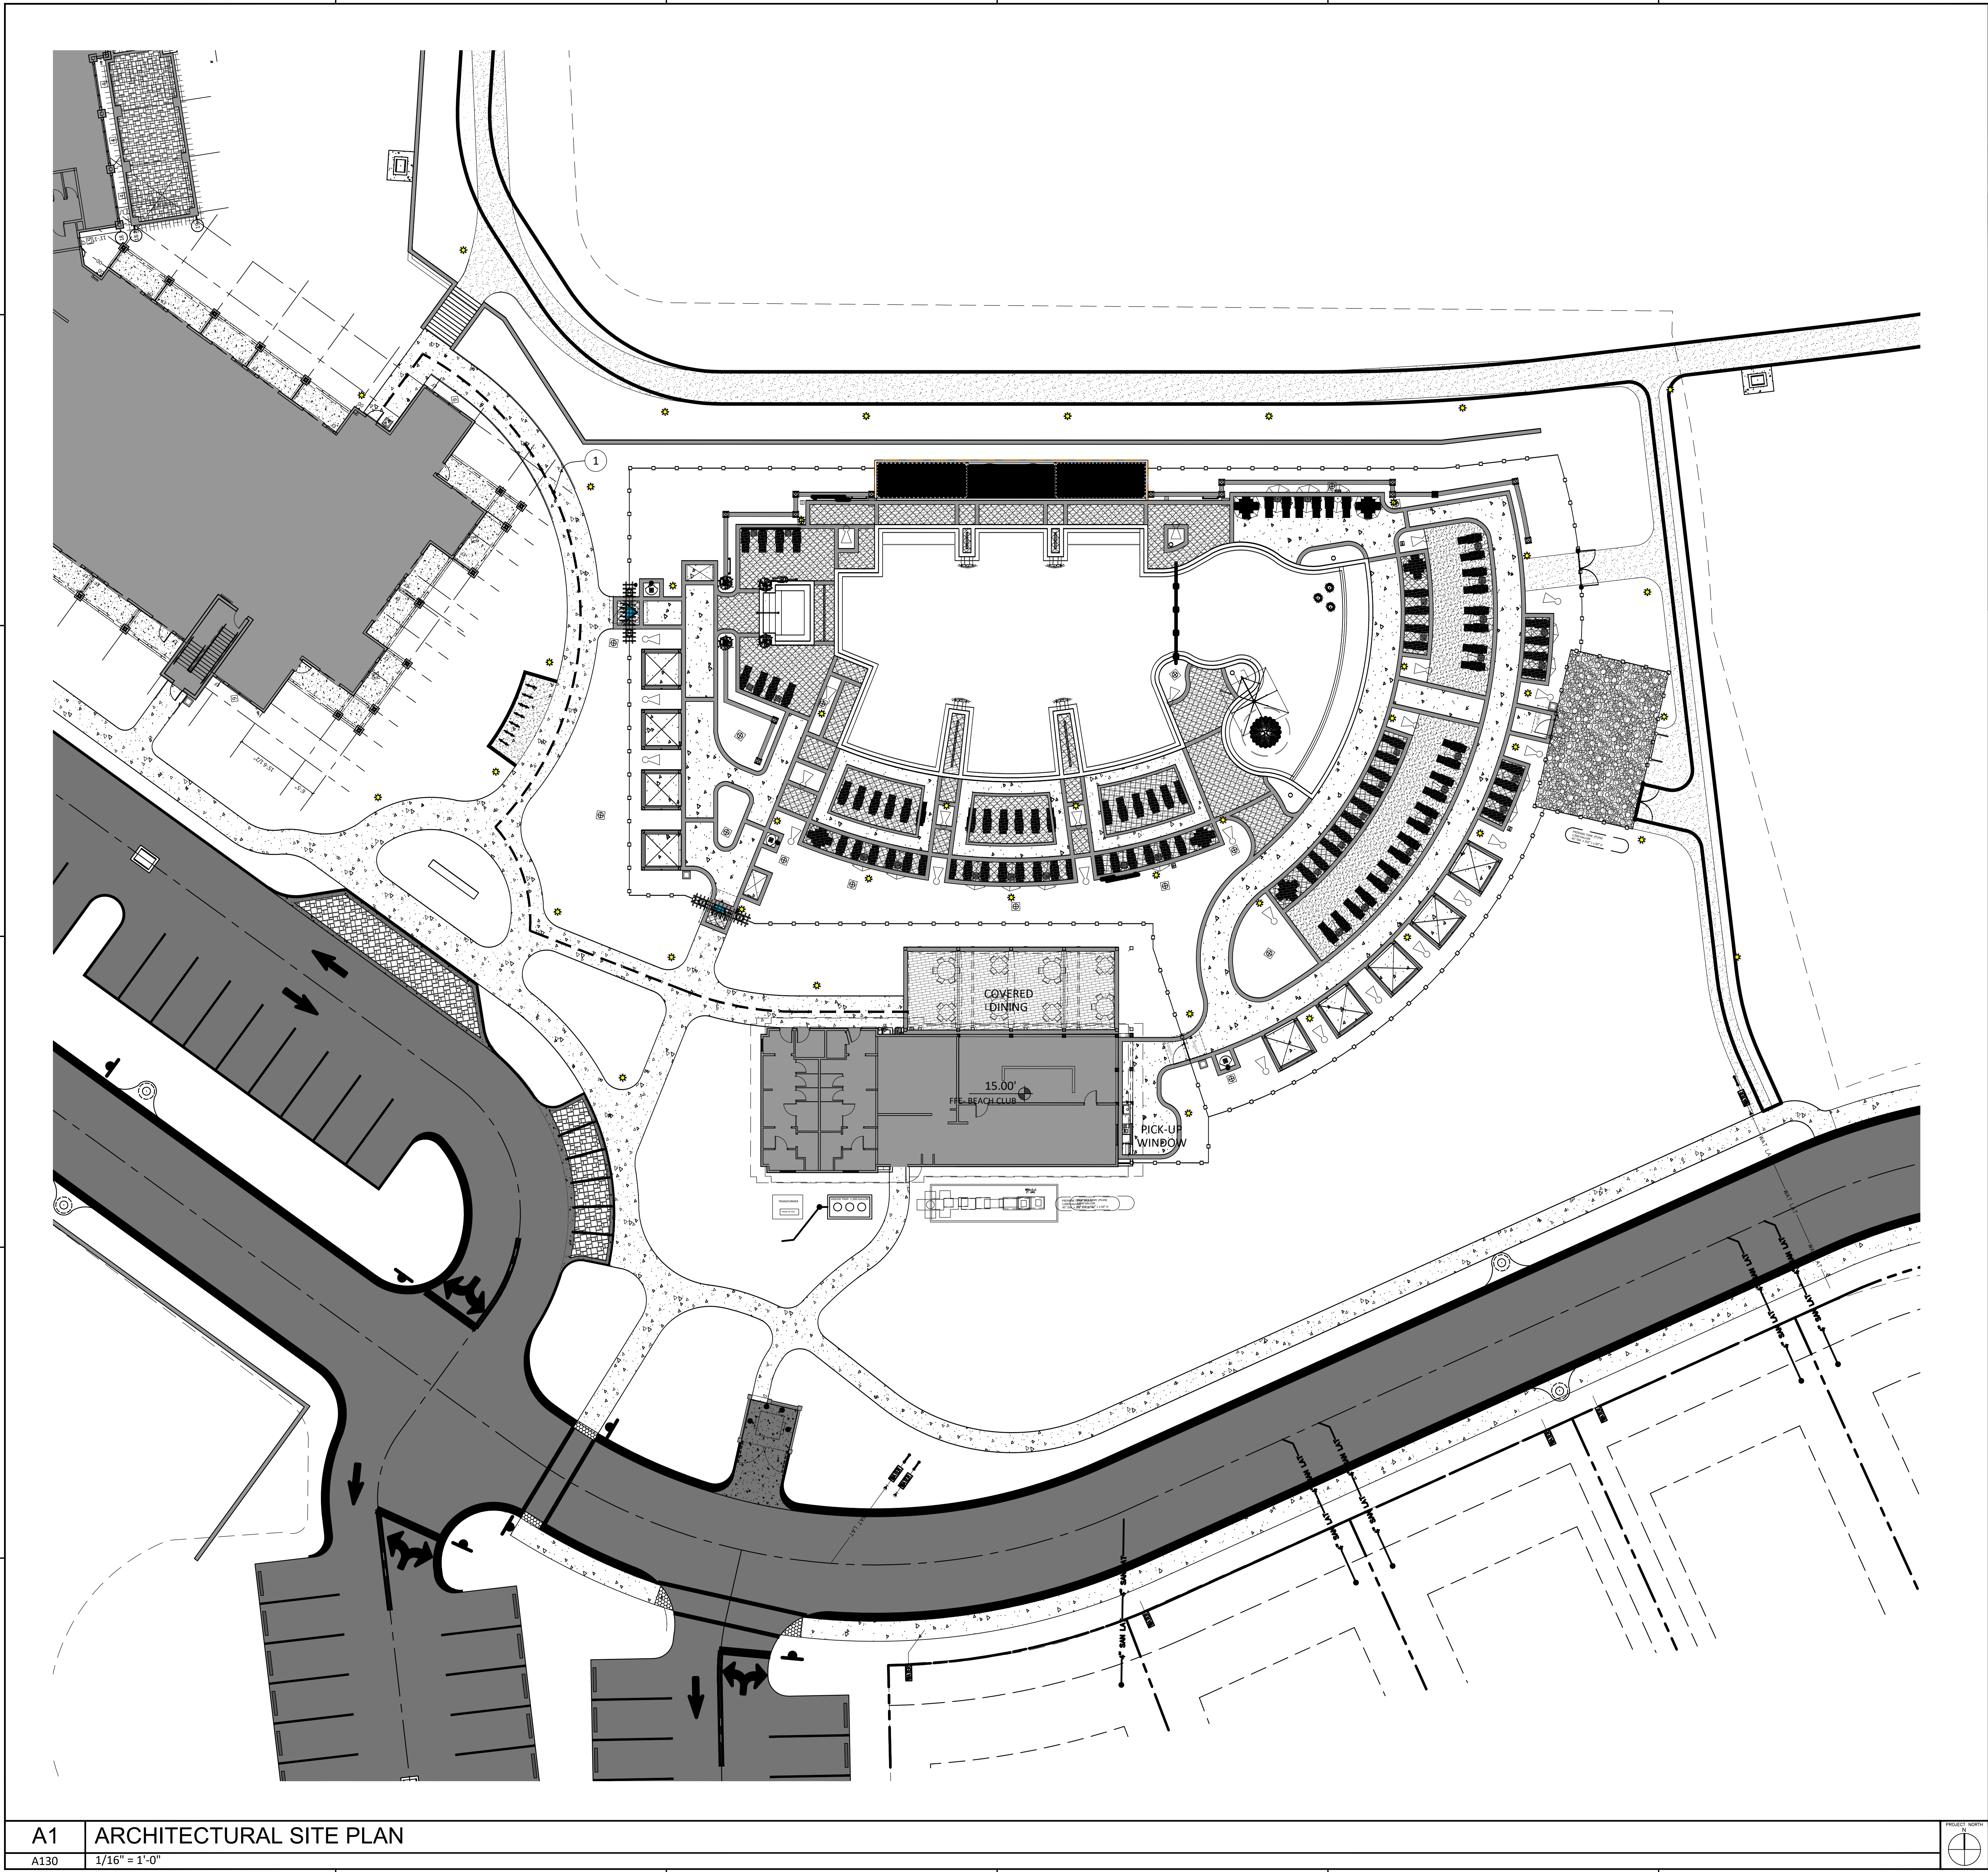

A1	ARCHITECTURAL SITE PLAN	PROJECT NORTH
A130	1/16" = 1'-0"	

SHEET NOTES / LEGEND

1. ACCESSIBLE ROUTE

GENERAL NOTES

A. -



730 PEACHTREE STREET, NE
STUDIO 325
ATLANTA, GEORGIA 30308
678.244.6270
www.KDCarchitects.com

ARCHITECT:

ARCH. REG: AR91344

CONSULTANT:

REVISIONS	
DATE:	DESCRIPTION:
10/18/24	SCHEMATIC DESIGN
7/24/25	DESIGN DEVELOPMENT
10/23/25	50% CONSTRUCTION DOCS
11/14/25	PERMIT SET

PROJECT:

SERENITY SEASIDE
RESORT

BUILDING #3
**BEACH
CLUB**

186 SOUTH BAY
SHORE DRIVE,
EASTPOINT, FL
32328

Serenity Seaside
Operations, LLC
174 Watercolor Way, PMB 410
Santa Rosa Beach, Florida 32459

JOB NUMBER: 23019.3


DATE: --/--/----

TITLE:
ARCHITECTURAL
SITE PLAN

SHEET:

A130

K:\Projects\23\23019\JMGS\Serenity Club Sheets\23019_3-A131.dwg Plotted: Nov 14, 2025 -- 1:19pm by CaeleLawrence

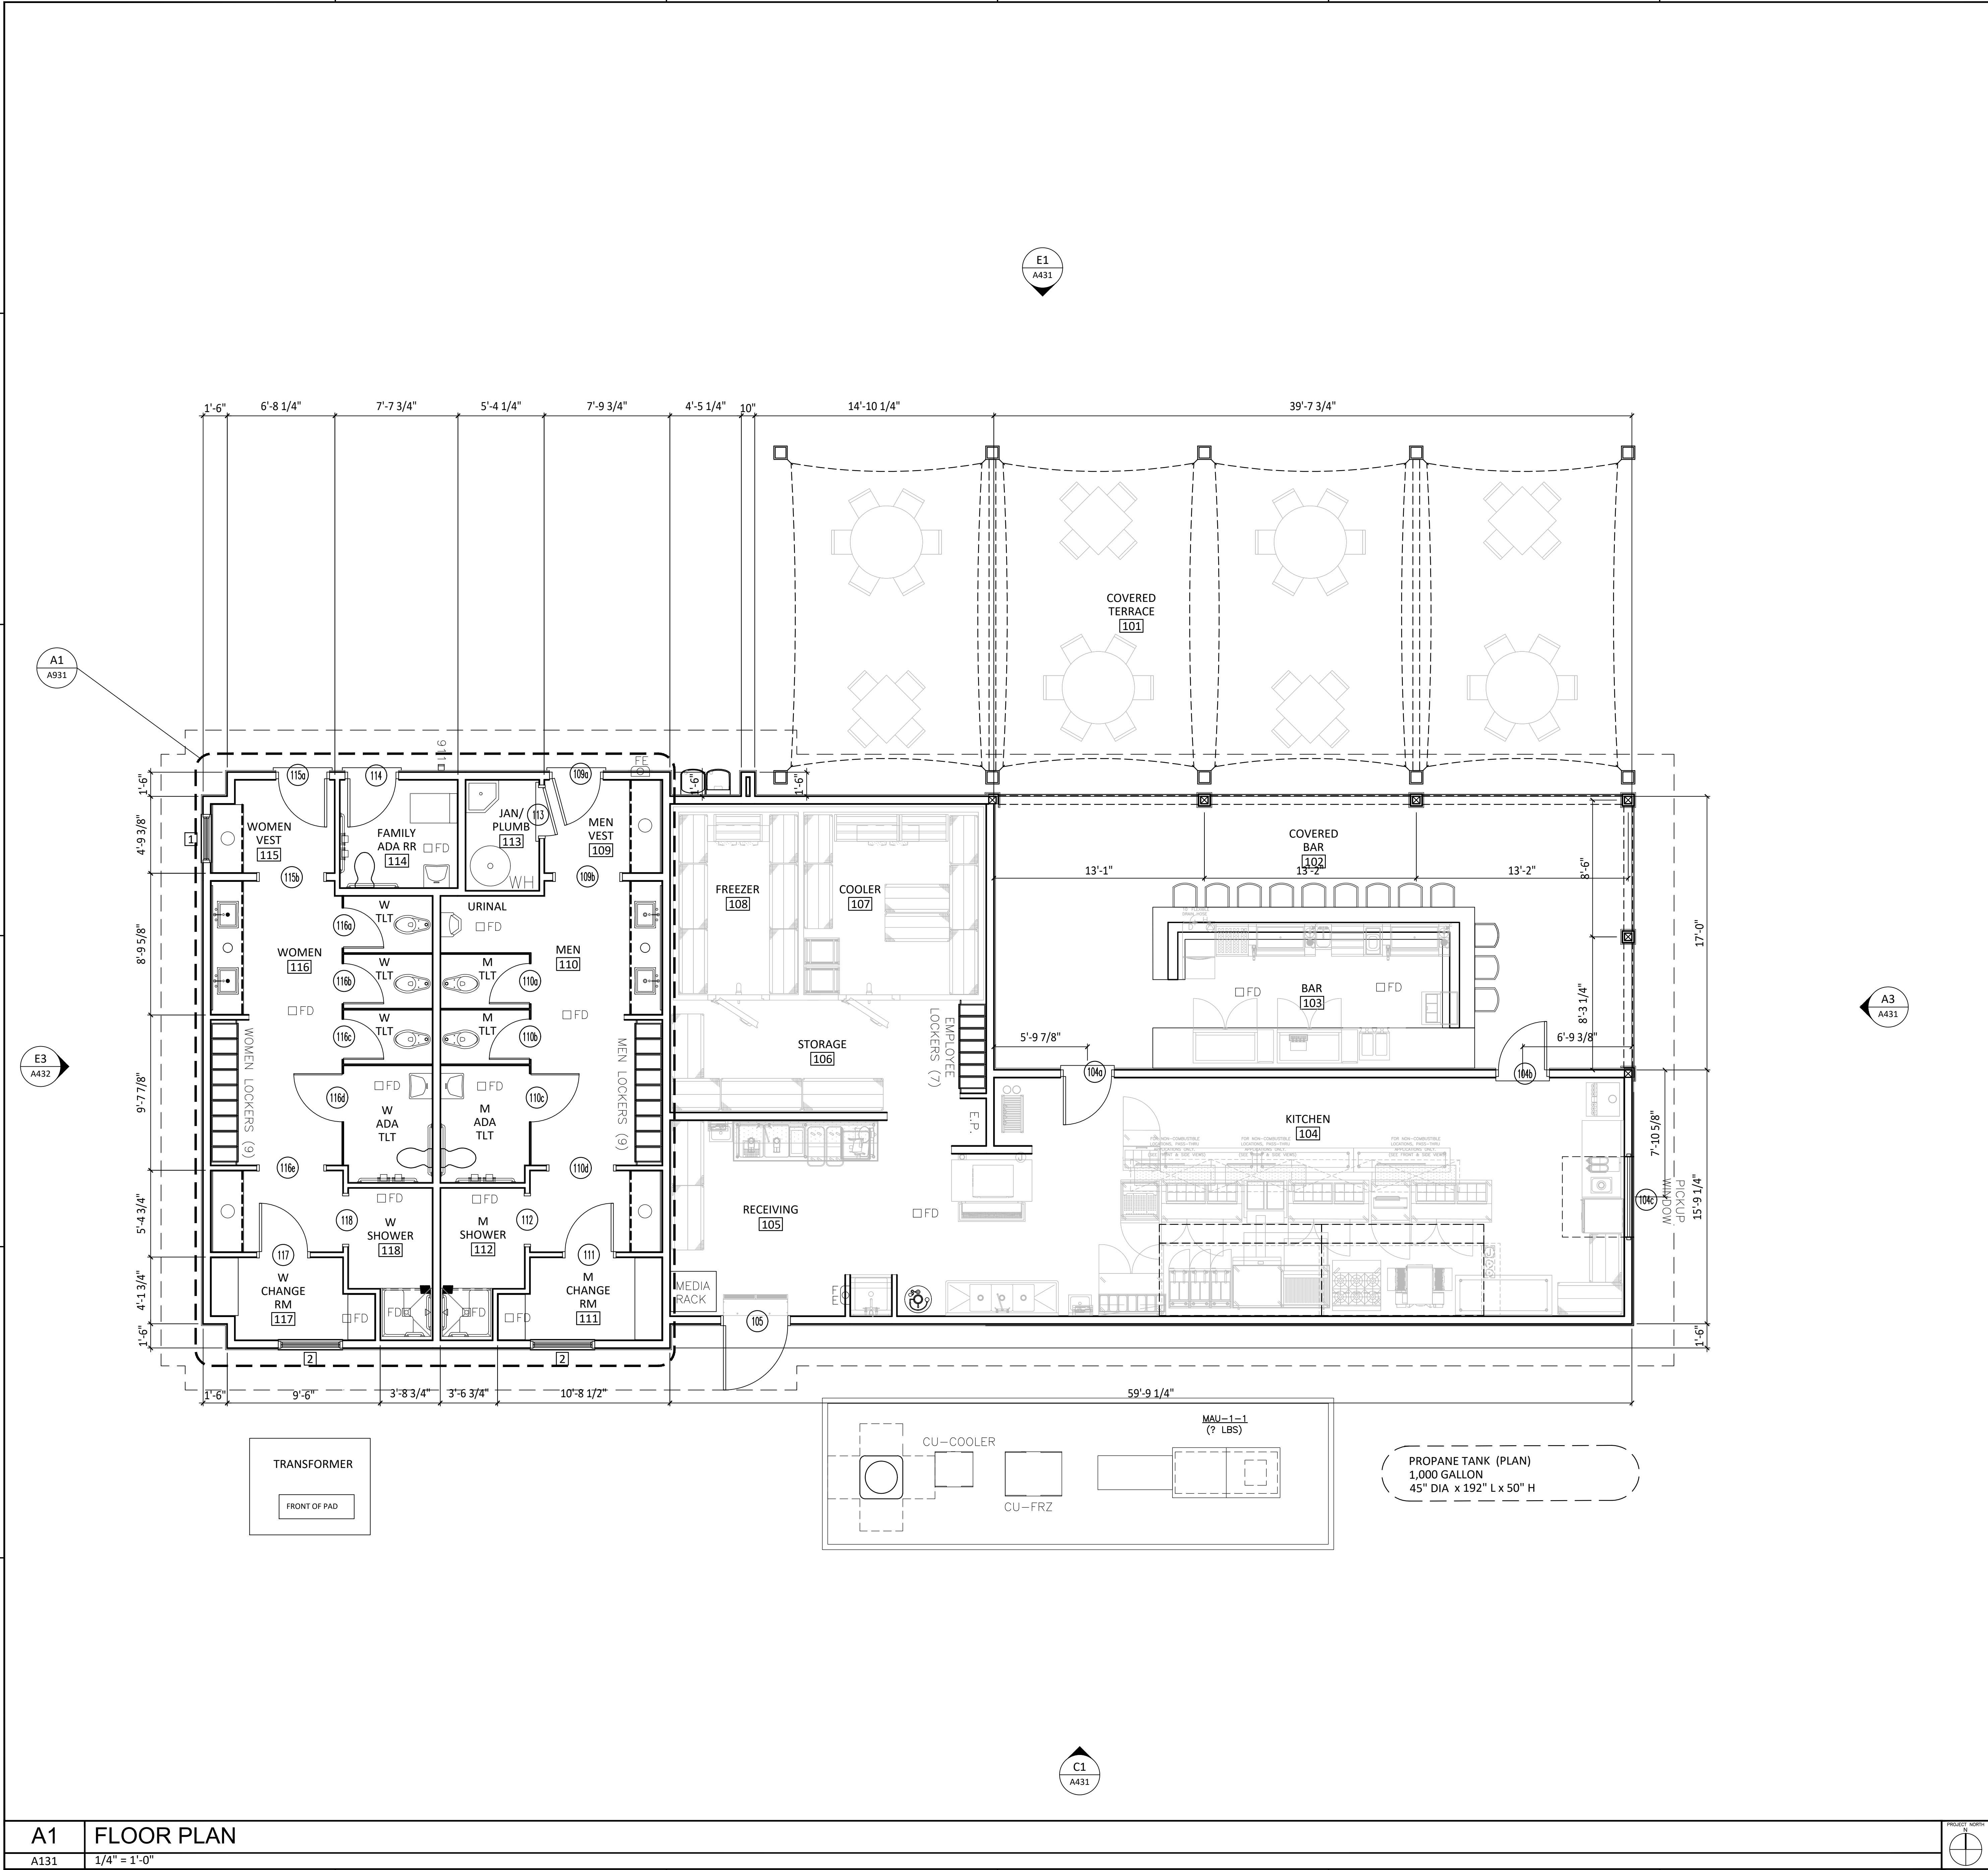

SHEET NOTES / LEGEND

1. STAINED CONCRETE

GENERAL NOTES

A. -

LEGEND

## DOOR / CASED OPENING	# WINDOW TAG
A# WALL PARTITION TAG	L# LOUVER TAG
#### ROOM NUMBER TAG	← SLOPE DIRECTION OF SLOPED FLOOR
## * EQUIPMENT TAG	LOCKERS - BY GC
Ⓢ GOLF CART CHARGER SEE DETAIL C1/A853	Ⓞ BD BOLLARD SEE DETAIL A2/A901
AD AREA DRAIN	EF EXHAUST FAN
CU CONDENSING UNIT	HB HOSE BIBB
EWG ELECTRIC WATER COLOR	TD TRENCH DRAIN
FE FIRE EXTINGUISHER	WH WATER HEATER
FD FLOOR DRAIN	DV DRYER VENT

GENERAL NOTES FOR FLOOR PLANS

A. INTERIOR PARTITION TYPES TO BE TYPE "A", U.N.O -SEE A72/A7851?

B. TOP-OF-PARTITION-DETAILS; SEE A73/A7852?

C. FIRE EXTINGUISHER-DETAILS; SEE A74/A7853?

D. ALL FURNITURE IS BY OWNER

E. REFER TO SHEETS G102 & G103 FOR ADA REQUIRED DIMENSIONS

F. TYP DOOR HINGE INSTALL DIMENSION @ PERPENDICULAR WALLS; SEE DETAIL C73/A7852?

G. DOOR SCHEDULES ON SHEETS A801 & A7802?

H. EQUIPMENT SCHEDULES; SEE DETAIL E2 A71001?

I. METAL LOCKERS BY GC

J. EMU CONTROL JOINTS; SEE DETAIL A71/A7852?

K. METAL STUD WALL FRAMING ADDITIONAL DETAILS ON SHEET A7853?

KEY PLAN

KUO DIEDRICH CHI

730 PEACHTREE STREET, NE
STUDIO 325
ATLANTA, GEORGIA 30308
678.244.6270
www.KDCarchitects.com

ARCHITECT:

ARCH. REG: AR91344

CONSULTANT:

REVISIONS

DATE:	DESCRIPTION:
10/18/24	SCHEMATIC DESIGN
7/24/25	DESIGN DEVELOPMENT
10/23/25	50% CONSTRUCTION DOCS
11/14/25	PERMIT SET

PROJECT: SERENITY SEASIDE RESORT

BUILDING #3 BEACH CLUB

186 SOUTH BAY SHORE DRIVE, EASTPOINT, FL 32328

Serenity Seaside Operations, LLC
174 Watercolor Way, PMB 410
Santa Rosa Beach, Florida 32459

JOB NUMBER: 23019.3

DATE: --/--/----

TITLE: FLOOR PLAN

SHEET: A131

SHEET NOTES / LEGEND

LEGEND

	[AT] ACOUSTIC CLG TILE : 24" x 24"		[GB] GYP. BD.
	[MD] ROOF MTL DECK, EXPOSED SLOPES		RATED CEILING (1-HOUR)
			RATED CEILING (2-HOUR)
	NO CEILING		[MS] METAL SOFFIT
	LINEAR AIR SUPPLY		CEILING HT. A.F.F./TYPE
	LINEAR AIR RETURN		ACCESS PANEL
	SQUARE AIR SUPPLY		OCCUPANCY SENSOR
	SQUARE AIR RETURN		AUDIO/VOICE ALARM
	UNIT HEATER- CEILING MTD.		SMOKE DETECTOR
	2 x 4 LIGHT		EXIT SIGN
	STRIP LIGHT		CEILING FAN
	PENDANT LIGHT		WIRELESS APPLICATION POINT (BY OWNER)
	SURFACE MOUNTED PENDANT		
	WALL MOUNT SCONCE		CAMERA (BY OWNER), GC PROVIDE SINGLE CAT6 & SINGLE GANG BOX
	RECESSED WALL WASHER		
	RECESSED DOWNLIGHT		SPEAKER CEILING MTD (BY OWNER)
	OPEN CEILING LIGHT		

GENERAL NOTES FOR REFLECTED CEILING PLANS

SEISMIC DETAILS FOR CEILINGS, SEE SHEETS A252, A253 & A254.

PROVIDE CEILING ACCESS DOORS IN GYP BD CEILINGS (& WALLS) AS REQUIRED BY MEP, SEE DETAIL E2/A251

FIRE RATED CEILING DETAILS, SEE SHEET A251

REFER TO ADDITIONAL CEILING NOTES ON SHEET G101


PROVIDE SOUND BATTS ABOVE CEILING OF ALL RESTROOMS & OFFICE SPACES

 KUO DIEDRICH CHI 730 PEACHTREE STREET, NE STUDIO 325 ATLANTA, GEORGIA 30308 678.244.6270 www.KDCarchitects.com	
ARCHITECT:	
ARCH. REG. AR91344	
CONSULTANT:	
REVISIONS	
DATE:	DESCRIPTION:
10/18/24	SCHEMATIC DESIGN
7/24/25	DESIGN DEVELOPMENT
10/23/25	50% CONSTRUCTION DOCS
11/14/25	PERMIT SET
PROJECT:	
SERENITY SEASIDE RESORT	
BUILDING #3 BEACH CLUB	
186 SOUTH BAY SHORE DRIVE, EASTPOINT, FL 32328	
Serenity Seaside Operations, LLC 174 Watercolor Way, PMB 410 Santa Rosa Beach, Florida 32459	
JOB NUMBER: 23019.3	
DATE: --/--/----	
TITLE: REFLECTED CEILING PLAN	
SHEET: A231	


[illegible]

KUO DIEDRICH CHI  730 PEACHTREE STREET, NE STUDIO 325 ATLANTA, GEORGIA 30308 678.244.6270 www.KDCarchitects.com	
ARCHITECT:	
ARCH. REG: AR91344	
CONSULTANT:	
REVISIONS	
DATE:	DESCRIPTION:
10/18/24	SCHEMATIC DESIGN
7/24/25	DESIGN DEVELOPMENT
10/23/25	50% CONSTRUCTION DOCS
11/14/25	PERMIT SET
PROJECT:	
SERENITY SEASIDE RESORT	
BUILDING #3 BEACH CLUB	
186 SOUTH BAY SHORE DRIVE, EASTPOINT, FL 32328	
Serenity Seaside Operations, LLC 174 Watercolor Way, PMB 410 Santa Rosa Beach, Florida 32459	
JOB NUMBER: 23019.3	
DATE: --/--/----	
TITLE: ROOF PLAN & ROOF DETAILS	
SHEET: A331	


	1	2	3	4	5	6	7
							SHEET NOTES / LEGEND
							1. -
							GENERAL NOTES
							A. -

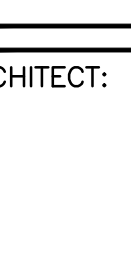 KUO DIEDRICH CHI 730 PEACHTREE STREET, NE STUDIO 325 ATLANTA, GEORGIA 30308 678.244.6270 www.KDCarchitects.com	
ARCHITECT:	
ARCH. REG. AR91344	
CONSULTANT:	
REVISIONS	
DATE:	DESCRIPTION:
10/18/24	SCHEMATIC DESIGN
7/24/25	DESIGN DEVELOPMENT
10/23/25	50% CONSTRUCTION DOCS
11/14/25	PERMIT SET
PROJECT:	
SERENITY SEASIDE RESORT	
BUILDING #3 BEACH CLUB	
186 SOUTH BAY SHORE DRIVE, EASTPOINT, FL 32328	
Serenity Seaside Operations, LLC 174 Watercolor Way, PMB 410 Santa Rosa Beach, Florida 32459	
JOB NUMBER:	23019.3
DATE:	--/--/----
TITLE:	ROOF DETAILS, SLOPED
SHEET:	
A332	


K:\Projects\23\23019\DWG\Serenity Club\Sheets\23019_3-A431.dwg Plotted: Nov 14, 2025 - 1:19pm by CalebLawrence

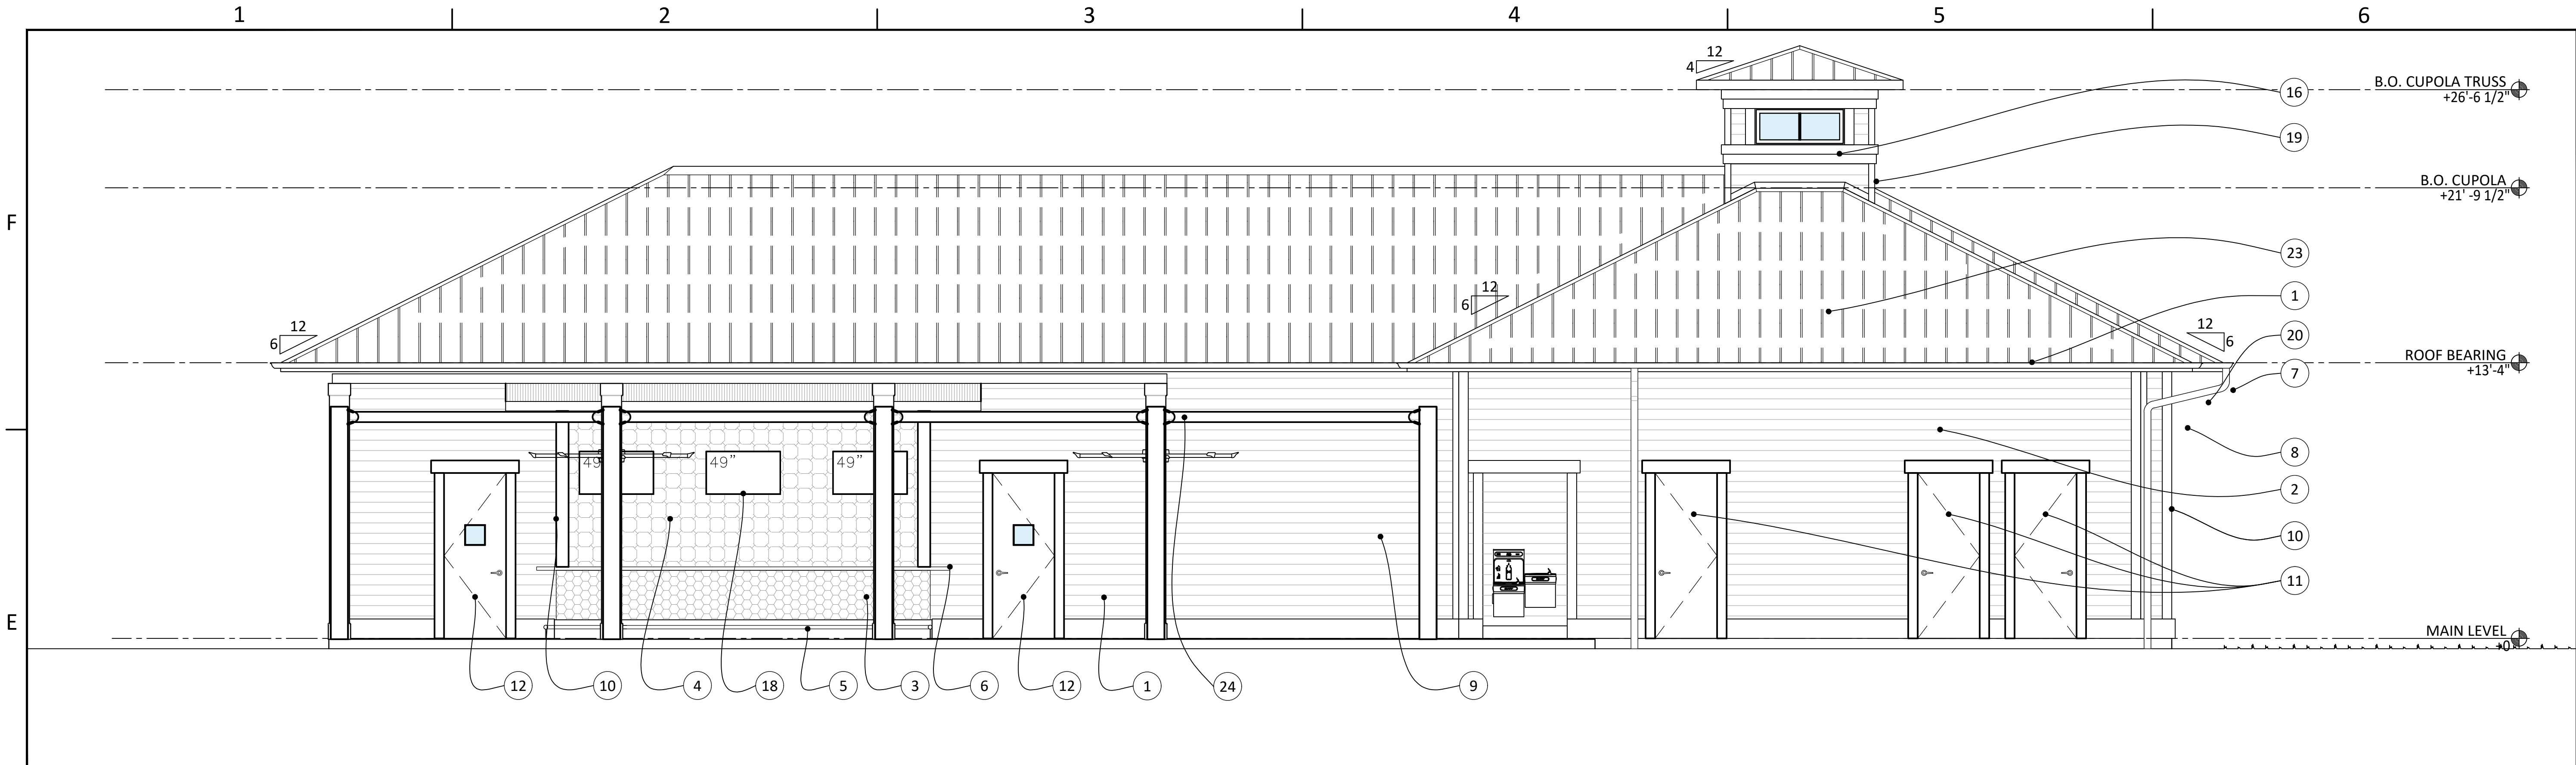

E1	EXTERIOR ELEVATION "SOUTH"
A431	1/4" = 1'-0"

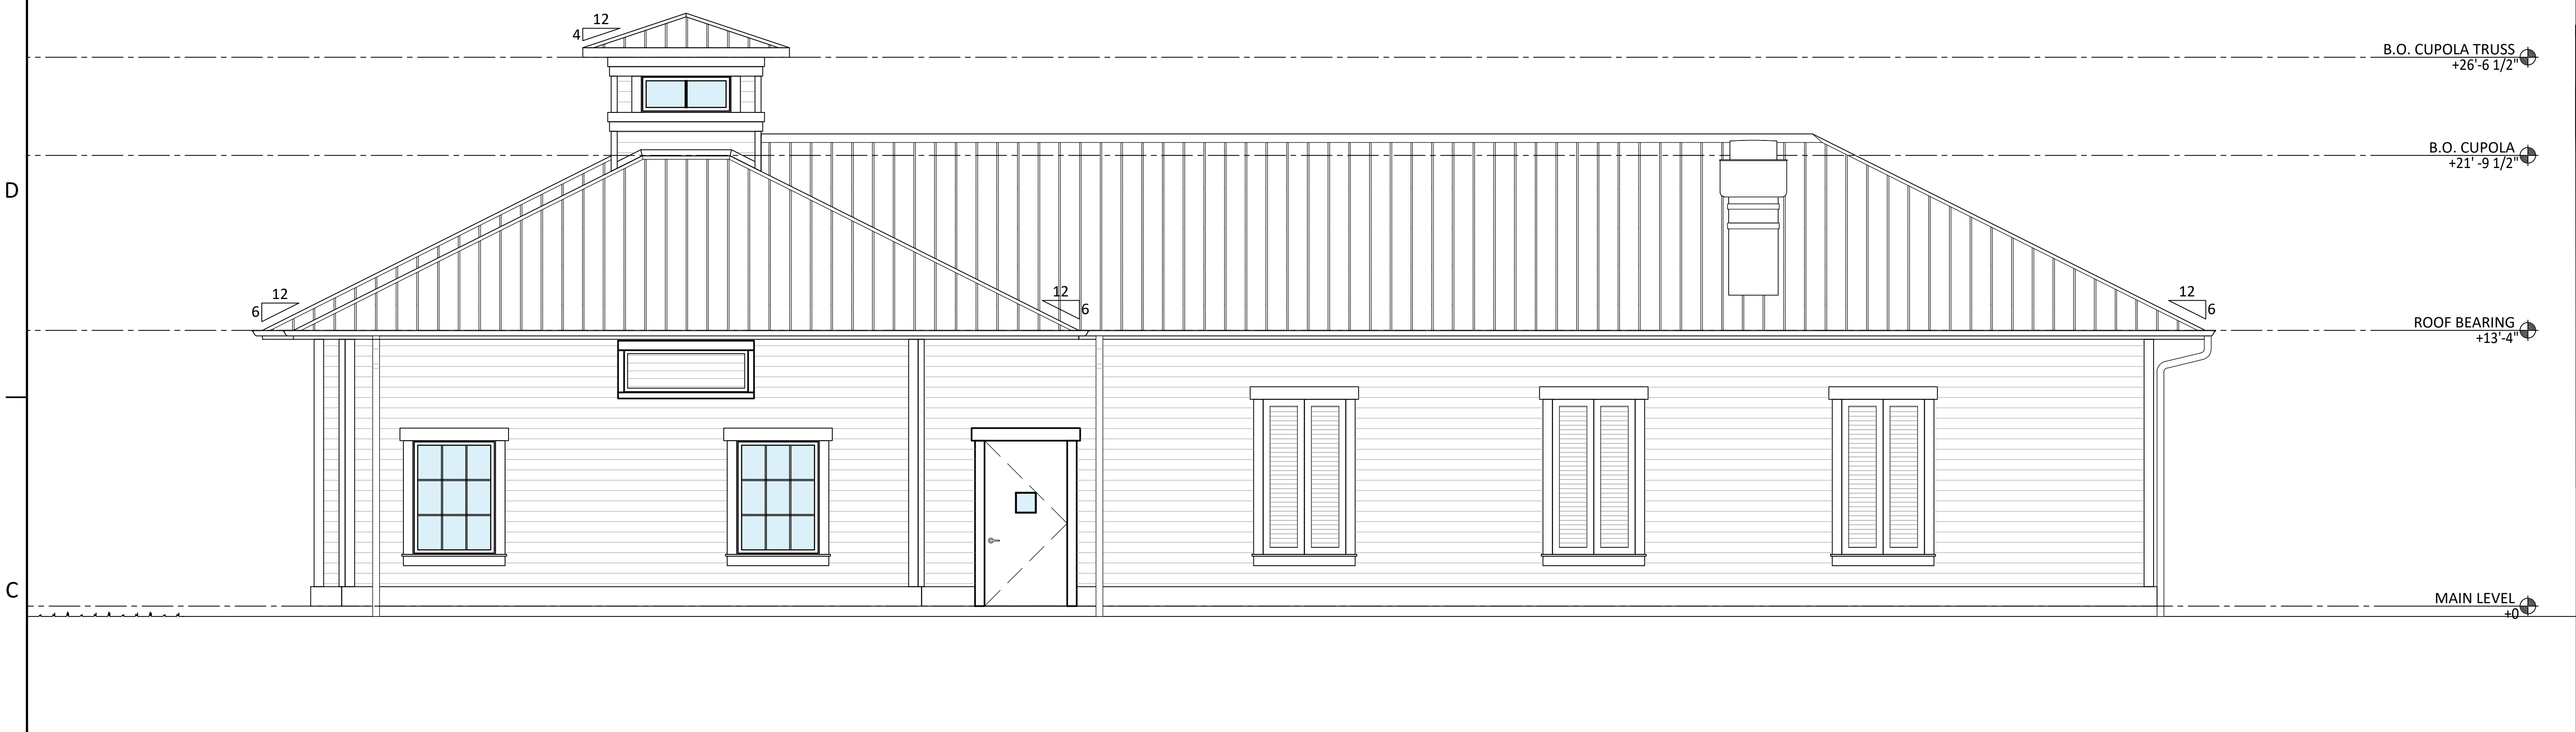

C1	EXTERIOR ELEVATION "NORTH"
A431	1/4" = 1'-0"

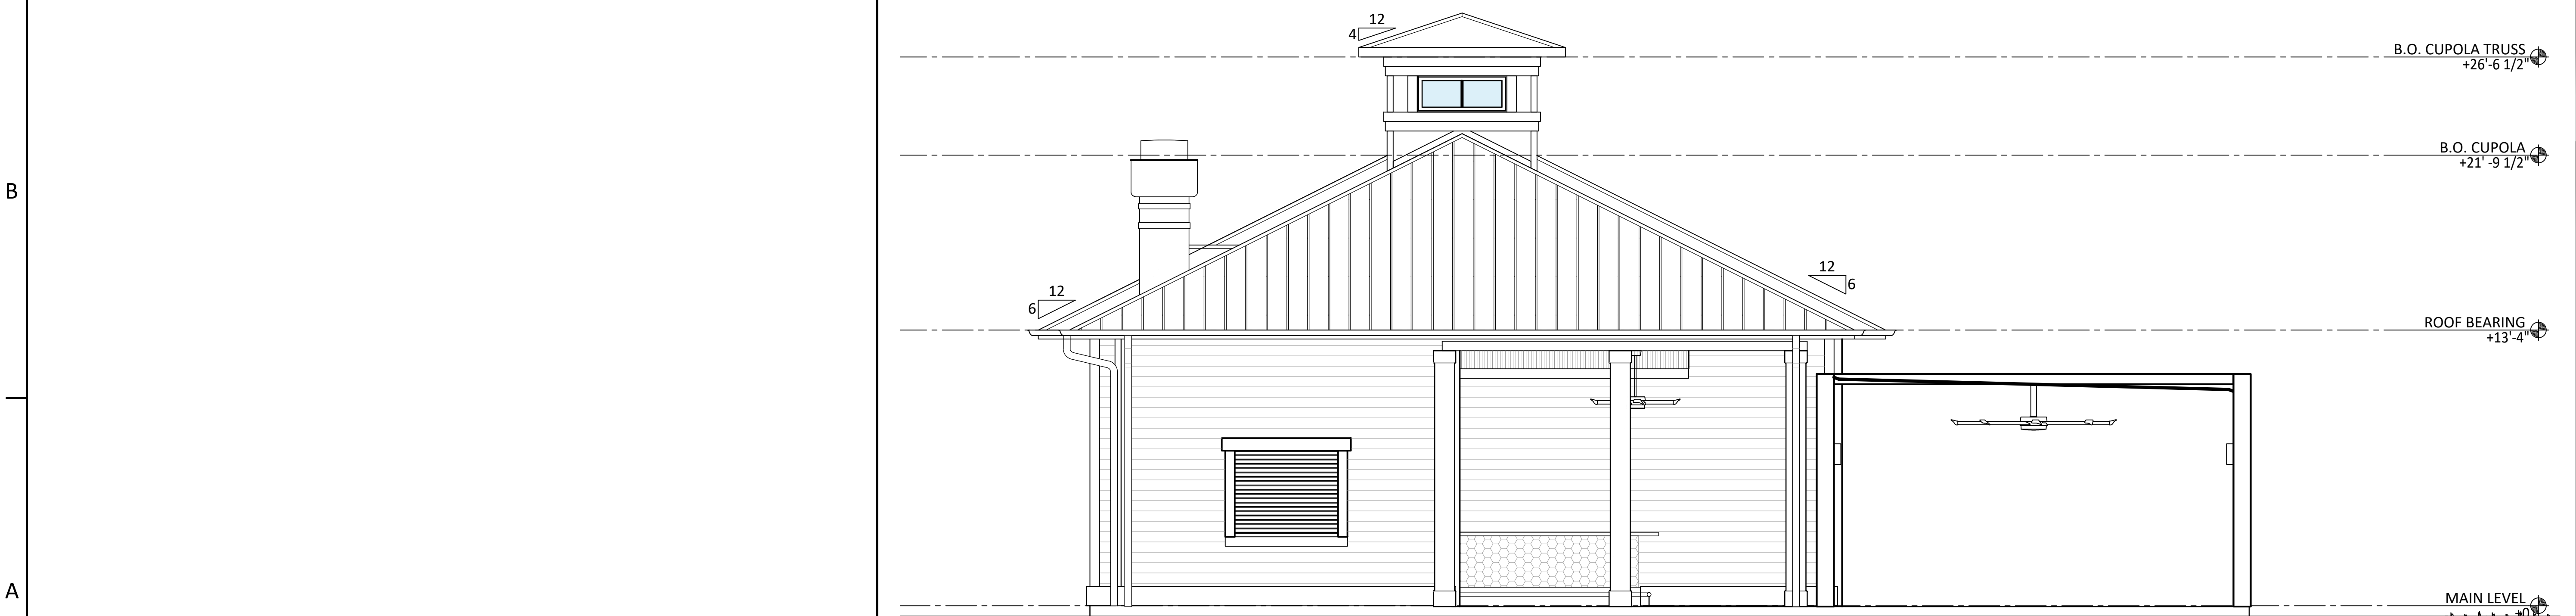

A3	EXTERIOR ELEVATION "WEST"
A431	1/8" = 1'-0"

SHEET NOTES / LEGEND


- STANDING SEAM METAL ROOF
- LAP BOARD SIDING
- FRONT BAR TILE
- BACK BAR CUSTOM FINISH
- BAR FOOT RAIL
- STONE COUNTERTOP
- ALUM GUTTER
- ALUM DOWNSPOUT
- WRAPPED COLUMN
- EXTERIOR FIBER CEMENT TRIM BOARD
- SINGLE HM DOOR, SEE SHEET A801
- SINGLE HM SERVICE DOOR W/ GLAZING, SEE SHEET A801
- DOUBLE HM SERVICE DOOR W/ GLAZING, SEE SHEET A801
- TYPE "W1" WINDOW, SEE SHEET A831
- TYPE "W2" WINDOW, SEE SHEET A831
- TYPE "W3" WINDOW, SEE SHEET A831
- PICK-UP COUNTER OPENING, SEE SHEET A831
- WALL MOUNTED TV (BY OWNER)
- CUPOLA TRIM
- DECORATIVE RAFTER TAILS
- DECORATIVE SHUTTER "L1", SEE SHEET A831
- DECORATIVE SHUTTER TRIM, SEE SHEET A831
- AIR INTAKE LOUVER
- COVERED TRELLIS STRUCTURE

GENERAL NOTES

- SEE EXTERIOR MATERIAL COLORS ON SHEET A???
- SEE ROOF PLANS ON SHEET A301 FOR EXTERIOR ELEVATION CALLOUTS
- SEE EXTERIOR GLAZING SCHEDULE ON SHEET A831

LEGEND

	SIDING (HORIZ) 6" W.		FRONT BAR WALL TILE
	METAL ROOFING, STANDING SEAM, 12" OC		CUSTOM BACK BAR
	GLAZING		

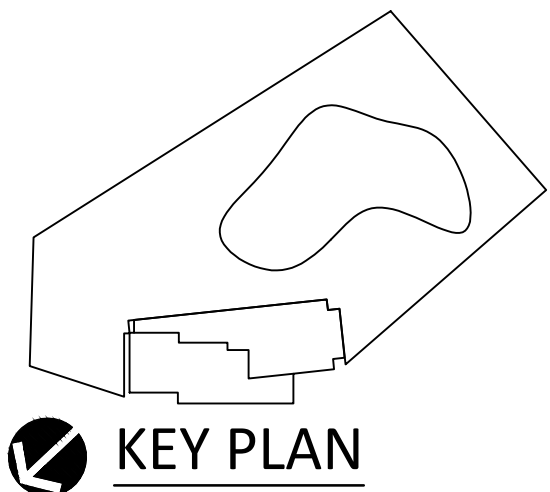

KEY PLAN

730 PEACHTREE STREET, NE
STUDIO 325
ATLANTA, GEORGIA 30308
678.244.6270
www.KDCarchitects.com

ARCHITECT:

ARCH. REG. AR91344

CONSULTANT:

REVISIONS

DATE:	DESCRIPTION:
10/18/24	SCHEMATIC DESIGN
7/24/25	DESIGN DEVELOPMENT
10/23/25	50% CONSTRUCTION DOCS
11/14/25	PERMIT SET

PROJECT:

SERENITY SEASIDE
RESORT

BUILDING #3
BEACH
CLUB

186 SOUTH BAY
SHORE DRIVE,
EASTPOINT, FL
32328

Serenity Seaside
Operations, LLC
174 Watercolor Way, PMB 410
Santa Rosa Beach, Florida 32459

JOB NUMBER: 23019.3


DATE: --/--/----

TITLE:
EXTERIOR
ELEVATIONS

SHEET:

A431

K:\Projects\23\23019\DWG\Serenity Club\Sheets\23019_3-A432.dwg Plotted: Nov 14, 2025 - 1:19pm by Caeblawrence

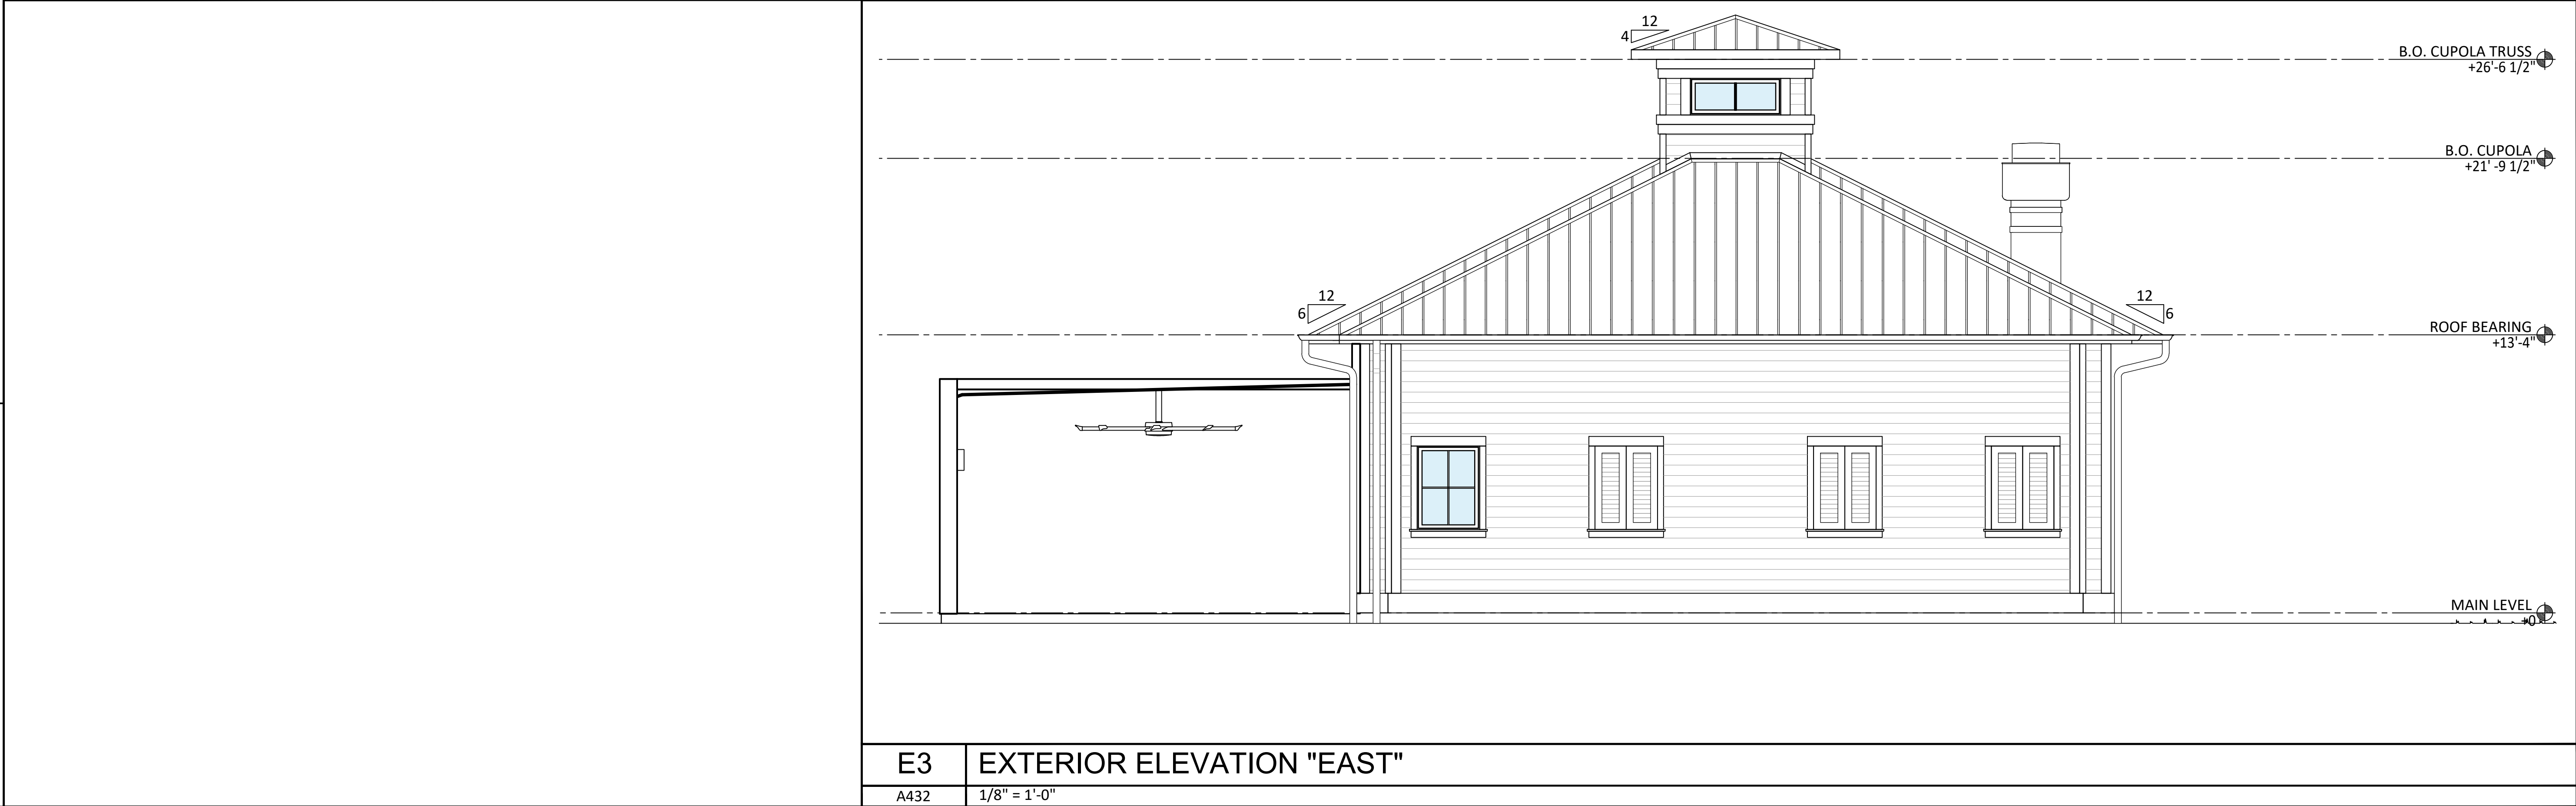

E3	EXTERIOR ELEVATION "EAST"
A432	1/8" = 1'-0"

SHEET NOTES / LEGEND


1. STANDING SEAM METAL ROOF
2. LAP BOARD SIDING
3. FRONT BAR TILE
4. BACK BAR CUSTOM FINISH
5. BAR FOOT RAIL
6. STONE COUNTERTOP
7. ALUM GUTTER
8. ALUM DOWNSPOUT
9. WRAPPED COLUMN
10. EXTERIOR FIBER CEMENT TRIM BOARD
11. SINGLE HM DOOR, SEE SHEET A801
12. SINGLE HM SERVICE DOOR W/ GLAZING, SEE SHEET A801
13. DOUBLE HM SERVICE DOOR W/ GLAZING, SEE SHEET A801
14. TYPE "W1" WINDOW, SEE SHEET A831
15. TYPE "W2" WINDOW, SEE SHEET A831
16. TYPE "W3" WINDOW, SEE SHEET A831
17. PICK-UP COUNTER OPENING, SEE SHEET A831
18. WALL MOUNTED TV (BY OWNER)
19. CUPOLA TRIM
20. DECORATIVE RAFTER TAILS
21. DECORATIVE SHUTTER "L1", SEE SHEET A831
22. DECORATIVE SHUTTER TRIM, SEE SHEET A831
23. AIR INTAKE LOUVER
24. COVERED TRELLIS STRUCTURE

GENERAL NOTES

- A. SEE EXTERIOR MATERIAL COLORS ON SHEET A???
B. SEE ROOF PLANS ON SHEET A301 FOR EXTERIOR ELEVATION CALLOUTS
C. SEE EXTERIOR GLAZING SCHEDULE ON SHEET A831

LEGEND

	SIDING (HORIZ) 6" W.		FRONT BAR WALL TILE
	METAL ROOFING, STANDING SEAM, 12" OC		CUSTOM BACK BAR
	GLAZING		

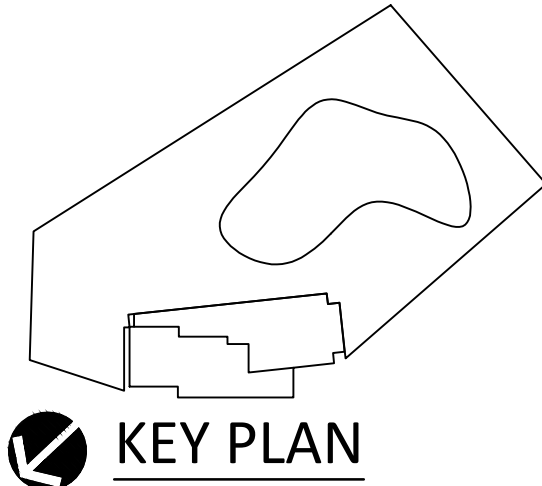

A1	EXTERIOR COLORS & FINISHES
A432	NTS

730 PEACHTREE STREET, NE
STUDIO 325
ATLANTA, GEORGIA 30308
678.244.6270
www.KDCarchitects.com

ARCHITECT:

ARCH. REG: AR91344

CONSULTANT:

REVISIONS	
DATE:	DESCRIPTION:
10/18/24	SCHEMATIC DESIGN
7/24/25	DESIGN DEVELOPMENT
10/23/25	50% CONSTRUCTION DOCS
11/14/25	PERMIT SET

PROJECT:

SERENITY SEASIDE
RESORT

BUILDING #3
BEACH
CLUB

186 SOUTH BAY
SHORE DRIVE,
EASTPOINT, FL
32328

Serenity Seaside
Operations, LLC
174 Watercolor Way, PMB 410
Santa Rosa Beach, Florida 32459

JOB NUMBER: 23019.3

DATE: --/--/----


TITLE:

EXTERIOR
ELEVATIONS

SHEET:

A432

K:\Projects\23\23019\DWG\Serenity_Bldg-3_Beach_Club\Sheets\23019_3-A531.dwg Plotted: Nov 14, 2025 - 1:19pm by Caeblawrence

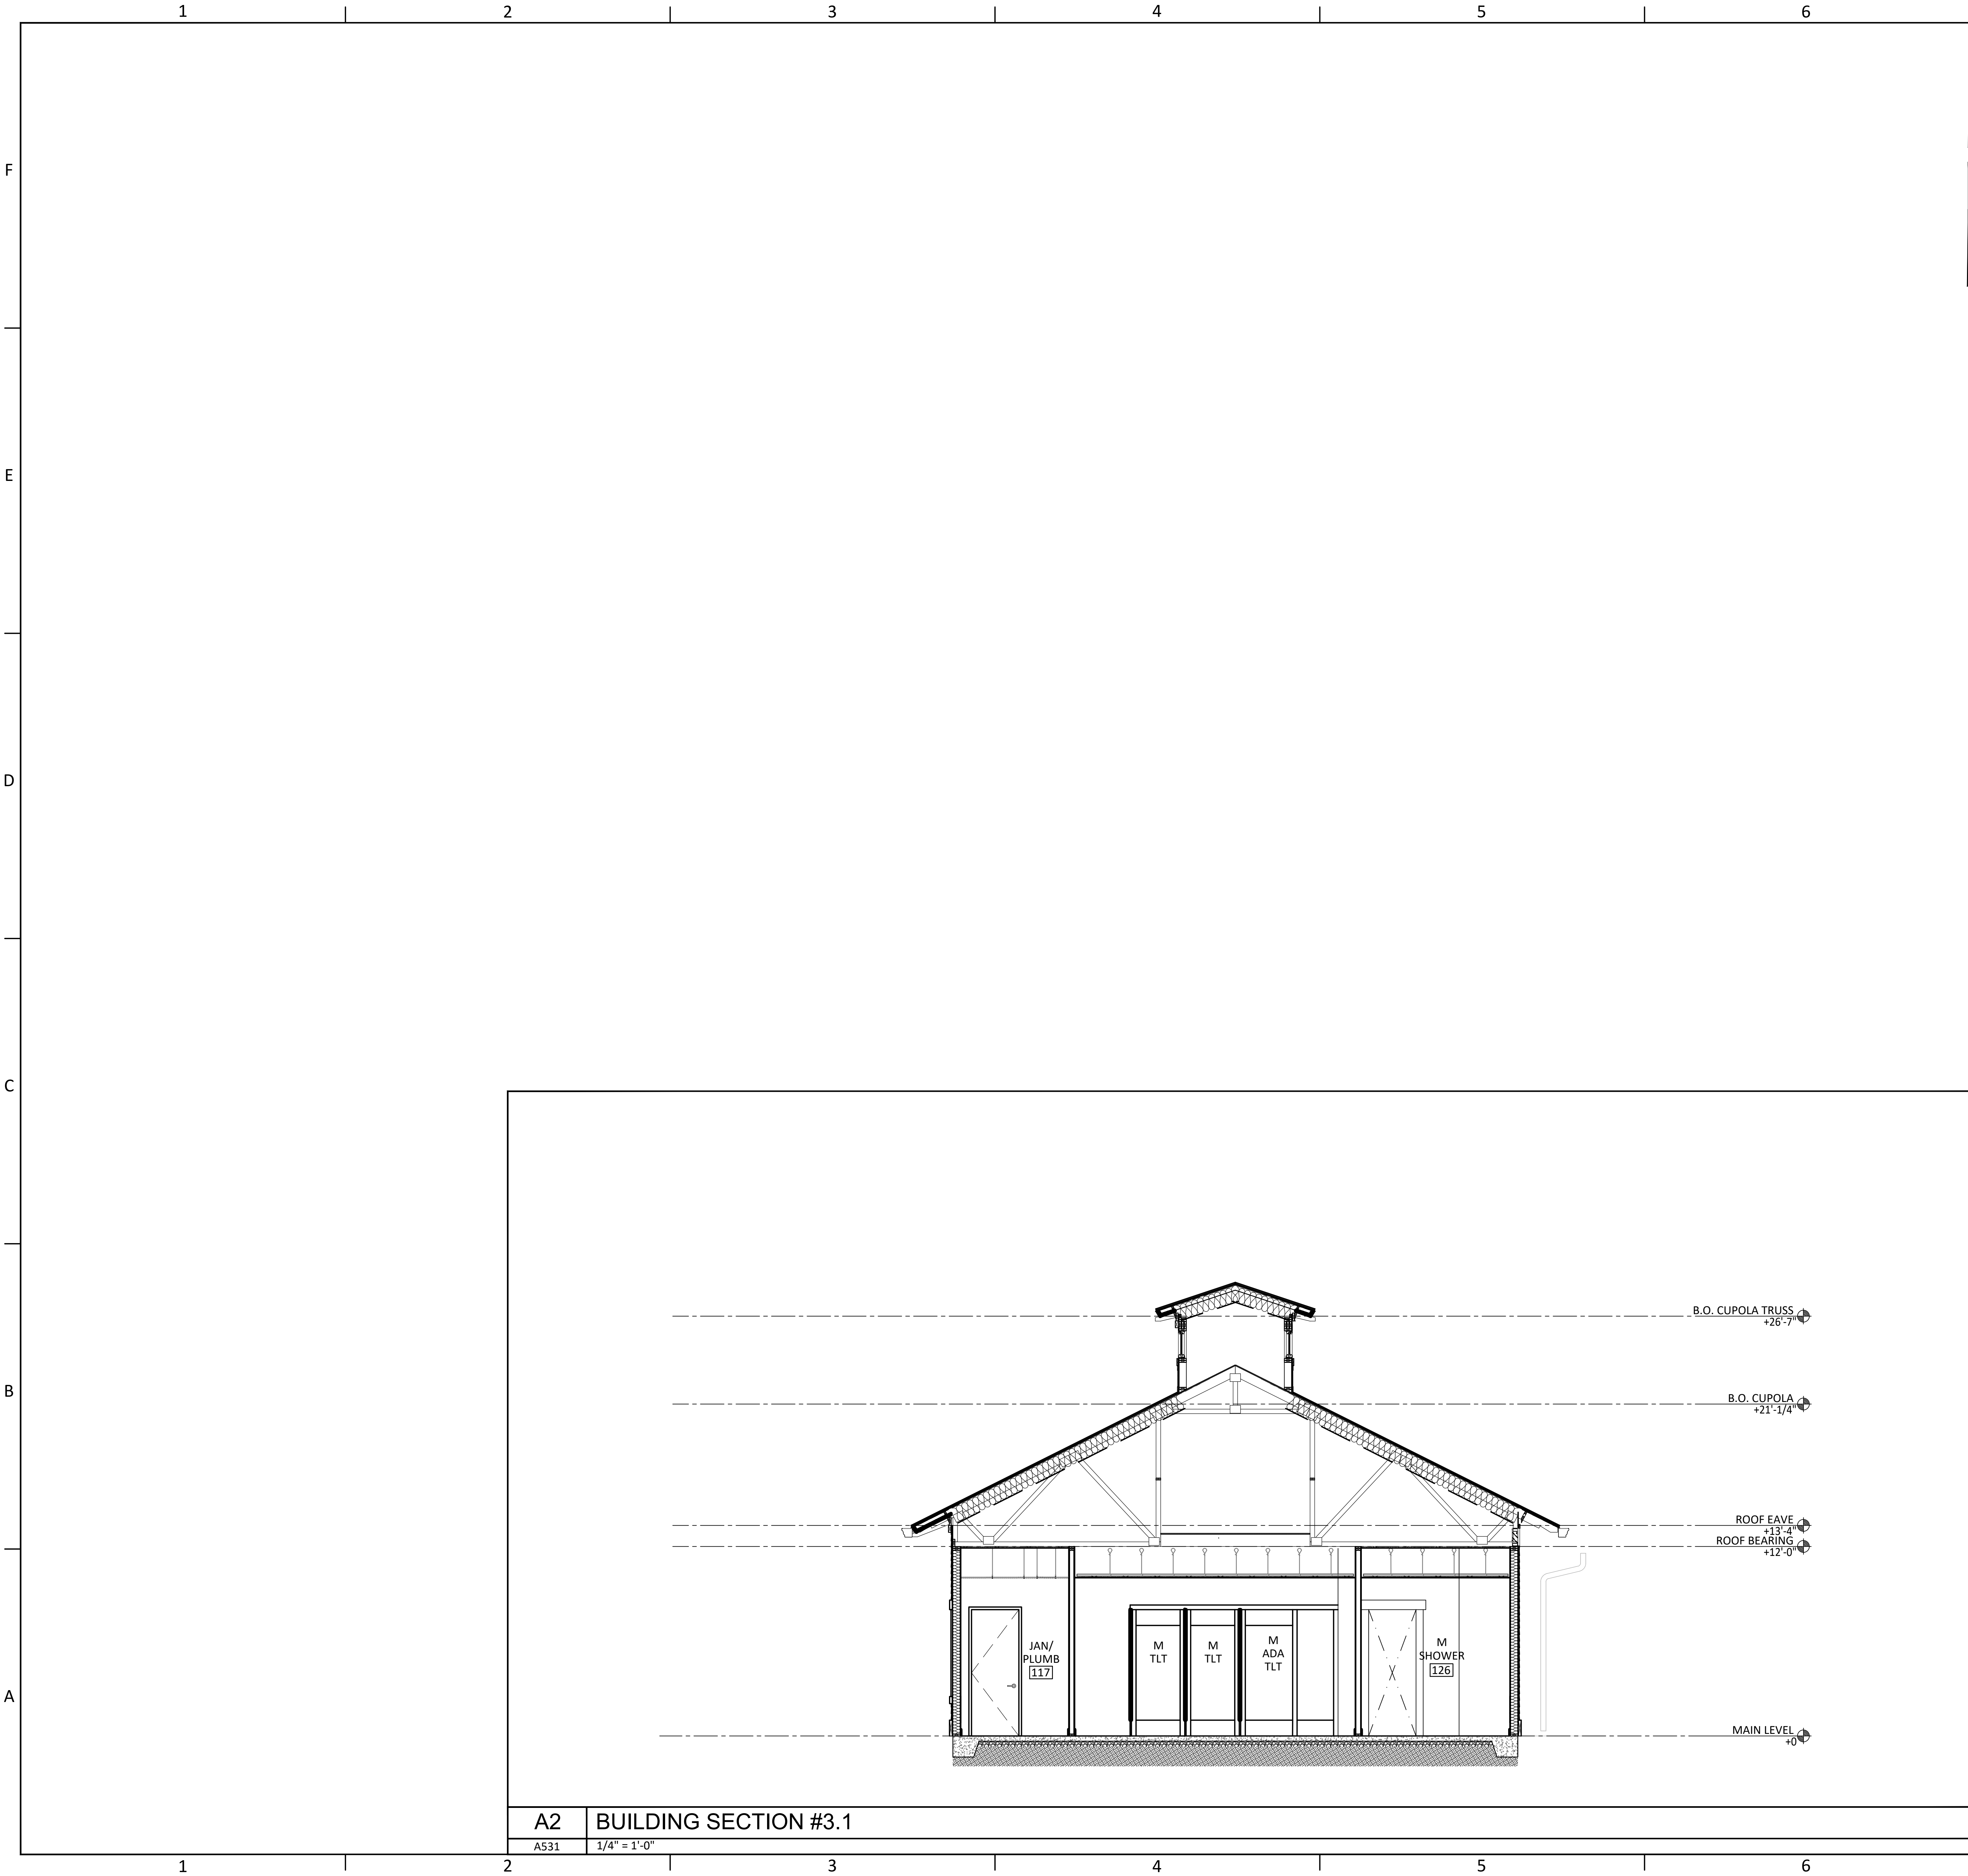

SHEET NOTES / LEGEND	
1.	-
GENERAL NOTES	
A.	-

GENERAL NOTES	
GENERAL NOTES: (APPLIES TO ALL WALL & BUILDING SECTION & DETAIL SHEETS)	
A.	STRUCTURAL STEEL, ROOF TRUSSES, CONCRETE FOUNDATIONS, & LINTELS & HEADERS AT OPENINGS SHOWN IN ARCHITECTURAL WALL SECTIONS ARE DRAWN GRAPHICALLY - REFER TO STRUCTURAL DRAWINGS FOR EXACT SIZES, REINFORCING, MISC BRACING MEMBERS & ATTACHMENTS
B.	EXPOSED METAL FLASHING IS ALUM., UNLESS NOTED OTHERWISE
C.	PROVIDE STAINLESS STEEL DRIP EDGE WHERE THRU WALL FLASHING DRIP WOULD BE EXPOSED TO SUN
D.	AIR & WATER MEMBERANE ON ALL SHEATHING IS WRAPSHIELD SA SELF ADHERED BY VAPROSHIELD
E.	SHEET MEMBRANE FLASHINGS & WATERPROOFING SHOULD BE TERMINATED WITH A CONTINUOUS TERMINATION BAR & SEALED
F.	ALL INSULATING MATERIALS SHALL HAVE A FLAMESPREAD INDEX OF NOT MORE THAN 25 & A SMOKE-DEVELOPED INDEX OF NOT MORE THAN 450 AS DETERMINED IN ACCORDANCE W/ ASTM E 84.
G.	BATT INSULATION IN EXTERIOR WALLS, REFER TO SPEC 07 21000 FOR MIN. THERMAL VALUE : R-19
H.	BATT INSULATION IN CEILINGS / SOFFITS, REFER TO SPEC 07 2100 FOR THERMAL VALUE : R-38
I.	RIGID INSULATION @ LOW SLOPE ROOFS, REFER TO SPEC 07 5442 FOR THERMAL VALUE : R-20
J.	PROVIDE FLEXIBLE VENEER ANCHORAGE AT 16" O.C. VERT. & 16" O.C. HORIZ MAX APPROPRIATE TO BACKUP AT ALL STONE VENEER LOCATIONS- WHETHER SPECIFICALLY INDICATED ON WALL SECTIONS OR NOT
K.	WHERE STONE VENEER IS 4" TH - PROVIDE ONE (1) INCH MINIMUM AIR SPACE BETWEEN STONE VENEER & THE OUTSIDE FACE OF EXTERIOR SHEATHING OR OUTSIDE FACE OF CMU
L.	METAL ROOF DETAILS, SEE SHEET A3??
M.	INTERIOR PARTITION DETAILS, SEE SHEET A8??
N.	ALL BEAMS + RAFTERS + T&G SOFFITS TO BE ??? (STAINED/SEALED)
O.	NATURAL STONE VENEER / PAVER SPECS, SEE SHEET A???



730 PEACHTREE STREET, NE
STUDIO 325
ATLANTA, GEORGIA 30308
678.244.6270
www.KDCarchitects.com

ARCHITECT:

ARCH. REG: AR91344

CONSULTANT:

REVISIONS	
DATE:	DESCRIPTION:
10/18/24	SCHEMATIC DESIGN
7/24/25	DESIGN DEVELOPMENT
10/23/25	50% CONSTRUCTION DOCS
11/14/25	PERMIT SET

PROJECT:
SERENITY SEASIDE RESORT

BUILDING #3 BEACH CLUB

186 SOUTH BAY SHORE DRIVE, EASTPOINT, FL 32328

Serenity Seaside Operations, LLC
174 Watercolor Way, PMB 410
Santa Rosa Beach, Florida 32459


JOB NUMBER: 23019.3

DATE: --/--/----

TITLE: BUILDING SECTIONS

SHEET: A531

K:\Projects\23\23019\DWG\A631\A631.dwg
Plotted: Nov 14, 2025 - 1:20pm by Caeblawrence

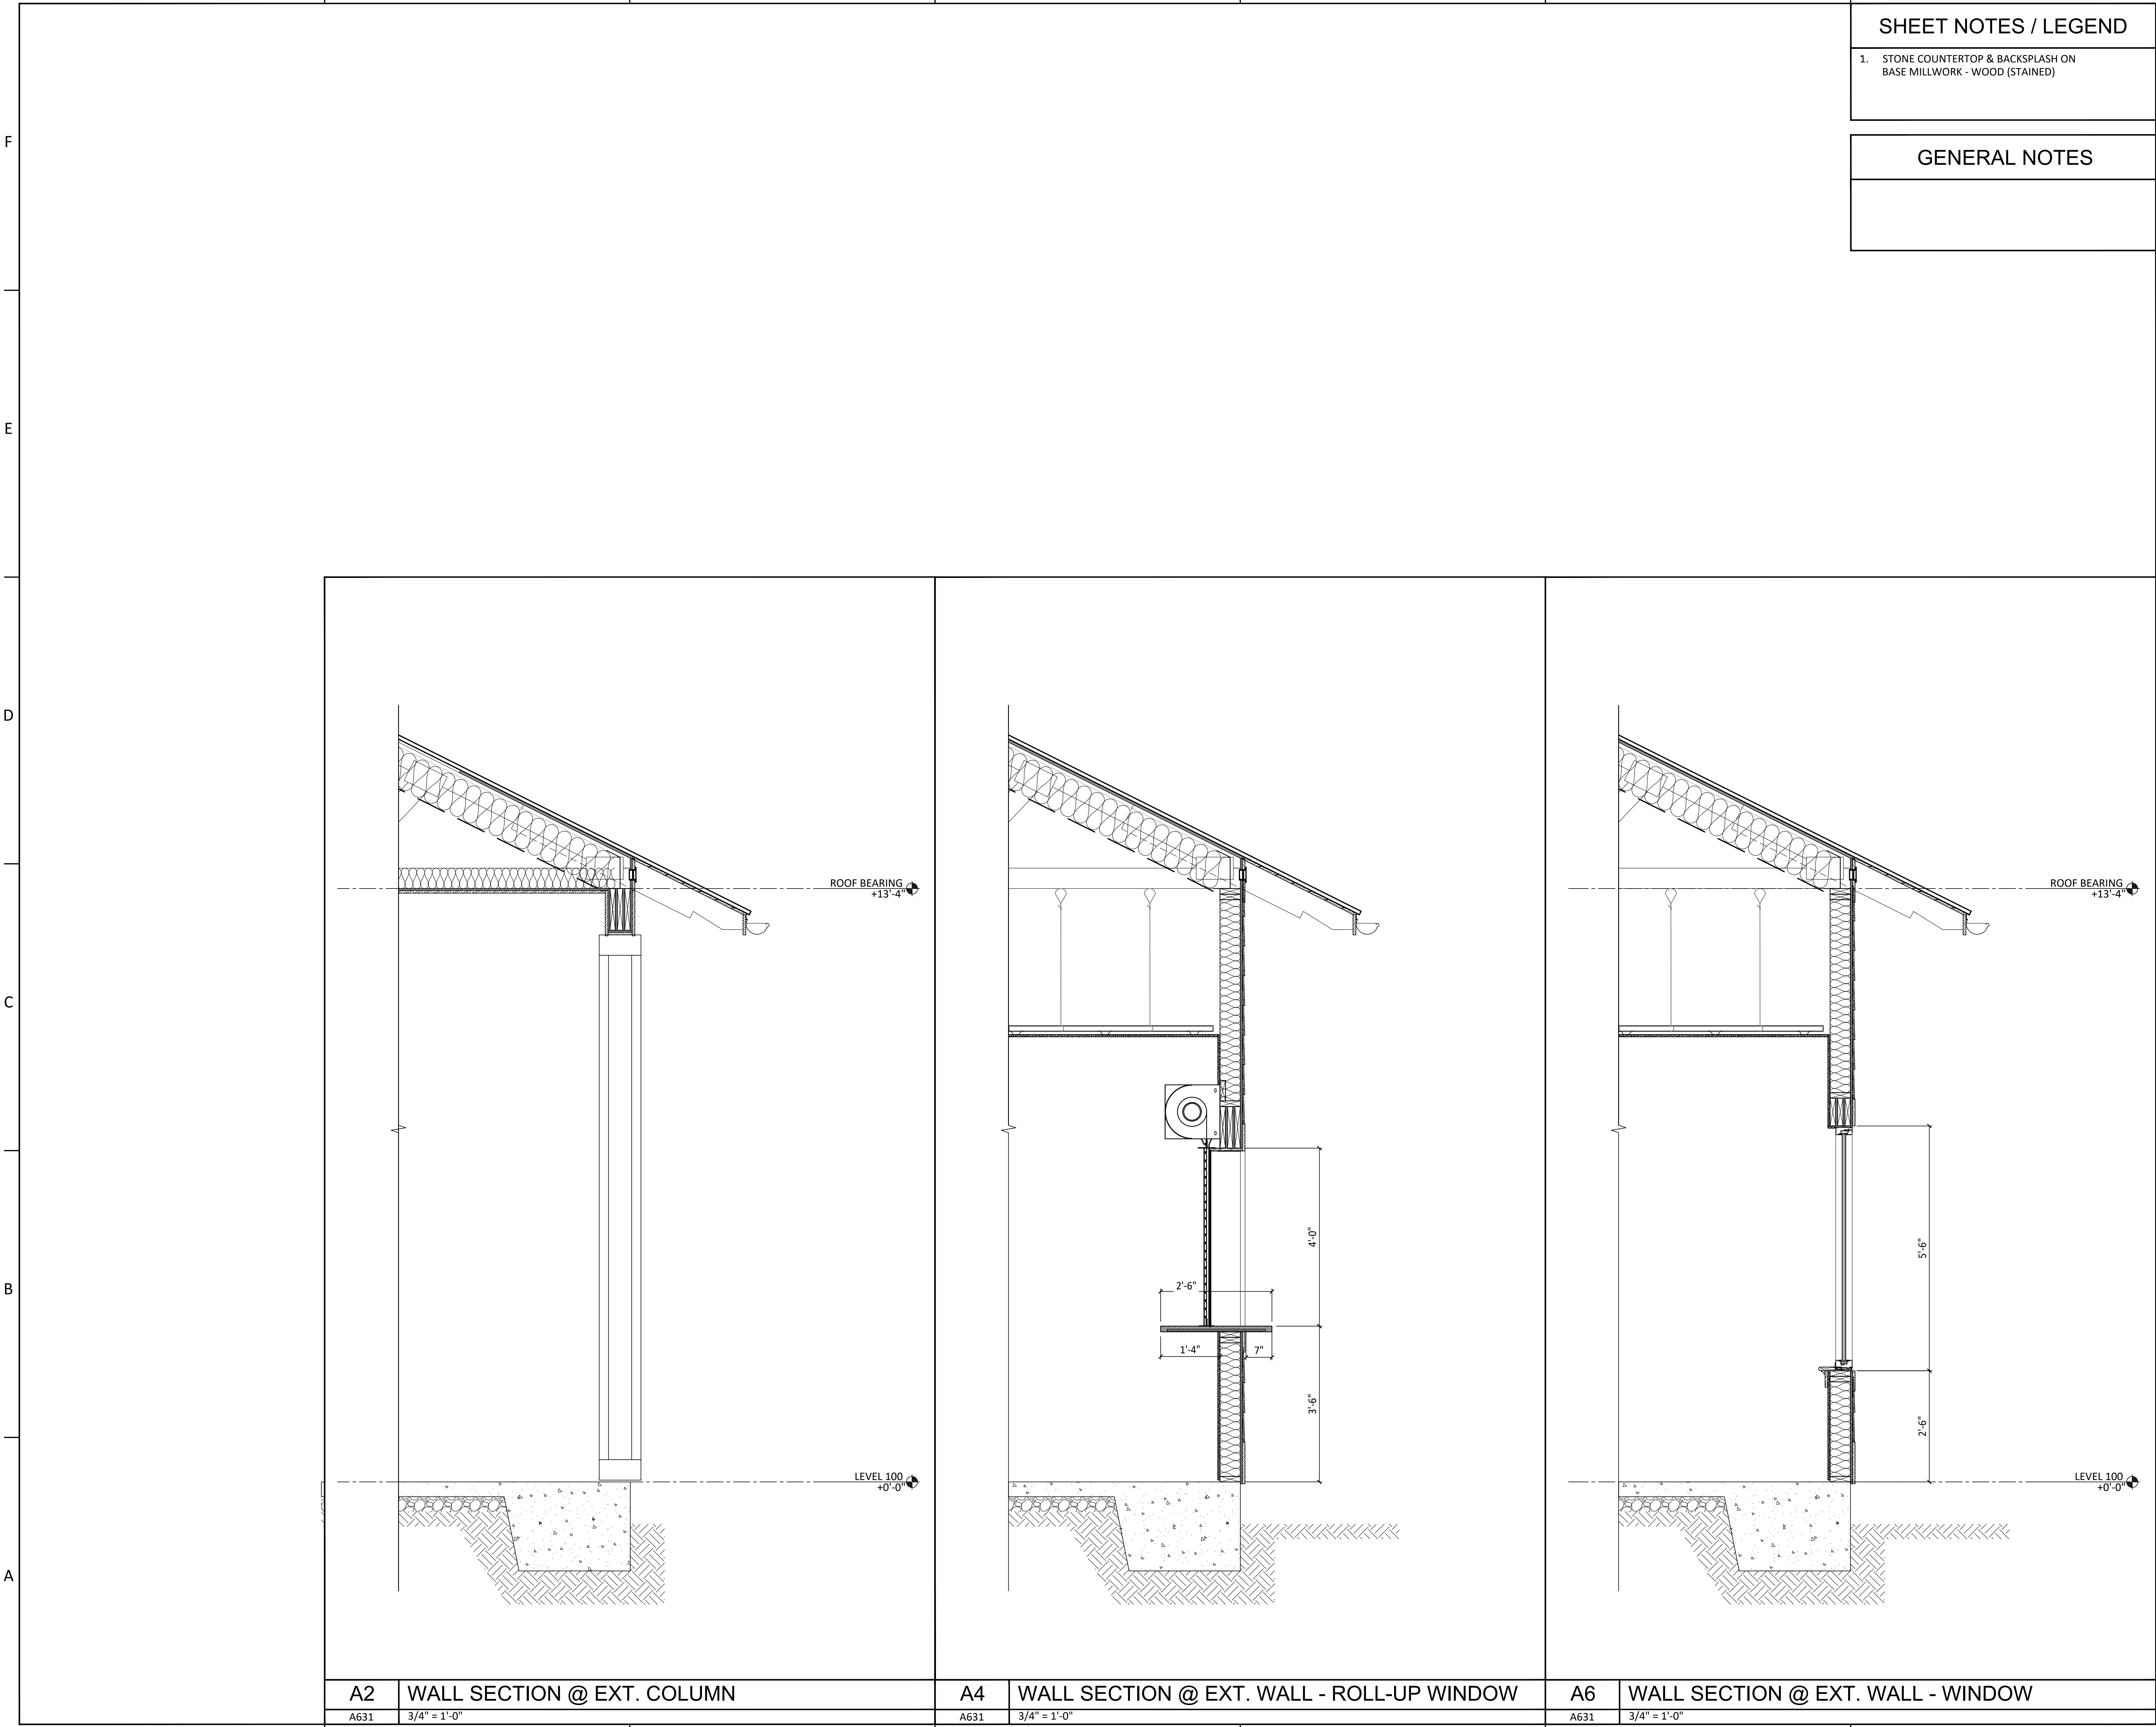


A2	WALL SECTION @ EXT. COLUMN	A4	WALL SECTION @ EXT. WALL - ROLL-UP WINDOW	A6	WALL SECTION @ EXT. WALL - WINDOW
A631	3/4" = 1'-0"	A631	3/4" = 1'-0"	A631	3/4" = 1'-0"

SHEET NOTES / LEGEND

- STONE COUNTERTOP & BACKSPLASH ON
BASE MILLWORK - WOOD (STAINED)

GENERAL NOTES

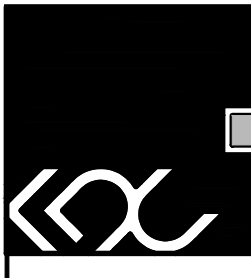

**KUO
DIEDRICH
CHI**

730 PEACHTREE STREET, NE
STUDIO 325
ATLANTA, GEORGIA 30308
678.244.6270
www.KDCarchitects.com

ARCHITECT:

ARCH. REG: AR91344

CONSULTANT:

REVISIONS	
DATE:	DESCRIPTION:
10/18/24	SCHEMATIC DESIGN
7/24/25	DESIGN DEVELOPMENT
10/23/25	50% CONSTRUCTION DOCS
11/14/25	PERMIT SET

PROJECT:

SERENITY SEASIDE
RESORT

BUILDING #3
BEACH
CLUB

186 SOUTH BAY
SHORE DRIVE,
EASTPOINT, FL
32328

Serenity Seaside
Operations, LLC
174 Watercolor Way, PMB 410
Santa Rosa Beach, Florida 32459

JOB NUMBER:

23019.3

DATE:

--/------


TITLE:

WALL
SECTIONS

SHEET:

A631

K:\Projects\23\23019\DWG\Serenity_Bldg-3_Beach_Club\Sheets\23019_3-A632.dwg Plotted: Nov 14, 2025 - 1:21pm by CalebLawrence

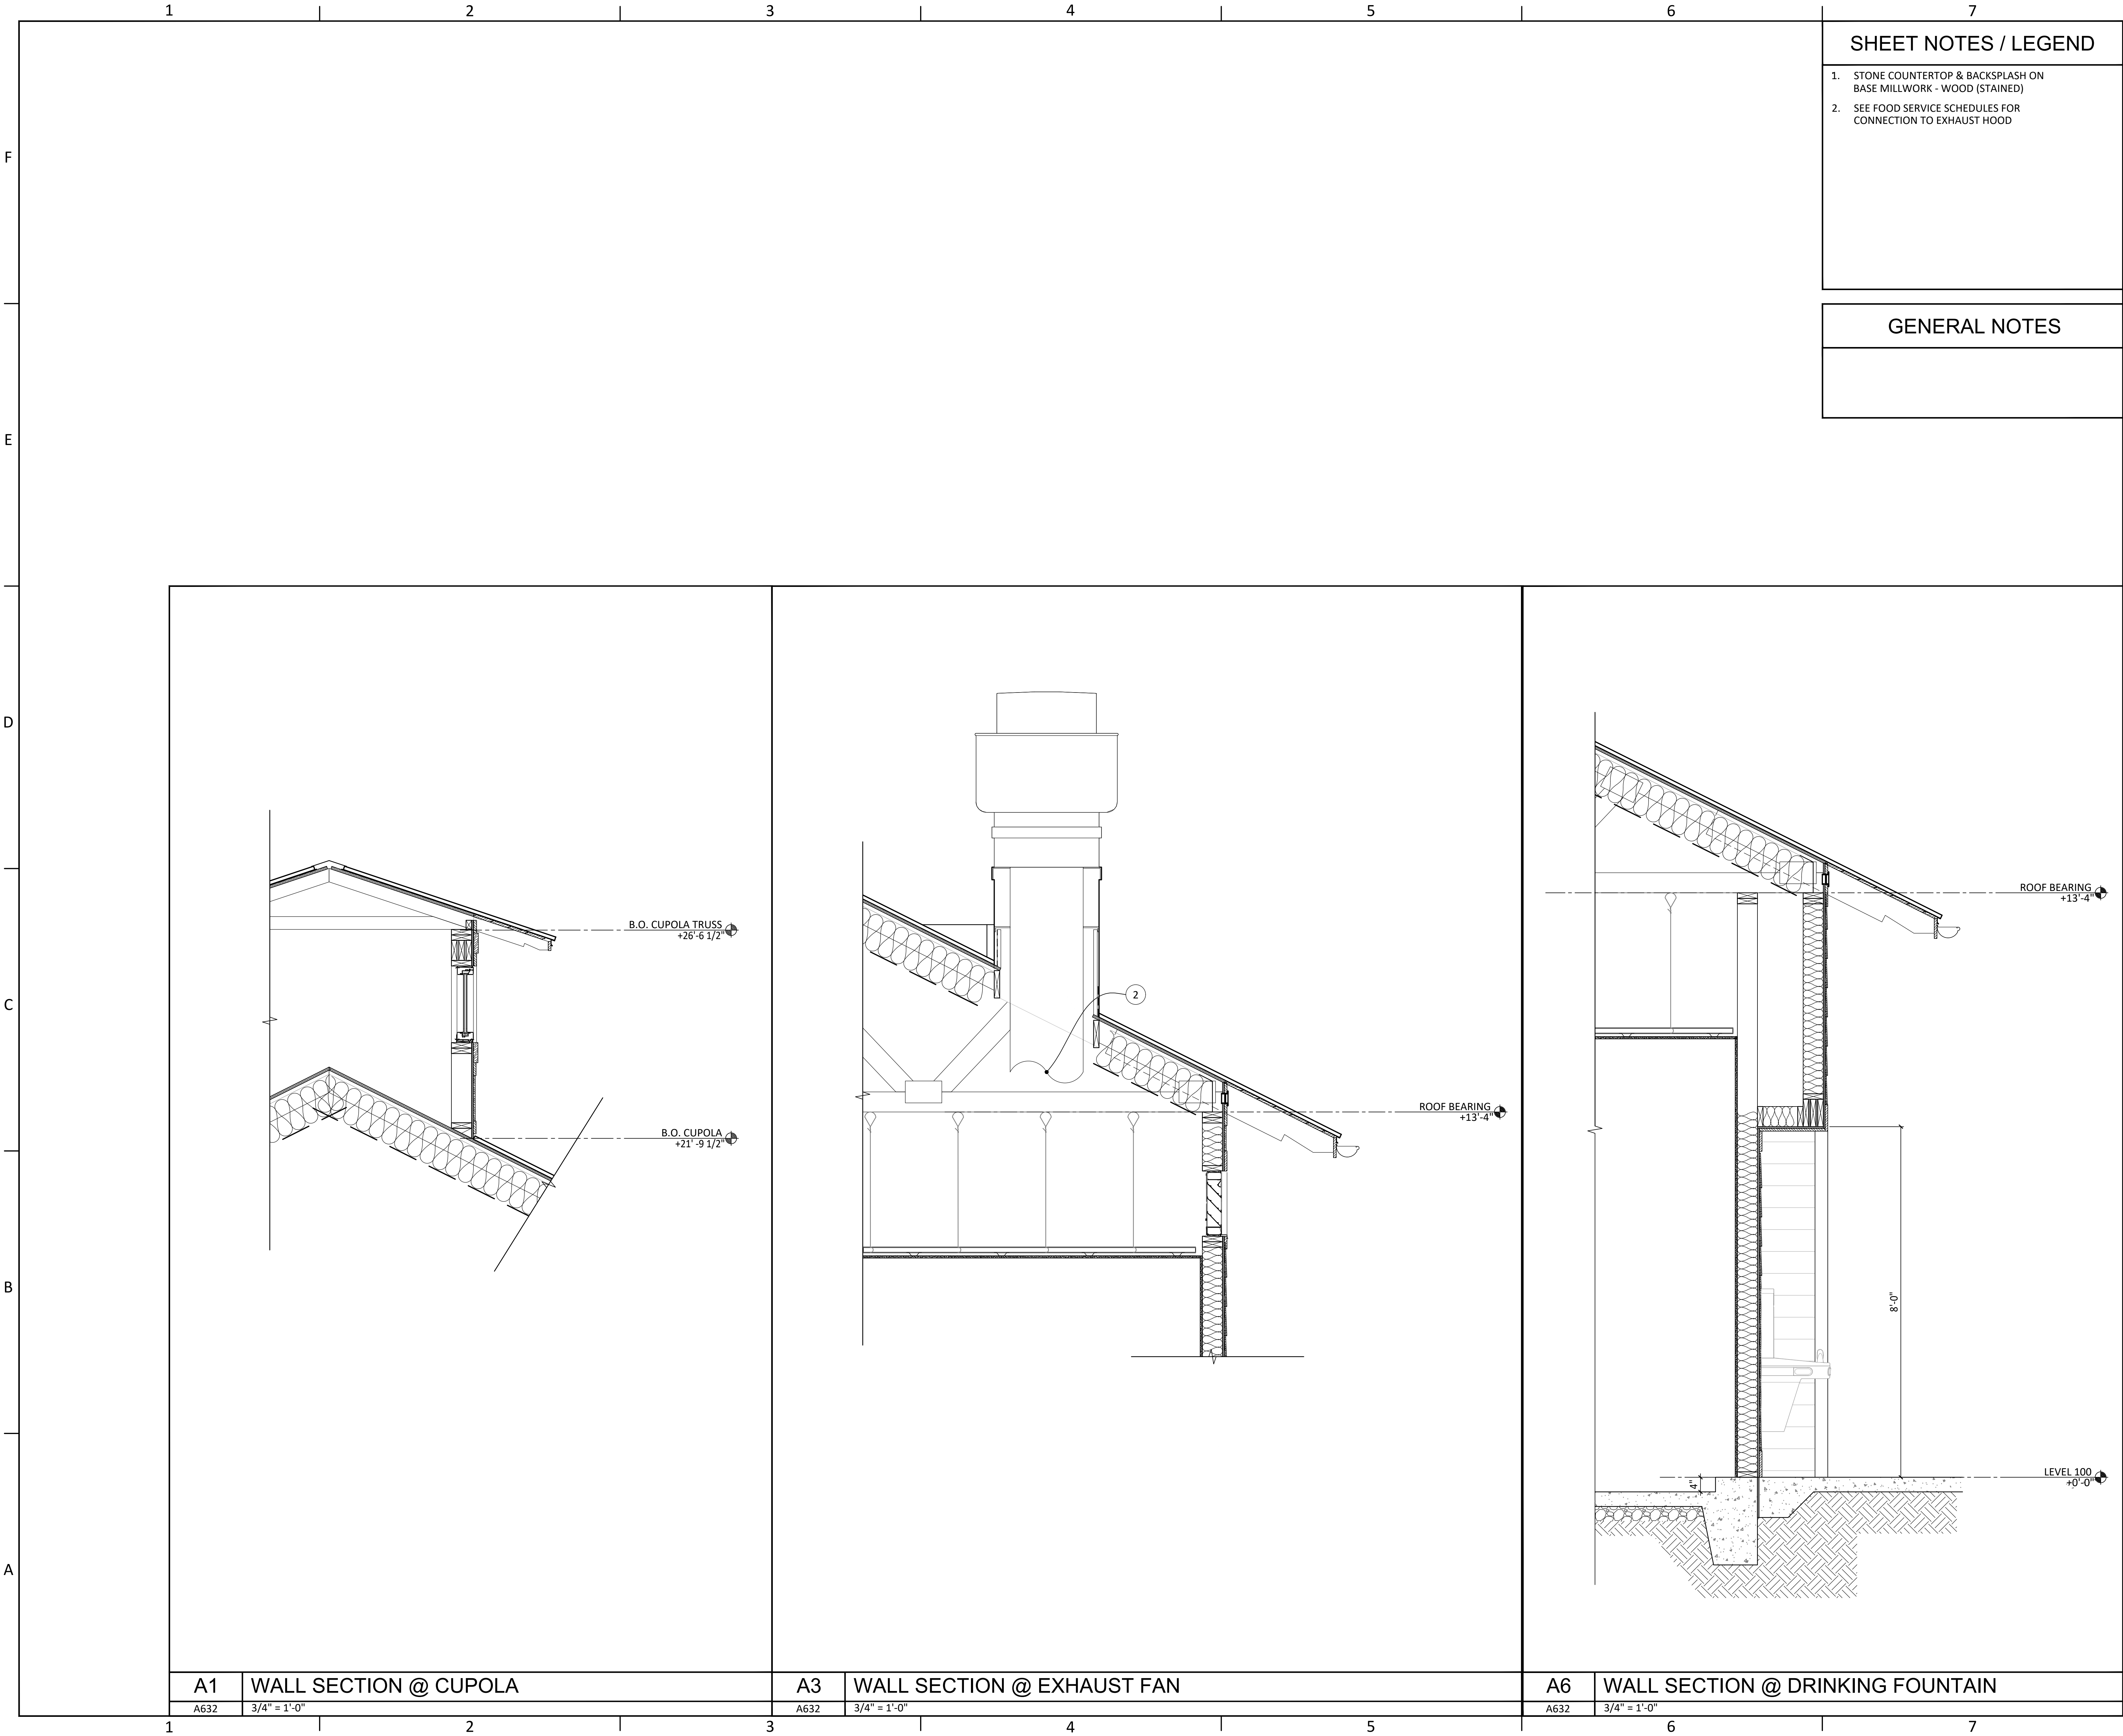



730 PEACHTREE STREET, NE
STUDIO 325
ATLANTA, GEORGIA 30308
678.244.6270
www.KDCarchitects.com

ARCHITECT:

ARCH. REG: AR91344

CONSULTANT:

REVISIONS	
DATE:	DESCRIPTION:
10/18/24	SCHEMATIC DESIGN
7/24/25	DESIGN DEVELOPMENT
10/23/25	50% CONSTRUCTION DOCS
11/14/25	PERMIT SET

PROJECT:

SERENITY SEASIDE
RESORT

BUILDING #3
BEACH
CLUB

186 SOUTH BAY
SHORE DRIVE,
EASTPOINT, FL
32328

Serenity Seaside
Operations, LLC
174 Watercolor Way, PMB 410
Santa Rosa Beach, Florida 32459

JOB NUMBER: 23019.3

DATE: --/------

TITLE:

WALL
SECTIONS

SHEET:

A632

K:\Projects\23019\DWG\Serenity_Bldg-3_Beach_Club\Sheets\23019.3-A831.dwg Plotted: Nov 14, 2025 - 1:21pm by Caeblawrence

DOOR & FRAME SCHEDULE																					
BUILDING 3																					
DOOR NO.	RM. NO.	LOCATION ROOM NAME	TYPE	DOOR SIZE			MATERIAL	FINISH	GLAZING	FRAME				CLOSER	FIRE RATING	CARD ACCESS	HARDWARE SET NO.	REMARKS	DOOR NO.		
				WIDTH	HEIGHT	THICK.				TYPE	MATERIAL	FINISH	DETAILS								
													HEAD	JAMB	THRESHOLD						
104a	104	KITCHEN	E3	3'-0"	8'-0"	1-3/4"	ALUM														
104b	104	KITCHEN	E3	3'-0"	8'-0"	1-3/4"	ALUM														
104c	104	KITCHEN	E4	3'-0"	8'-0"	1-3/4"	ALUM														
105	105	DELIVERY/RECEIVING	E2	4'-0"	8'-0"	1-3/4"	ALUM														
109	109	MEN VESTIBULE	E1	3'-0"	8'-0"	1-3/4"	HM														
110a	110	MEN RESTROOM																			
110b	110	MEN RESTROOM																			
110c	110	MEN RESTROOM																			
111	111	MEN CHANGE RM	D1	3'-0"	8'-0"	1-3/4"	WD														
113	113	JAN/PLUMB	D1	3'-0"	8'-0"	1-3/4"	WD														
114	114	FAMILY ADA RR	E1	3'-0"	8'-0"	1-3/4"	HM														
115	115	WOMEN VESTIBULE	E1	3'-0"	8'-0"	1-3/4"	HM														
116a	116a	WOMEN RESTROOM																			
116b	116b	WOMEN RESTROOM																			
116c	116c	WOMEN RESTROOM																			
116d	116d	WOMEN RESTROOM																			
117	117	WOMEN CHANGE RM	D1	3'-0"	8'-0"	1-3/4"	WD														

E2	DOOR SCHEDULE
A831	NTS

</

SHEET NOTES / LEGEND

1. -

GENERAL NOTES

A. -



730 PEACHTREE STREET, NE
STUDIO 325
ATLANTA, GEORGIA 30308
678.244.6270
www.KDCarchitects.com

ARCHITECT:

ARCH. REG: AR91344

CONSULTANT:

REVISIONS

DATE:	DESCRIPTION:
10/18/24	SCHEMATIC DESIGN
7/24/25	DESIGN DEVELOPMENT
10/23/25	50% CONSTRUCTION DOCS
11/14/25	PERMIT SET

PROJECT:

SERENITY SEASIDE
RESORT

BUILDING #3
**BEACH
CLUB**

186 SOUTH BAY
SHORE DRIVE,
EASTPOINT, FL
32328

Serenity Seaside
Operations, LLC
174 Watercolor Way, PMB 410
Santa Rosa Beach, Florida 32459

JOB NUMBER: 23019.3


DATE: --/--/----

TITLE:
DOOR
SCHEDULE &
DOOR
FRAME TYPES

SHEET:

A831

K:\Projects\23\23019\DWG\Serenity_Bldg-3_Beach_Club\Sheets\23019_3-A832.dwg Plotted: Nov 14, 2025 - 1:21pm by Caeblawrence

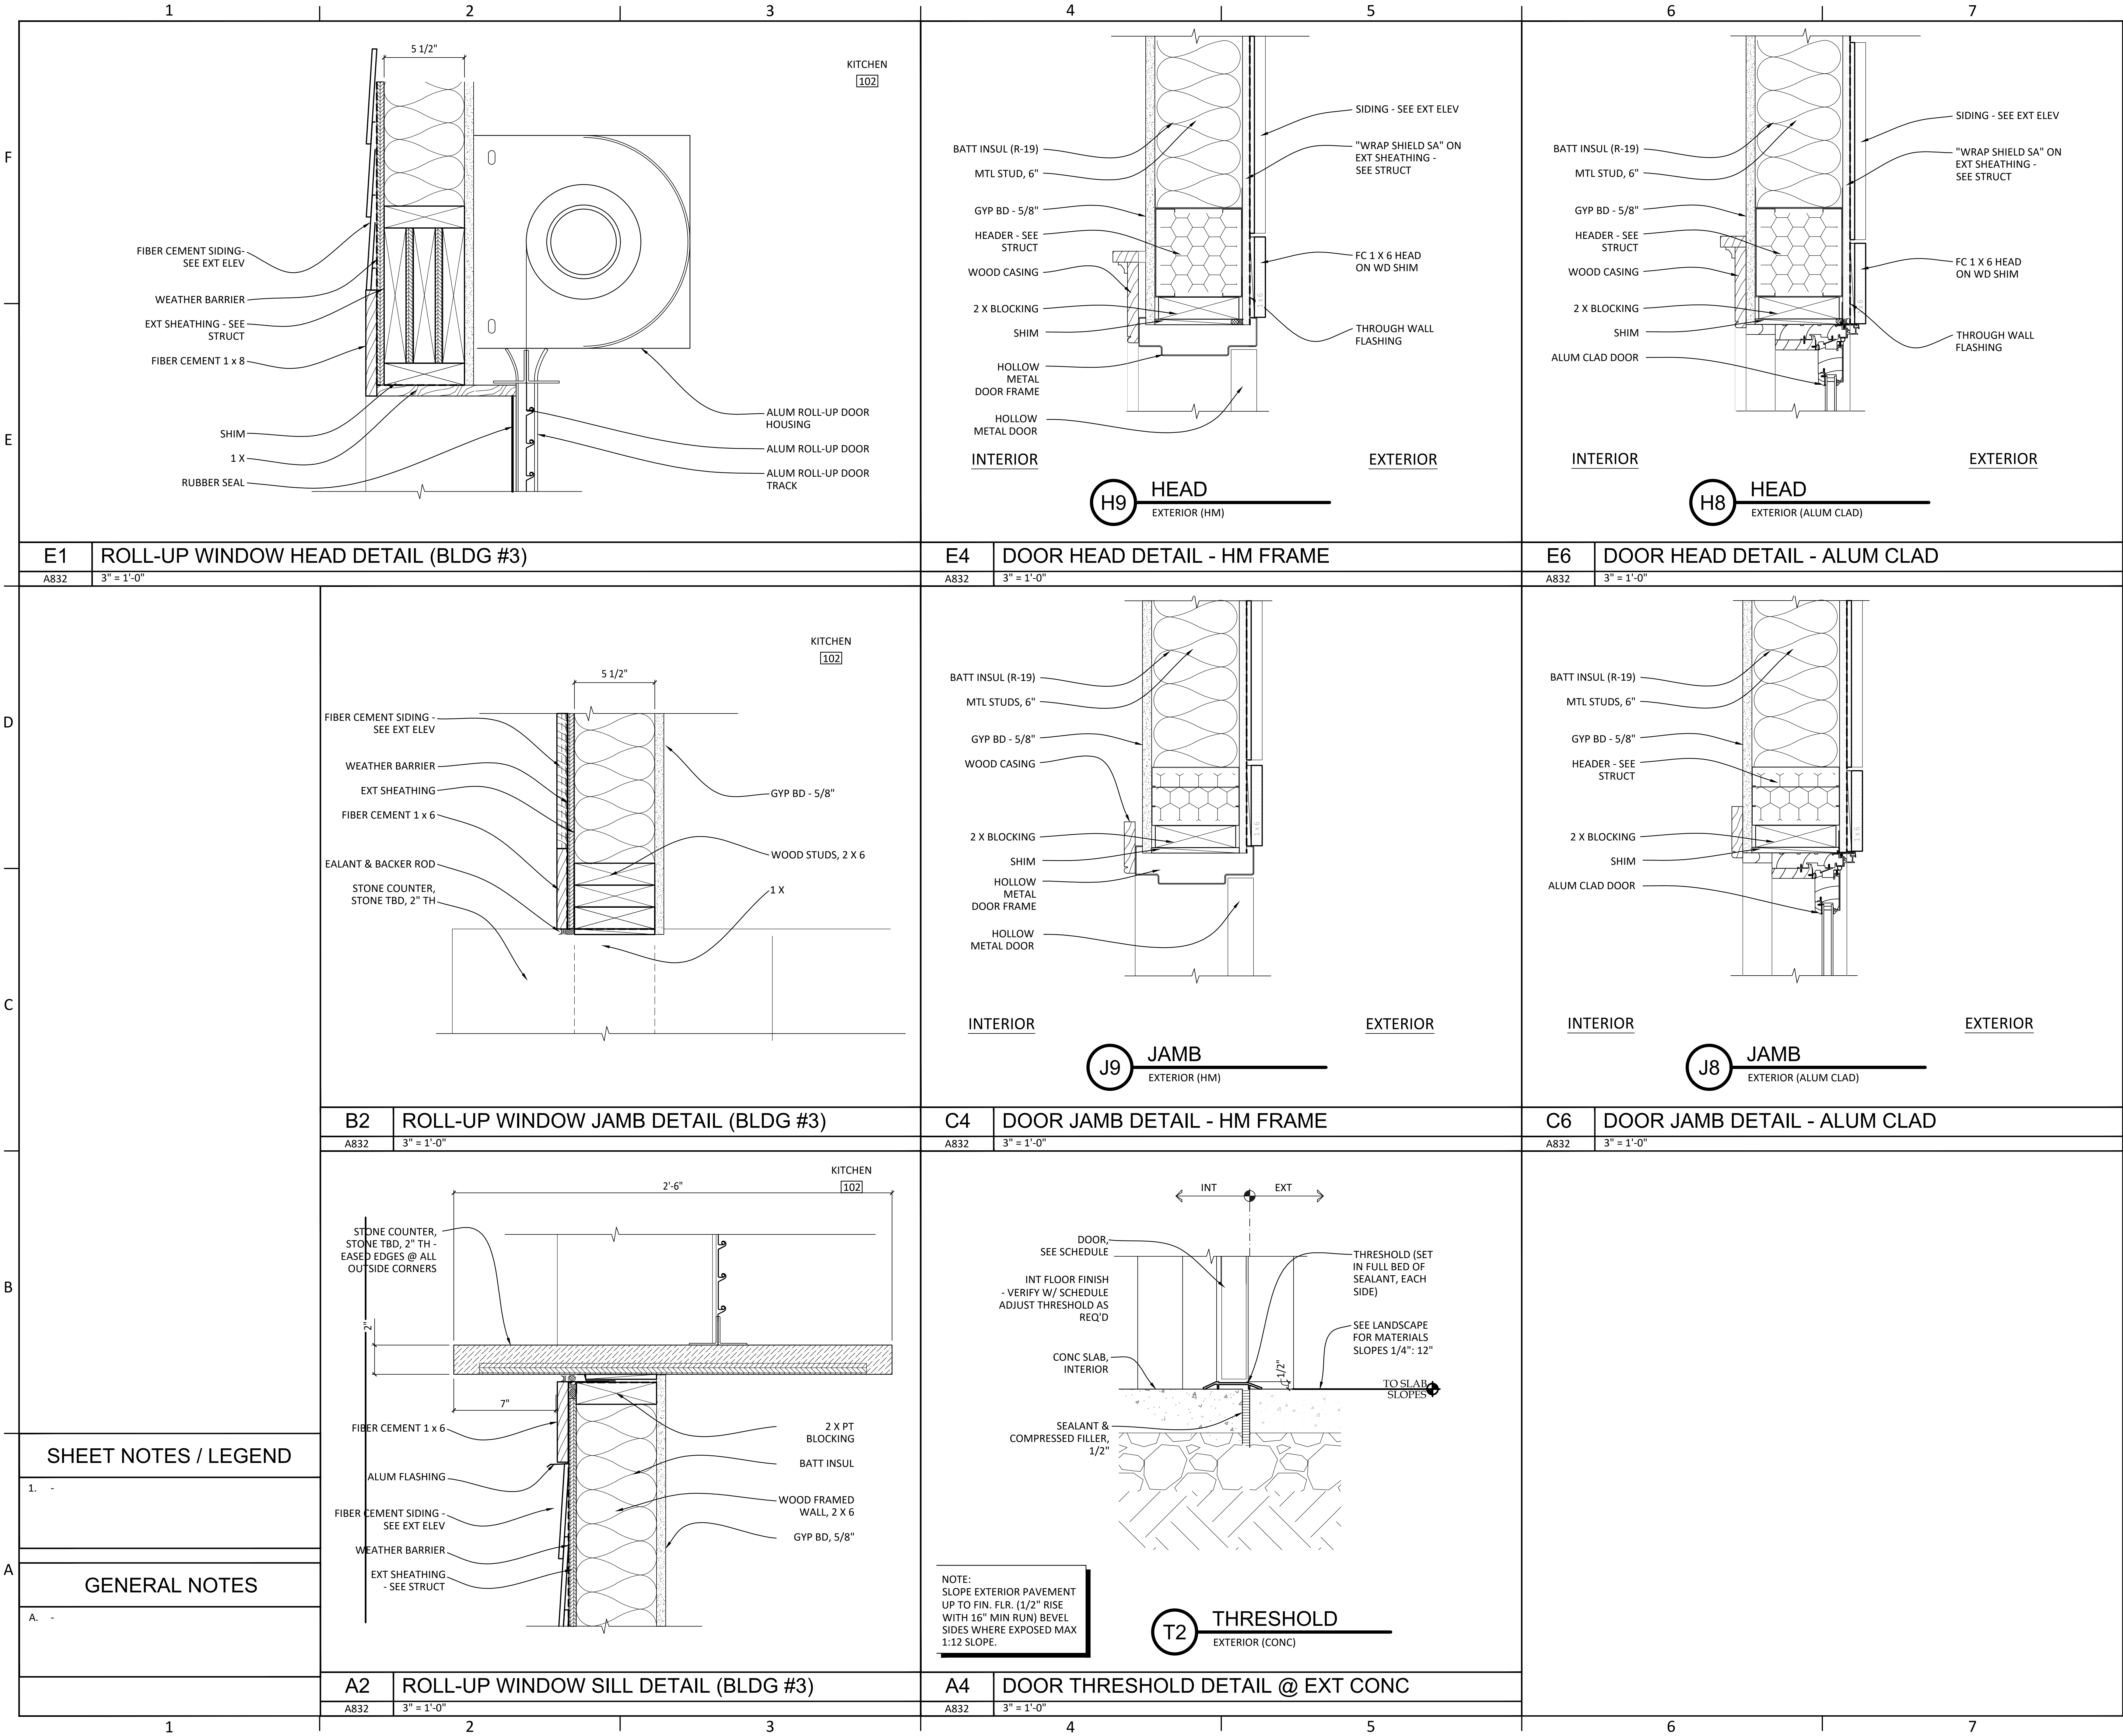

730 PEACHTREE STREET, NE
STUDIO 325
ATLANTA, GEORGIA 30308
678.244.6270
www.KDCarchitects.com

ARCHITECT:

ARCH. REG. AR91344

CONSULTANT:

REVISIONS	
DATE:	DESCRIPTION:
10/18/24	SCHEMATIC DESIGN
7/24/25	DESIGN DEVELOPMENT
10/23/25	50% CONSTRUCTION DOCS
11/14/25	PERMIT SET

PROJECT:

SERENITY SEASIDE
RESORT

BUILDING #3
BEACH
CLUB

186 SOUTH BAY
SHORE DRIVE,
EASTPOINT, FL
32328

JOB NUMBER: 23019.3



DATE: --/------

TITLE:

DOOR
DETAILS

SHEET:

A832




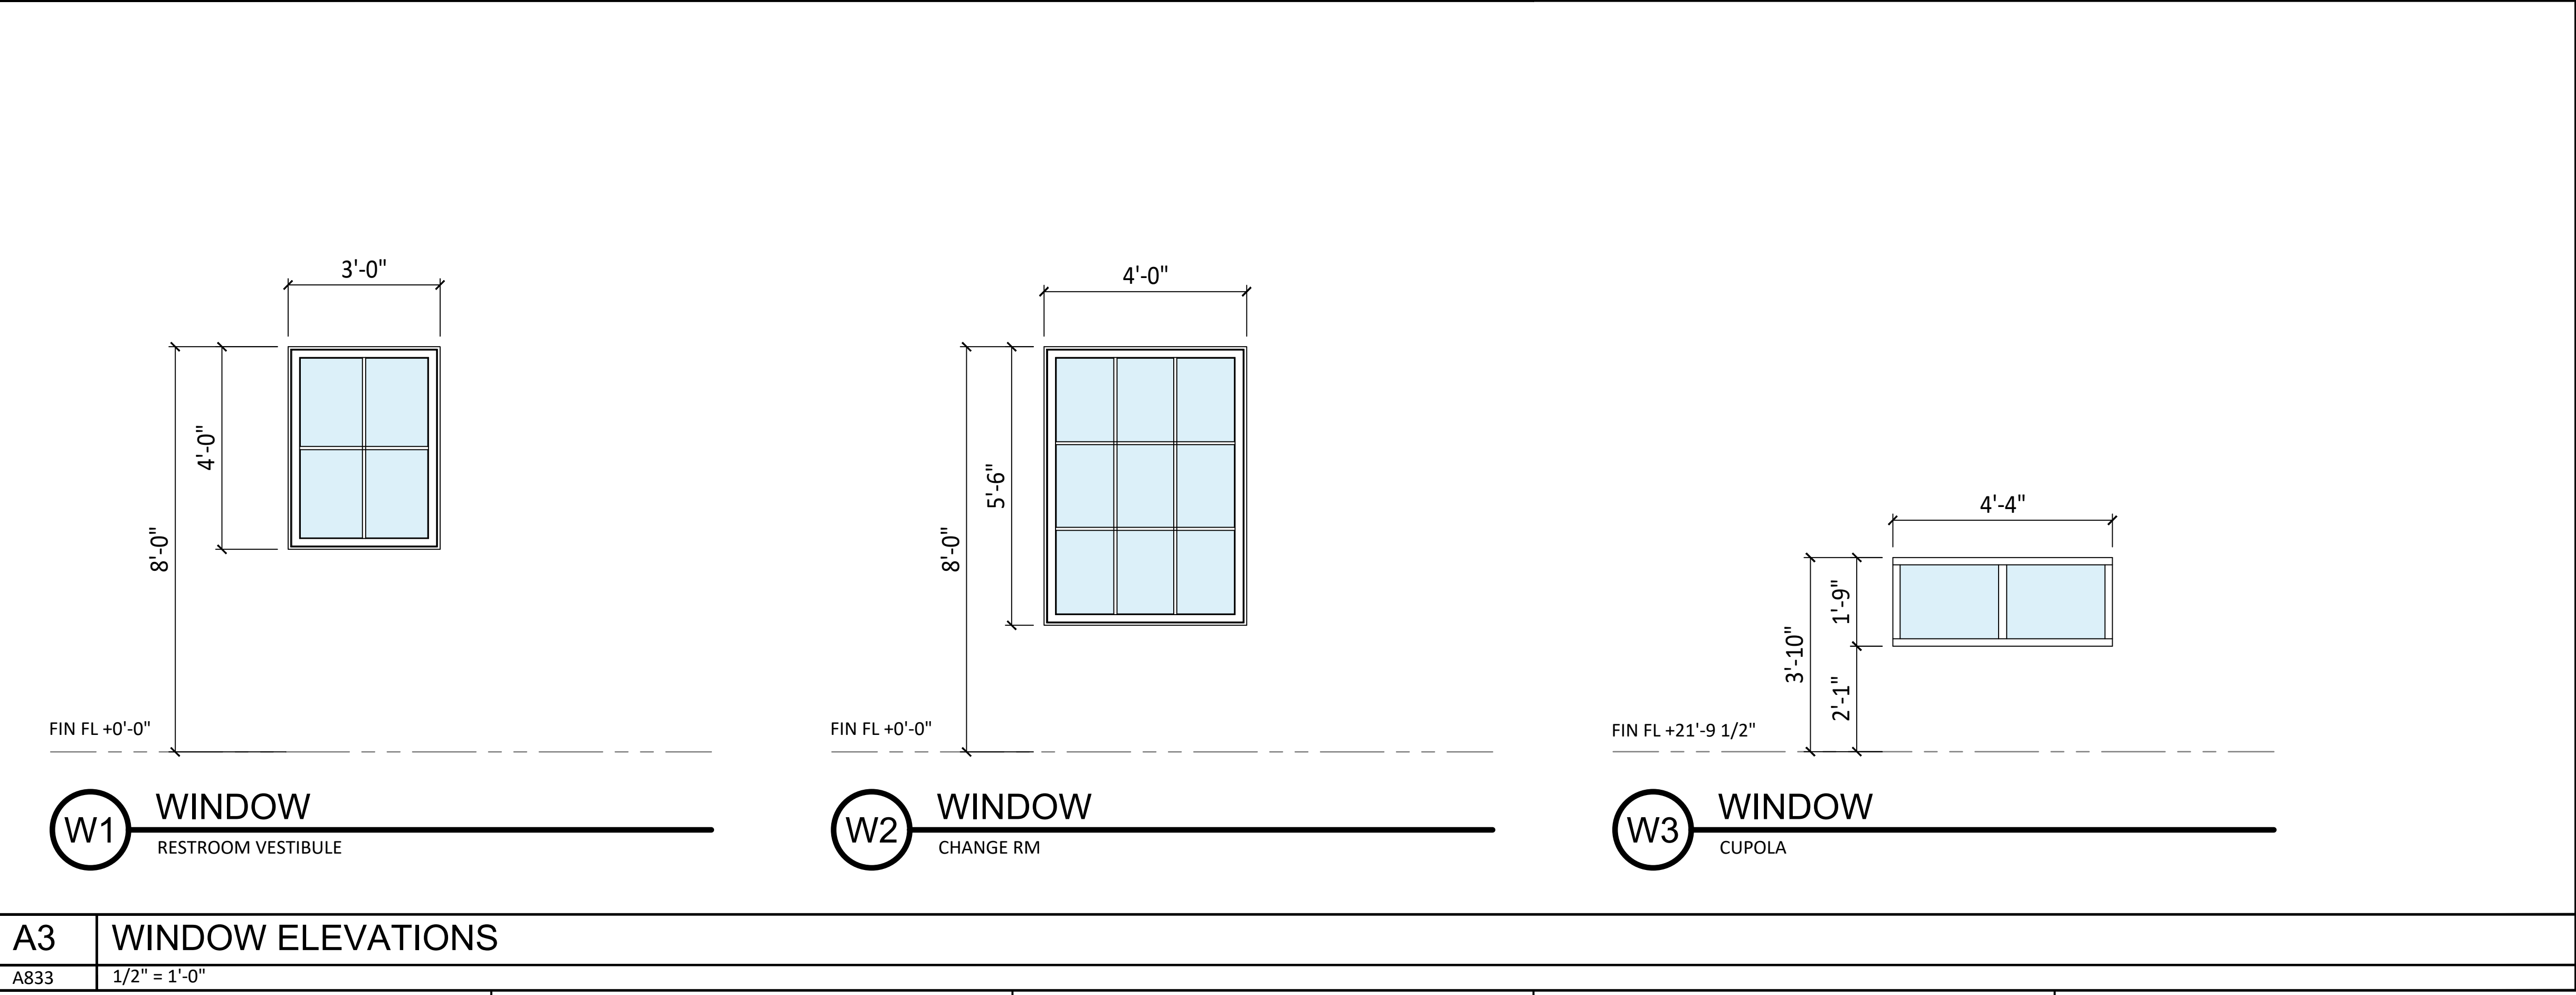
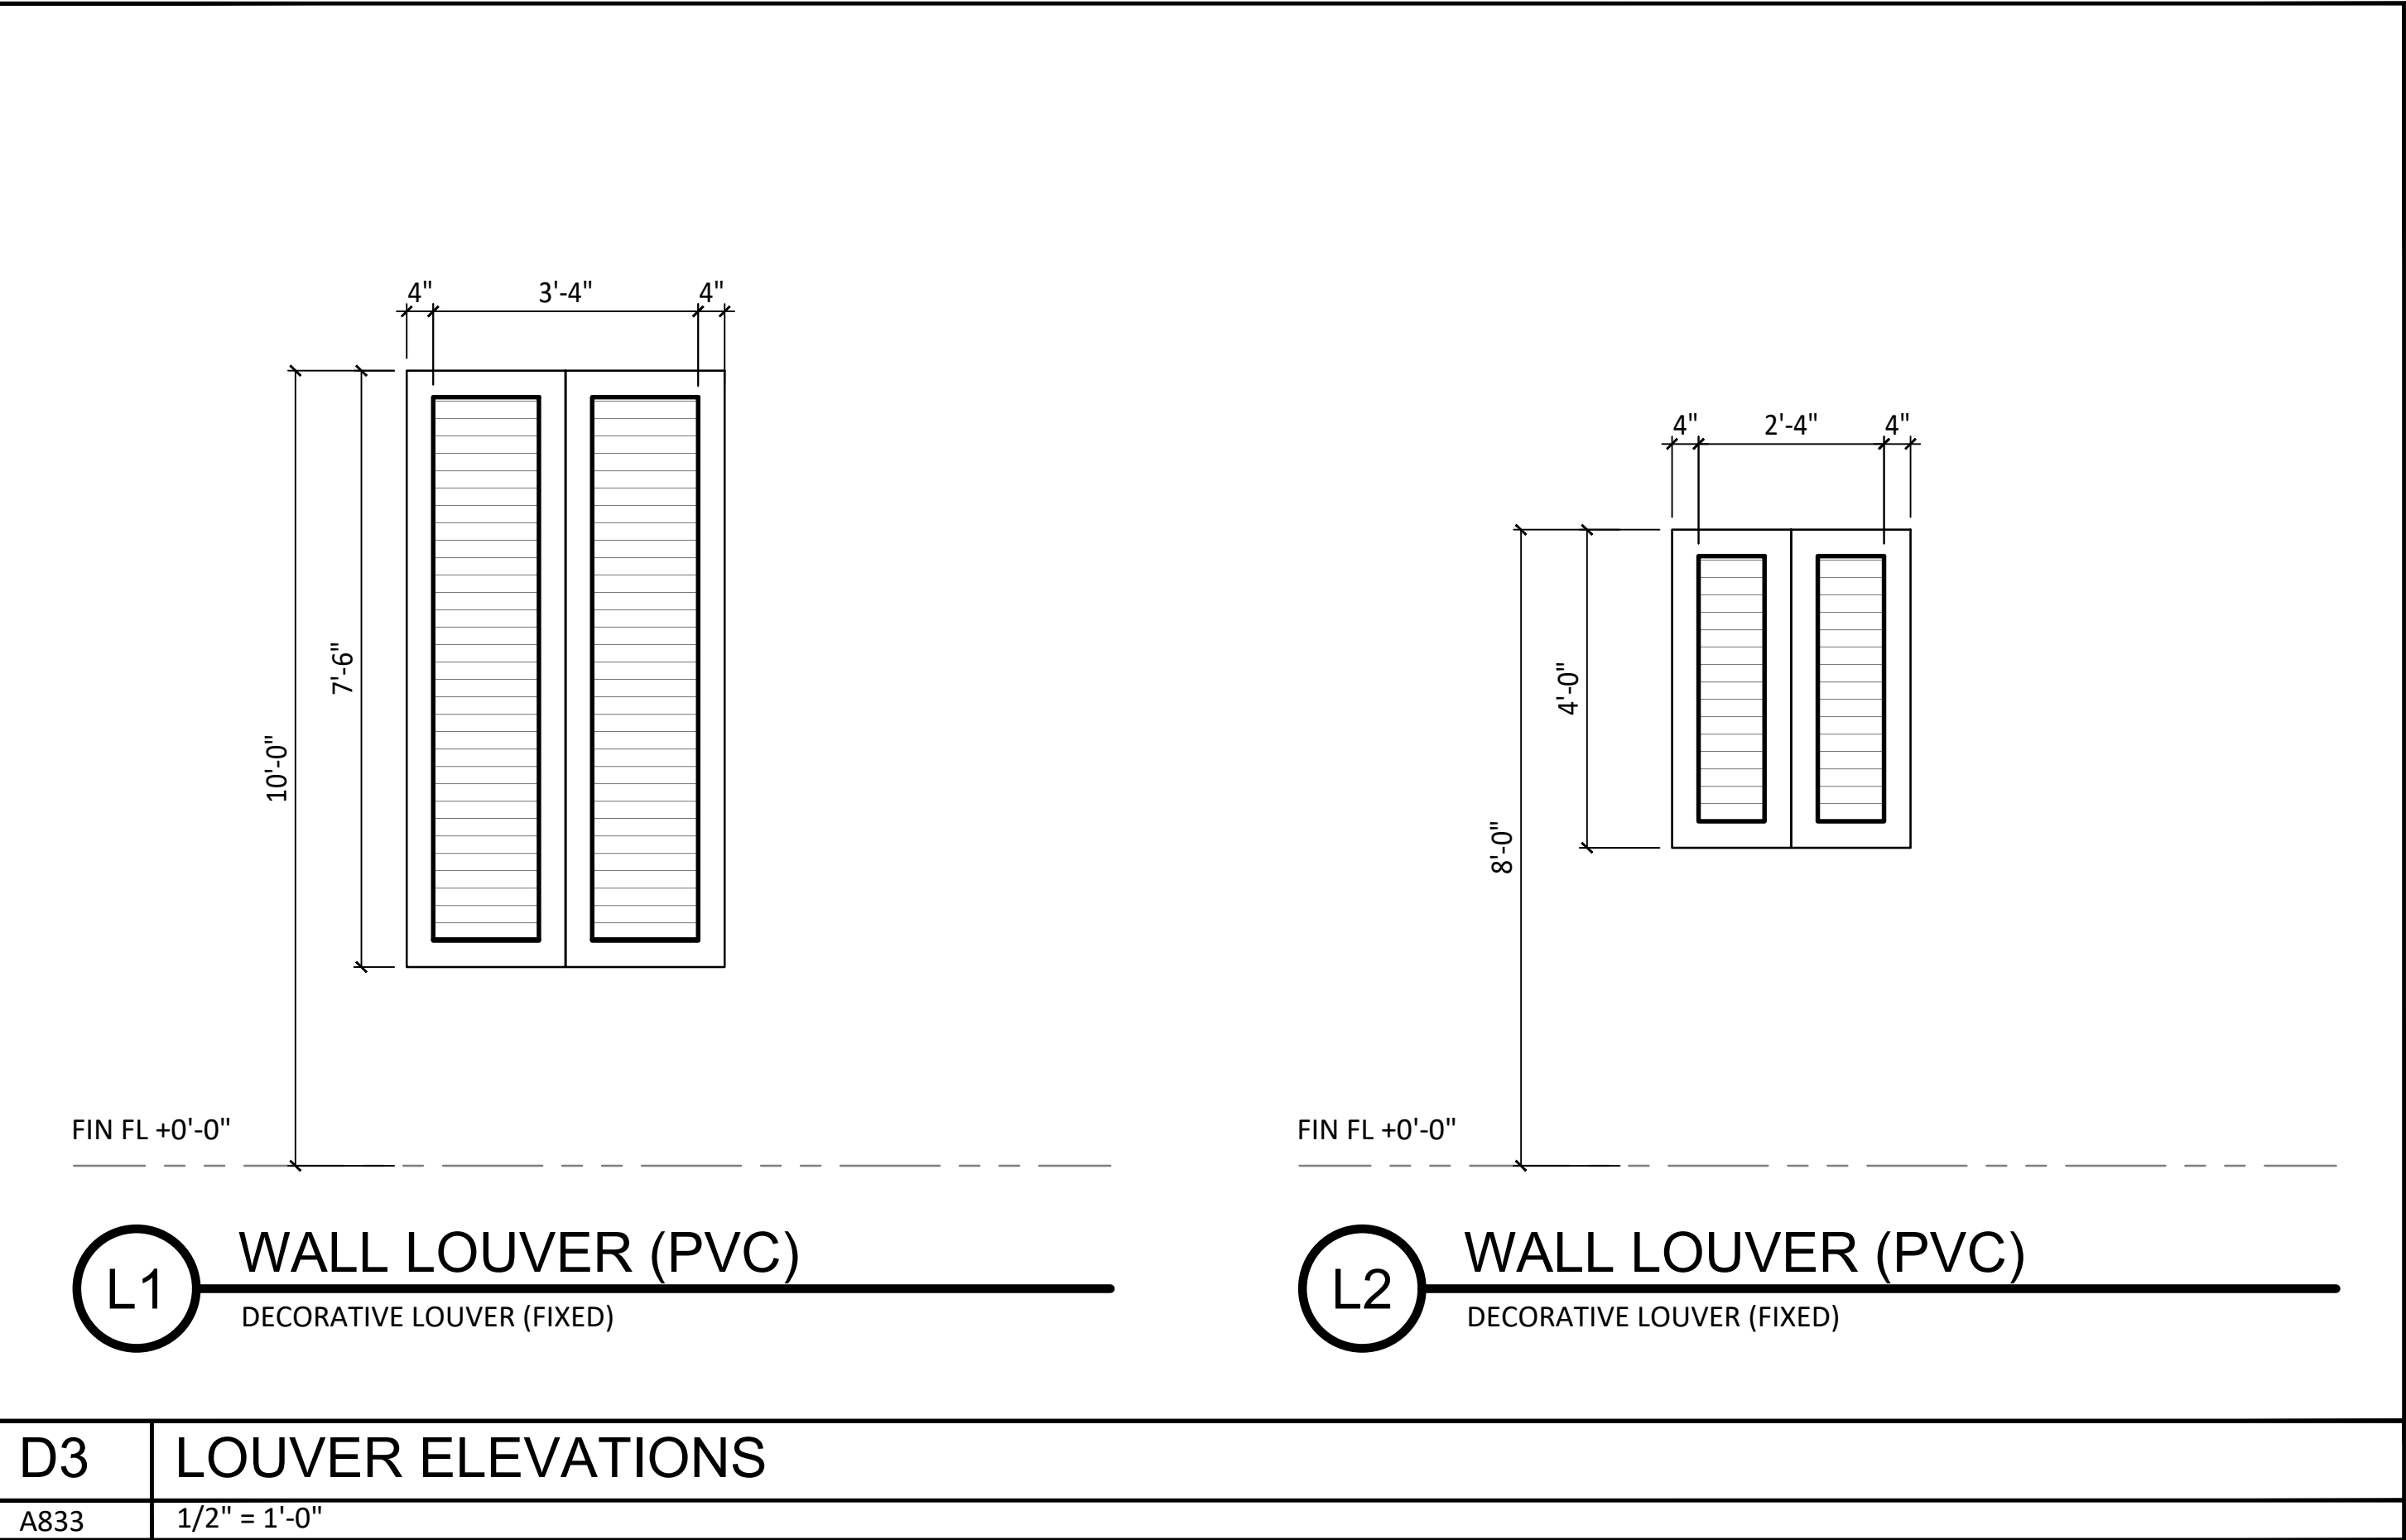


 KUO DIERICH CHI		730 PEACHTREE STREET, NE STUDIO 325 ATLANTA, GEORGIA 30308 678.244.6270 www.KDCarchitects.com
ARCHITECT:		
ARCH. REG. AR91344		
CONSULTANT:		
REVISIONS		
DATE:	DESCRIPTION:	
10/18/24	SCHEMATIC DESIGN	
7/24/25	DESIGN DEVELOPMENT	
10/23/25	50% CONSTRUCTION DOCS	
11/14/25	PERMIT SET	
PROJECT:		
SERENITY SEASIDE RESORT		
BUILDING #3		
BEACH CLUB		
186 SOUTH BAY SHORE DRIVE, EASTPOINT, FL 32328		
Serenity Seaside Operations, LLC 174 Watercolor Way, PMB 410 Santa Rosa Beach, Florida 32459		
JOB NUMBER: 23019.3		
DATE: --/--/----		
TITLE:		
WINDOW & LOUVER ELEVATIONS		
SHEET:		
A833		



A834

K:\Projects\23\23019\DWG\Serenity_Bldg-3_Beach_Club\Sheets\23019_3-A835.dwg Plotted: Nov 14, 2025 - 1:21pm by Caeblawrence

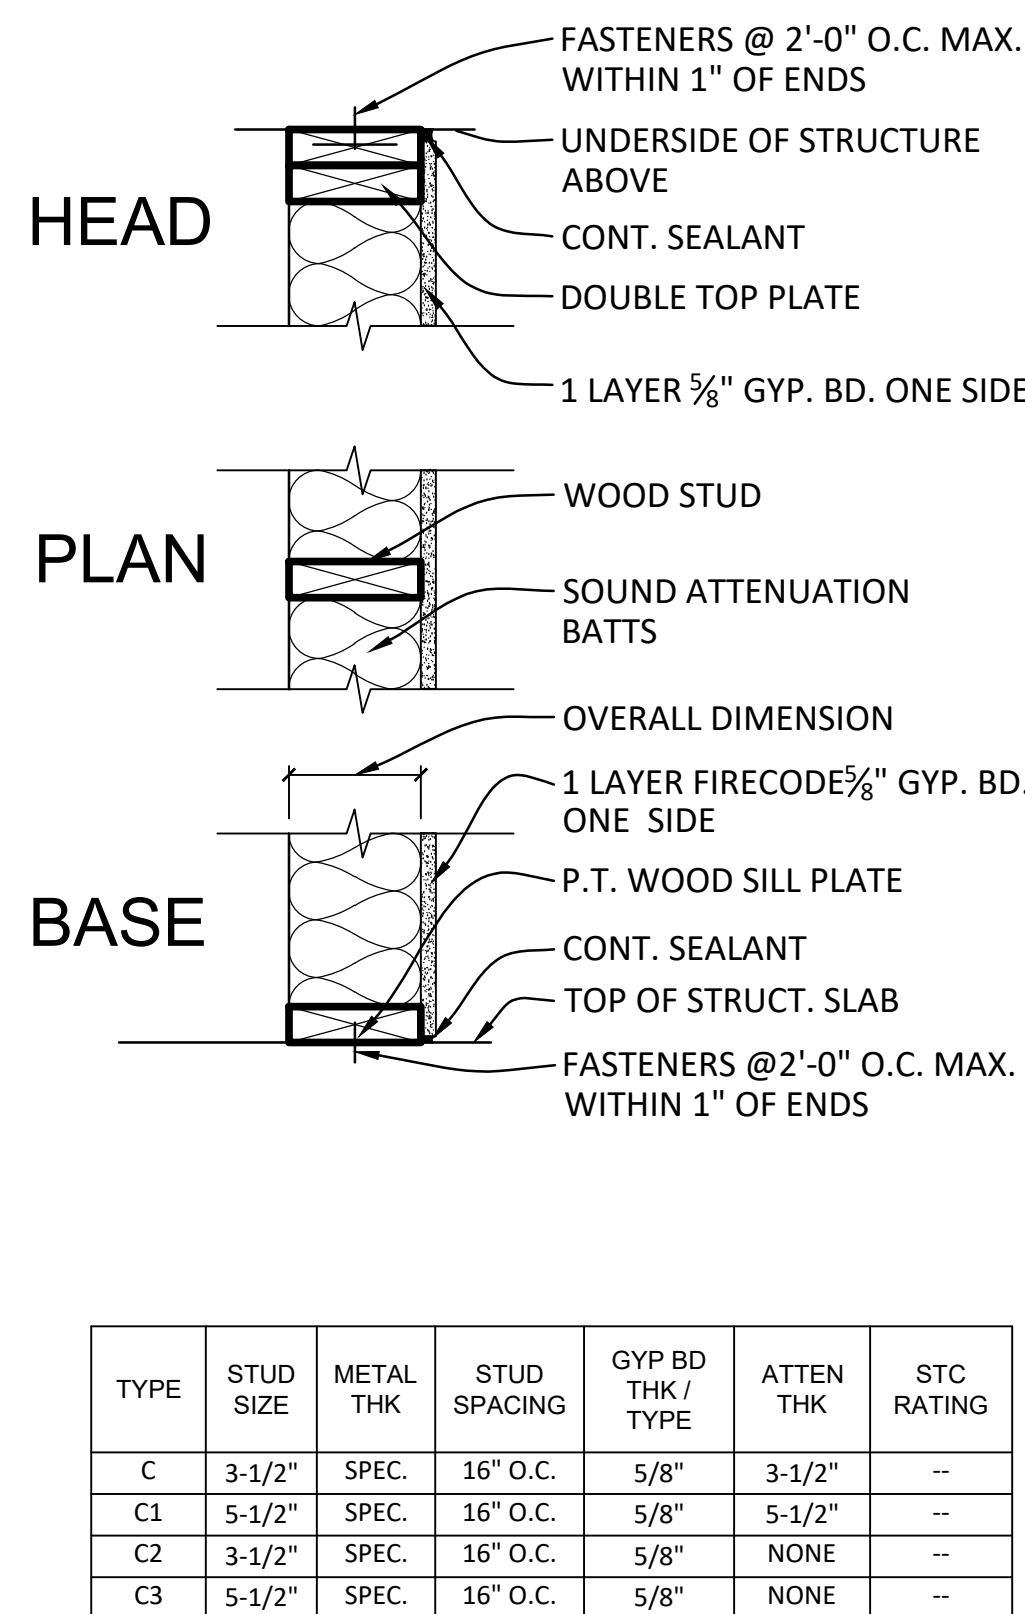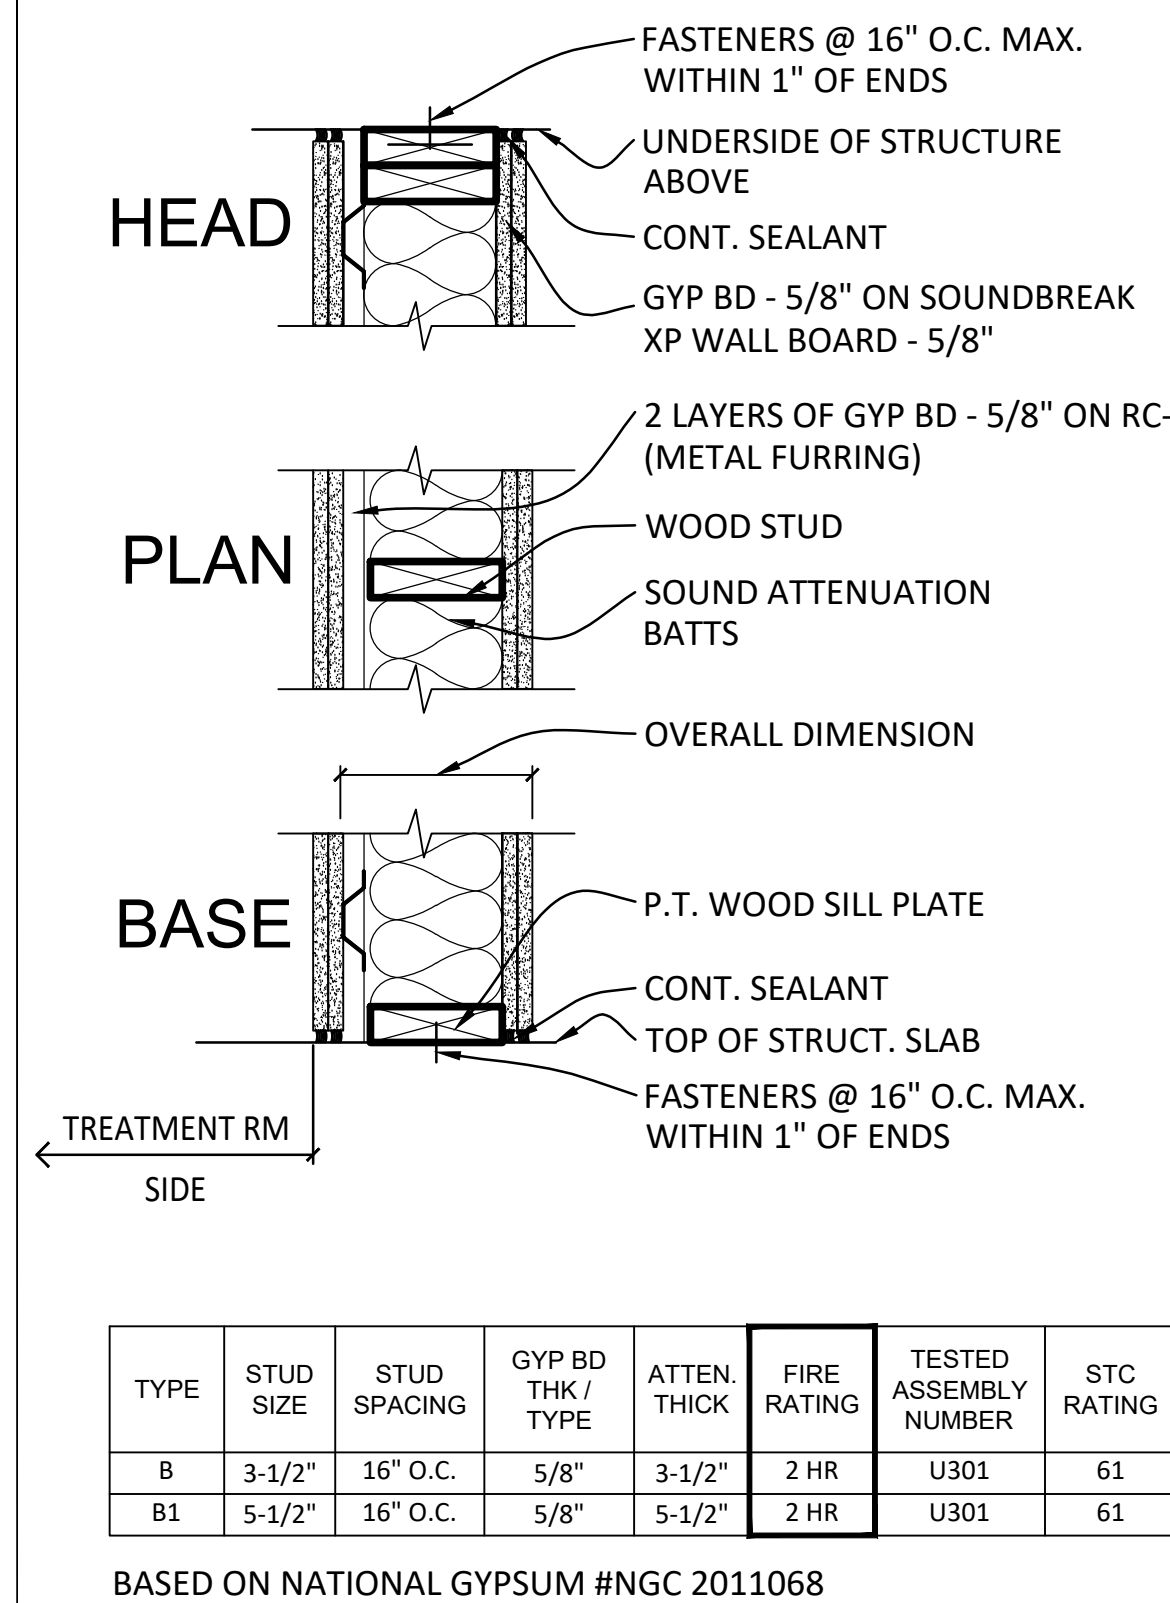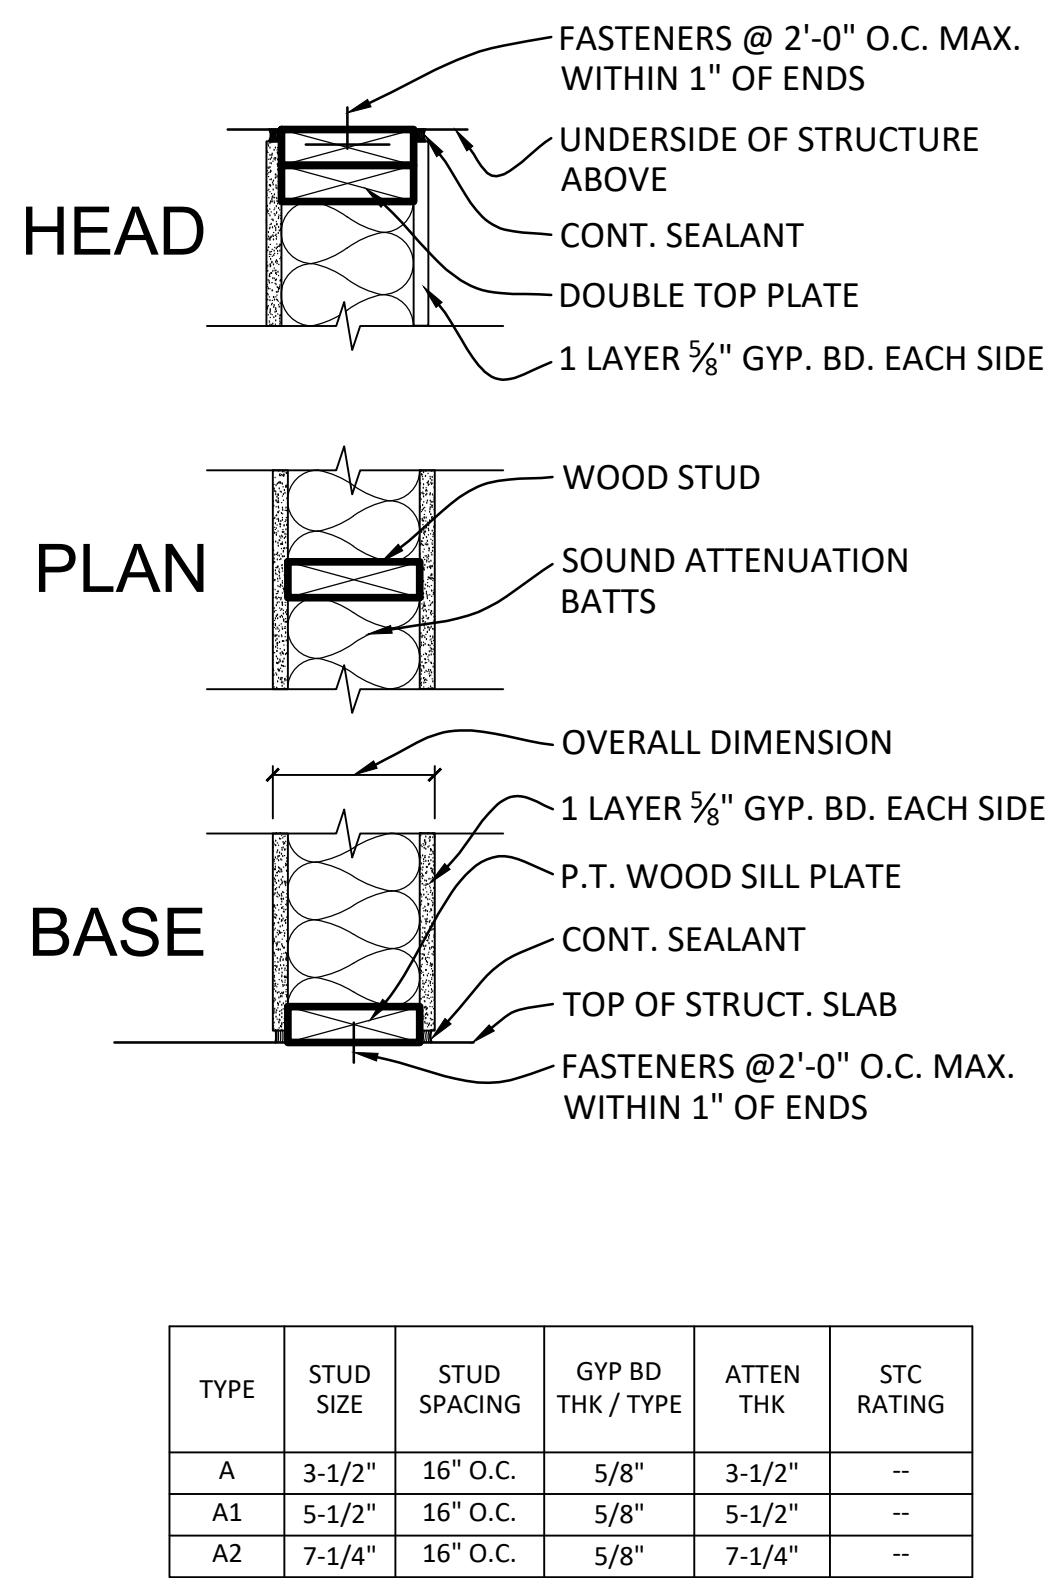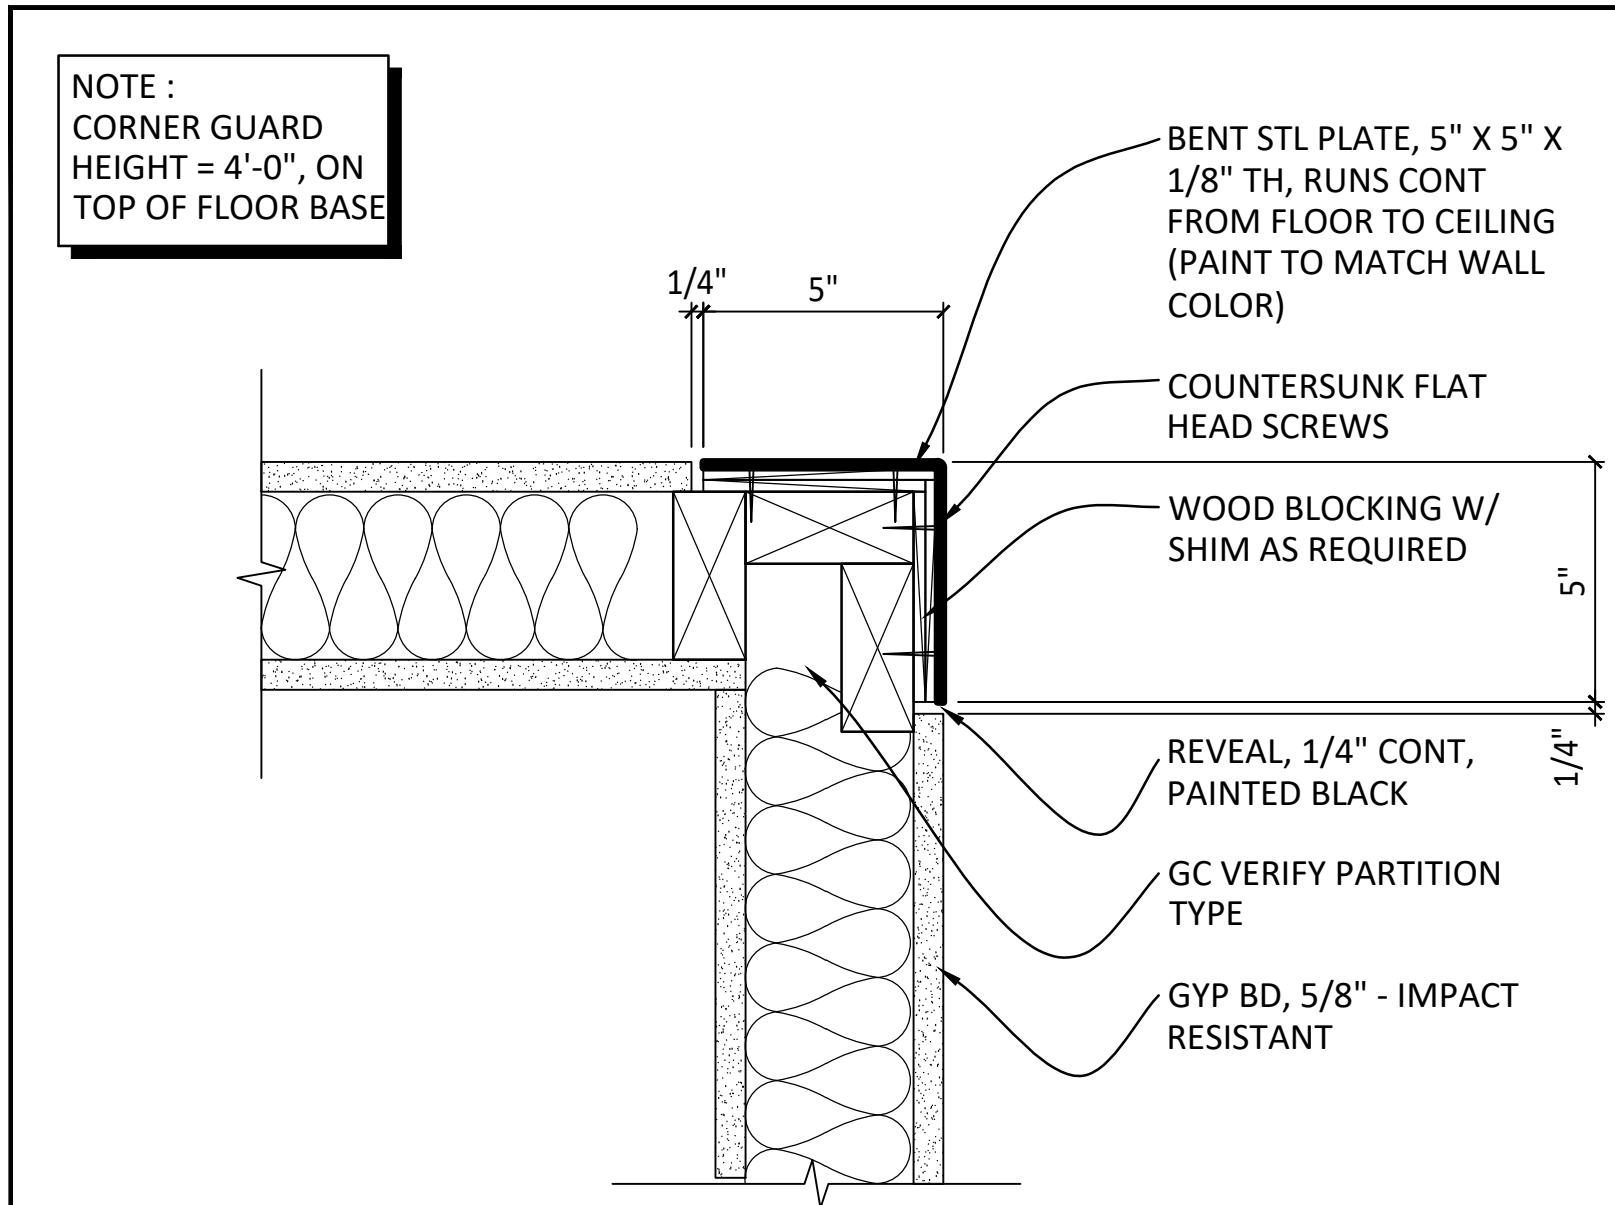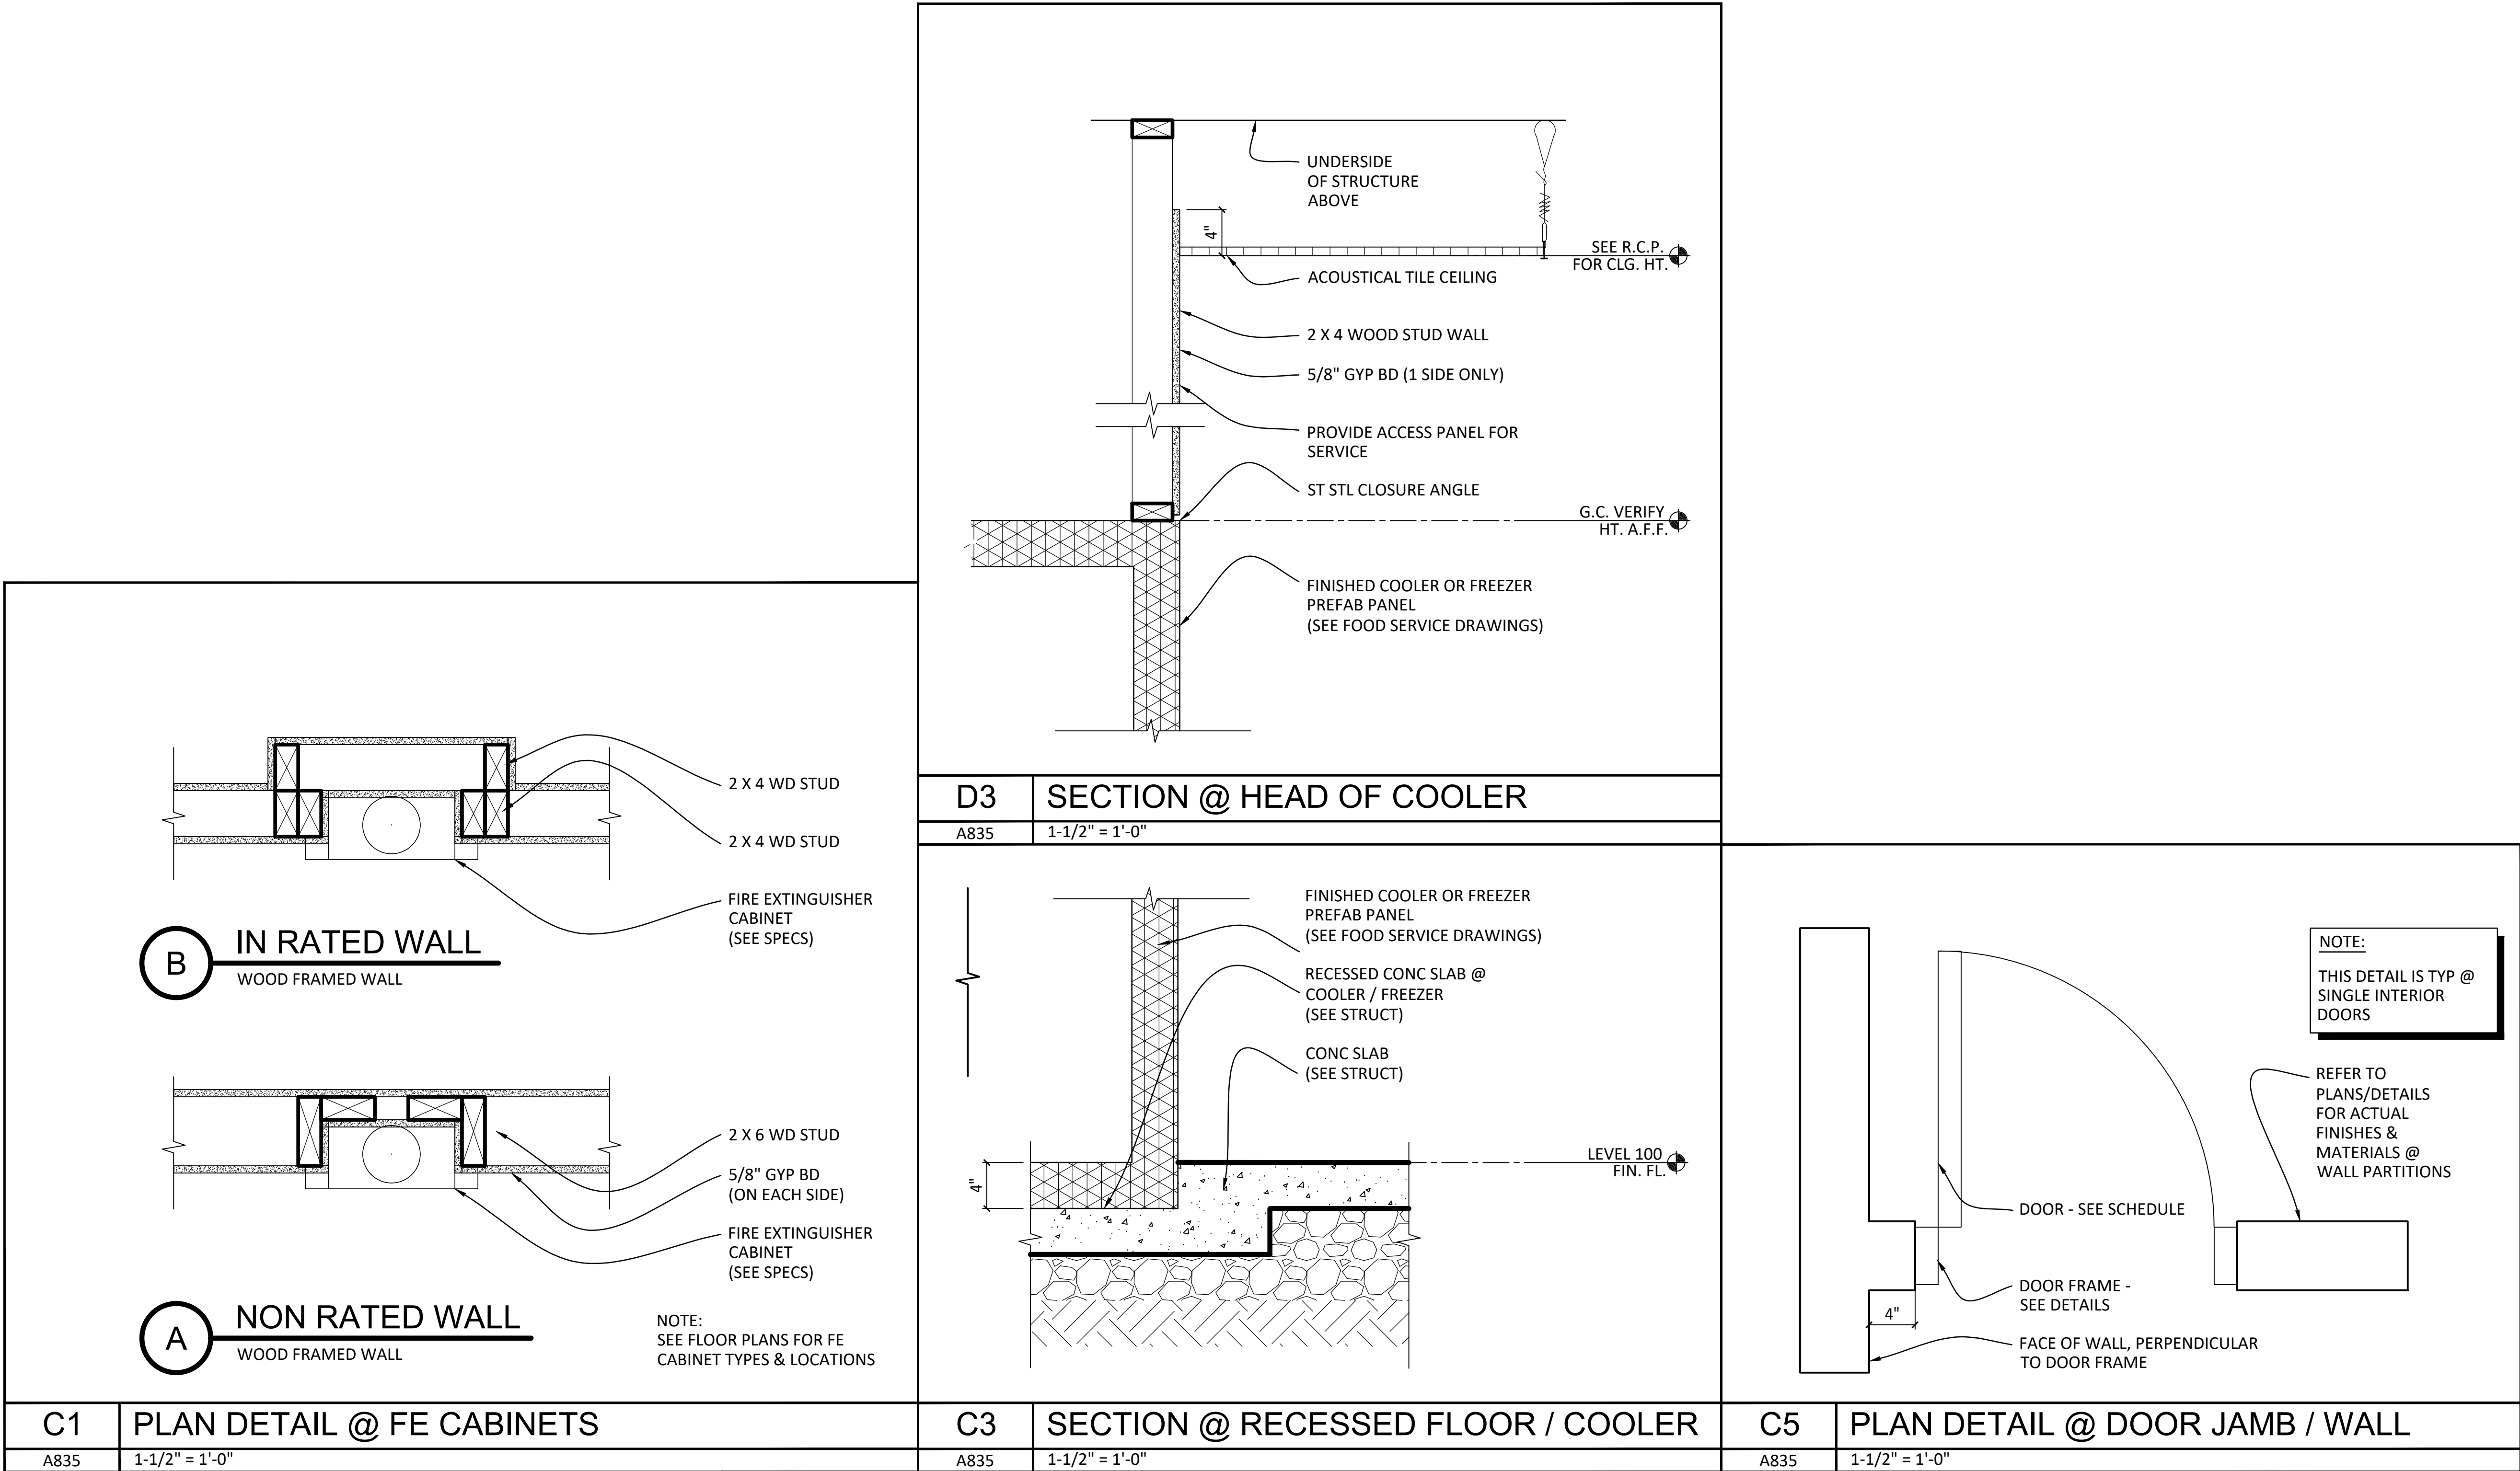

PARTITION NOTES

- ALL INTERIOR PARTITIONS SHALL BE TYPE "A", UNLESS NOTED OTHER WISE ON FLOOR PLANS
- METAL STUDS USED IN INTERIOR PARTITIONS & SOFFIT FRAMING ARE MIN 25 GA AT 16" O/C MAX SPACING UNLESS NOTED OTHERWISE
- ALL PARTITIONS TERMINATE AT UNDERSIDE OF STRUCTURE ABOVE UNLESS NOTED OTHERWISE
- PROVIDE SOUND ATTENUATION BATTS AT ALL TOILET ROOMS AND OFFICES W/ METAL STUD WALLS TYP
- PROVIDE 5/8" TILE BACKER BOARD (W/ TAPED SEAMS & CORNERS) IN LIEU OF GYP BD AT ALL TILE WAINSCOT WALLS (SEE ID FINISH SCHEDULE)
- INTERIOR PARTITION LIMITING HEIGHT SHALL BE BASED ON CHARTS PUBLISHED BY UNIMAST, INC. UNLESS OTHER DATA BY THE APPLICABLE LIGHT GAUGE STEEL STUD MANUFACTURER IS SUBMITTED
- INTERIOR METAL STUD PARTITIONS TO ADEQUATELY RESIST THE APPLICABLE DESIGN LOADS INCLUDING THE GRAVITY DESIGN LOADS (FOR LOAD BEARING WALLS) AND A MINIMUM HORIZONTAL DESIGN LOAD OF 5 PSF APPLIED NORMAL TO THE WALL SURFACE
- STEEL MATERIAL FOR STUDS & TRACK FOR SHEAR WALL CONSTRUCTION SHALL HAVE A MIN. THICKNESS OF 20 GAUGE & SHALL COMPLY W/ GRADE 33 REQUIREMENTS OF EITHER ASTM A 653 SS, ASTM A792 SS, OR ASTM A 875 SS.
- ALL FIRE BARRIER WALLS SHALL EXTEND FULL HEIGHT FROM THE TOP OF FLOOR ASSEMBLY BELOW, TIGHT TO UNDERSIDE OF FLOOR / ROOF SLAB / DECK
- PROVIDE 5/8" MOISTURE RESISTANT GYP BD ON ALL WALLS/CEILINGS ADJ TO PLUMBING FIXTURES (THAT DO NOT HAVE TILE BACKER BOARD)
- SEE SHEET A861 FOR TOP OF WALL DETAILS
- COORDINATE FINAL WALL FINISH ON ALL PARTITIONS WITH ID FINISH SCHEDULE



730 PEACHTREE STREET, NE
STUDIO 325
ATLANTA, GEORGIA 30308
678.244.6270

www.KDCarchitects.com

ARCHITECT:

ARCH. REG: AR91344

CONSULTANT:

REVISIONS

DATE:	DESCRIPTION:
10/18/24	SCHEMATIC DESIGN
7/24/25	DESIGN DEVELOPMENT
10/23/25	50% CONSTRUCTION DOCS
11/14/25	PERMIT SET

PROJECT:

SERENITY SEASIDE
RESORT

BUILDING #3
**BEACH
CLUB**

186 SOUTH BAY
SHORE DRIVE,
EASTPOINT, FL
32328

Serenity Seaside
Operations, LLC
174 Watercolor Way, PMB 410
Santa Rosa Beach, Florida 32459

JOB NUMBER: 23019.3

DATE: --/--/----


TITLE:

**INTERIOR
PARTITION
DETAILS**




SHEET:

A835

K:\Projects\23\23019\OWB\Serenity_Bldg-3_Beach_Club\Sheets\23019.3-A931.dwg Plotted: Nov 14, 2025 - 1:22pm by CalebLawrence

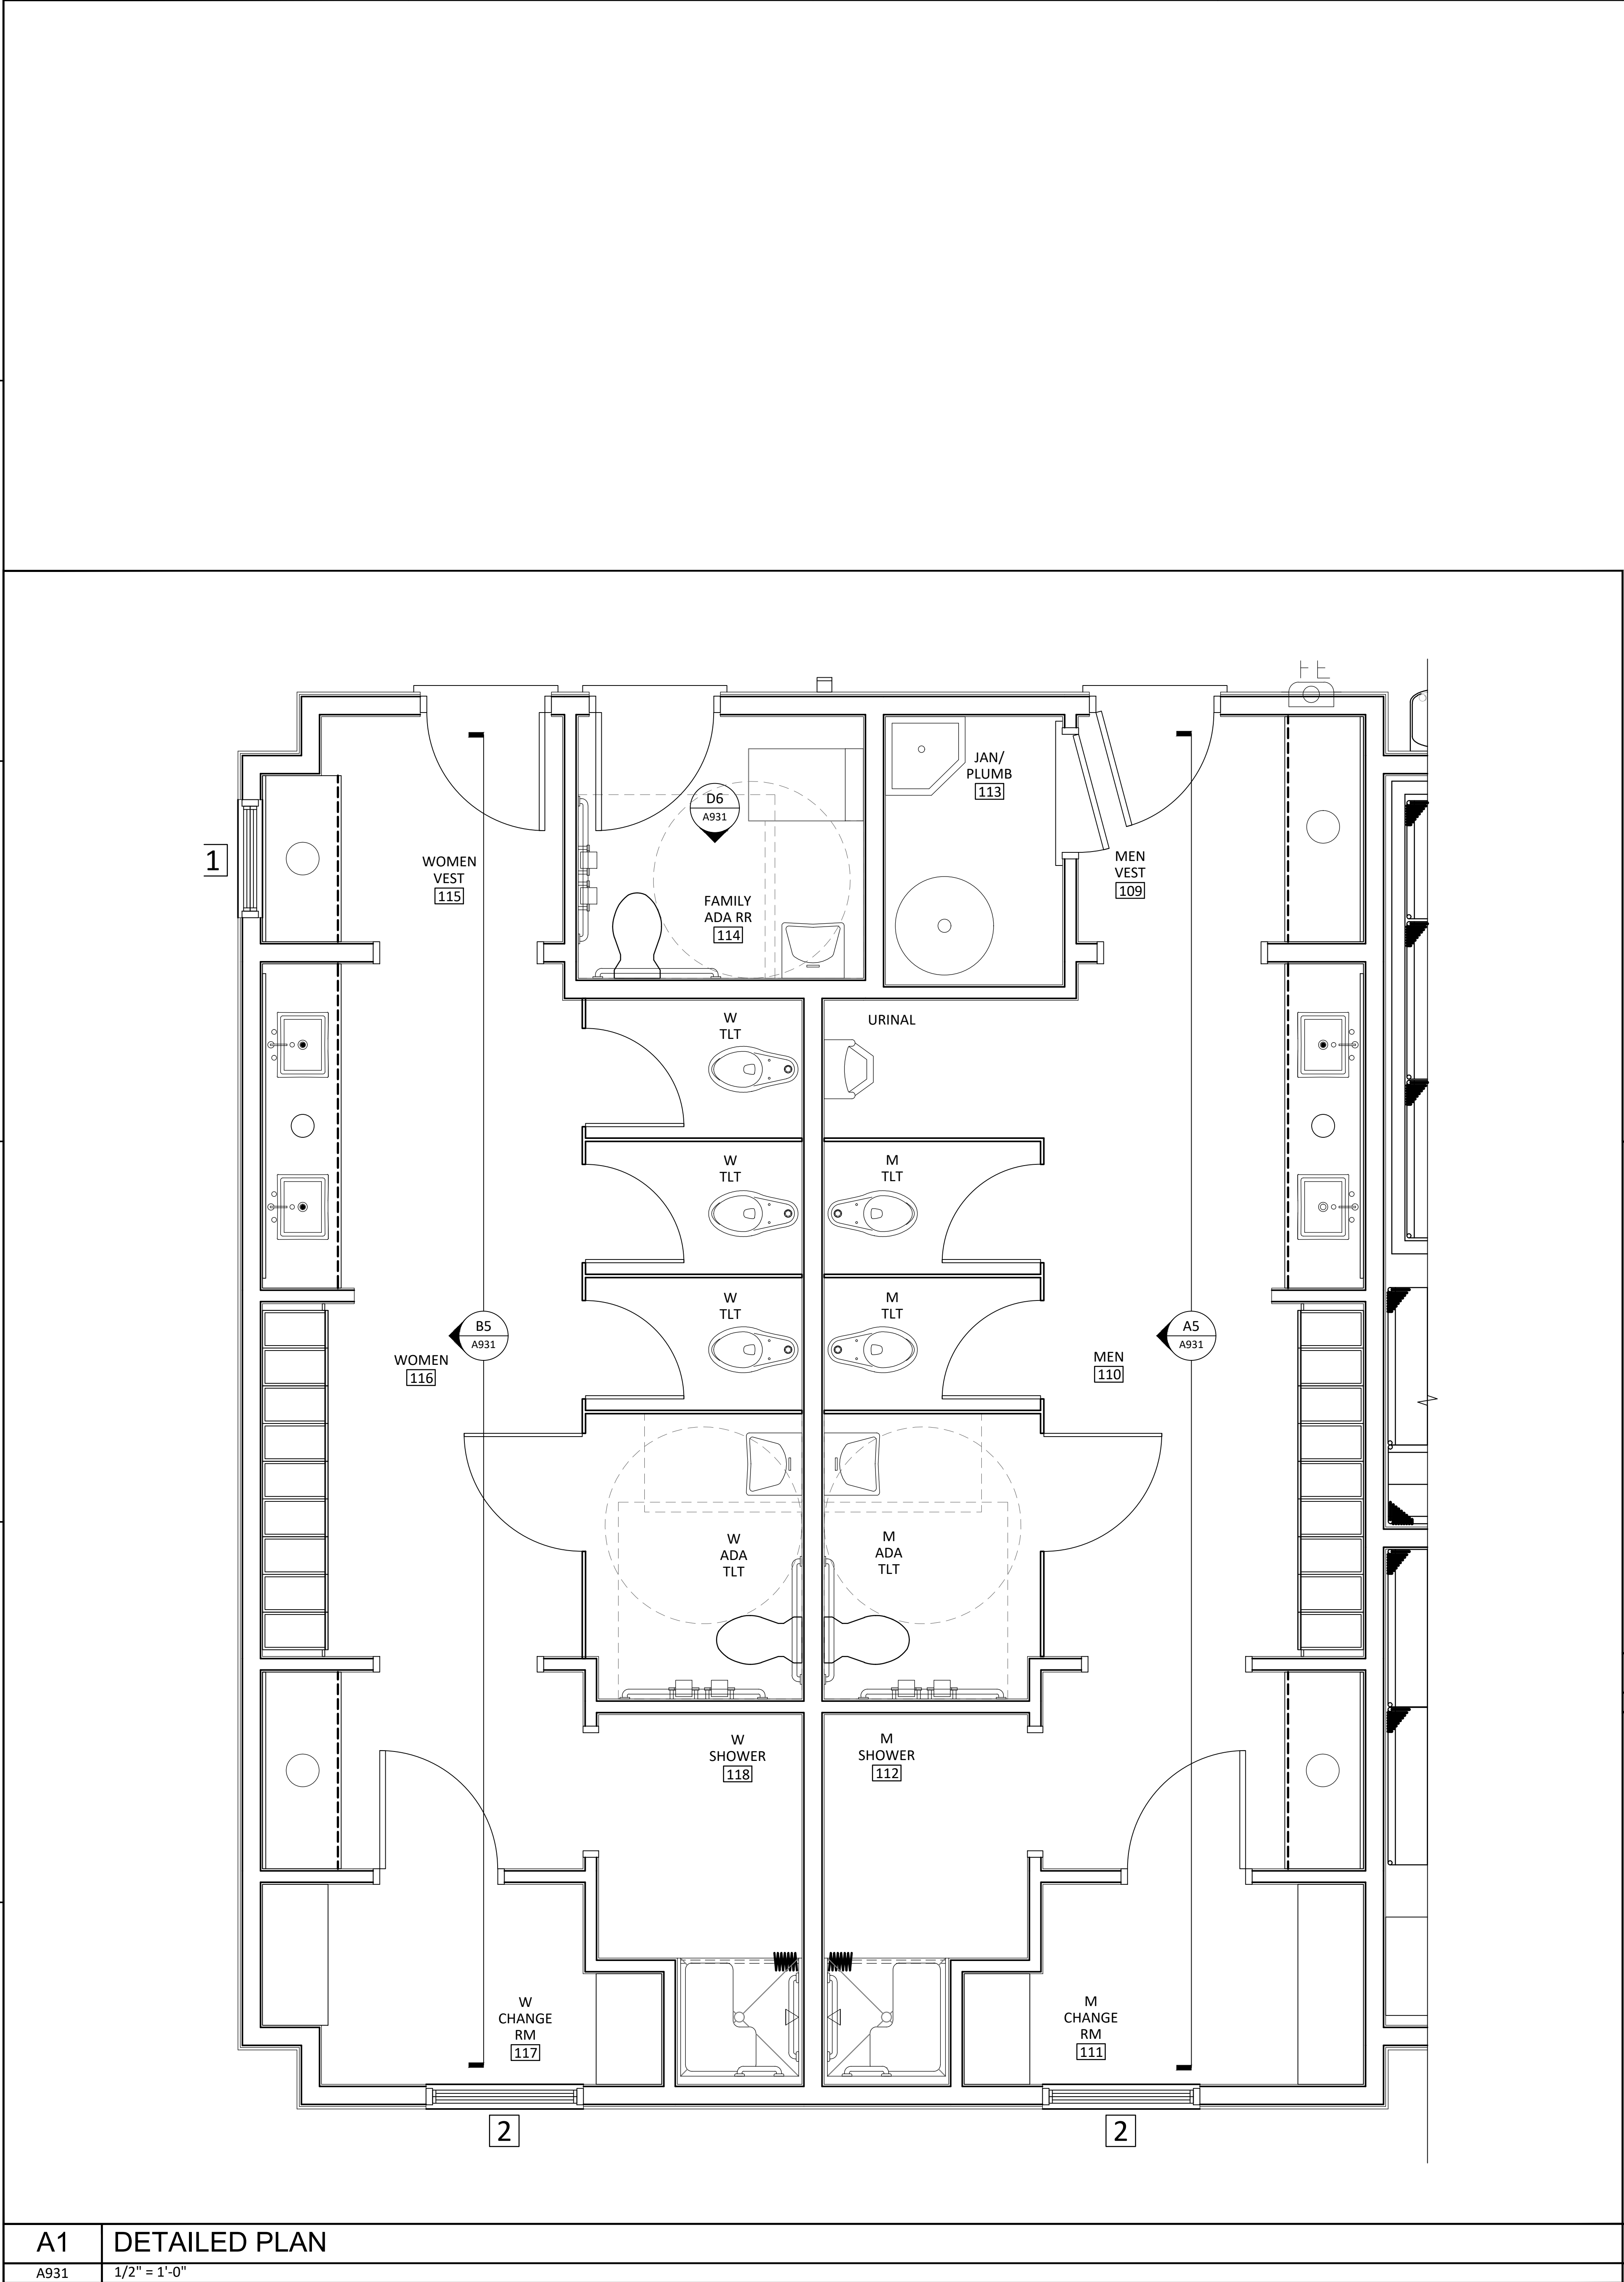

SHEET NOTES / LEGEND	
1.	-
GENERAL NOTES	
A.	-

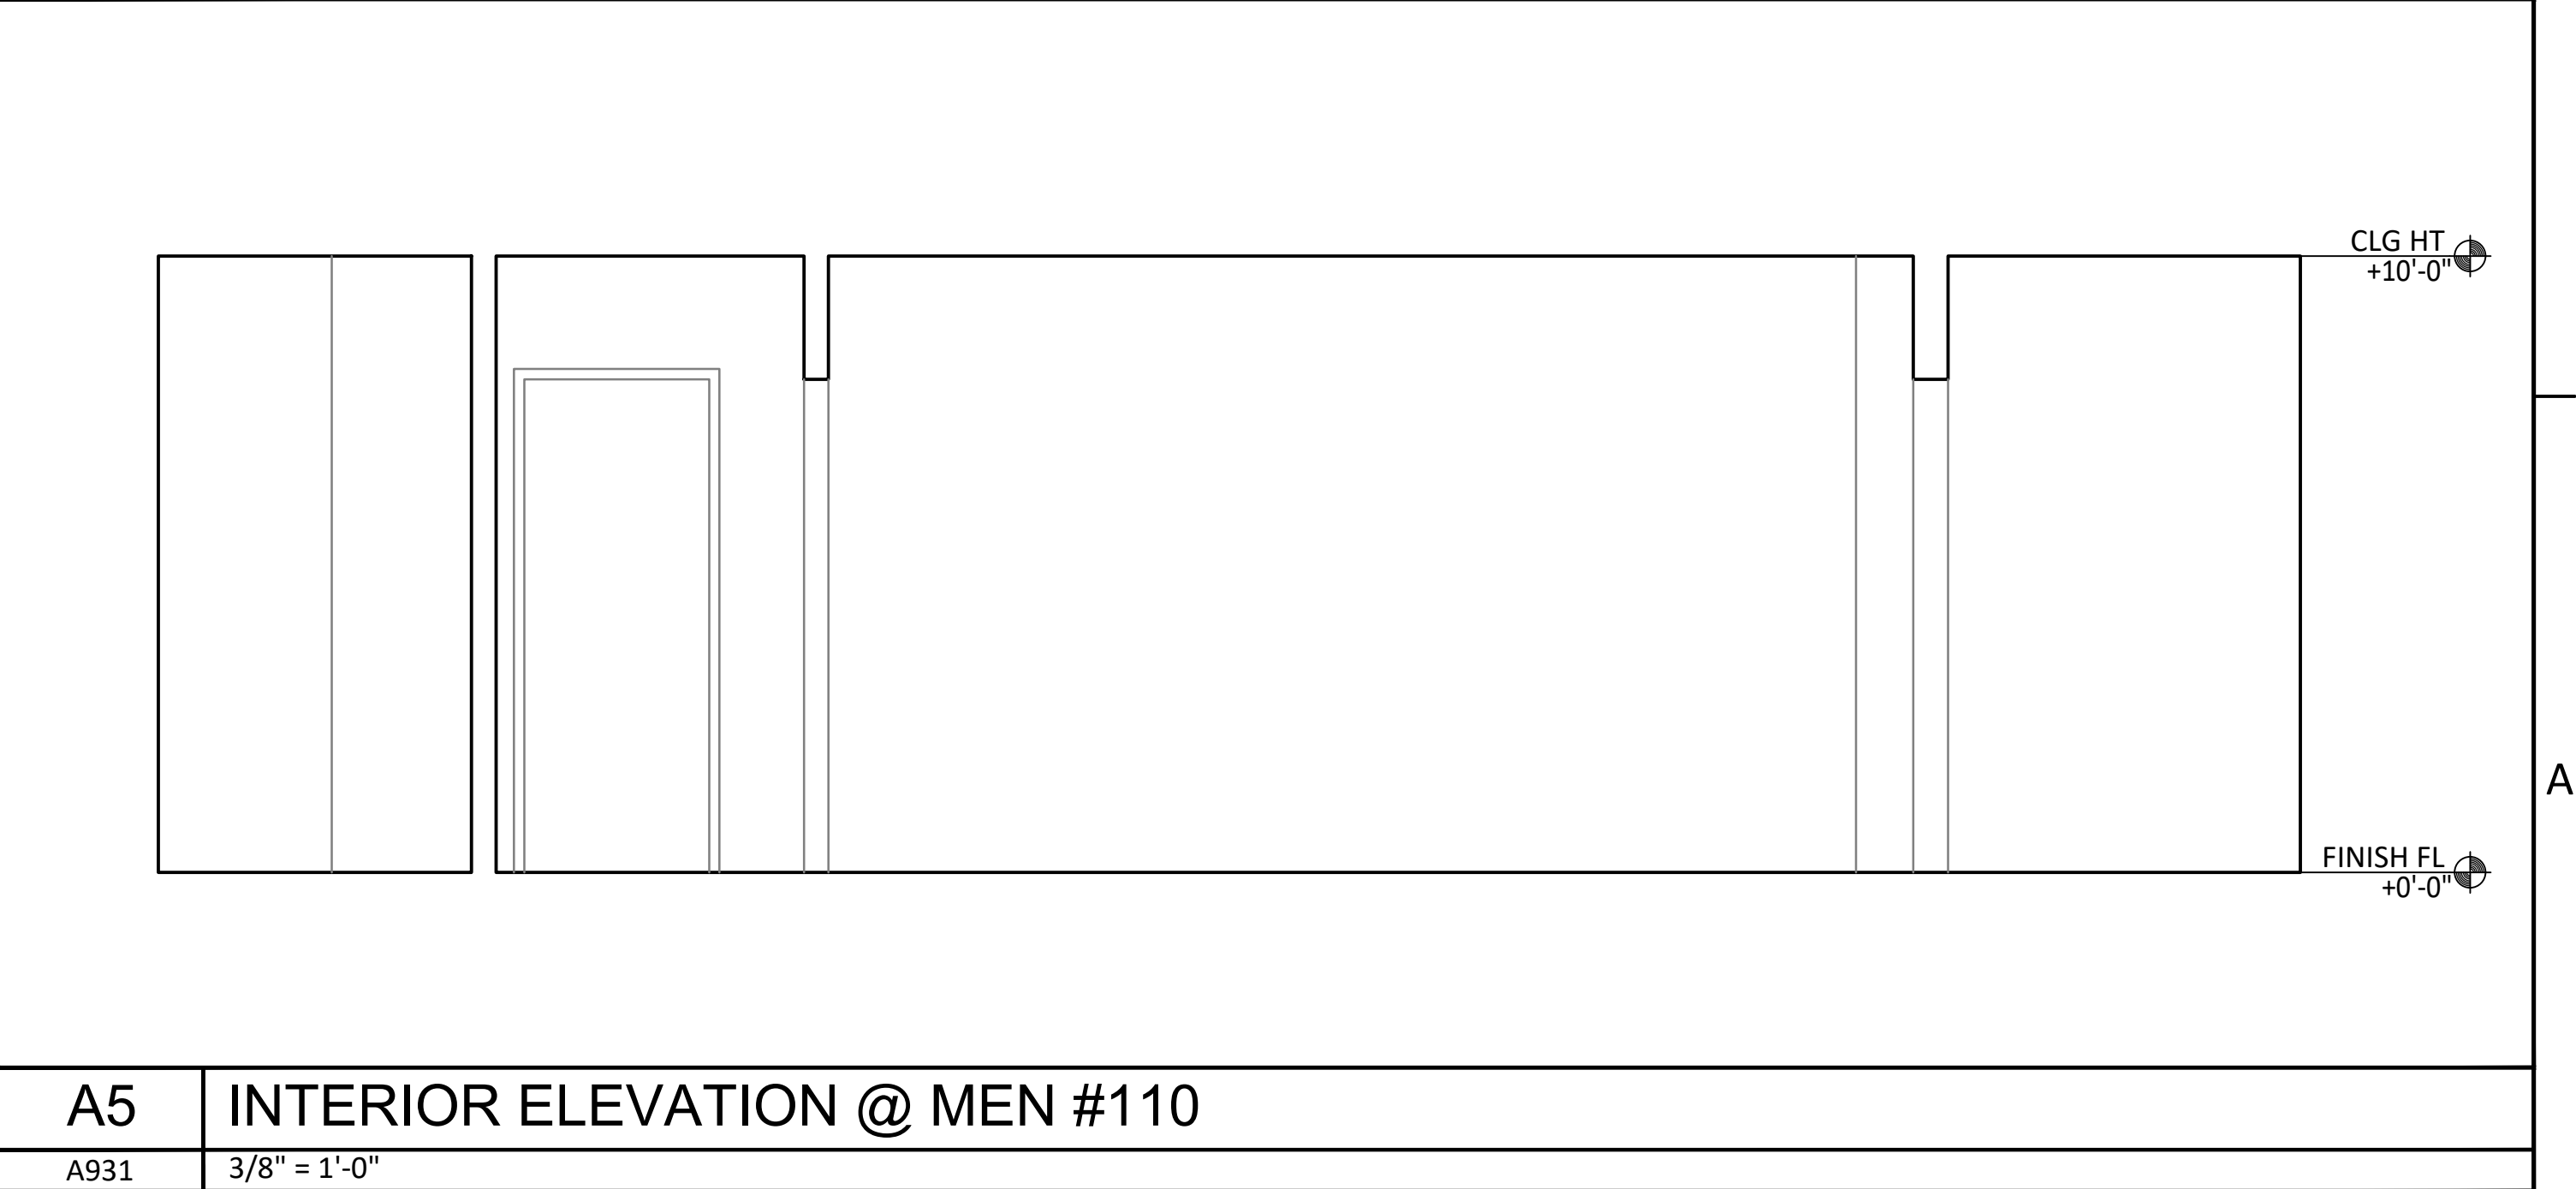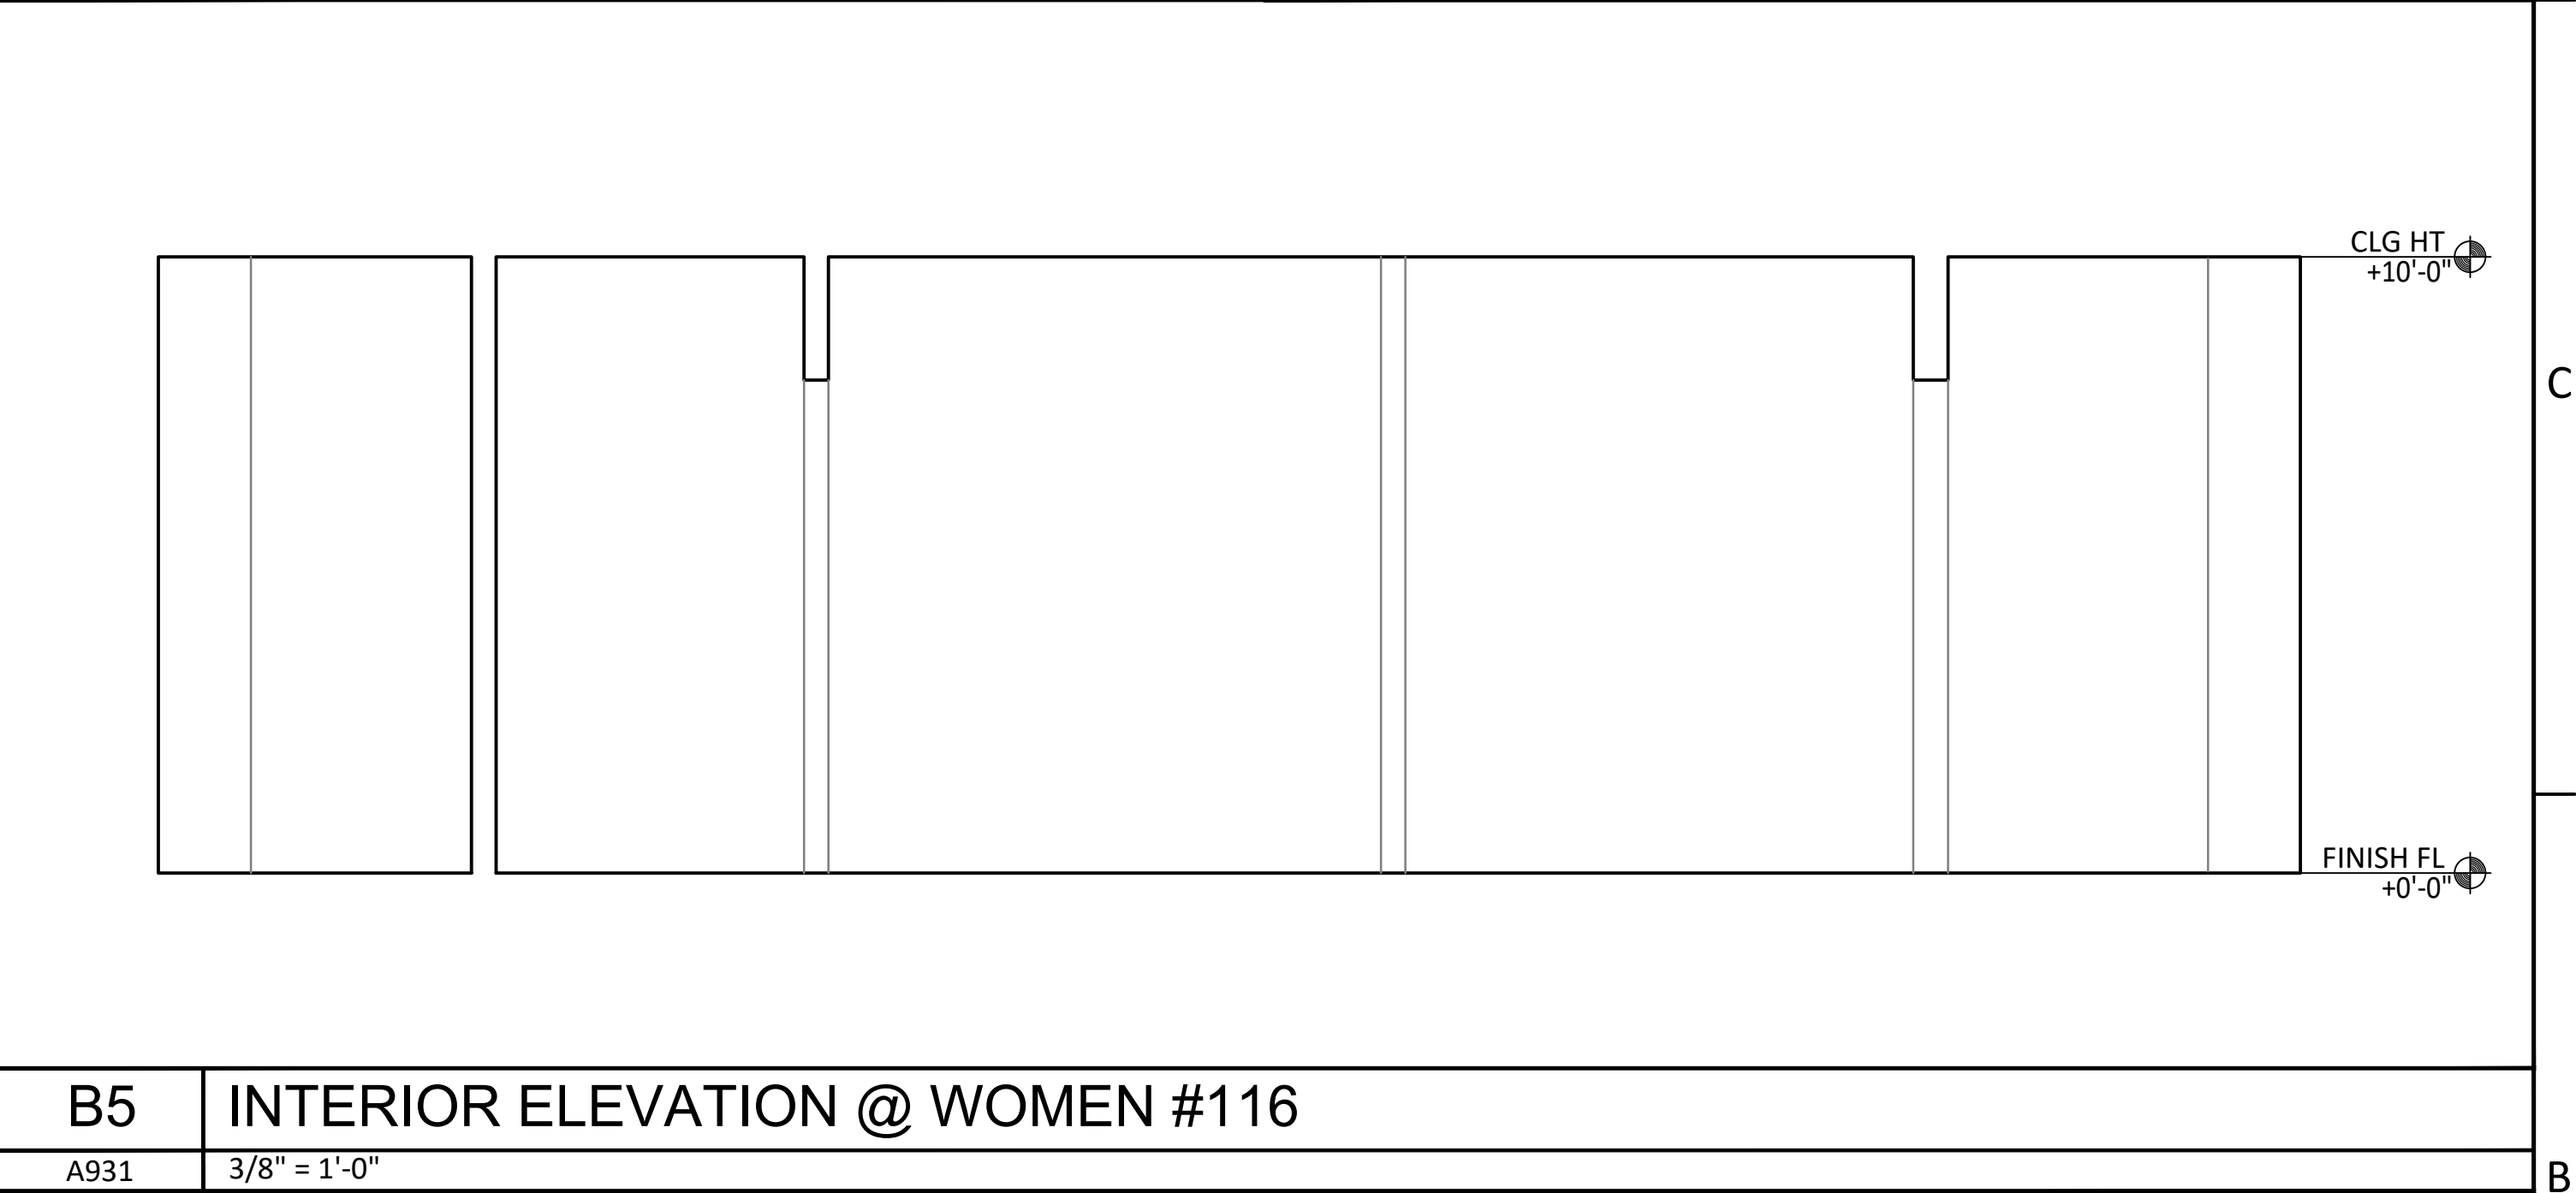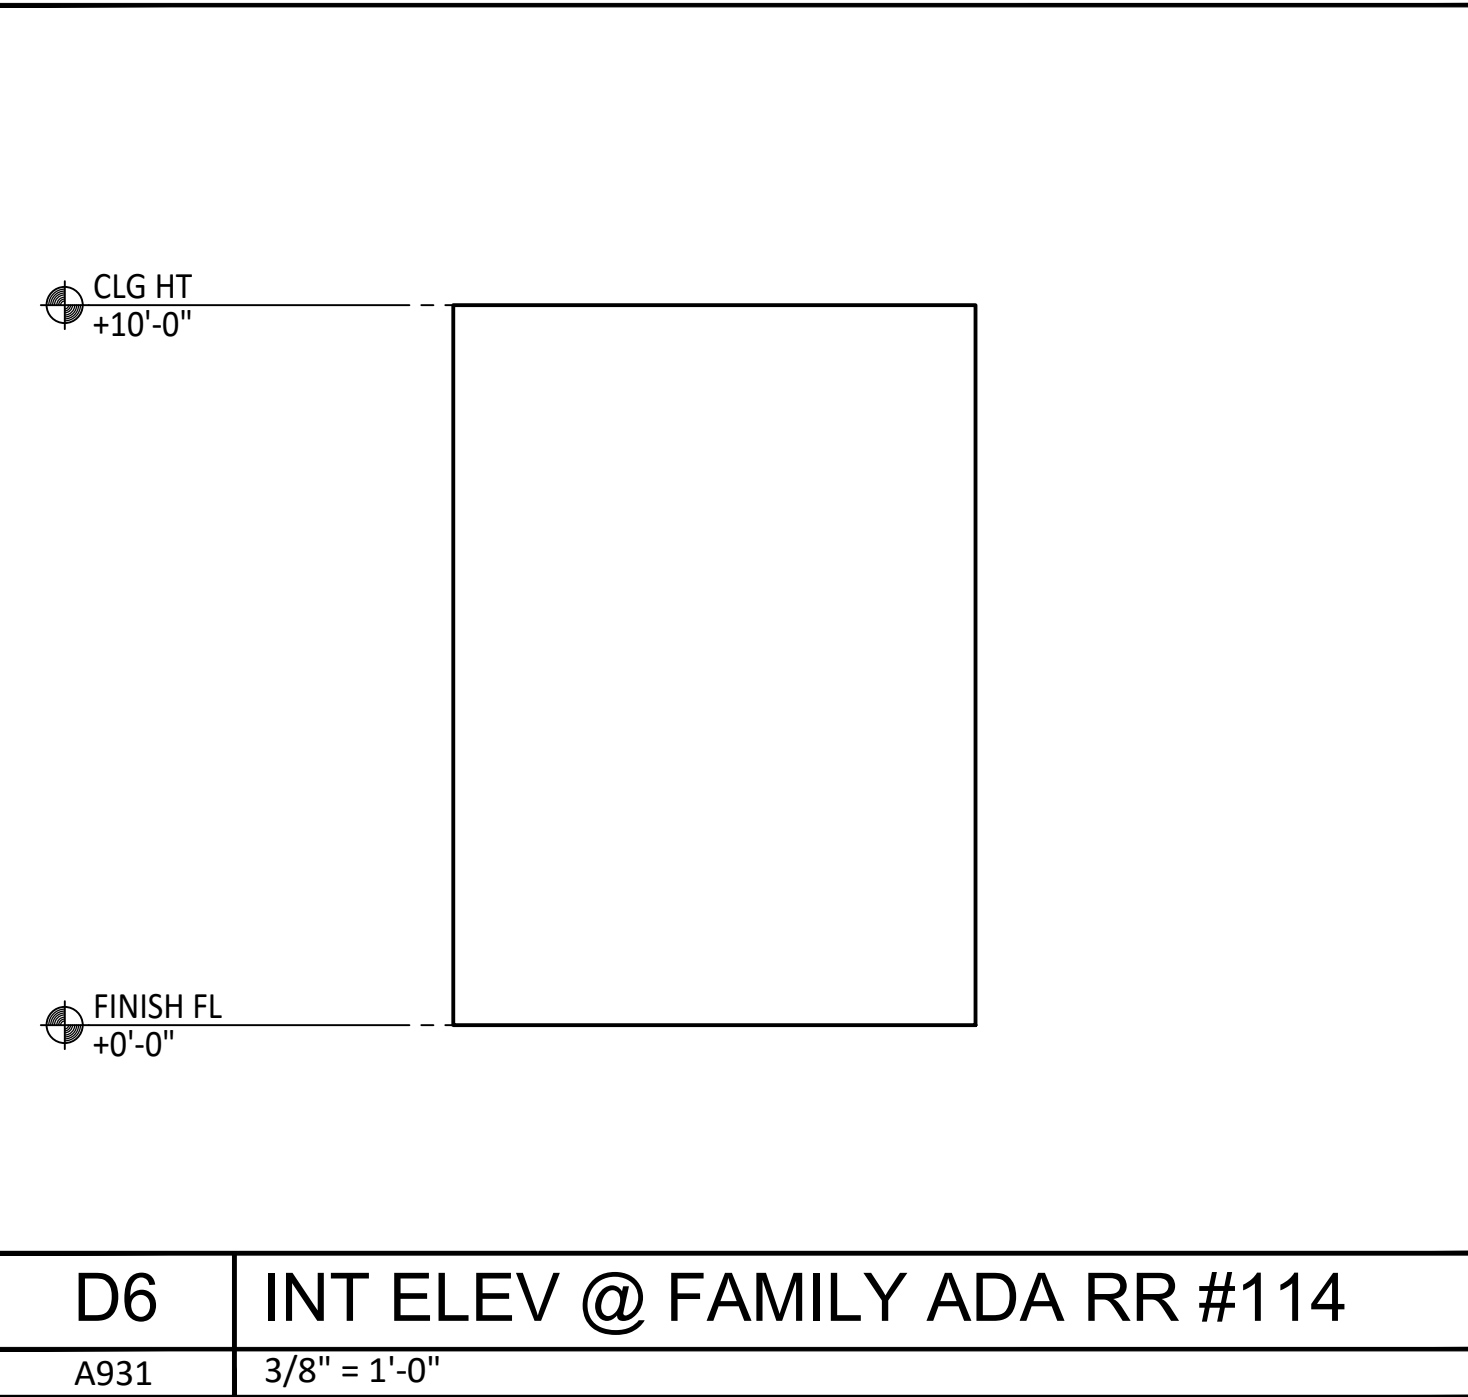



730 PEACHTREE STREET, NE
STUDIO 325
ATLANTA, GEORGIA 30308
678.244.6270
www.KDCarchitects.com

ARCHITECT:

ARCH. REG: AR91344

CONSULTANT:

REVISIONS	
DATE:	DESCRIPTION:
10/18/24	SCHEMATIC DESIGN
7/24/25	DESIGN DEVELOPMENT
10/23/25	50% CONSTRUCTION DOCS
11/14/25	PERMIT SET

PROJECT:
SERENITY SEASIDE RESORT

BUILDING #3 BEACH CLUB

186 SOUTH BAY SHORE DRIVE, EASTPOINT, FL 32328

Serenity Seaside Operations, LLC
174 Watercolor Way, PMB 410
Santa Rosa Beach, Florida 32459

JOB NUMBER: 23019.3

DATE: --/--/----

TITLE:
INTERIOR ELEVATIONS

SHEET:
A931

K:\Projects\23\23019\DWG\Serenity_Bldg-3_Beach_Club\Sheets\23019_3-A932.dwg Plotted: Nov 14, 2025 - 1:22pm by CalebLawrence



730 PEACHTREE STREET, NE
STUDIO 325
ATLANTA, GEORGIA 30308
678.244.6270
www.KDCarchitects.com

ARCHITECT:

ARCH. REG: AR91344

CONSULTANT:

REVISIONS	
DATE:	DESCRIPTION:
10/18/24	SCHEMATIC DESIGN
7/24/25	DESIGN DEVELOPMENT
10/23/25	50% CONSTRUCTION DOCS
11/14/25	PERMIT SET

PROJECT:
**SERENITY SEASIDE
RESORT**

**BUILDING #3
BEACH
CLUB**

186 SOUTH BAY
SHORE DRIVE,
EASTPOINT, FL
32328


Serenity Seaside
Operations, LLC
174 Watercolor Way, PMB 410
Santa Rosa Beach, Florida 32459

JOB NUMBER: 23019.3

DATE: --/--/----

TITLE:
**INTERIOR
MILLWORK
DETAILS
&
SECTIONS**

SHEET:
A932

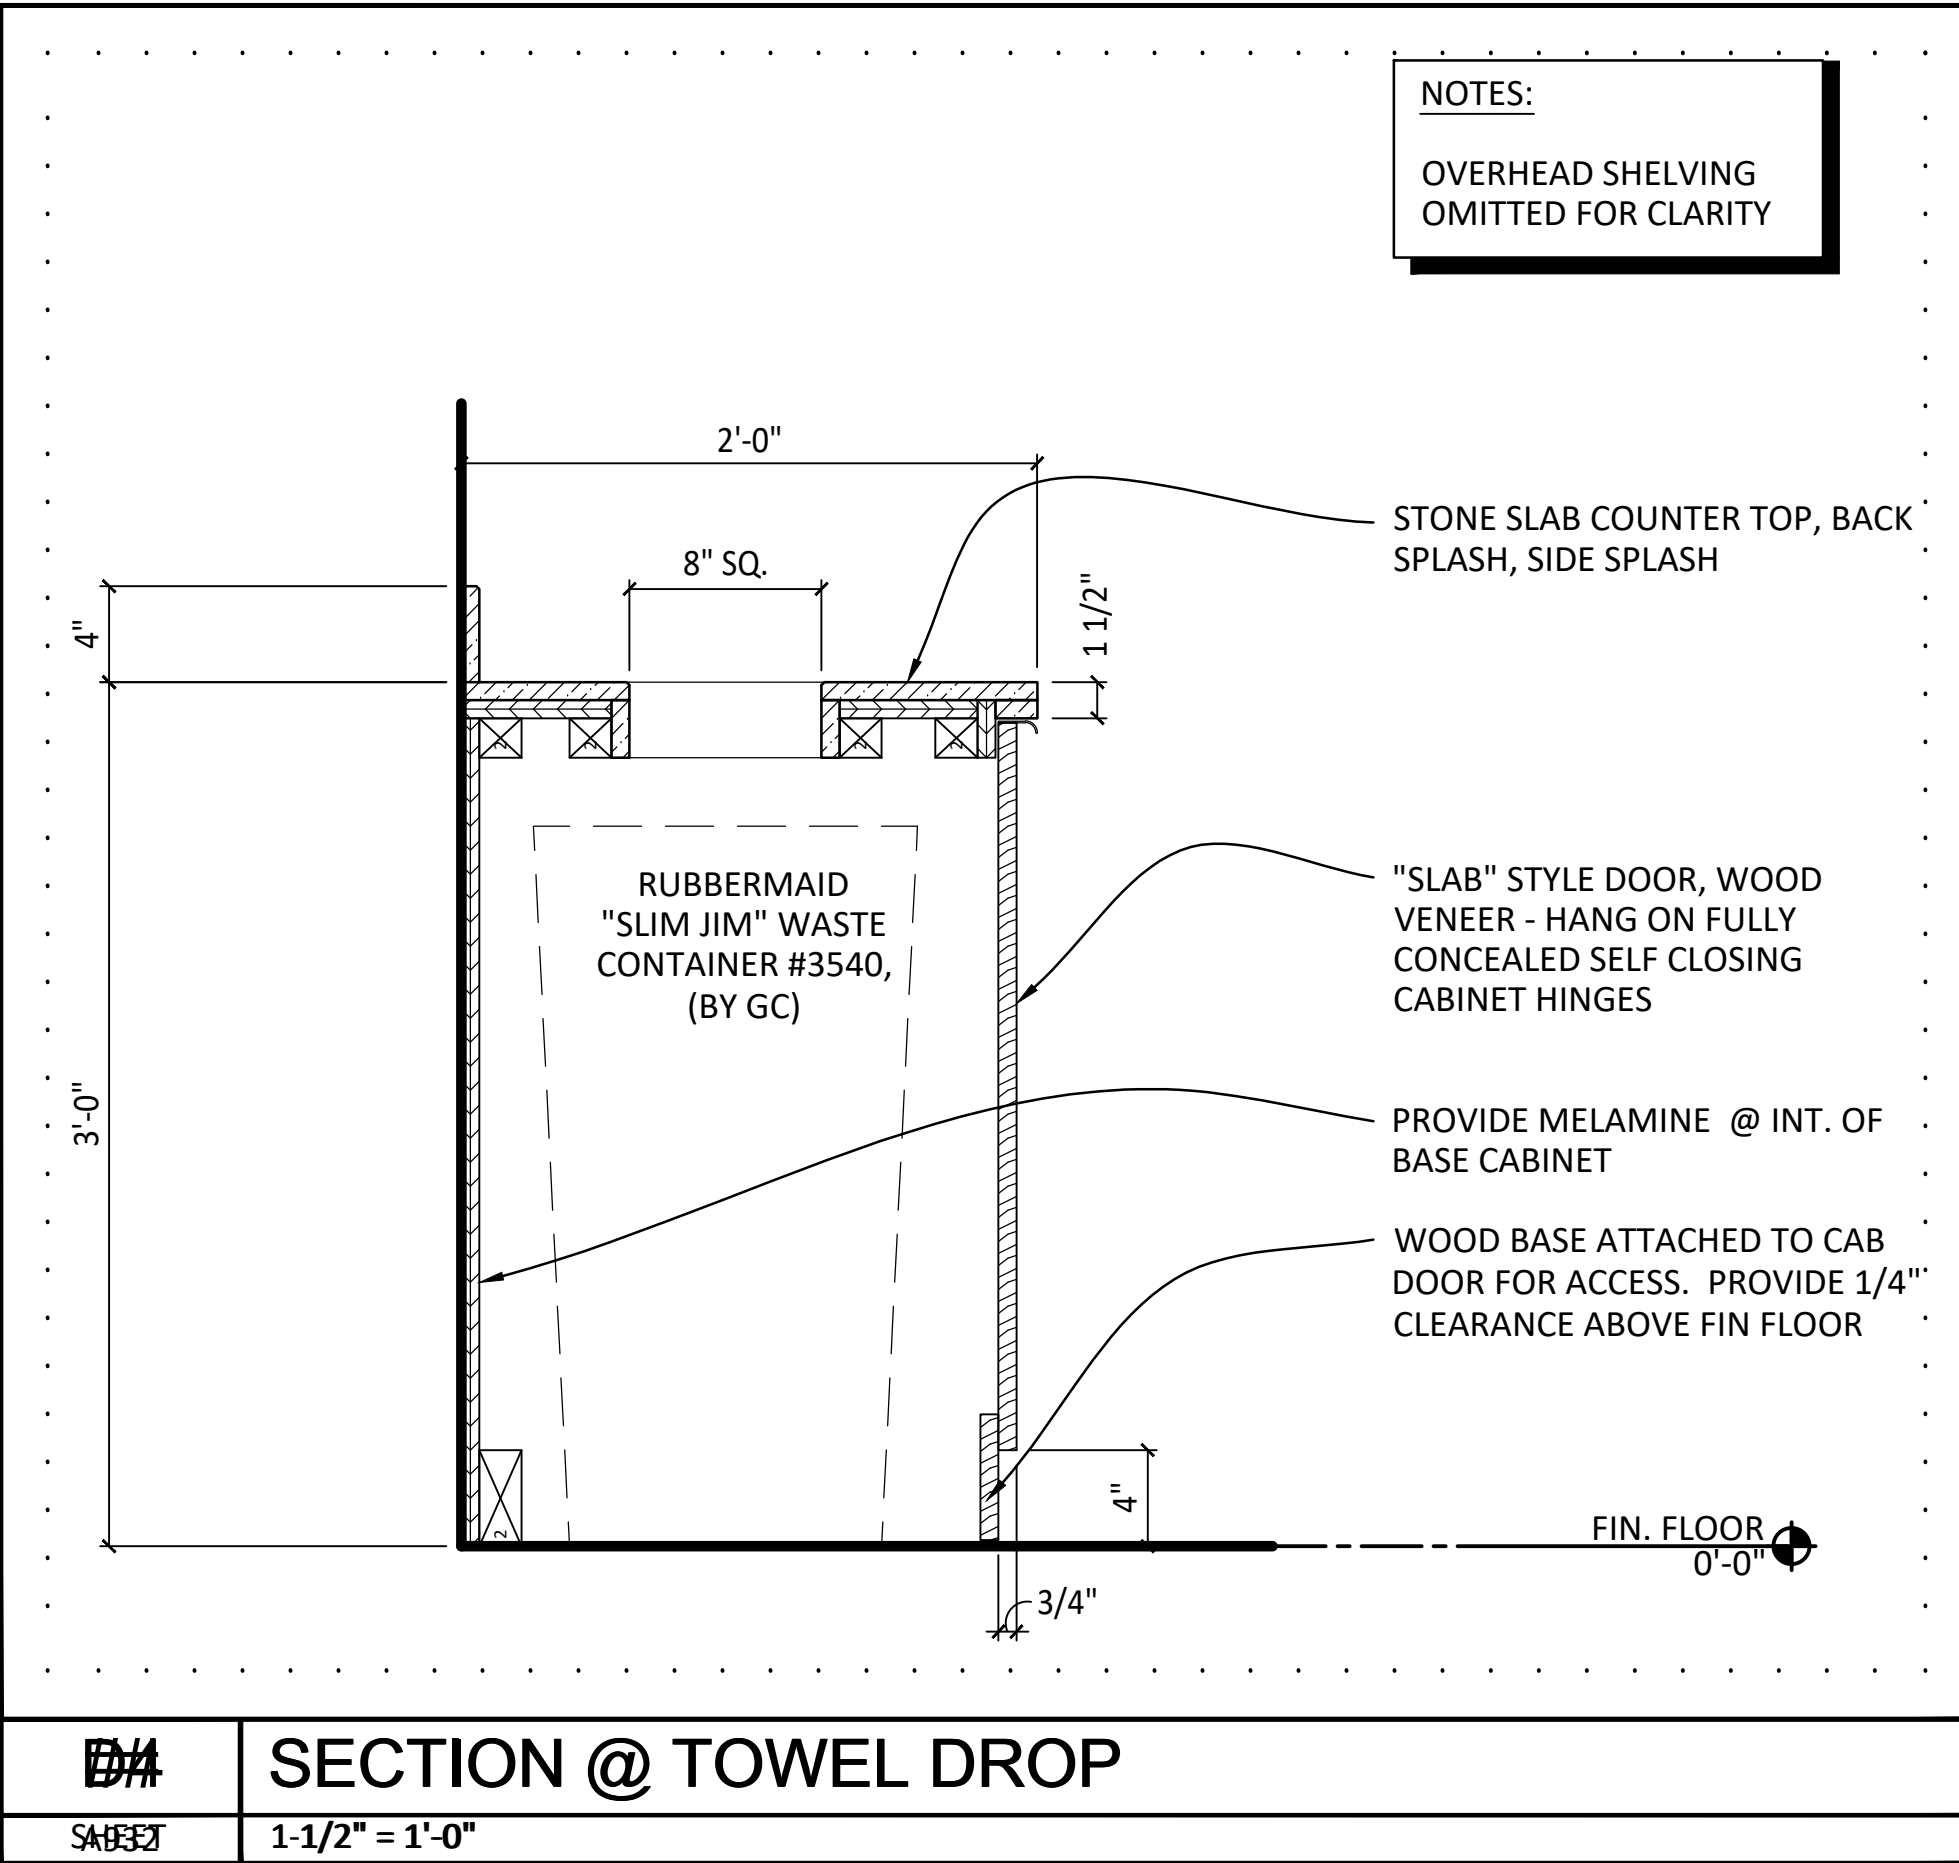


DA

SECTION @ TOWEL DROP

SAB32

1-1/2" = 1'-0"

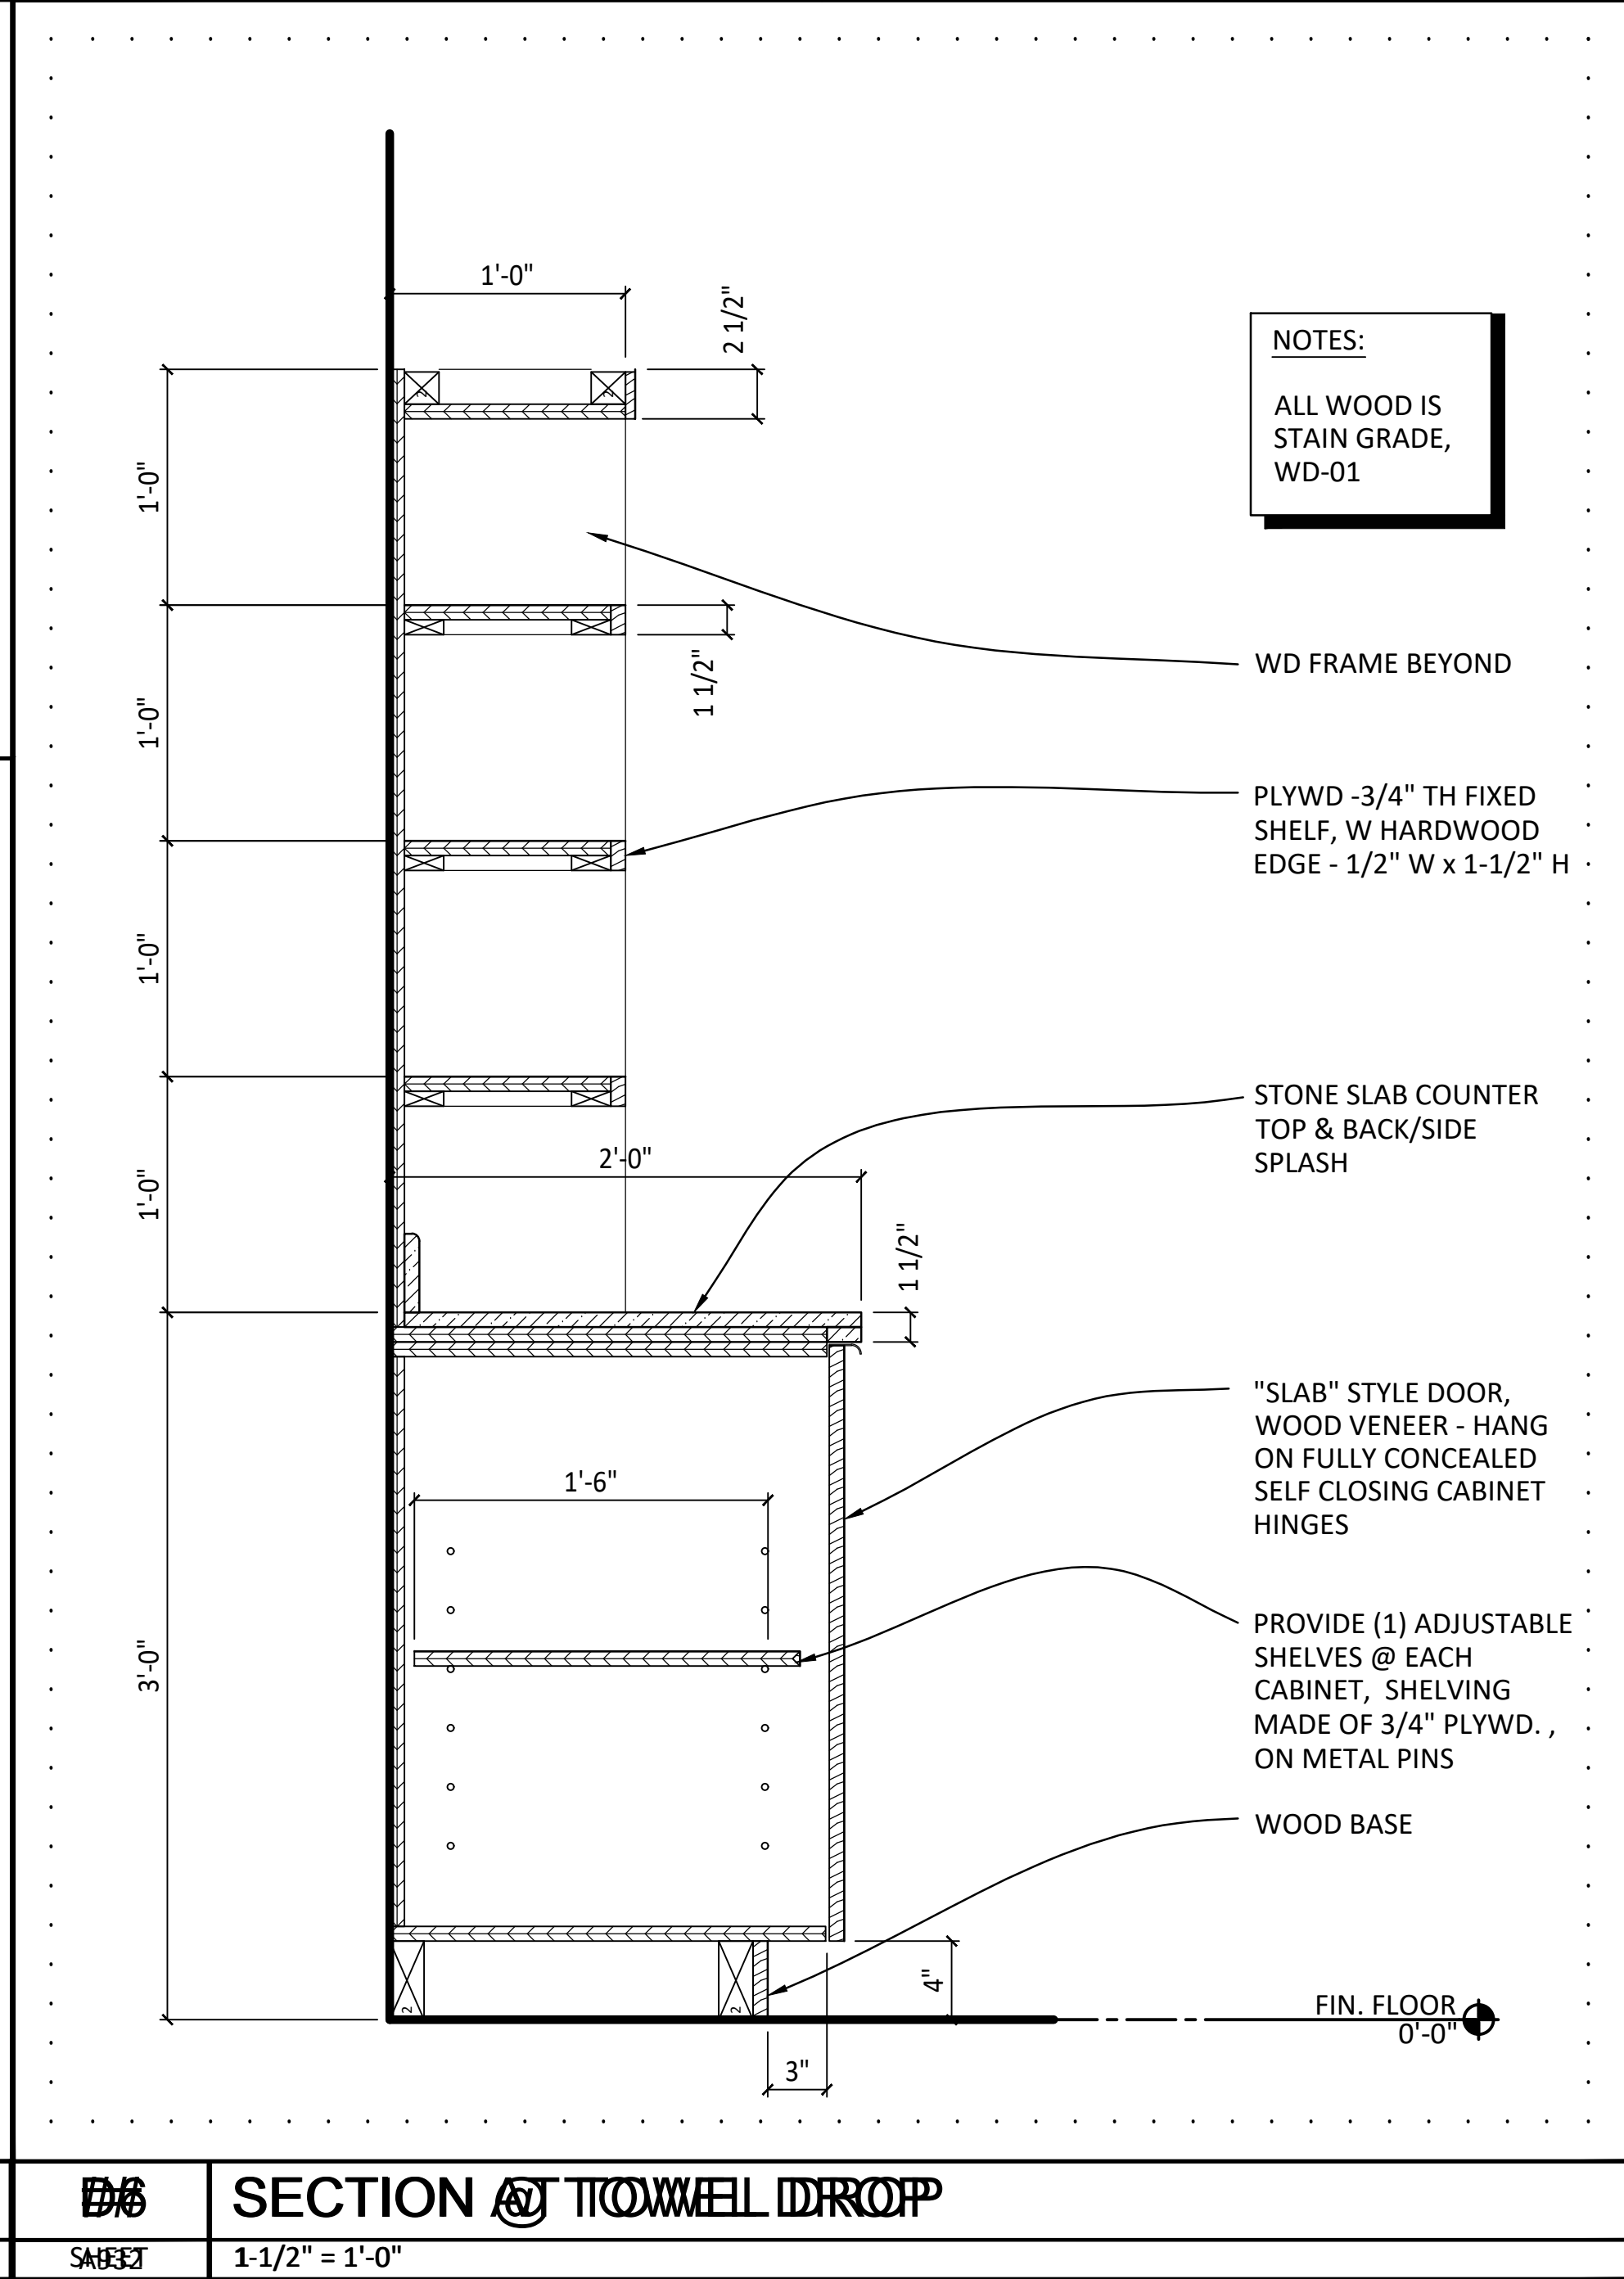


DA

SECTION @ TOWEL DROP

SAB32

1-1/2" = 1'-0"

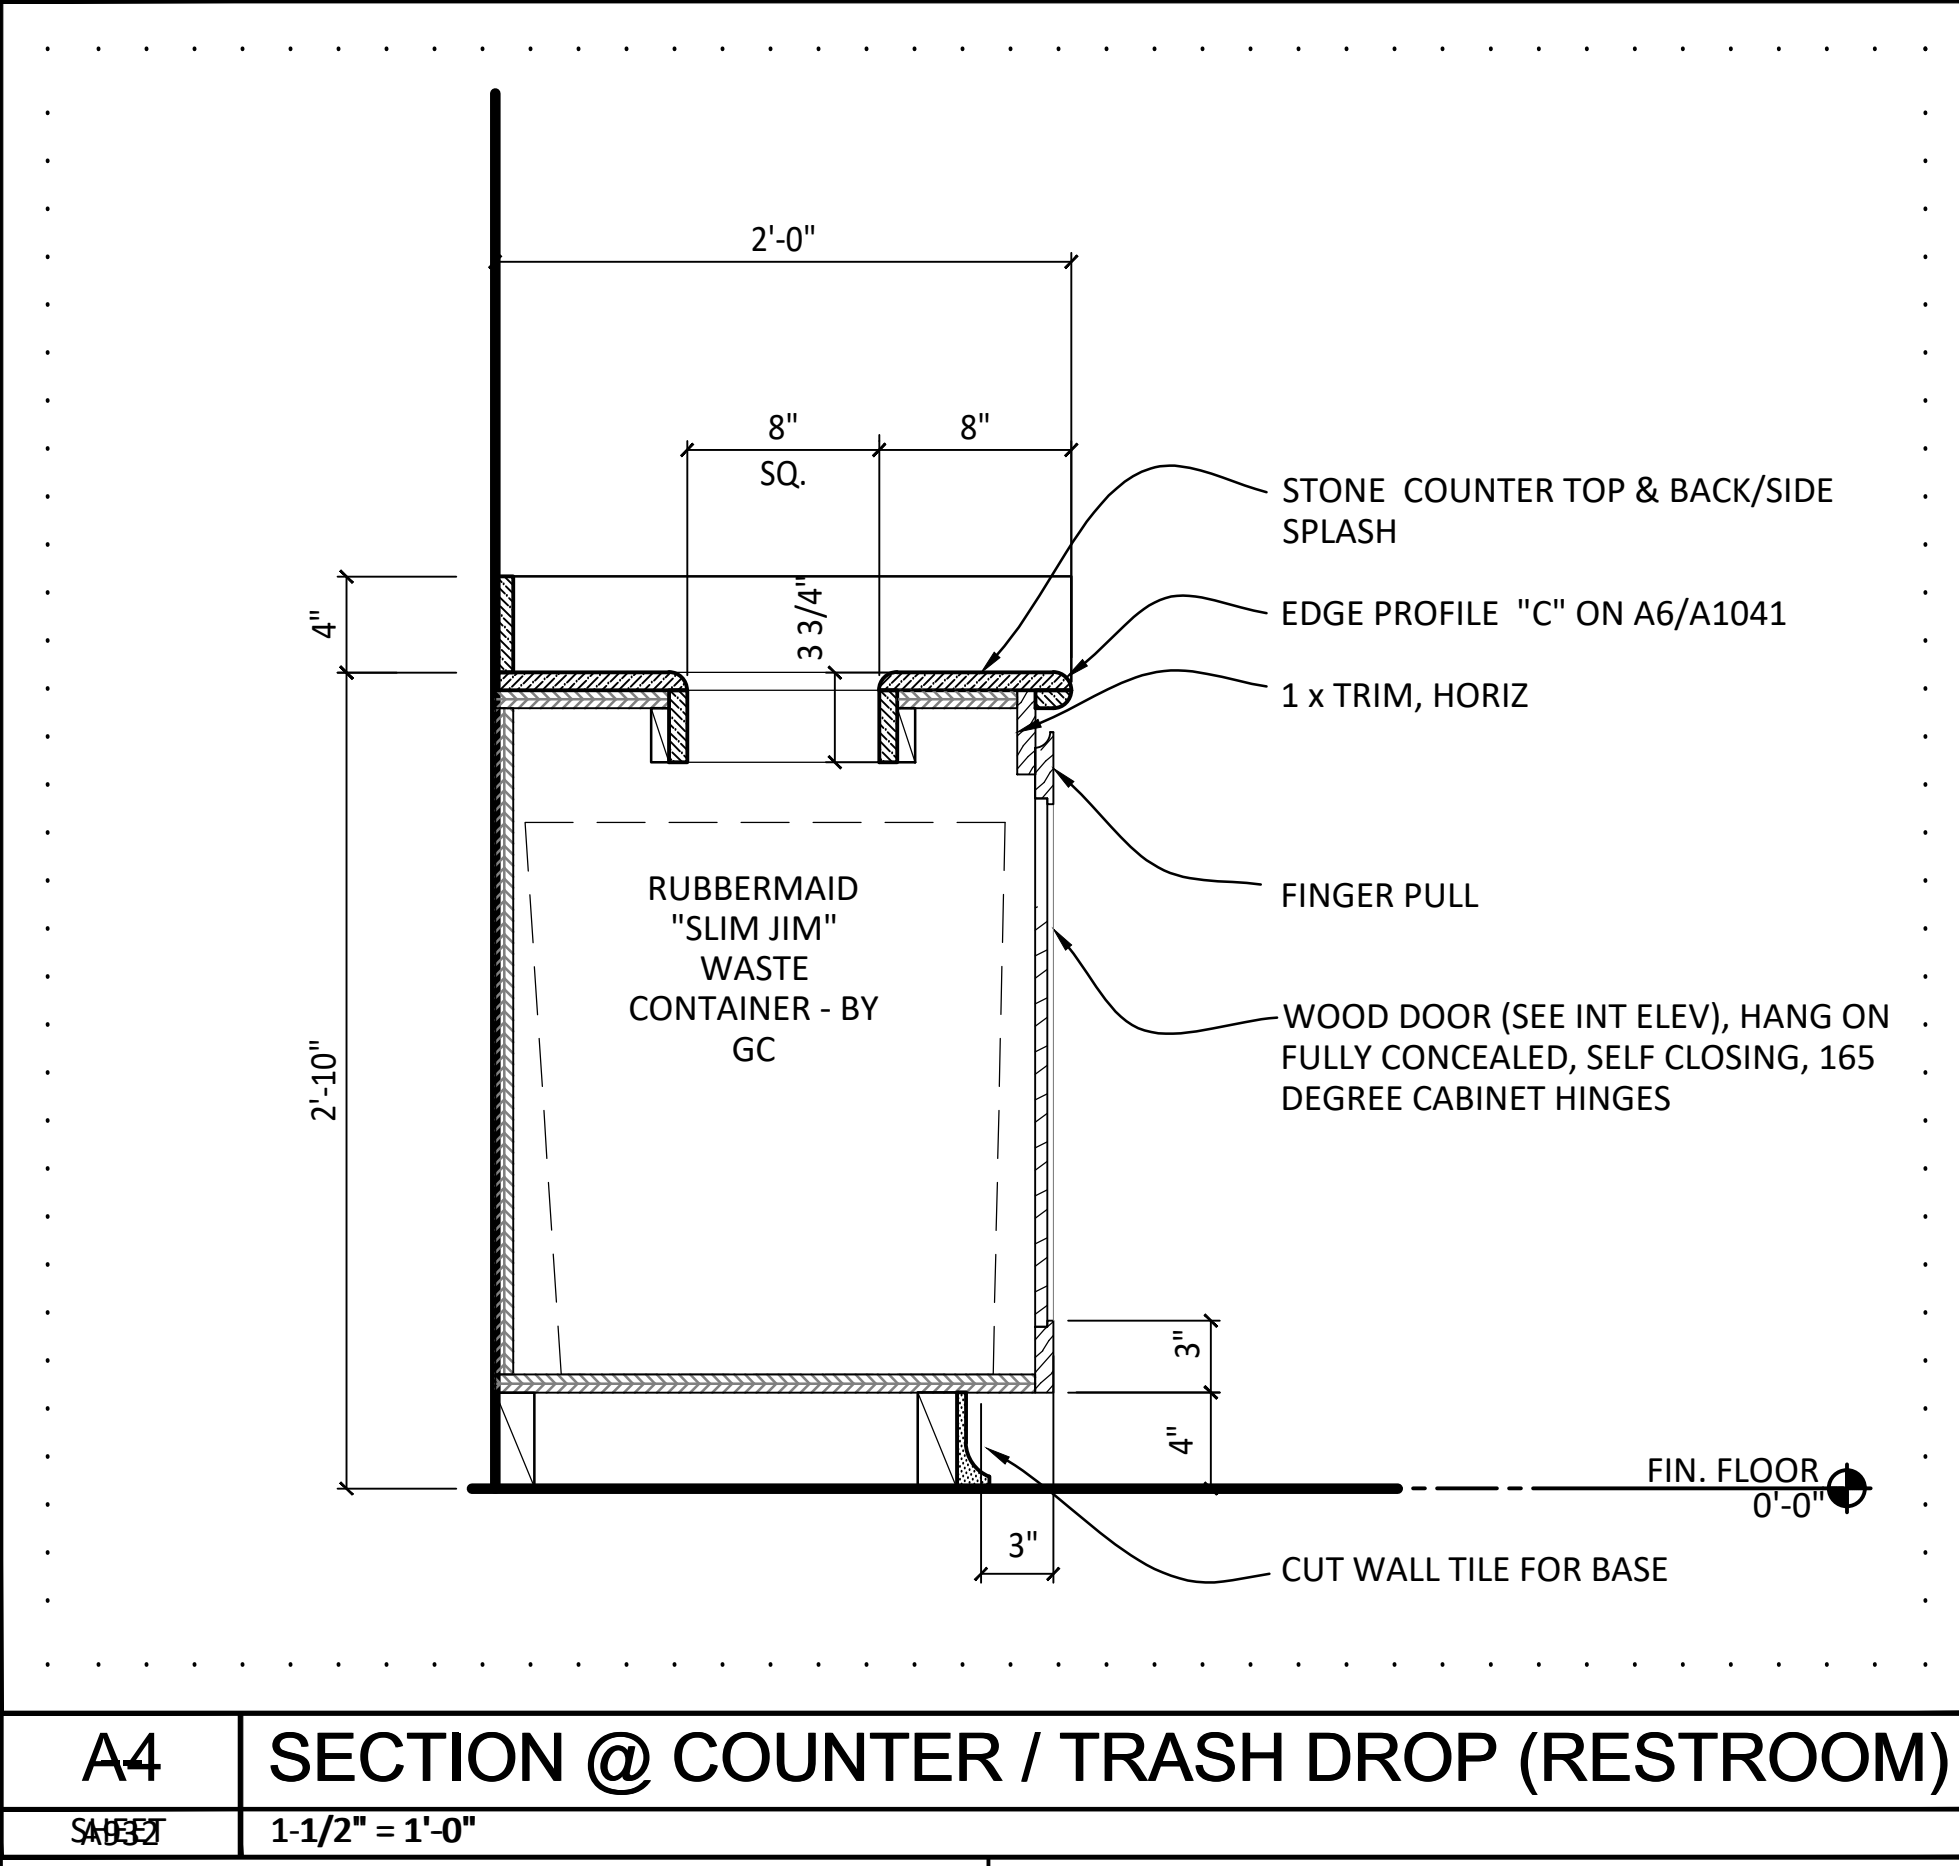


A4

SECTION @ COUNTER / TRASH DROP (RESTROOM)

SAB32

1-1/2" = 1'-0"

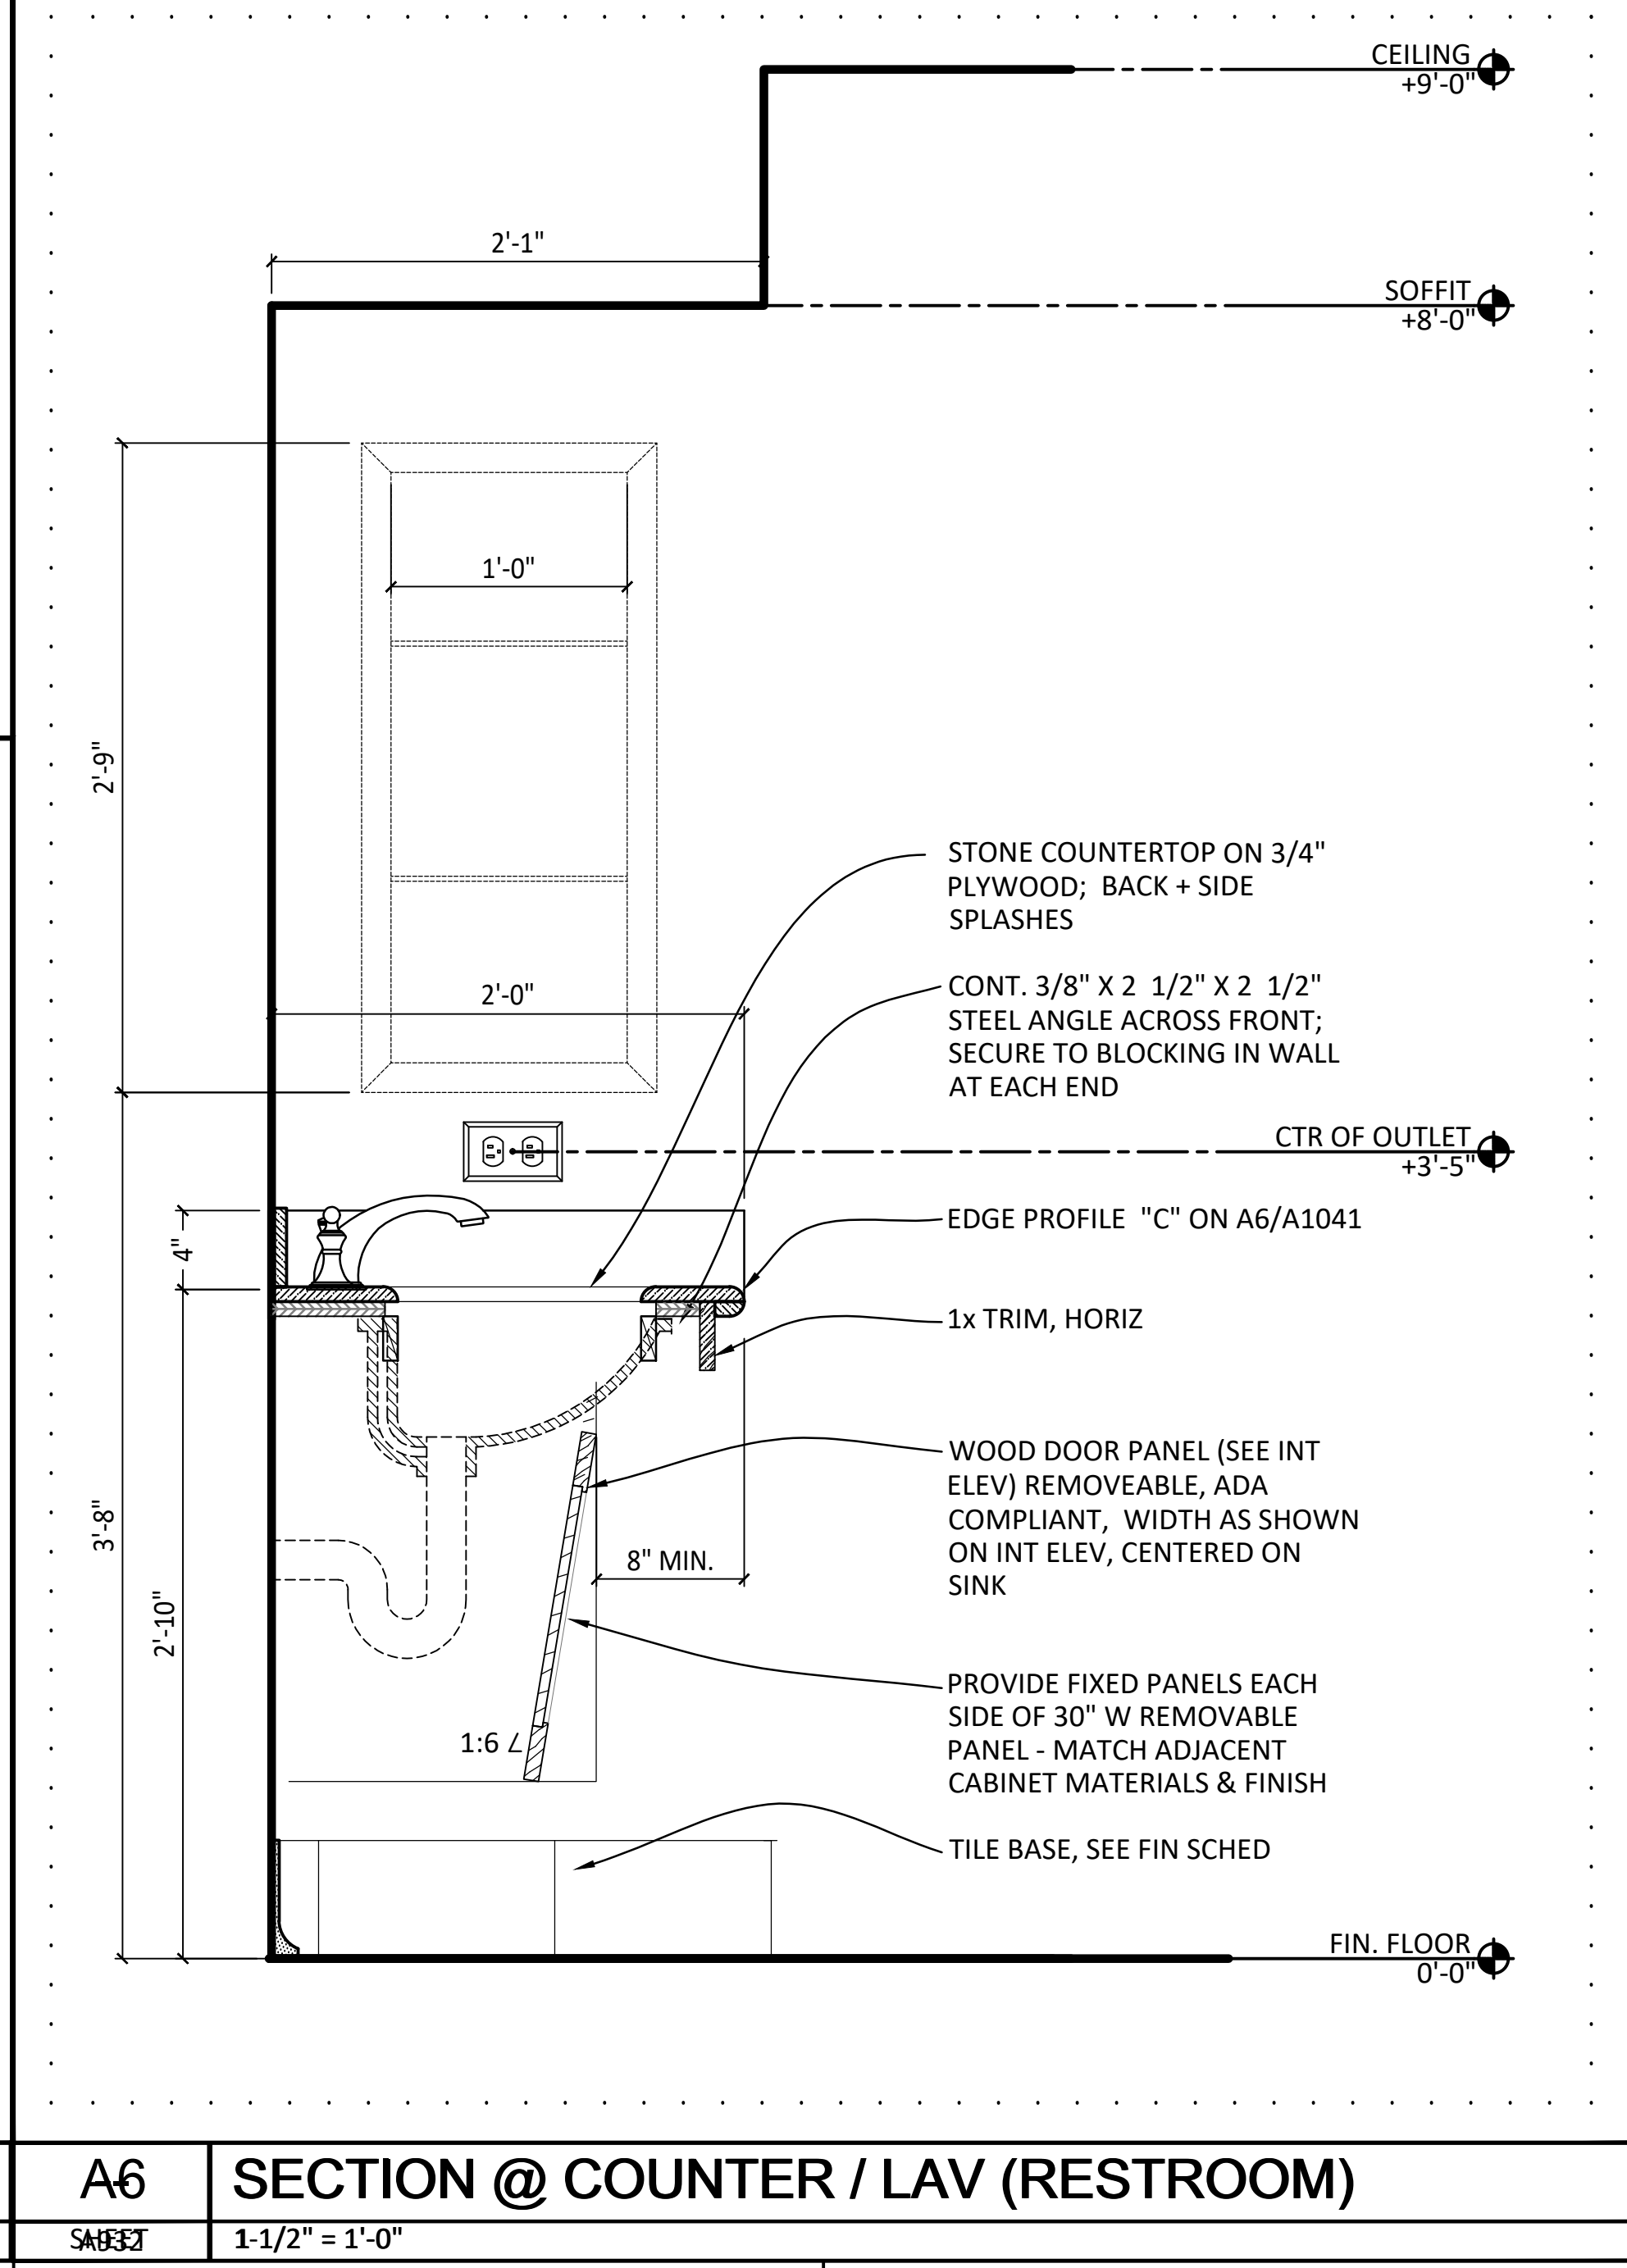



A6

SECTION @ COUNTER / LAV (RESTROOM)


SAB32

1-1/2" = 1'-0"

K:\Projects\23\23019\DWG\Serenity_Club\Sheets\23019_3-A934.dwg Plotted: Nov 14, 2025 - 1:22pm by CalebLawrence

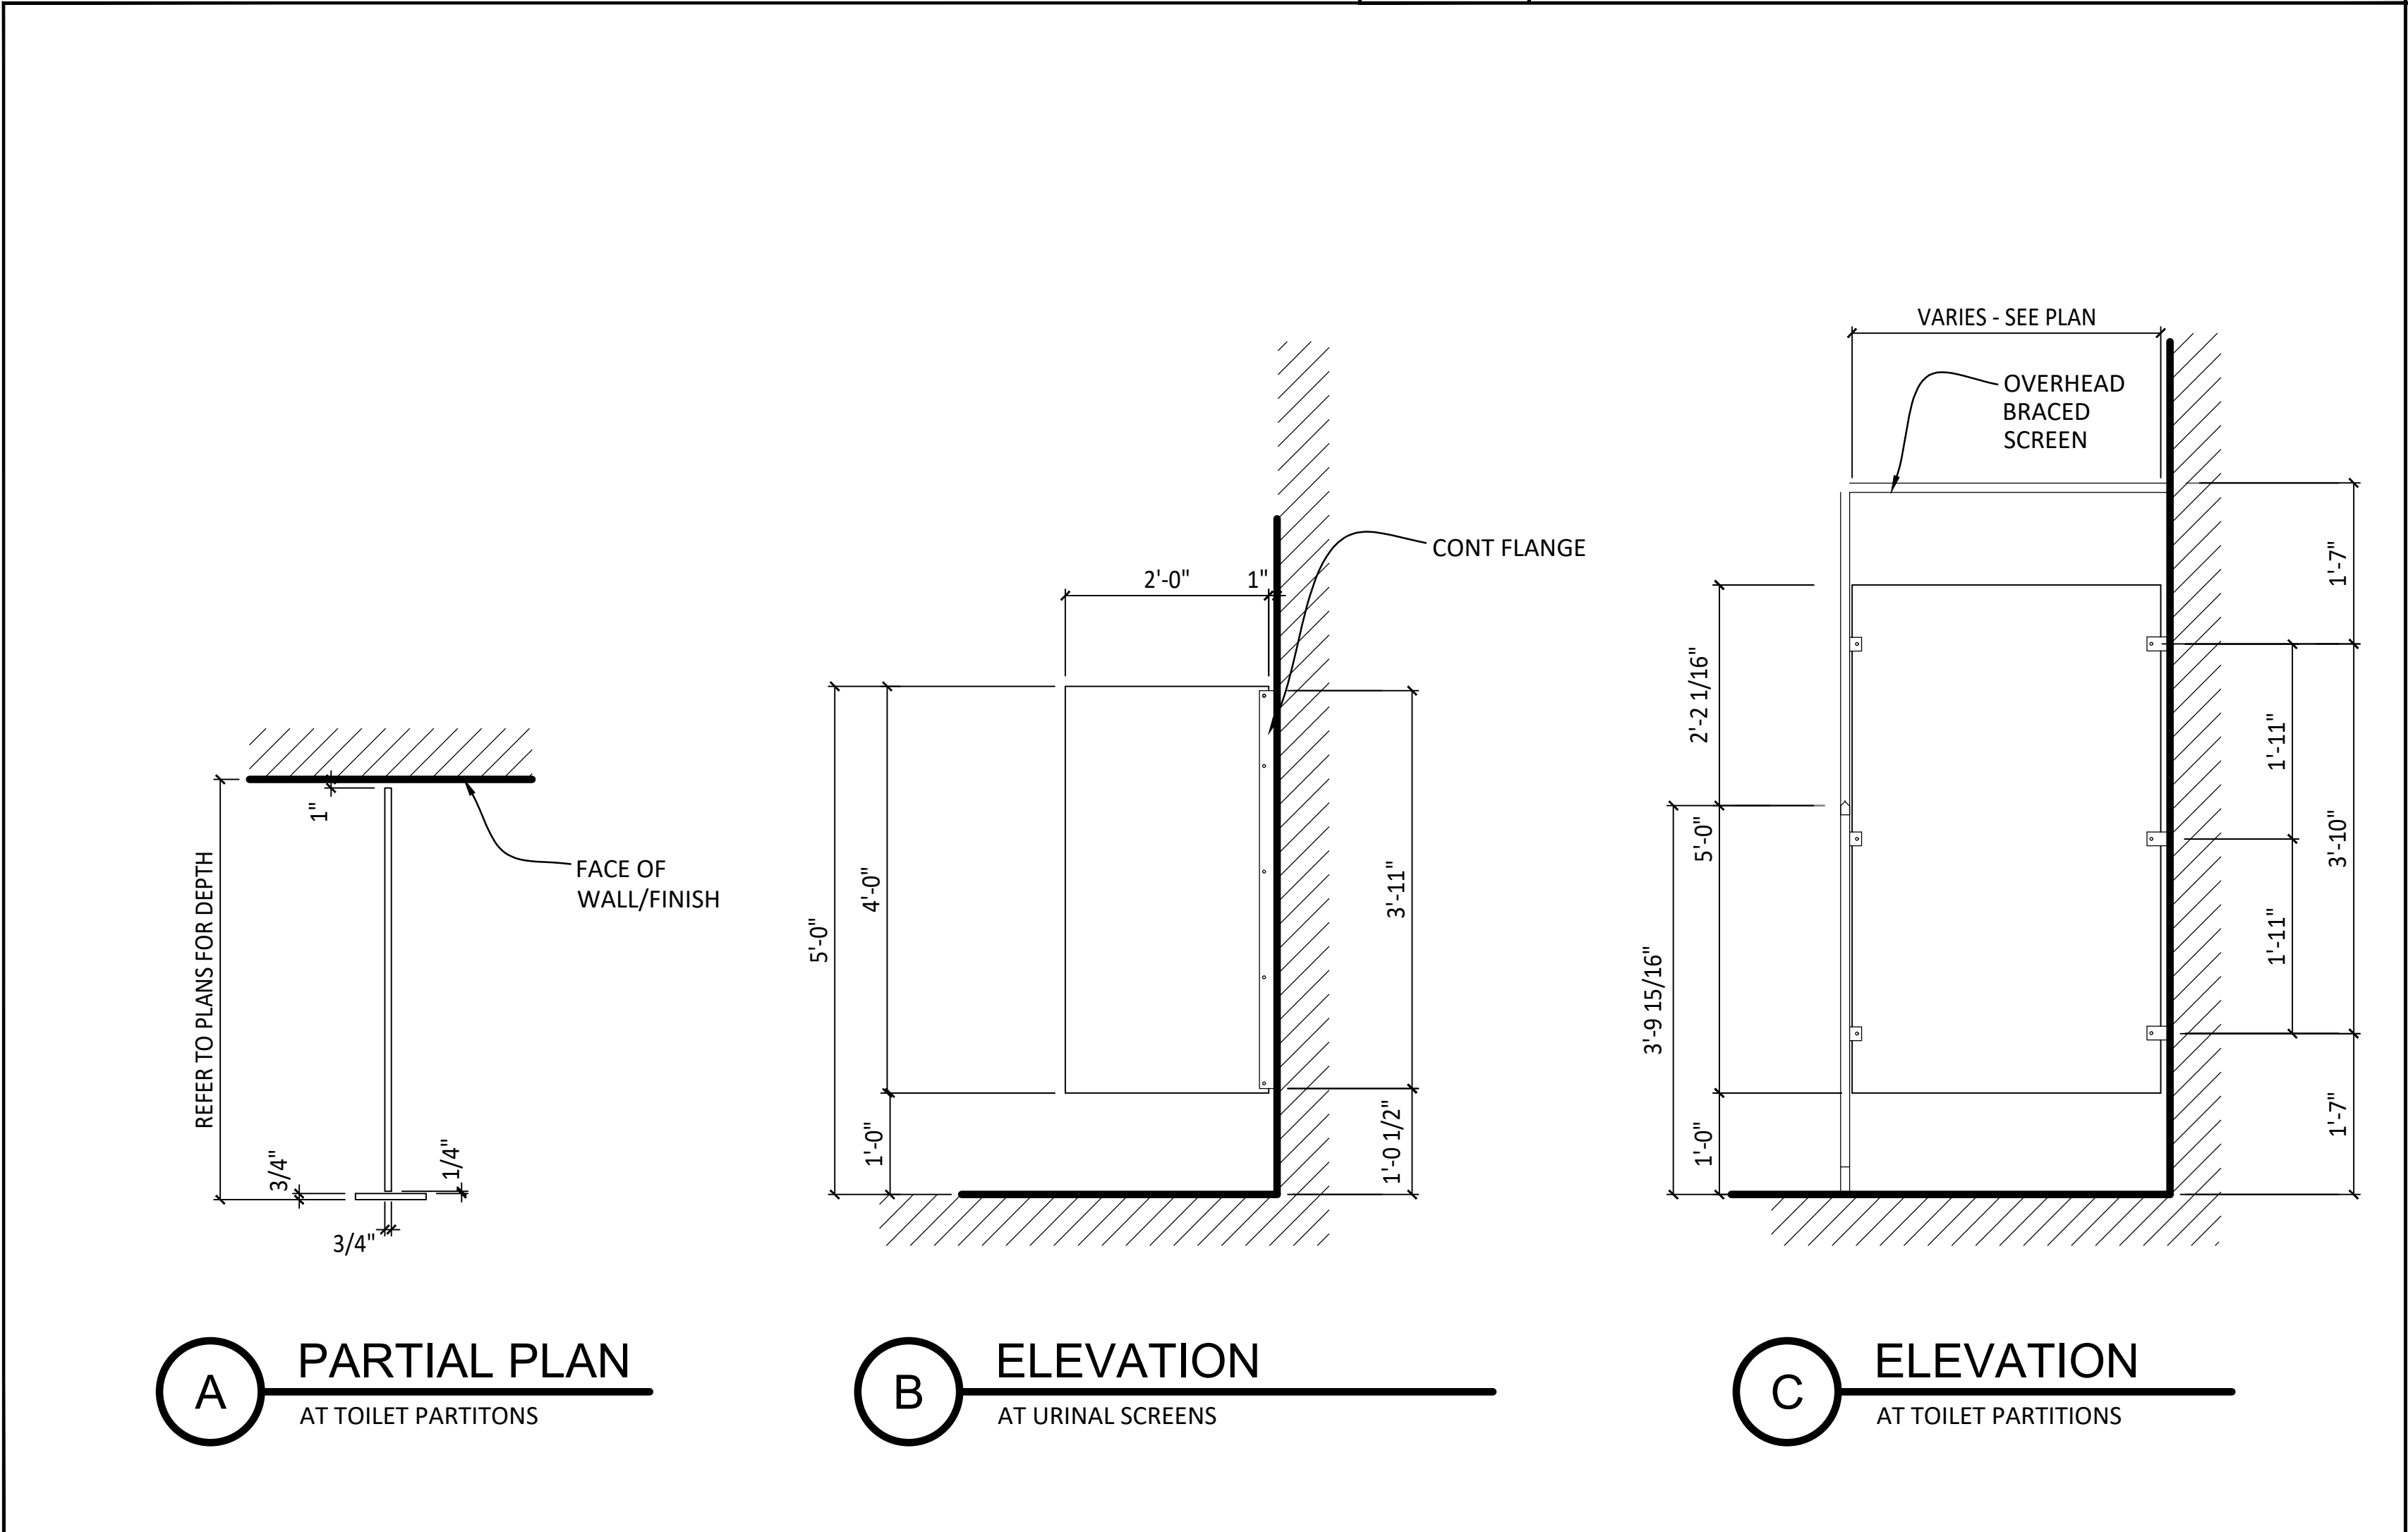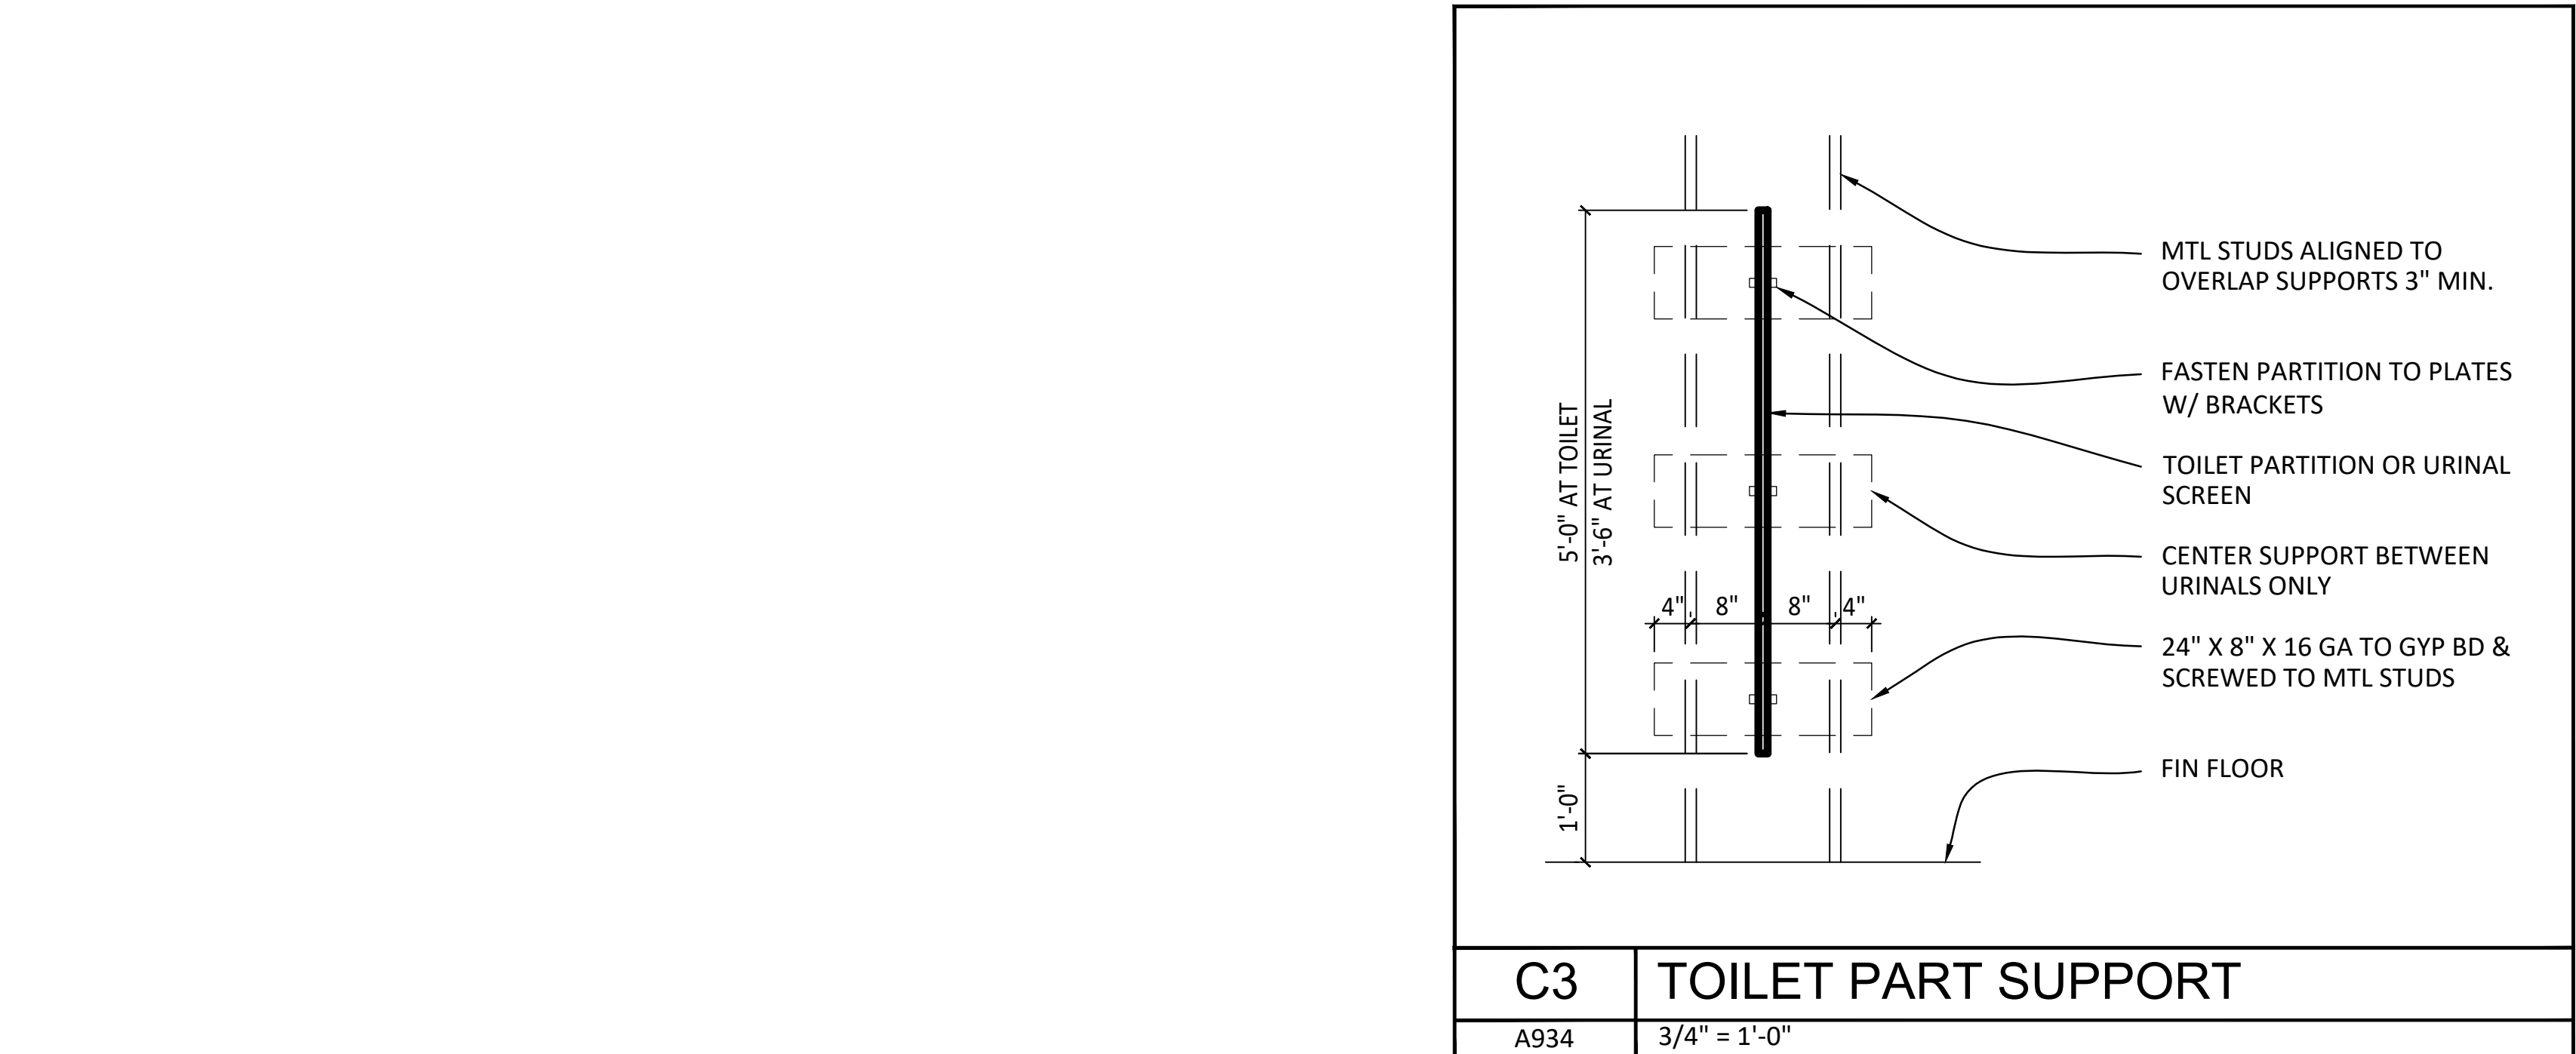

A1	ELEVATIONS @ SCREENS FOR TOILET & URINALS
A934	3/4" = 1'-0"

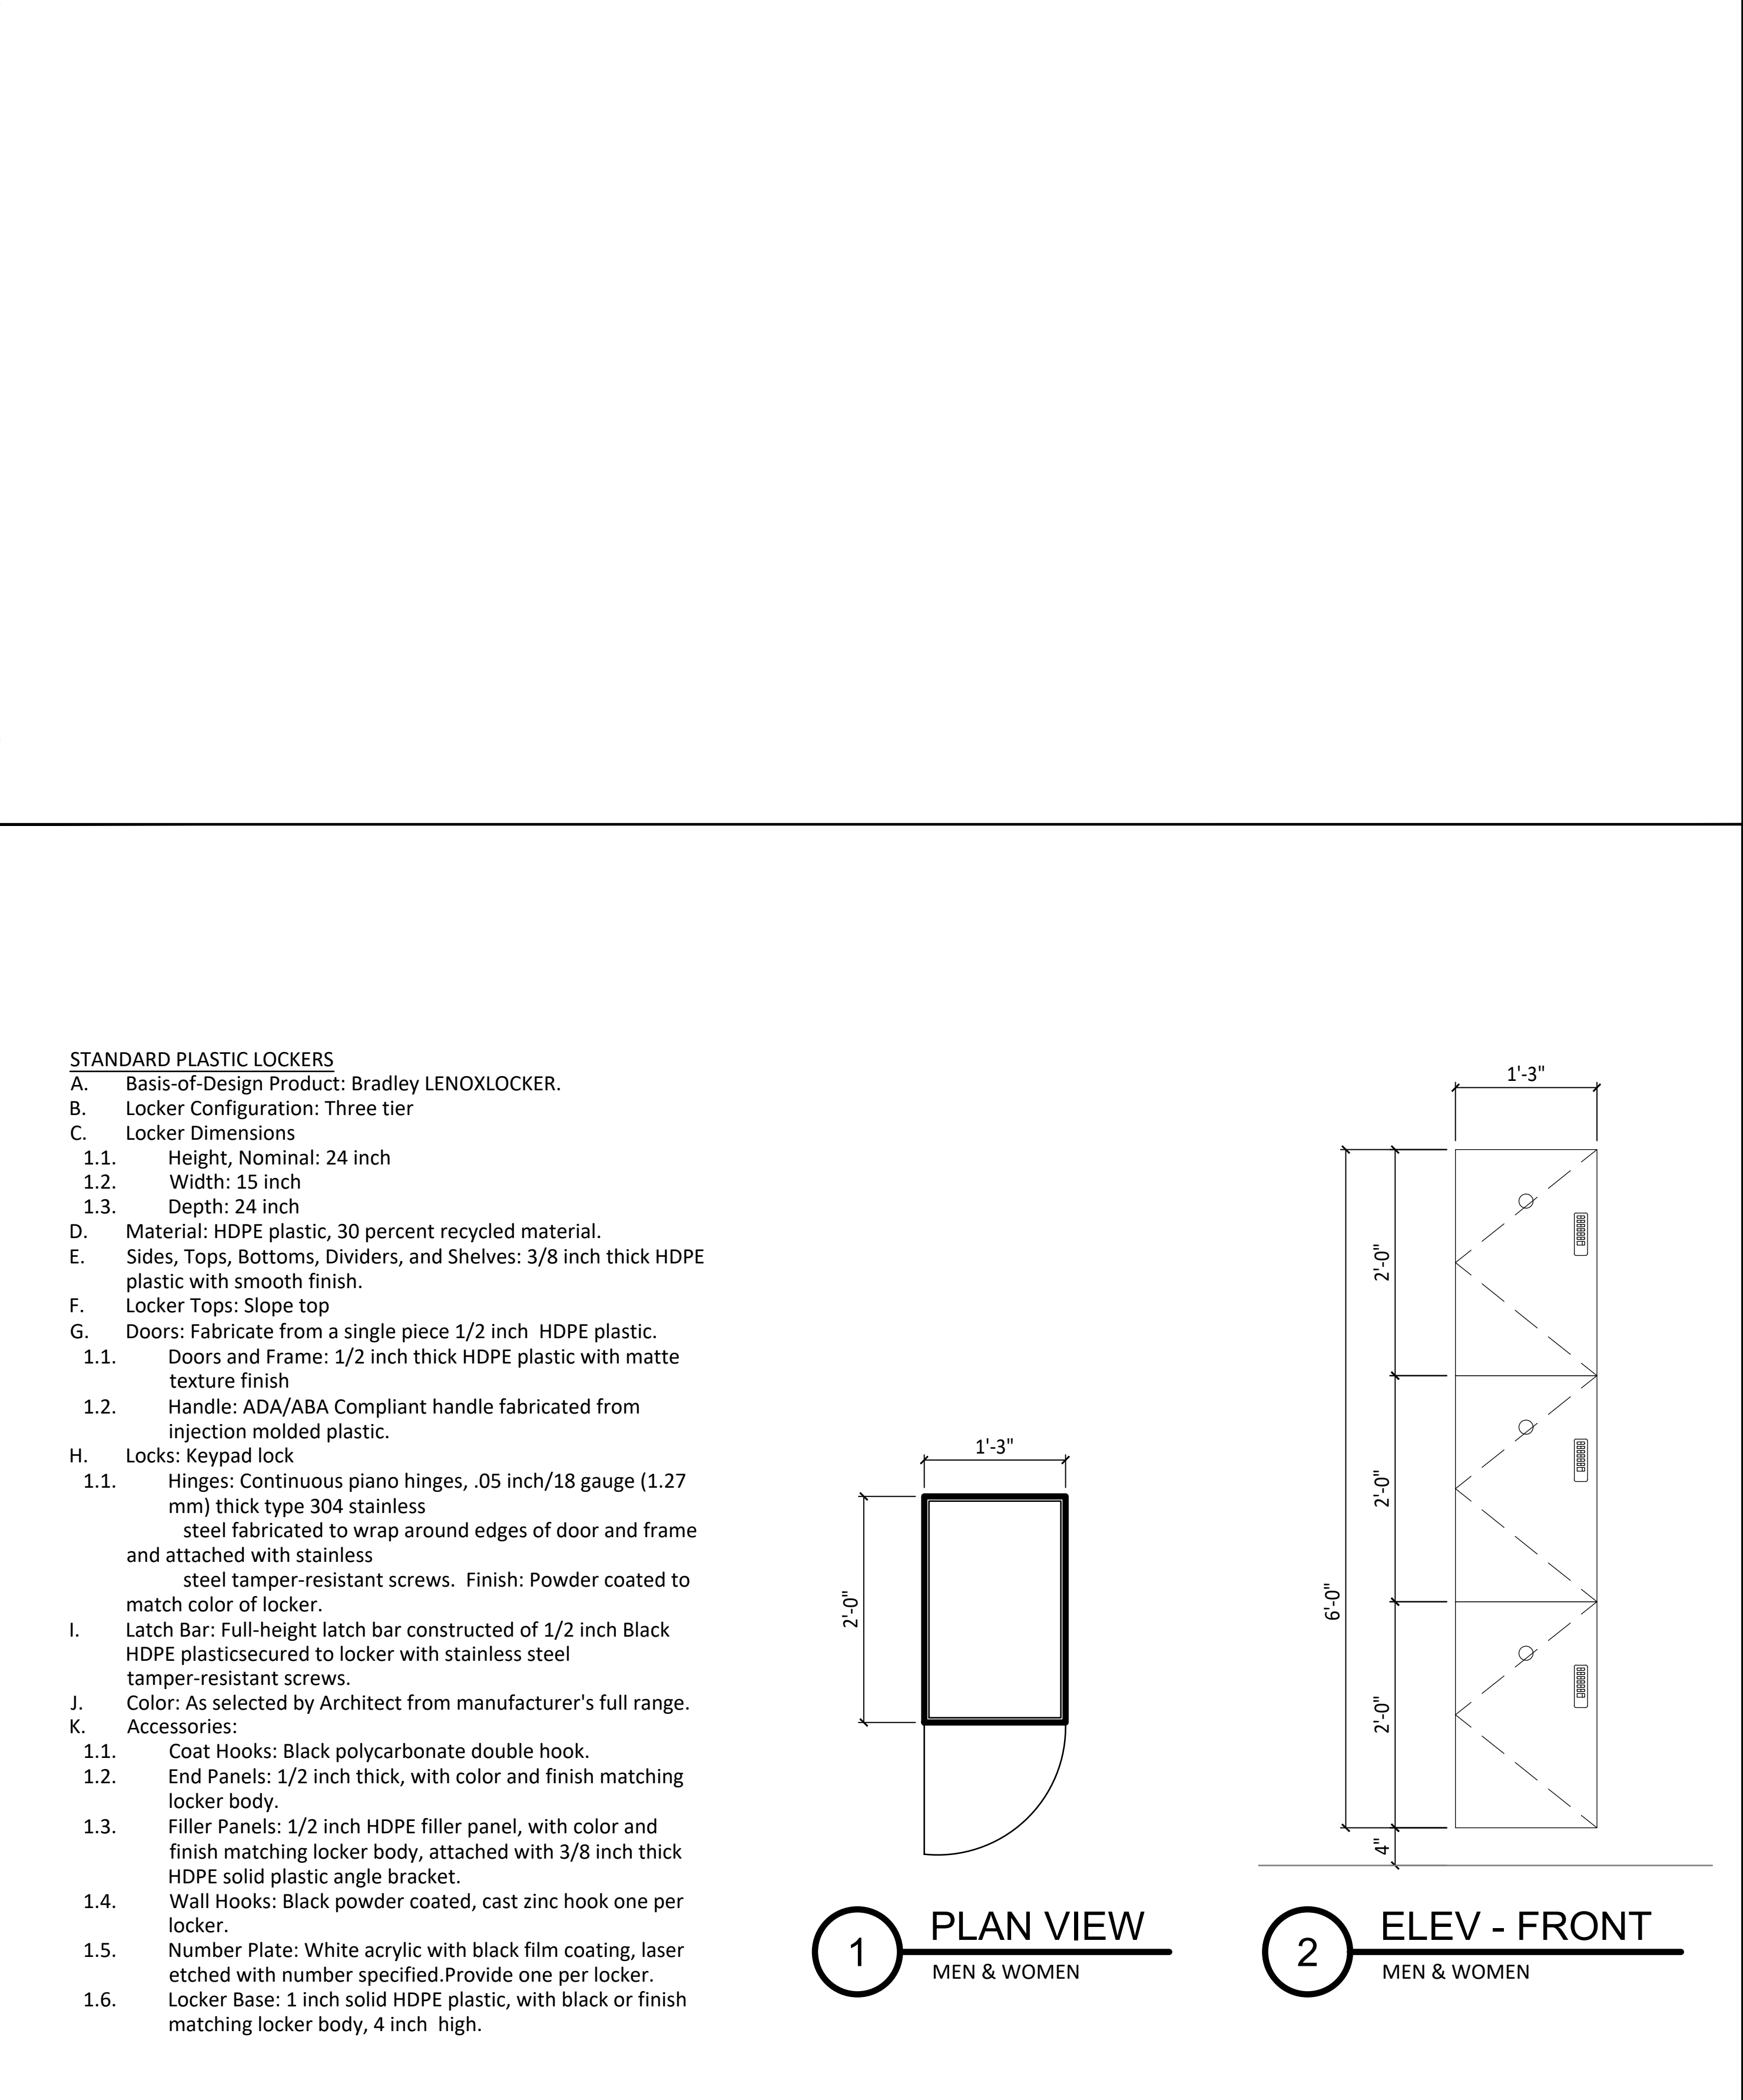

A5	DETAILS @ PHENOLIC LOCKERS
A934	1" = 1'-0"

SHEET NOTES / LEGEND

1. -

GENERAL NOTES

A. -



730 PEACHTREE STREET, NE
STUDIO 325
ATLANTA, GEORGIA 30308
678.244.6270
www.KDCarchitects.com

ARCHITECT:

ARCH. REG: AR91344

CONSULTANT:

REVISIONS

DATE:	DESCRIPTION:
10/18/24	SCHEMATIC DESIGN
7/24/25	DESIGN DEVELOPMENT
10/23/25	50% CONSTRUCTION DOCS
11/14/25	PERMIT SET

PROJECT:

SERENITY SEASIDE
RESORT

BUILDING #3
BEACH
CLUB

186 SOUTH BAY
SHORE DRIVE,
EASTPOINT, FL
32328

Serenity Seaside
Operations, LLC
174 Watercolor Way, PMB 410
Santa Rosa Beach, Florida 32459

JOB NUMBER: 23019.3

DATE: --/--/----

TITLE:
DETAILS &
SECTIONS

SHEET:

A934

K:\Projects\231\23019\DWG\A935\A935.dwg
Plotted: Nov 14, 2025 - 1:22pm by CabelLawrence



730 PEACHTREE STREET, NE
STUDIO 325
ATLANTA, GEORGIA 30308
678.244.6270
www.KDCarchitects.com

ARCHITECT:

ARCH. REG: AR91344

CONSULTANT:

REVISIONS	
DATE:	DESCRIPTION:
10/18/24	SCHEMATIC DESIGN
7/24/25	DESIGN DEVELOPMENT
10/23/25	50% CONSTRUCTION DOCS
11/14/25	PERMIT SET

PROJECT:

SERENITY SEASIDE
RESORT

BUILDING #3
BEACH
CLUB

186 SOUTH BAY
SHORE DRIVE,
EASTPOINT, FL
32328


Serenity Seaside
Operations, LLC
174 Watercolor Way, PMB 410
Santa Rosa Beach, Florida 32459

JOB NUMBER: 23019.3


DATE: --/------

TITLE: INTERIOR
DETAILS
&
SECTIONS


SHEET: A935

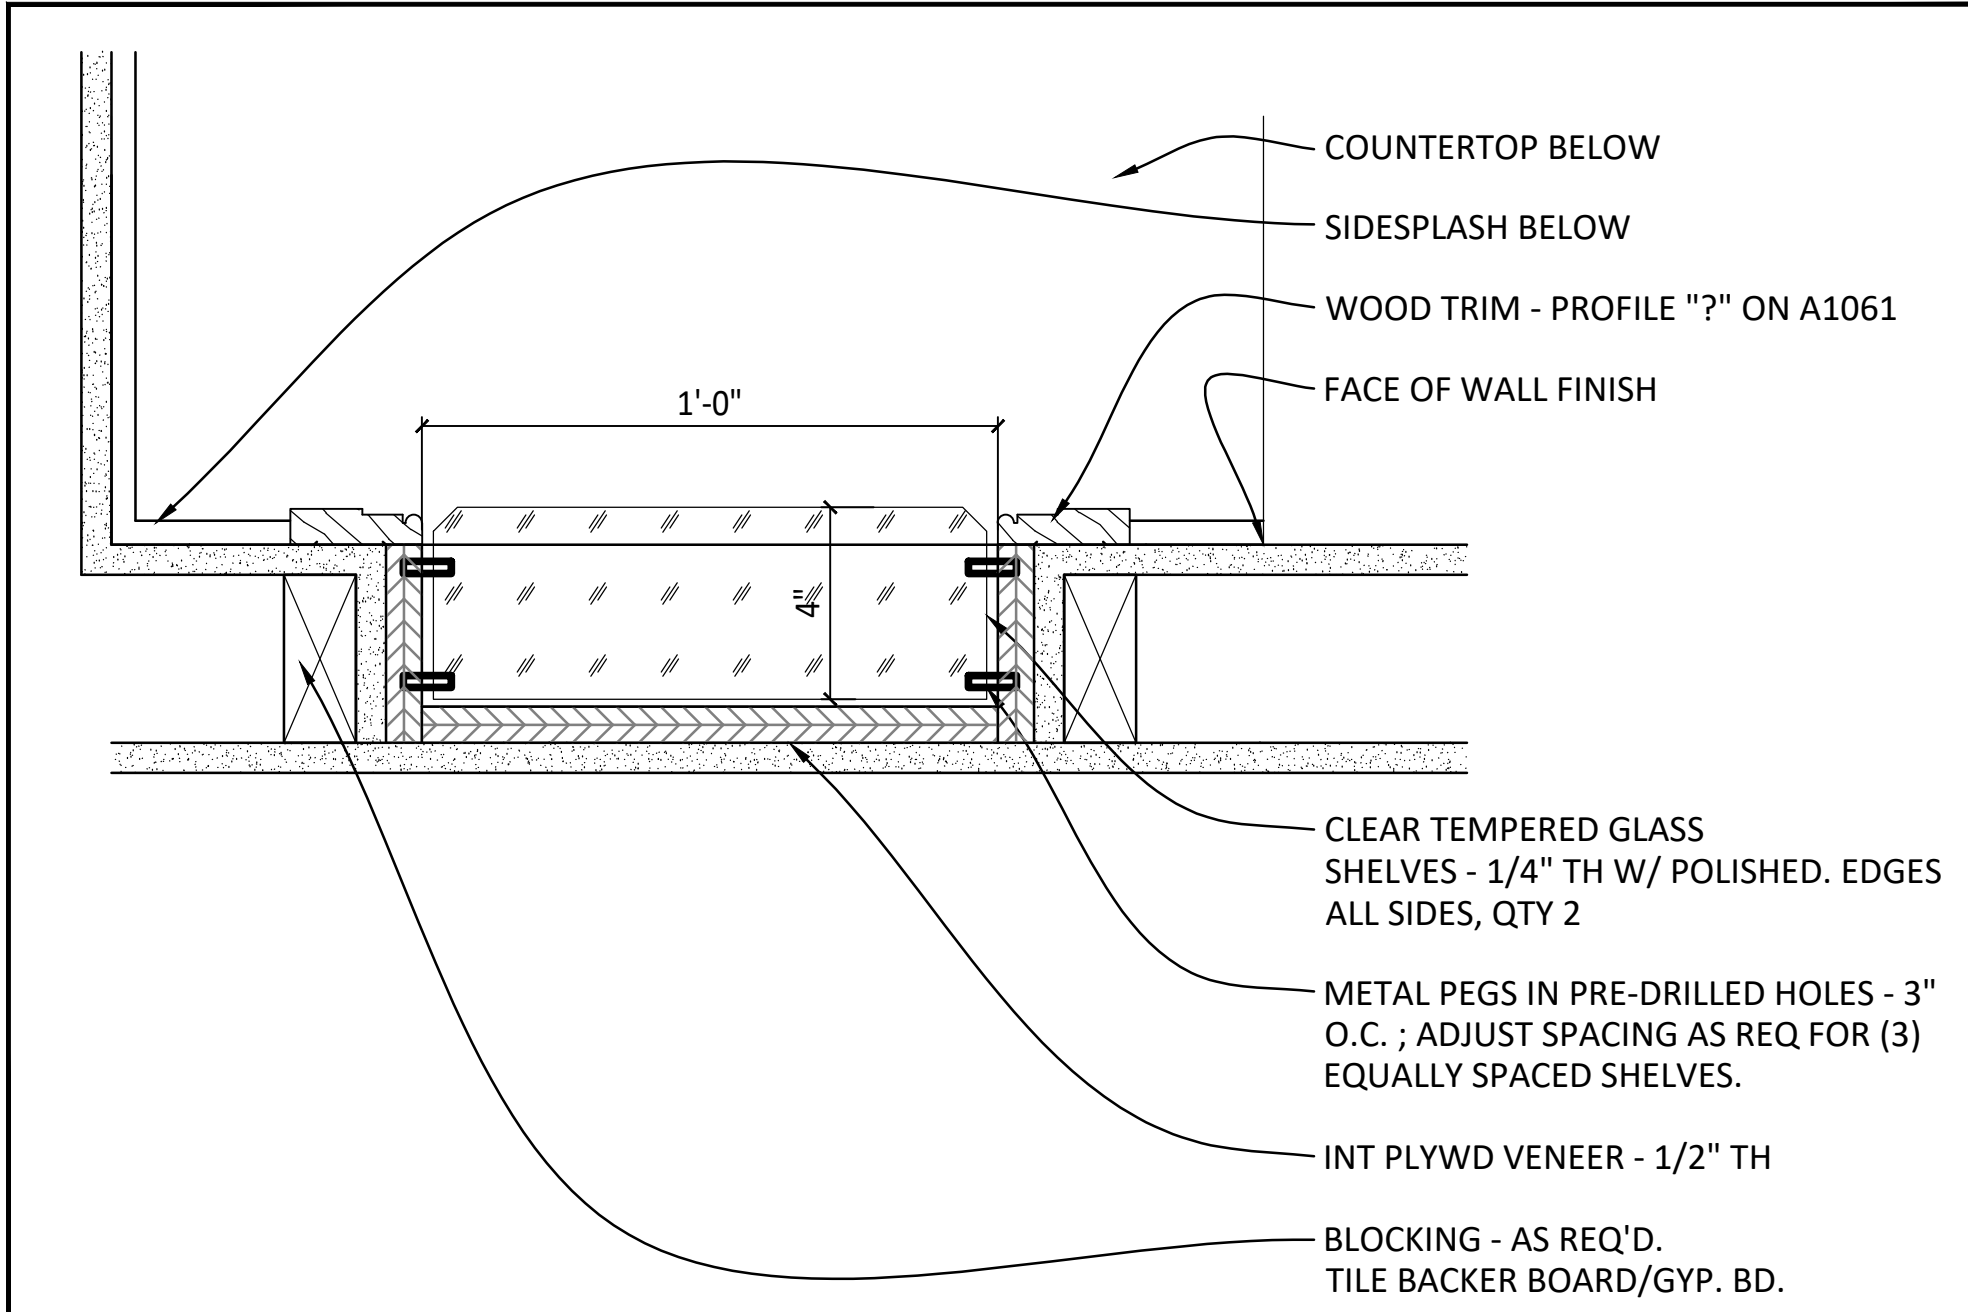


D1 PLAN DETAIL @ HAND TOWEL RECESS
A935 3" = 1'-0"

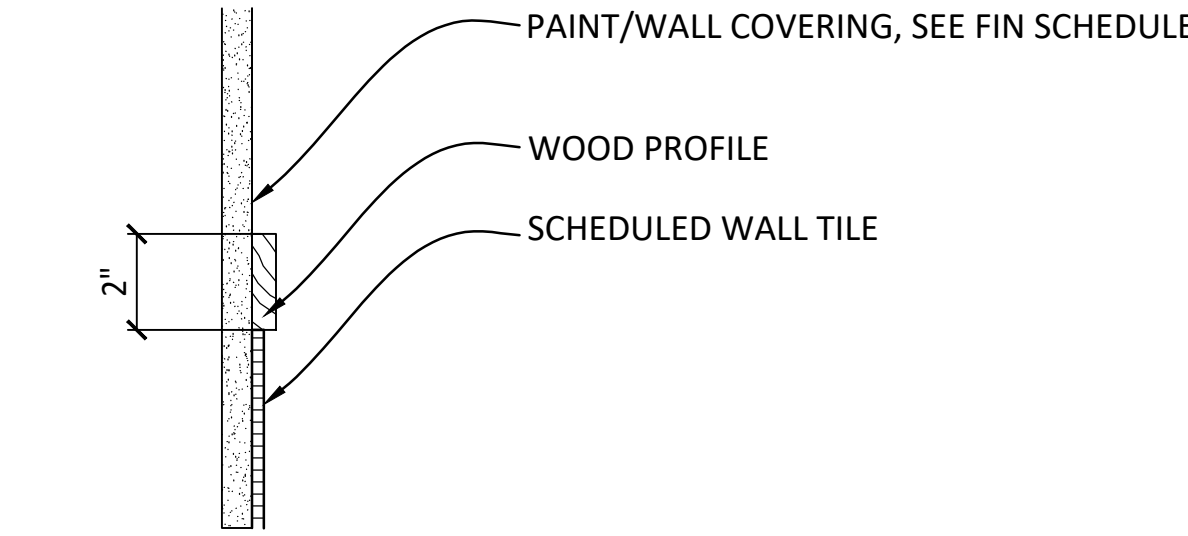


F3 WALL TILE TRANSITION DETAIL
A935 3" = 1'-0"

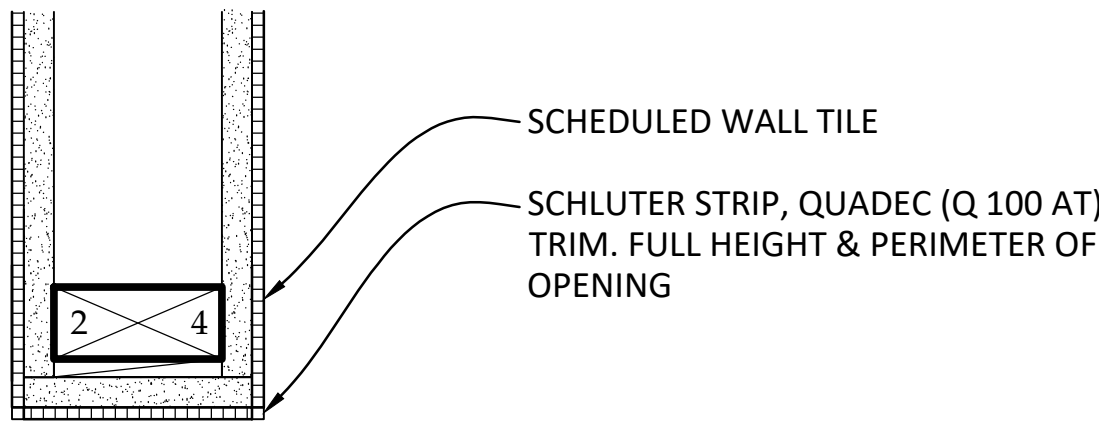


E3 DETAIL @ TILE OPENING
A935 3" = 1'-0"

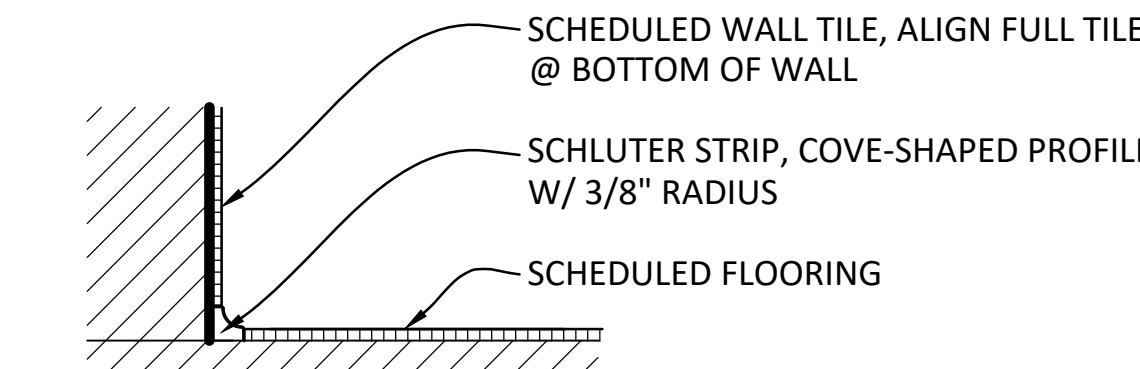


D3 DETAIL @ TILE BASE TRANSITION
A935 3" = 1'-0"

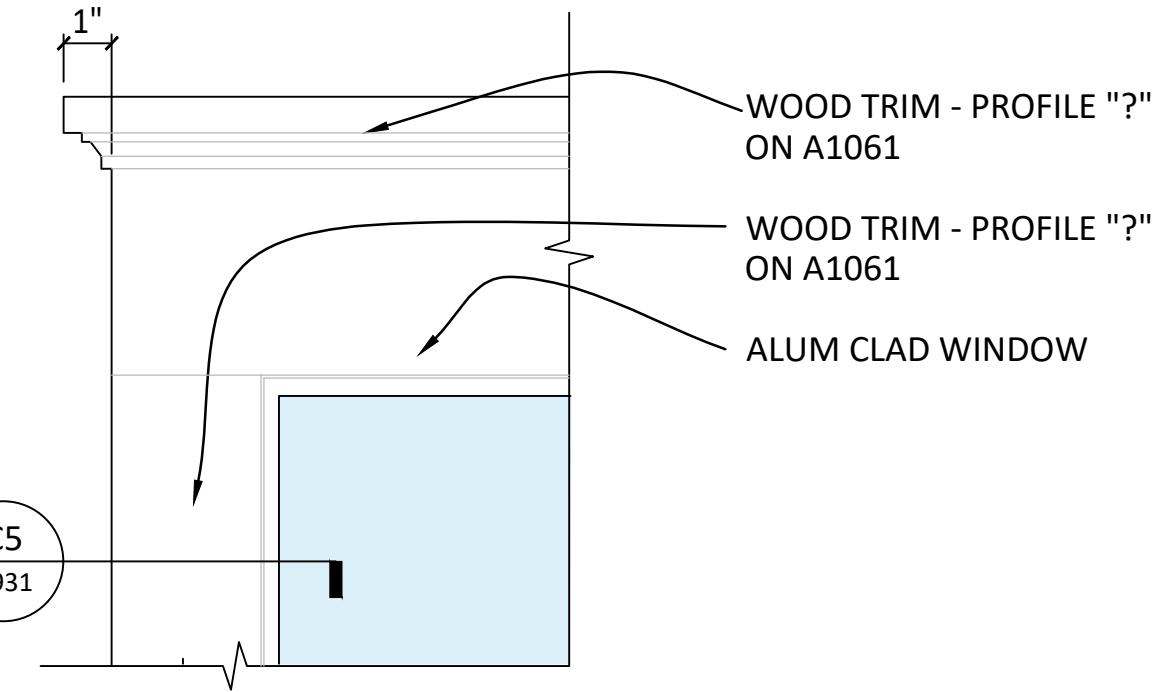


E5 INT HEAD ELEV @ ALUM WINDOW
A935 3" = 1'-0"

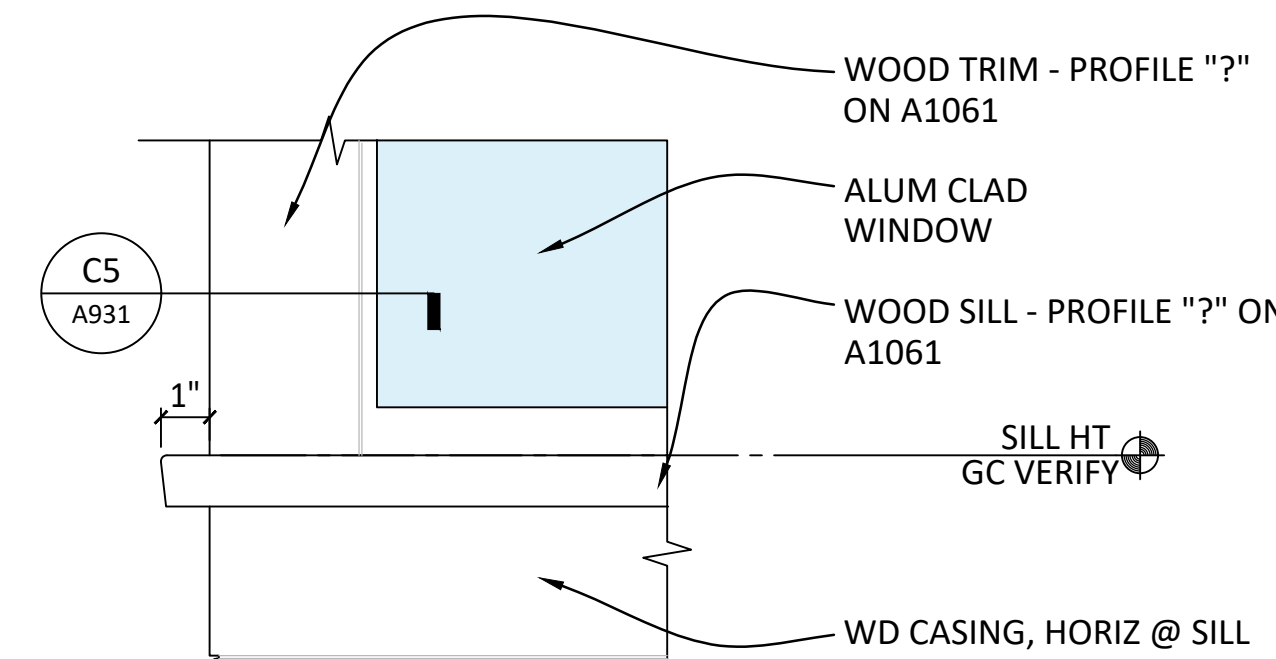


C5 INT SILL ELEV @ ALUM WINDOW
A935 3" = 1'-0"

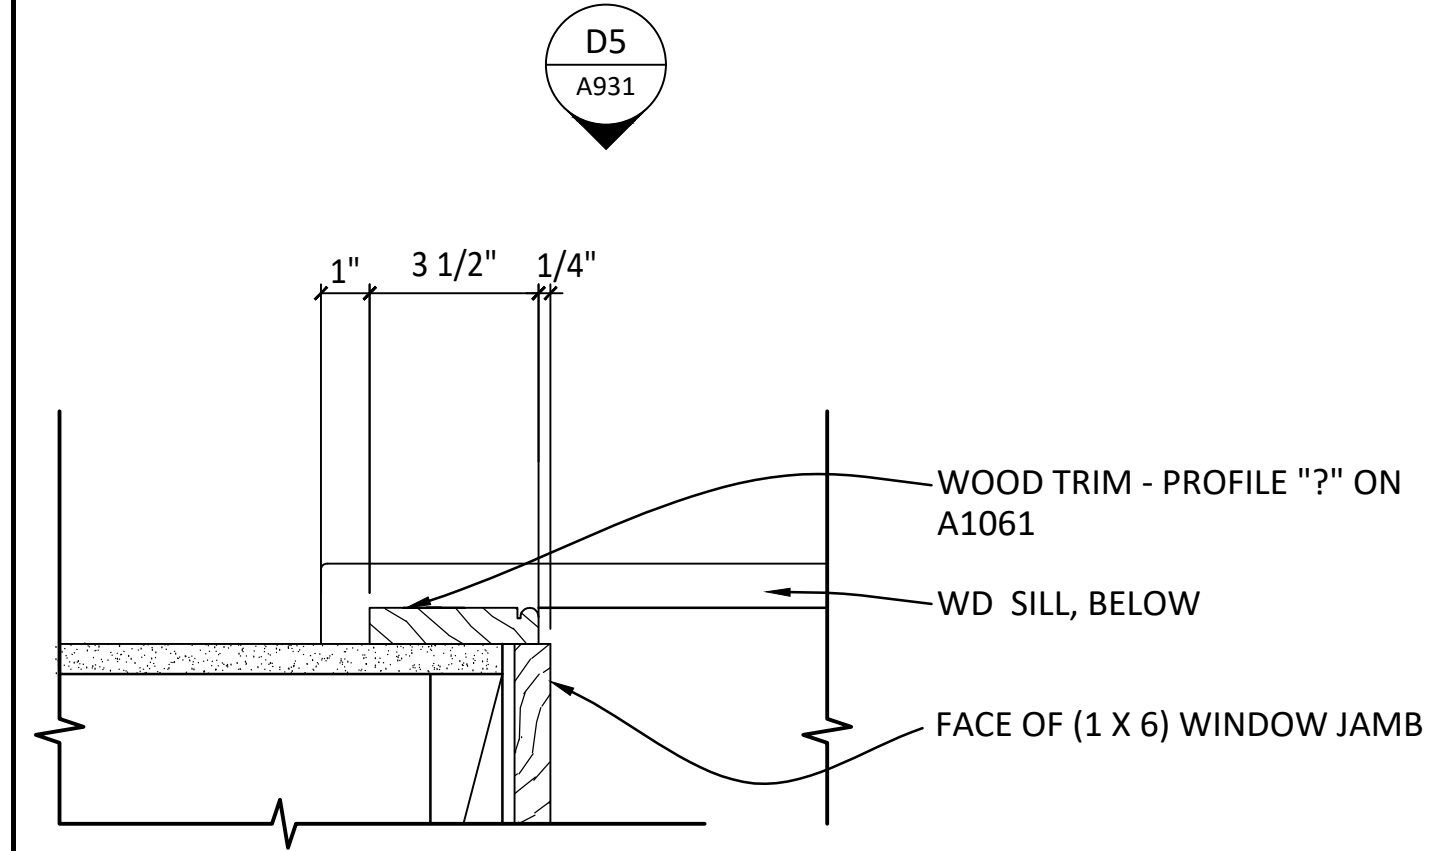


B5 INT JAMB DETAIL @ ALUM WINDOW
A935 3" = 1'-0"

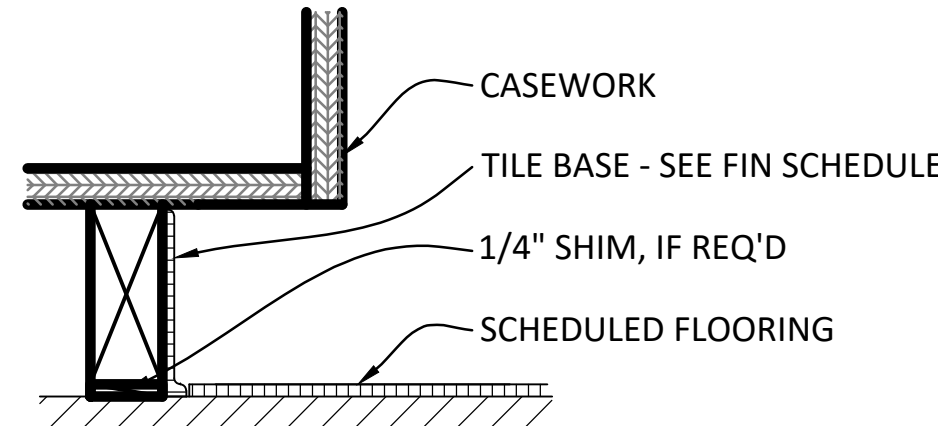


D6 DETAIL @ TILE BASE & CABINET
A935 3" = 1'-0"

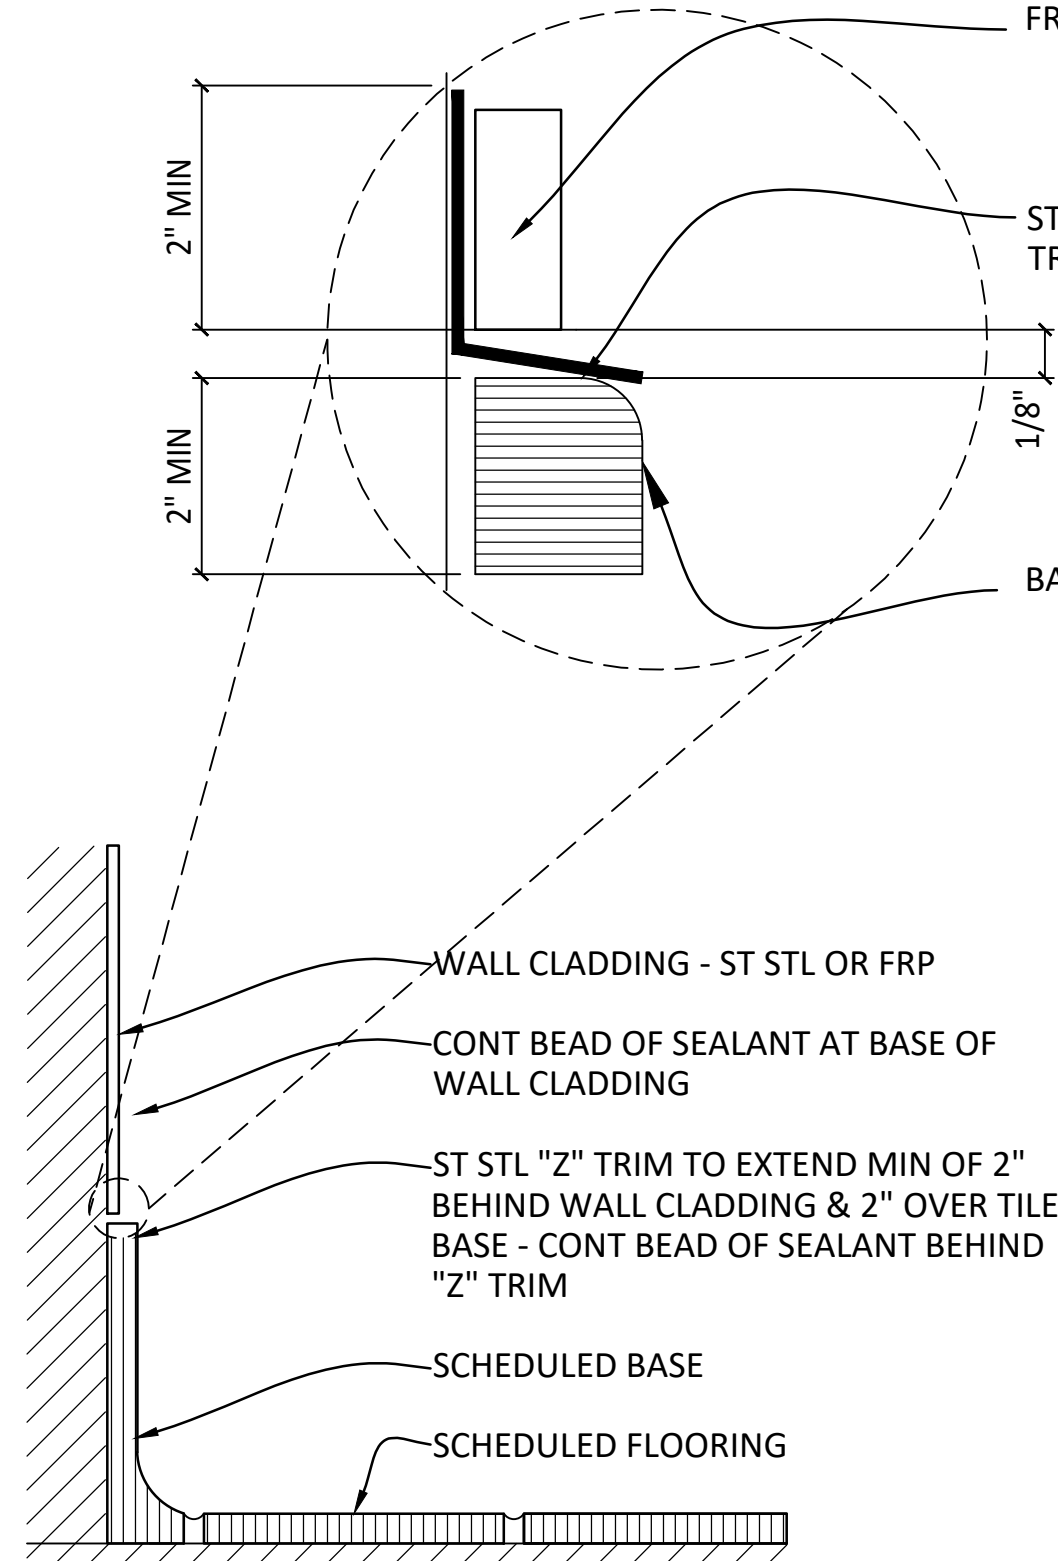


B6 DETAIL @ KITCHEN WALL BASE
A935 3" = 1'-0"

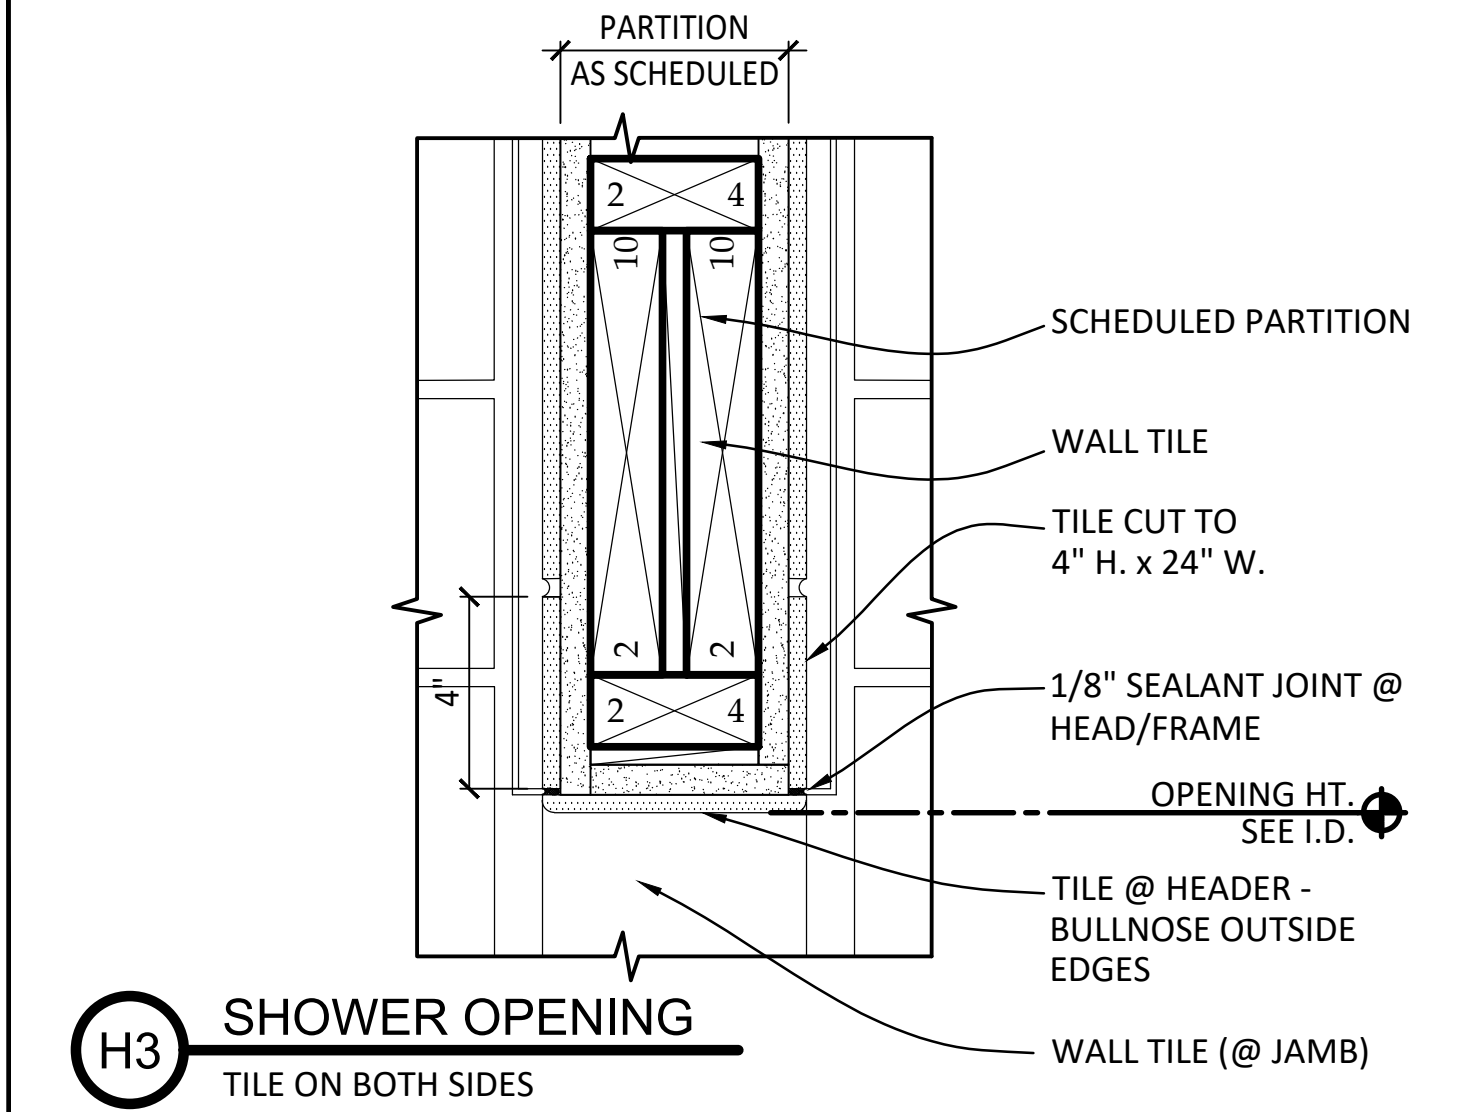


B1 DOOR DETAIL - HEAD
A935 3" = 1'-0"

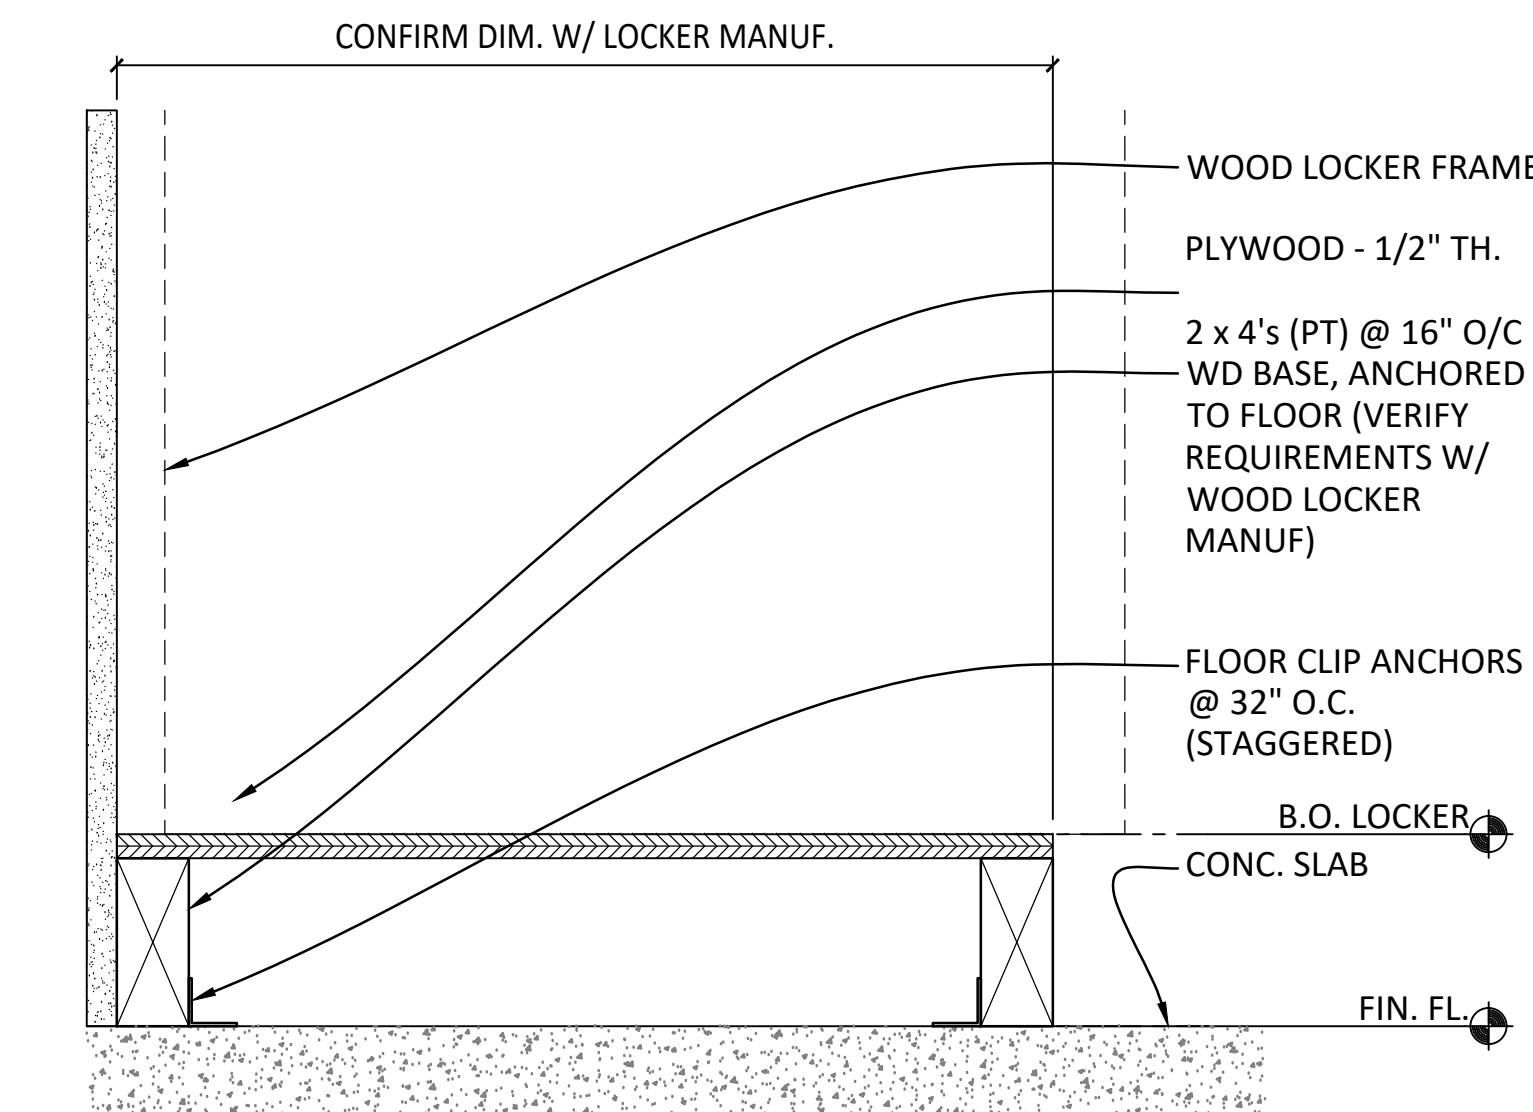


B3 DETAIL @ BASE OF LOCKERS
A935 3" = 1'-0"

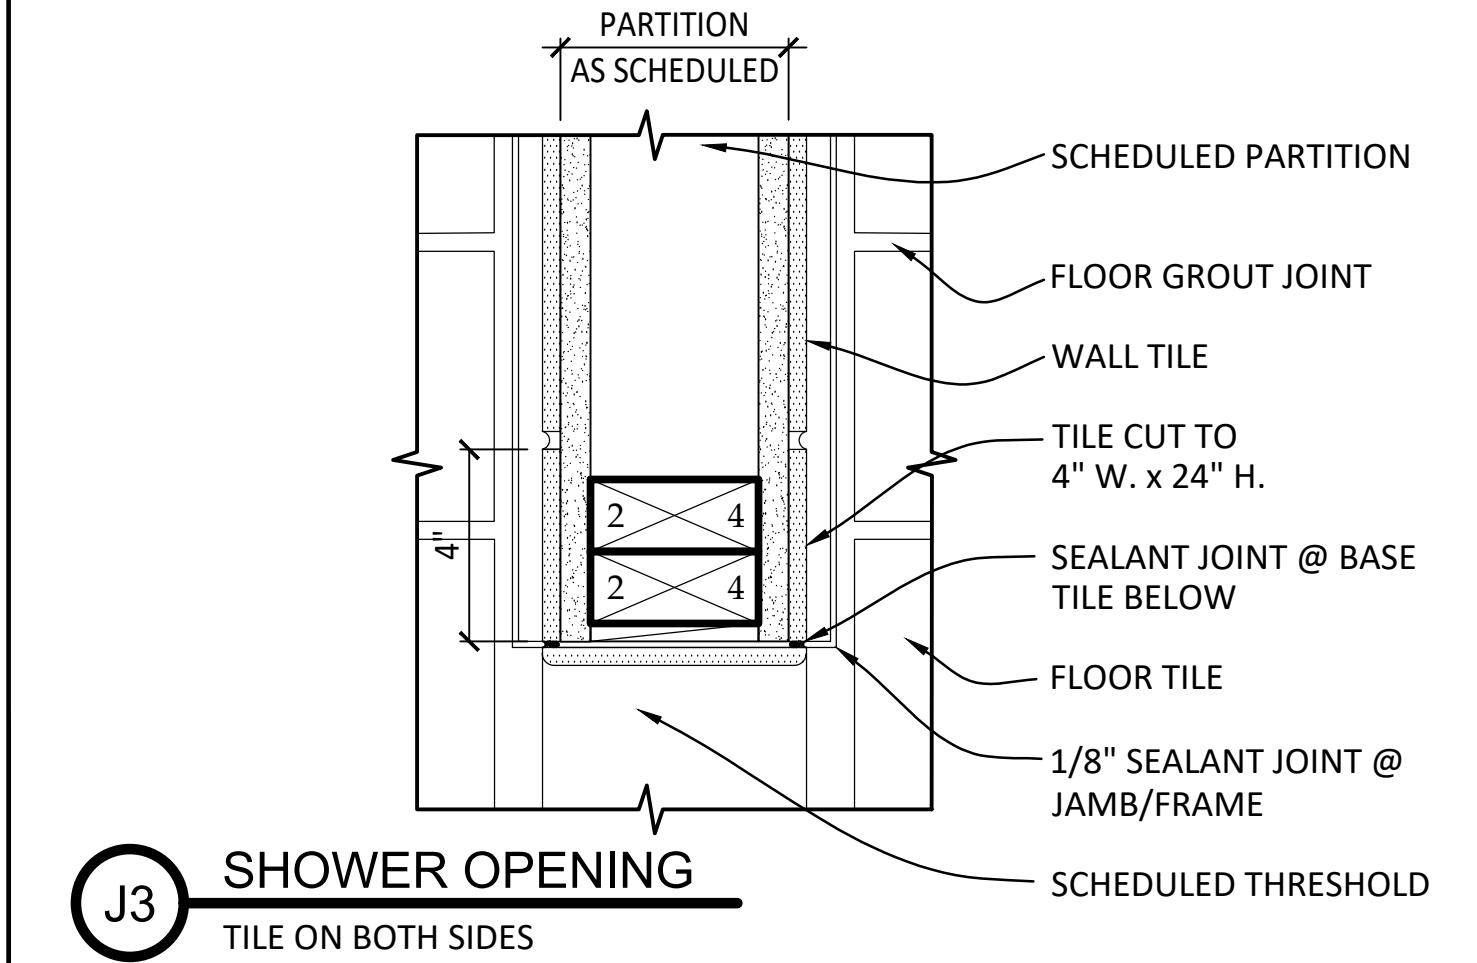

A1 DOOR DETAIL - JAMB
A935 3" = 1'-0"

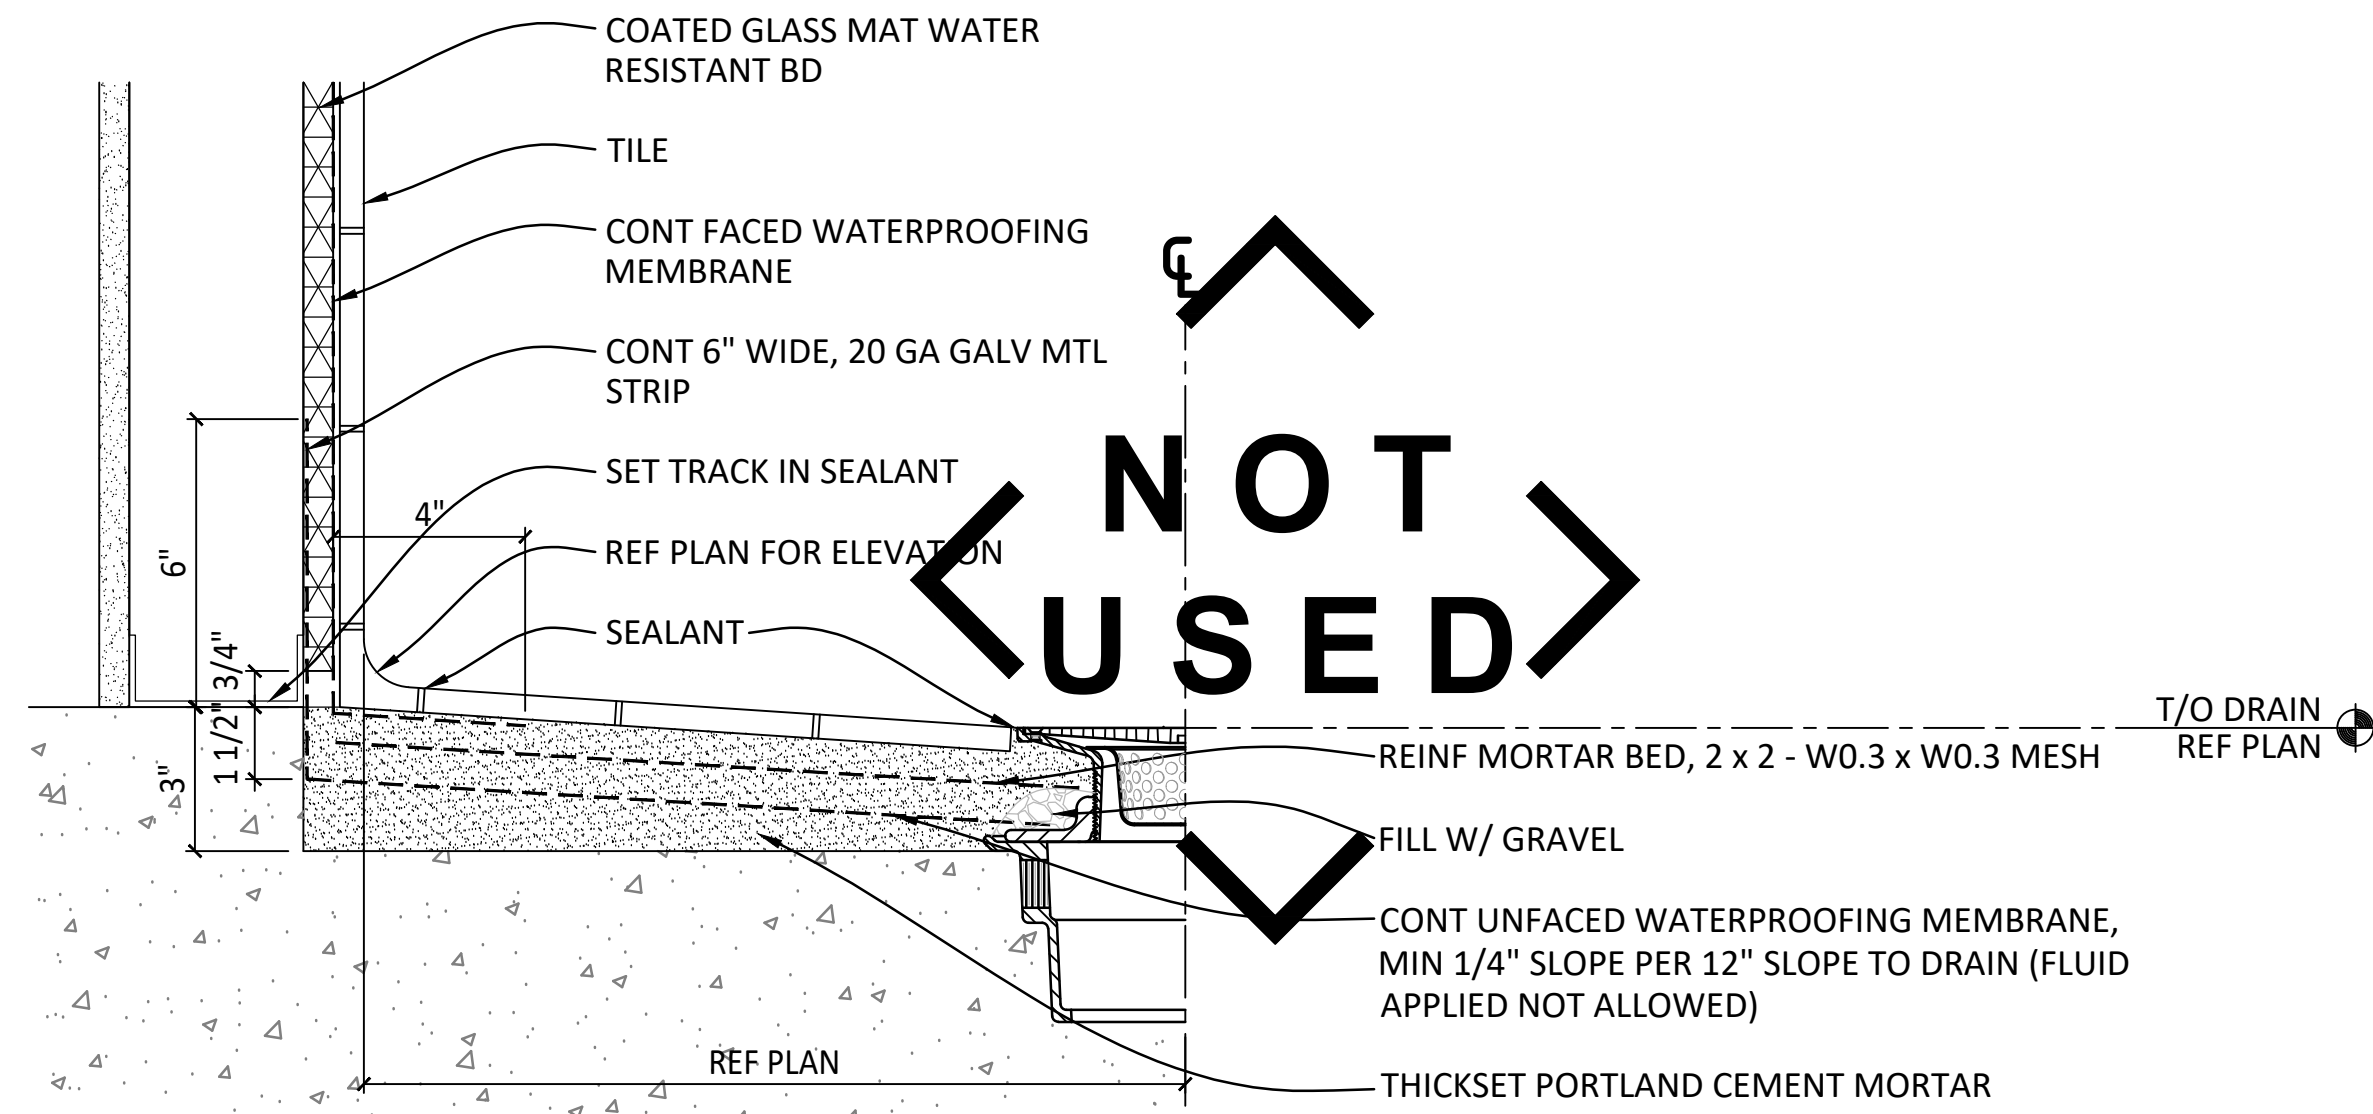

A3 SECTION @ SHOWER DRAIN
A935 3" = 1'-0"

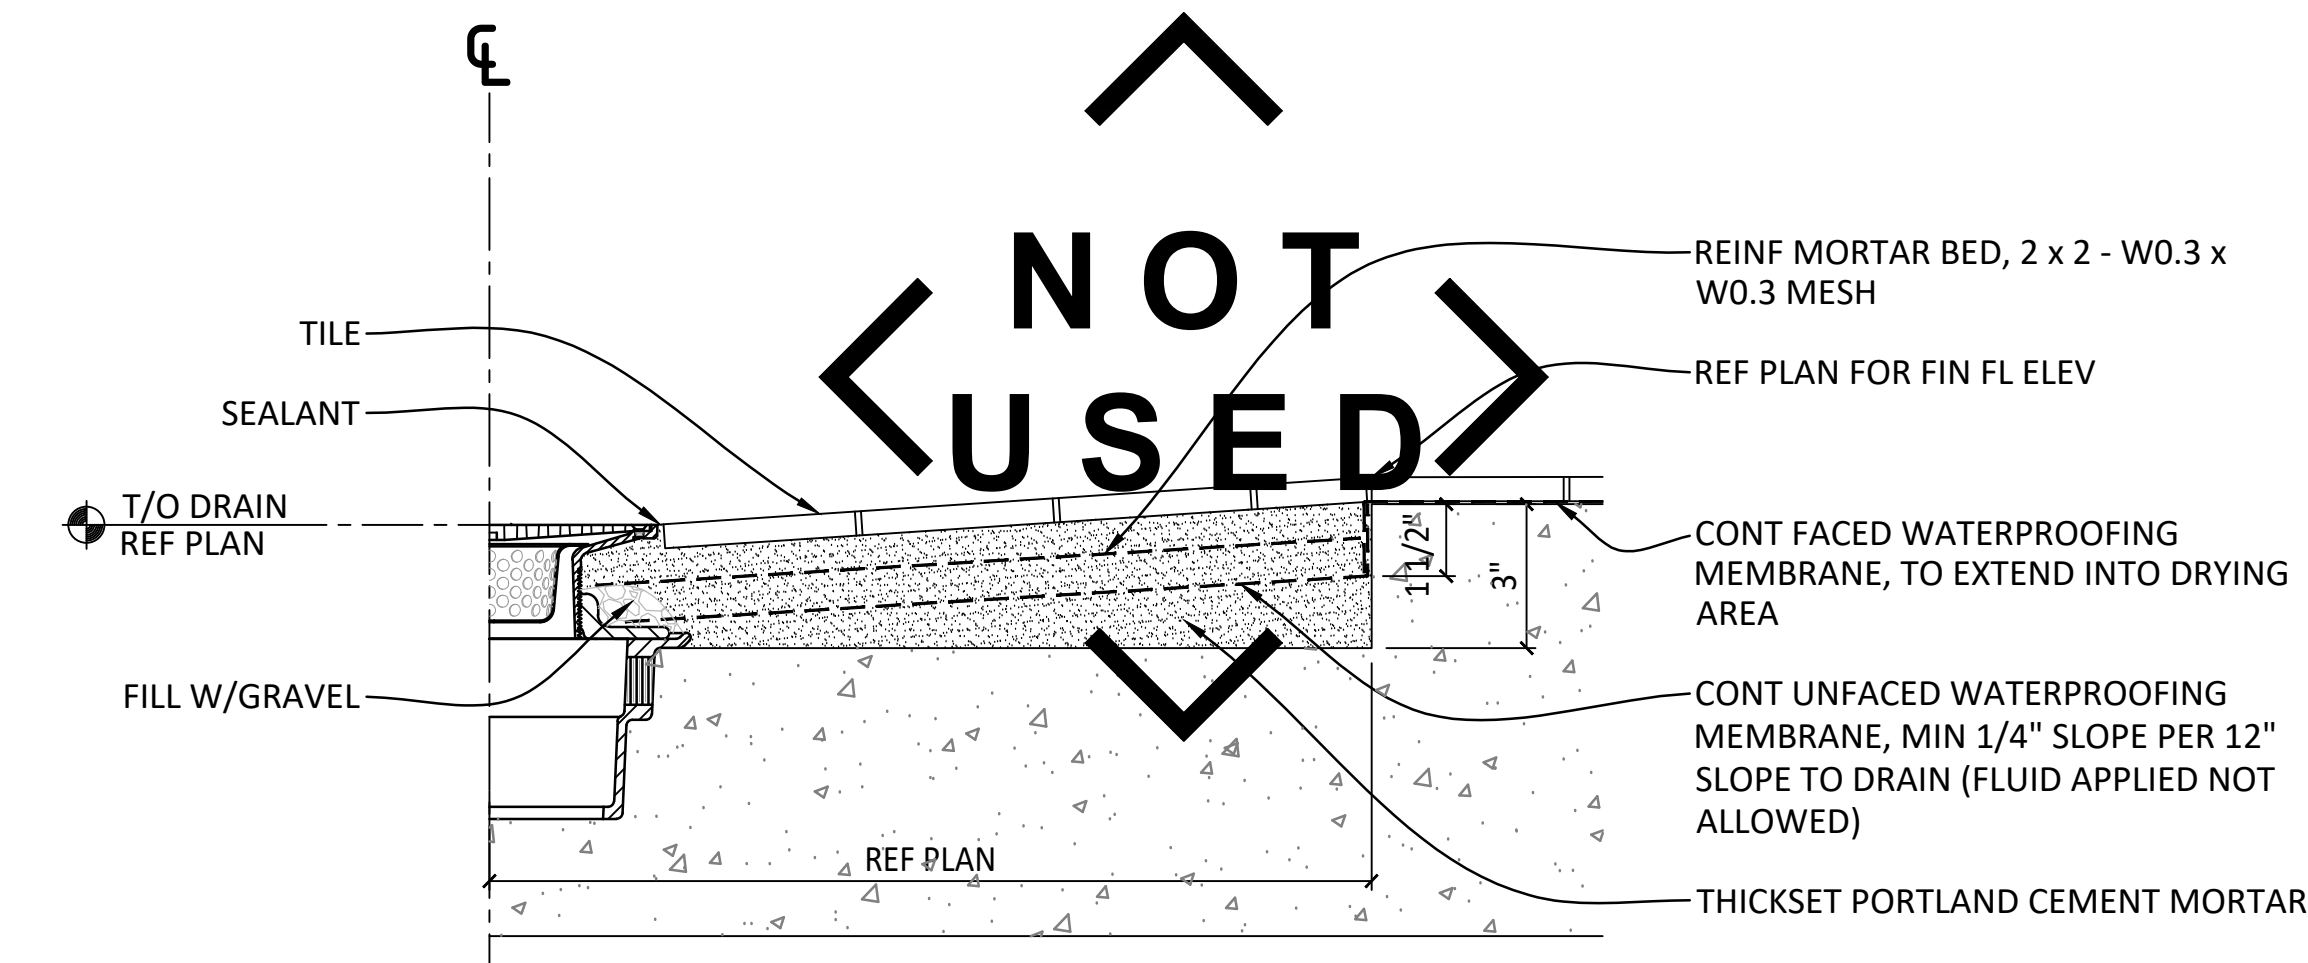

A5 SECTION @ SHOWER DRAIN
A935 3" = 1'-0"